

Prepared For:
**119 Development,
LLC**

Consultant:
Crabtree Engineering
278 Amelia Cove
Caldwellsville, Tennessee 38017
majidhatazadeh@yahoo.com


Architect:
ARCHITECTYPE
Architects
48 Union Wharf Portland, Maine 04101
(207) 772-6022 Fax (207) 772-4056

Project:
PRESS HOTEL
390 CONGRESS STREET
PORTLAND, ME 04101

Revisions:
1 | 13_07-01 | 30% Marriott Submission
2 | 13_09-09 | 60% Marriott Sub. & Pric.
3 | 13_10-14 | Issue for Bid & Marriott Revw

Date: 08 OCT 13
Scale: 1/8" = 1'-0"
**SECOND FLOOR
PLAN - FIRE
SPRINKLER**

F2.00

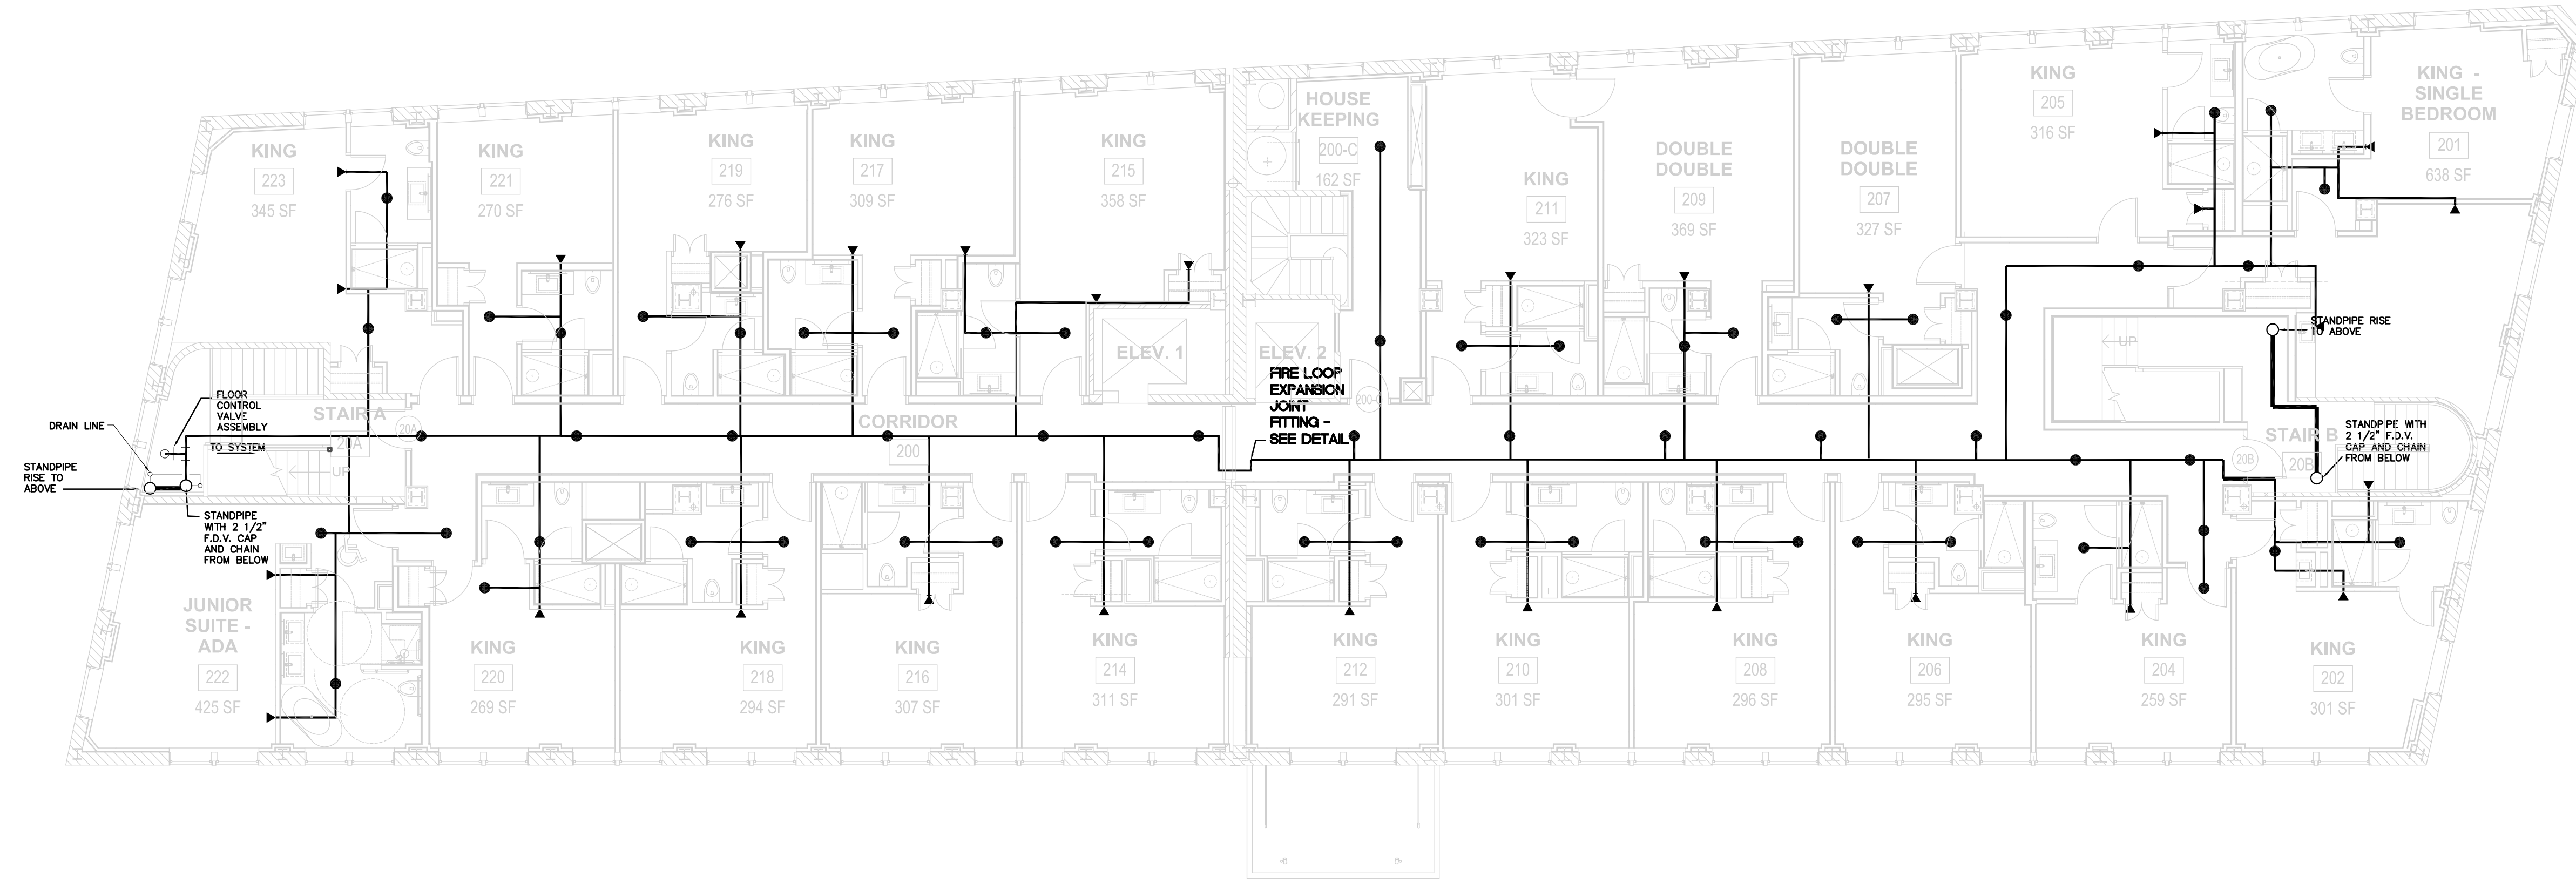

SPRINKLER LEGEND:	
●	SEMI-RECESSED Q.R. WHITE PENDANT HEAD.
▼	SIDEWALL Q.R. WHITE HEAD.
▼	212-SIDEWALL Q.R. EXTENDED COVERAGE WHITE HEAD.

1 | SECOND FLOOR PLAN - FIRE SPRINKLER
SCALE: 1/8"=1'-0"

