

Prepared For:  
**119 Development,  
LLC**

Consultant:  
Crabtree Engineering  
278 Amelia Cove  
Caldwellsville, Tennessee 38017  
majidhatamzadeh@yahoo.com


Architect:  
**ARCHITECTS**  
Architects  
48 Union Wharf Portland, Maine 04101  
(207) 772-6022 Fax (207) 772-4056

Project:  
**PRESS HOTEL**  
390 CONGRESS STREET  
PORTLAND, ME 04101


Revisions:  
1 | 13\_07-01 | 30% Marriott Submission  
2 | 13\_09-09 | 60% Marriott Sub. & Pric.  
3 | 13\_10-14 | Issue for Bld & Marriott Revw

Date: 08 OCT 13  
Scale: 1/8" = 1'-0"  
**THIRD FLOOR  
PLAN - FIRE  
SPRINKLER**

**F3.00**

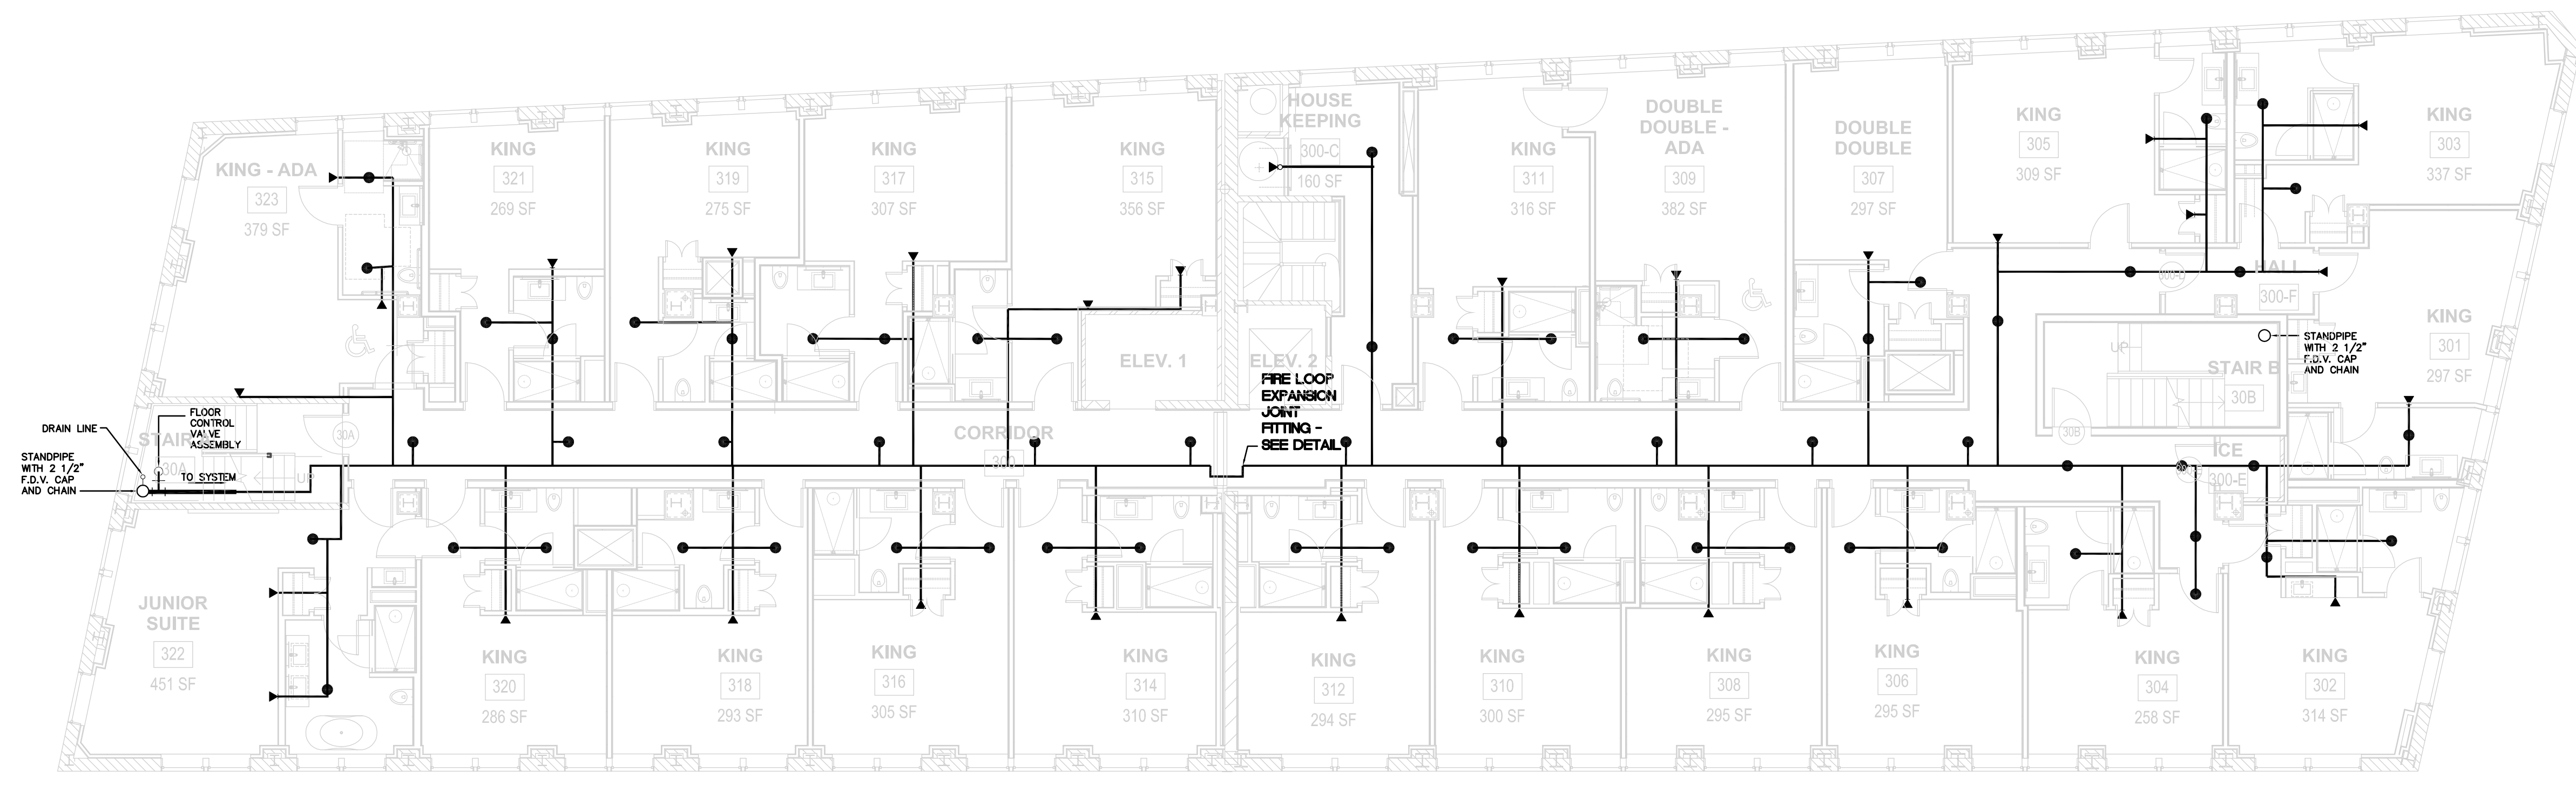

SPRINKLER LEGEND:	
●	SEMI-RECESSED Q.R. WHITE PENDANT HEAD.
▼	SIDEWALL Q.R. WHITE HEAD.
▼ <sub>212</sub>	SIDEWALL Q.R. EXTENDED COVERAGE WHITE HEAD.

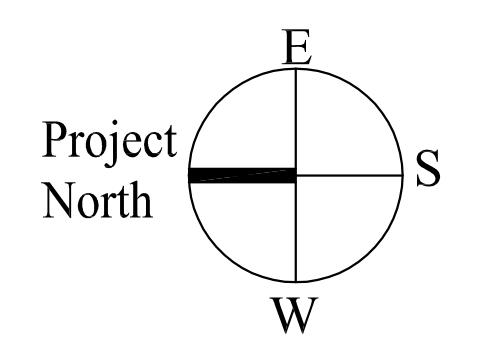

**1** | THIRD FLOOR PLAN - FIRE SPRINKLER  
SCALE: 1/8"=1'-0"