

Prepared For:
**119 Development,
 LLC**

Consultant:
 Crabtree Engineering
 278 Amelia Cove
 Collierville, Tennessee 38017
 majidatamzadeh@yahoo.com


Architect:
ARCHITECT
A r c h i t e c t s
 48 Union Wharf Portland, Maine 04101
 (207) 772-6022 Fax (207) 772-4056

Project:
PRESS HOTEL
 390 CONGRESS STREET
 PORTLAND, ME 04101

Revisions:
 1 | 13_07-01 | 30% Marriott Submission
 2 | 13_09-09 | 60% Marriott Sub. & Pric.
 3 | 13_10-14 | Issue for Bld & Marriott Revw

Date: **08 OCT 13**
 Scale: **1/8" = 1'-0"**
**SIXTH FLOOR PLAN
 FIRE SPRINKLER**

F6.00

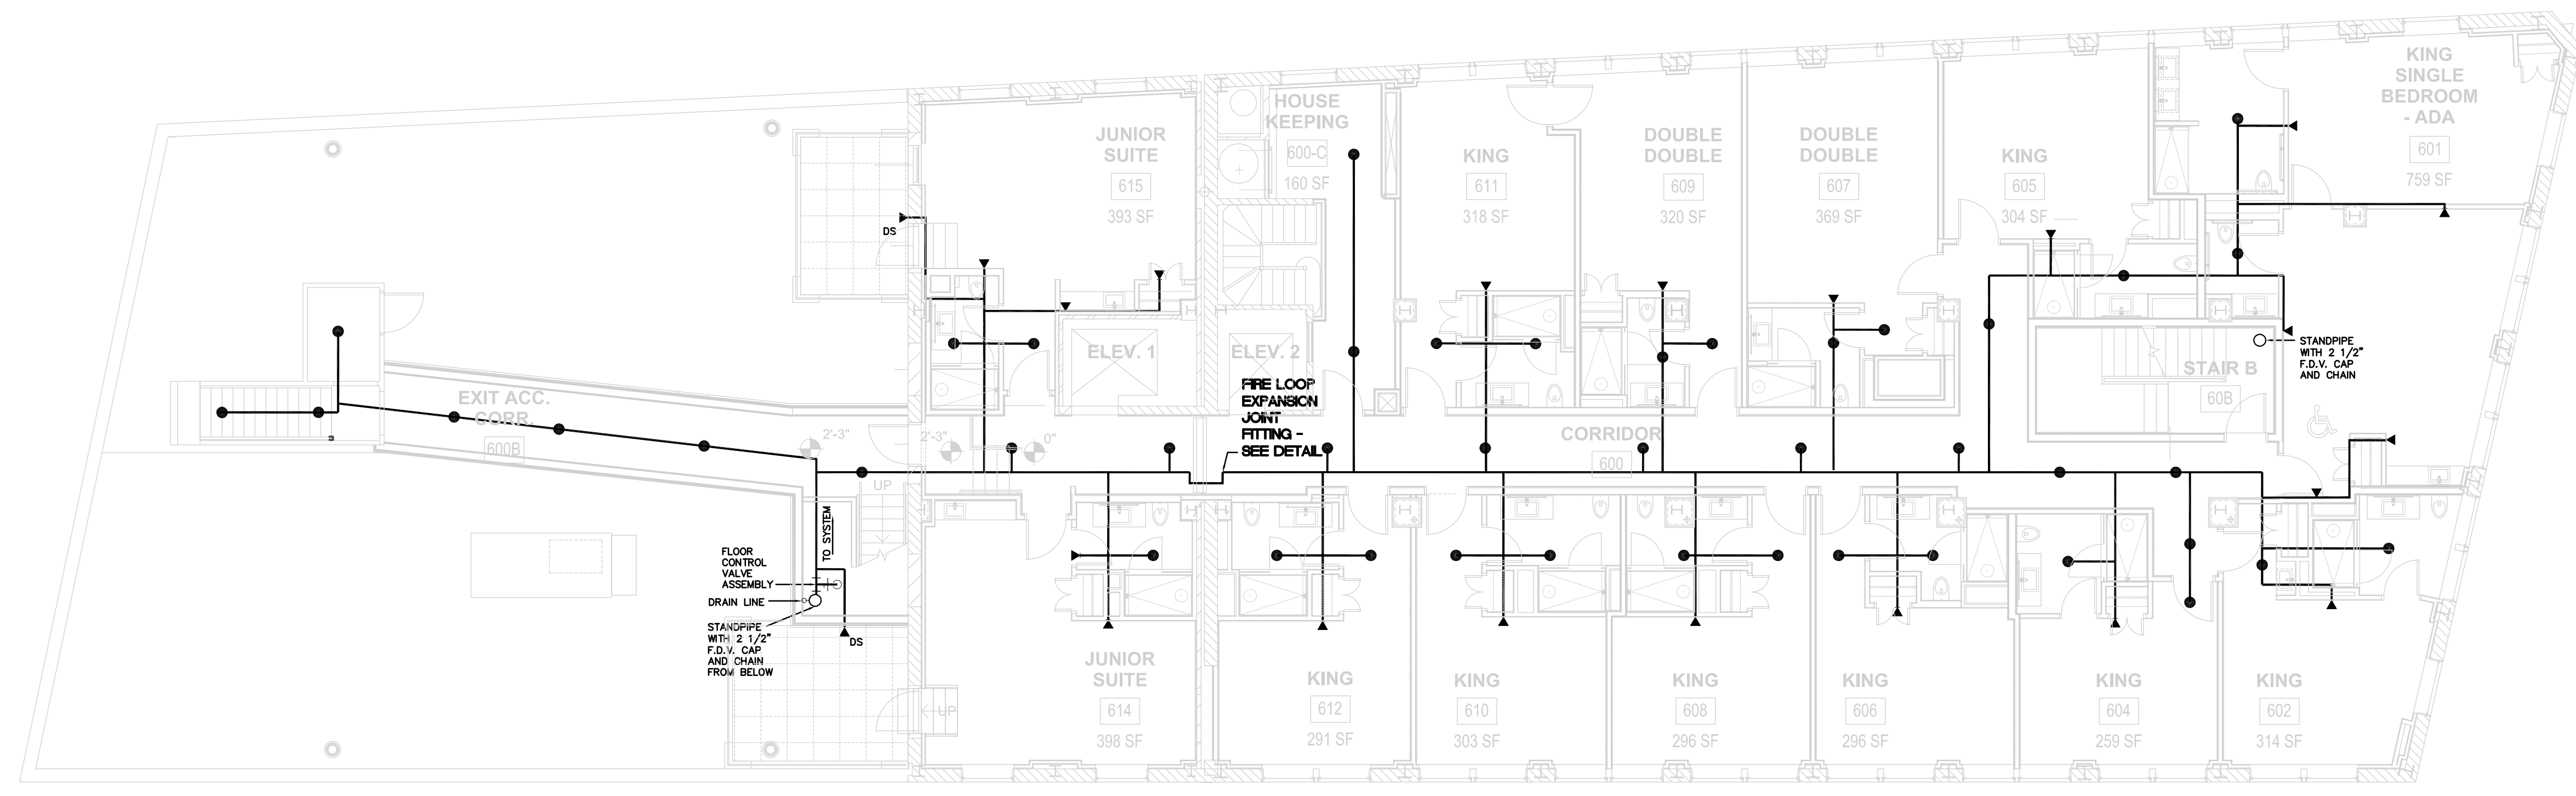

SPRINKLER LEGEND:	
●	SEMI-RECESSED Q.R. WHITE PENDANT HEAD.
▼	SIDEWALL Q.R. WHITE HEAD.
▼ ₂₁₂	SIDEWALL Q.R. EXTENDED COVERAGE WHITE HEAD.

1 | SIXTH FLOOR PLAN - FIRE SPRINKLER
 SCALE: 1/8"=1'-0"

