

Prepared For:
119 Development, LLC

Consultant:
 Crabree Engineering
 278 Amelia Cove
 Collierville, Tennessee 38017
 majidatanzadeh@yahoo.com

Architect:
ARCHITECTS
Architects
 48 Union Wharf Portland, Maine 04101
 (207) 772-6022 Fax (207) 772-4056


Project:
PRESS HOTEL
 390 CONGRESS STREET
 PORTLAND, ME 04101

Revisions:

1	13_07-01	30% Marriott Submission
2	13_09-09	60% Marriott Sub. & Pric.
3	13_10-14	Issue for Bld & Marriott Revw

Date: **08 OCT 13**
 Scale: **1/8" = 1'-0"**
SEVENTH FLOOR
PLAN - FIRE
SPRINKLER

F7.00

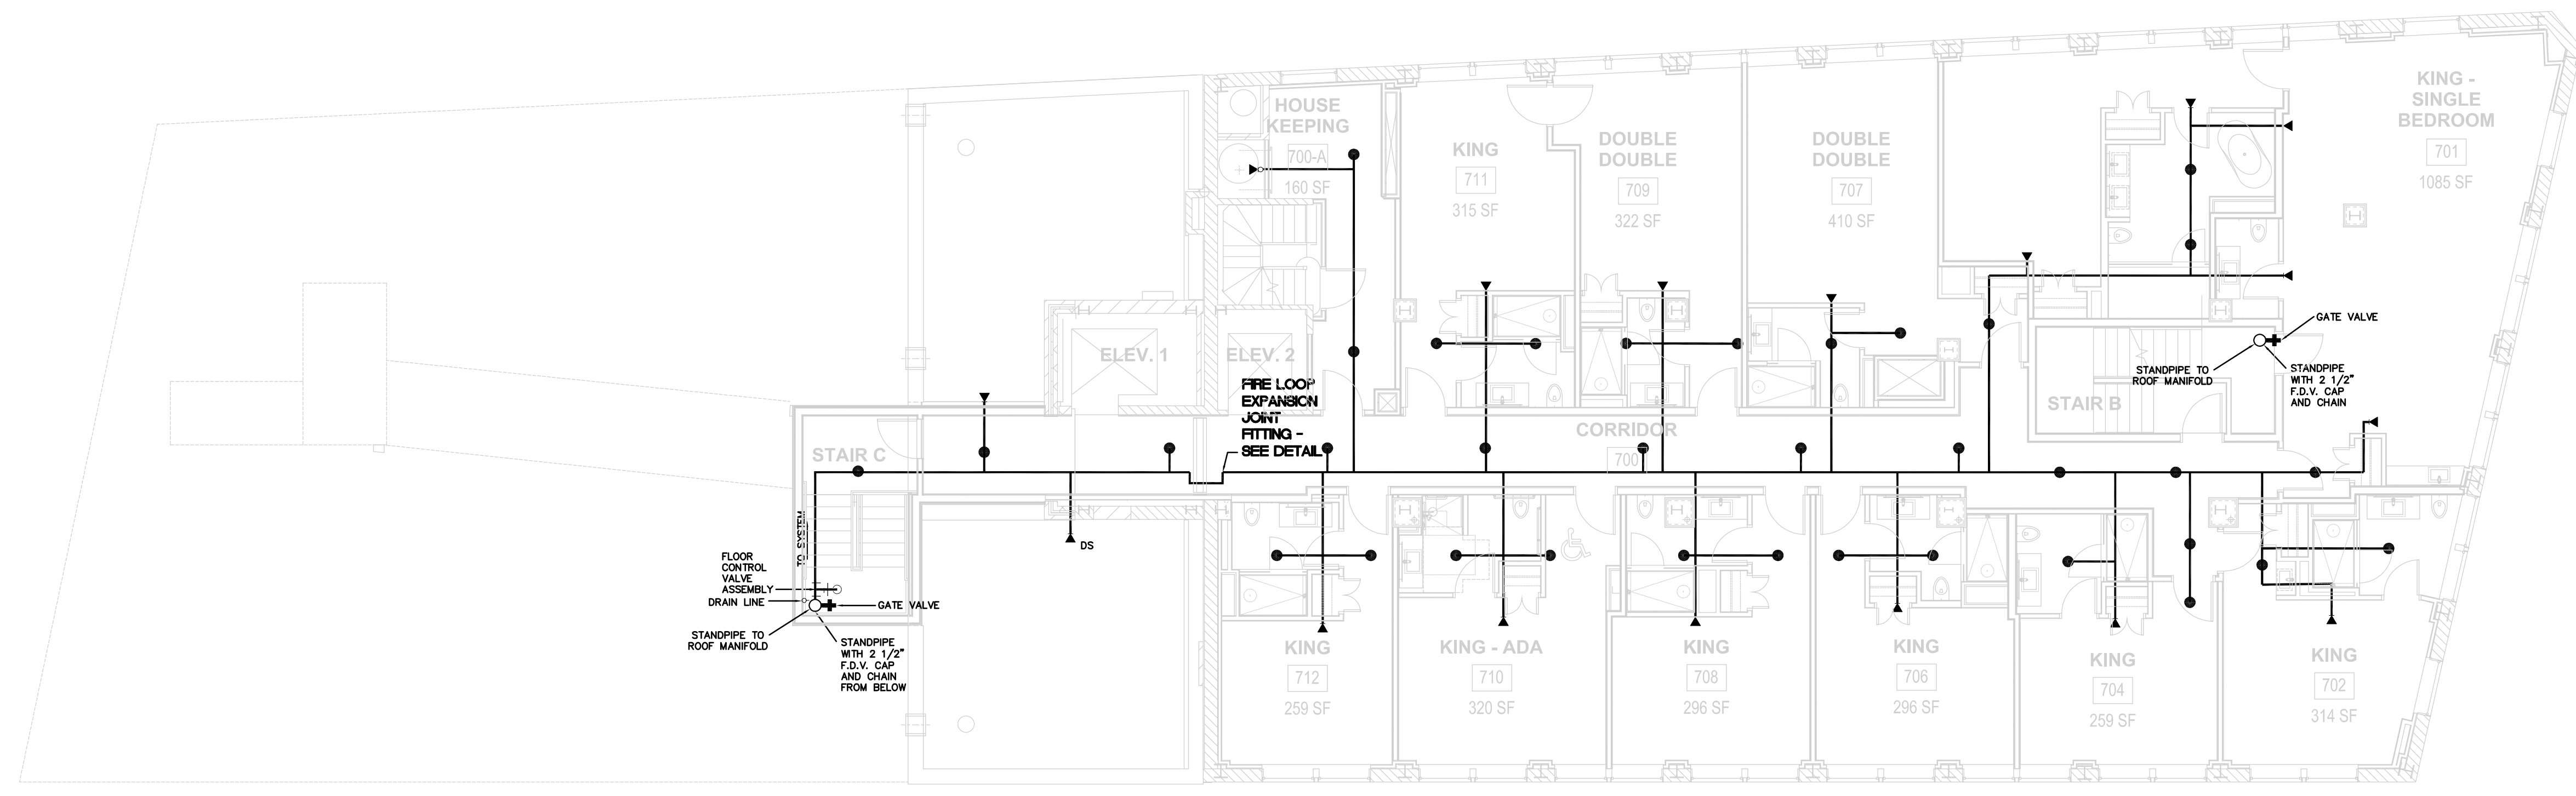

SPRINKLER LEGEND:

●	SEMI-RECESSED Q.R. WHITE PENDANT HEAD.
▼	SIDEWALL Q.R. WHITE HEAD.
▼ ₂₁₂	SIDEWALL Q.R. EXTENDED COVERAGE WHITE HEAD.

1 SEVENTH FLOOR PLAN - FIRE SPRINKLER
 SCALE: 1/8"=1'-0"

