



**1** FIRST FLOOR PLAN - WATER  
SCALE: 1/8"=1'-0"

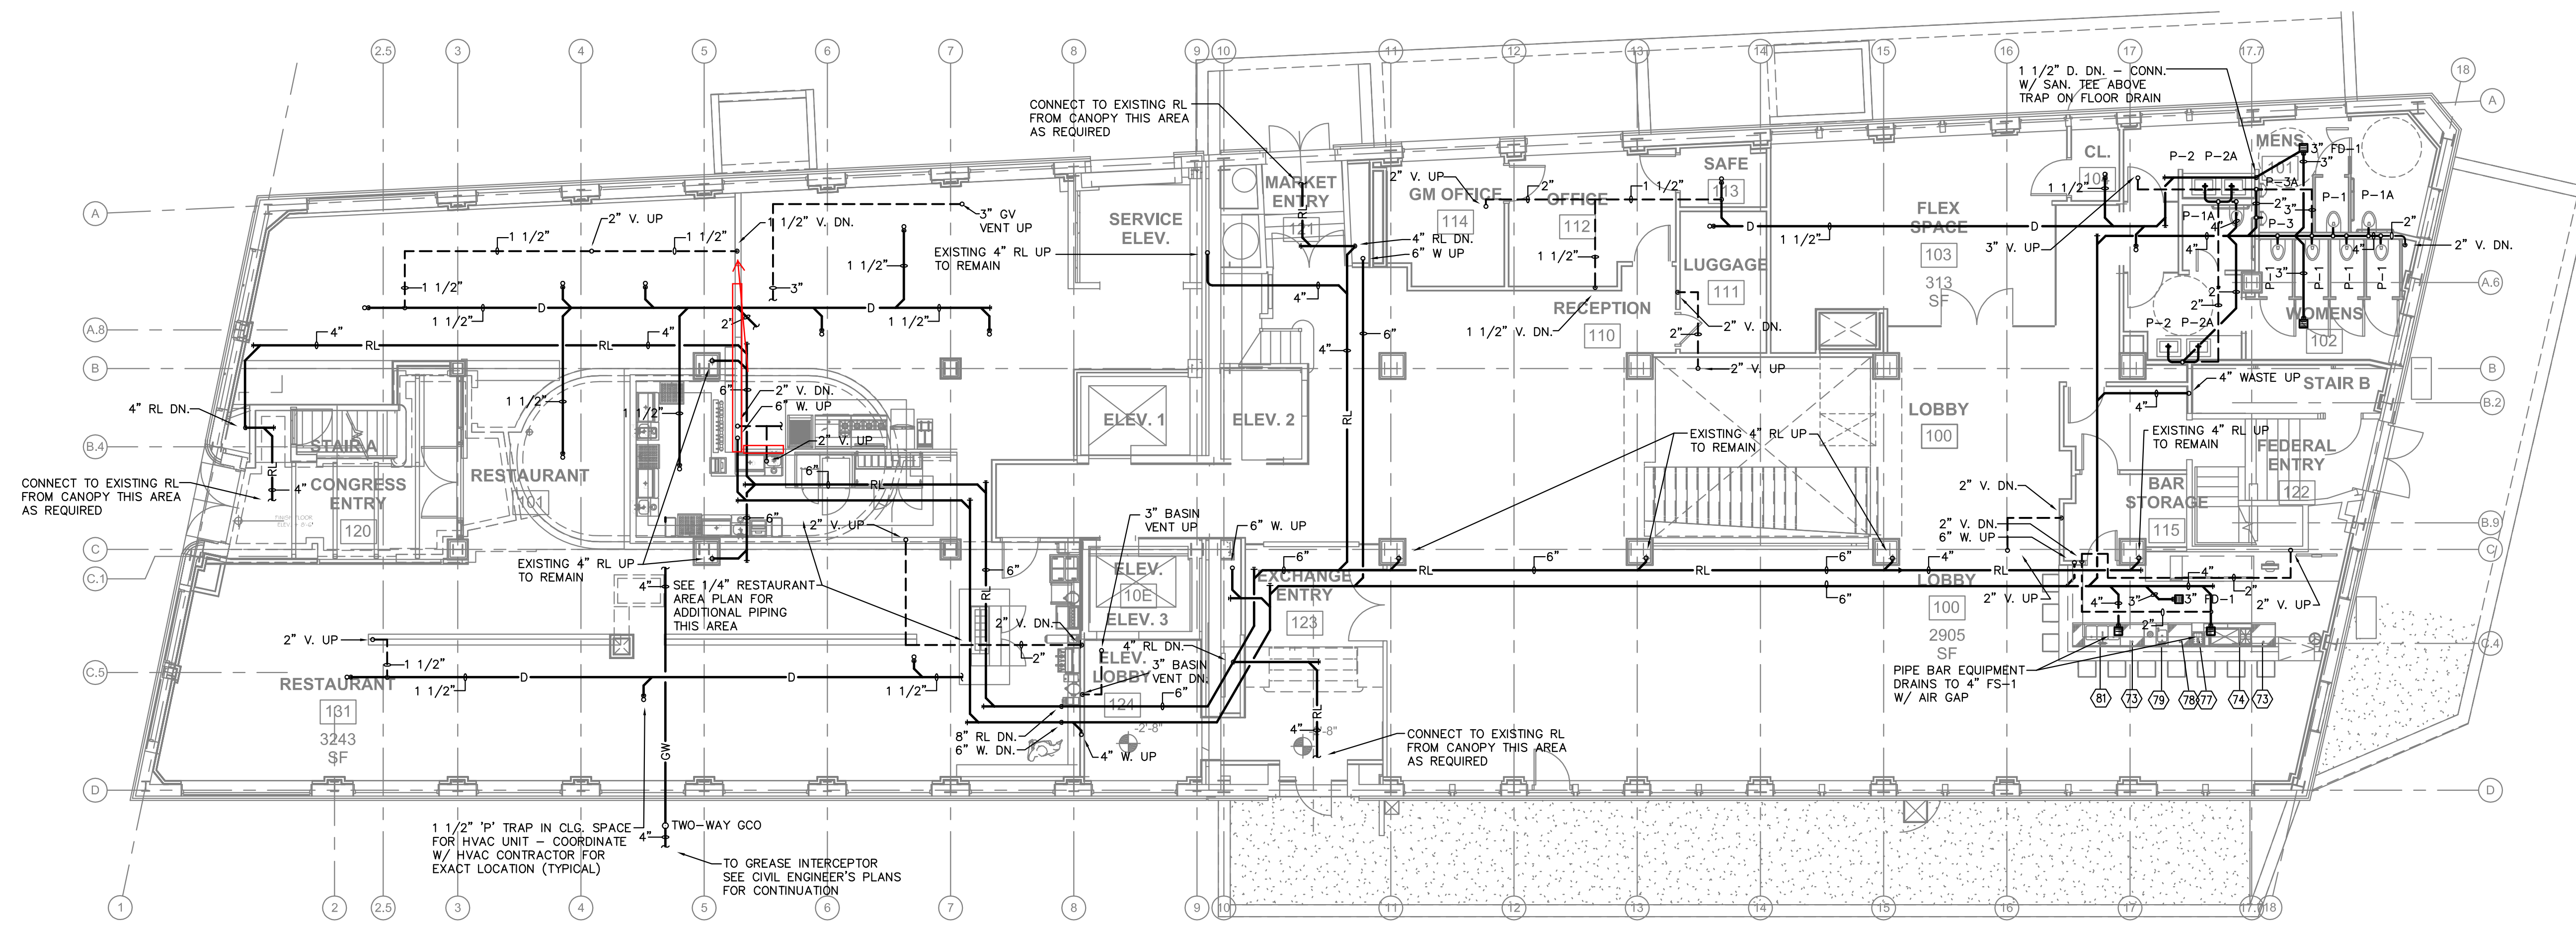

**2** FIRST FLOOR PLAN - WASTE, VENT AND RAIN LEADER  
SCALE: 1/8"=1'-0"

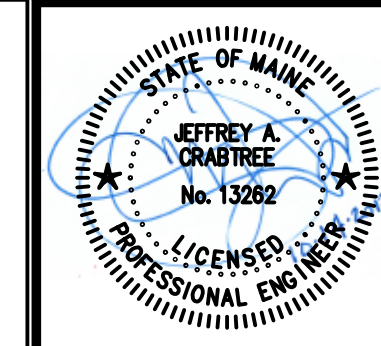

Prepared For:  
**119 Development, LLC**  
P.O. Box 7468  
Portland, ME 04112

Consultant:  
**CRABTREE ENGINEERING**  
278 AMELIA COVE  
COLLIERVILLE, TN 38017  
PLUMBING: bob@crabtreeeng.com

Architect:  
**ARCHETYPE architects**  
48 Union Wharf Portland, Maine 04101  
(207) 772-6022 Fax (207) 772-4056

Project:  
**PRESS HOTEL**  
390 CONGRESS STREET  
PORTLAND, ME 04101

Revisions:  
1 13-07-01 30% Marriott Submission  
2 13-09-09 60% Marriott Sub. & Pric.  
3 13-10-14 Issue for Bid & Marriott Rev.

Date:  
13 October 2013  
Scale:  
1/8" = 1'-0"  
**FIRST FLOOR PLANS  
- PLUMBING**

**P1.00**