



1 FIFTH FLOOR PLAN - WATER
SCALE: 1/8"=1'-0"

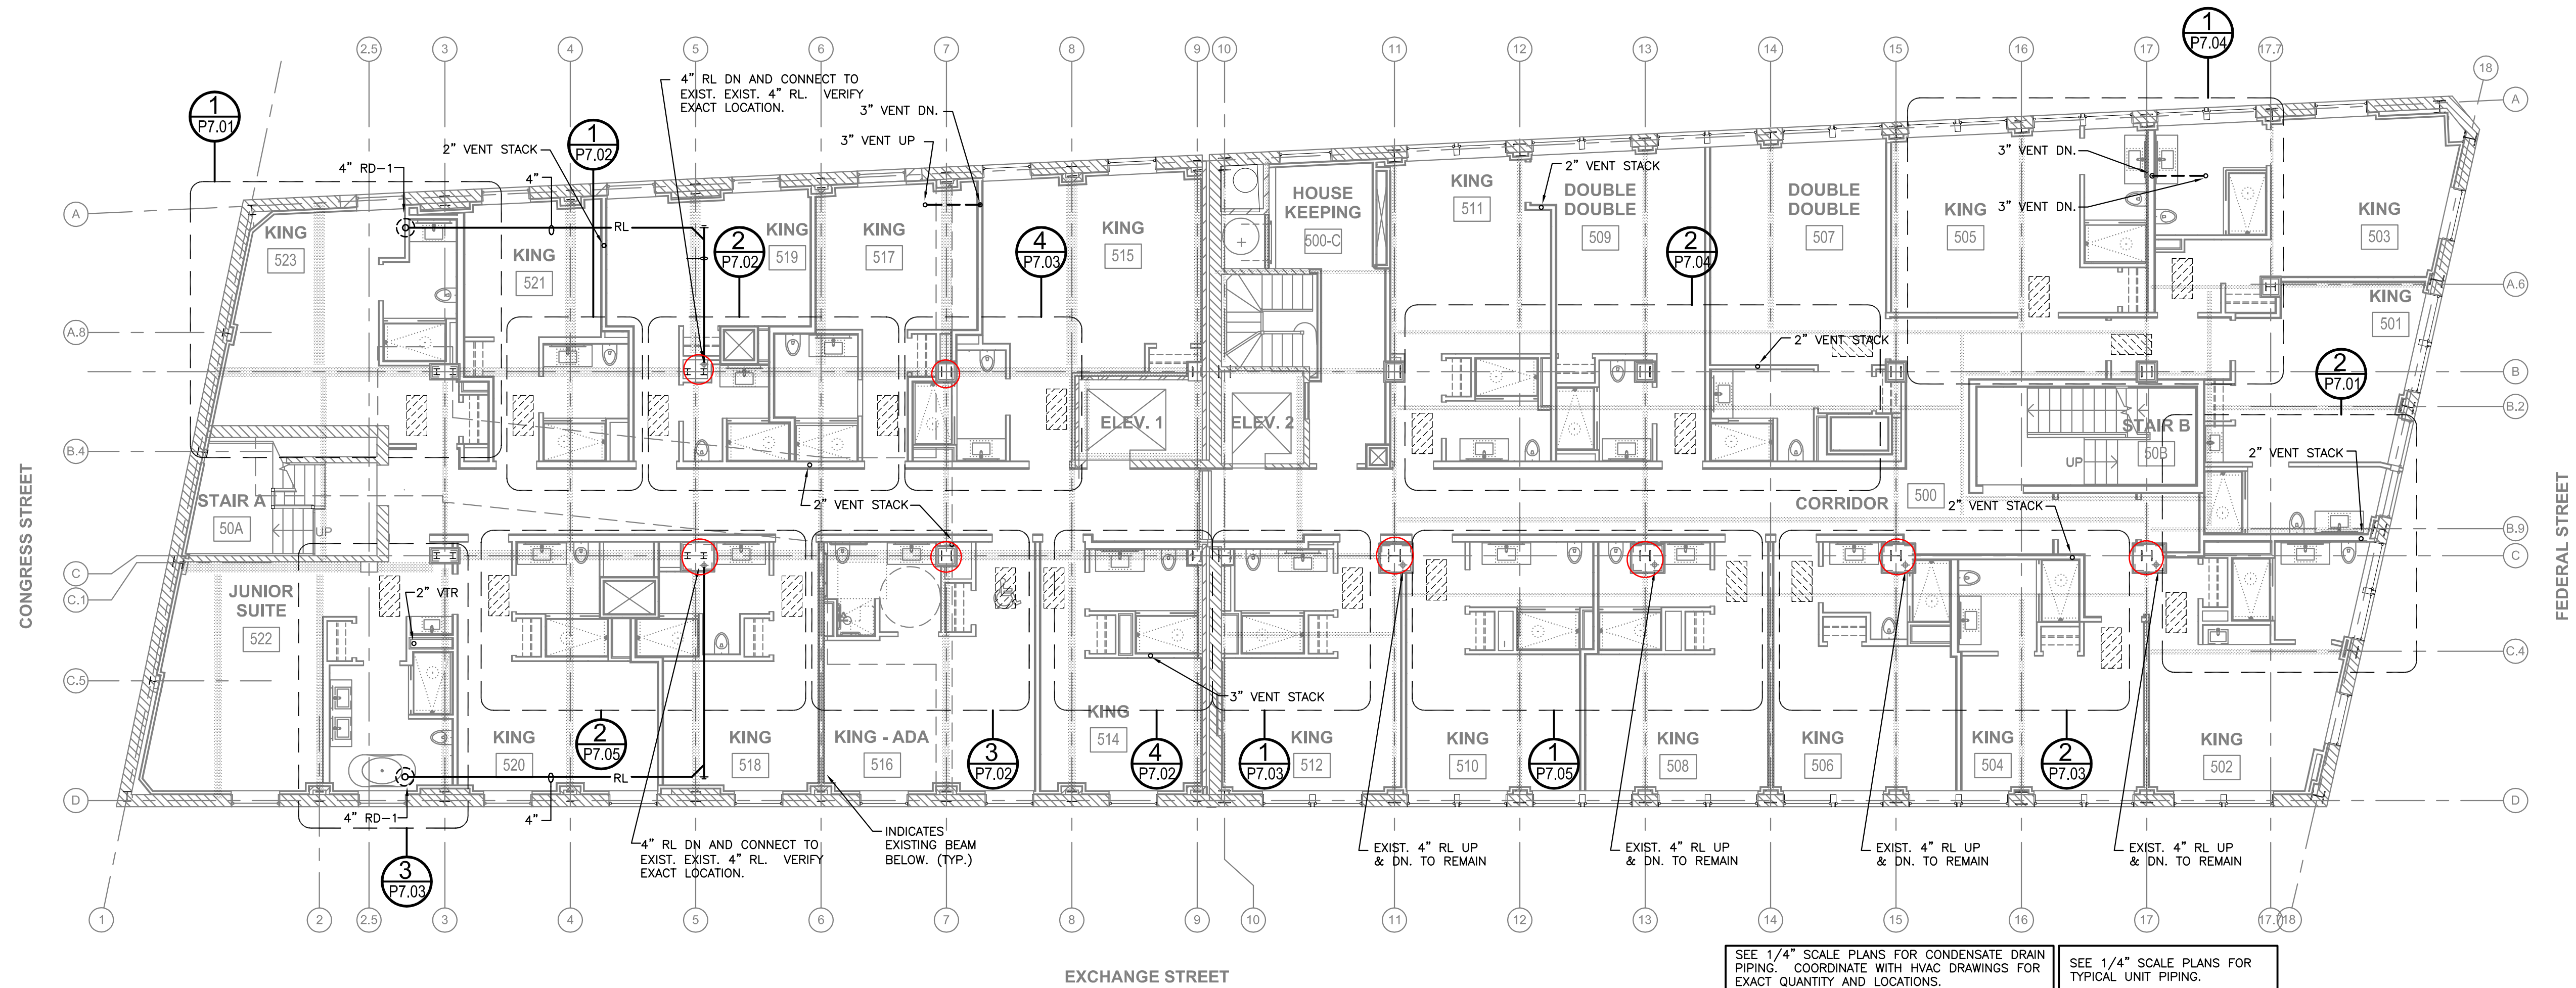

2 FIFTH FLOOR PLAN - WASTE, VENT AND RAIN LEADER
SCALE: 1/8"=1'-0"

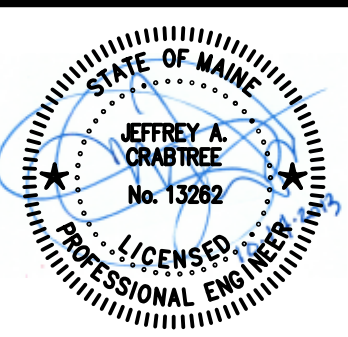

Prepared For:
119 Development, LLC
P.O. Box 7468
Portland, ME 04112

Consultant:
CRABTREE ENGINEERING
278 AMELIA COVE
COLLIERVILLE, TN 38017
PLUMBING: bob@crabtreeeng.com

Architect:
ARCHETYPE architects
48 Union Wharf Portland, Maine 04101
(207) 772-6022 Fax (207) 772-4056

Project:
PRESS HOTEL
390 CONGRESS STREET
PORTLAND, ME 04101

Revisions:
1 13-07-01 30% Marriott Submission
2 13-09-09 60% Marriott Sub. & Pric.
3 13-10-14 Issue for Bid & Marriott Rev

Date: 13 October 2013
Scale: 1/8" = 1'-0"
FIFTH FLOOR PLANS - PLUMBING

P5.00