

Prepared For:
119 Development, LLC
 P.O. Box 7468
 Portland, ME 04112

Consultant:
CRABTREE ENGINEERING
 278 AMELIA COVE
 COLLIERVILLE, TN 38017
 PLUMBING: bobhygonak@gmail.com

Architect:
ARCHETYPE architects
 48 Union Wharf Portland, Maine 04101
 (207) 772-6022 Fax (207) 772-4056


Project:
PRESS HOTEL
 390 CONGRESS STREET
 PORTLAND, ME 04101

Revisions:


1	13_07-01	30% Marriott Submission
2	13_09-09	60% Marriott Sub. & Pric.
3	13_10-14	Issue for Bid & Marriott Revw.

Date: 13 October 2013
 Scale: 1/8" = 1'-0"
7TH FLOOR PLANS - PLUMBING

P7.00

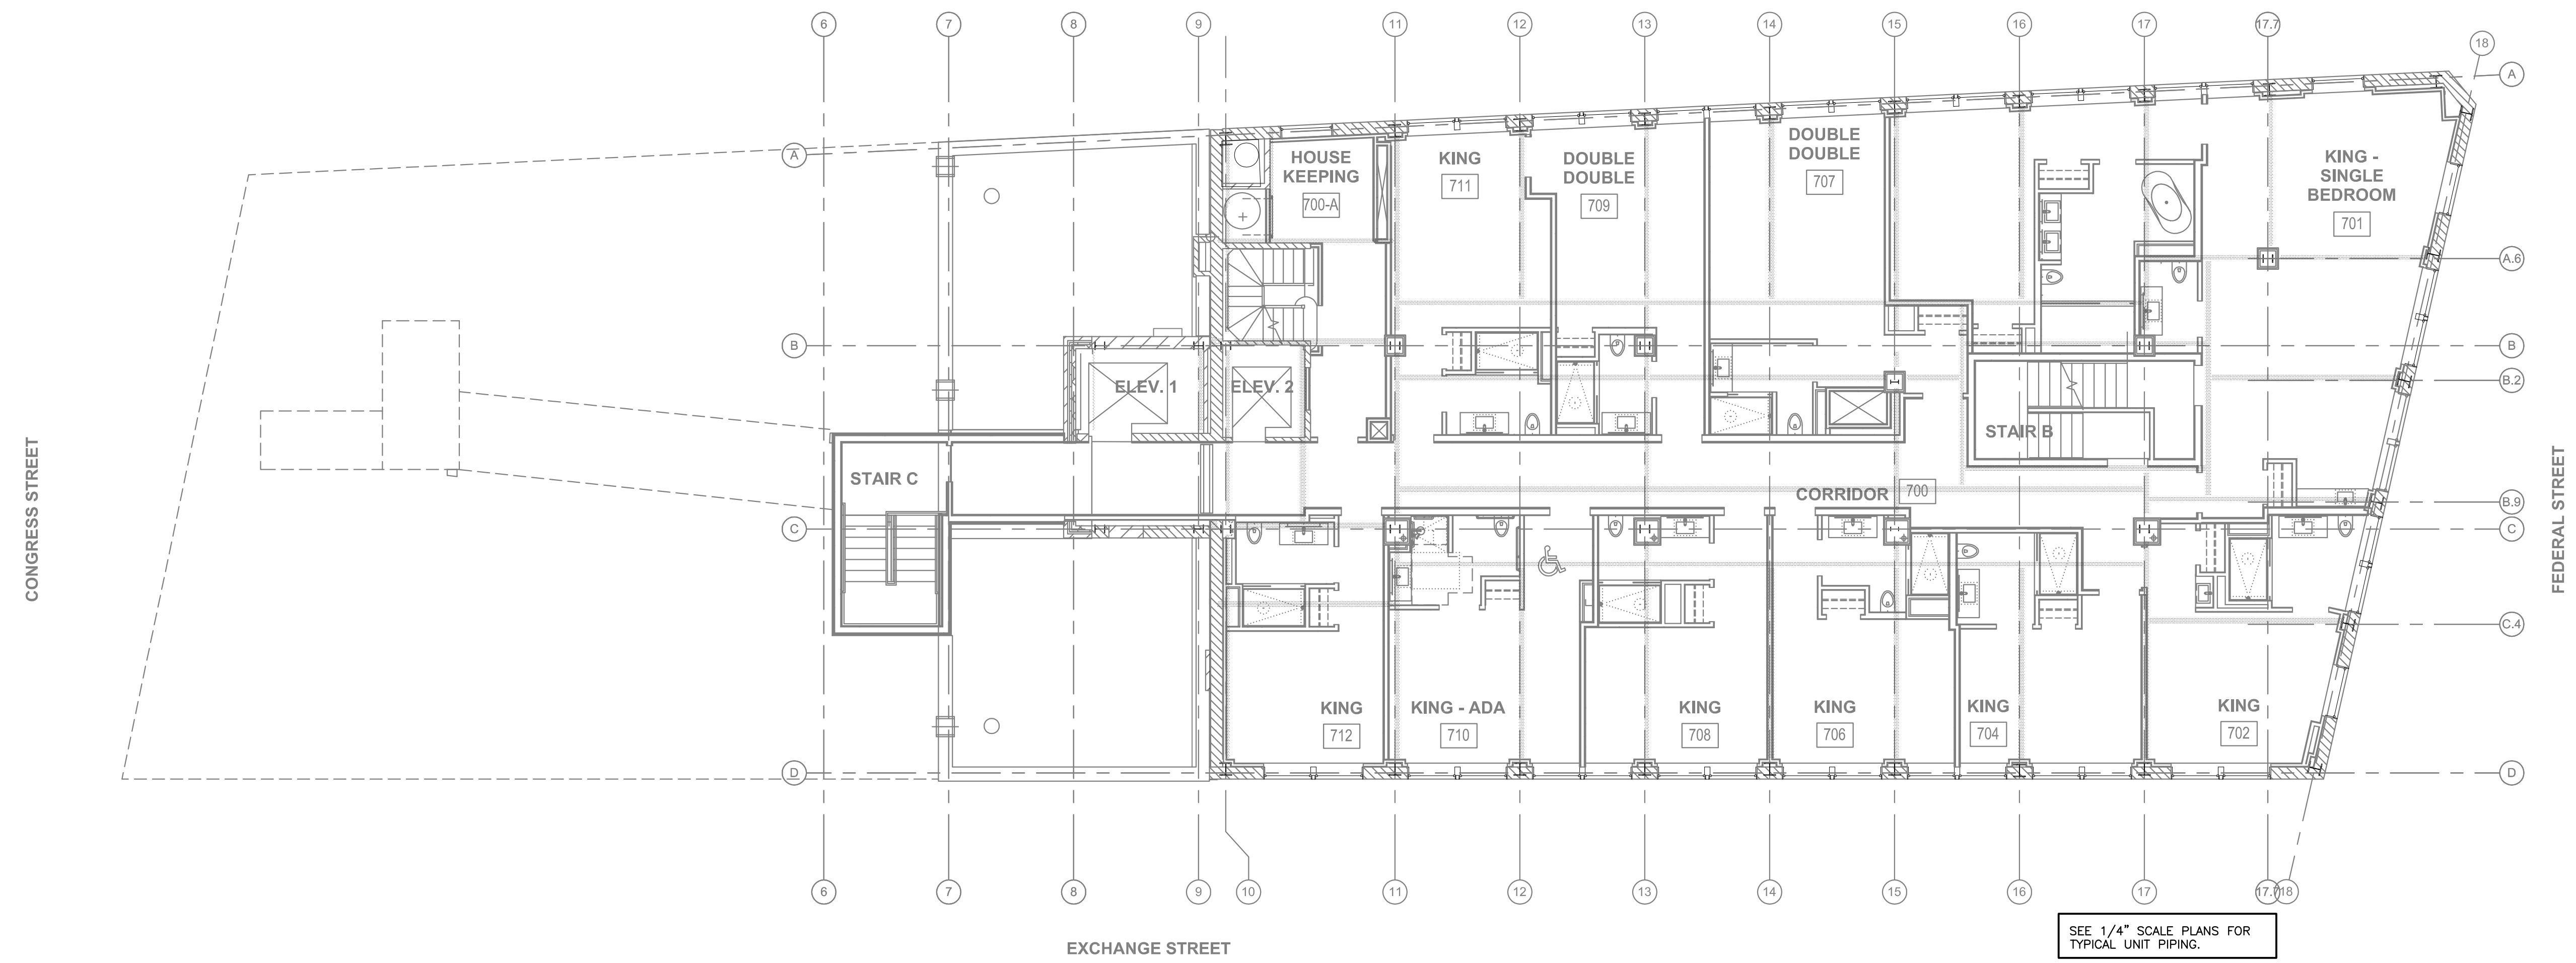

1 SEVENTH FLOOR PLAN - WATER
 SCALE: 1/8"=1'-0"

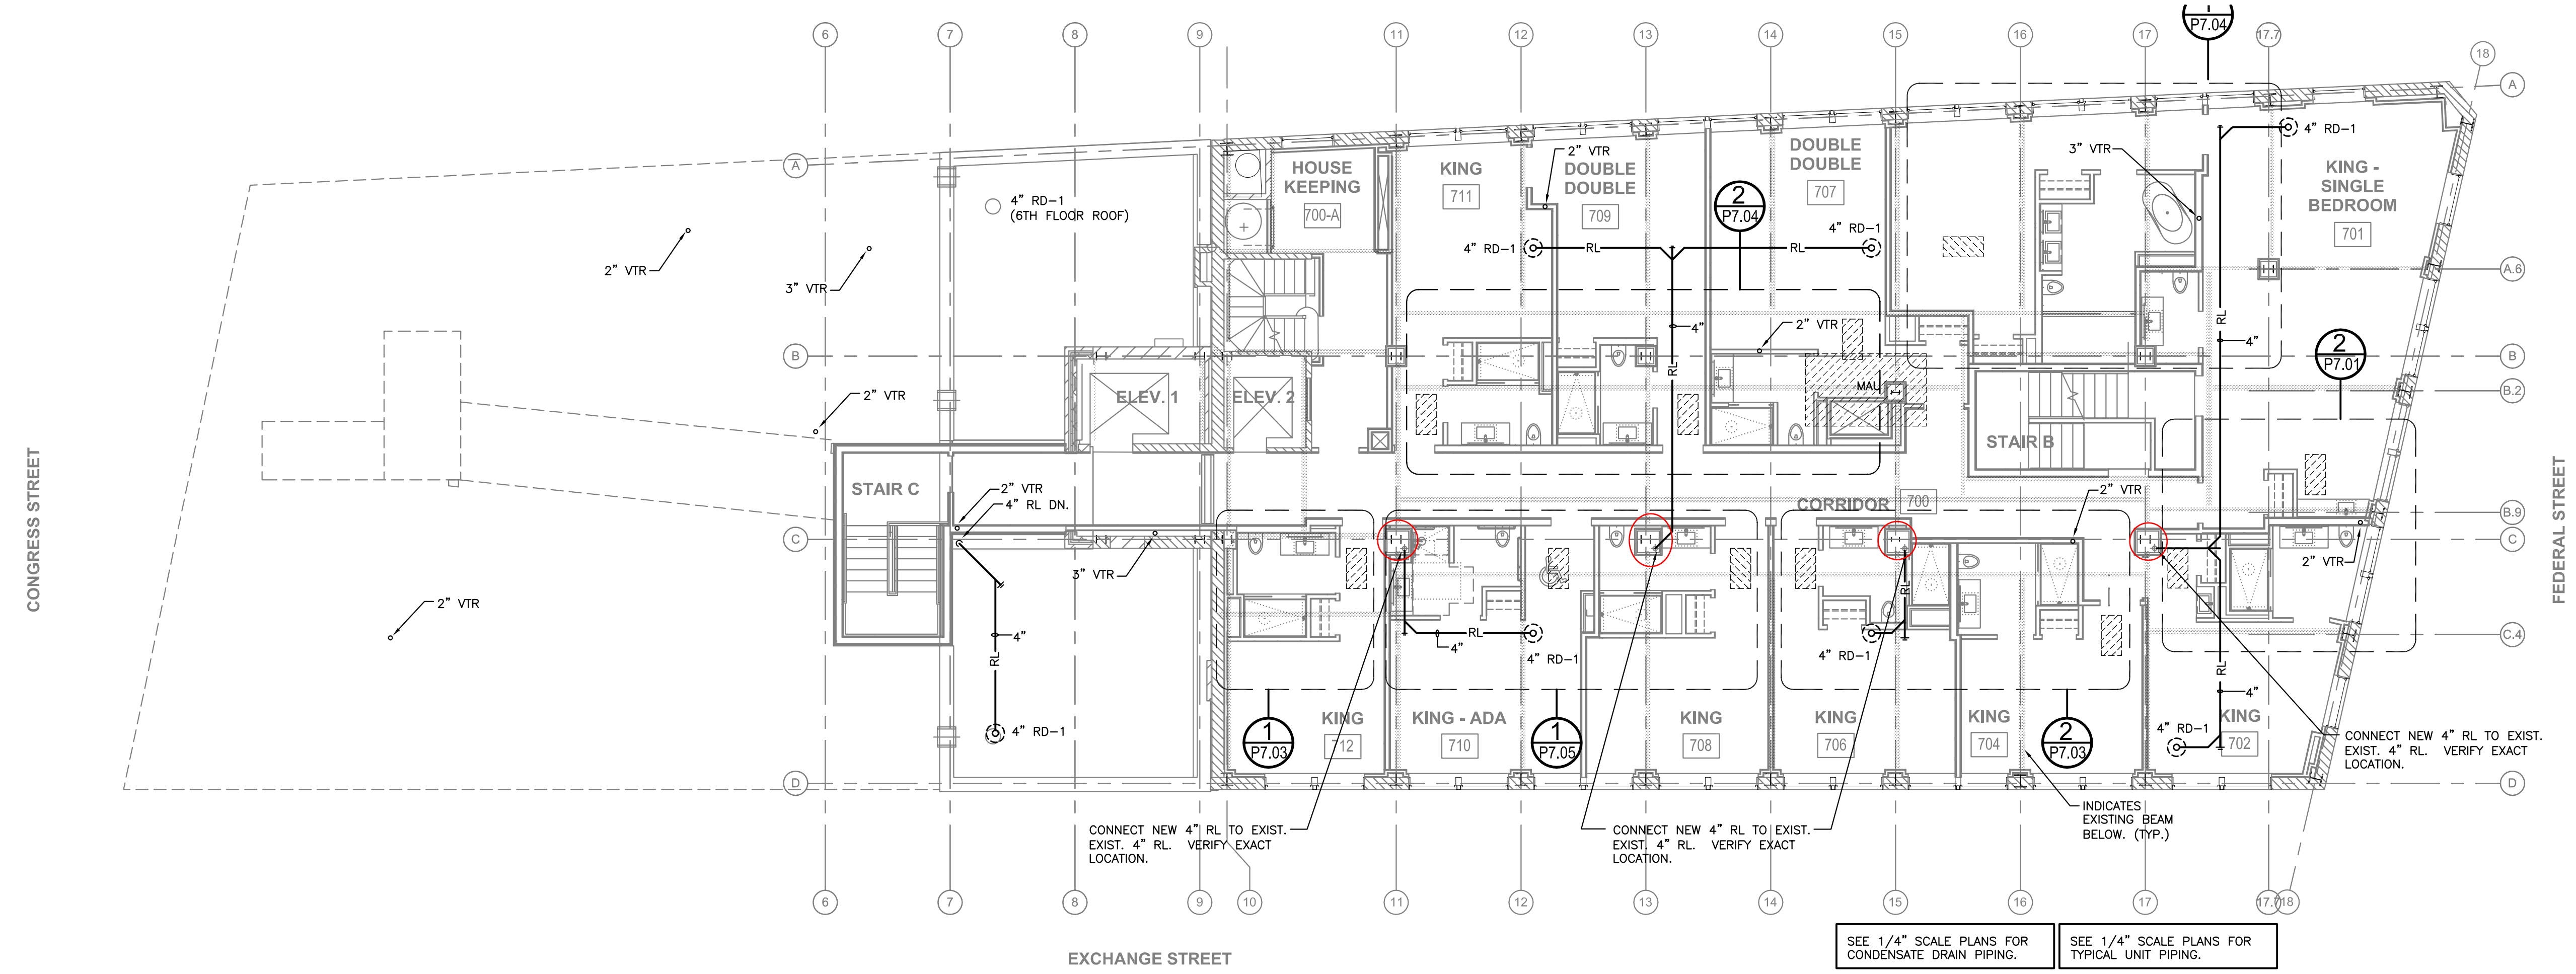

2 SEVENTH FLOOR PLAN - WASTE, VENT AND RAIN LEADER
 SCALE: 1/8"=1'-0"

SEE 1/4" SCALE PLANS FOR TYPICAL UNIT PIPING.

SEE 1/4" SCALE PLANS FOR CONDENSATE DRAIN PIPING.

SEE 1/4" SCALE PLANS FOR TYPICAL UNIT PIPING.