



REFER TO DRAWINGS AND SCHEDULES BY KNLD AND STONEHILL TAYLOR FOR ADDITIONAL LIGHTING INFORMATION

REFER TO SHEET E4.02 AND E4.03 FOR LIGHTING CONTROL PANEL SCHEDULES AND DIAGRAMS

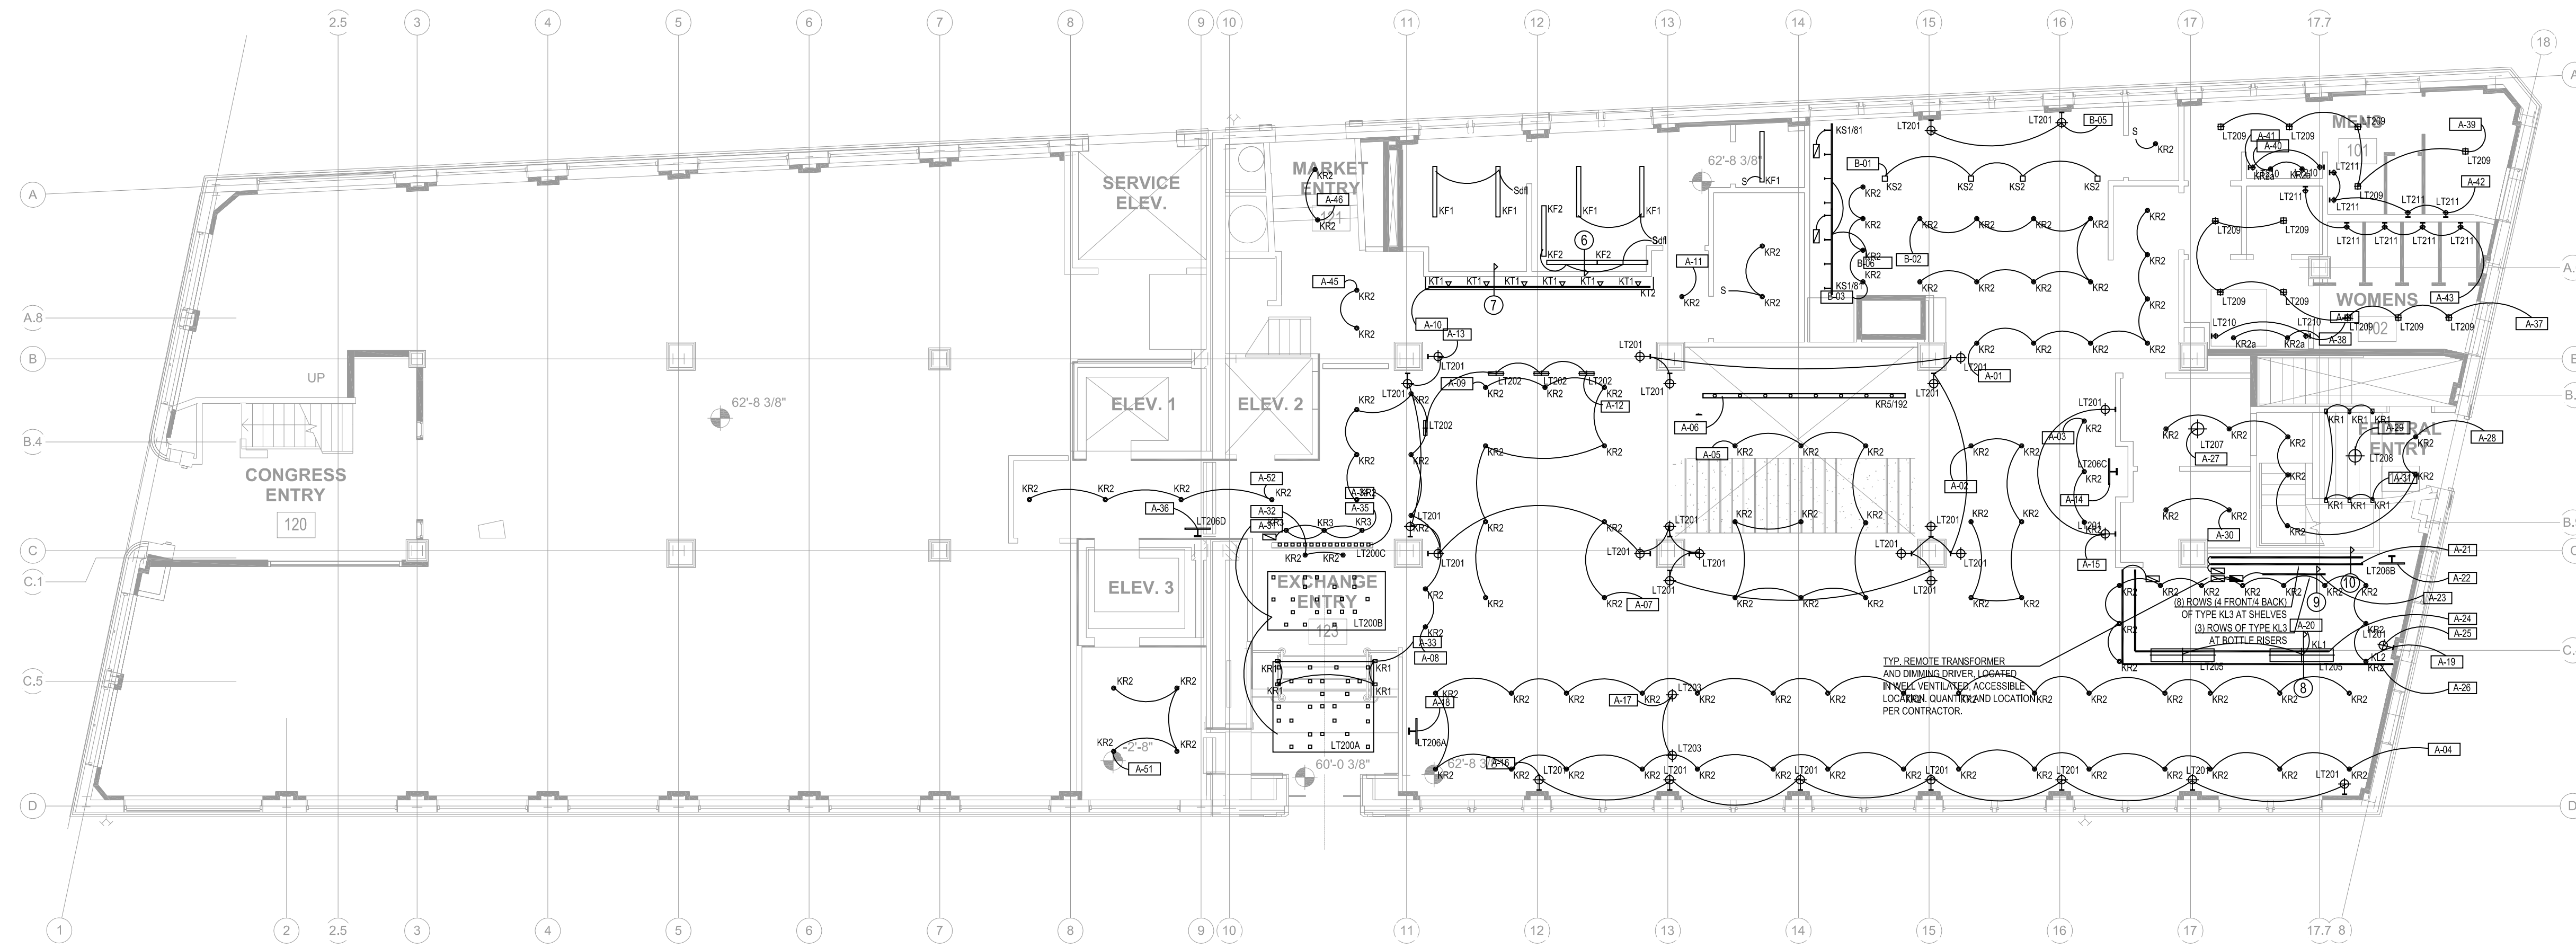

1 FIRST FLOOR LIGHTING PLAN
SCALE: 1/8"=1'-0"

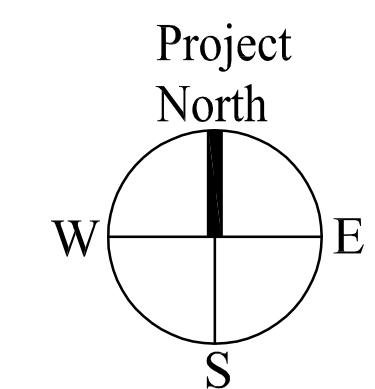

Prepared For:
119 Development, LLC
P.O. Box 7468
Portland, ME 04112

Consultant:
CHS ENGINEERING
CONSTANCE HIGKEY SCOTT, PE
7846 WOOD OAK COVE
CORDOVA, TN 38016
TEL: (901) 830-5300
EMAIL: chscoot@chsengineering.com

Architect:
ARCHETYPE architects
48 Union Wharf Portland, Maine 04101
(207) 772-6022 Fax (207) 772-4056

Project:
Press Hotel
119 Exchange St.
Portland, ME 04101

Revisions:
ISSUED FOR BID 10/14/13

Scale:
FIRST FLOOR LIGHTING PLAN

Date:
E2.01A