



REFER TO SHEET E4.01 FOR MECHANICAL EQUIPMENT SCHEDULES

2 | ELEVATOR MACHINE ROOM ELECTRICAL PLAN
SCALE: 1/8"=1'-0"

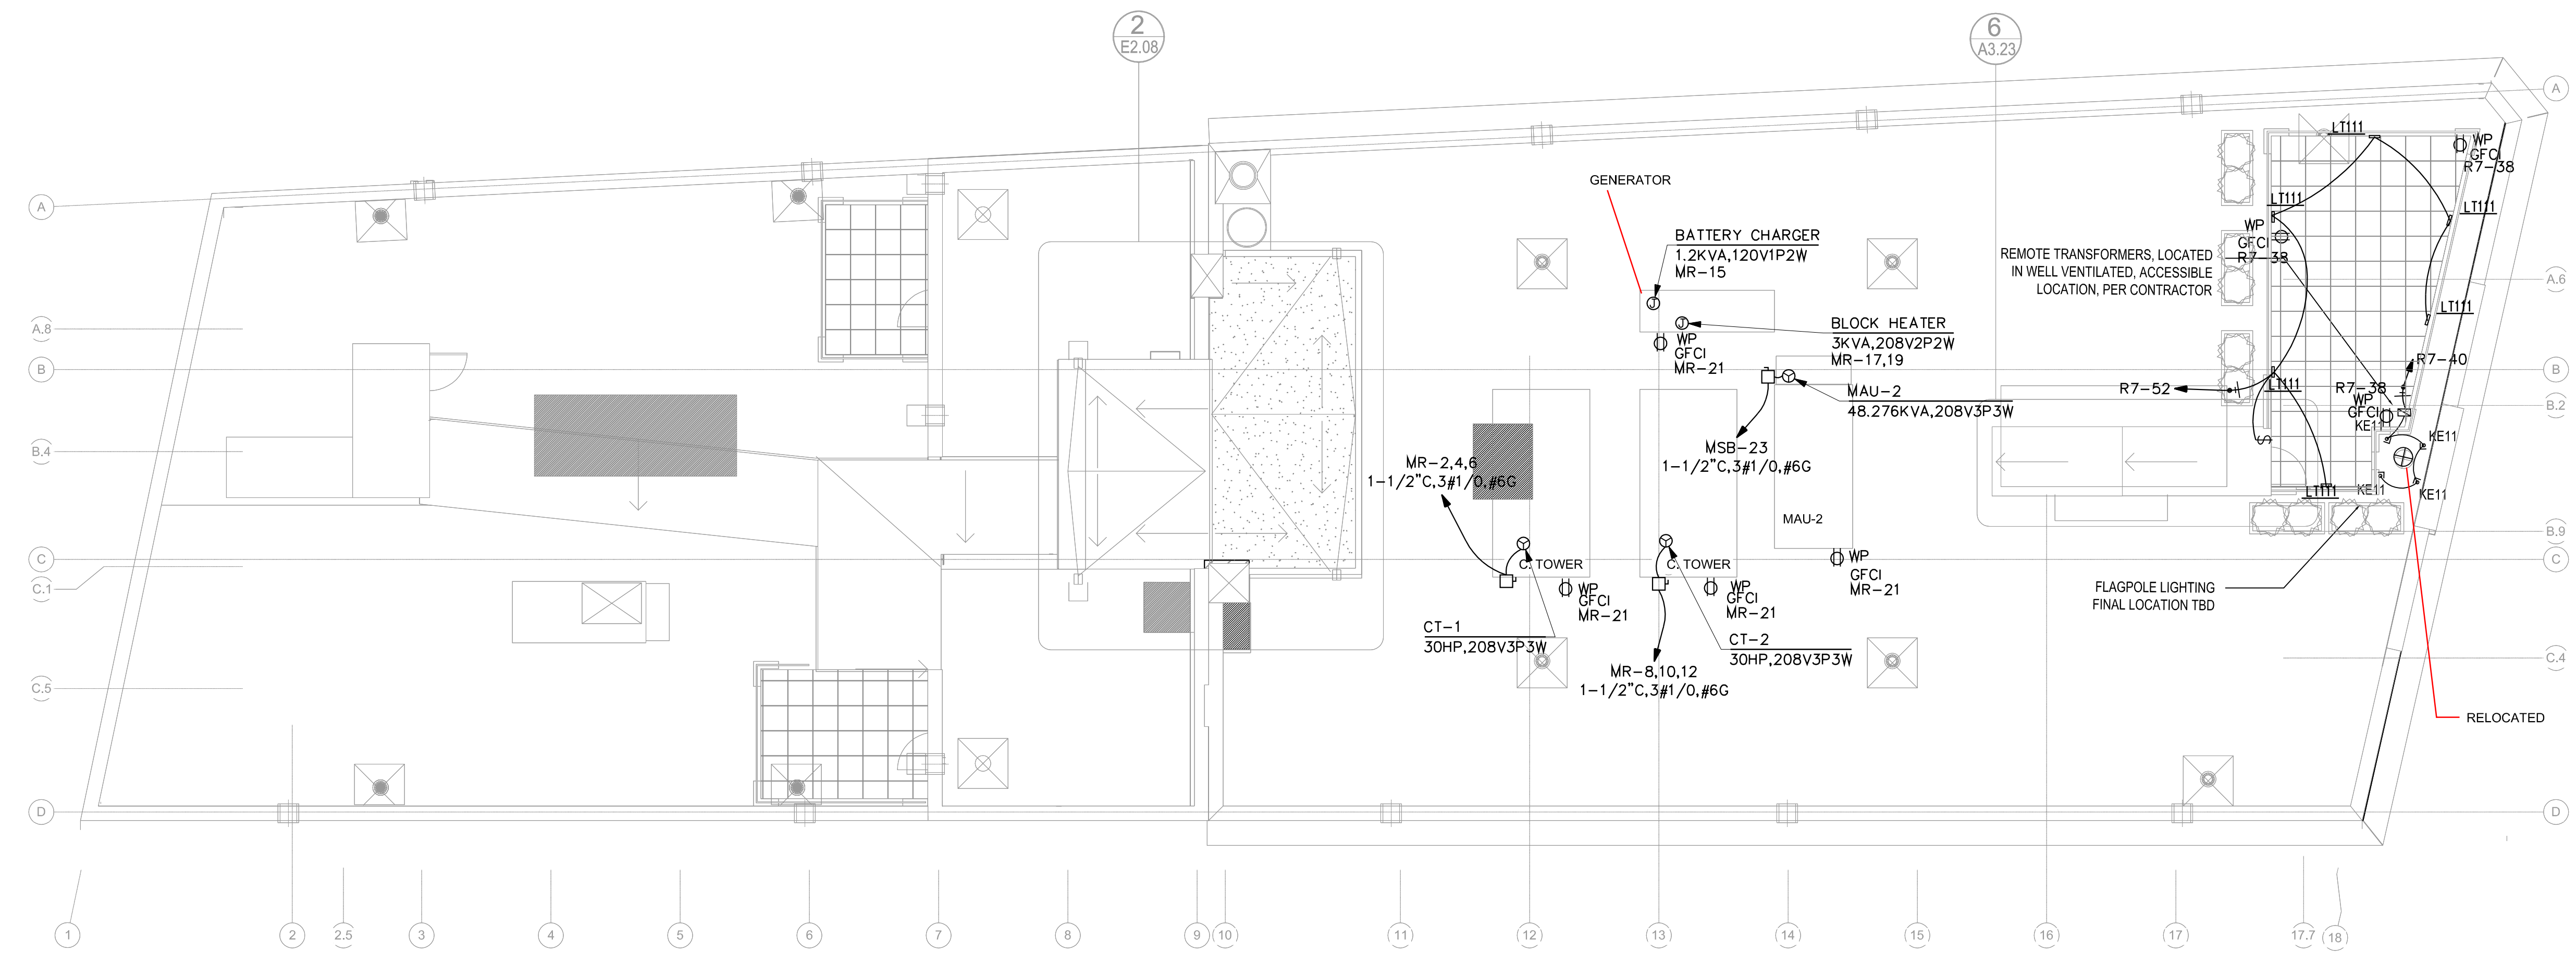

1 | ROOFTOP ELECTRICAL PLAN
SCALE: 1/8"=1'-0"

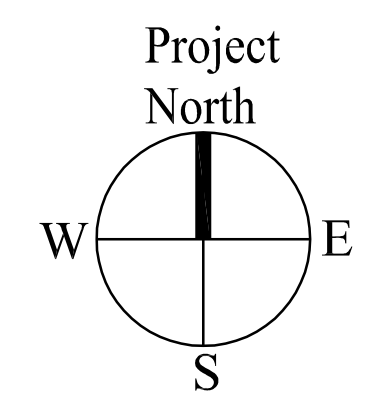

Prepared For:	119 Development, LLC P.O. Box 7468 Portland, ME 04112
Consultant:	CJS ENGINEERING CONSTANCE HIGKEY SCOTT, PE 7846 WOOD OAK COVE CORDOVA, TN 38016 TEL: (901) 830-5300 EMAIL: chscott@cjsengineering.com
Architect:	ARCHETYPE Architects 48 Union Wharf Portland, Maine 04101 (207) 772-6022 Fax (207) 772-4056
Project:	Press Hotel 119 Exchange St. Portland, ME 04101
Revisions:	ISSUED FOR BID 10/14/13
Scale:	ROOFTOP ELECTRICAL PLAN
Date:	E2.08