


LAST PRINTED: 5/29/2014 3:07:56 PM

LAST PRINTED: 5/29/2014 3:07:56 PM

24" x 36" - Arch D Size

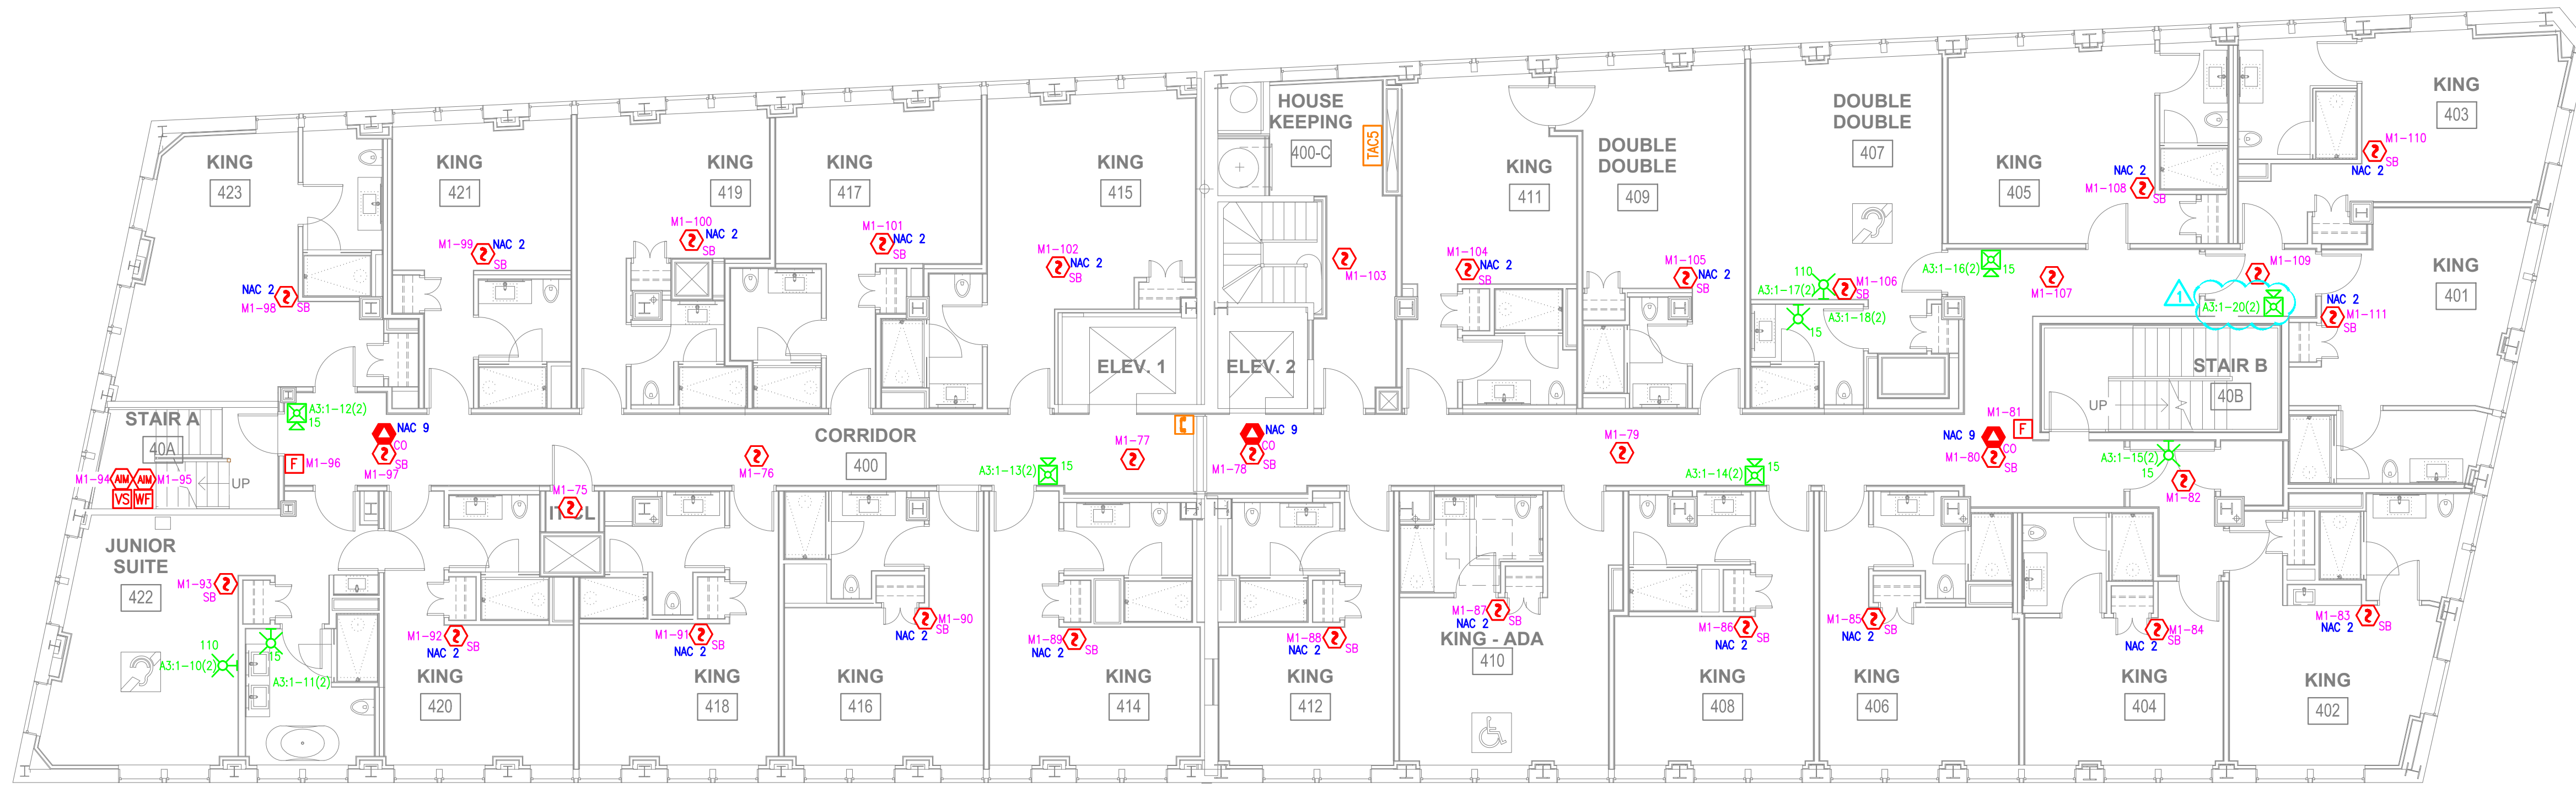

**FOURTH FLOOR DEVICE PLACEMENT PLAN**

SCALE: 1/8"=1'-0"



(IN FEET)

**PRESS HOTEL**

PRESS HOTEL  
119 EXCHANGE ST  
PORTLAND, ME

ISSUE NO.	DATE	CD	CHK	DESCRIPTION
1	5/29/14	SD	RS	REVISED PER ENGINEER'S COMMENTS & ADDED AFR SYSTEM

DRAWN BY:	JD
CHECKED BY:	IG
ISSUE DATE:	4/24/14
JOB #:	977465501
PROJECT #:	147:PRE-BOOKED
SIMPLEXGRINNELL ©	2013

SYSTEM:  
FIRE ALARM SYSTEM

SHEET:  
FOURTH FLOOR DEVICE  
PLACEMENT PLAN

FA-106

IMPORTANT NOTICE TO USER: This drawing is the property of Tyco Fire Protection Products, Inc. and is not to be reproduced, stored in a retrieval system, or transmitted in any form or by any means, electronic, mechanical, photocopying, recording, or by any information storage and retrieval system, without the prior written permission of Tyco Fire Protection Products, Inc. This information may not be sold or transferred to any third party, used or other projects or addresses to the project for which it was prepared, or used for completion of this project by any third party. SimplexGrinnell assumes all liability for the use or reuse of this drawing.