
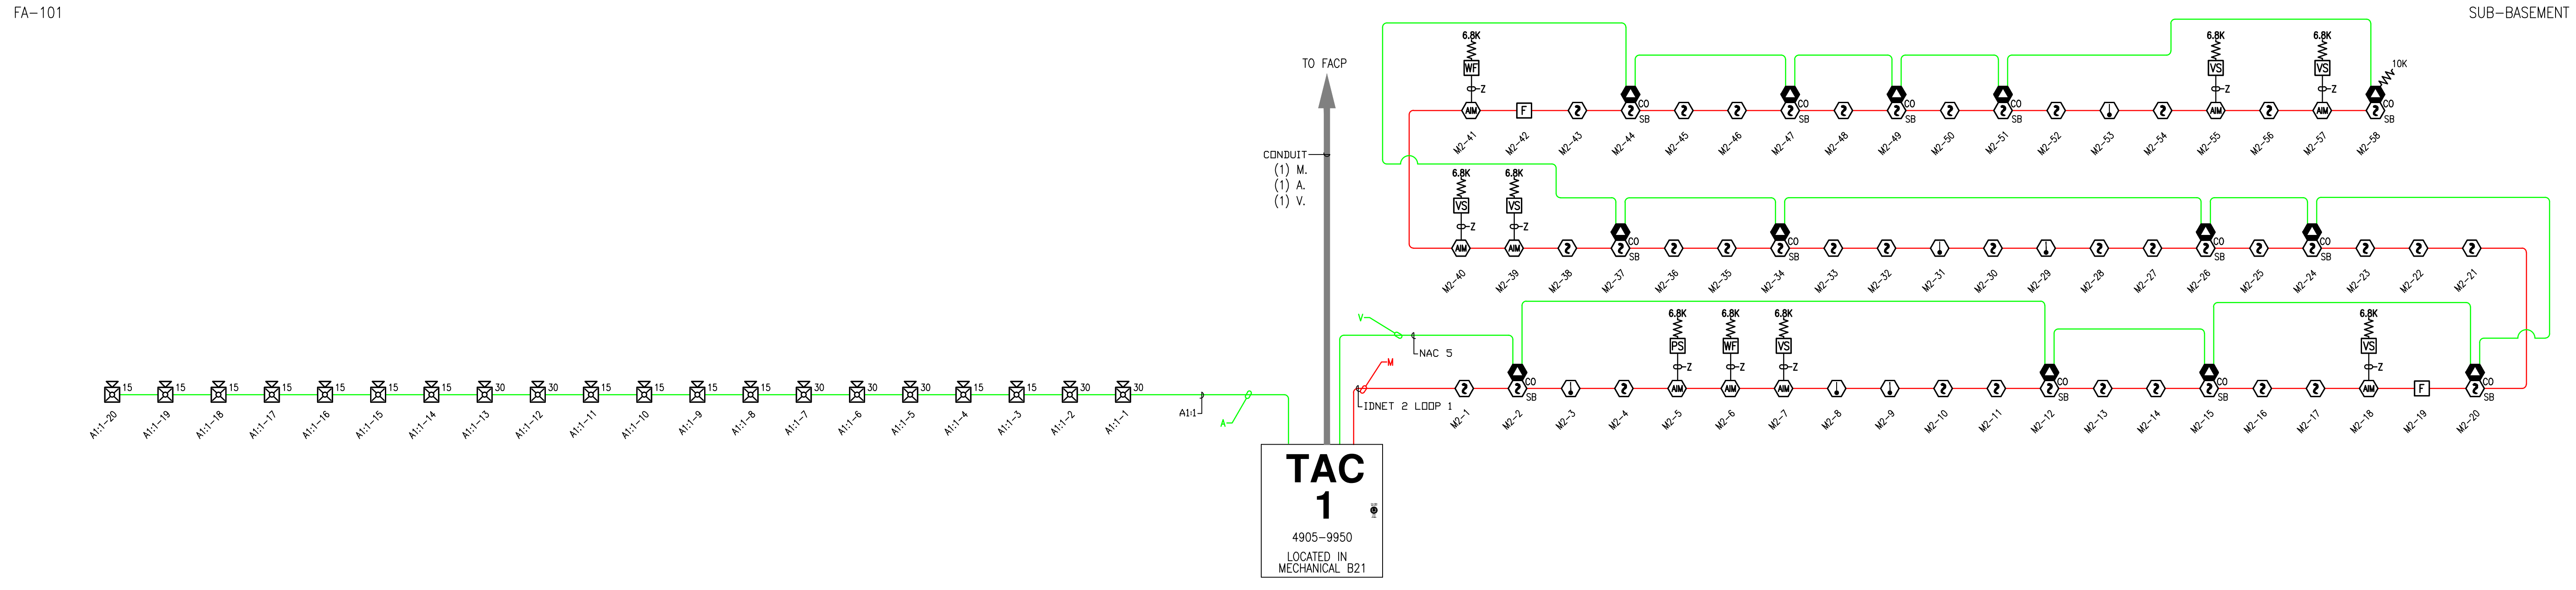


LAST PRINTED: 5/29/2014 3:08:18 PM

LAST PRINTED: 5/29/2014 3:08:18 PM

24" x 36" - Arch D Size

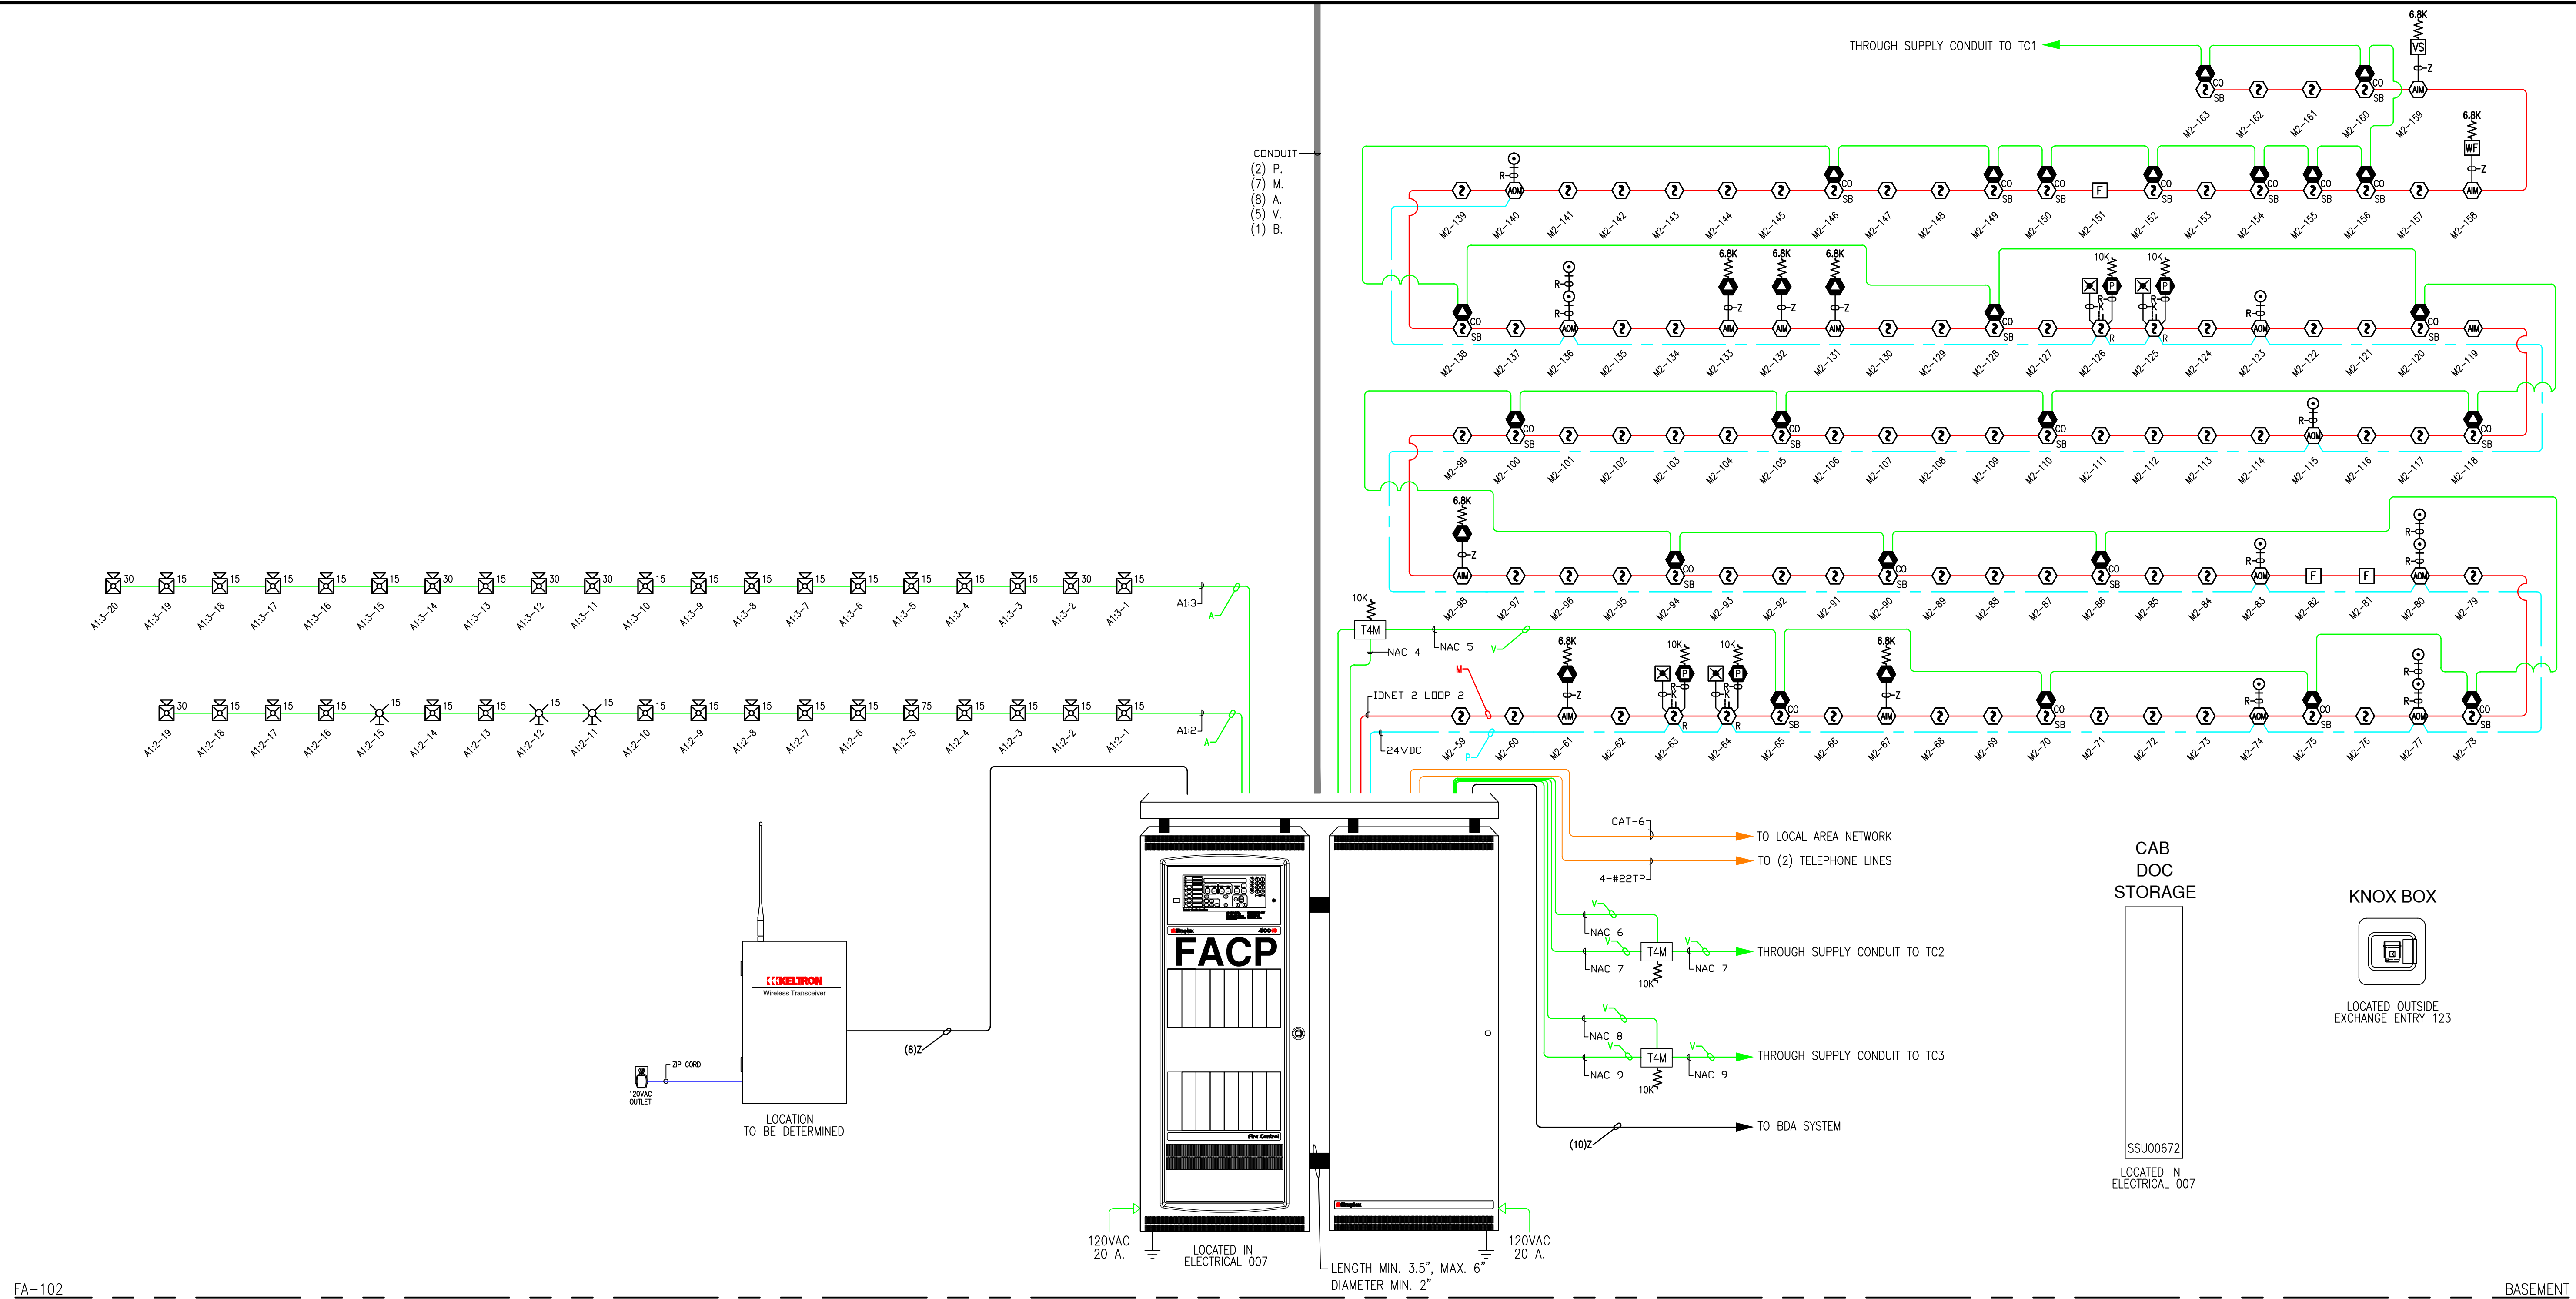

ISSUE NO.	DATE	CHK	DESCRIPTION
1	5/29/14	KS	REVISED PER ENGINEERS COMMENTS & ADDED AER SYSTEM

DRAWN BY:	JD
CHECKED BY:	KG
ISSUE DATE:	4/24/14
JOB #:	977465501
PROJECT #:	147-PRE-BOOKED
SIMPLEXGRINNELL © 2013	
SYSTEM: FIRE ALARM SYSTEM	
SHEET: SUB-BASEMENT TO BASEMENT RISER DIAGRAM	
FA-201	

IMPORTANT NOTICE TO USER: This drawing is the property of Tyco Fire Protection Products, Inc. and is not to be reproduced, stored in a retrieval system, or transmitted in any form or by any means, electronic, mechanical, photocopying, recording, or by any information storage and retrieval system, without the prior written permission of Tyco Fire Protection Products, Inc. The information contained herein is for the project for which it was prepared or used to complete the project. This information may not be used for any other project or address to which it was prepared or used to complete the project. SimplexGrinnell assumes no liability for the use of this information.