

LAST SAVED BY: JUDELACRUZ

LAST PRINTED: 5/29/2014 3:08:29 PM

24" x 36" - Arch D Size

FA-109

FA-108

FA-107


FA-106

SEVENTH FLOOR

SIXTH FLOOR

FIFTH FLOOR

FOURTH FLOOR

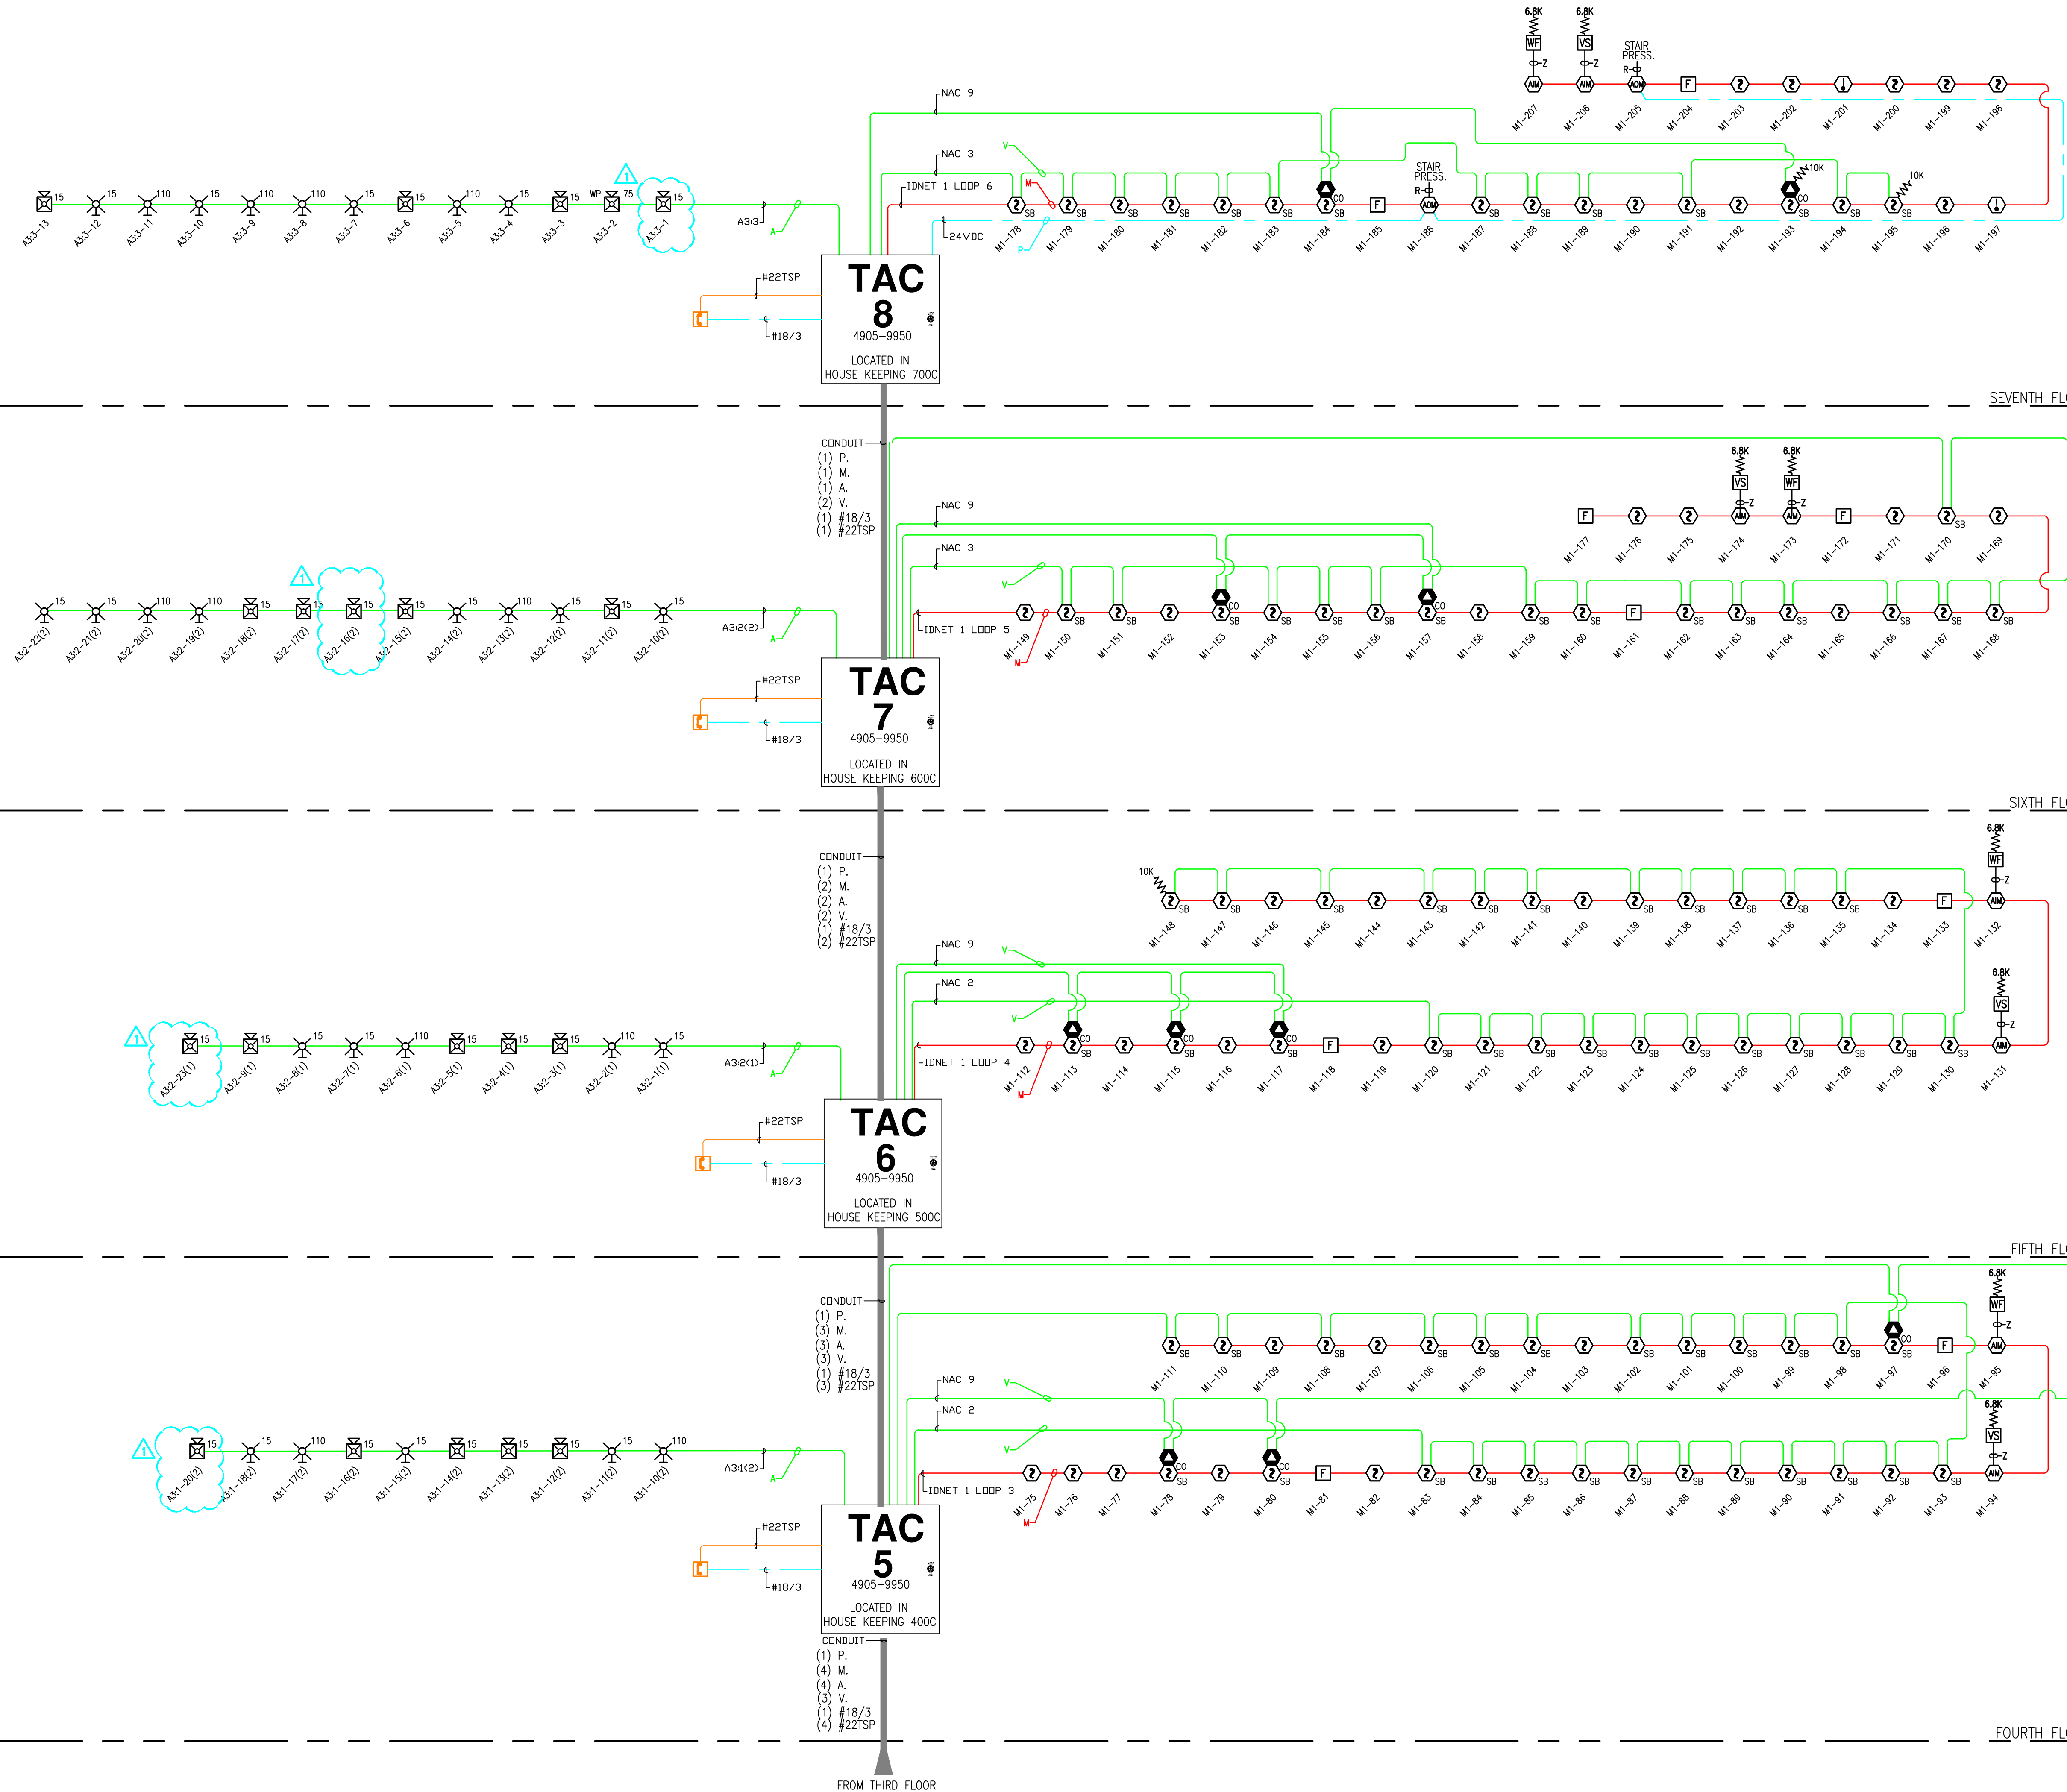

tyco
SimplexGrinnell
Safer. Smarter. Tyco.[®]
DISTRICT - HF
WESTBROOK, ME 04092
SERVICE: 207-842-6440
PHONE: 207-842-4440
FAX: 207-842-6439

PRESS HOTEL

PRESS HOTEL
119 EXCHANGE ST
PORTLAND, ME

ISSUE NO.	DATE	CHK	DESCRIPTION
1	5/29/14	KS	REVISED PER ENGINEERS COMMENTS & ADDED AGR SYSTEM

DRAWN BY:	JD
CHECKED BY:	KG
ISSUE DATE:	4/24/14
JOB #:	977465501
PROJECT #:	147:PRE-BOOKED
SIMPLEXGRINNELL ©	2013

SYSTEM:
FIRE ALARM SYSTEM

SHEET:

FOURTH TO SEVENTH FLOOR RISER DIAGRAM

IMPORTANT NOTICE: TO USER: The accuracy of every drawing is the responsibility of the drafter. The drafter's responsibility for the accuracy of the drawings shall be limited to the information contained herein and shall be subject to the limitations of the contract. For your review, copying, modification or alteration of the information contained herein shall be at the risk of the user. This information may not be used or transferred to any third party, used or other projects or addresses of the project for which it was prepared or used for completion of this project by any party. SimplexGrinnell assumes no liability for the user or misuse of drawings.