

REMOTE TRANSFORMER TO BE LOCATED IN WELL VENTILATED, ACCESSIBLE LOCATION QUANTITY AND LOCATION PER CONTRACTOR.

LOW VOLTAGE WIRE


TYPE KE9 SURFACE MOUNTED ADJUSTABLE LED TO REPLACE EXISTING FIXTURES IN CANOPY

EXISTING FIXTURES AND LENSES TO BE REMOVED AND REPLACED WITH BLANK METAL PLATE

EXISTING CAVITY

EXISTING EXTERIOR CANOPY

RESTAURANT BUILDING FACADE

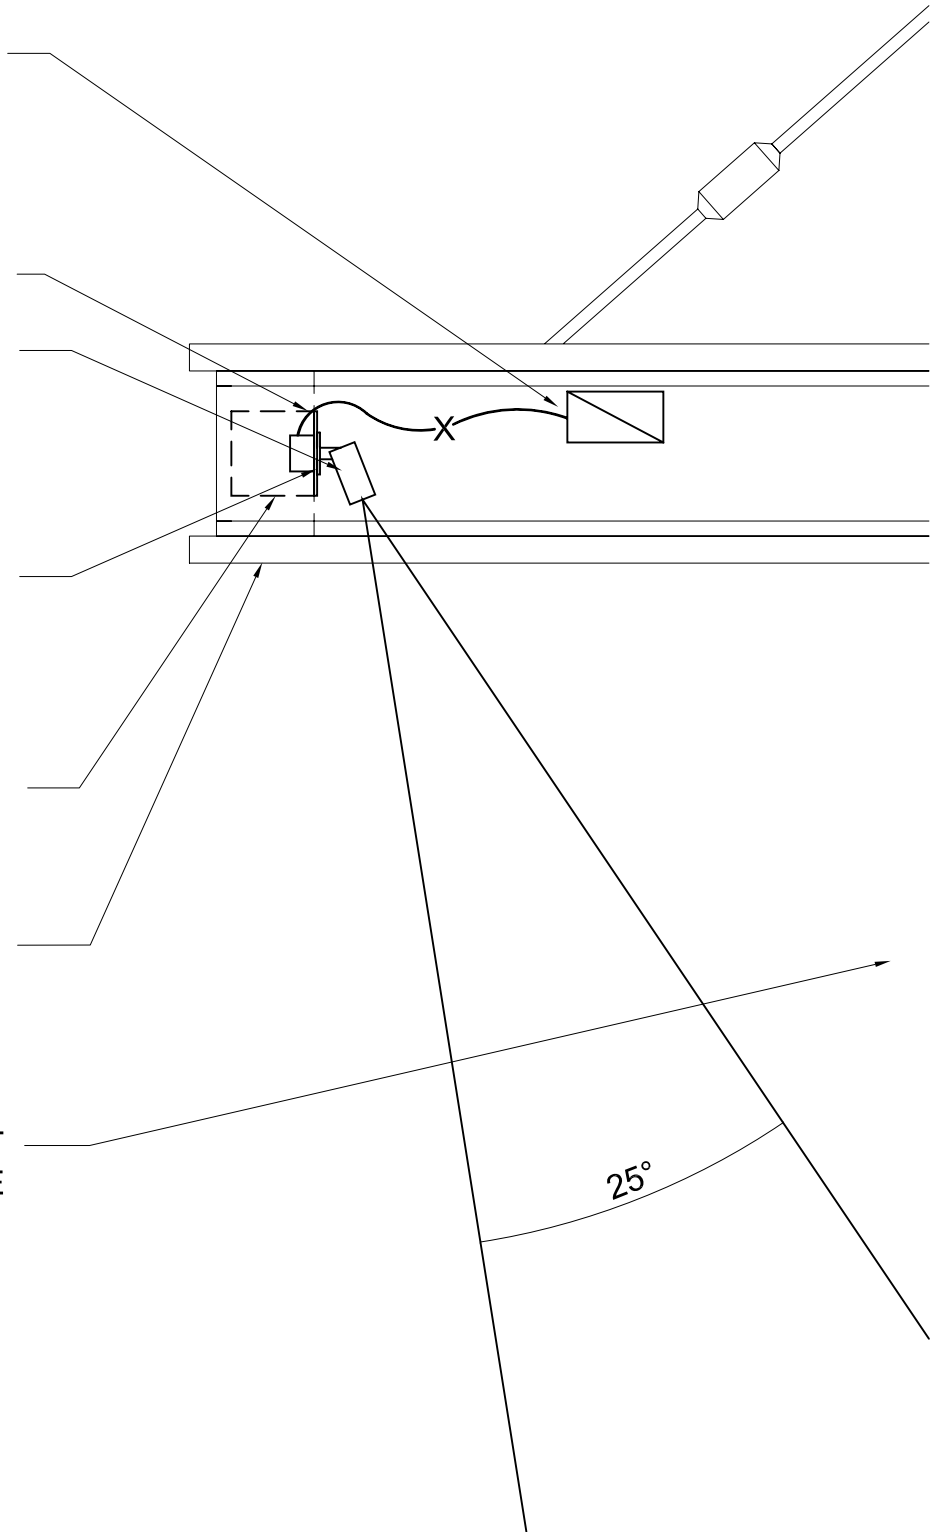

3 CANOPY SECTION

PROJECT NAME:	THE PRESS HOTEL	DATE:	09/20/2013
DRAWING NAME:	RESTAURANT CANOPY SECTION	SCALE:	3/4" = 1'-0"
KUGLER NING	Lighting Design 49 West 38th Street New York, NY 10018 Tel: 212 382 2100 Fax: 212 730 4412	REVISION:	
		01/15/2014	

TYPE KE3
 RECESSED WET LOCATION
 ADJUSTABLE HALOGEN
 DOWNLIGHT TO REPLACE
 EXISTING FIXTURE

5 1/2"

SOFFIT


EQ

EQ

⌀


WALL BEHIND

ENTRY DOOR TO
 RESTAURANT

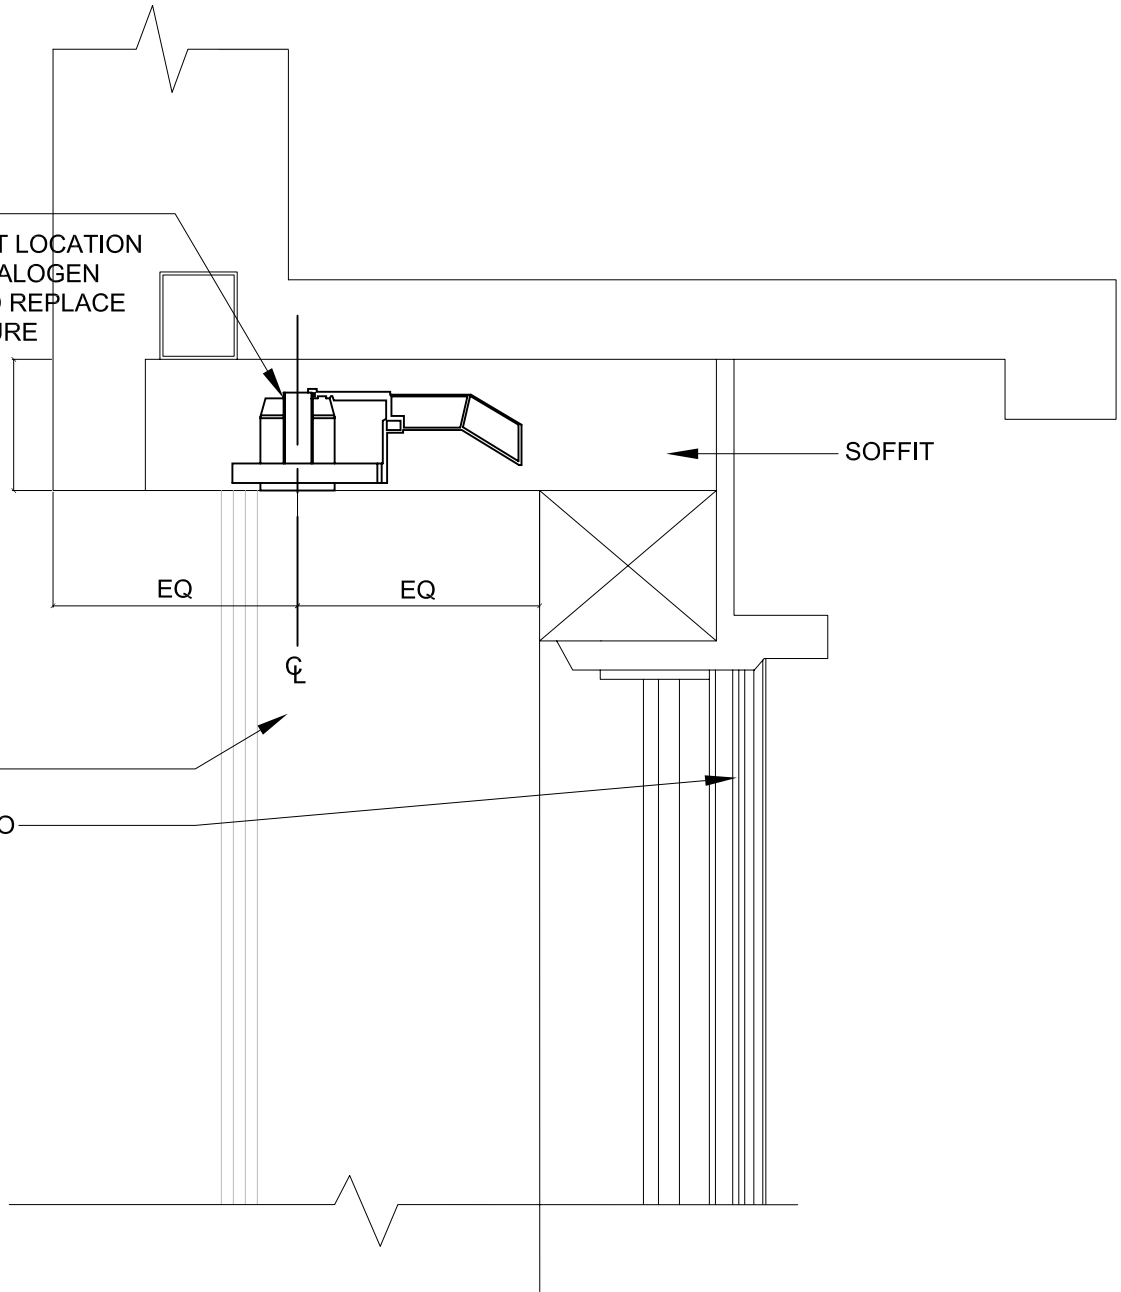


4 VESTIBULE SECTION

PROJECT NAME:	THE PRESS HOTEL	DATE:	09/20/2013
DRAWING NAME:	RESTAURANT VESTIBULE SECTION	SCALE:	1-1/2" = 1'-0"
KUGLER NING	Lighting Design 49 West 38th Street New York, NY 10018 Tel: 212 382 2100 Fax: 212 730 4412	REVISION:	
		01/15/2014	

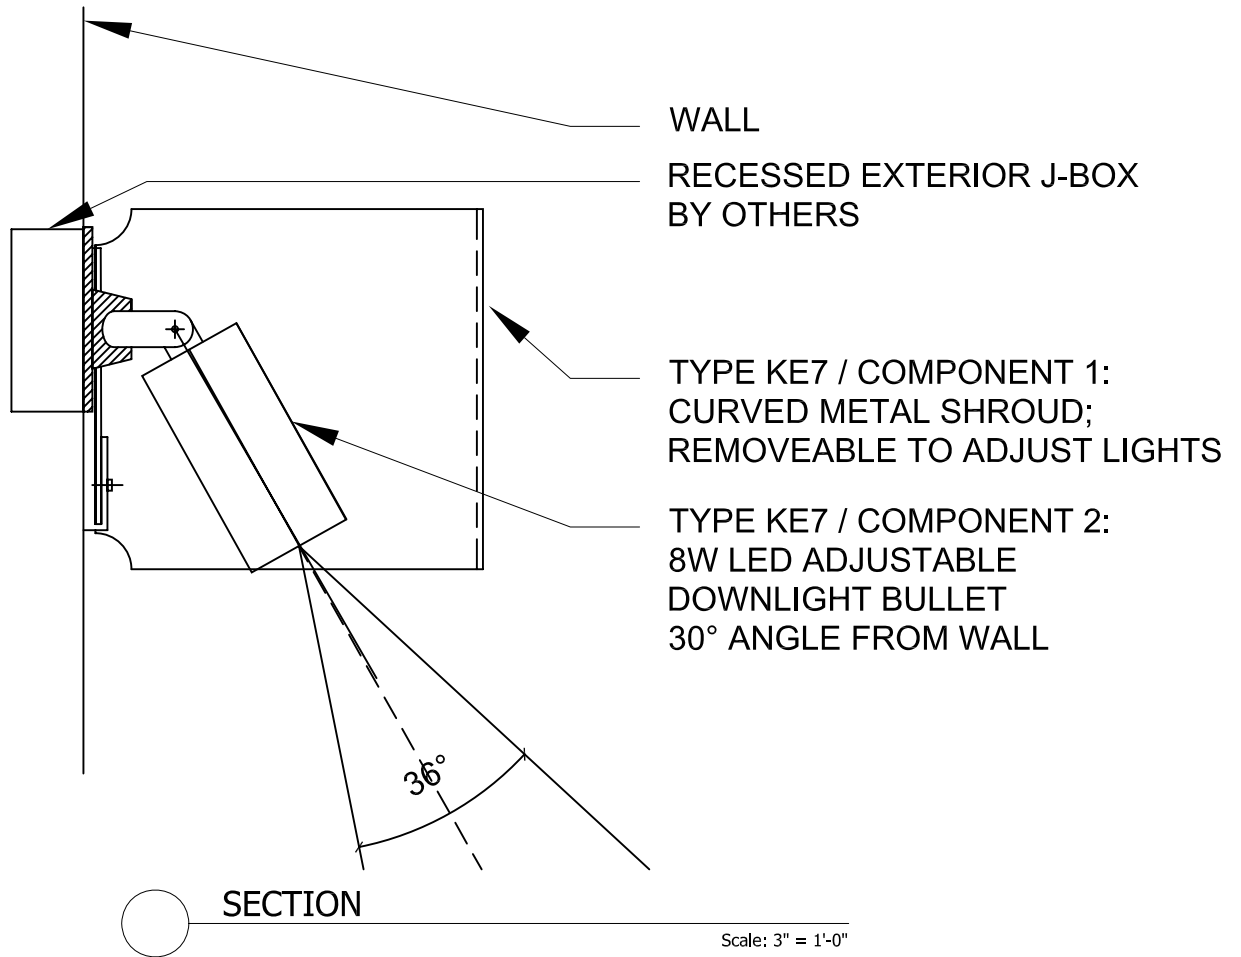


1'-2"

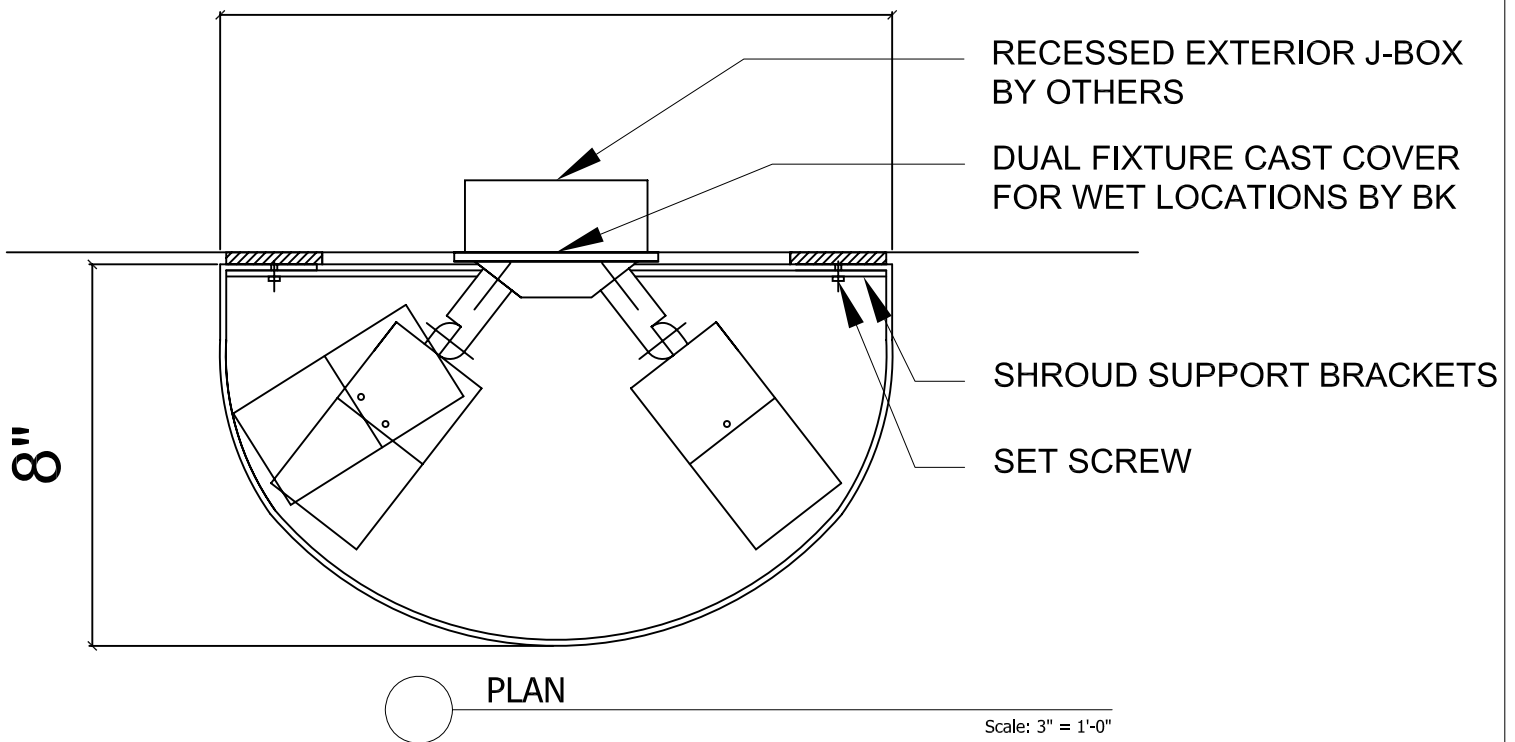

PROJECT NAME:	THE PRESS HOTEL	DATE:	01/15/2014
DRAWING NAME:	HOTEL CANOPY DETAIL	SCALE:	AS NOTED
KUGLER NING	Lighting Design 49 West 38th Street New York, NY 10018 Tel: 212 382 2100 Fax: 212 730 4412	REVISION:	

7 1/2"

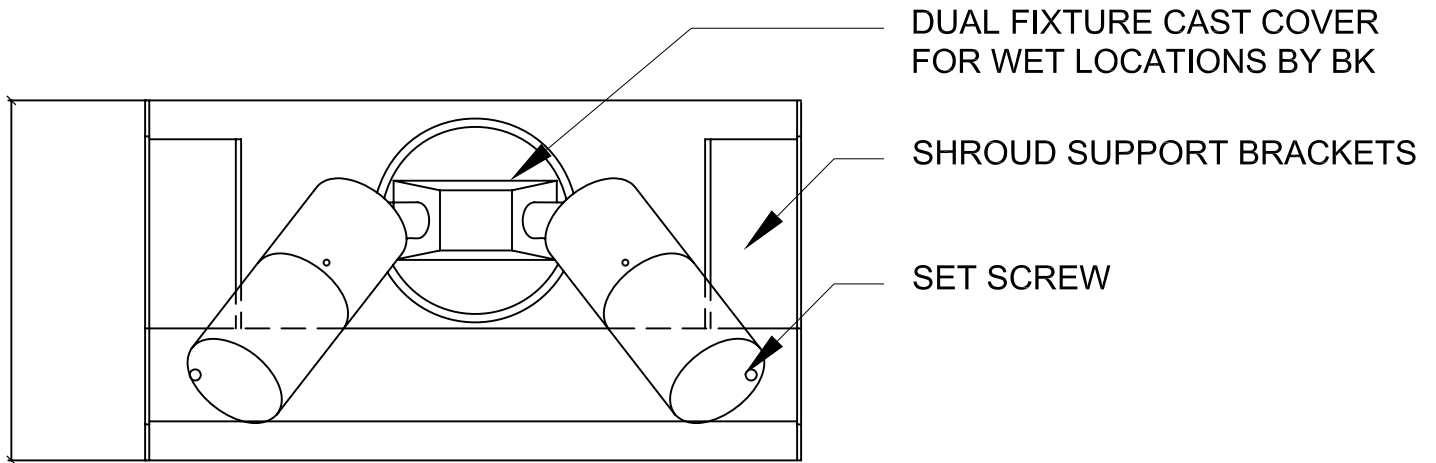


SECTION

Scale: 3" = 1'-0"



FRONT ELEVATION

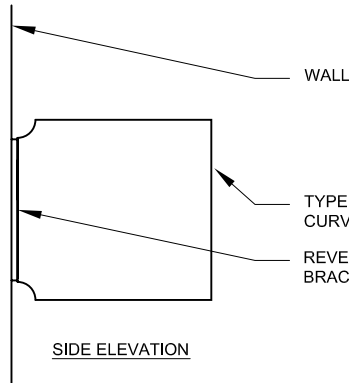


SIDE ELEVATION


ELEVATIONS

Scale: 1 1/2" = 1'-0"

PROJECT NAME:	THE PRESS HOTEL	DATE:	01/15/2014
DRAWING NAME:	HOTEL CANOPY DETAIL	SCALE:	AS NOTED
KUGLER NING	Lighting Design 49 West 38th Street New York, NY 10018 Tel: 212 382 2100 Fax: 212 730 4412	REVISION:	

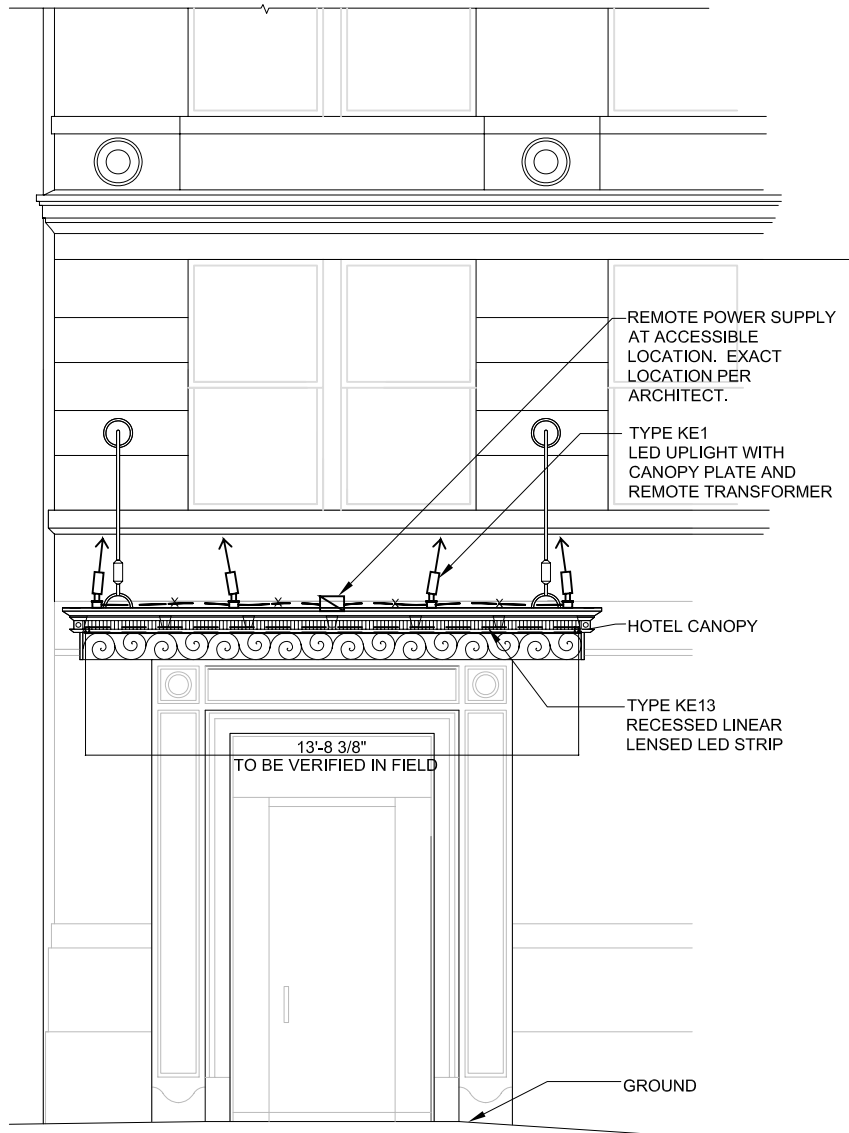


1 FRONT ELEVATION

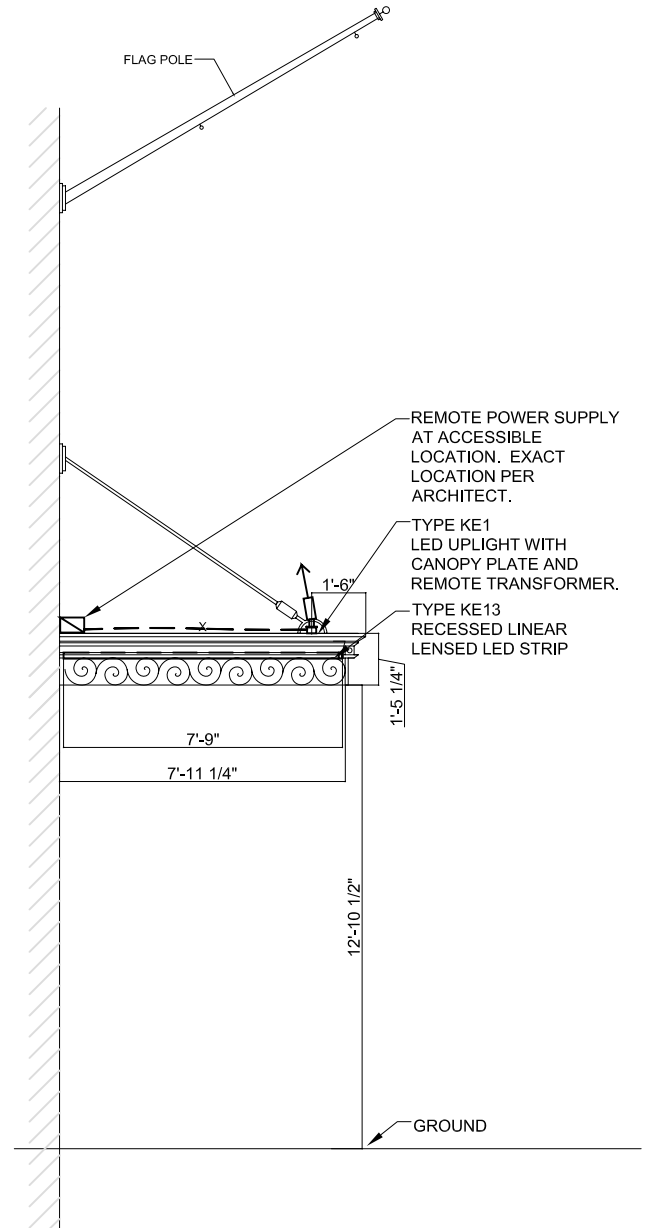


2 SIDE ELEVATION

PROJECT NAME:	THE PRESS HOTEL	DATE:	10/14/2013
DRAWING NAME:	HOTEL CANOPY ELEVATION	SCALE:	3/16" = 1'-0"
KUGLER NING Lighting Design 49 West 38th Street New York, NY 10018 Tel: 212 382 2100 Fax: 212 730 4412	REVISION:	11/08/2013	
		01/15/2014	

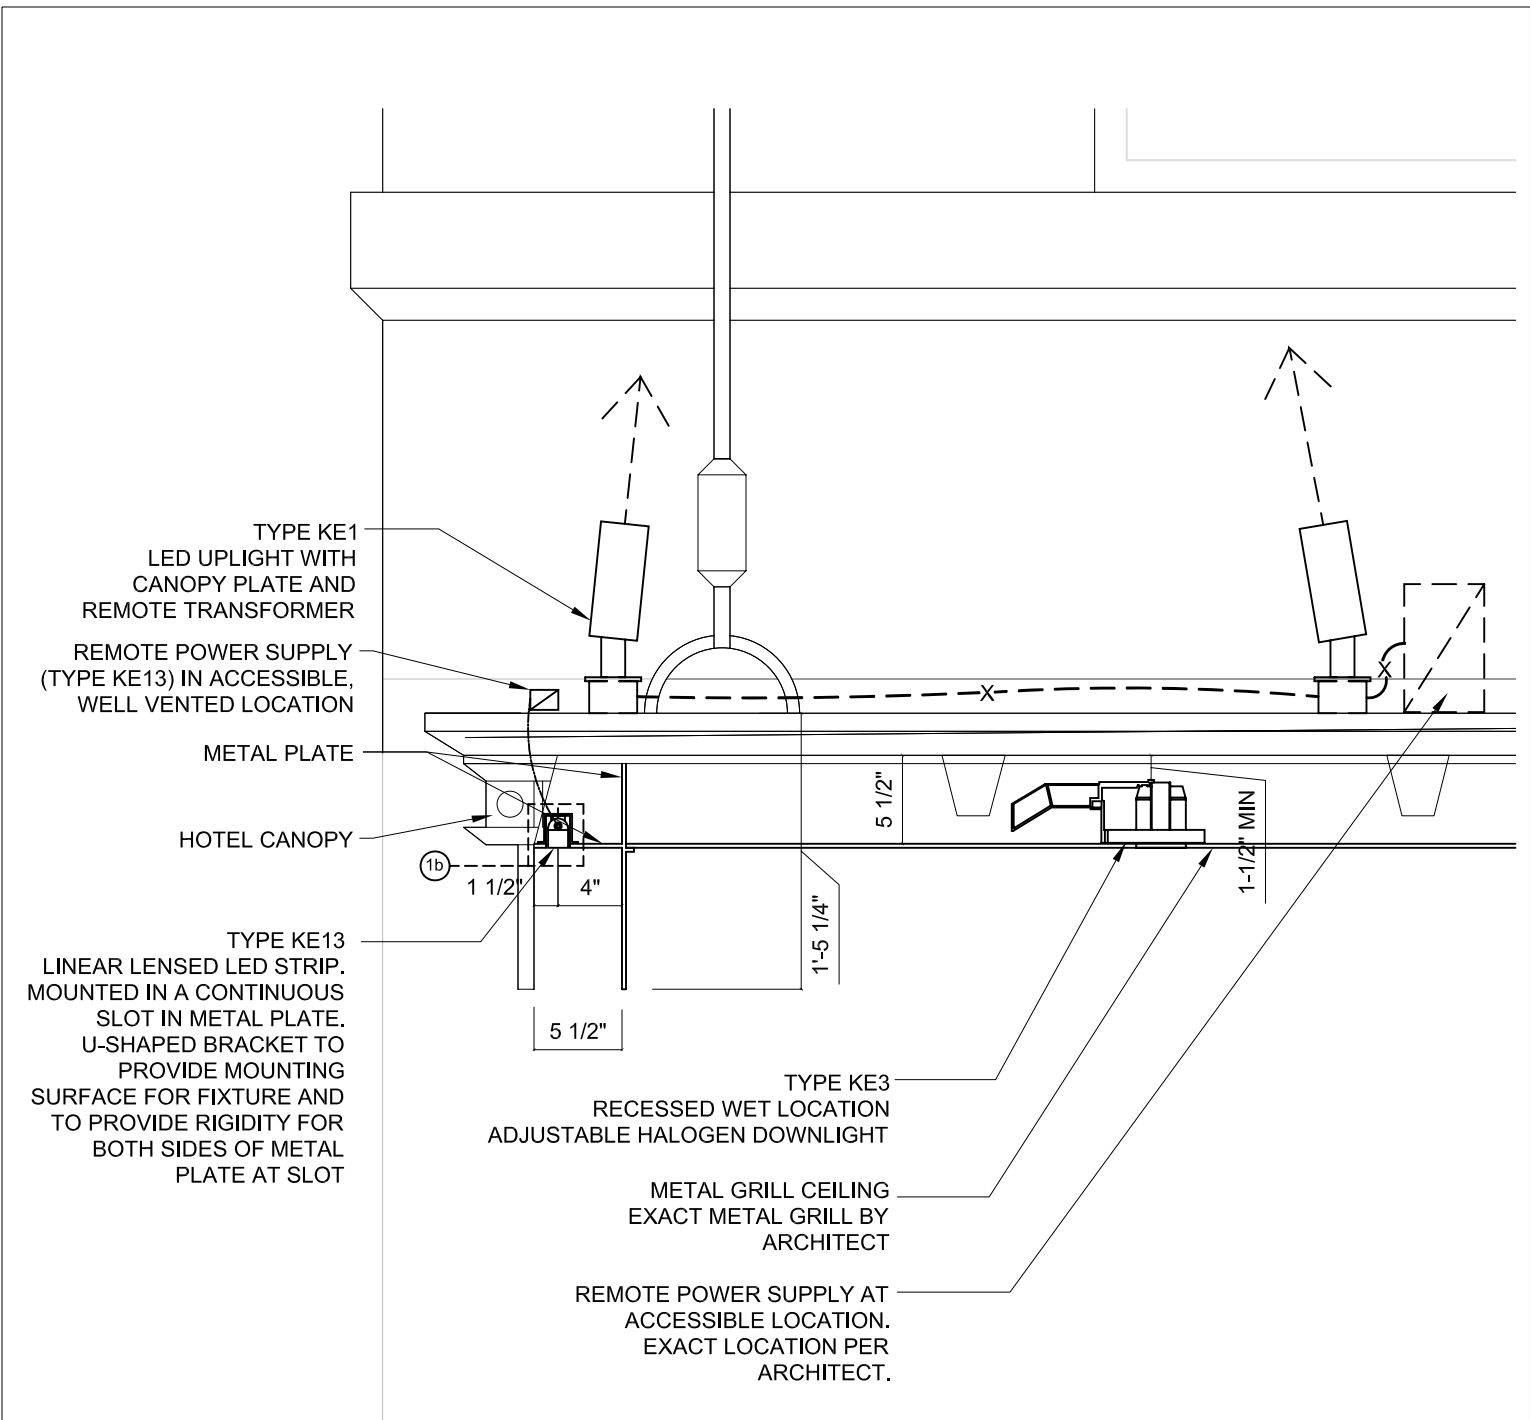


1a ENLARGED DETAIL

PROJECT NAME:	THE PRESS HOTEL	DATE:	09/20/2013
DRAWING NAME:	HOTEL CANOPY DETAIL	SCALE:	1" = 1'-0"
KUGLER NING Lighting Design 49 West 38th Street New York, NY 10018 Tel: 212 382 2100 Fax: 212 730 4412	REVISION:	11/08/2013	
		01/15/2014	

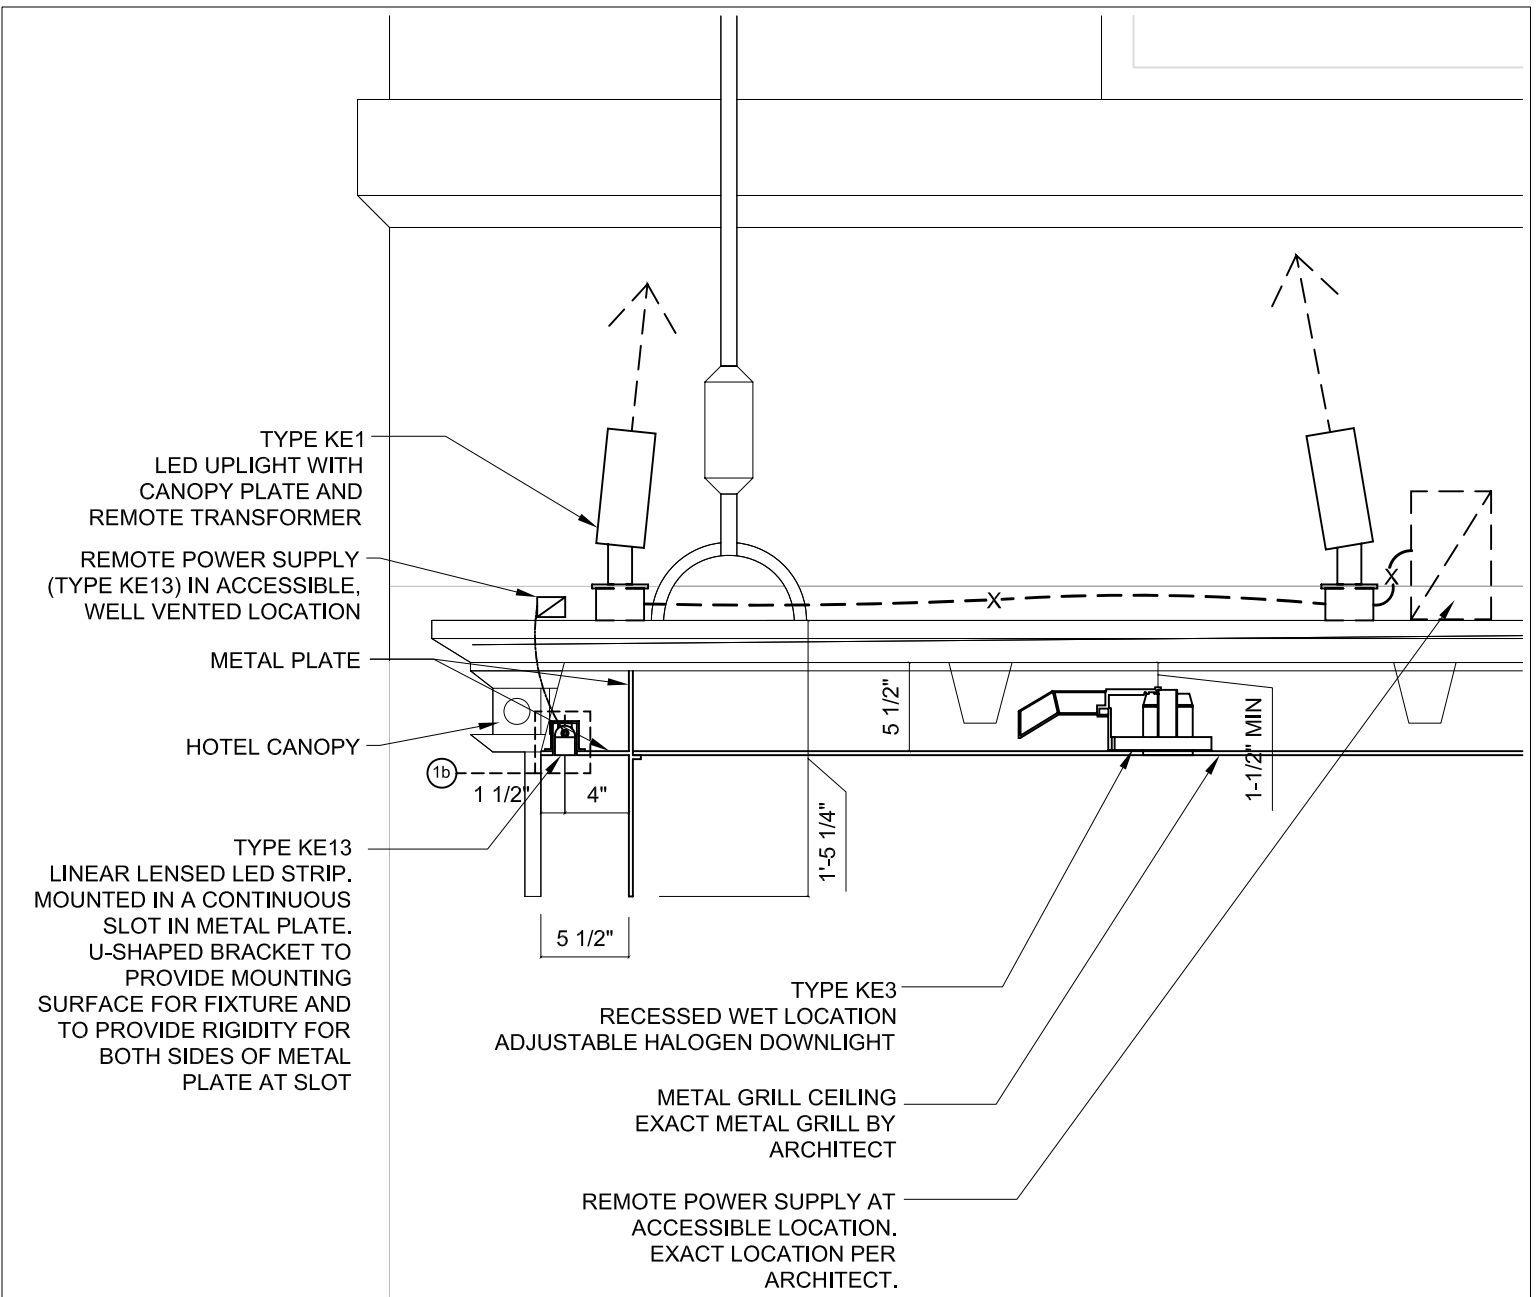

1a ENLARGED DETAIL

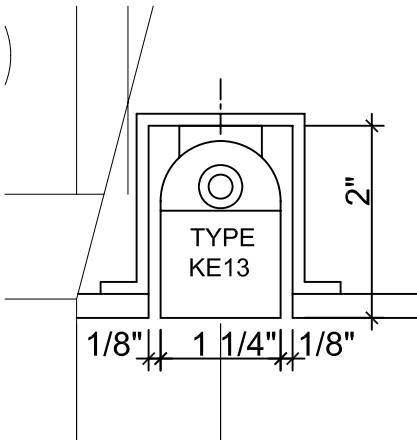

1b ENLARGED DETAIL at LED STRIP - KE13

PROJECT NAME:	THE PRESS HOTEL	DATE:	10/14/2013
DRAWING NAME:	HOTEL CANOPY DETAIL	SCALE:	1" = 1'-0"
KUGLER NING Lighting Design 49 West 38th Street New York, NY 10018 Tel: 212 382 2100 Fax: 212 730 4412	REVISION:		
		11/08/2013	
		01/15/2014	