




Reviewed for Code Compliance
 Permitting and Inspections Department
 Approved with Conditions
 05/13/2020



Anthony Mancini, Inc.
 179 SHERIDAN ST.
 PORTLAND, ME 04101
 P: (207) 774-6800 F: (207) 774-6866
 E: info@mancinielec.com
 "We appreciate Your Business."

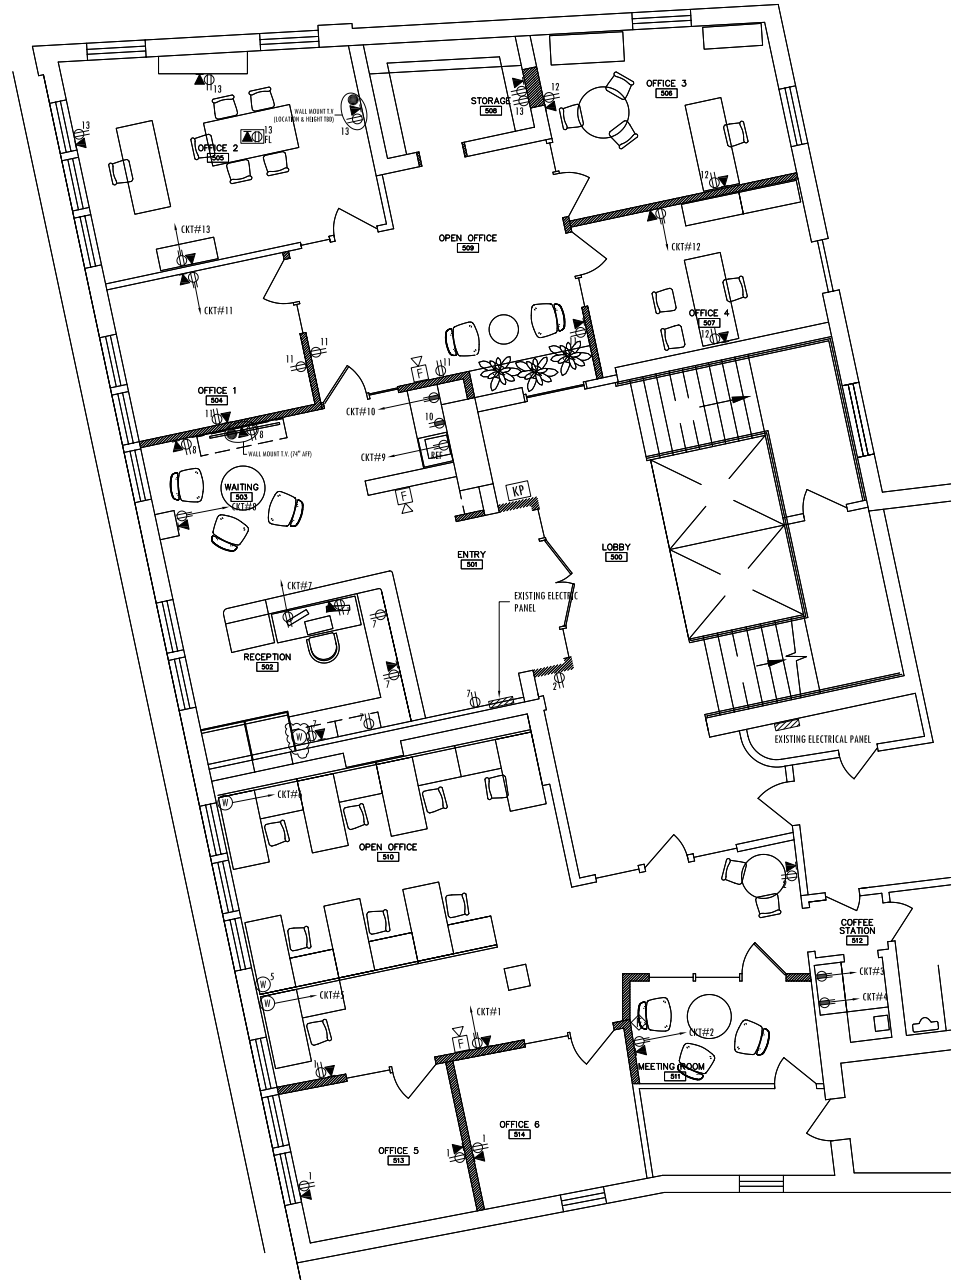

NO.	DATE	DESCRIPTION
A	01/17/2020	PER CUSTOMER NOTES


PROJECT NAME & ADDRESS:
 Systems Engineering
 120 Exchange Street
 Portland, Maine

SHEET NAME:
 5th floor - Systems
 Date: 01.06.2020
 Drawn By: G. MANCINI
 Scale: 1/4" = 1'-0"

SHEET:
 E3




Reviewed for Code Compliance
 Permitting and Inspections Department
 Approved with Conditions
 05/13/2020

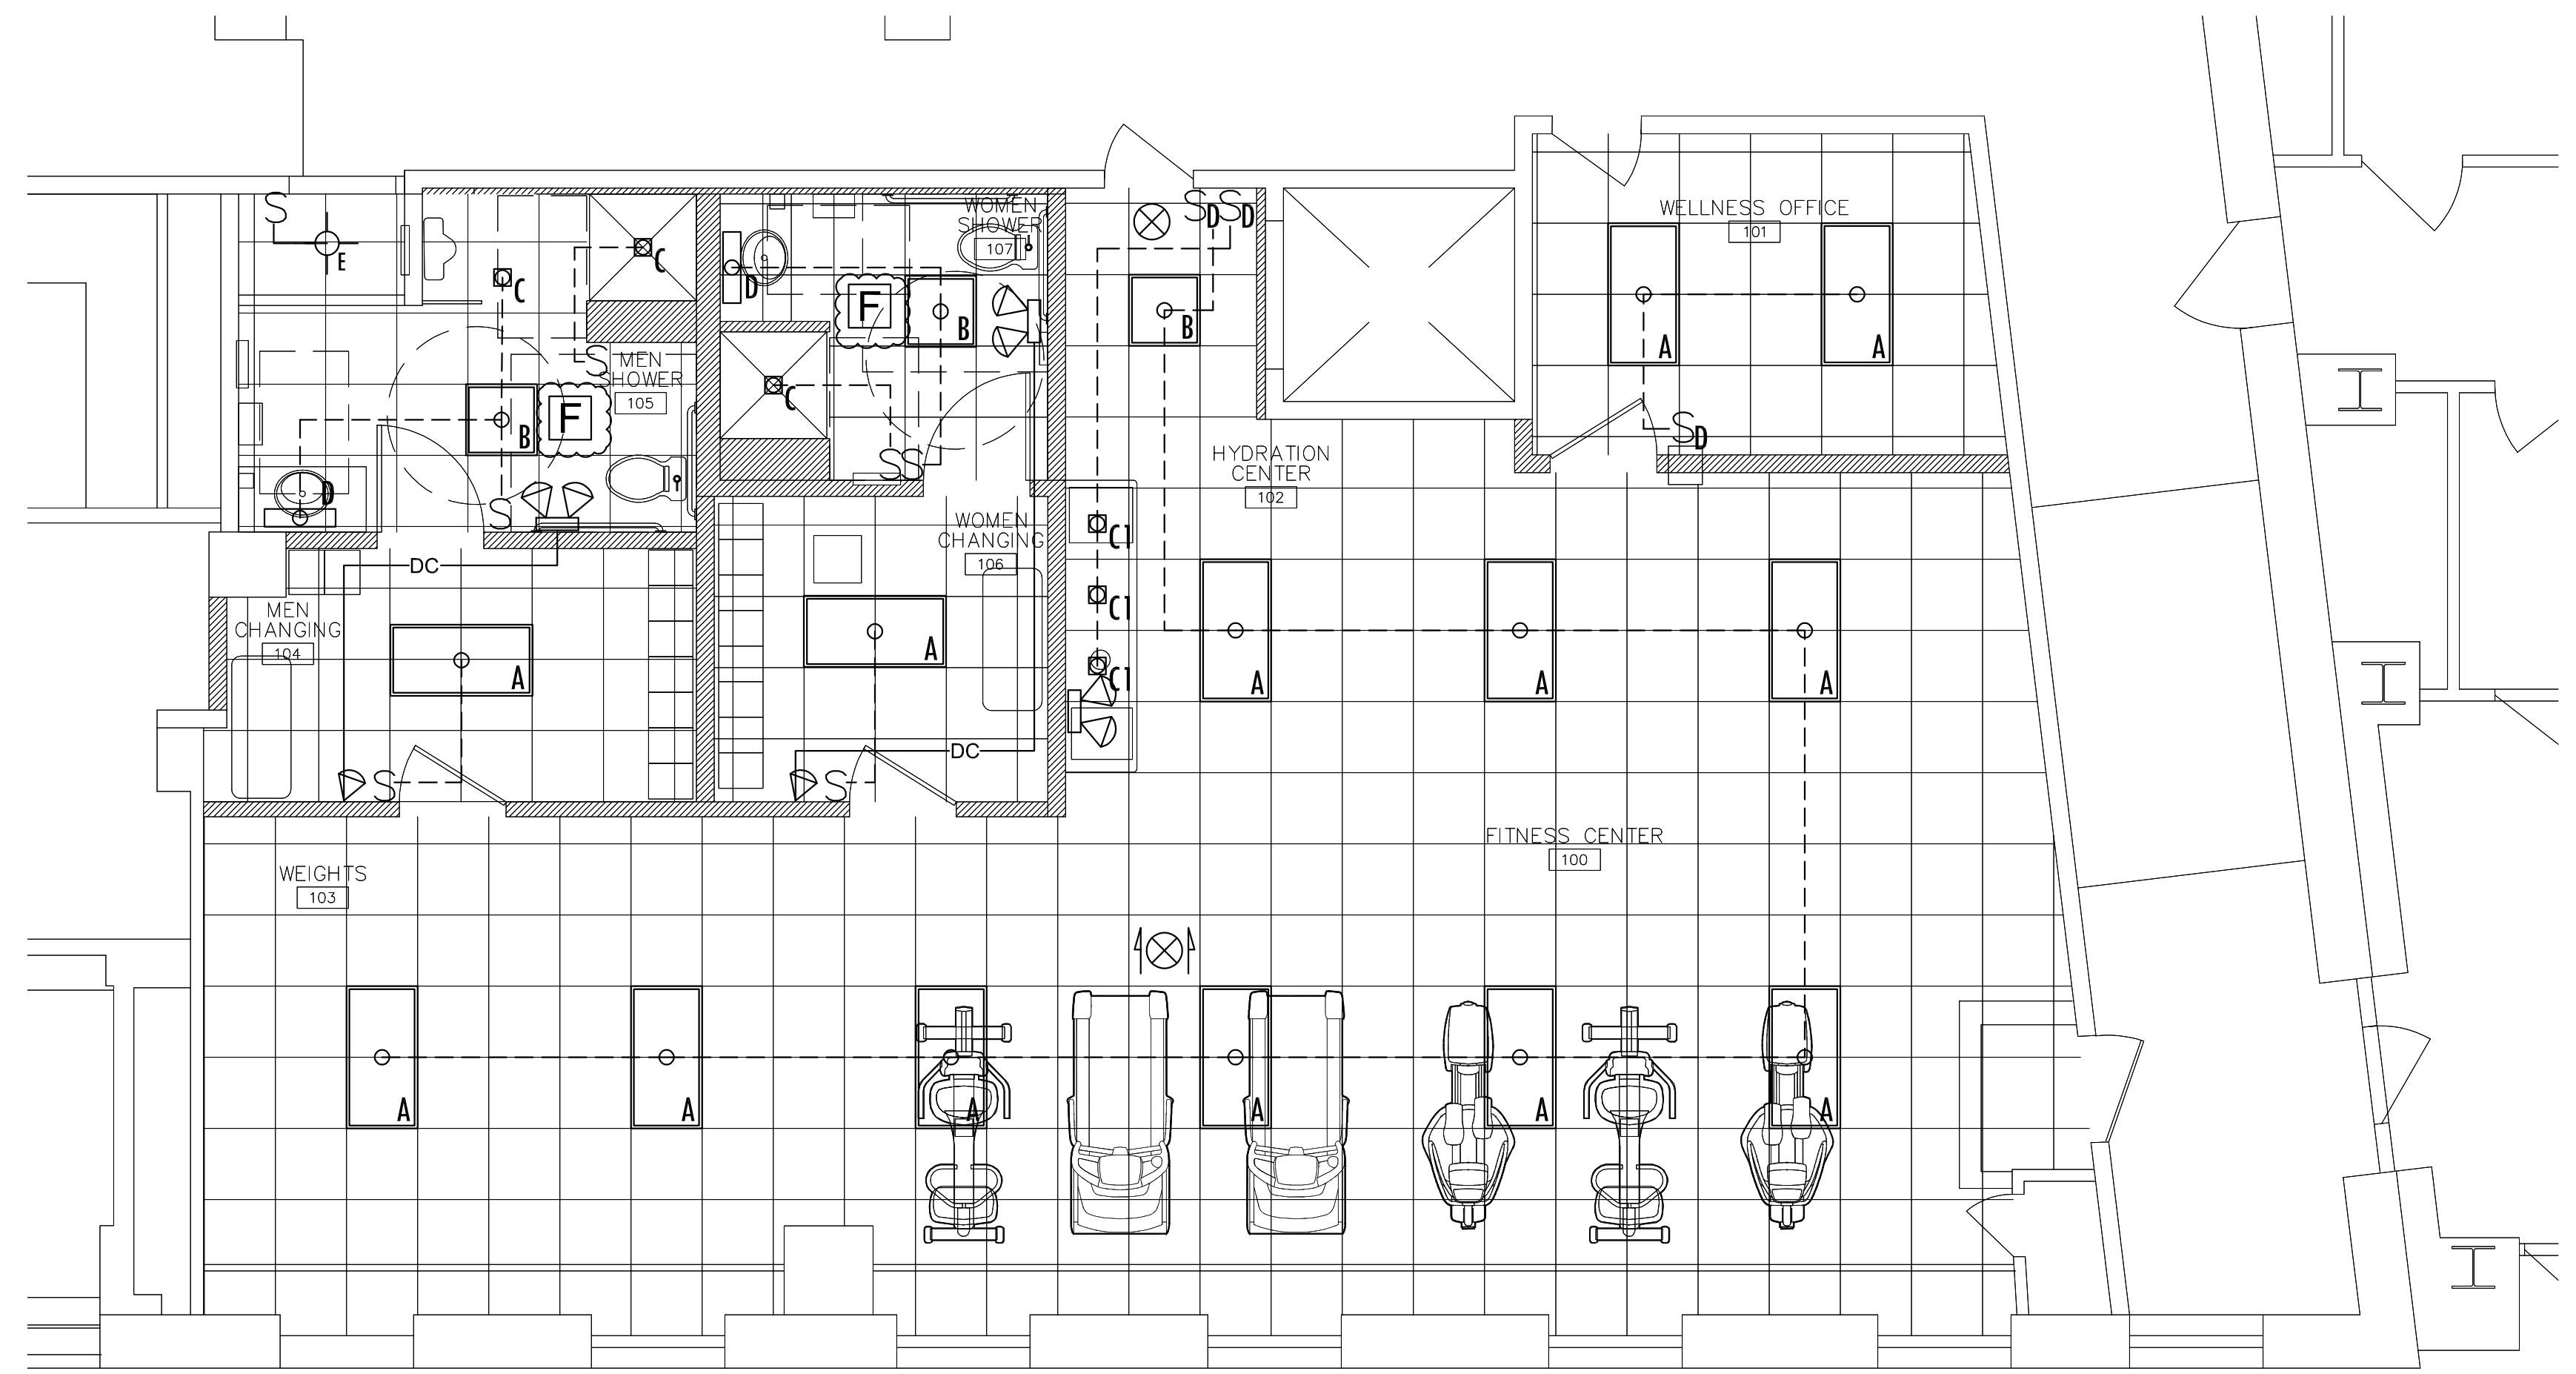

1ST FLOOR FITNESS CENTER - LIGHTING & EMERGENCY LIGHTING LAYOUT

1/4"=1'-0"

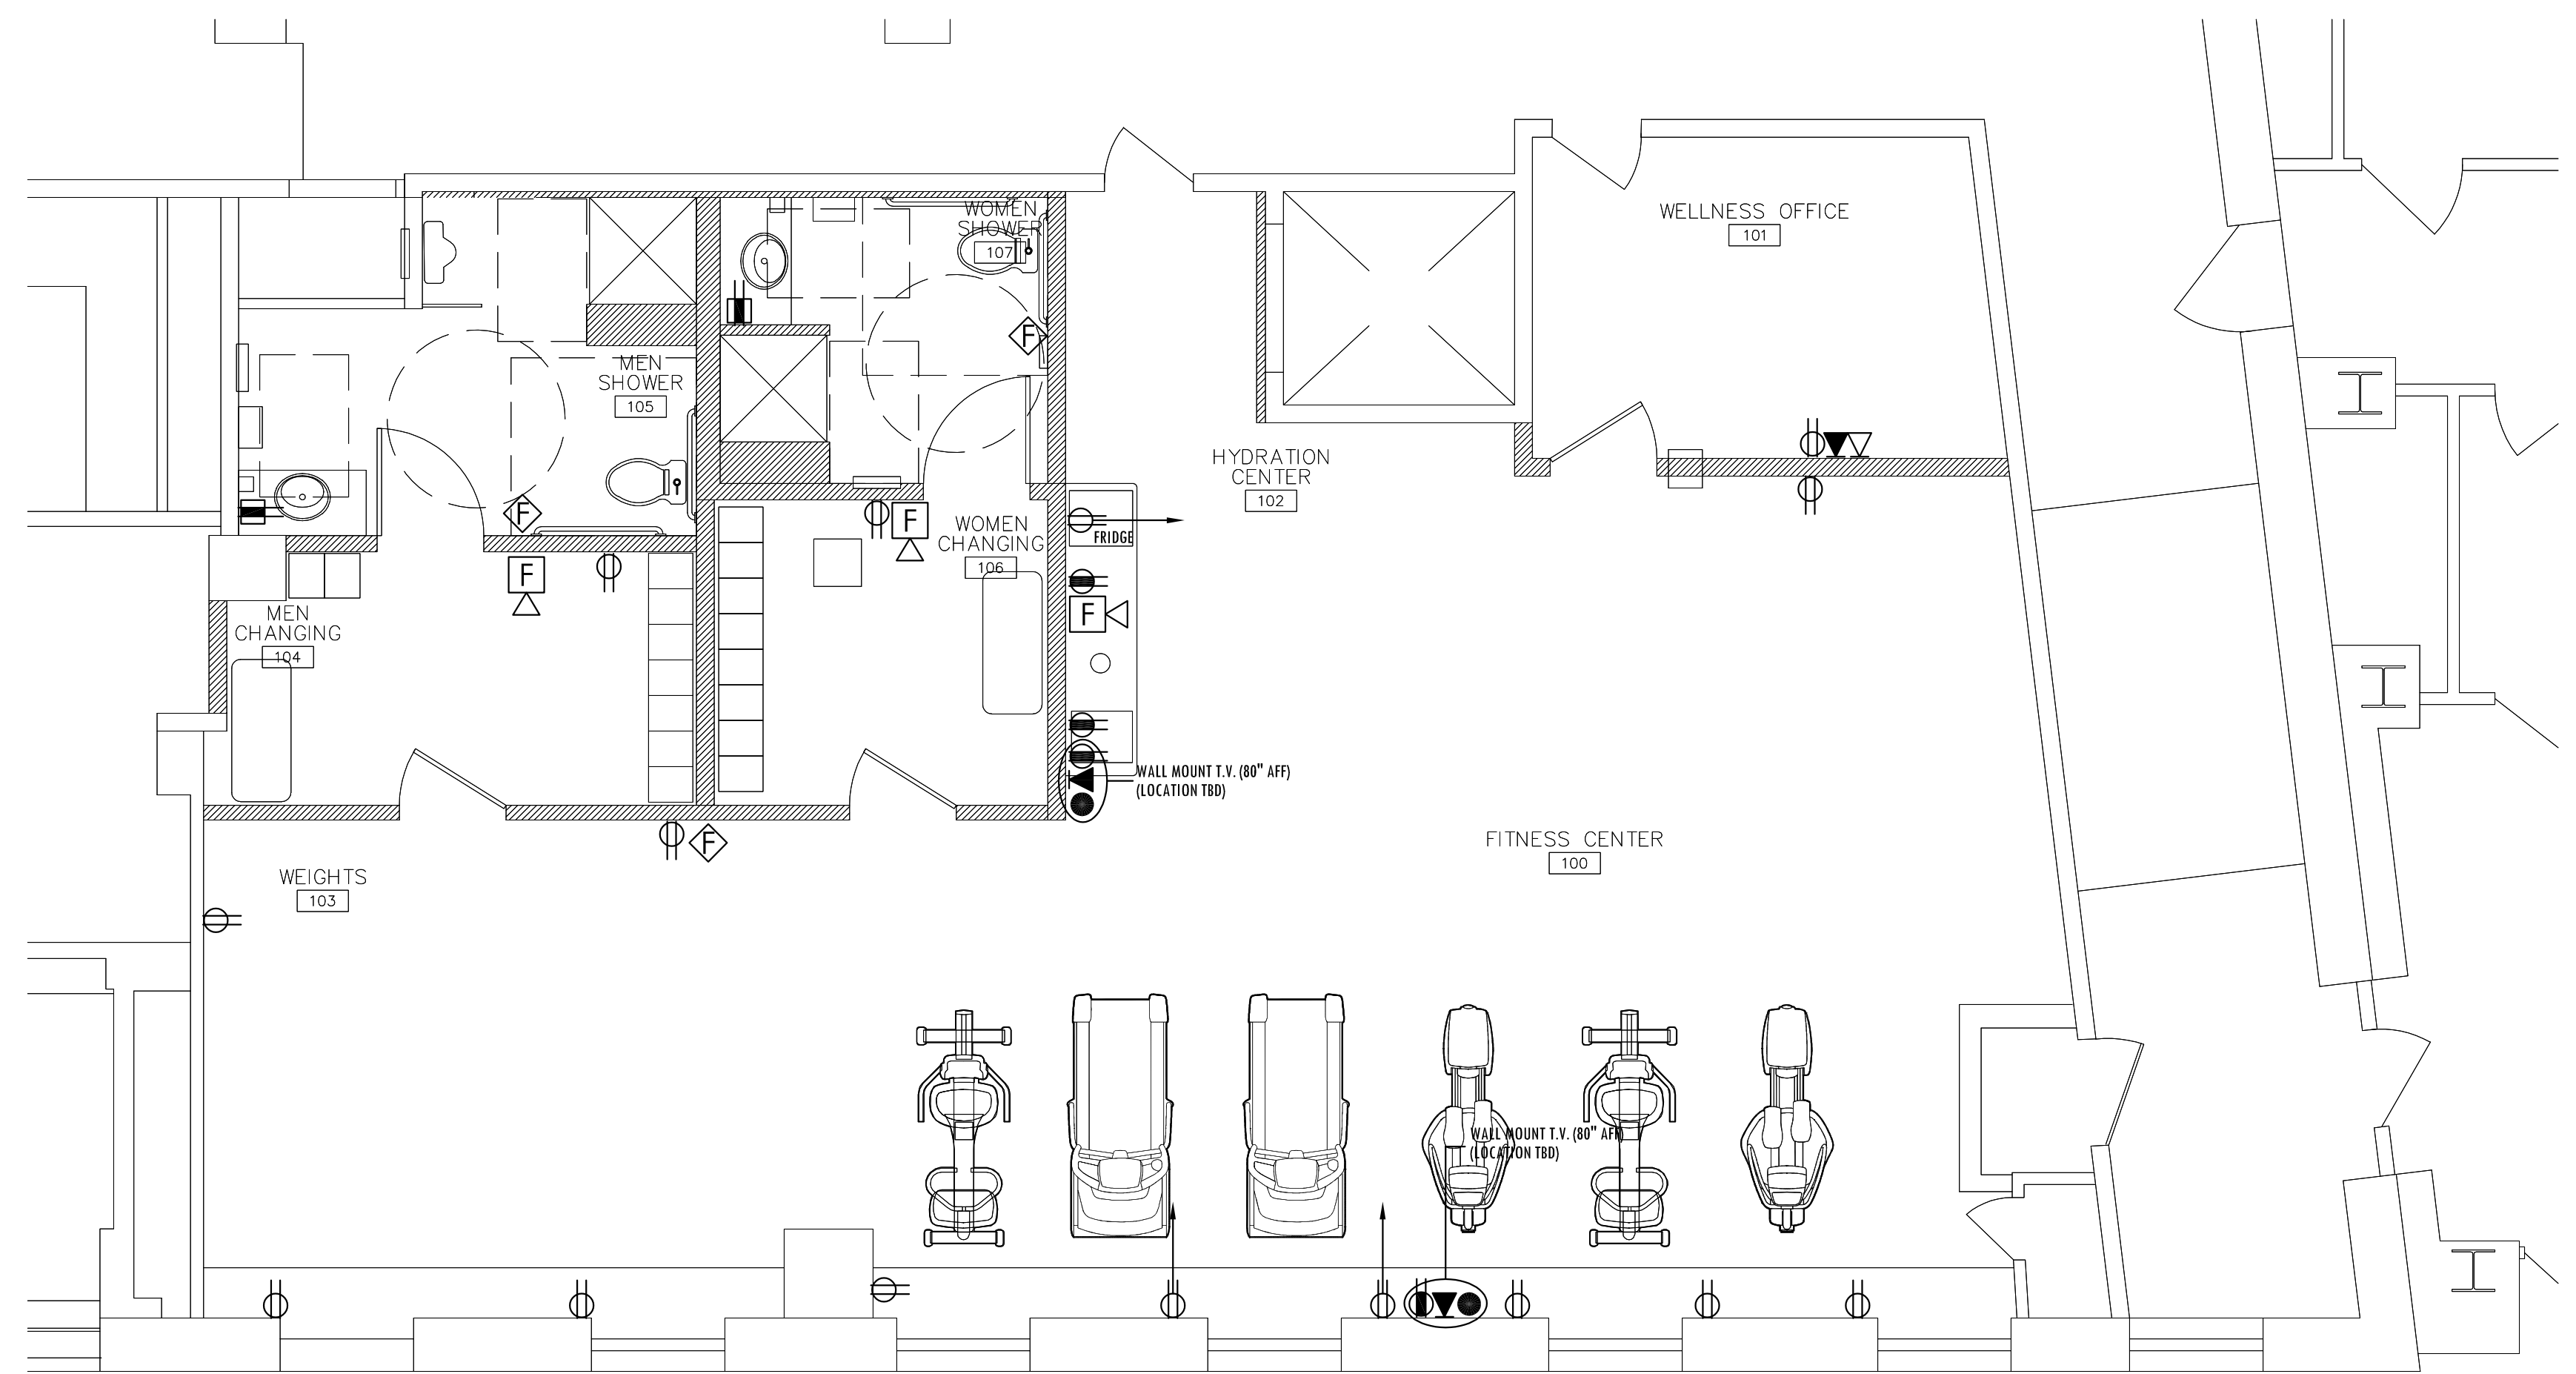

1ST FLOOR FITNESS CENTER - SYSTEMS LAYOUT

1/4"=1'-0"

Anthony Mancini, Inc.
 179 SHERIDAN ST.
 PORTLAND, ME 04101
 P: (207)774-5829 F: (207)772-1686
 E: info@mancinielectric.com
 "We appreciate Your Business."



DESCRIPTION

DATE

NO.

PROJECT NAME & ADDRESS:

Systems Engineering
 120 Exchange Street
 Portland, Maine

SHEET NAME

1st Floor Layouts


Date: 01.06.2020
 Scale: 1/4" = 1'-0"

Checked By: G. MANCINI
 Drawn By: A. AMES

SHEET:

E1

NO.	DATE	DESCRIPTION

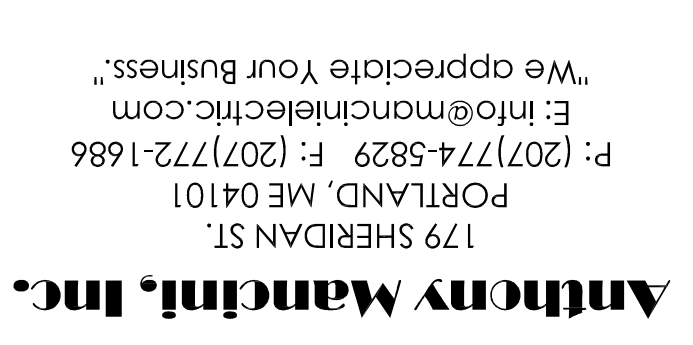

179 SHERIDAN ST.
PORTLAND, ME 04101
P: (207)774-5829 F: (207)772-1686
E: info@mancinielec.com
"We appreciate Your Business."

FIXTURE SCHEDULE

QUANTITY	TYPE	MANUFACTURER	CATALOG NUMBER	DESCRIPTION	LAMPS
36	A	COOPER	24CZ2-45HE-UNV-L835-CD1-U	2x4 LED FIXTURE	LED
5	B	COOPER	22CZ2-34HE-UNV-L835-CD1-U	2x2 LED FIXTURE	LED
13	C	LOTUS	LL4RR-30K-WH	4IN LED DOWNLIGHT	LED
8	C1	NDR	OB-300-0510-3K-WH	3IN LED DOWNLIGHT	LED
2	D	SEAGULL	4435591S-962	VANITY LIGHT	-
-	E	-	-	RECESSED LINEAR LED FIXTURE	LED
4	EX	SURE-LITE	APLXTRG	LED EXIT SIGN	
1	COMBO	SURE-LITE	APC7R	LED EXIT SIGN	
5	EM1	DUAL-LITE	LZ15	EMERGENCY BATTERY UNIT	
2	SHR	DUAL-LITE	LZRSW0605	EMERGENCY REMOTE HEAD	

LIGHTING & EMERGENCY

- RECESSED LIGHT FIXTURE
- RECESSED LIGHT FIXTURE - EMERGENCY BATTERY BACK-UP
- PENDING/HANGING LIGHT FIXTURE
- A - FIXTURE TYPE ON FIXTURE SCHEDULE
- α - SWITCHING CONTROL
- 2X2 LED LIGHT FIXTURE
- 2X4 LED LIGHT FIXTURE
- S SINGLE-POLE SWITCH
- S₃ THREE-WAY SWITCH
- S₄ FOUR-WAY SWITCH
- S_D SINGLE-POLE DIMMER SWITCH - MOUNTED 48" AFF TO TOP
- S_{B3} THREE-WAY DIMMER SWITCH - MOUNTED 48" AFF TO TOP
- S_M MOTION SENSOR SWITCH - MOUNTED 48" AFF TO TOP
- ⊗ LED EXIT SIGN

POWER

- ⊕ DUPLEX CONVENIENCE RECEPTACLE - MOUNTED HORIZONTAL, LOCATED IN WALL BASE
- ⊕ DUPLEX CONVENIENCE RECEPTACLE - 46" AFF TO TOP
- ⊕ GROUND FAULT INTERRUPTER RECEPTACLE
- ⊕ GROUND FAULT INTERRUPTER RECEPTACLE - 46" AFF TO TOP
- ⊕ WEATHERPROOF GFI RECEPTACLE
- ⊕ ISOLATED GROUND RECEPTACLE
- ⊕ SPECIAL EQUIPMENT WIRING
- PC PARTIAL CIRCUIT
- ▽ VOICE/DATA RECEPTACLE 18" AFF TO TOP
- ▽ WALL MOUNTED TELEPHONE JACK - 48" AFF TO TOP
- DATA & HDMI RECEPTACLE FOR T.V. - MOUNTING HEIGHT TBD IN FIELD
- ⊕ RECESSED MOUNTED LIGHTING & POWER PANEL
- ⊕ FUSED DISCONNECT SWITCH
- ⊕ MOTOR SWITCH

FIRE ALARM

- FIRE ALARM MANUAL PULL STATION - MOUNT 52" AFF TO TOP OF BOX
- FIRE ALARM HORN AND STROBE UNIT - MOUNT 84" AFF TO TOP OF BOX OR 8' BELOW CEILING, WHICH EVER IS LOWER
- FIRE ALARM STROBE UNIT - MOUNT ABOVE DOOR - MOUNT 84" AFF TO BOTTOM OF BOX OR 6' BELOW CEILING, WHICH EVER IS LOWER
- ⊕ SMOKE DETECTOR - CEILING MOUNTED
- ⊕ HEAT DETECTOR - CEILING MOUNTED
- ⊕ SMOKE DETECTOR - CEILING MOUNTED
- ⊕ KNOX BOX - MOUNT CENTER OF BOX 5' AFG
- SPRINKLER SYSTEM TAMPER SWITCH
- SPRINKLER SYSTEM FLOW SWITCH
- DUCT SMOKE DETECTOR REMOTE TEST SWITCH
- FIRE ALARM ANNUNCIATOR PANEL - MOUNT CENTER OF BOX 5'-6" AFF



Reviewed for Code Compliance
Permitting and Inspections Department
Approved with Conditions
05/13/2020