
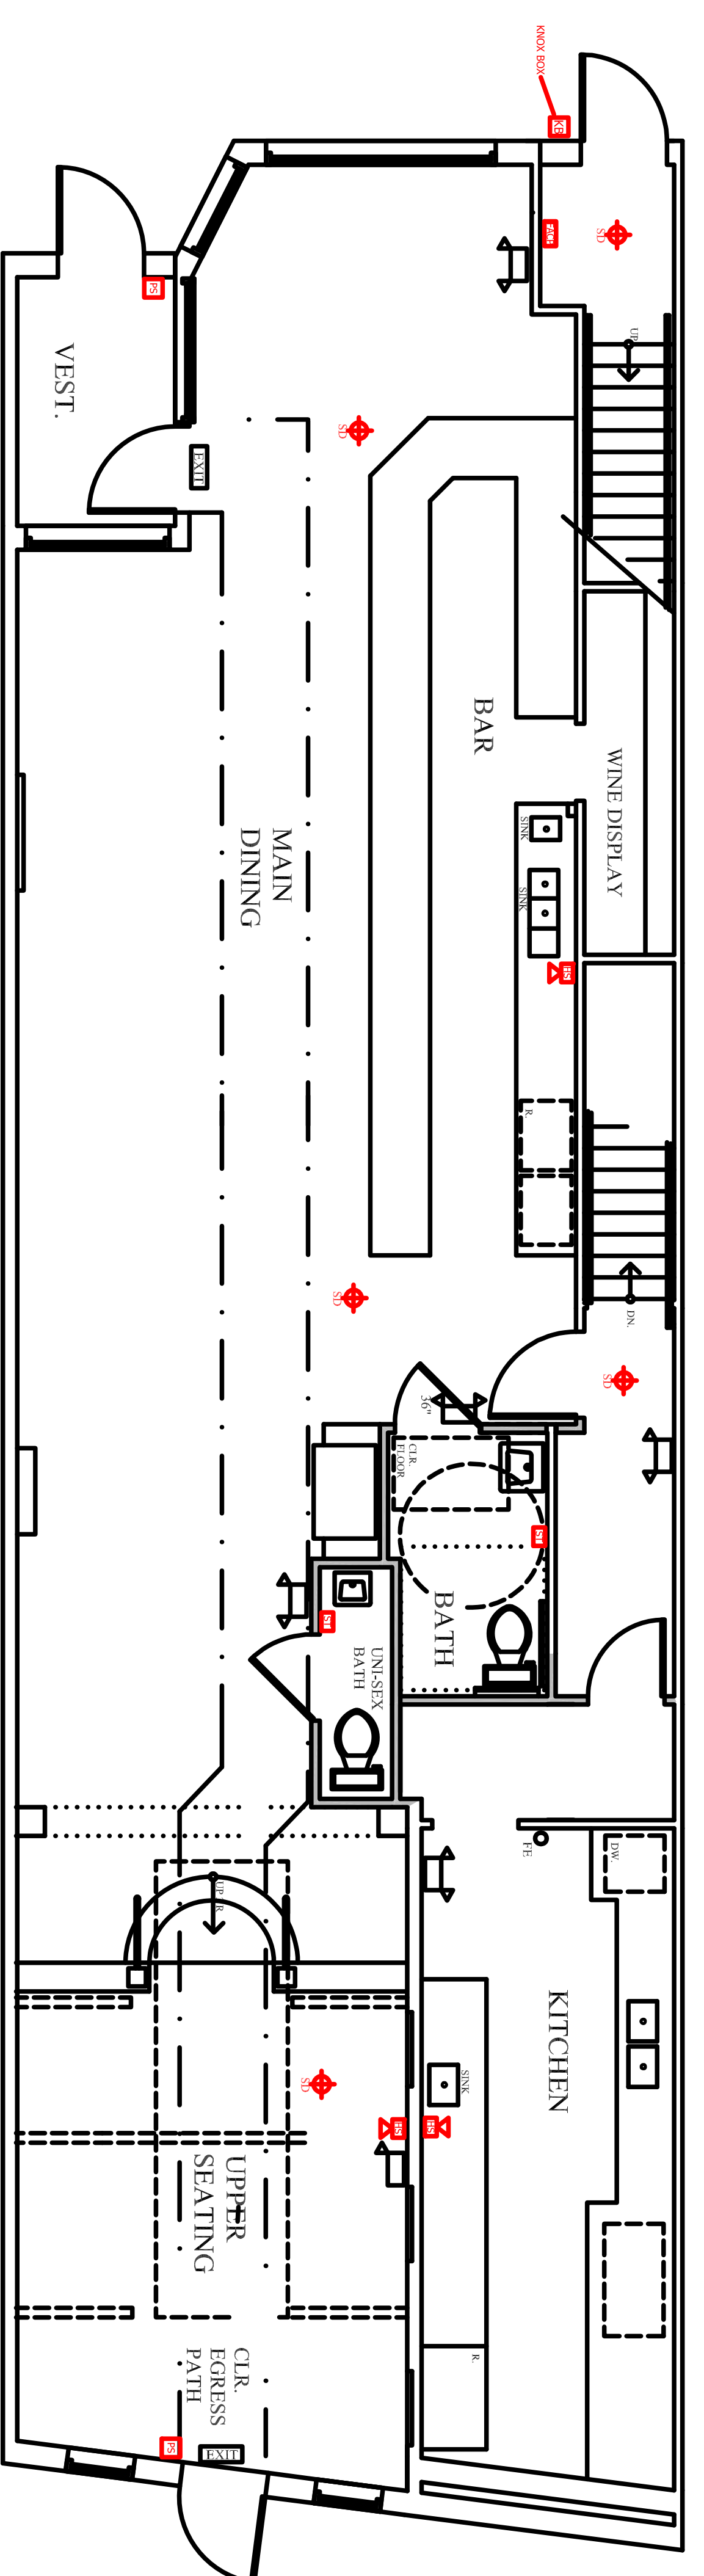


LOWER LEVEL

NOTE:
BASEMENT: UN-OCCUPIED

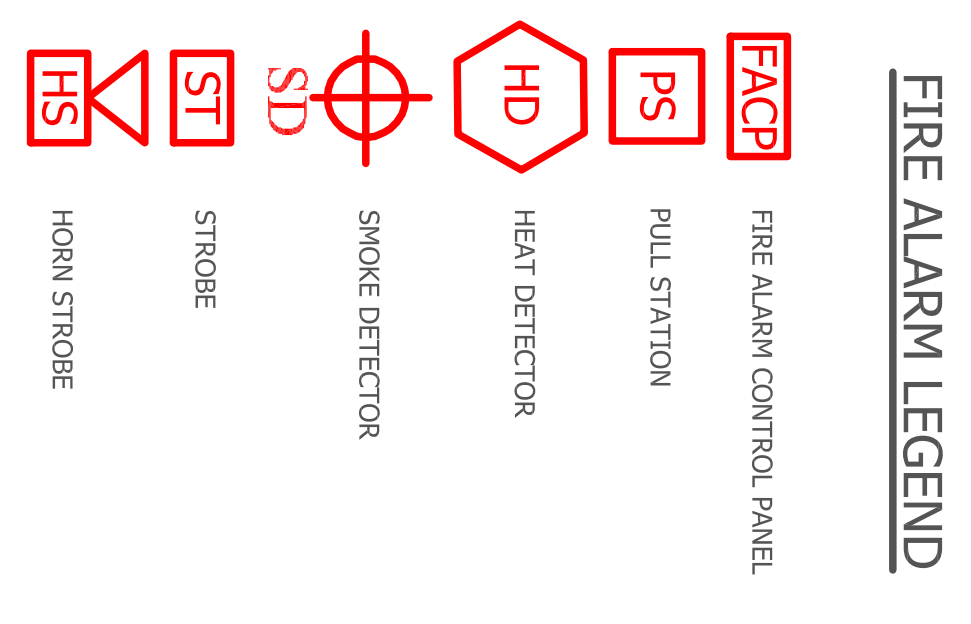

FIRST FLOOR

General Notes
This document and all drawings, specifications, data, design concepts, workflow processes, information strategies, configurations and other information provided herein are the property of Securadyme Systems, Inc. and all intellectual or other proprietary rights are reserved. The recipient may not use, reproduce or disclose the document or its contents except as necessary for the specific purposes contained within the drawings. The recipient may not create, modify, or otherwise use the drawings for any other project or construction other than the specific project. Any unapproved use or disclosure without the prior written permission of Securadyme Systems, Inc. is prohibited.

NO.	DATE	DESCRIPTION
REVISIONS		

securadyme systems
 NE-Region, MA Office
 100 Washington St., 11th Floor
 Boston, MA 02108
 Tel: 617-552-4444
 Fax: 617-552-4444
 Email: info@securadyme.com
 Website: www.securadyme.com
 NE-Region, ME Office
 100 Exchange St., 11th Floor
 Portland, ME 04101
 Tel: 207-488-9119
 Fax: 207-488-9119
 Email: info@securadyme.com
 Website: www.securadyme.com

Client
 106 Exchange St.
 Portland, ME.
 04101

Title
 Fire Alarm Layout
 Basement and
 1st floors

Date: 5/12/2014 Drawing Scale: 1/4"=1'
 Drawn By: ZND SSI: KIM
 Email Address: ZACHARY.DAVIS@SECURADYME.COM
 Securadyme File Name: 5.12.14_TIMBER FOR CONSTRUCTION
 Securadyme Quote/Proj No.: 942408 Sheet: 1 OF 3