

CONSULTANTS:

REVISIONS:

No.	Name	Date

**ISSUED FOR PERMITTING**

ISSUED: 11/01/17


PROJECT No: 1714

DRAWN BY: LG


CHECKED BY:

SHEET TITLE:  
BATHROOM ENLARGED PLANS & INTERIOR ELEVATIONS


**A502**

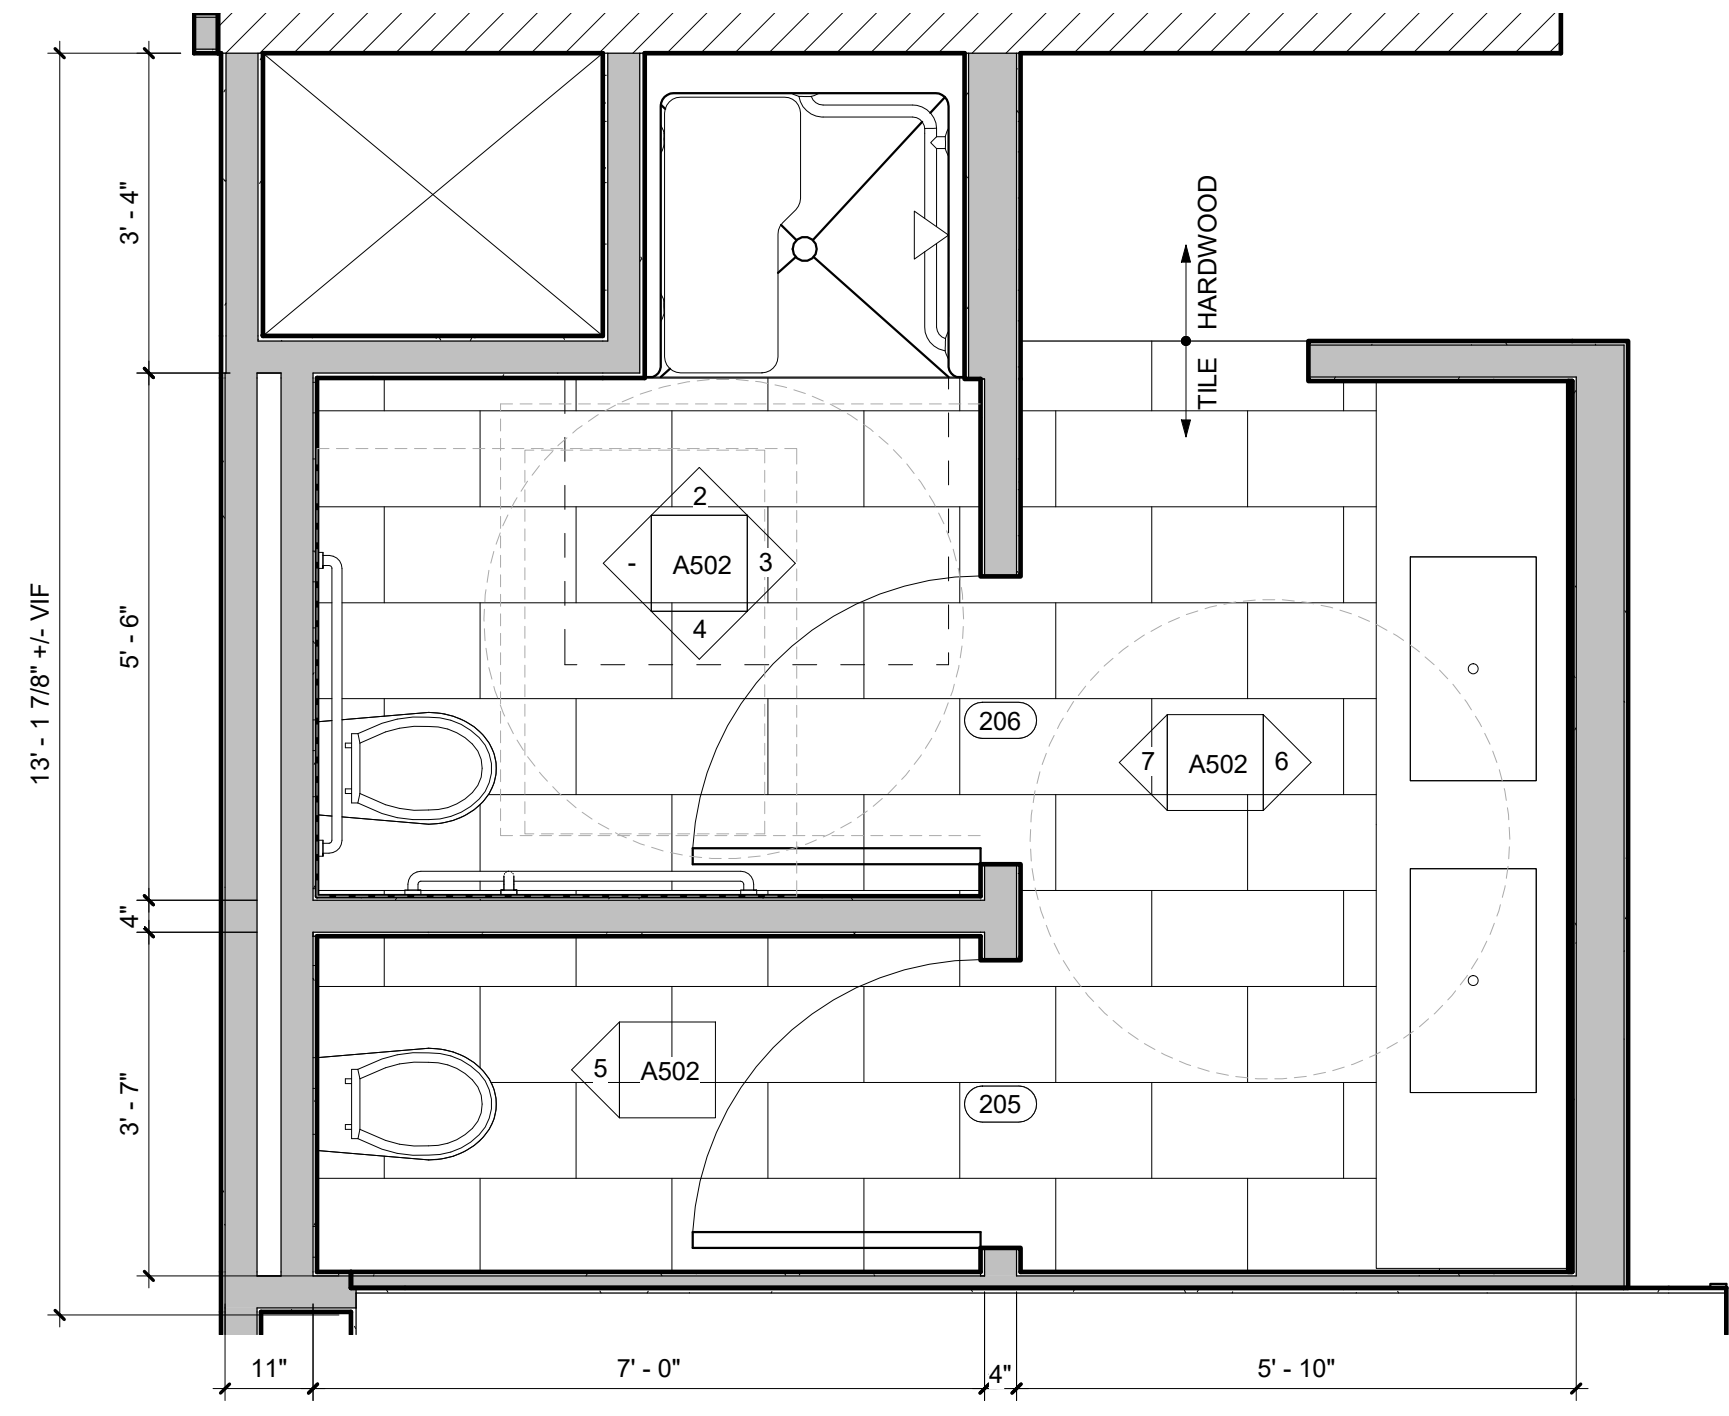


1 TYPICAL BATHROOM ENLARGED PLAN  
1/2" = 1'-0"

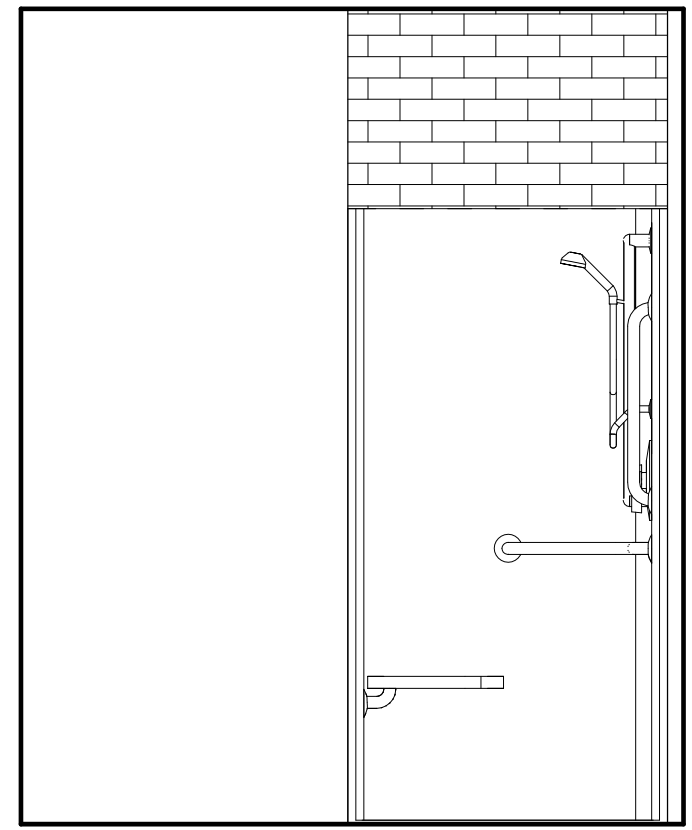


2 SHOWER ELEVATION  
1/2" = 1'-0"

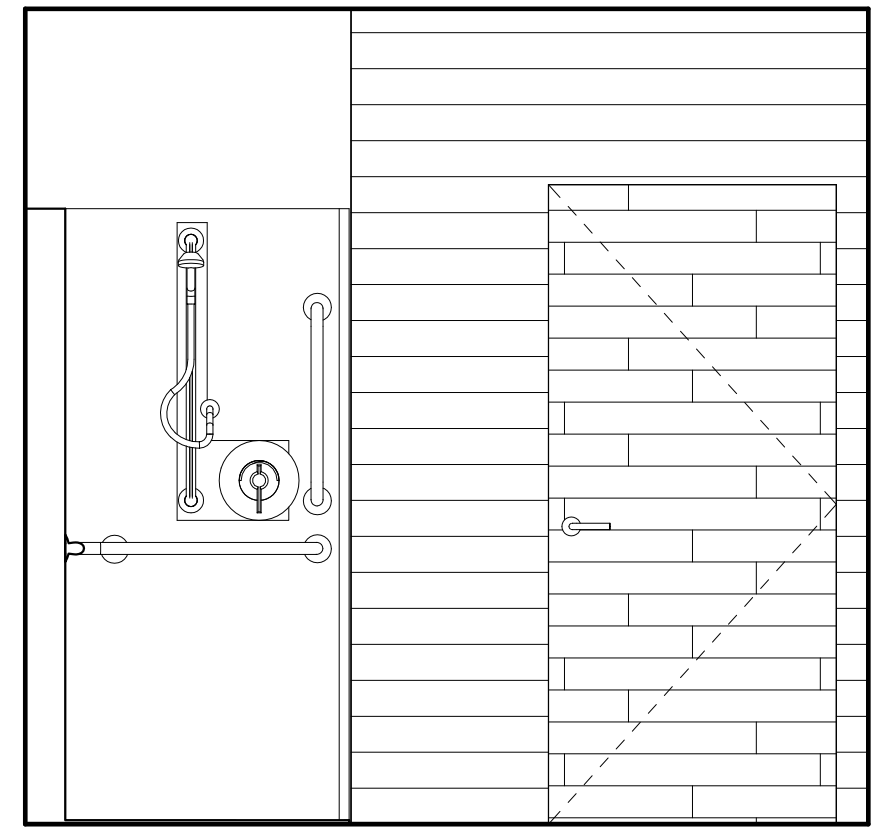


3 SHOWER FIXTURE ELEVATION  
1/2" = 1'-0"

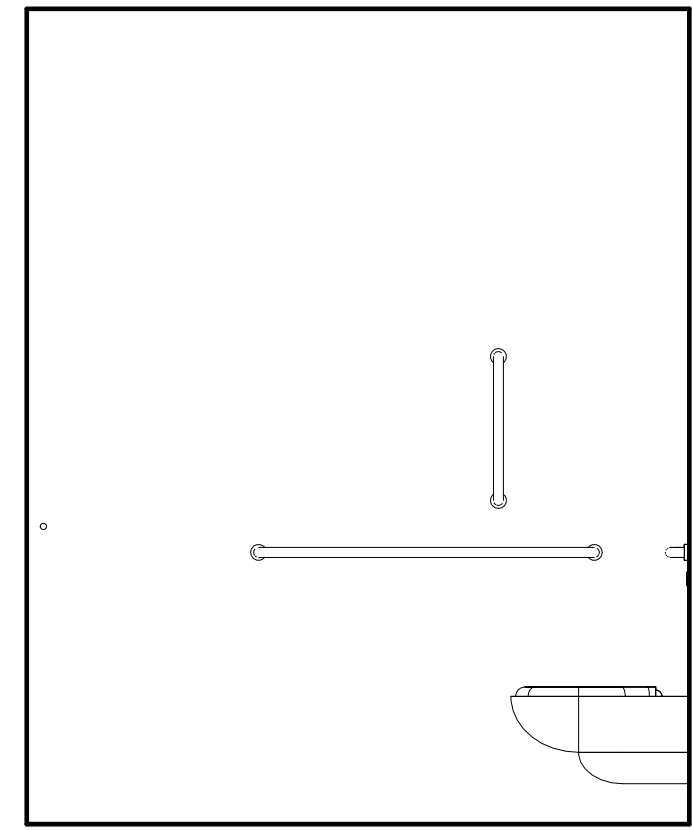


4 TOILET ELEVATION  
1/2" = 1'-0"

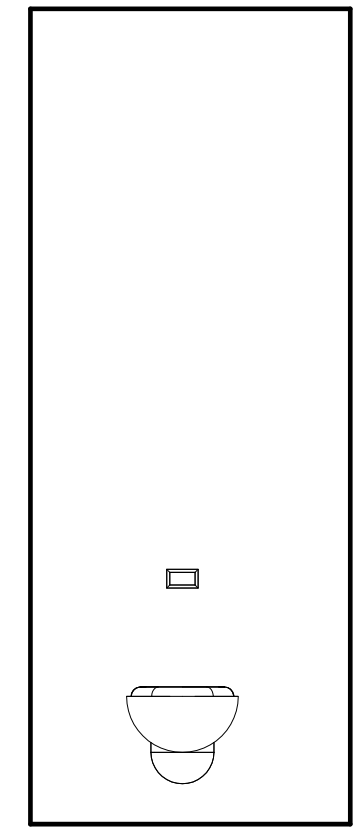


5 TOILET ELEVATION  
1/2" = 1'-0"

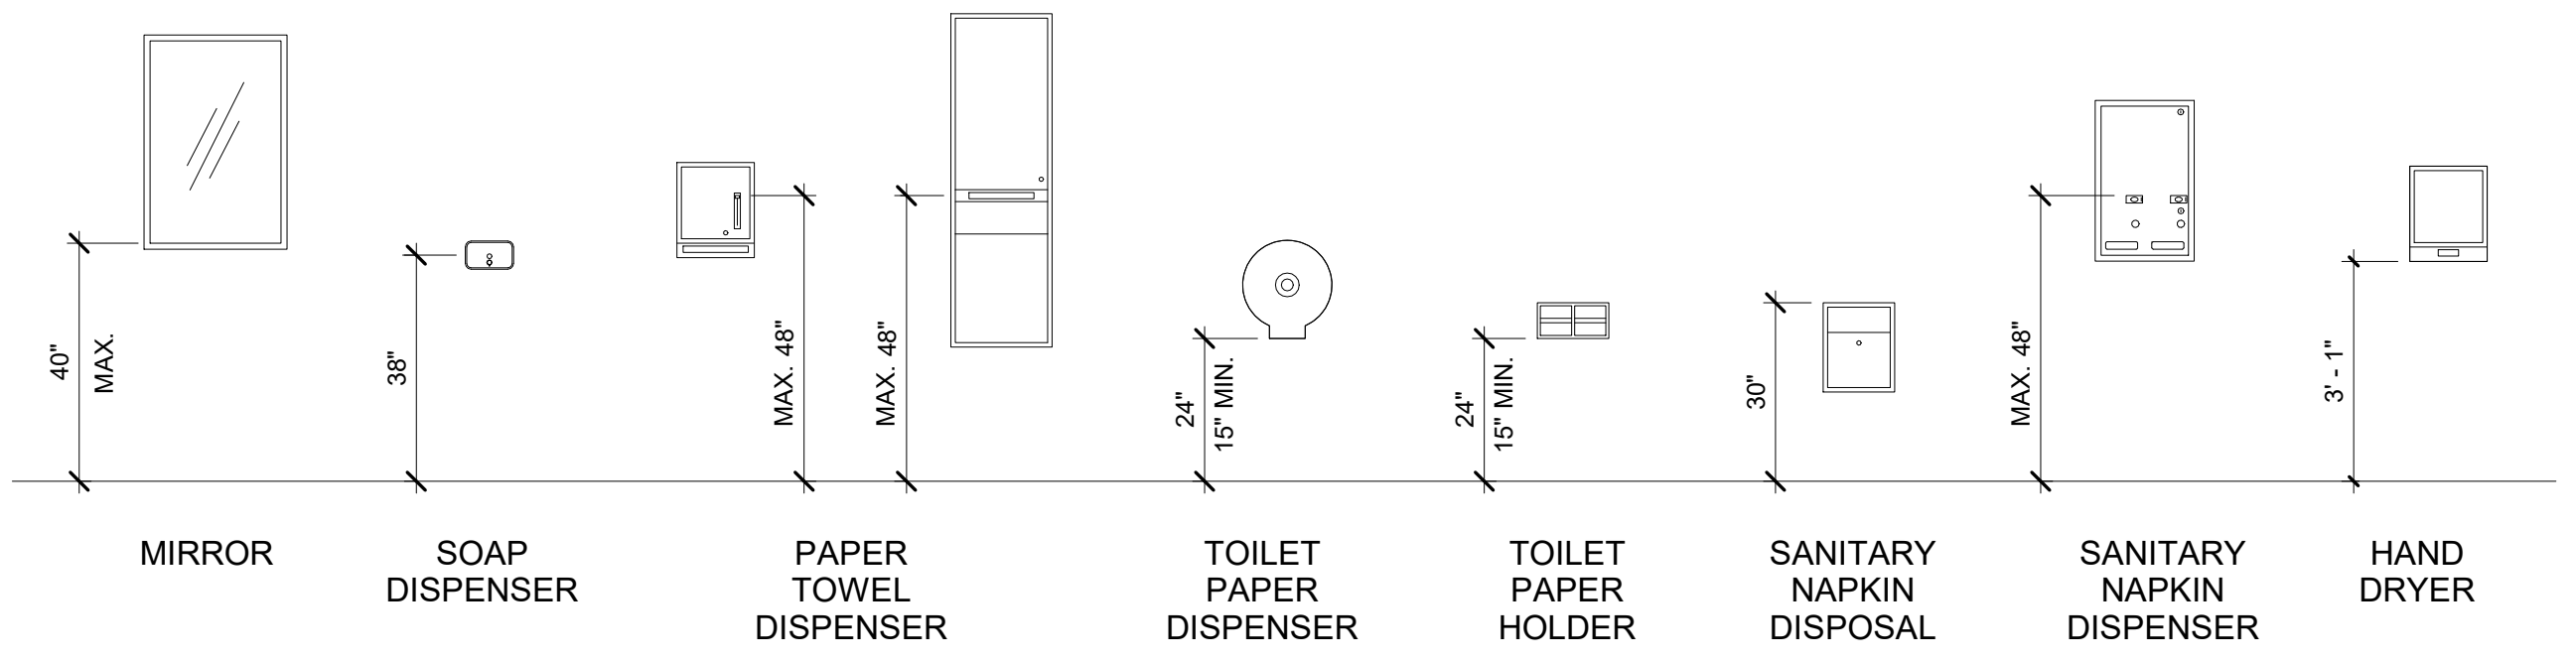


**TYPICAL TOILET ACCESSORIES MOUNTING HEIGHTS**

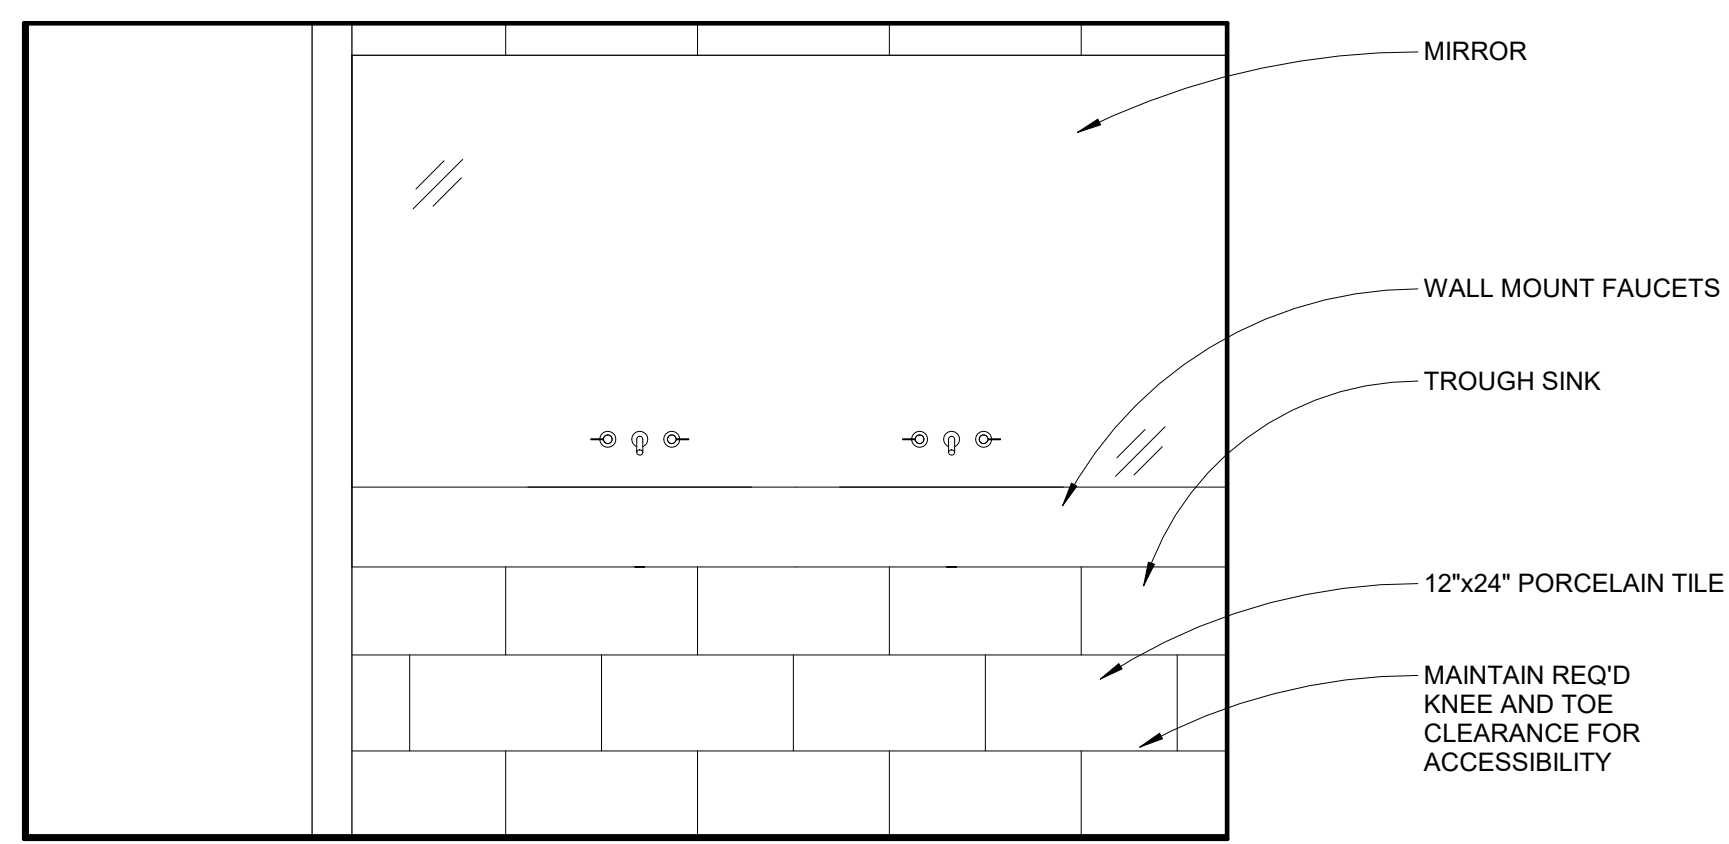

6 BATHROOM SINK ELEVATION  
1/2" = 1'-0"

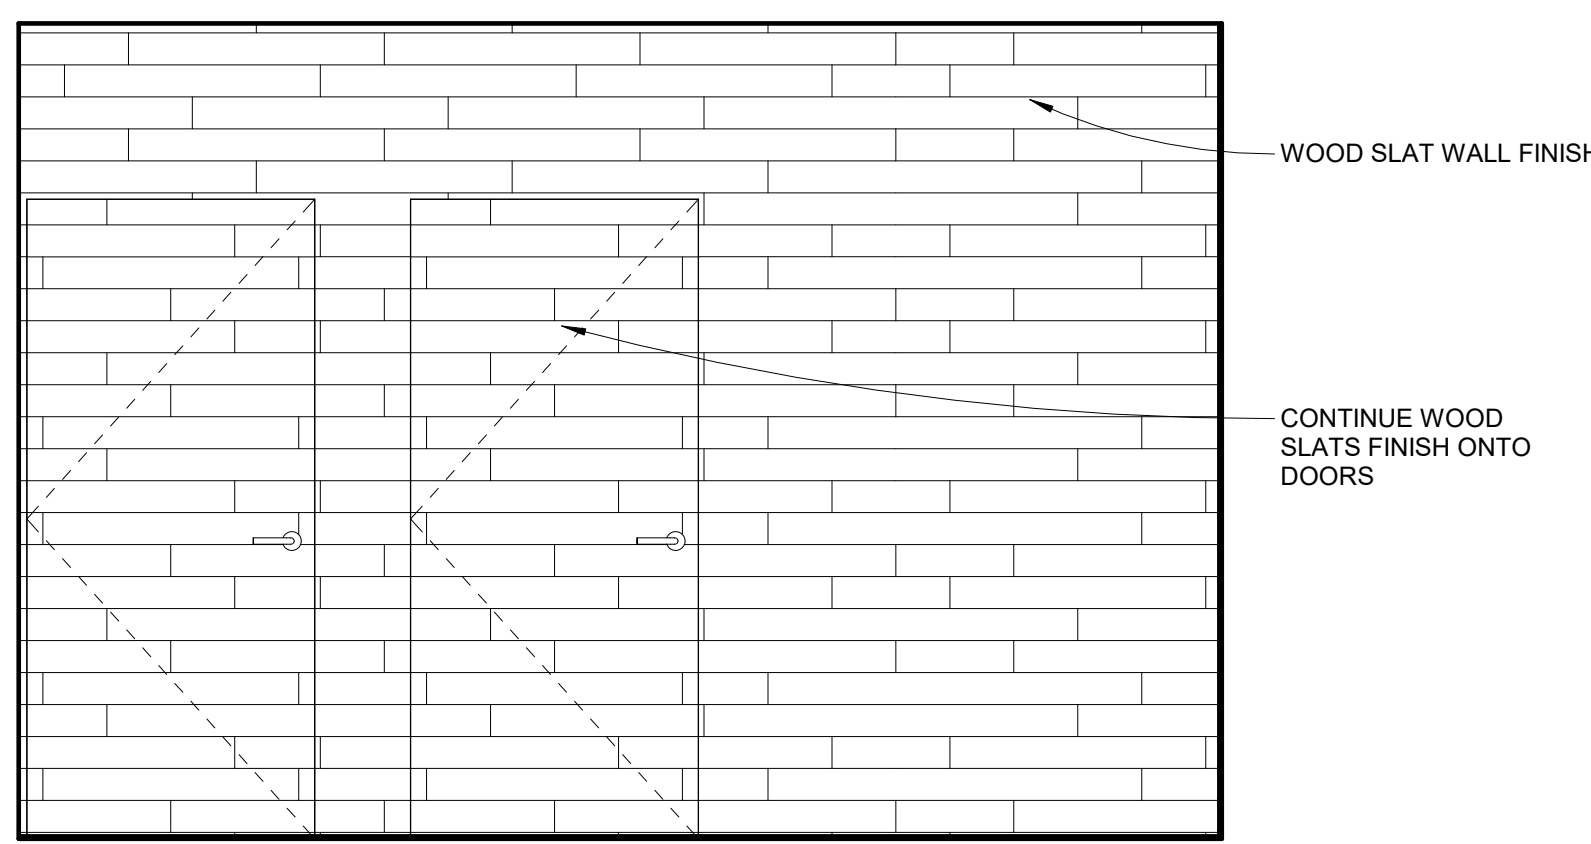

7 BATHROOM STALL DOORS ELEVATION  
1/2" = 1'-0"

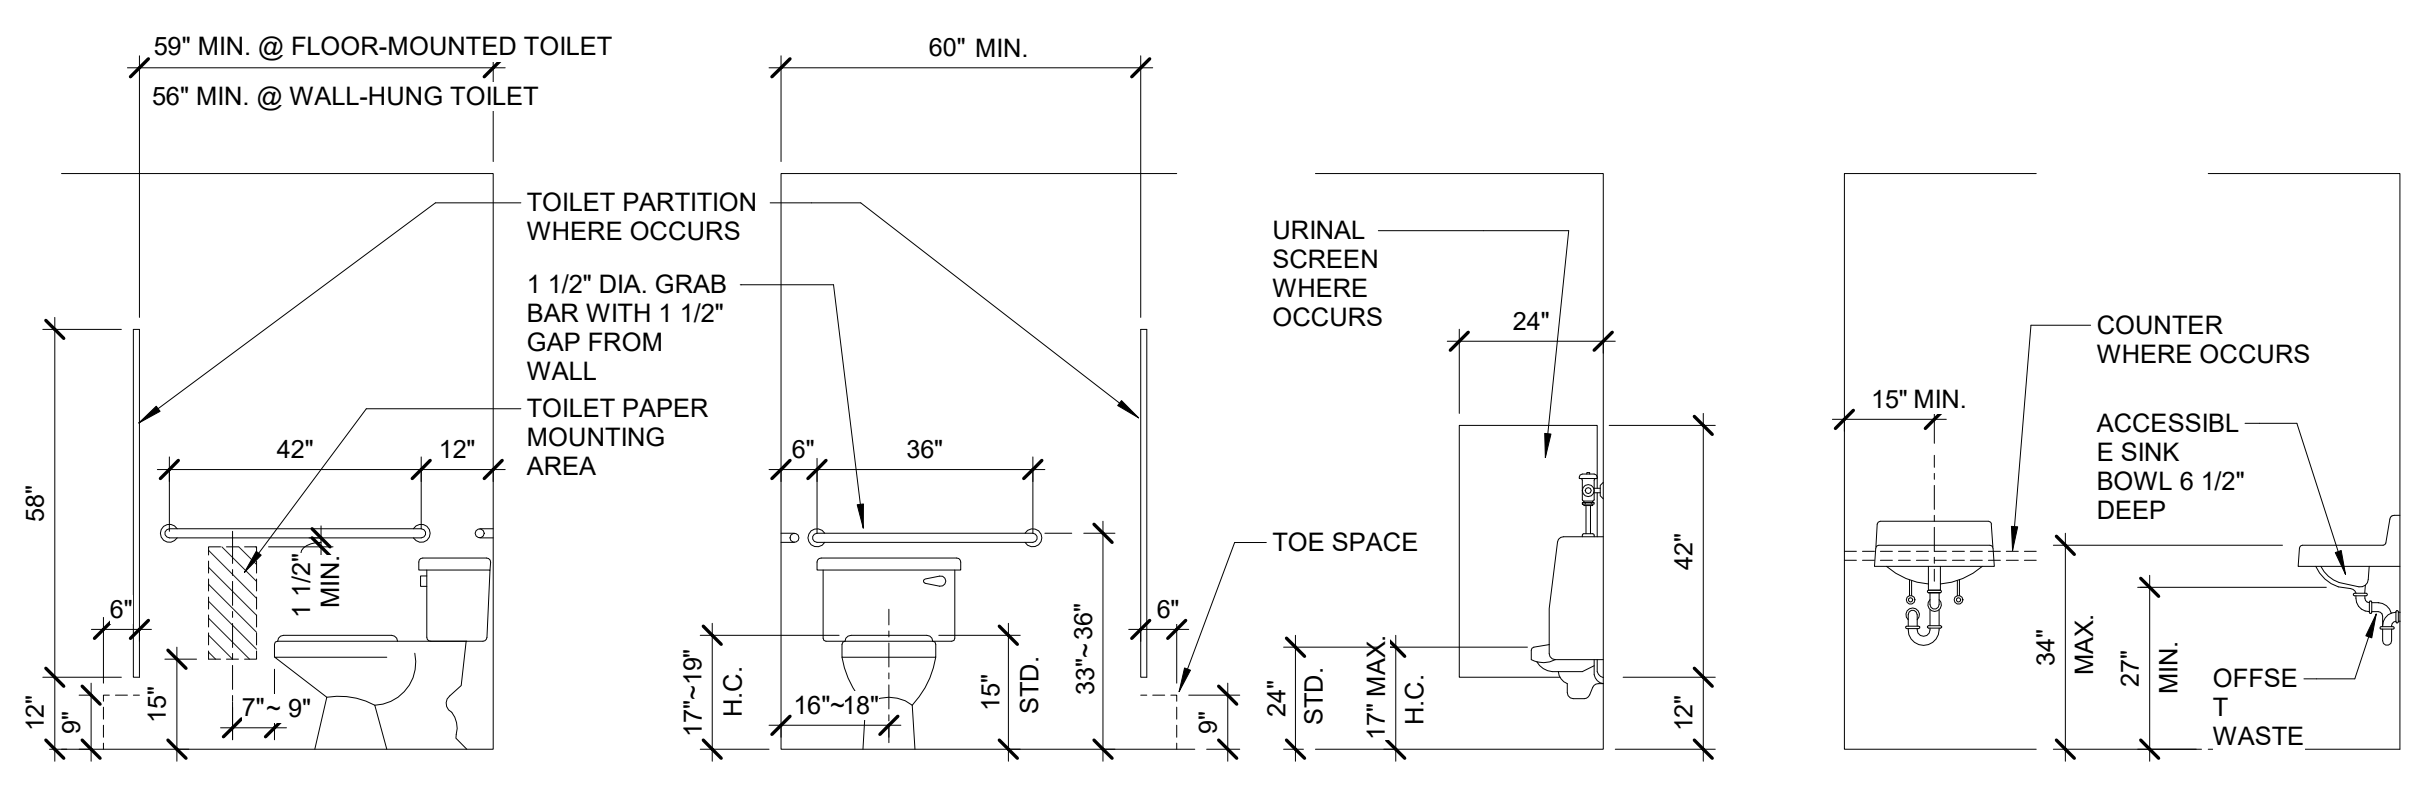

**TYPICAL PLUMBING FIXTURES AND ACCESSORIES MOUNTING HEIGHTS**