

NOT FOR  
CONSTRUCTION

80 EXCHANGE STREET  
PORTLAND, MAINE  
OFFICE RENOVATION

**BRI BURN**  
architecture for life  
28 Maple St. Suite 202 Portland, ME 04101 (207) 774-8482


CONSULTANTS:  
**RIPCORD**  
engineering  
PO BOX 4175  
PORTLAND, ME 04101  
207-835-4060  
www.ripcorengineering.com

REVISIONS:

No.	Name	Date

ISSUED:  
PROJECT No: 17-029  
DRAWN BY: JPS  
CHECKED BY: SMB  
SHEET TITLE:  
HVAC ROOF  
PLAN

M104

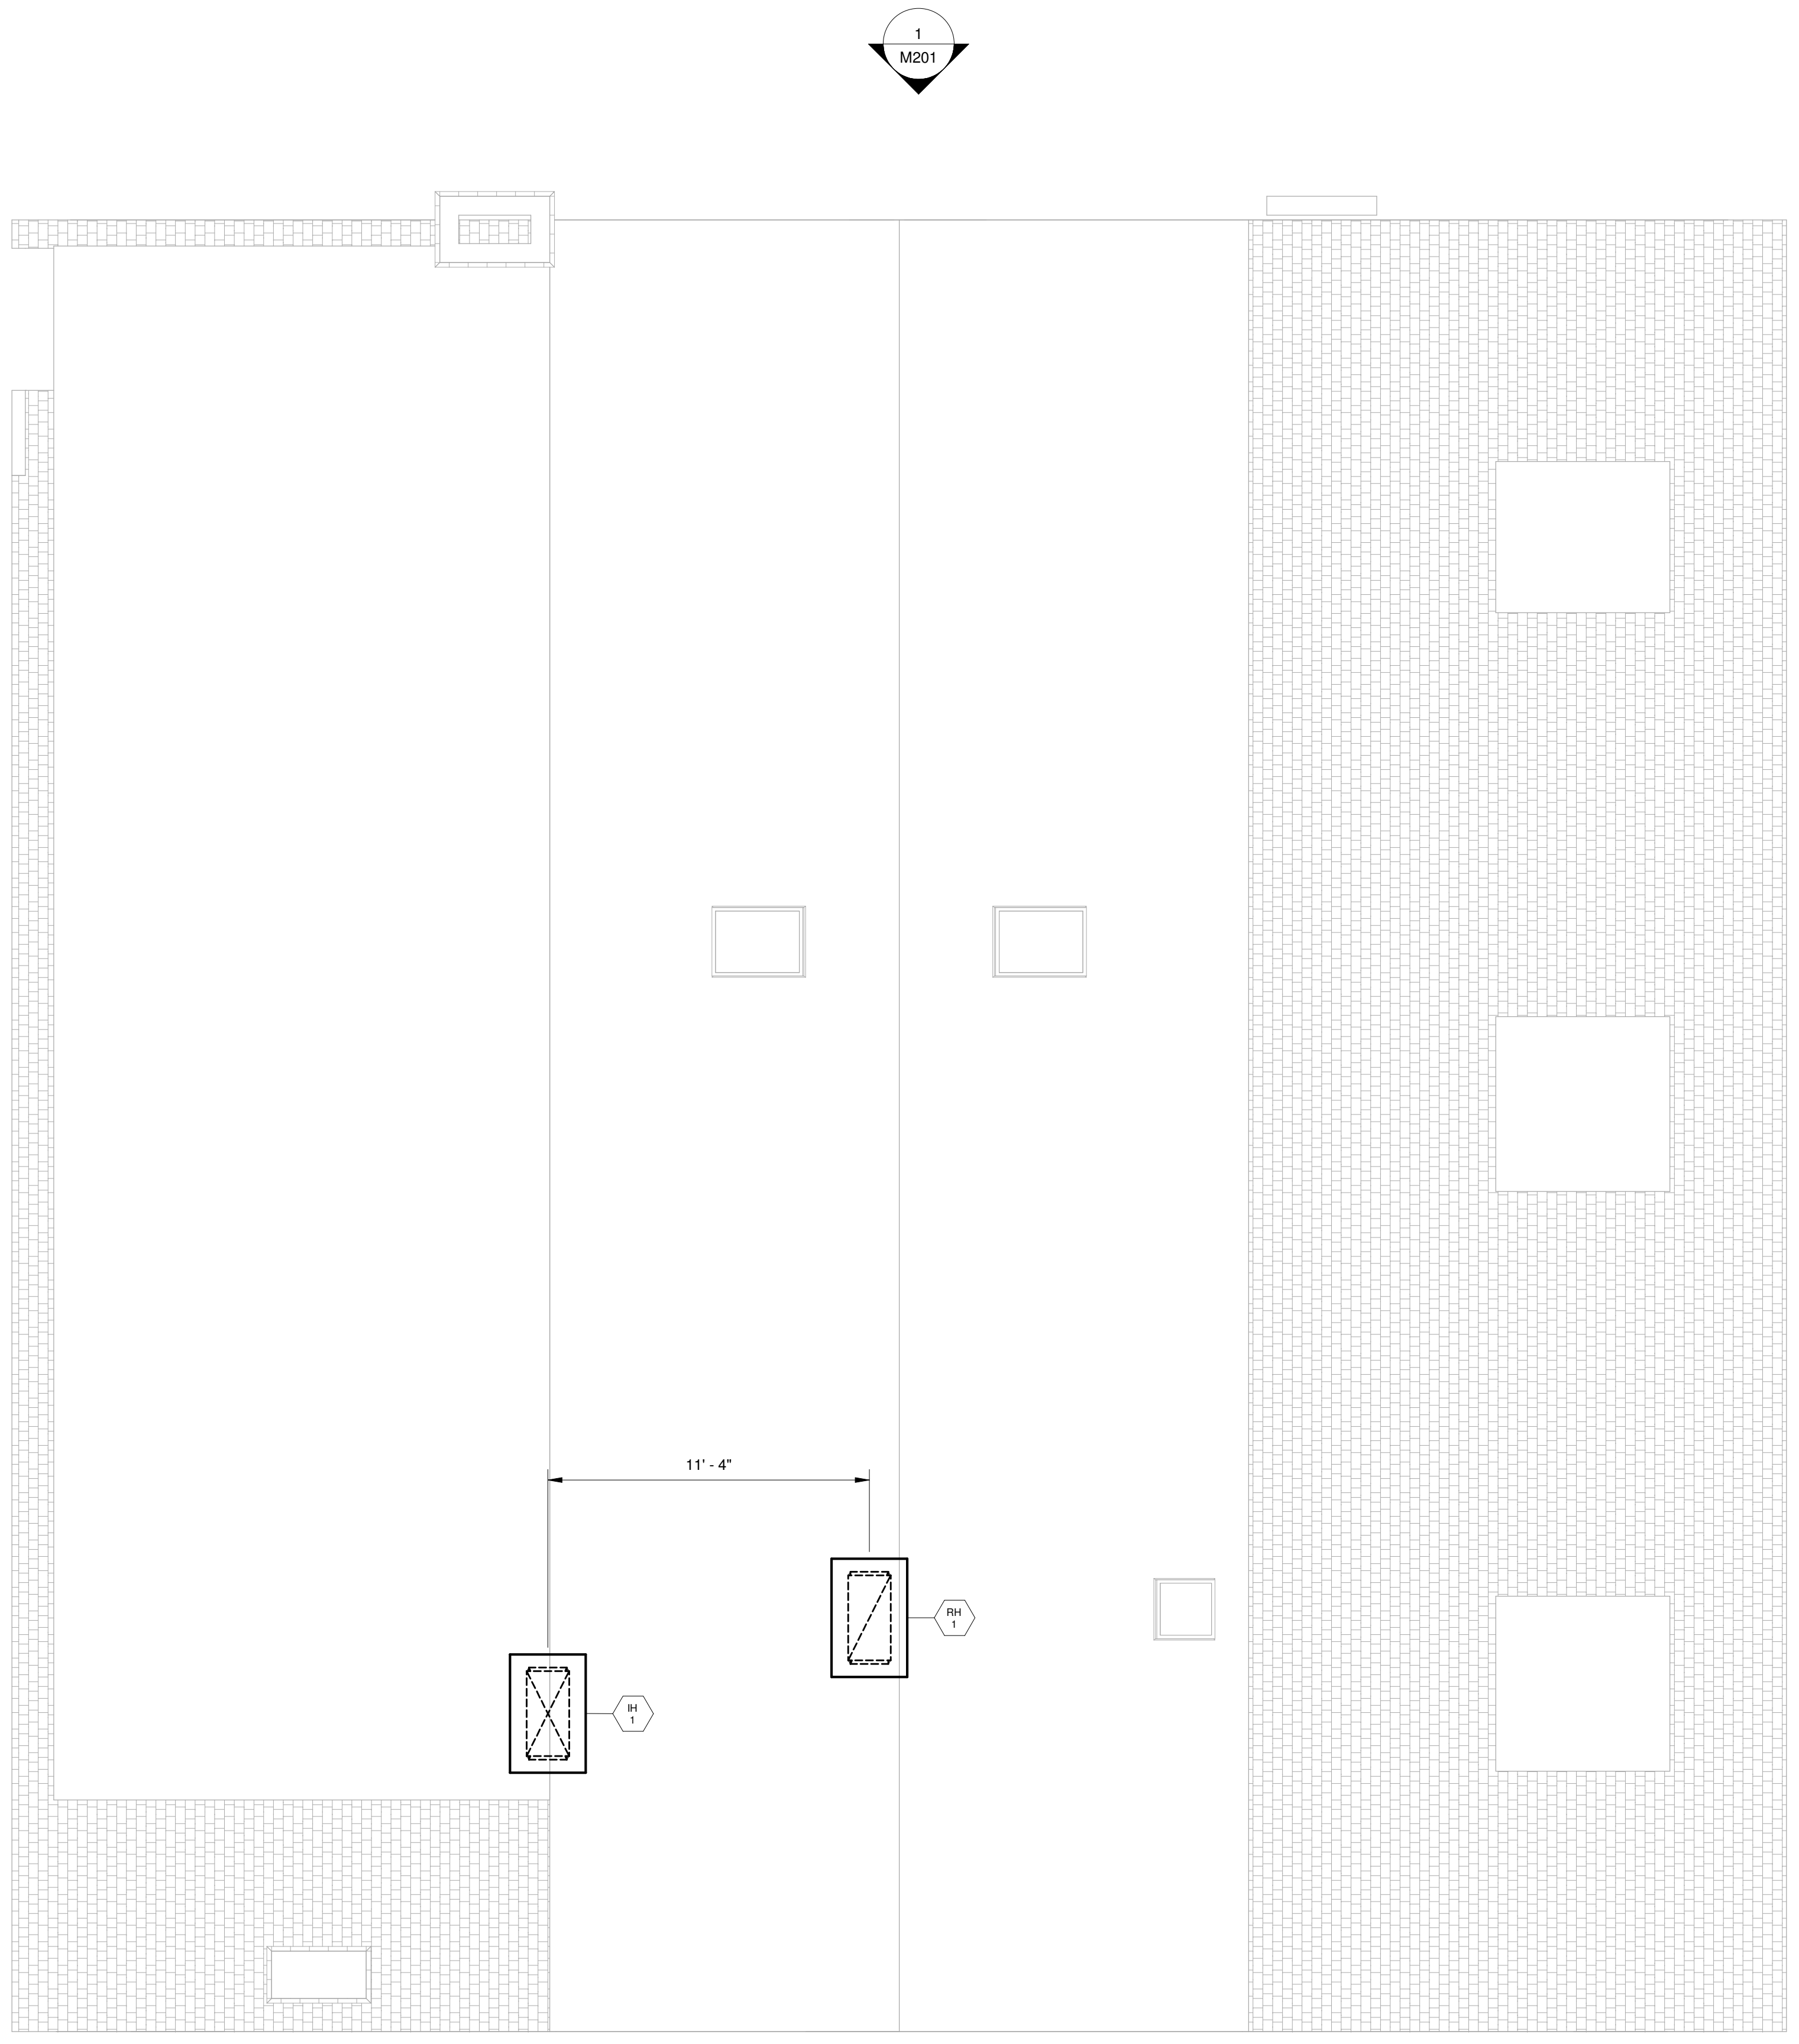

1 HVAC ROOF PLAN  
1/4" = 1'-0"