




01 TOILET ELEVATION
1/2" = 1'-0"

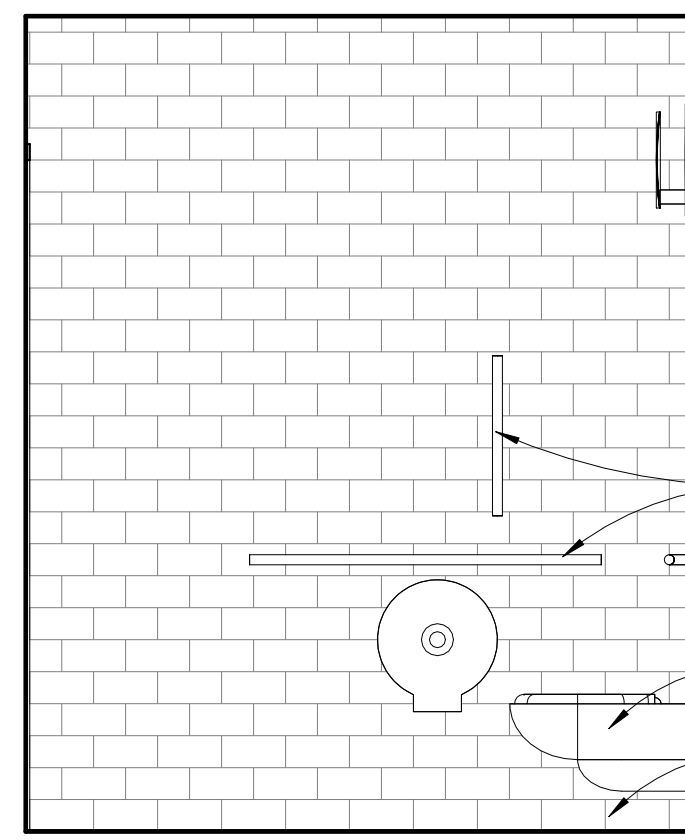


02 TOILET ELEVATION
1/2" = 1'-0"

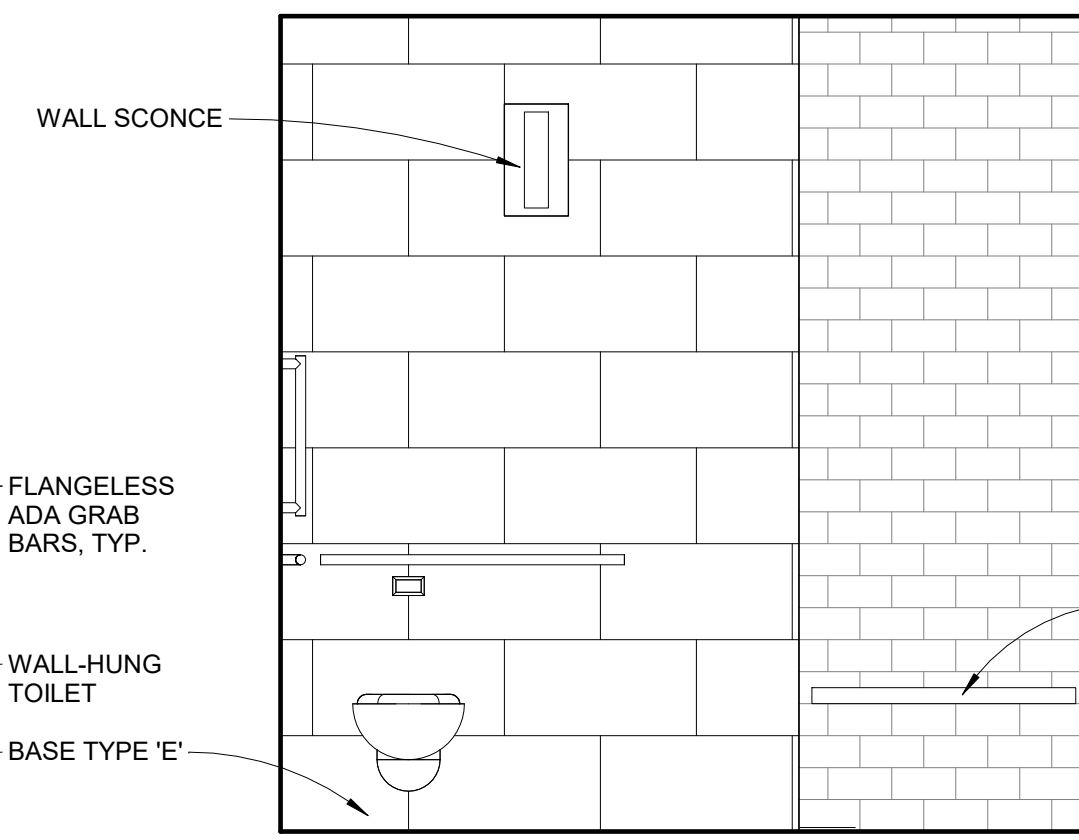


03 TOILET/SHOWER ELEVATION
1/2" = 1'-0"

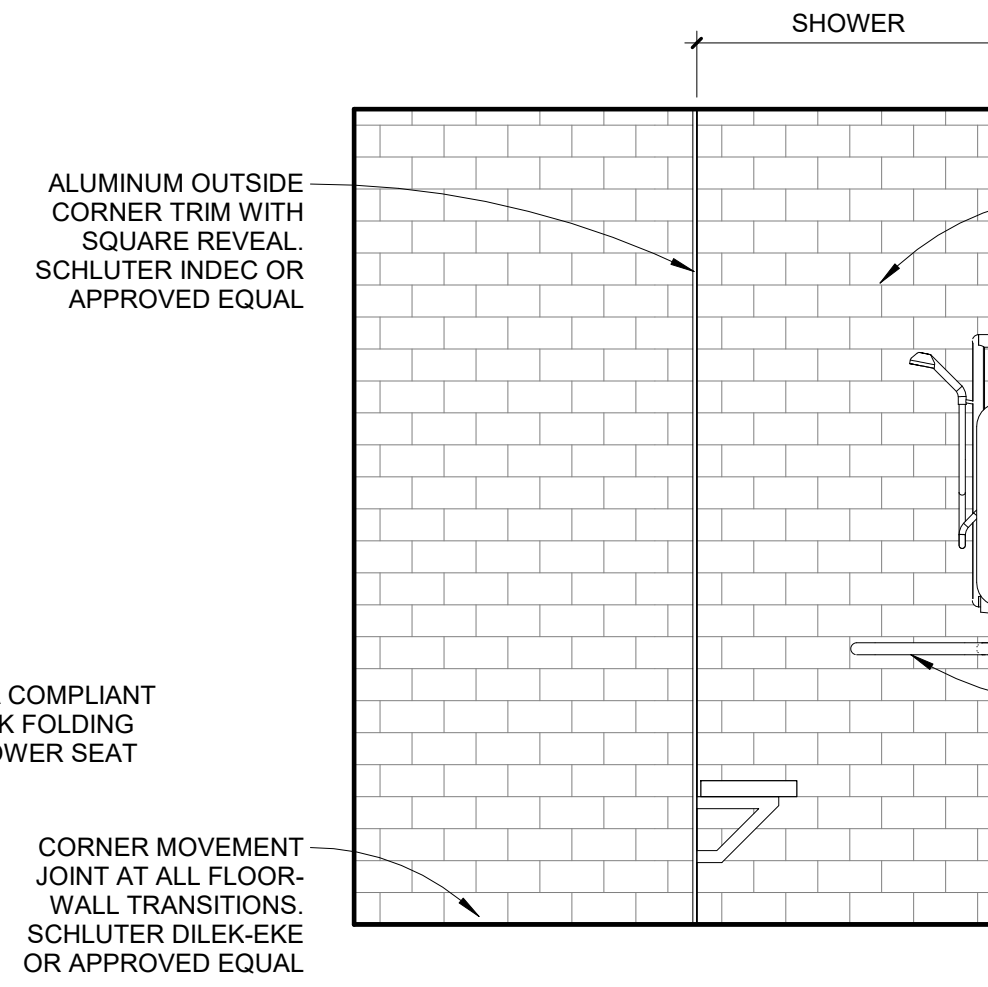


04 SHOWER ELEVATION
1/2" = 1'-0"

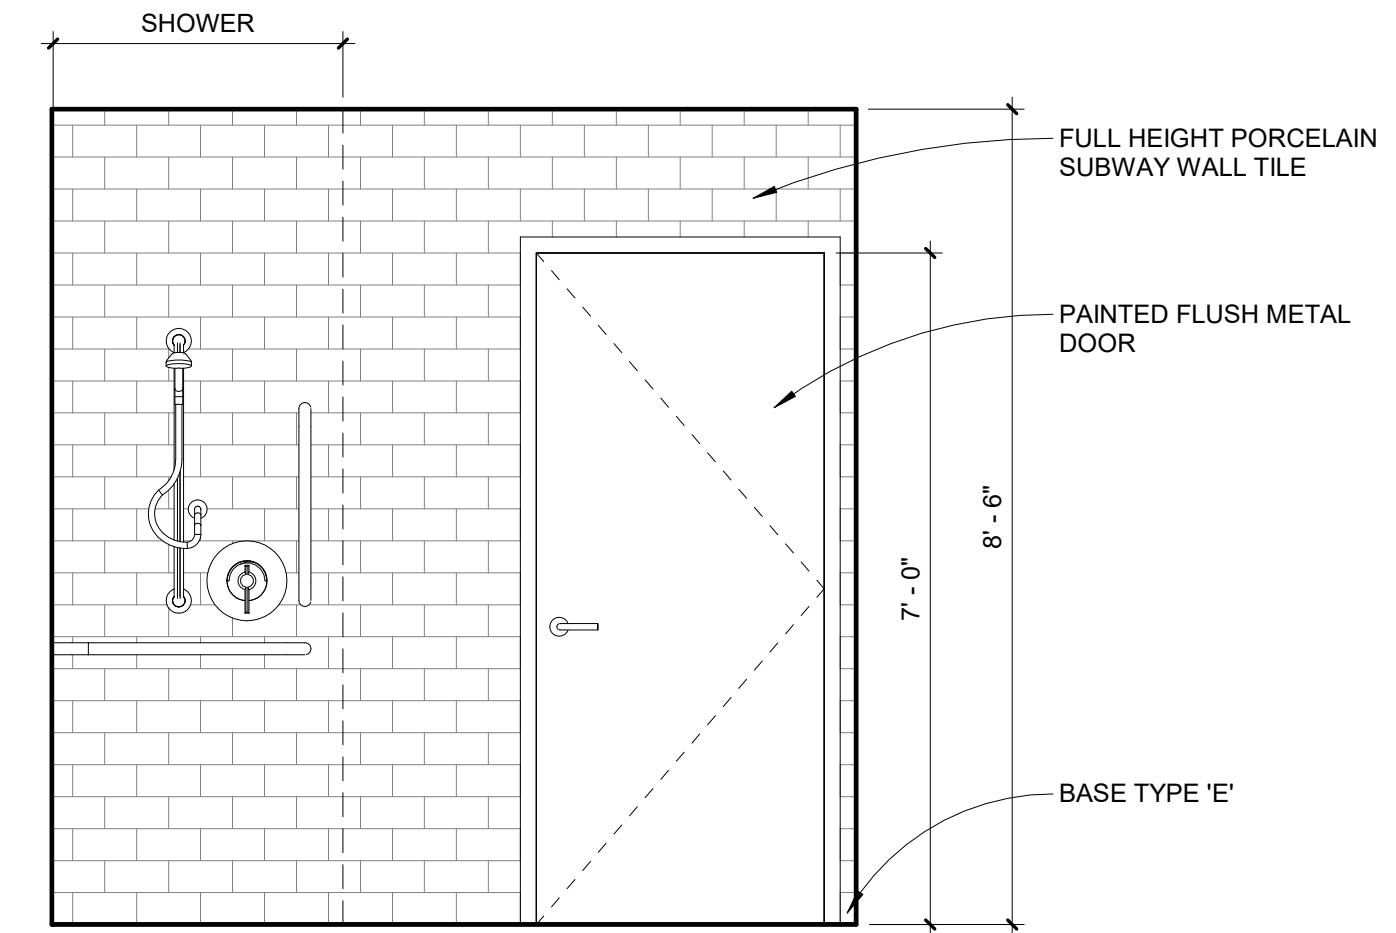


05 SHOWER ELEVATION
1/2" = 1'-0"

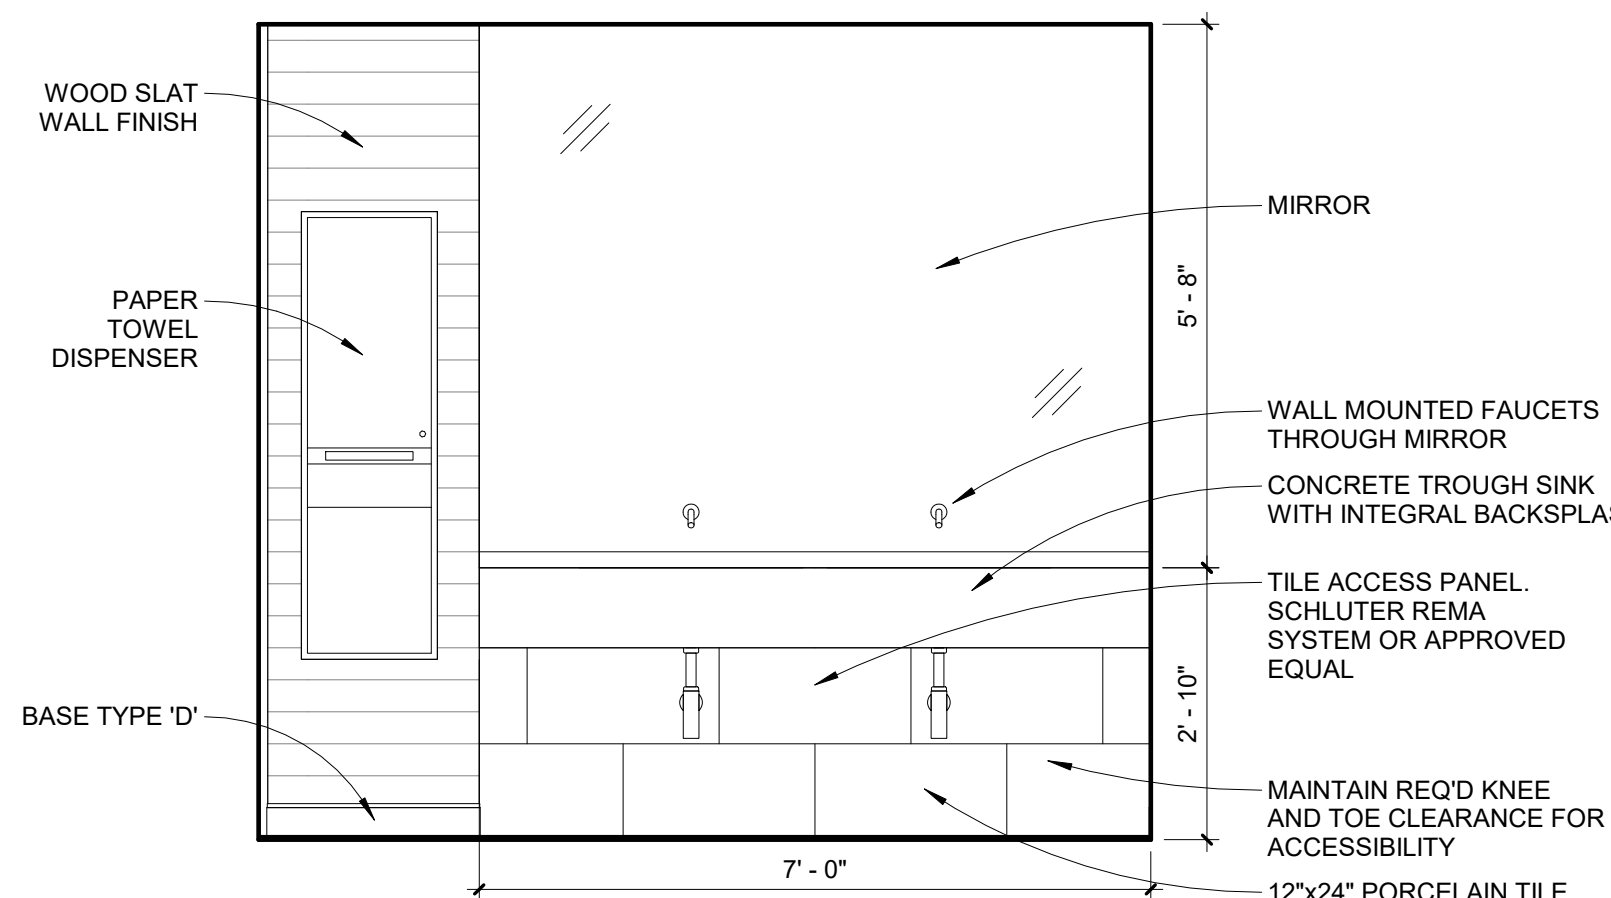


07 BATHROOM SINK ELEVATION
1/2" = 1'-0"

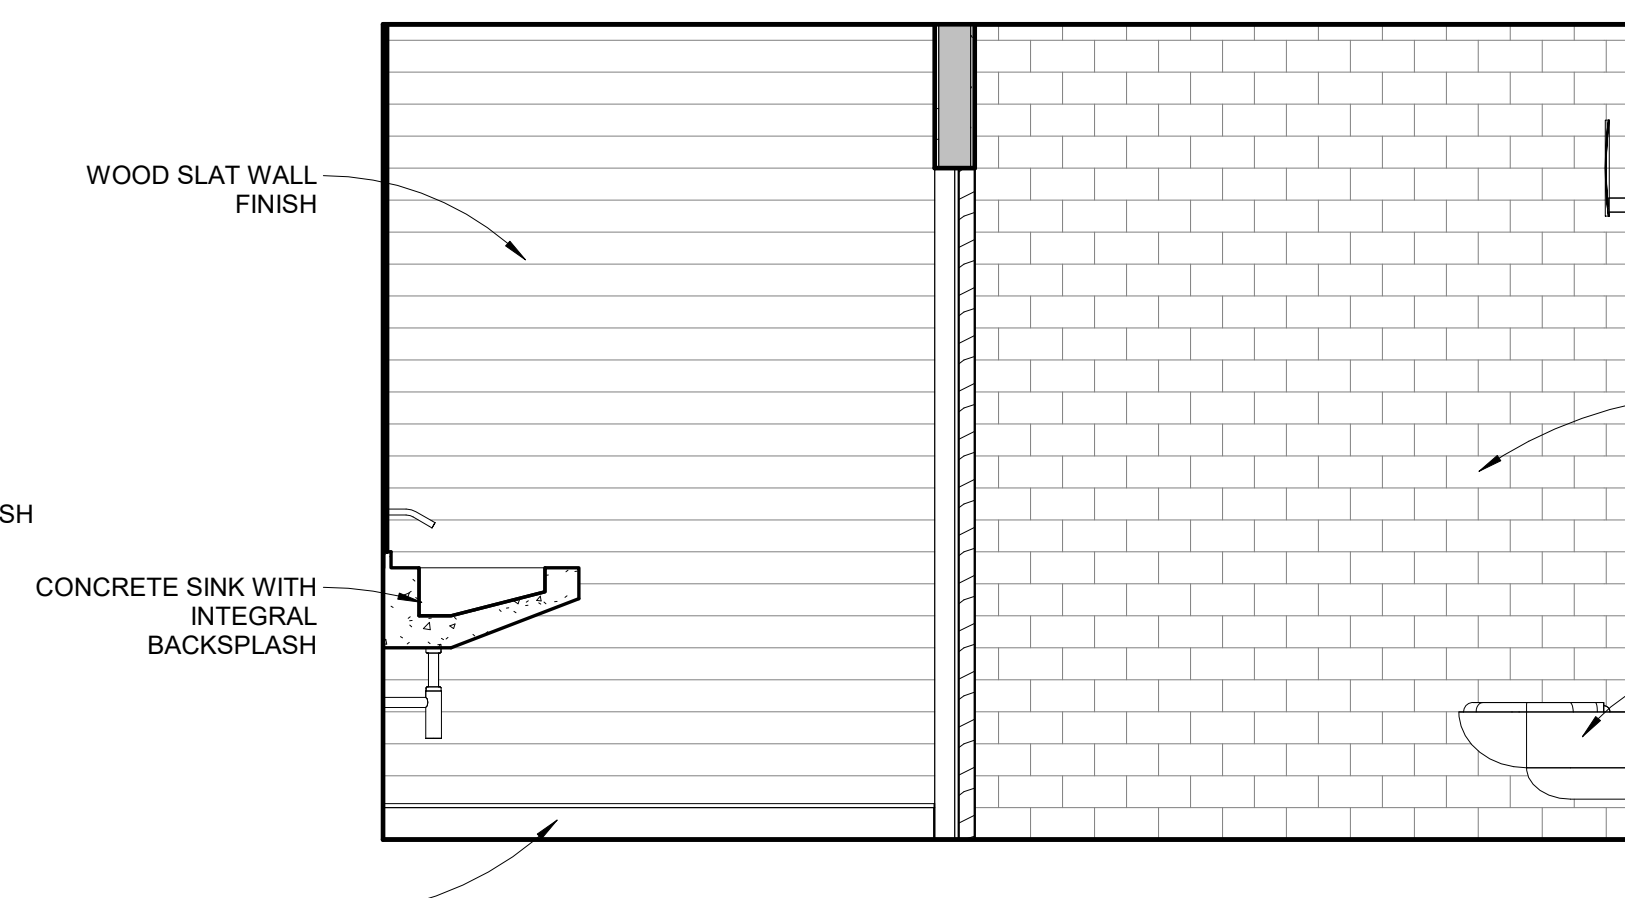


09 TOILET ELEVATION
1/2" = 1'-0"

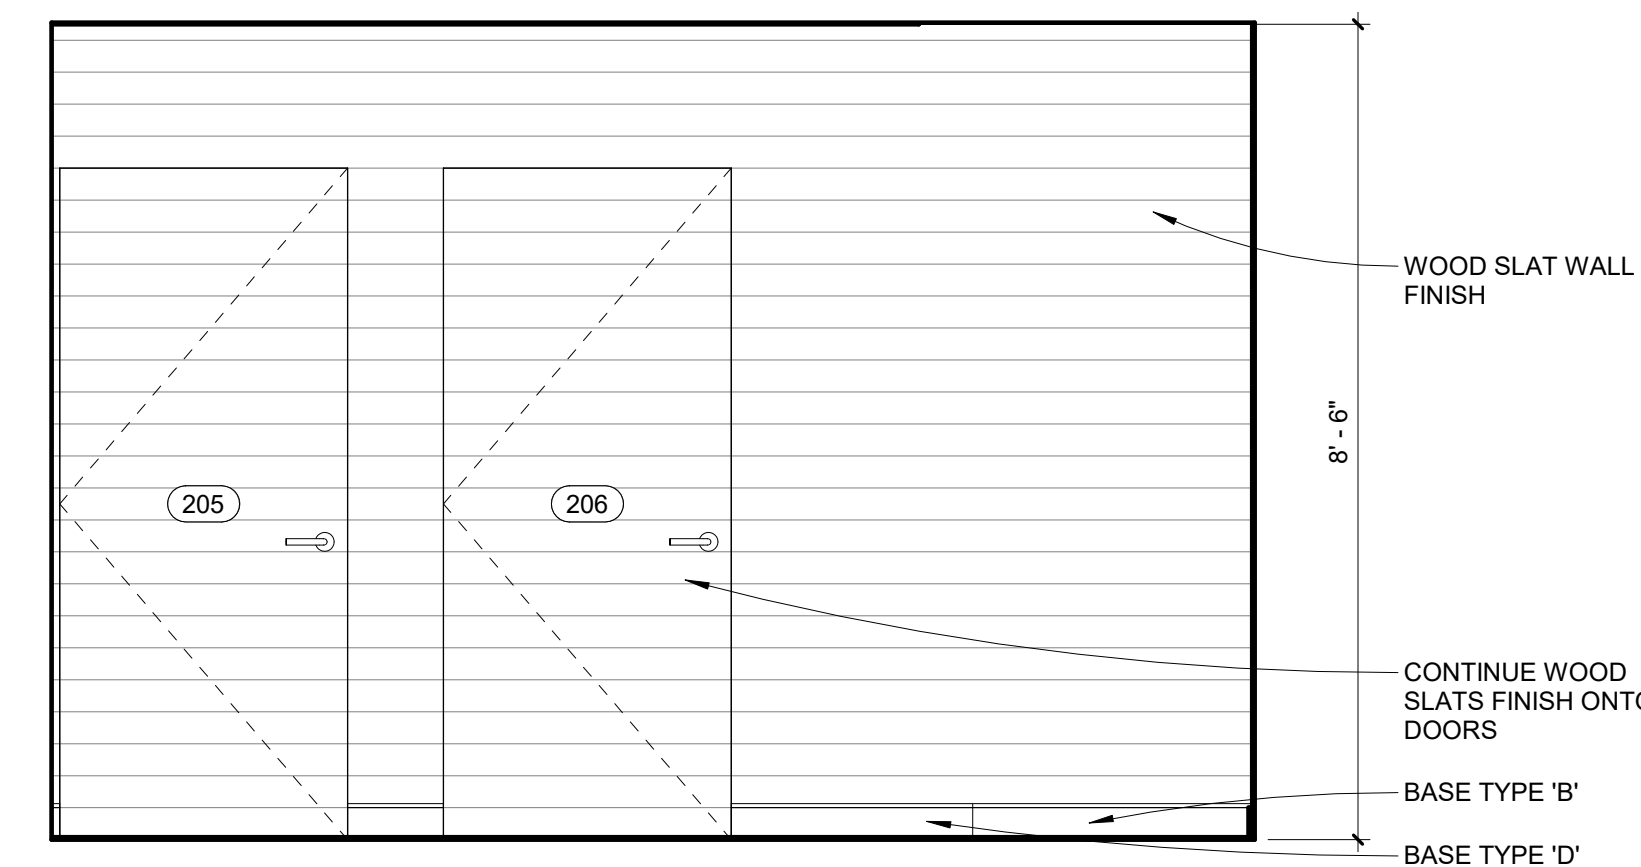


08 BATHROOM STALL DOORS ELEVATION
1/2" = 1'-0"

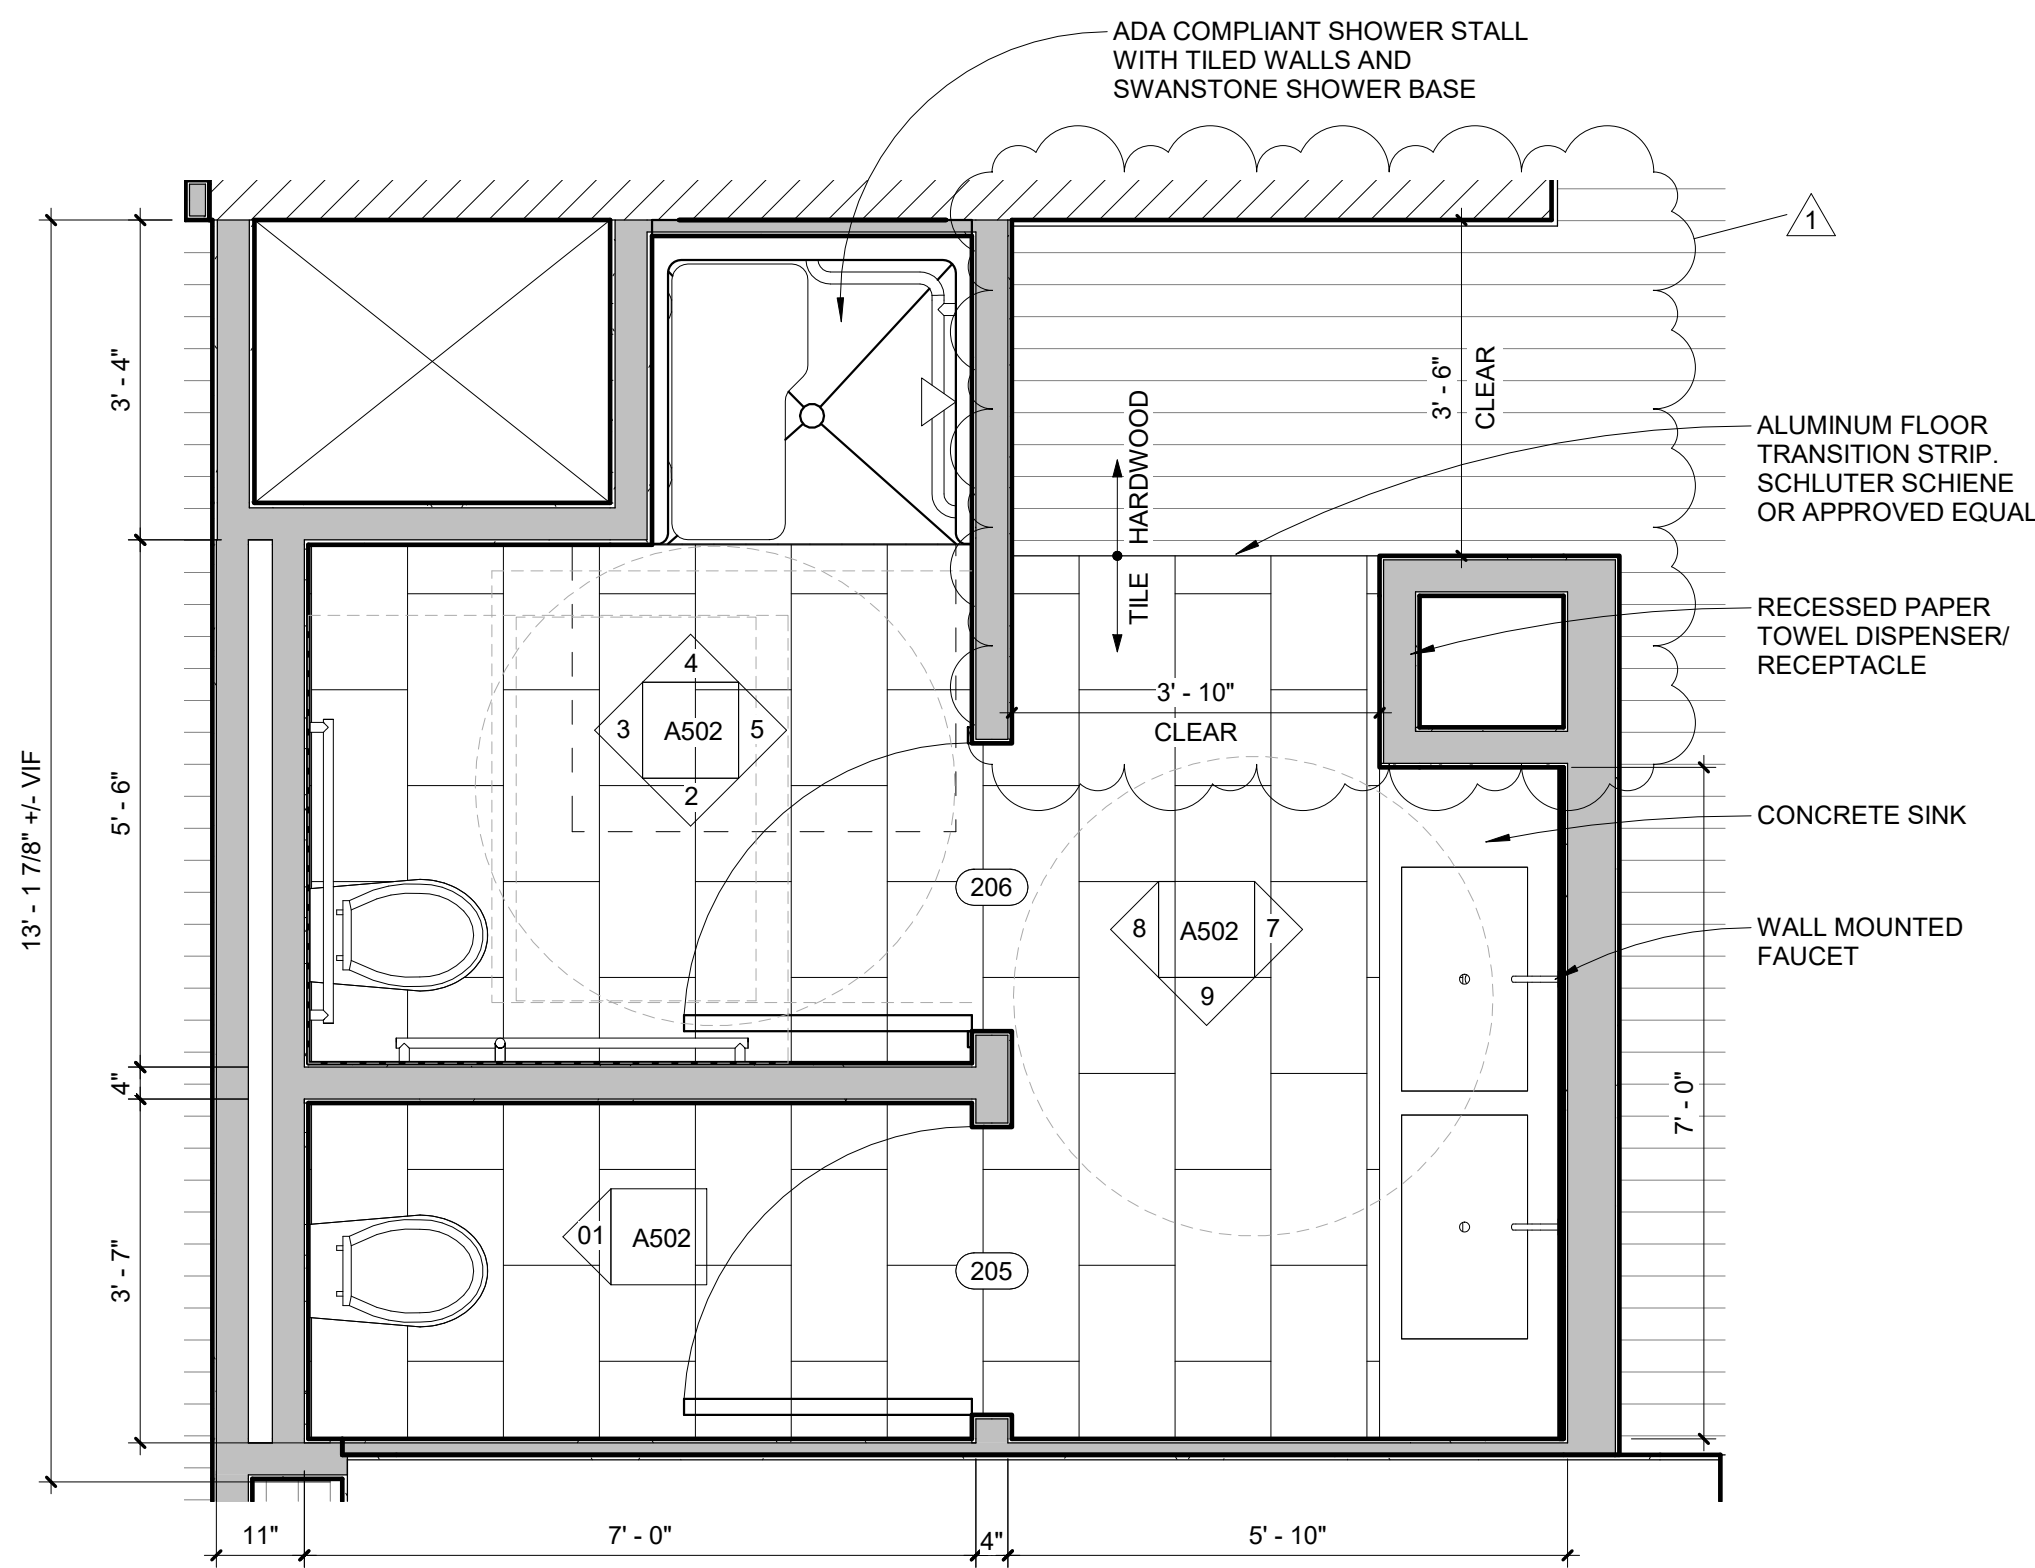

06 TYPICAL BATHROOM ENLARGED PLAN
1/2" = 1'-0"

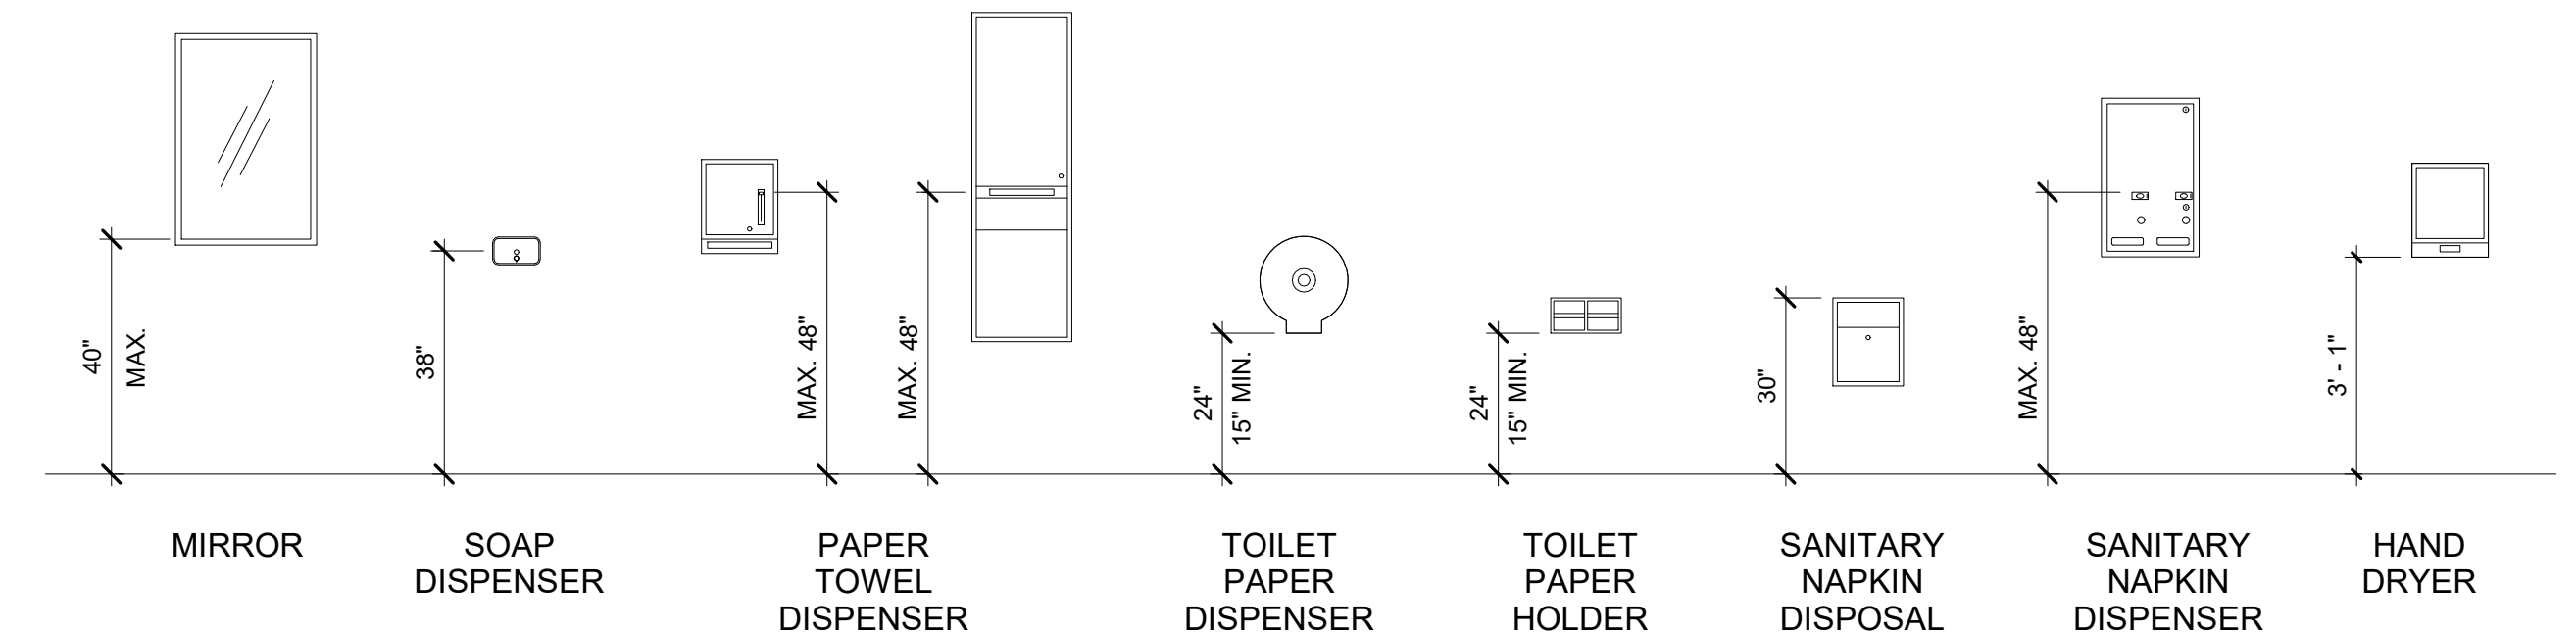

TYPICAL TOILET ACCESSORIES MOUNTING HEIGHTS

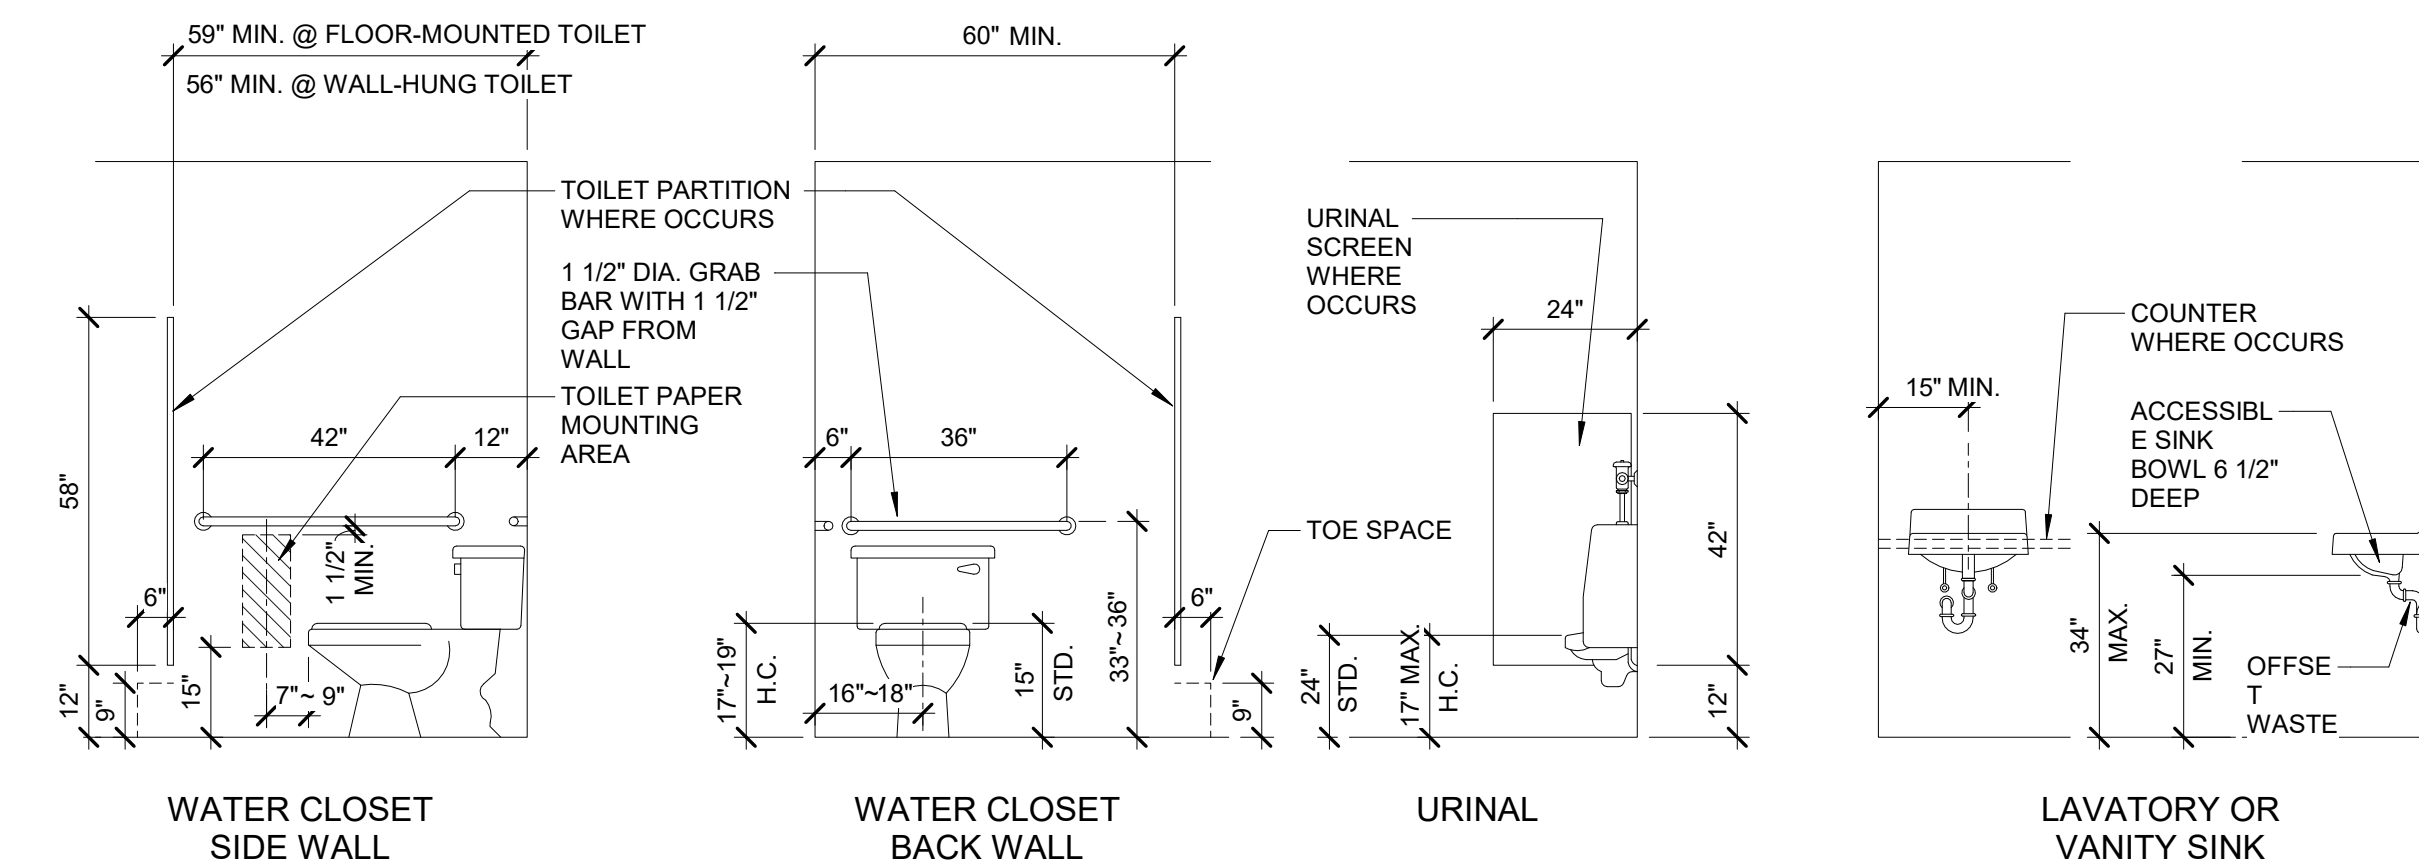

TYPICAL PLUMBING FIXTURES AND ACCESSORIES MOUNTING HEIGHTS

REVISIONS:

No.	Name	Date
1	REV 1	1/5/18

ISSUED FOR PERMITTING

ISSUED: 11/01/17

PROJECT No: 1714

DRAWN BY: LG

CHECKED BY:

SHEET TITLE:
BATHROOM
ENLARGED
PLANS &
INTERIOR
ELEVATIONS