

REVISION	DESCRIPTION	DATE
0	ISSUED FOR REVIEW & APPROVAL	11/7/2016


RESERVED FOR CITY STAMP

**CUNNINGHAM**  
 Security Systems  
 10 Princes Point Road, Yarmouth, Maine 04096  
 Office: 207.846.3350 • Fax: 207.846.6080


**MACHIAS SAVINGS BANK**  
 193 MIDDLE STREET  
 PORTLAND, MAINE 04101  
**FIRST FLOOR FIRE ALARM PLAN**

DRAWN	JPB UNICAD JOB #16870
CHECKED	WAYNE B. HAWES NCET # 90496
DATE	11/7/2016
REVISION	0
SCALE	1/8" = 1'-0"

**FA-2**

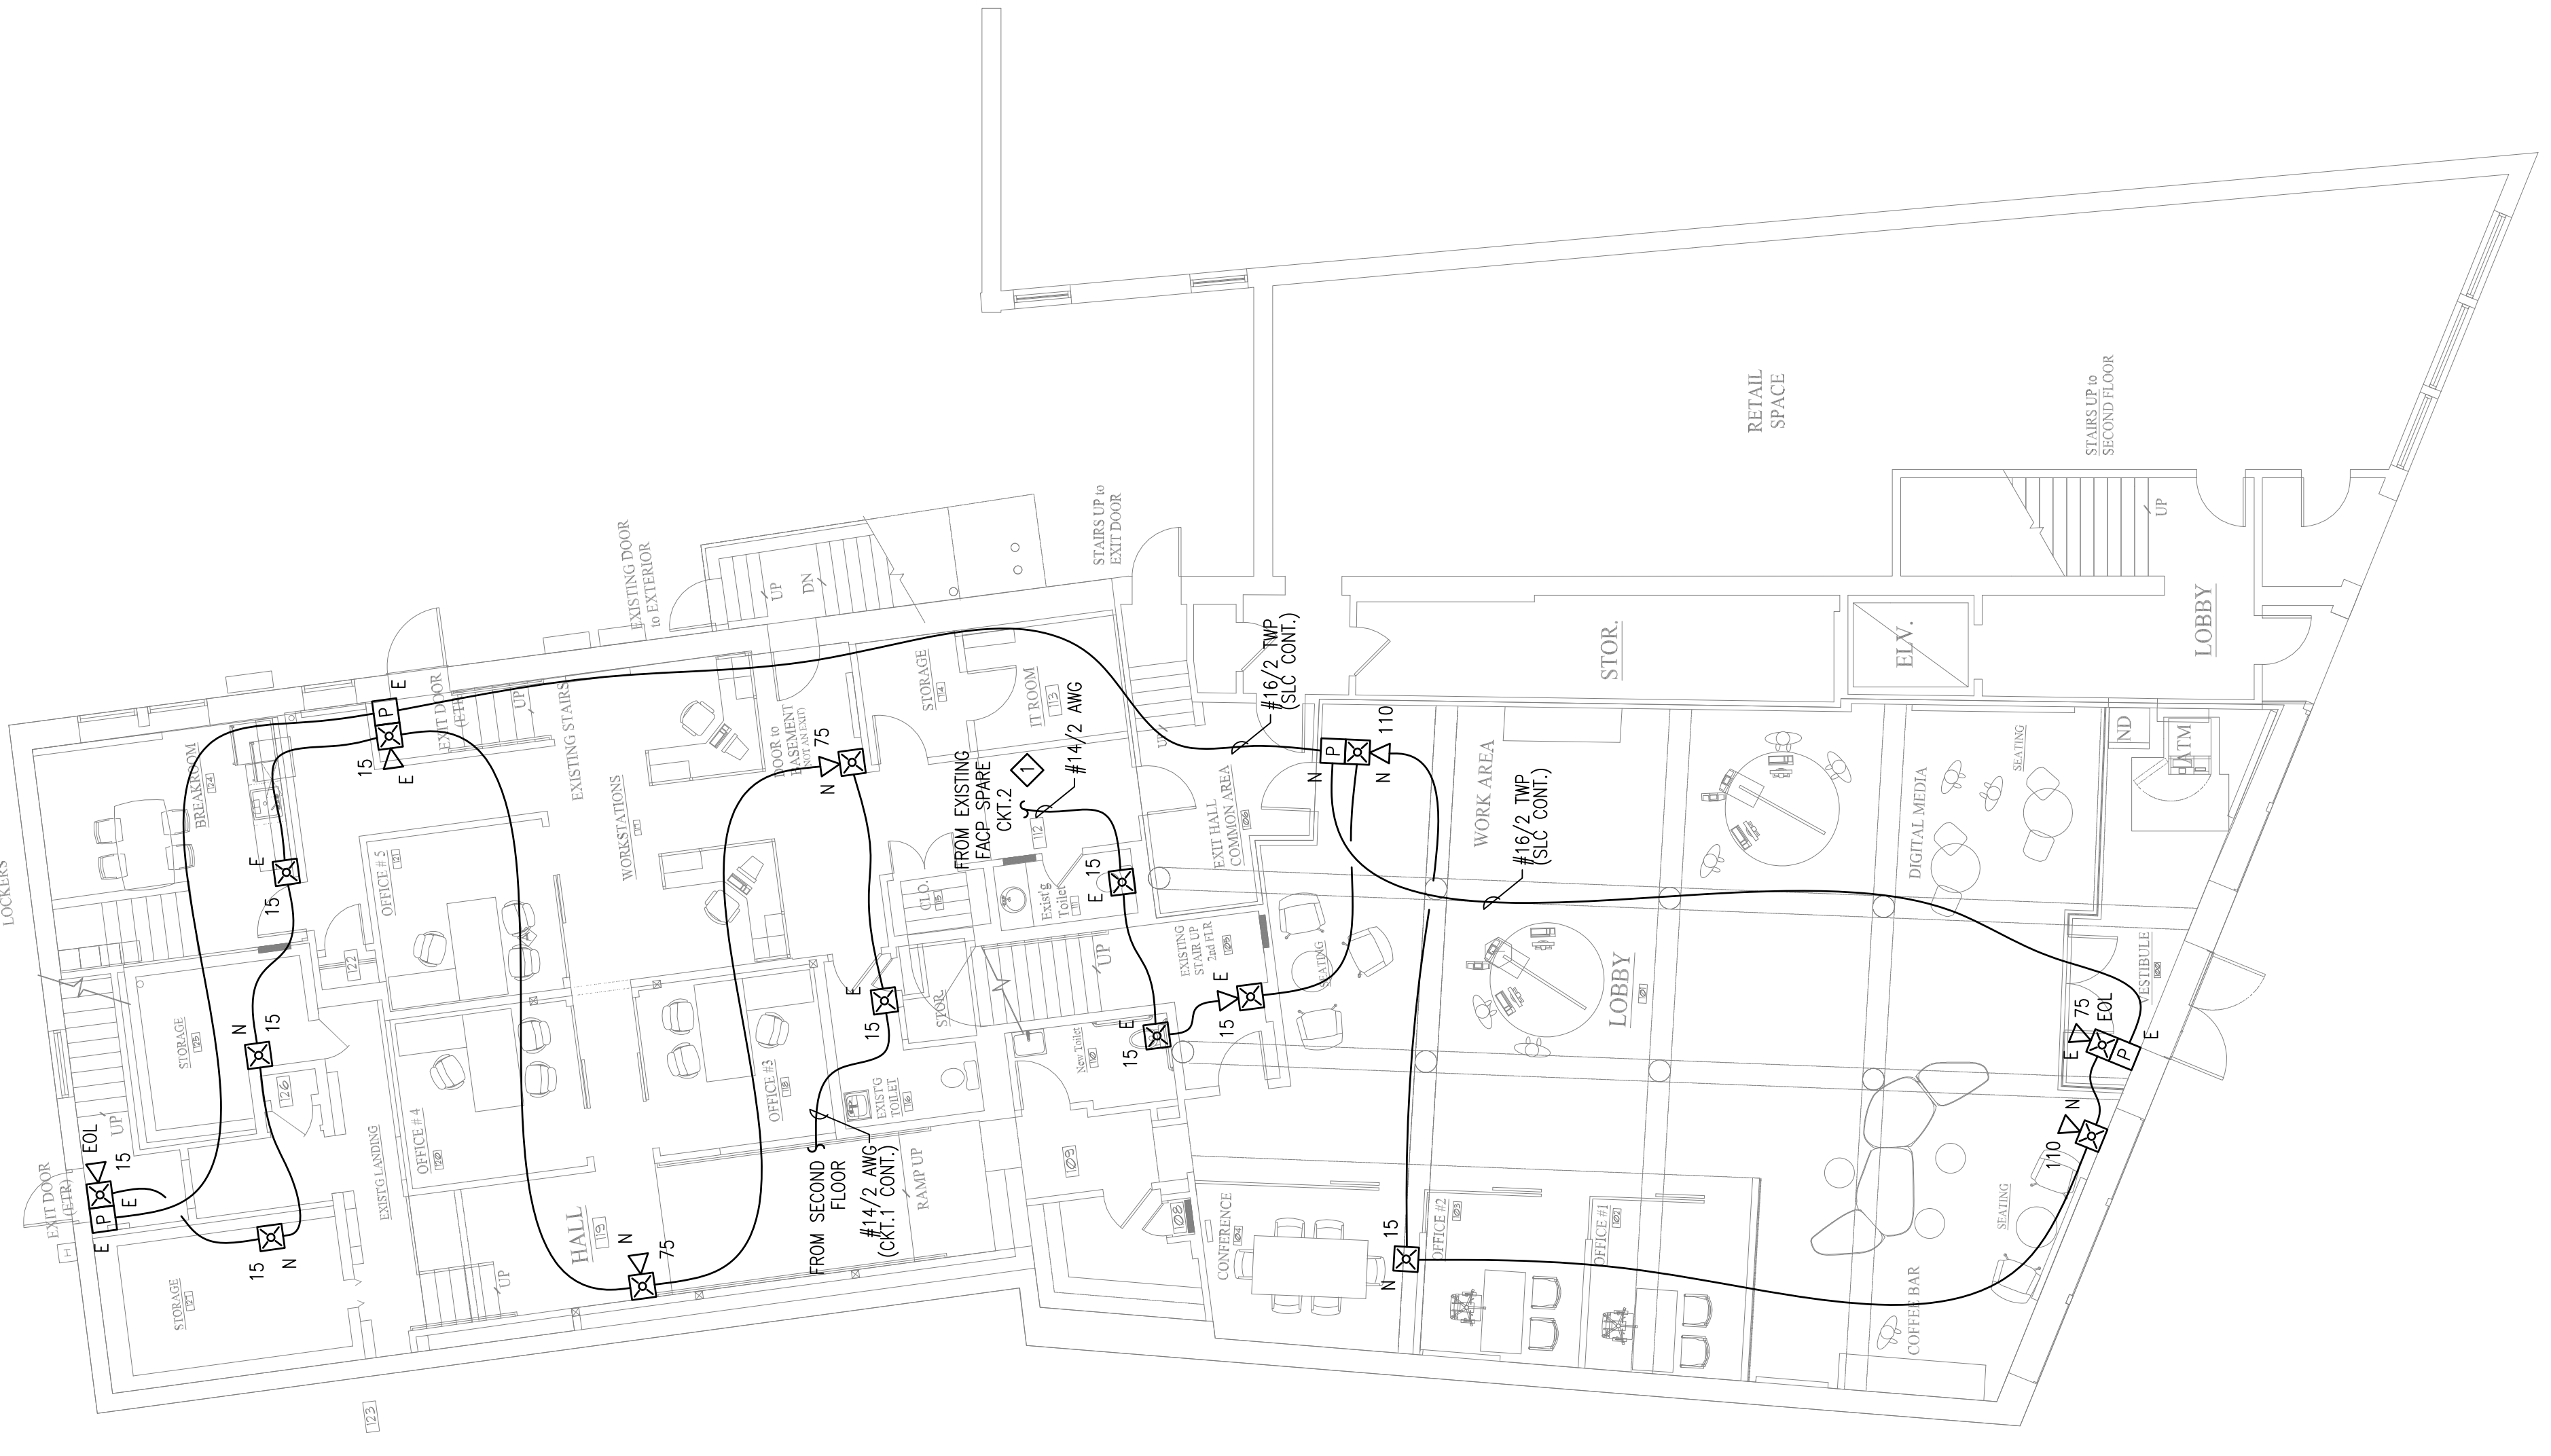

**SHEET NOTES:**  
 ◇ FIELD VERIFY LOCATION OF EXISTING FACP FOR CONNECTION.

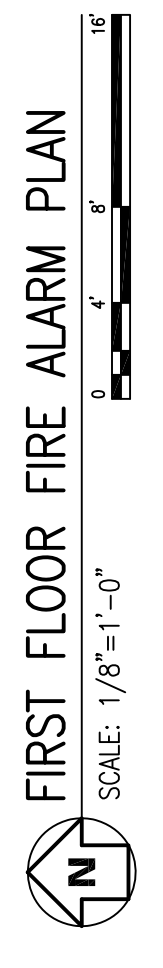

**UNICAD** Inc.  
 Fire Alarm Design & Drafting Services  
 578 W. 40th St.  
 Portland, ME 04102  
 Office: 603.865.6410  
 www.unicad.net