


REVISION	DESCRIPTION	DATE
0	ISSUED FOR REVIEW & APPROVAL	11/7/2016

RESERVED FOR CITY STAMP

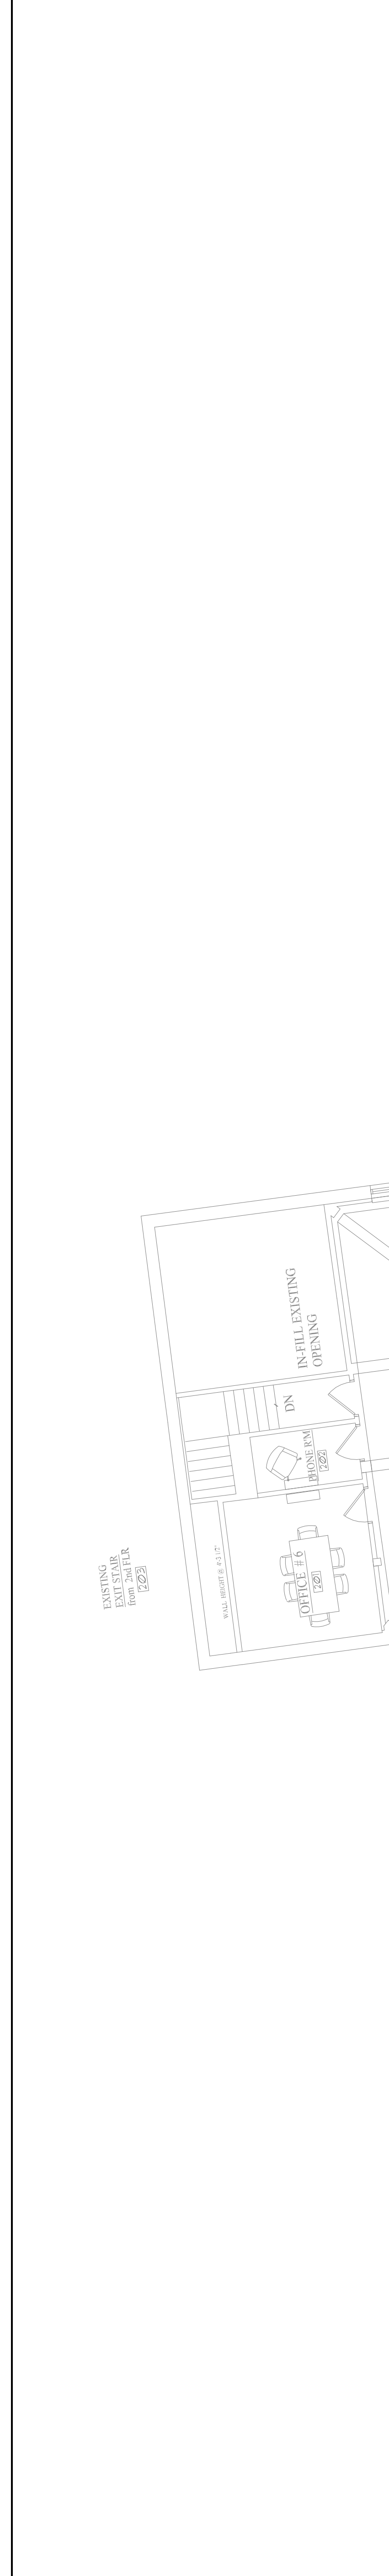

**SECOND FLOOR FIRE ALARM PLAN**  
SCALE: 1/8"=1'-0"

**CUNNINGHAM**  
**Security Systems**  
10 Princes Point Road, Yarmouth, Maine 04096  
Office: 207.846.3350 • Fax: 207.846.6080

**MACHIAS SAVINGS BANK**  
**193 MIDDLE STREET**  
**PORTLAND, MAINE 04101**  
**SECOND FLOOR FIRE ALARM PLAN**

DRAWN	JPB UNICAD JOB #16870
CHECKED	WAYNE B. HAWES NGEET # 90496
DATE	11/7/2016
REVISION	0
SCALE	1/8" = 1'-0"

**FA-3**

**SHEET NOTES:**  
◇ FIELD VERIFY LOCATION OF EXISTING FACP FOR CONNECTION.

**UNICAD** Inc.  
1000 Main Street  
Portland, ME 04101  
Office: 603.865.6410  
www.unicad.net  
Fire Alarm Design & Drafting Services