


**GAWRON
TURGEON
ARCHITECTS**
29 Black Point Road
Scarborough, ME 04074
www.gawronturgeon.com
Tel. 207 . 883 . 6307
Fax. 207 . 883 . 0361

KeyBank
Office Renovation
One Canal Plaza

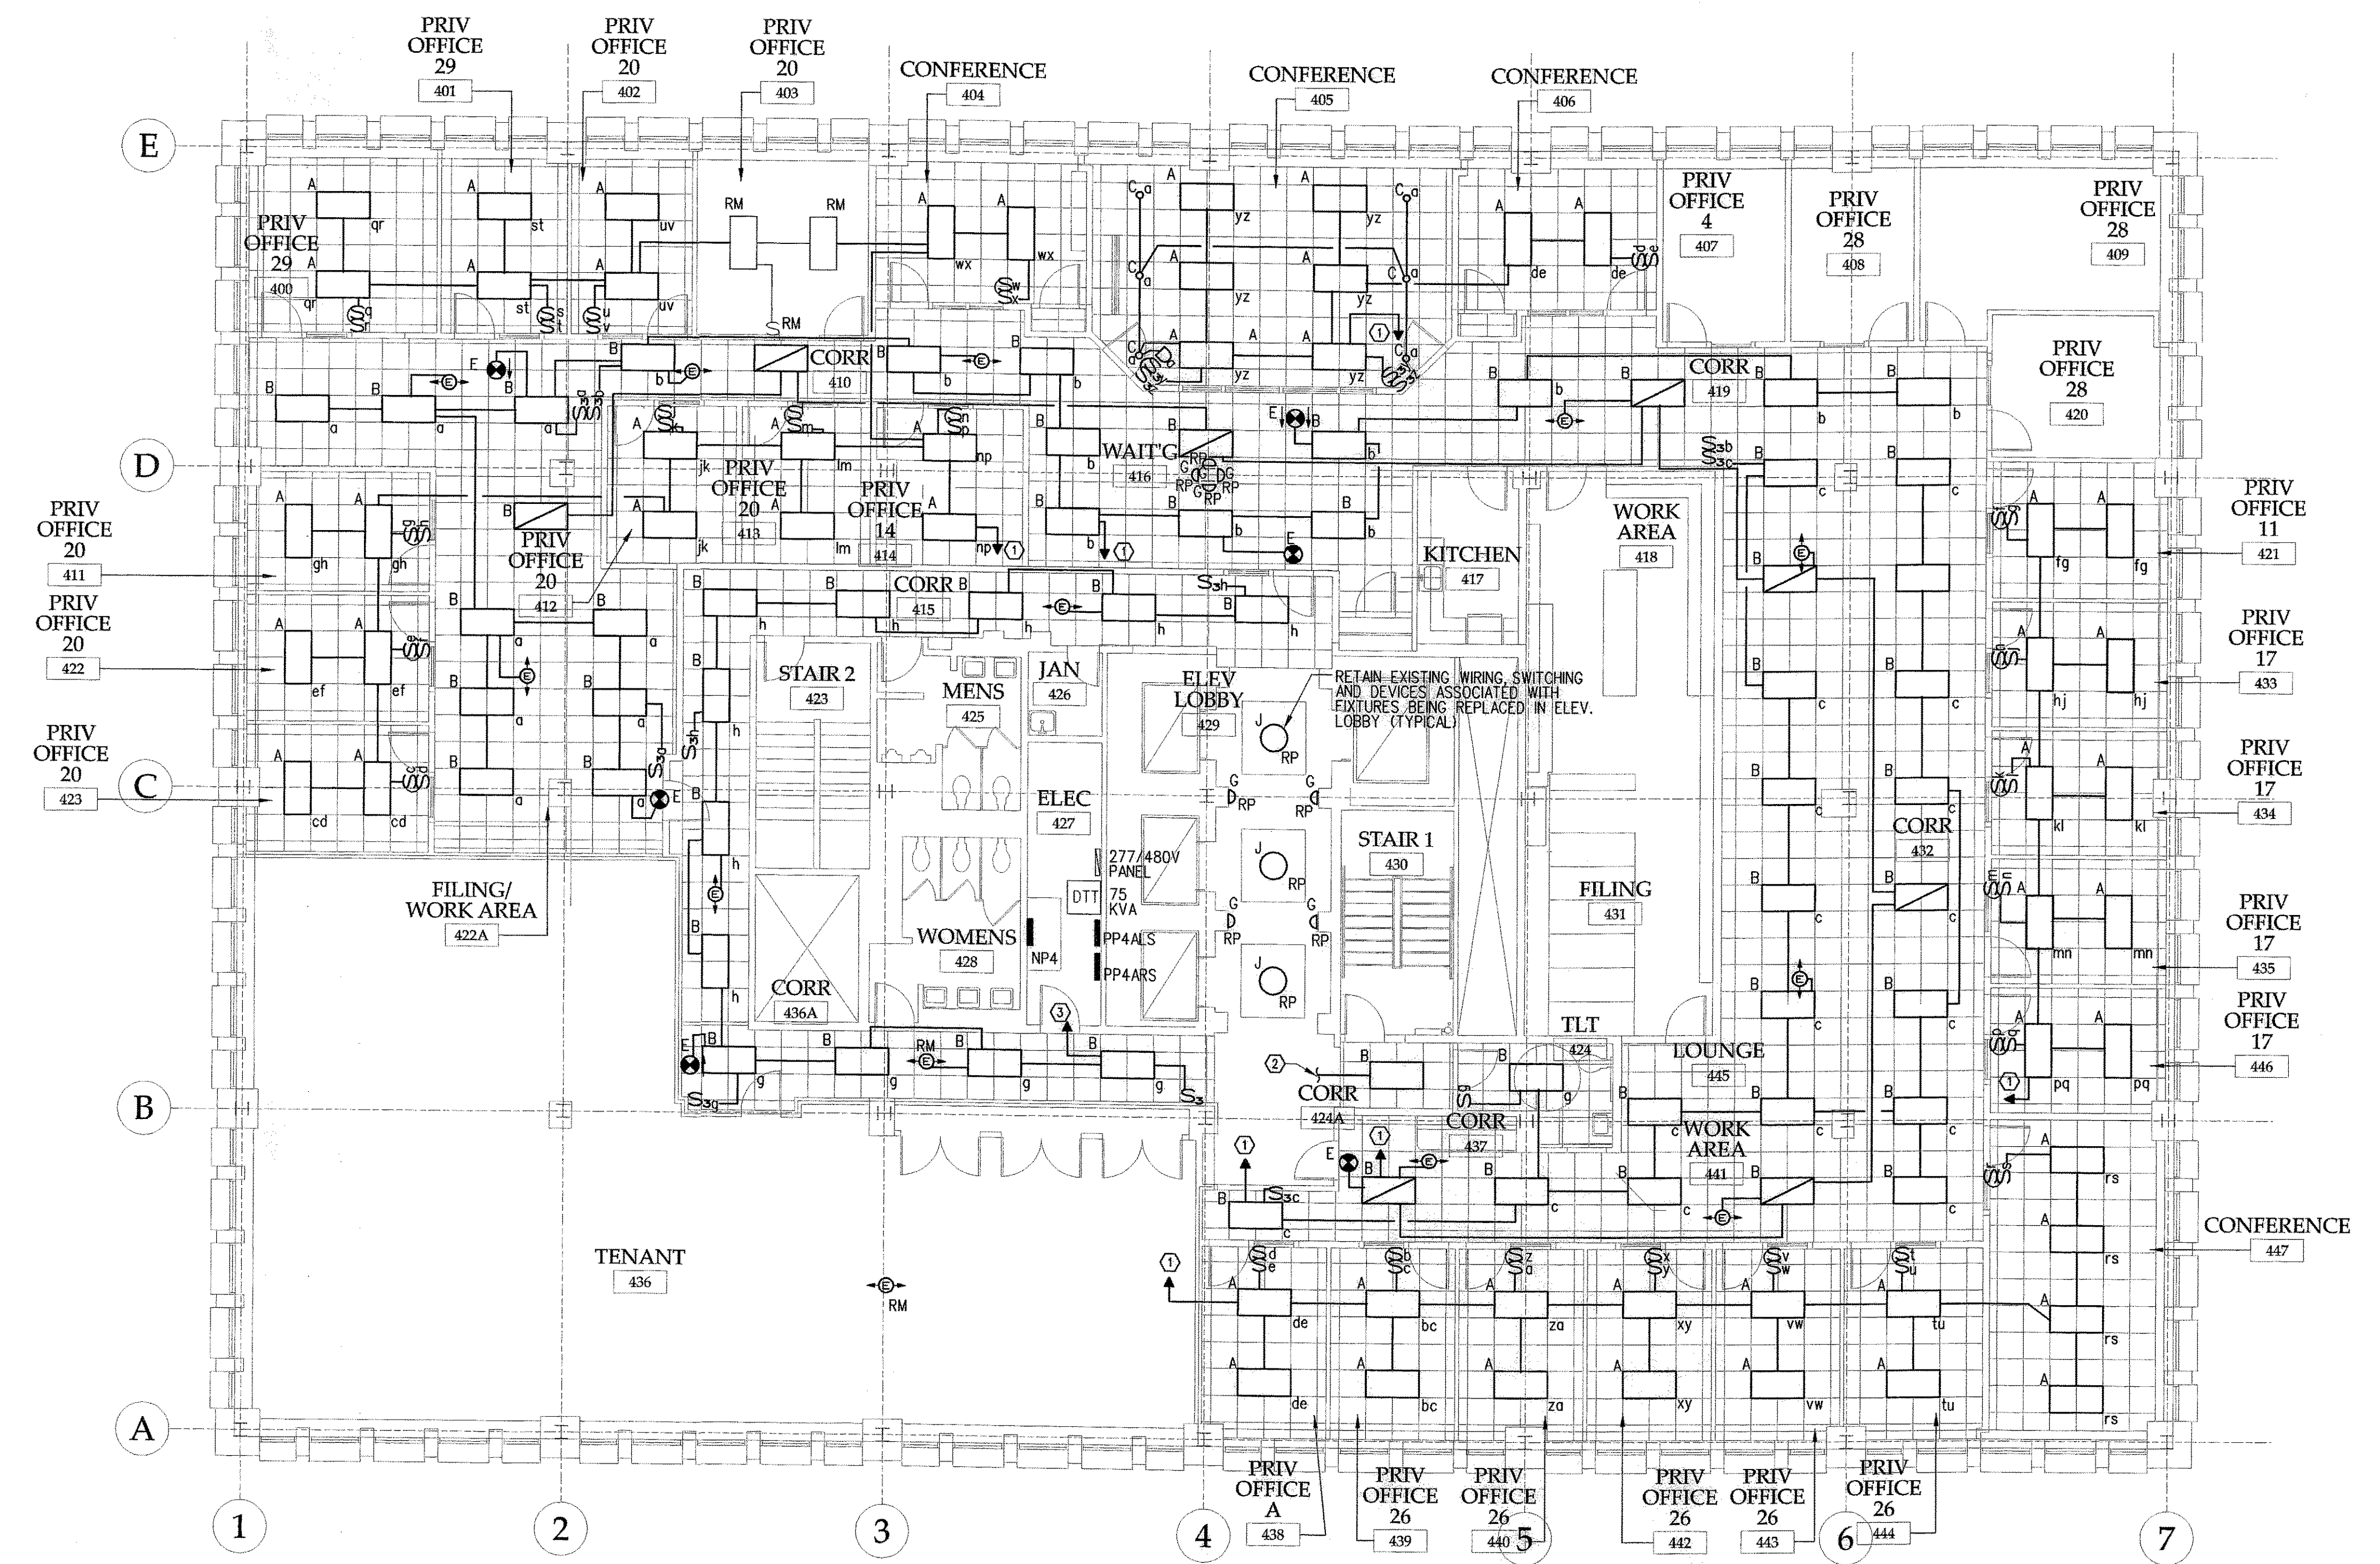

FOURTH FLOOR LIGHTING PLAN
SCALE - 1/8" = 1' - 0"

- NOTES:**
- ① PROVIDE 1 POLE, 20 AMP CIRCUIT BREAKER IN EXISTING 277/480V PANEL LOCATED IN ELEC. RM. 427.
 - ② CONNECT TO EXISTING CORRIDOR LIGHTING CIRCUIT.
 - ③ REUSE EXISTING CORRIDOR LIGHTING CIRCUIT.

REVISIONS

#	DATE	DESCRIPTION

REVISIONS

#	DATE	DESCRIPTION
1	08.29.07	PROCESS RELEASE-RJC CONSULTING

DATE:	10.22.07
PROJECT #	020807
DRAWN BY:	SPD
CHECKED BY:	CWA
DRAWING SCALE	AS NOTED

SHEET TITLE

CANAL PLAZA
FOURTH FLOOR
LIGHTING PLAN

E103