


**GAWRON
TURGEON
ARCHITECTS**
29 Black Point Road
Scarborough, ME 04074
www.gawronturgeon.com
Tel. 207. 883. 6307
Fax. 207. 883. 0361

KeyBank
Office Renovation
One Canal Plaza

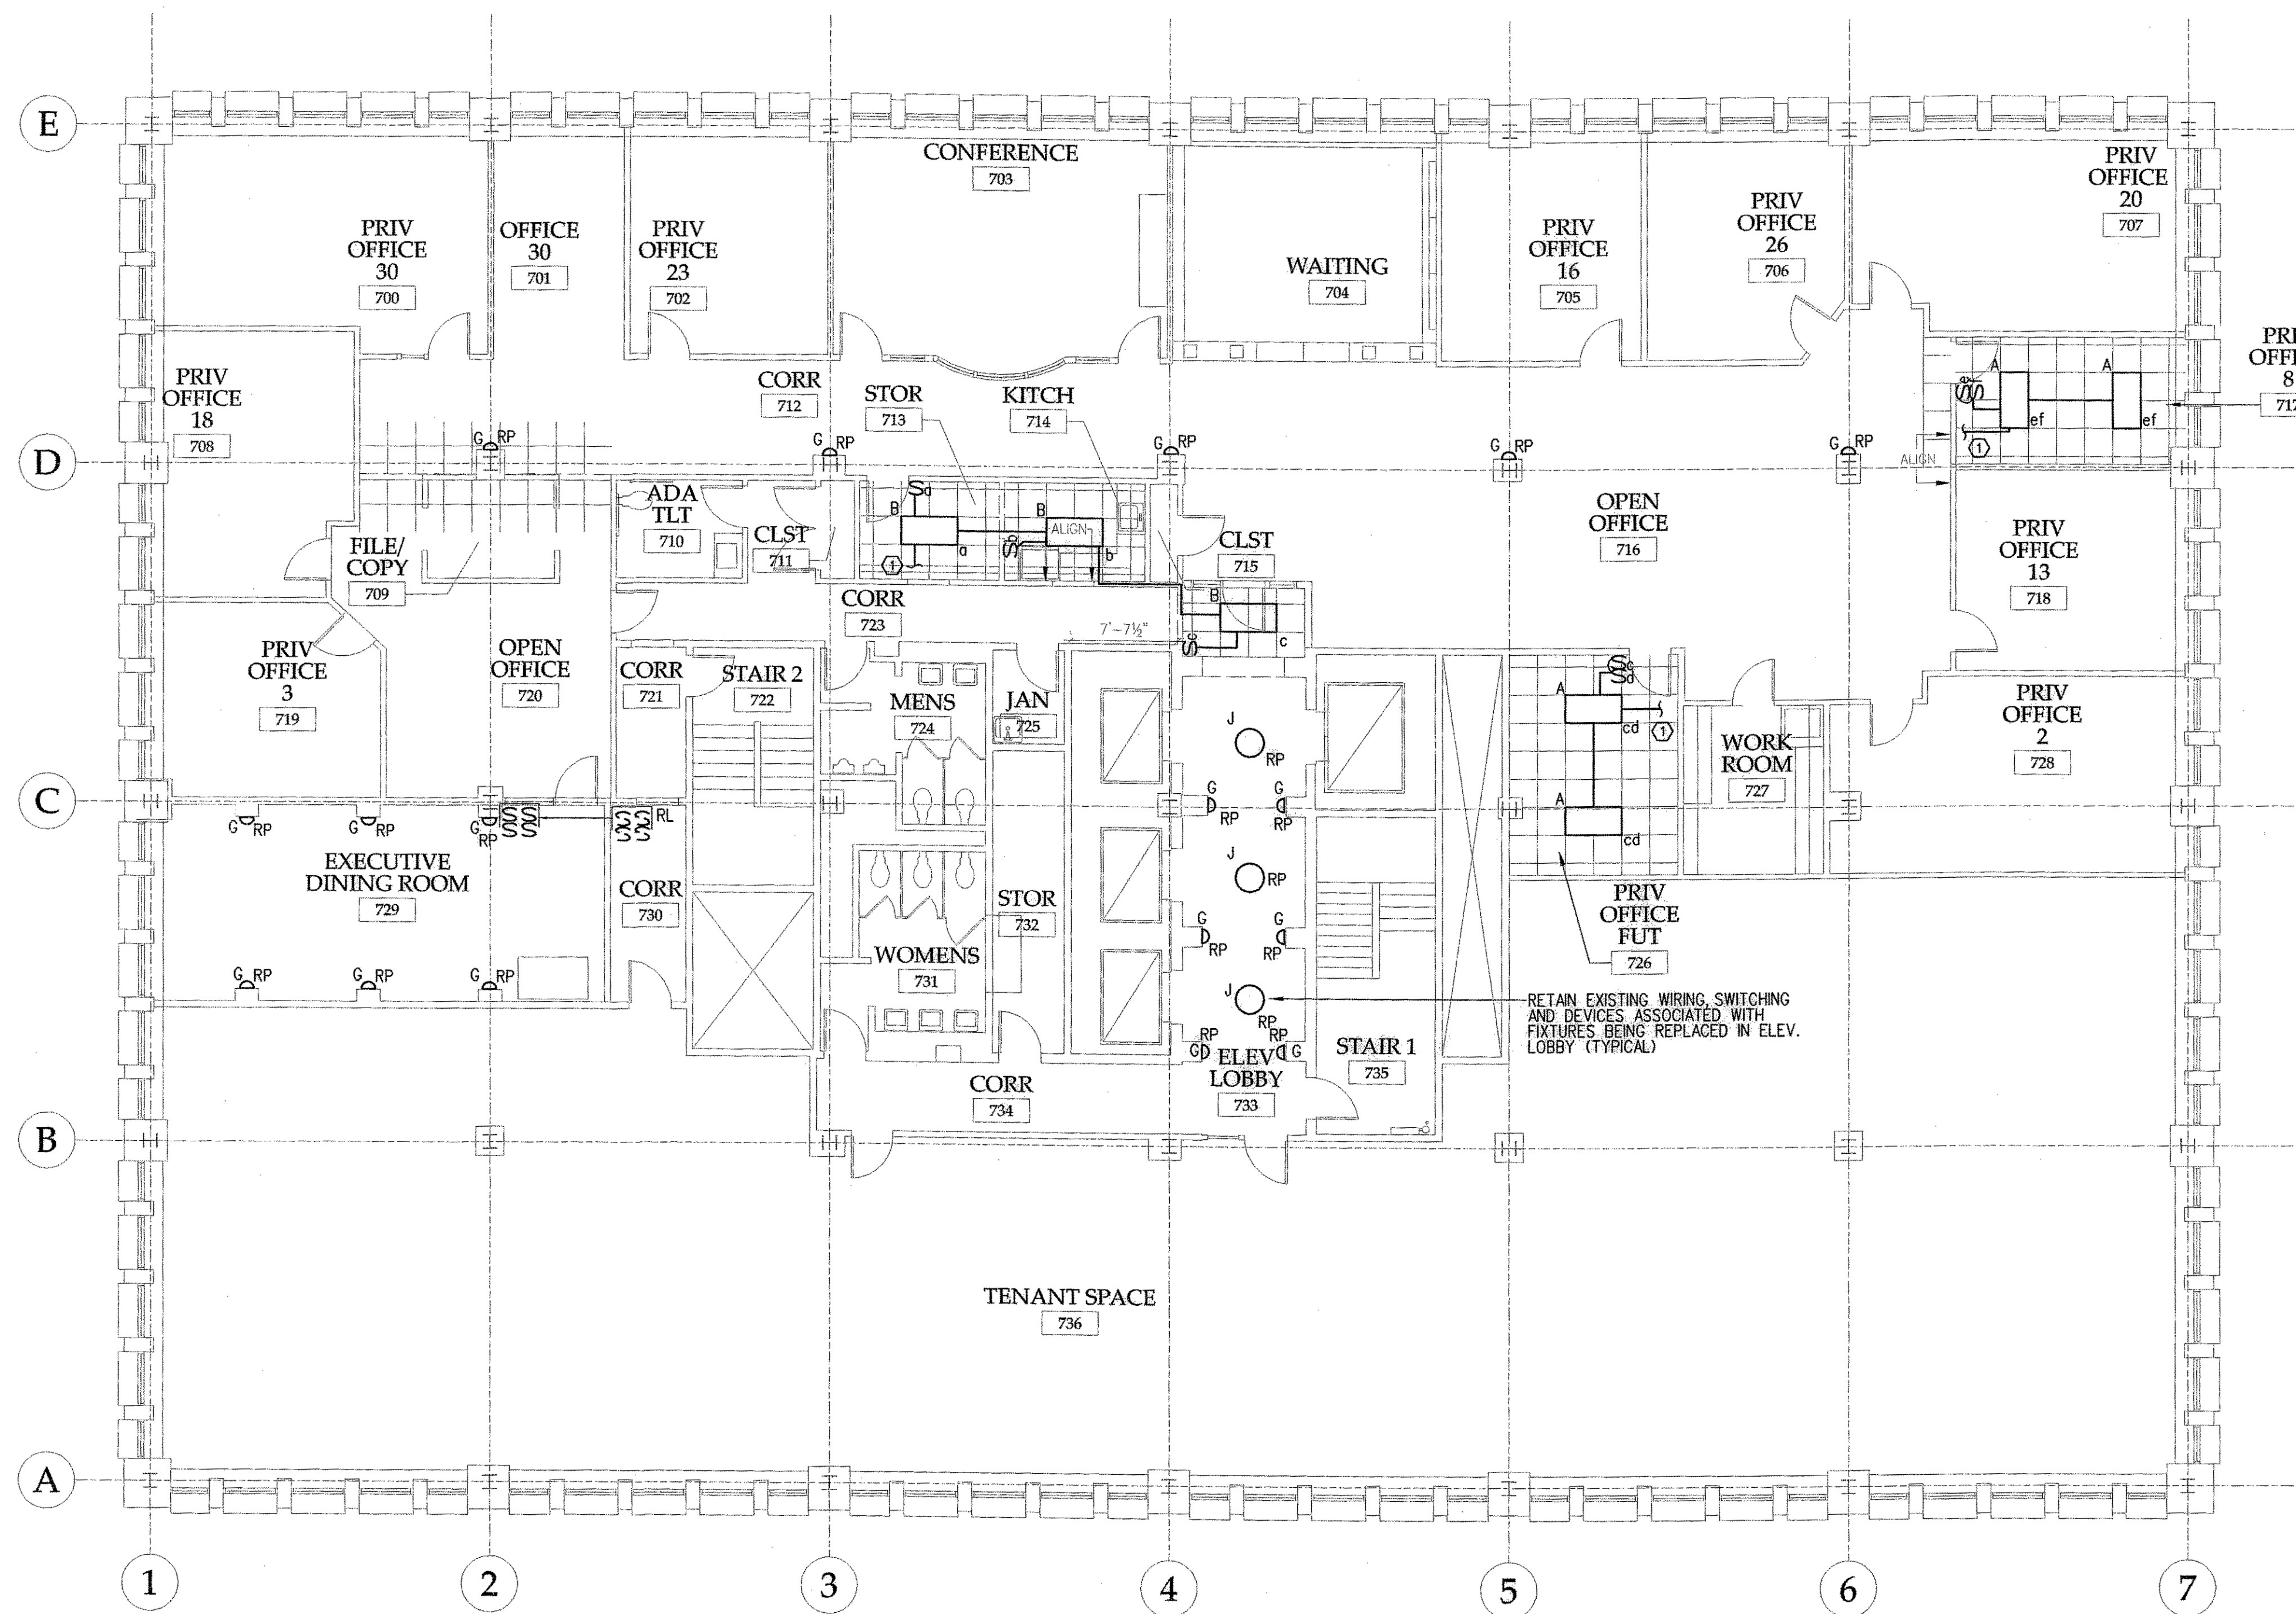

SEVENTH FLOOR LIGHTING PLAN
SCALE - 1/8" = 1' - 0"

NOTES:
① CONNECT TO EXISTING 277V LIGHTING CIRCUIT.

REVISIONS

| # | DATE | DESCRIPTION |
|---|------|-------------|
| | | |

REVISIONS

| # | DATE | DESCRIPTION |
|---|----------|-----------------------------------|
| 1 | 08.29.07 | PROGRESS RELEASE - RPC CONSULTING |

| | |
|---------------|----------|
| DATE: | 10.22.07 |
| PROJECT # | 020807 |
| DRAWN BY: | SPD |
| CHECKED BY: | CWA |
| DRAWING SCALE | AS NOTED |

SHEET TITLE

CANAL PLAZA
SEVENTH FLOOR
LIGHTING PLAN

E104

© COPYRIGHT 1985-2006
REPRODUCTION OR USE OF THIS
DOCUMENT WITHOUT THE
PERMISSION OF GAWRON TURGEON
ARCHITECTS IS PROHIBITED.