


**GAWRON
TURGEON
ARCHITECTS**
29 Black Point Road
Scarborough, ME 04074
www.gawronturgeon.com
Tel. 207.883.6307
Fax. 207.883.0361

KeyBank
Office Renovation
One Canal Plaza

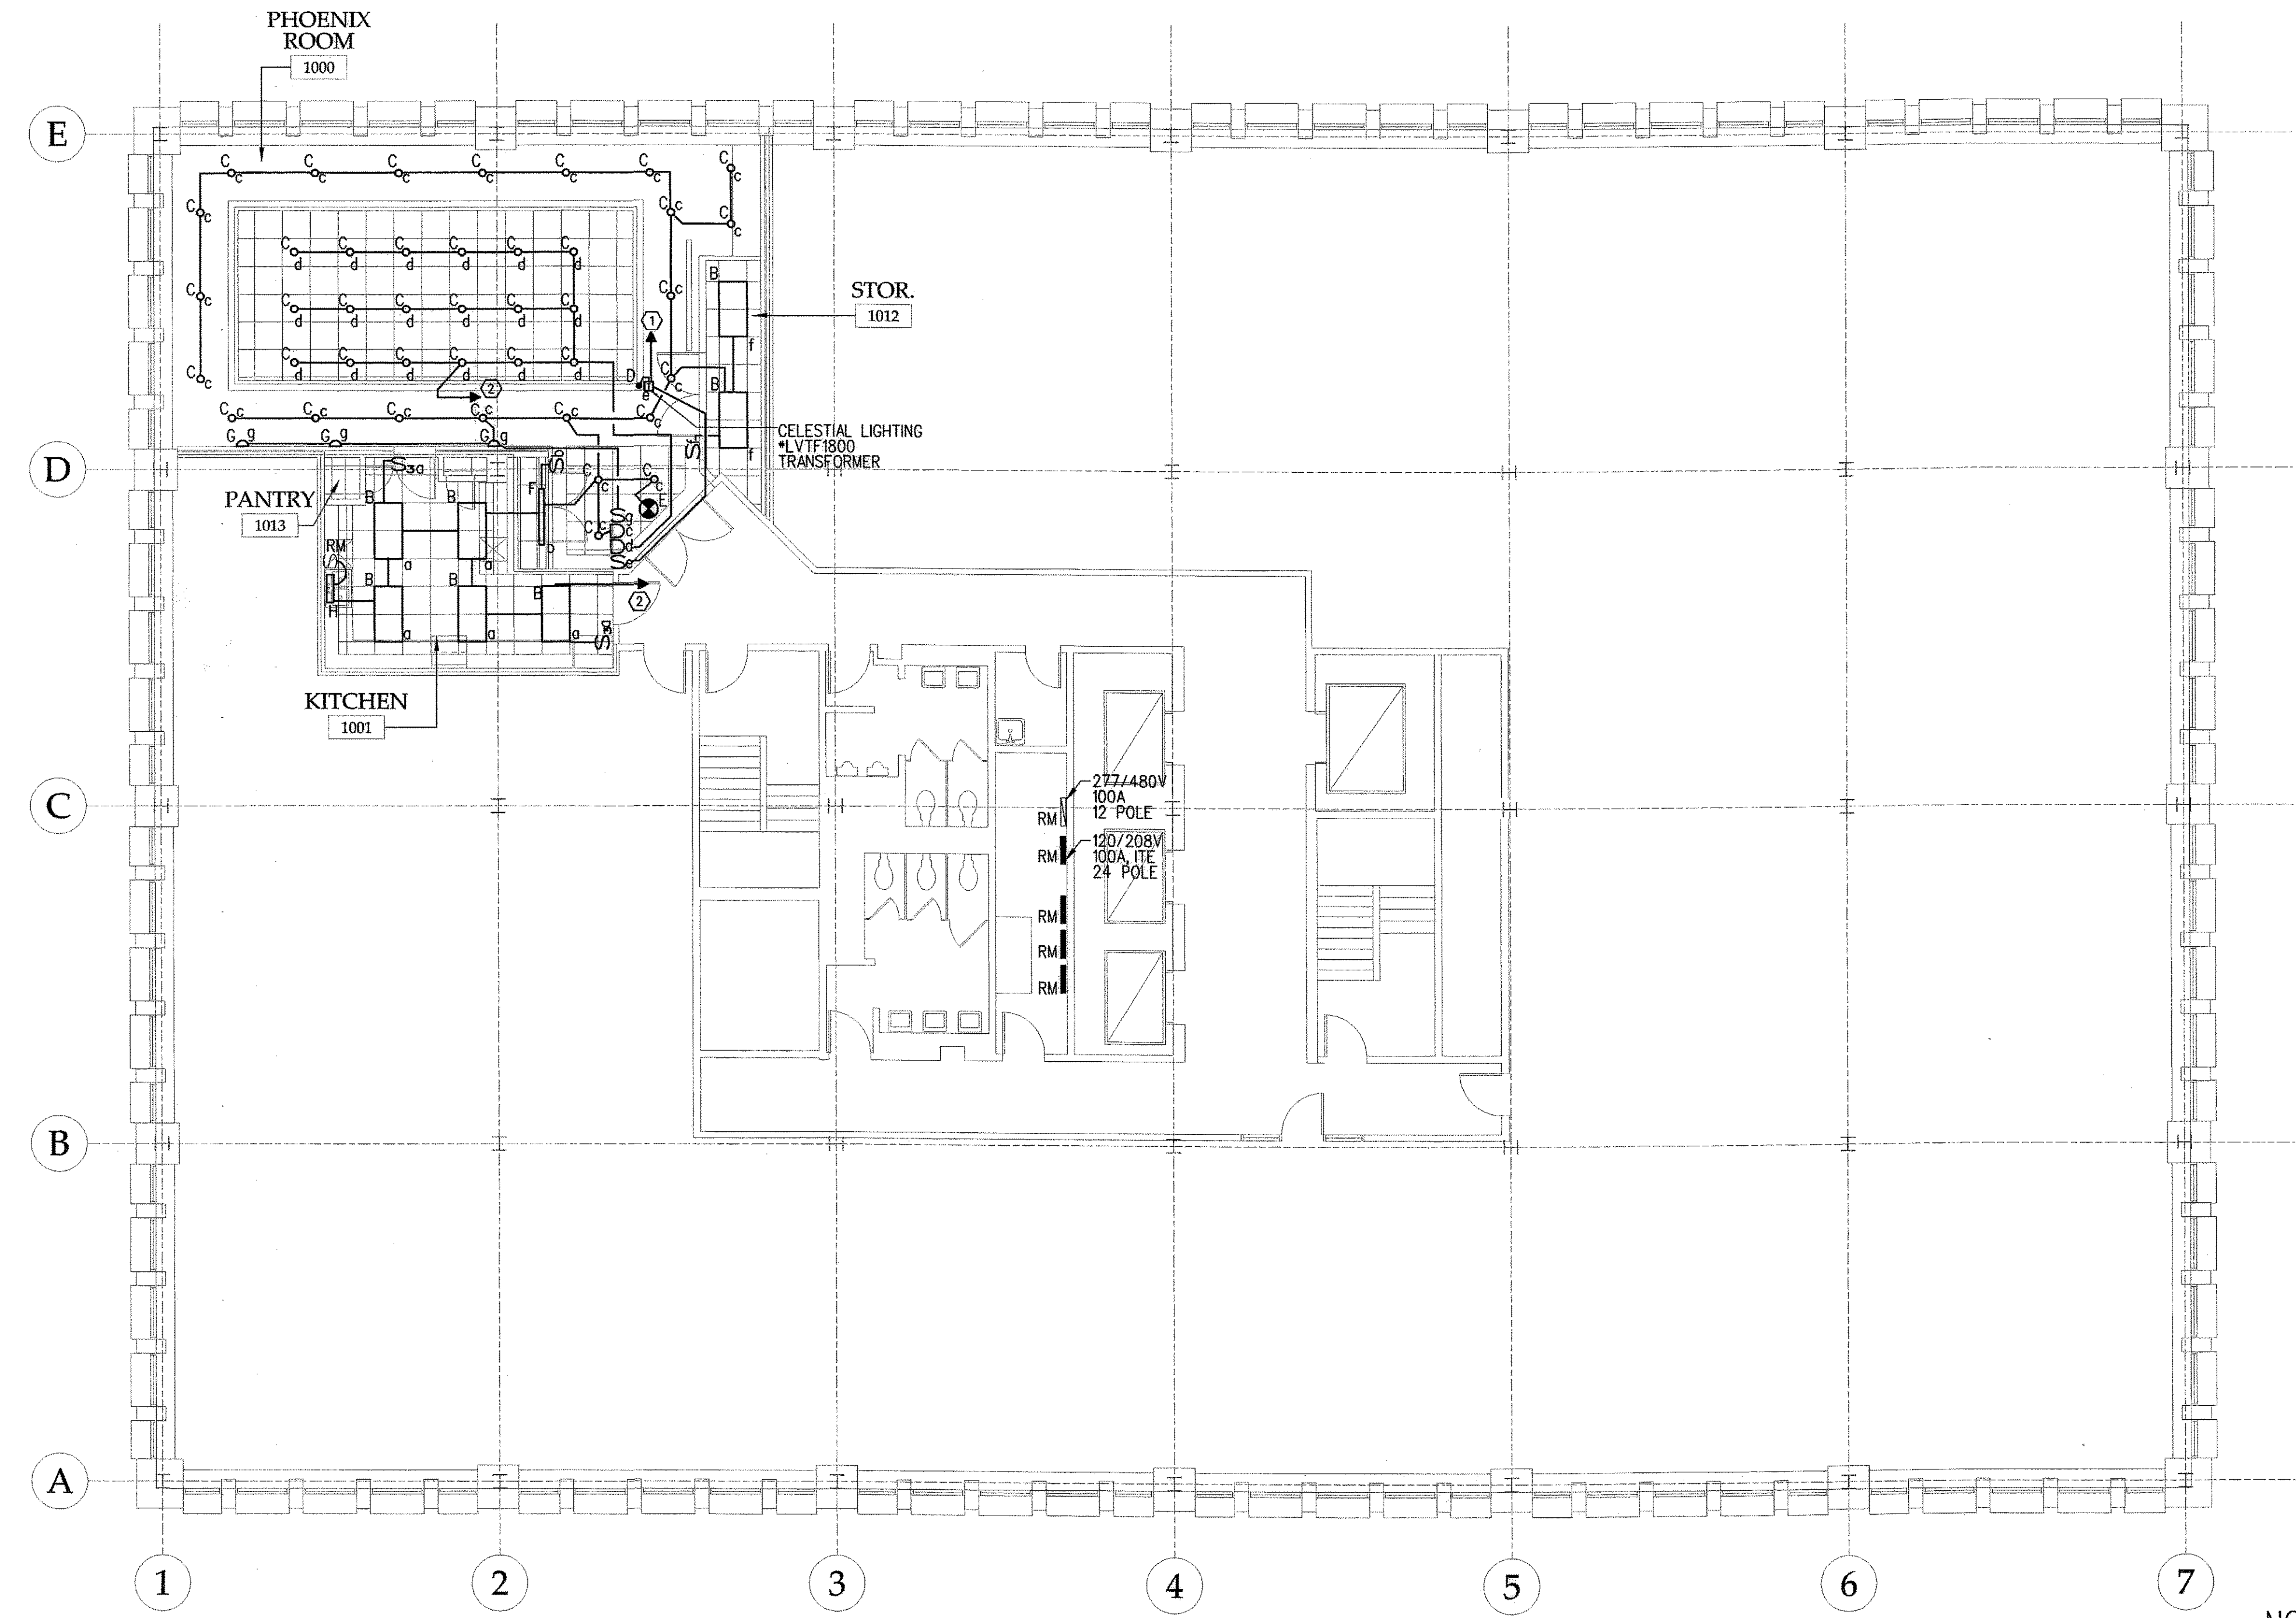

TENTH FLOOR LIGHTING PLAN
SCALE - 1/8" = 1' - 0"

- NOTES:**
- ① PROVIDE 1 POLE, 20 AMP CIRCUIT BREAKER IN EXISTING 120/208V PANEL LOCATED IN IT RM. 1007.
 - ② PROVIDE 1 POLE, 20 AMP CIRCUIT BREAKER IN EXISTING 277/480V PANEL LOCATED IN IT RM. 1007.

REVISIONS		
#	DATE	DESCRIPTION
REVISIONS		
#	DATE	DESCRIPTION
1	08.29.07	PROGRESS RELEASE - RJC CONSULTING

DATE:	10.22.07
PROJECT #	020807
DRAWN BY:	SPD
CHECKED BY:	CWA
DRAWING SCALE	AS NOTED

SHEET TITLE
CANAL PLAZA
TENTH FLOOR
LIGHTING PLAN

E105

© COPYRIGHT 1985-2006
REPRODUCTION OR RELEASE OF THIS
DOCUMENT WITHOUT WRITTEN
PERMISSION OF GAWRON TURGEON
ARCHITECTS IS PROHIBITED