


**GAWRON  
TURGEON  
ARCHITECTS**  
29 Black Point Road  
Scarborough, ME 04074  
www.gawronturgeon.com  
Tel. 207.883.6307  
Fax. 207.883.0361

**KeyBank**  
Office Renovation  
One Canal Plaza

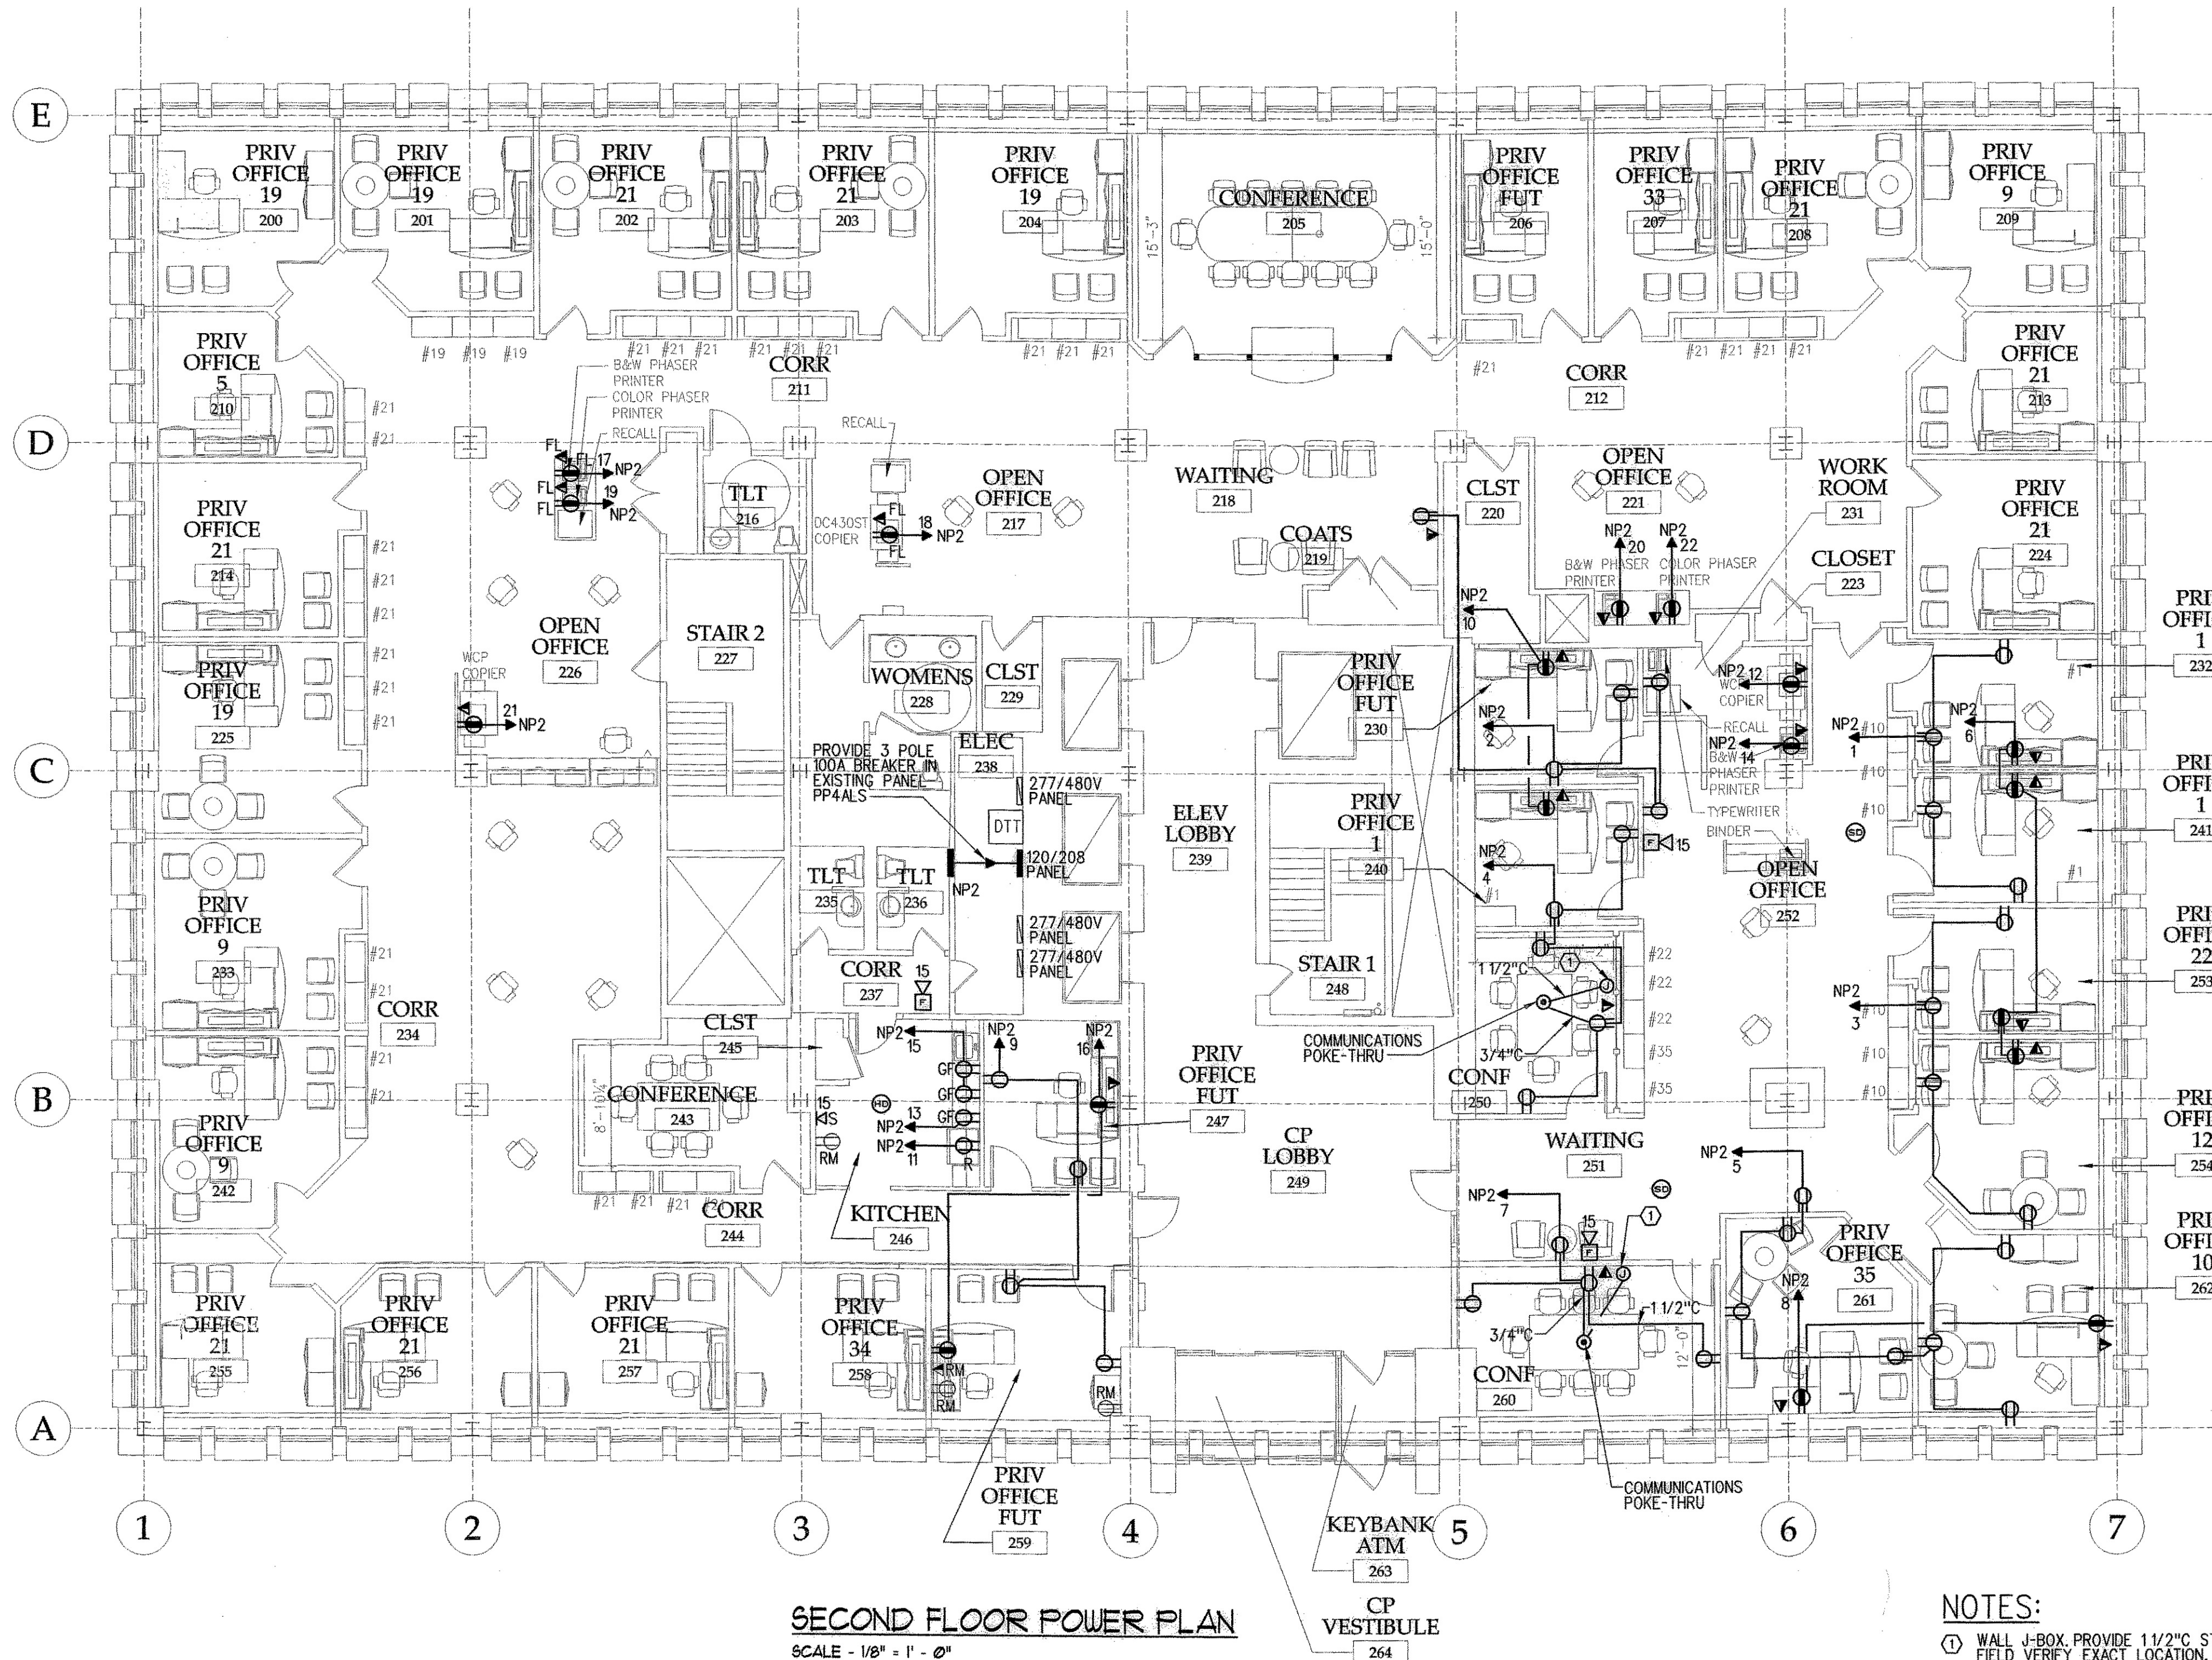

**SECOND FLOOR POWER PLAN**  
SCALE - 1/8" = 1' - 0"

**NOTES:**  
① WALL I-BOX, PROVIDE 1 1/2" C STUBBED TO ABOVE CEILING W/ SWEEPING 90° AND CHASE RING. FIELD VERIFY EXACT LOCATION.

**REVISIONS**

#	DATE	DESCRIPTION

**REVISIONS**

#	DATE	DESCRIPTION
1	08.29.07	PROGRESS RELEASE - RJC CONSULTING

DATE:	10.22.07
PROJECT #:	028807
DRAWN BY:	SPD
CHECKED BY:	CWA
DRAWING SCALE:	AS NOTED

**SHEET TITLE**

CANAL PLAZA  
SECOND FLOOR  
POWER PLAN

**E201**

© COPYRIGHT 1985-2006  
REPRODUCTION OR RISK OF THIS  
DOCUMENT WITHOUT WRITTEN  
PERMISSION OF GAWRON TURGEON  
ARCHITECTS IS PROHIBITED