


**GAWRON
TURGEON
ARCHITECTS**
29 Black Point Road
Scarborough, ME 04074
www.gawronturgeon.com
Tel. 207 . 853 . 6307
Fax. 207 . 853 . 0361

KeyBank
Office Renovation
One Canal Plaza

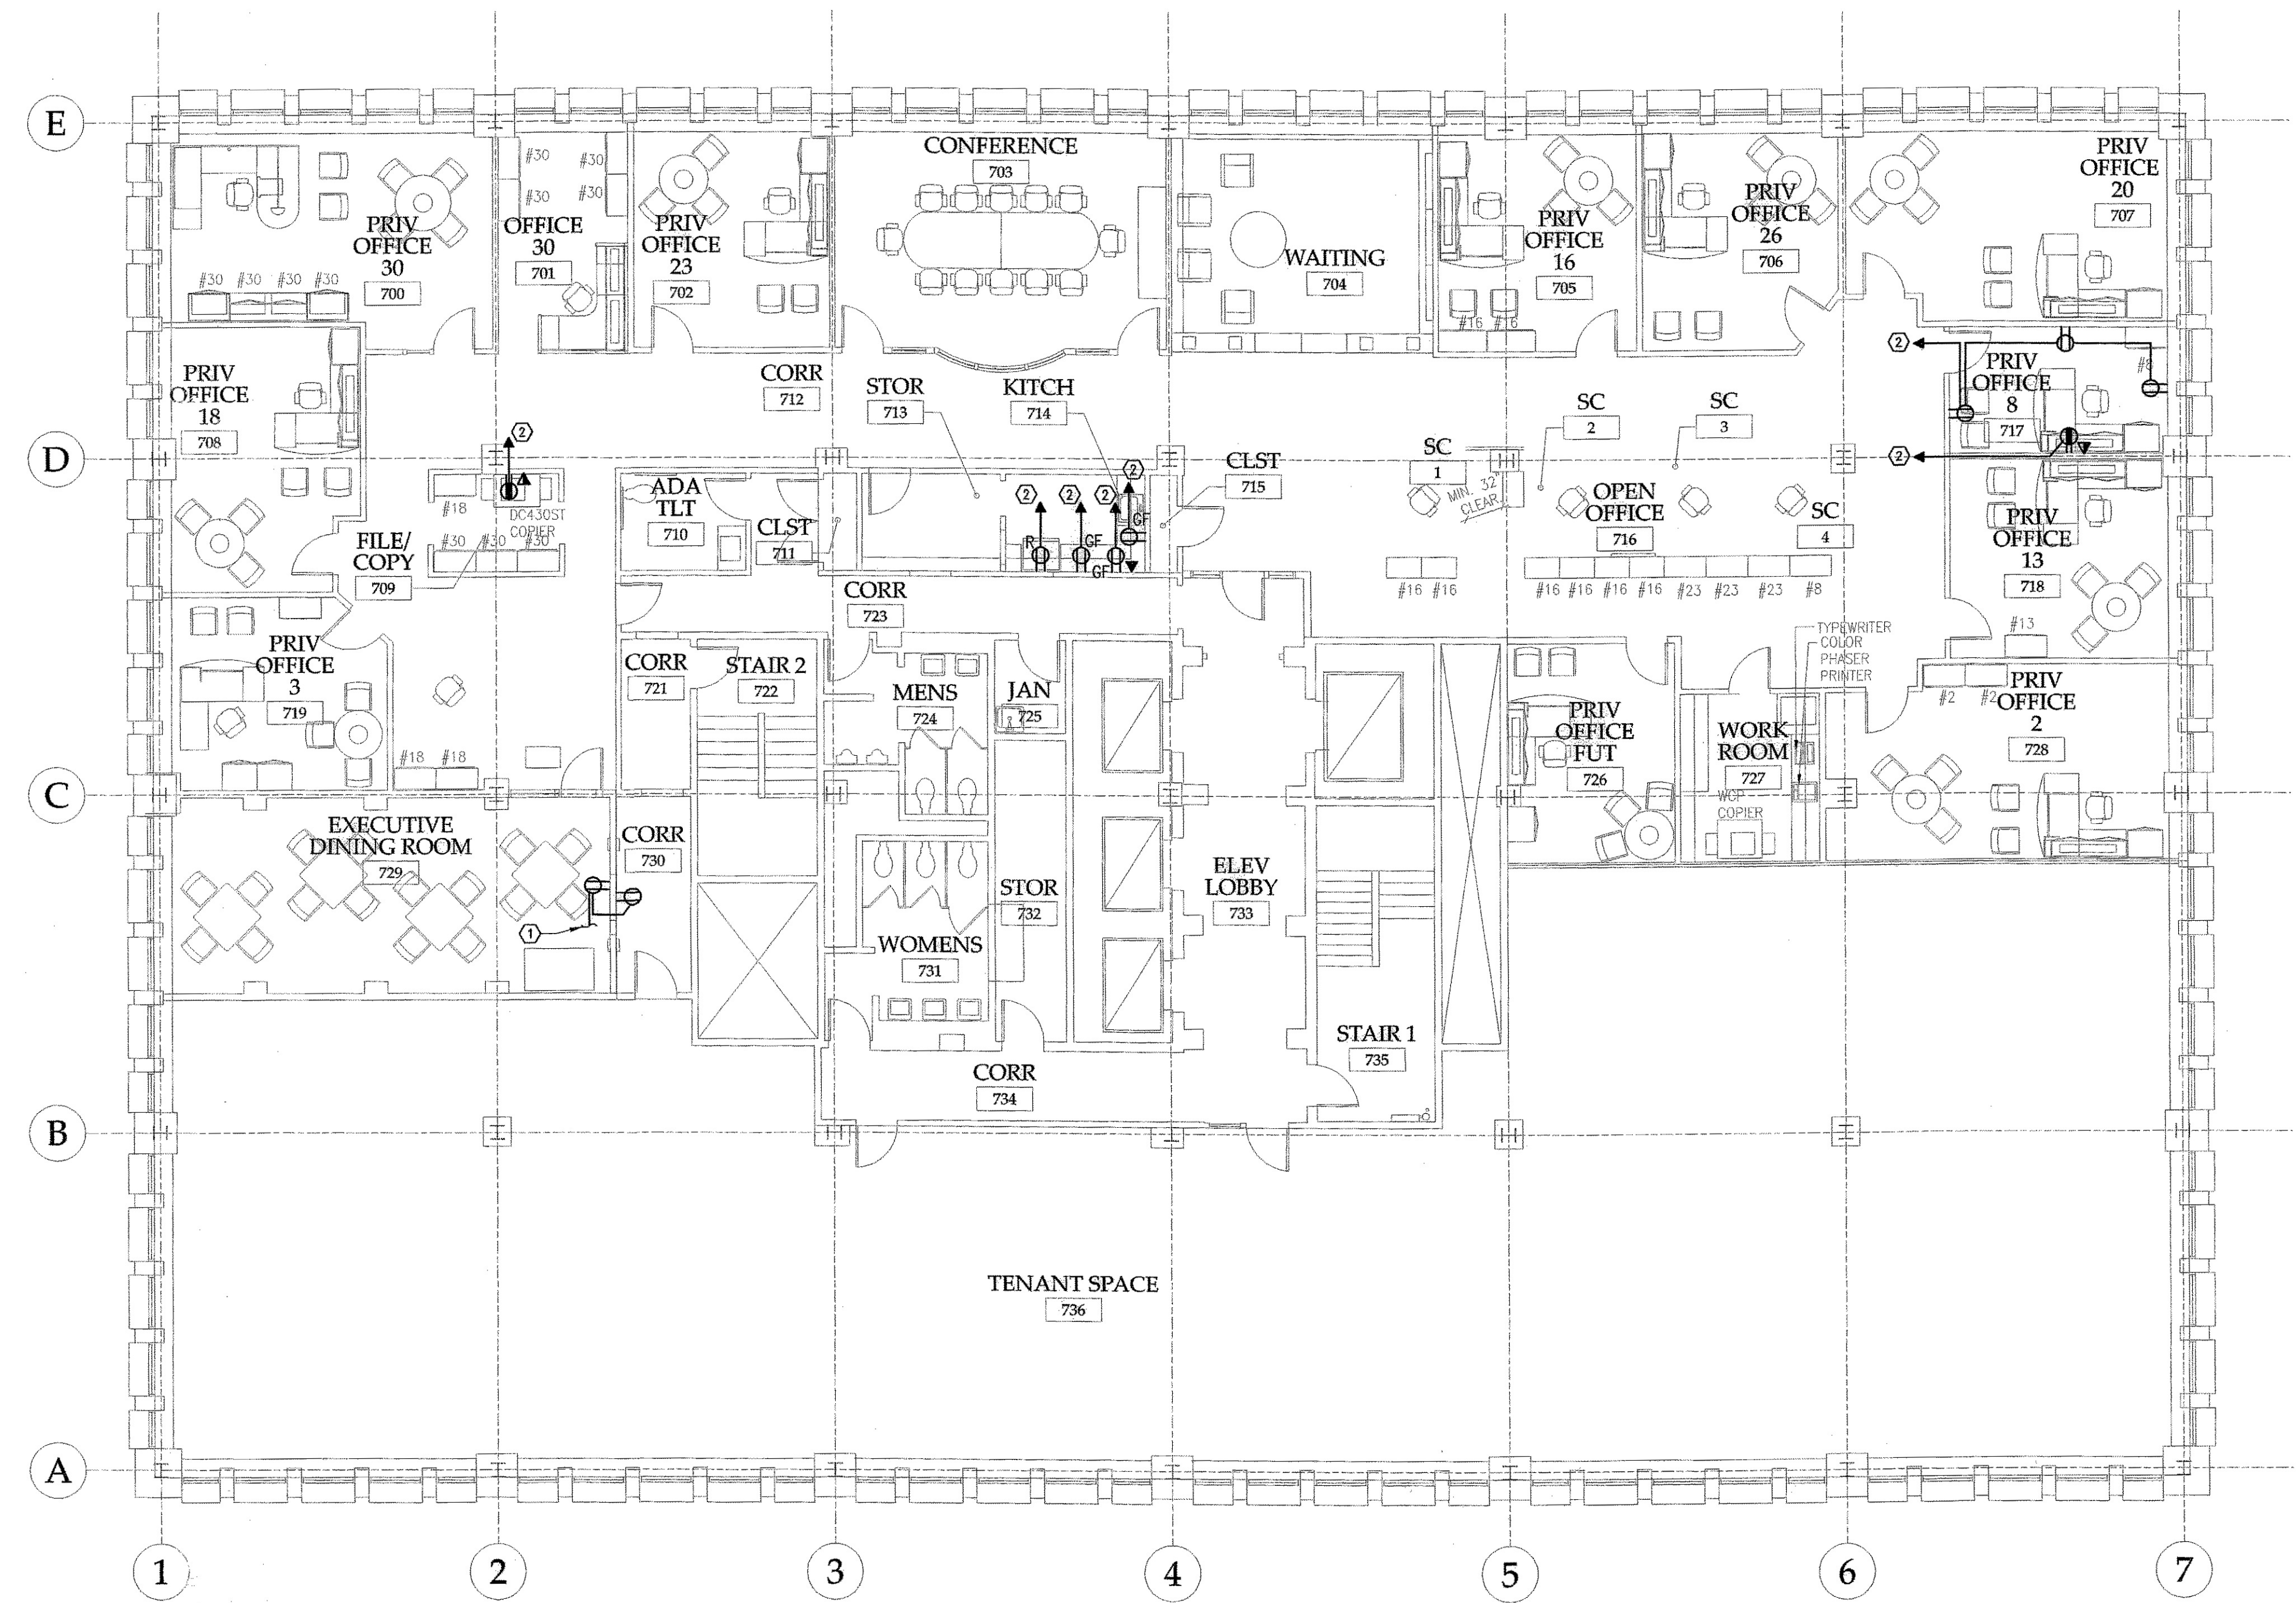

SEVENTH FLOOR POWER PLAN
SCALE - 1/8" = 1' - 0"

- NOTES:**
- ① CONNECT TO EXISTING 120V DINING ROOM RECEPTACLE CIRCUIT.
 - ② PROVIDE 1 POLE, 20 AMP CIRCUIT BREAKER IN EXISTING 120/208V PANEL SERVING 7TH FLOOR RECEPTACLE LOADS.

REVISIONS		
#	DATE	DESCRIPTION
REVISIONS		
#	DATE	DESCRIPTION
1	08.29.07	PROGRESS RELEASE - RYC CONSULTING

DATE:	10.22.07
PROJECT #	020807
DRAWN BY:	CWA
CHECKED BY:	SPD
DRAWING SCALE	AS NOTED

SHEET TITLE
CANAL PLAZA
SEVENTH FLOOR
POWER PLAN

E203

© COPYRIGHT 1985-2006
REPRODUCTION OR BASIS OF THIS
DOCUMENT WITHOUT WRITTEN
PERMISSION OF GAWRON TURGEON
ARCHITECTS IS PROHIBITED.