


**GAWRON  
TURGEON  
ARCHITECTS**  
29 Black Point Road  
Scarborough, ME 04074  
www.gawronturgeon.com  
Tel. 207 . 883 . 6307  
Fax. 207 . 883 . 0361

**KeyBank**  
Office Renovation  
One Canal Plaza

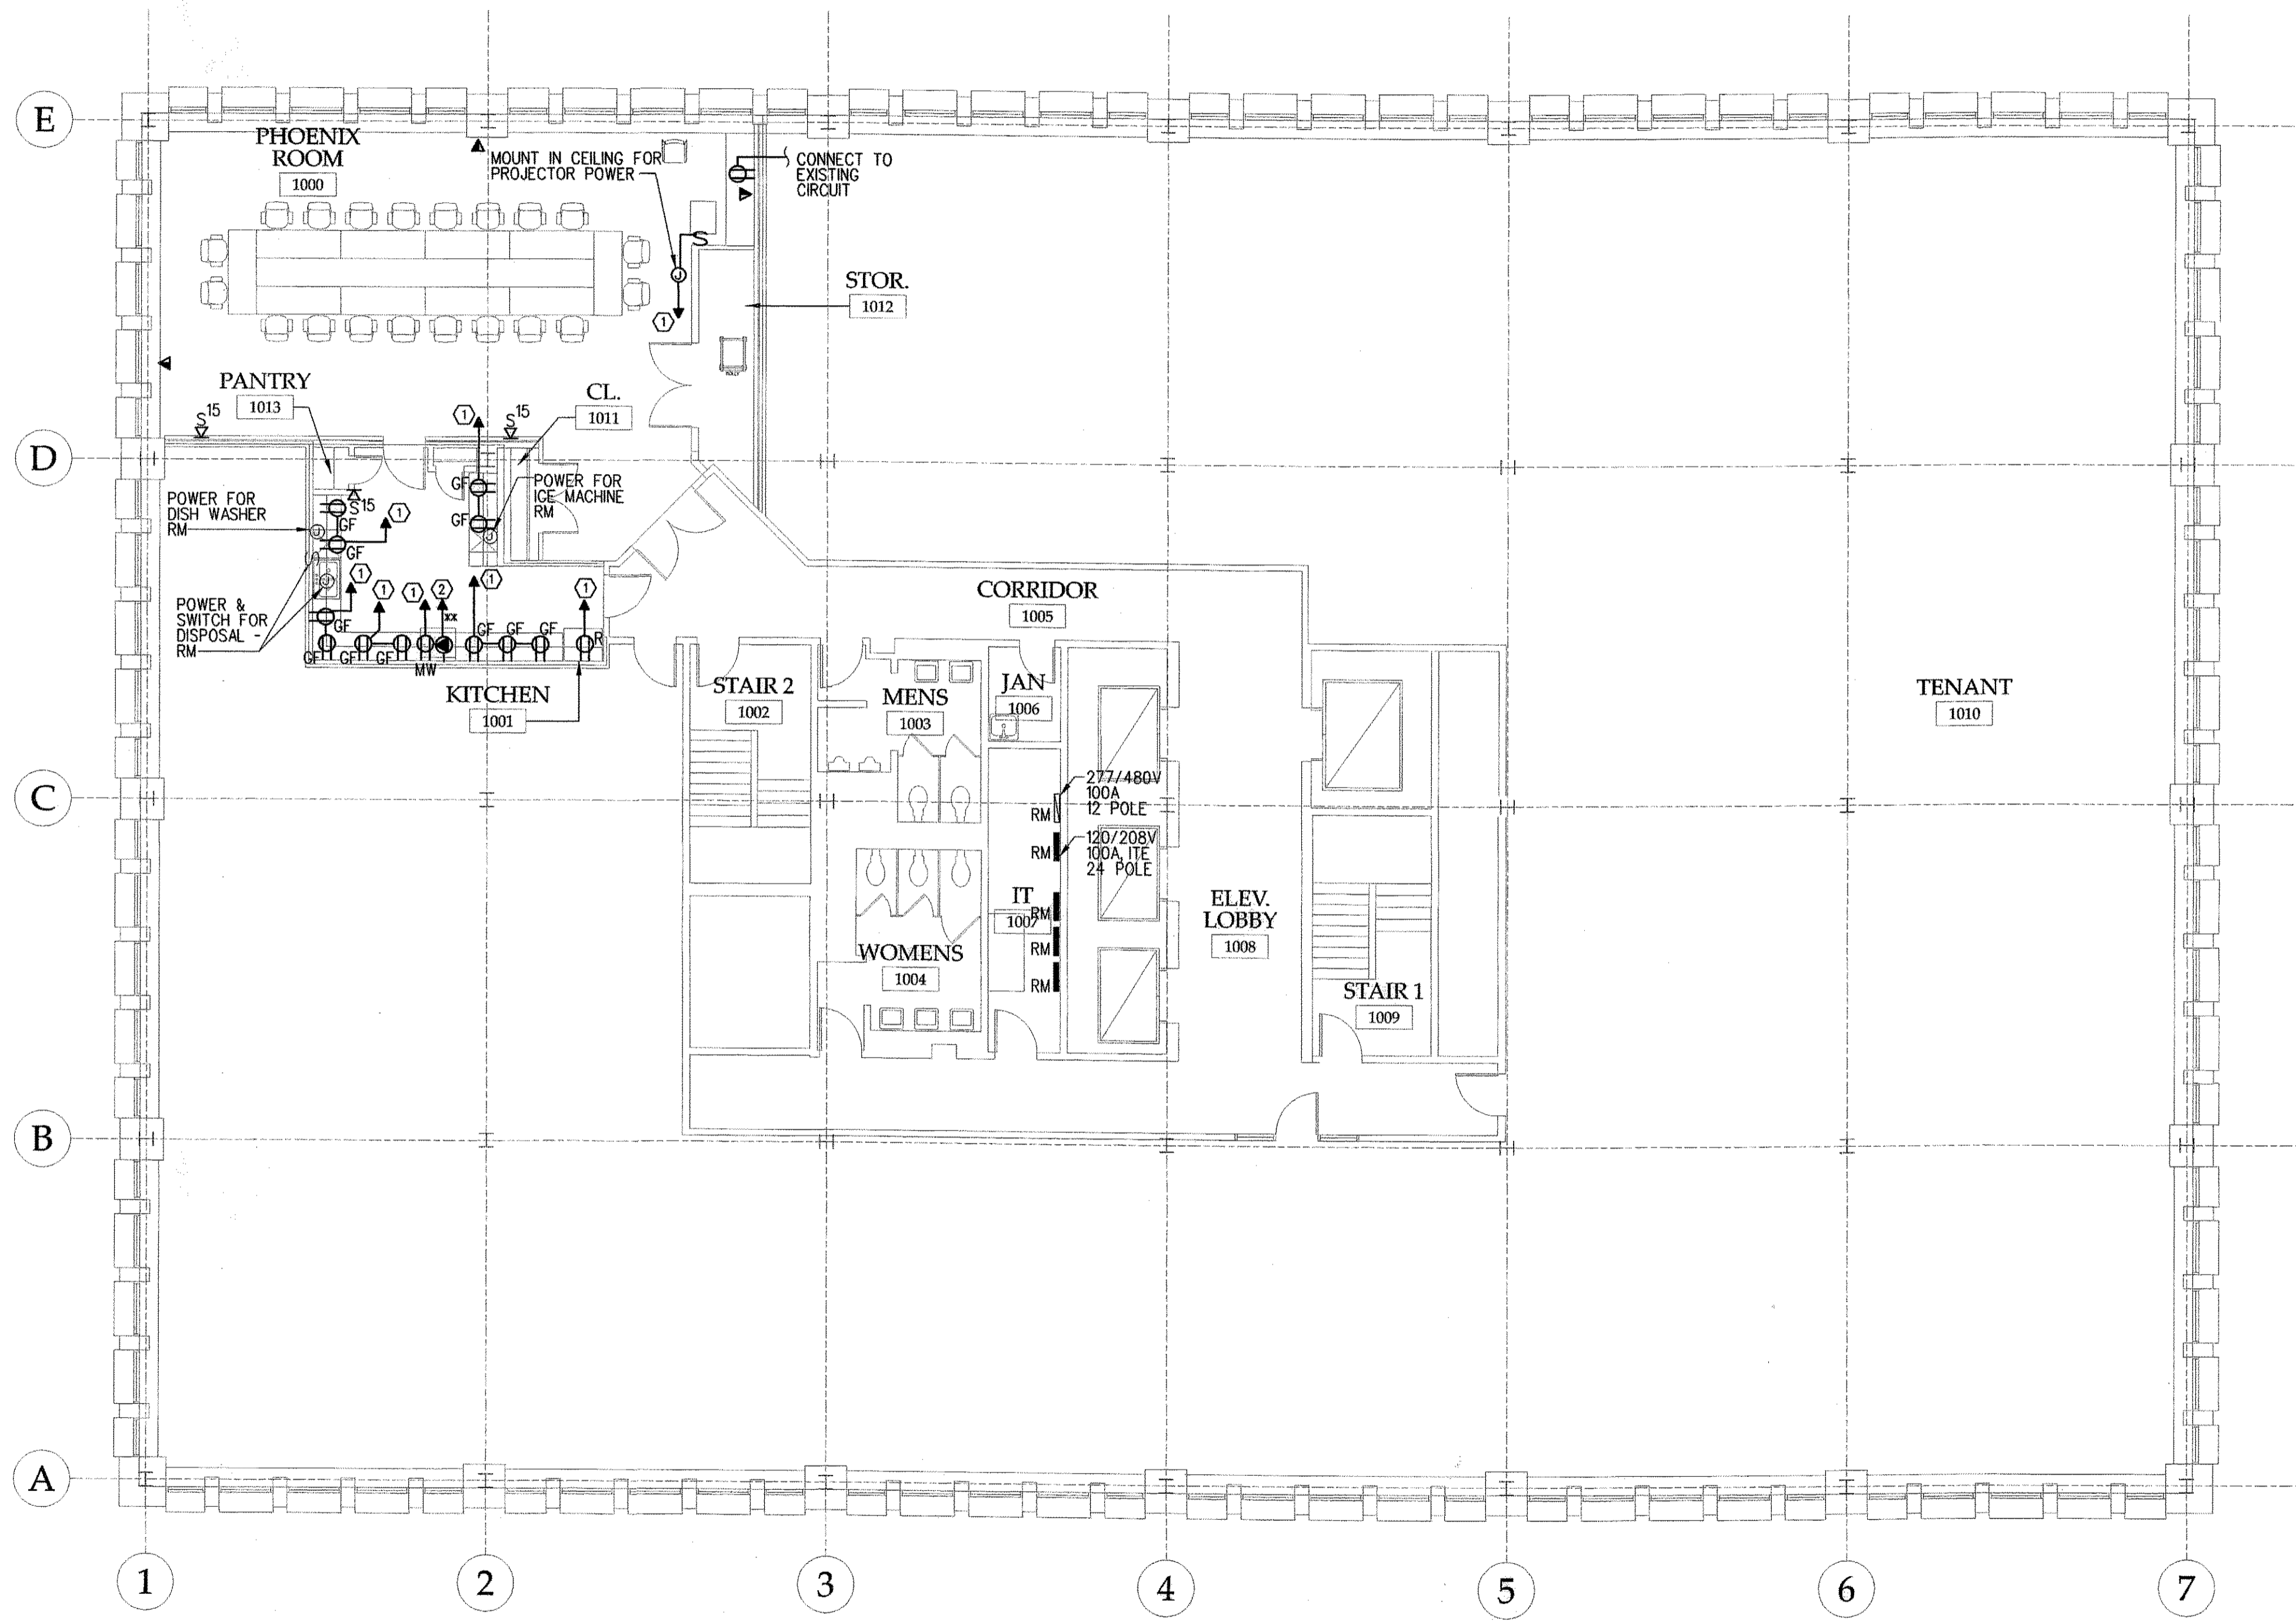

**TENTH FLOOR POWER PLAN**  
SCALE - 1/8" = 1' - 0"

- NOTES:**
- ① PROVIDE 1 POLE, 20 AMP CIRCUIT BREAKER IN EXISTING 120/208V PANEL LOCATED IN IT RM. 1007.
  - ② PROVIDE 2 POLE, 50 AMP CIRCUIT BREAKER IN EXISTING 120/208V PANEL LOCATED IN IT RM. 1007.

**REVISIONS**

| # | DATE | DESCRIPTION |
|---|------|-------------|
|   |      |             |

**REVISIONS**

| # | DATE     | DESCRIPTION                       |
|---|----------|-----------------------------------|
| 1 | 08.29.07 | PROGRESS RELEASE - RJC CONSULTING |

|               |          |
|---------------|----------|
| DATE:         | 10.22.07 |
| PROJECT #     | 020807   |
| DRAWN BY:     | SPD      |
| CHECKED BY:   | CWA      |
| DRAWING SCALE | AS NOTED |

**SHEET TITLE**

CANAL PLAZA  
TENTH FLOOR  
POWER PLAN

**E204**