


**GAWRON
TURGEON
ARCHITECTS**
29 Black Point Road
Scarborough, ME 04074
www.gawronturgeon.com
Tel. 207. 883. 6307
Fax. 207. 883. 0361

KeyBank
Office Renovation
One Canal Plaza

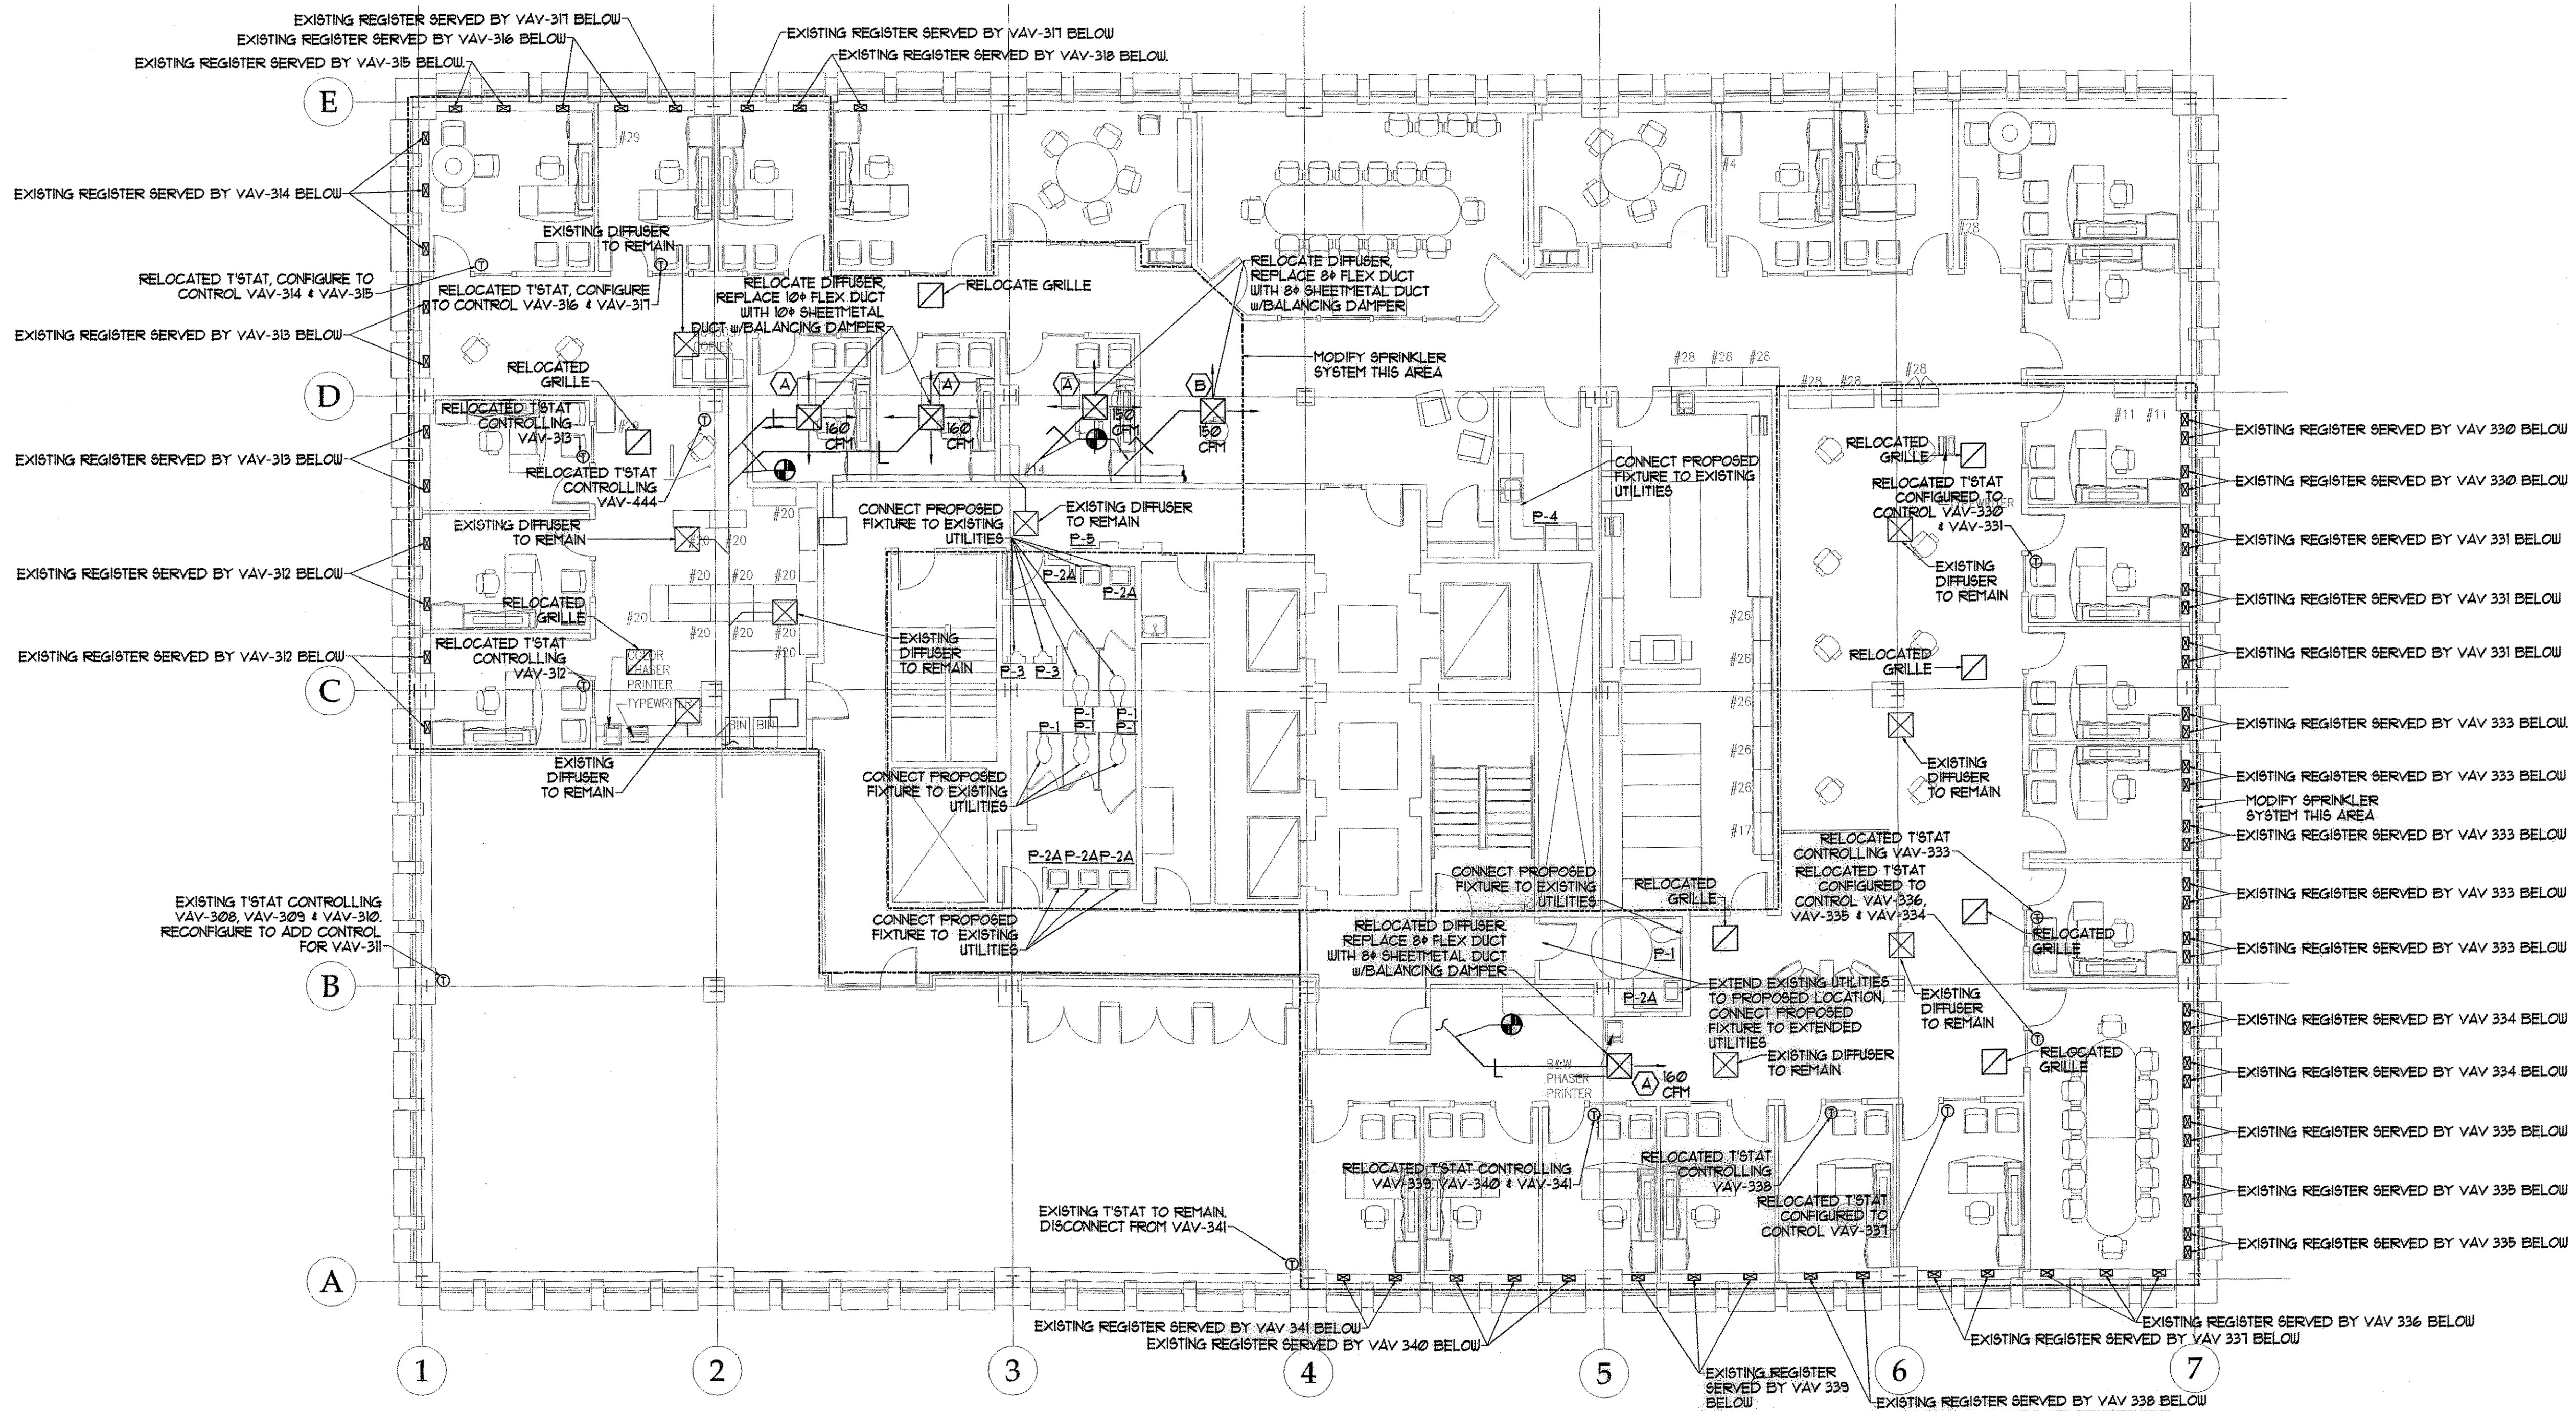

FOURTH FLOOR MECHANICAL PLAN

SCALE - 1/8" = 1' - 0"

NOTES -
1. Fabricate and install metal splice covers for perimeter HVAC discharge plenums at windows at all areas where existing partitions are indicated to be removed. Anchor securely to existing perimeter enclosure. Match thickness and profile of existing splices.
2. Cut existing perimeter HVAC discharge plenum at windows at all areas where partition walls are being added. Install sheetmetal end wall plenum mests proposed wall and seal airtight.

REVISIONS

#	DATE	DESCRIPTION

REVISIONS

#	DATE	DESCRIPTION
1	08.29.07	PROGRESS RELEASE - JYC CONSULTING

DATE: 10.22.07

PROJECT #: 020807

DRAWN BY: JMV

CHECKED BY: SPDoel

DRAWING SCALE: AS NOTED

SHEET TITLE

CANAL PLAZA
FOURTH FLOOR
MECHANICAL PLAN

M203

© COPYRIGHT 1985-2006
REPRODUCER OR USER OF THIS
DOCUMENT WITHOUT WRITTEN
PERMISSION OF GAWRON TURGEON
ARCHITECTS IS PROHIBITED.