

**GAWRON
TURGEON
ARCHITECTS**
29 Black Point Road
Scarborough, ME 04074
www.gawronturgeon.com
Tel. 207. 883. 6307
Fax. 207. 883. 0361

KeyBank
Office Renovation
One Canal Plaza

REVISIONS

#	DATE	DESCRIPTION

REVISIONS

#	DATE	DESCRIPTION
1	08.29.07	PROCESS RELEASE - RJC CONSULTING

DATE: 10.22.07

PROJECT #: 008807

DRAWN BY: JMV

CHECKED BY: SPDoel


DRAWING SCALE: AS NOTED

SHEET TITLE

CANAL PLAZA
SEVENTH FLOOR
MECHANICAL PLAN

M204

© COPYRIGHT 1985-2006
REPRODUCTION OR RISK OF THIS
DOCUMENT WITHOUT WRITTEN
PERMISSION OF GAWRON TURGEON
ARCHITECTS IS PROHIBITED

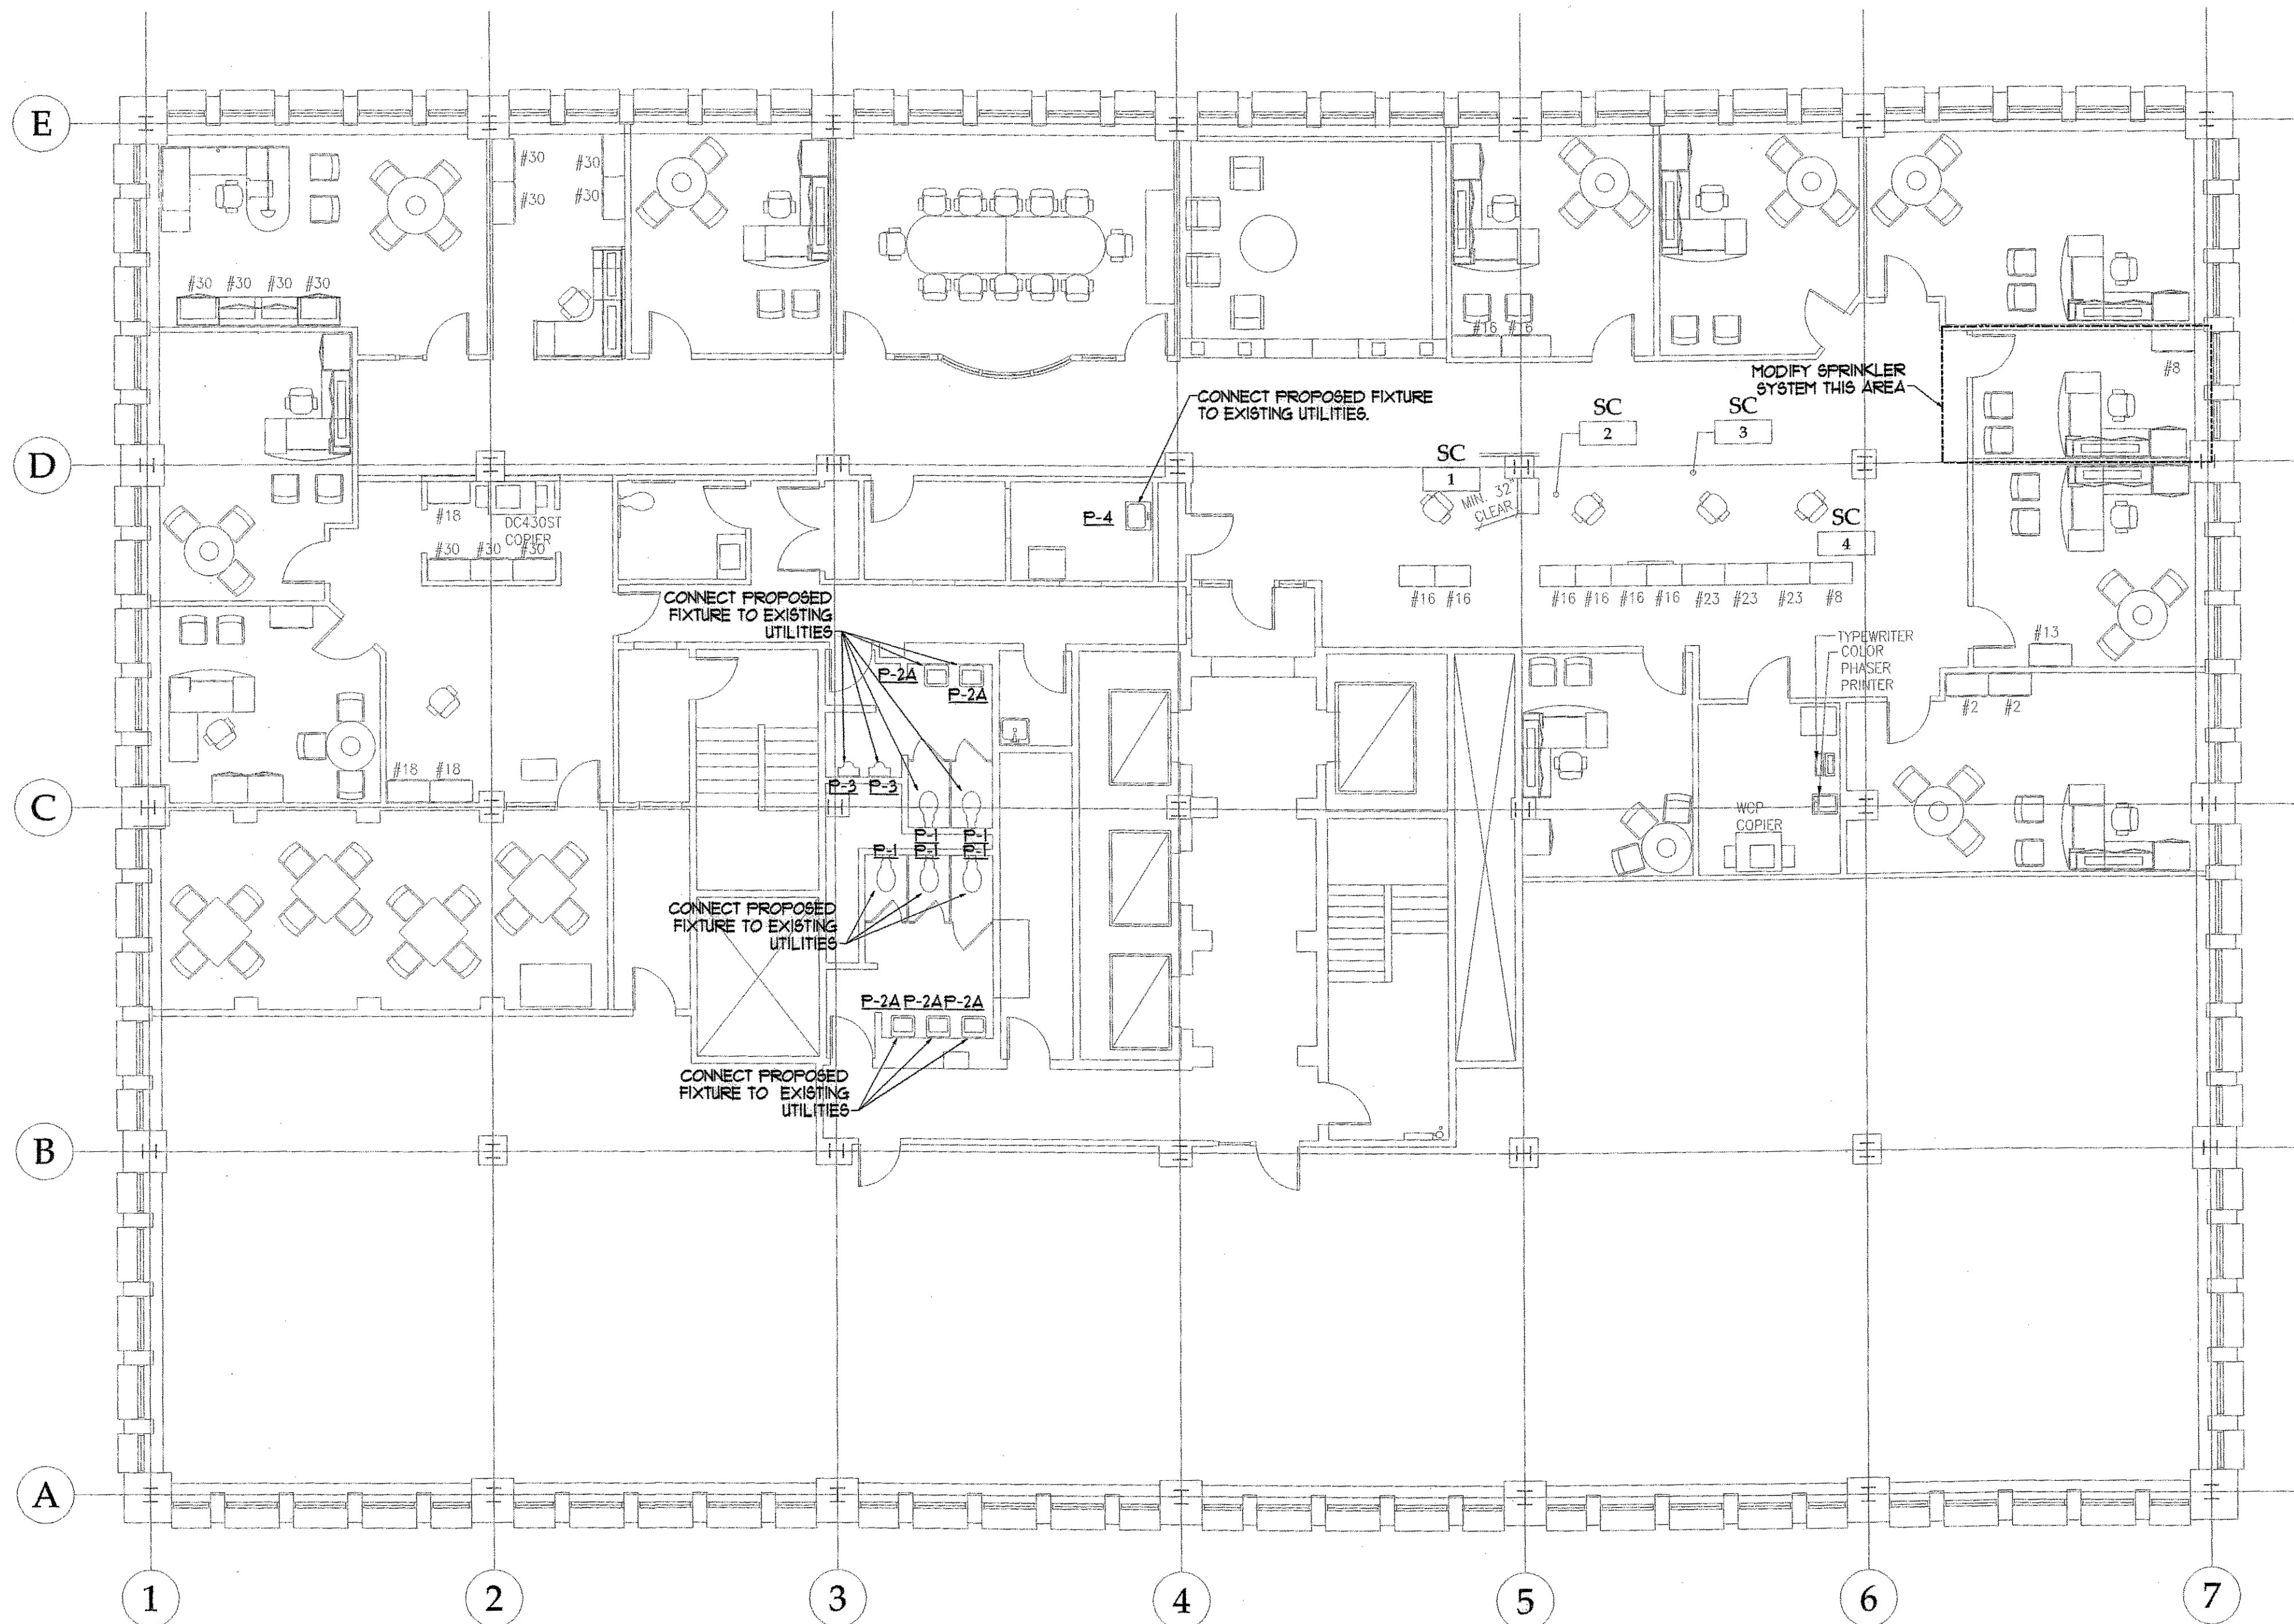

SEVENTH FLOOR MECHANICAL PLAN

SCALE - 1/8" = 1' - 0"

NOTES -

1. Fabricate and install metal splice covers for perimeter HVAC discharge plenums at windows at all areas where existing partitions are indicated to be removed. Anchor securely to existing perimeter enclosure. Match thickness and profile of existing splices.
2. Cut existing perimeter HVAC discharge plenums at windows at all areas where partition walls are being added. Install sheetmetal end w/ce plenum meets proposed wall and seal airtight.