


**INSET A**  
SCALE: 1" = 10'

PIPE TABLE			
PIPE NAME	SIZE	LENGTH	SLOPE
PIPE 1S	6" PVC	36'	0.0050
PIPE 2S	6" PVC	112'	0.0317
PIPE 3S	6" PVC	125'	0.0050
PIPE 4S	6" PVC	16'	0.0050

STRUCTURE TABLE					
NAME	DIA.	GRATE	RIM	INV IN/SIZE/FROM	INV OUT/SIZE/TO
EX. SMH	48"	24"	40.36	31.01/6"PVC/SMH1 30.81/12" EX. SS/	30.78/12"EX. SS/
SMH1	48"	24"	48.36	44.36/6"PVC/SMH2 31.29/6"PVC/OUTSIDE DROP	31.19/6"PVC/EX. SMH
SMH2	48"	24"	52.69	48.00/6"PVC/SMH3	47.90/6"PVC/SMH1
SMH3	48"	24"	52.71	48.72/6"PVC/	48.62/6"PVC/SMH2

- NOTES:**
- UTILITY CONSTRUCTION SHALL COMPLY WITH PORTLAND WATER DISTRICT, UNITL, CMP AND CITY OF PORTLAND STANDARDS AND SPECIFICATIONS.
  - CONTRACTOR IS RESPONSIBLE FOR ALL UTILITY CONNECTION PERMITS, TESTING, COORDINATING INSPECTIONS WITH UTILITY COMPANY AND ASSOCIATED FEES.

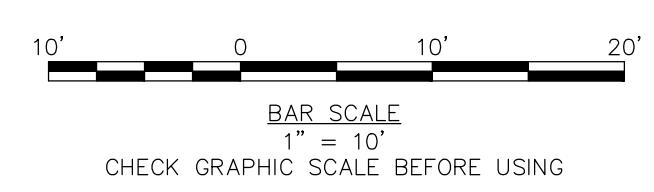

41 Hutchins Drive  
Portland, Maine 04102  
800.426.4262 | www.woodardcurran.com

**WOODARD & CURRAN**

COMMITMENT & INTEGRITY DRIVE RESULTS

THIS DOCUMENT IS THE PROPERTY OF WOODARD & CURRAN, INC. AND ITS CLIENT. REPRODUCTION OR MODIFICATION WITHOUT WRITTEN PERMISSION IS PROHIBITED.

LAUREN JANE SNIET  
12284  
3/21/2017

3/21/2017

REV	DESCRIPTION	DATE
2	REVISED WATER SERVICE	3/21/2017
1	ADDENDUM 1	10/11/16

CHECKED BY: DAS  
DRAWN BY: JBC  
22311-C204.dwg

CANALSTUDIO

ZERO CANAL PLAZA DEVELOPMENT

UTILITY PLAN

JOB NO.: 229311  
DATE: SEPTEMBER 19, 2016  
SCALE: 1" = 10"  
SHEET: 7 OF 10

**C-204**