


CLIENT/OWNER/TENANT  
FAT FACE LTD  
1-3 RIDGWAY HAVANT, PO9 1QJ  
UNITED KINGDOM  
CONTACT: DAVID LILLEY  
TEL: 0044.2392.441100  
E: DAVID.LILLEY@FATFACE.COM

DESIGNER  
BOX OF FROGS LTD  
2 WILLOW PARK STROKE POGES BUCKS SL2 4ES  
CONTACT: SARAH MALCOM-RICHARDS  
TEL: 007748608997  
E: SARAH@BOXOFFROGS.WEB.COM

MEP ENGINEER  
FISKAA  
589 8TH AVENUE  
NEW YORK, NY, 10018  
CONTACT: ERIC MARTINSEN  
TEL: 212.736.9500  
E: EMARTINSEN@FISKAA.COM

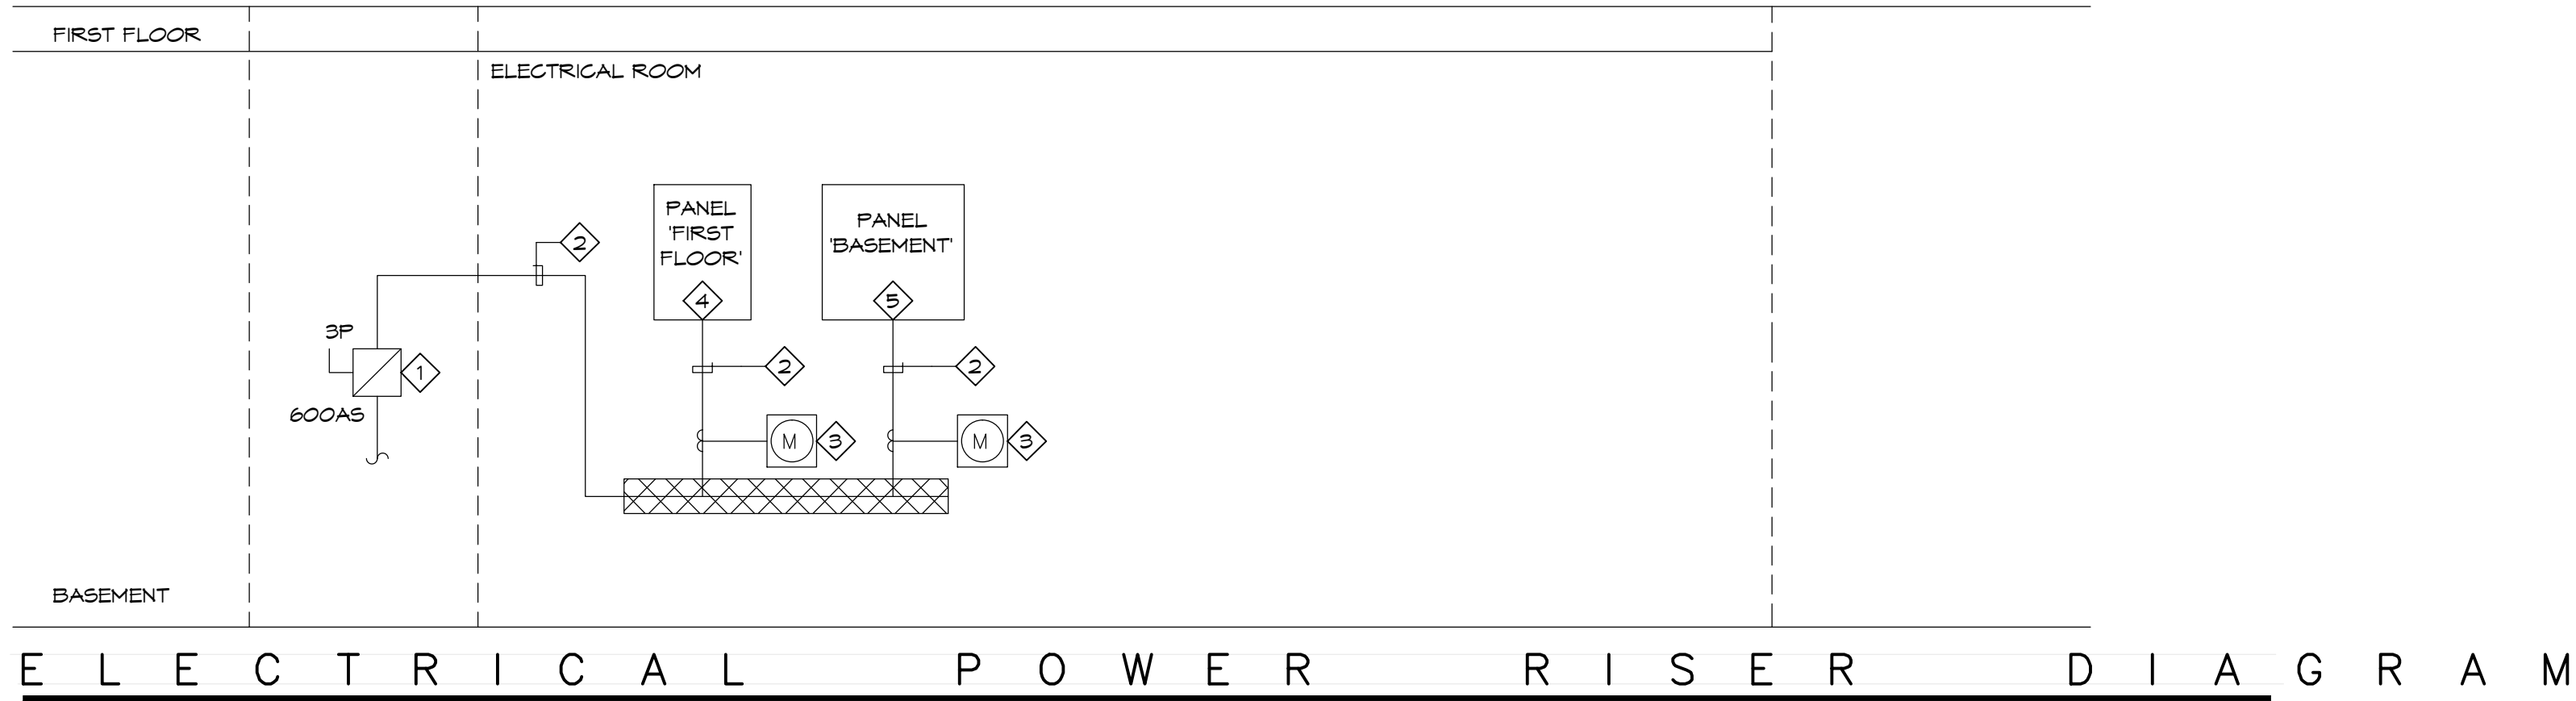


ELECTRICAL POWER RISER DIAGRAM

SCALE: NONE


REFERENCE NOTES:

- 1 EXISTING TO REMAIN 600A, 208V, 3P, DISCONNECT SWITCH.
- 2 EXISTING TO REMAIN FEEDER.
- 3 EXISTING TO REMAIN CON EDISON METER.
- 4 EXISTING TO REMAIN 100A, 208/120V, 3P, 4W, 34-POSITION, 10A MCB PANELBOARD. PROVIDE NEW CIRCUIT BREAKERS.
- 5 EXISTING TO REMAIN 100A, 208/120V, 3P, 4W, 18-POSITION, 100A MCB PANELBOARD. PROVIDE NEW CIRCUIT BREAKERS.

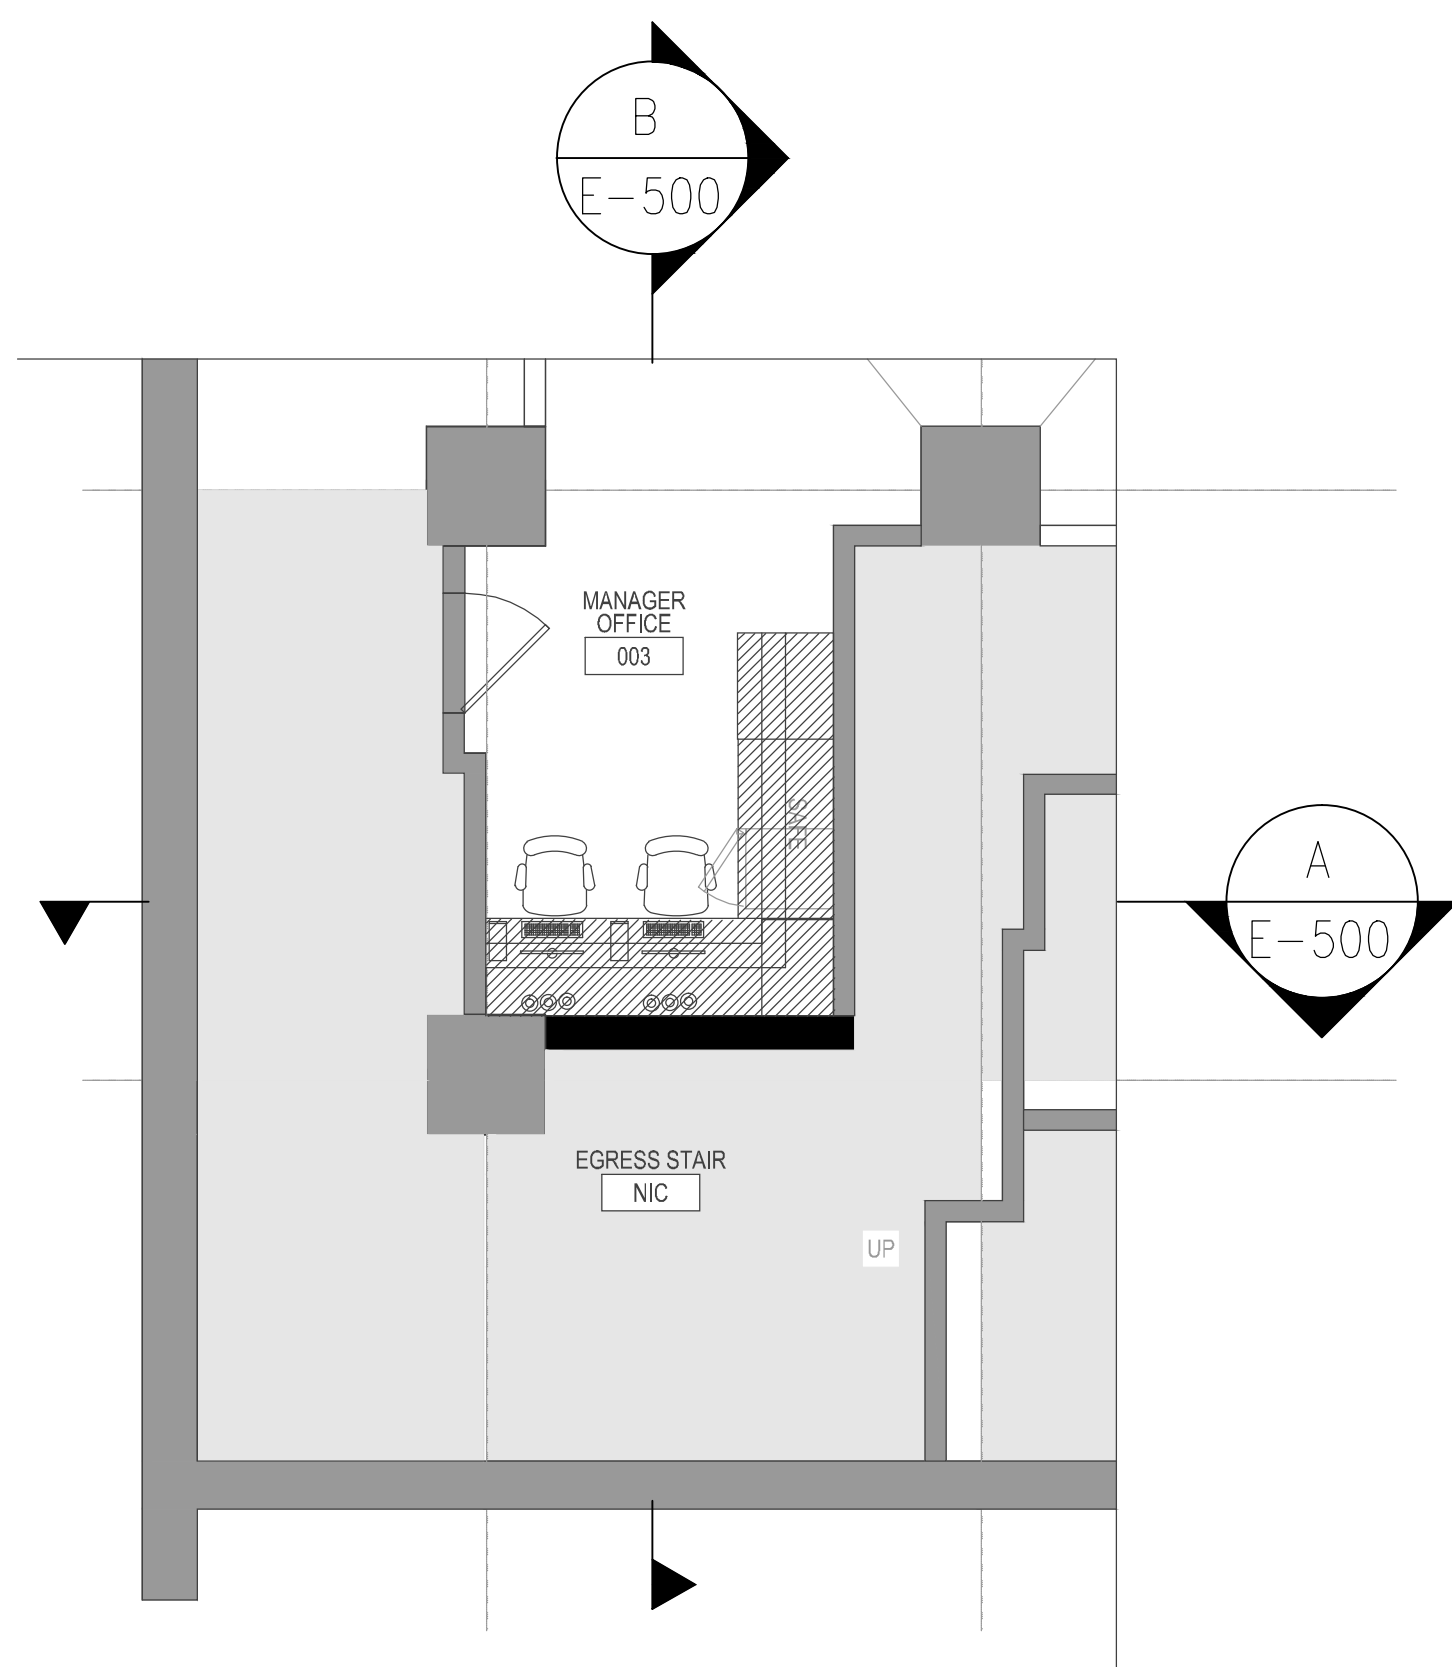



MANAGERS OFFICE

SCALE: 1/4" = 1'-0"

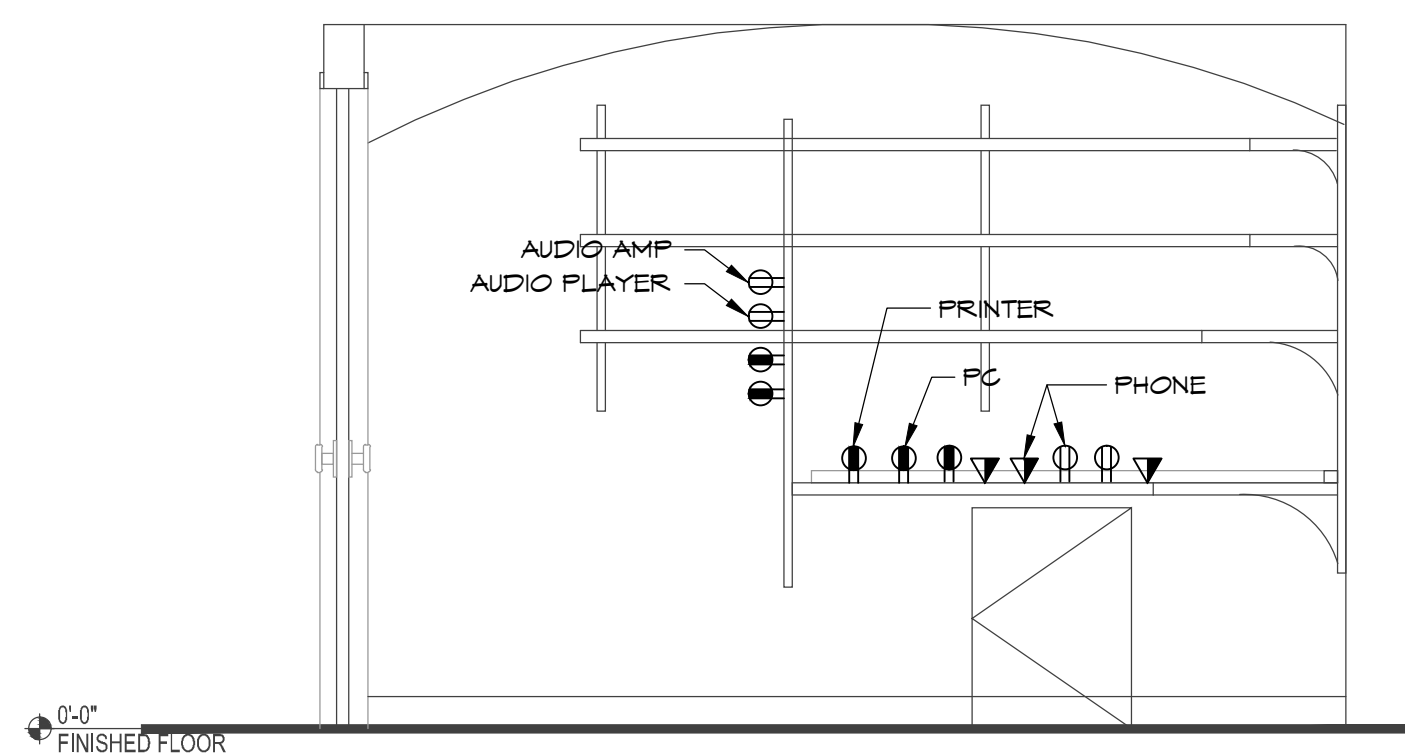


PLAN SOUTH SECTION

SCALE: NONE

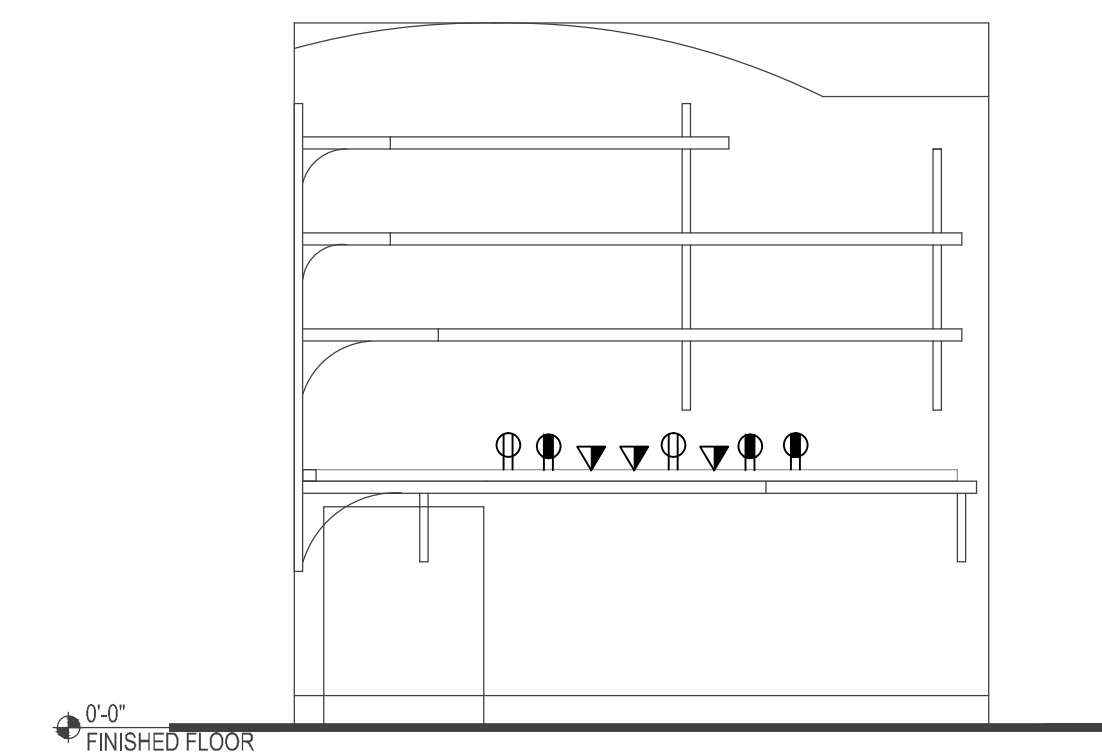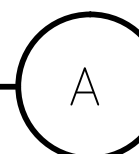

PLAN WEST SECTION

SCALE: NONE

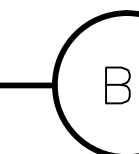


Issue	Date	Issue	Date
A. ISSUE FOR LL REVIEW & HISTORIC REVIEW	07/10/2015		
B. ISSUE FOR DEMO PERMIT	07/20/2015		
C. ISSUE FOR PERMIT	07/24/2015		

Project:  
FAT FACE PORTLAND  
34 EXCHANGE STREET  
PORTLAND, ME 04104  
Drawing Title:  
ELECTRICAL RISER DIAGRAM

Project No.	Drawn By	Date	Scale
15.102.00	JM	---	---

Seal: JM Floor(s):

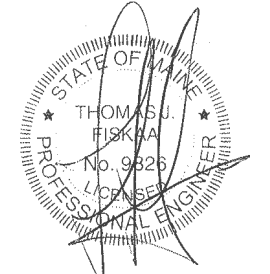

Drawing No.  
E-500