
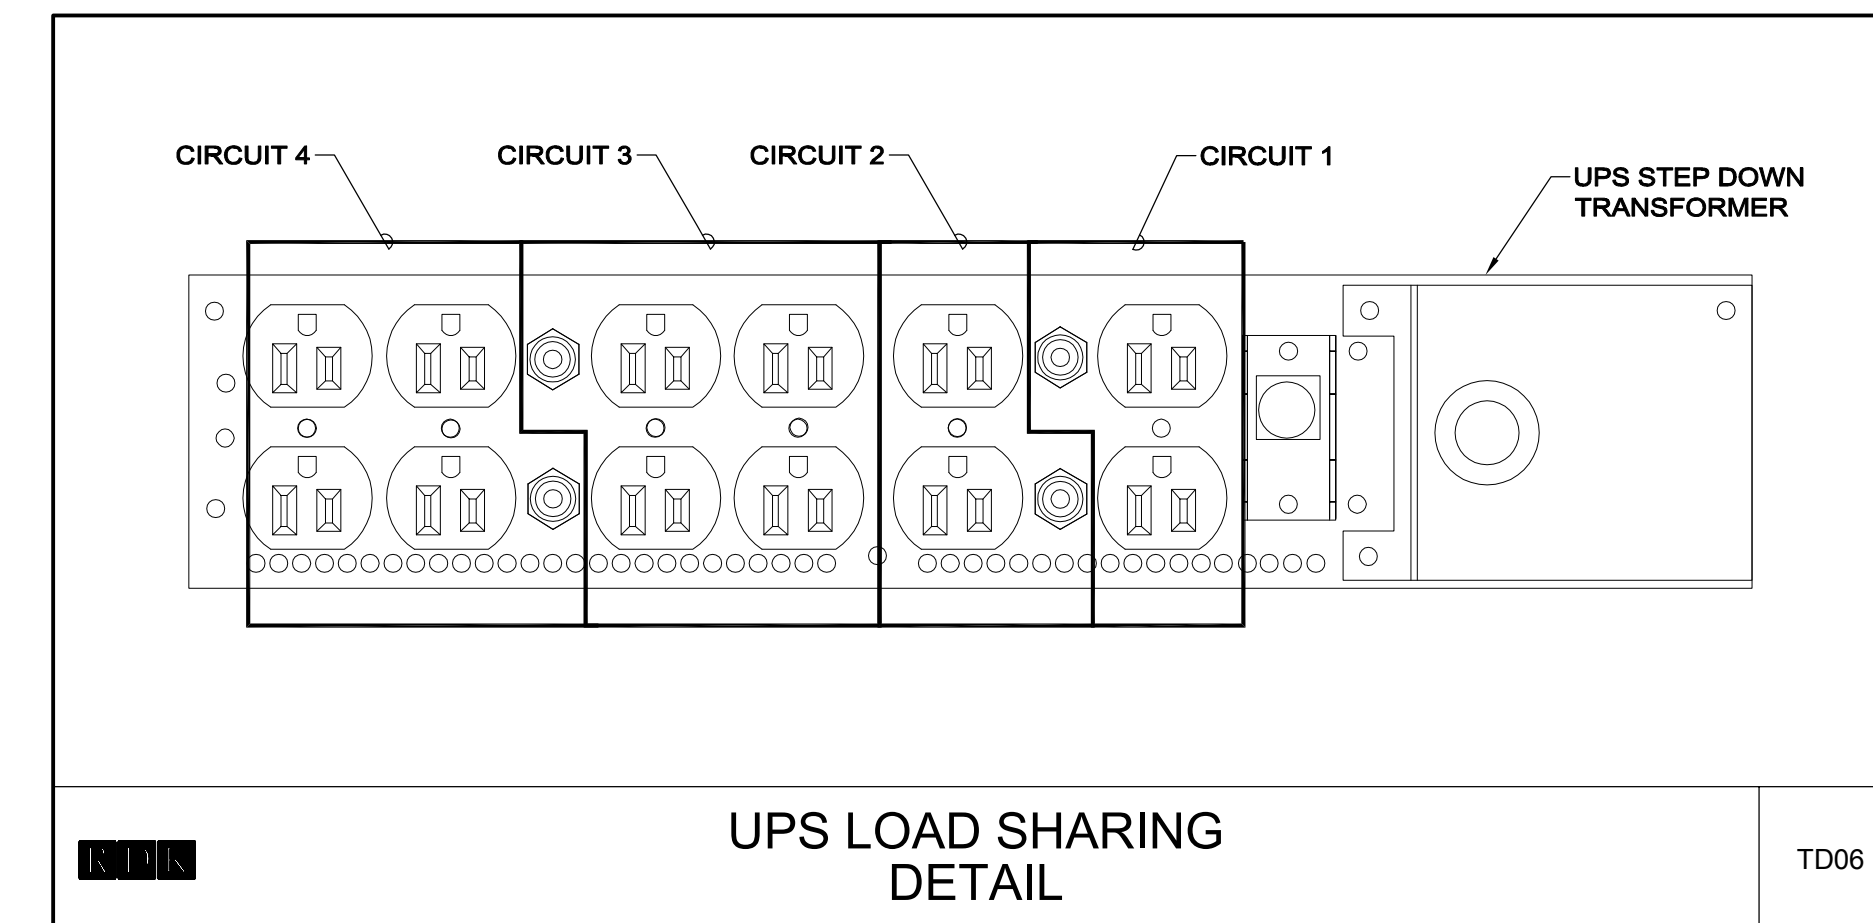
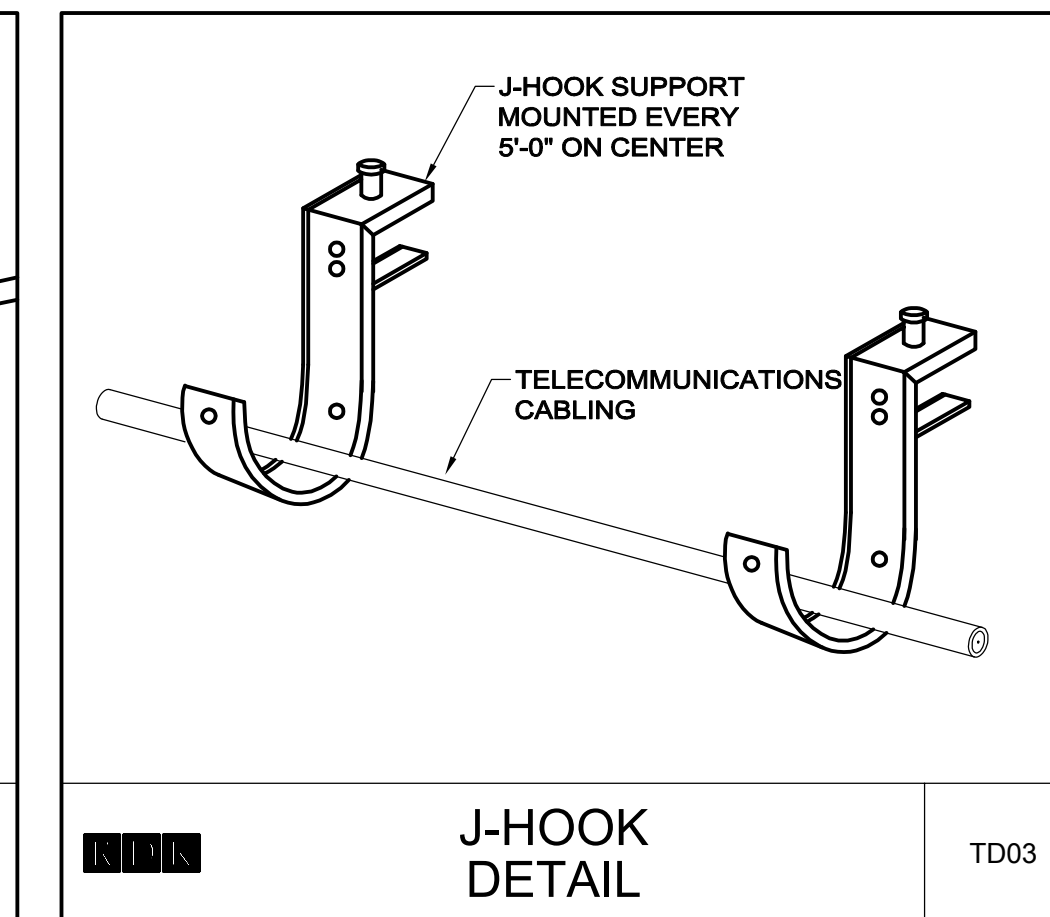
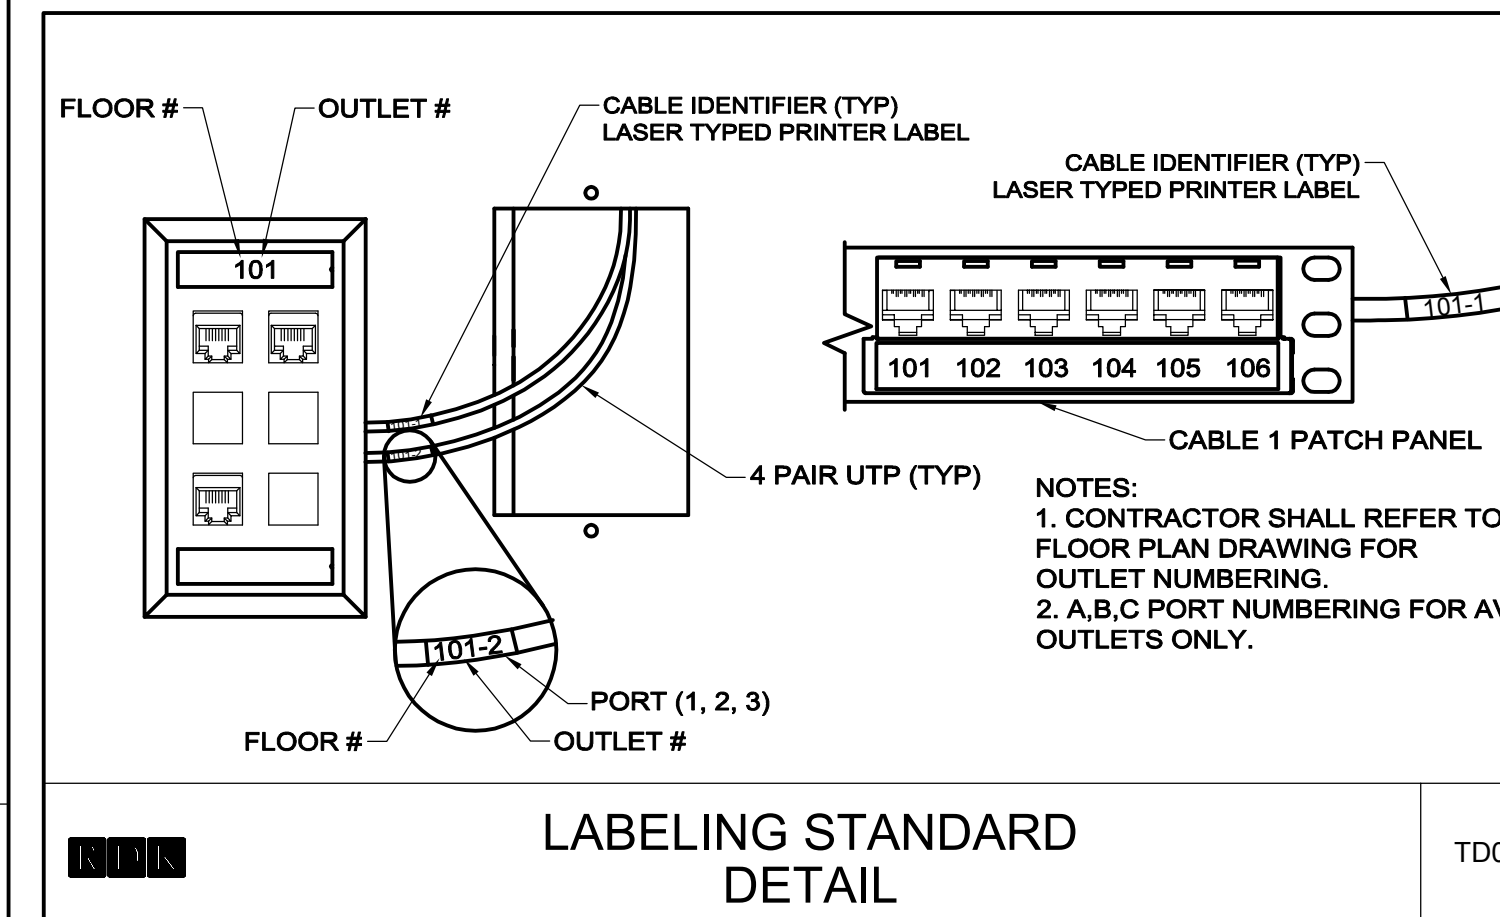
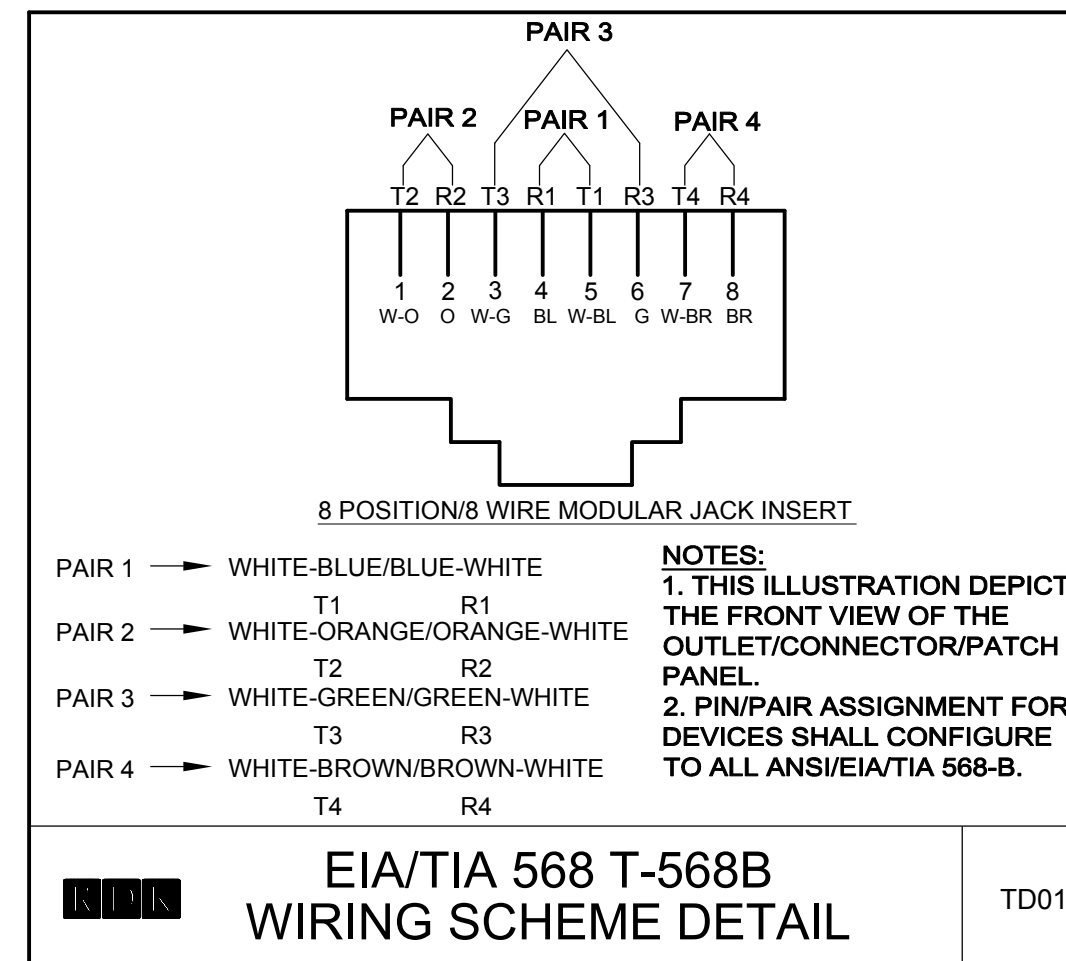


NOTES:

- FOR GENERAL LEGEND, NOTES AND ABBREVIATIONS REFER TO TELECOMMUNICATIONS DRAWING T-000.
- REFER TO ARCHITECTURAL DRAWINGS FOR ASSOCIATED NOTES, MOUNTING DETAILS, HEIGHTS, AND EXACT LOCATIONS OF ALL DEVICES.
- PATCH PANEL QUANTITIES SHOWN ARE DIAGRAMMATIC ONLY. PROVIDE APPROPRIATE QUANTITY OF PATCH PANELS WITHIN EACH RACK TO ACCOMMODATE THE REQUIRED NUMBER OF CABLES PER THE FLOOR PLANS AND SPECIFICATIONS.
- THIS CONTRACTOR SHALL COORDINATE EXACT LOCATIONS OF ALL RACK AND WALL FIELD TERMINATION AND ASSOCIATED TELECOMMUNICATIONS HARDWARE WITH THE OWNER'S INFORMATION TECHNOLOGY REPRESENTATIVE PRIOR TO INSTALLATION. THIS CONTRACTOR SHALL PROVIDE DIMENSIONED DRAWINGS OF LAYOUT COORDINATION TO ENGINEER FOR RECORD.
- ORTRONICS PATCH PANELS SHALL HAVE COMPUTER COLOR CODED ICONS APPLIED TO THE APPROPRIATE LOCATIONS. COORDINATE ALL LOCATIONS WITH FIDELITY IT.
- THIS CONTRACTOR SHALL RELOCATE, TERMINATE, TEST AND RENUMBER ALL EXISTING HORIZONTAL CABLING WITHIN 2-POST RACK AND APPLY NEW PATCHING DESIGN. REFER TO RACK ELEVATION "TE01" FOR ADDITIONAL INFORMATION.
- CONTRACTOR SHALL REMOVE EXISTING WHITE VOICE PATCH PANELS AND ASSOCIATED CABLING TO THEIR POINT OF ORIGIN.


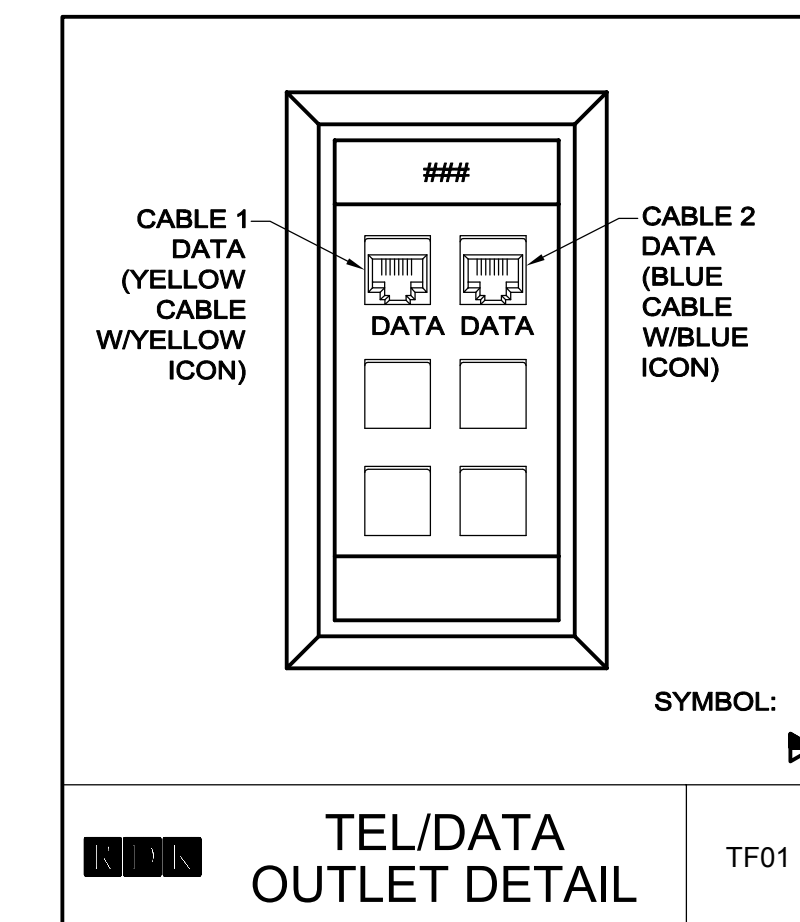


RACKS & EQUIPMENT			
ITEM	DESCRIPTION	MANUFACTURER	PART NUMBER
HORIZONTAL WIRE MANAGER	1RU	ORTRONICS	OR-80800010
HORIZONTAL WIRE MANAGER	2RU	ORTRONICS	OR-808044549
24 PORT PATCH PANEL	MODULAR RJ45	ORTRONICS	OR-PHD56U24
APC 8000VA/4200W	UPS	APC	SURTKRML3U-TF5
APC SMARTUPS RAILS	UPS 2-POST RAIL KIT	APC	AP9625

CABLING			
ITEM	DESCRIPTION	MANUFACTURER	PART NUMBER
HORIZONTAL CABLING BLUE	CATEGORY 5E	BERK-TEK	10032065
HORIZONTAL CABLING YELLOW	CATEGORY 5E	BERK-TEK	10032060

NOTES:
1. CONTRACTOR SHALL PLUG RACK MOUNTED ONE POWER STRIP INTO CIRCUIT 1 ON THE UPS TRANSFORMER AND ONE POWER STRIP INTO CIRCUIT 2 ON THE UPS TRANSFORMER. REFER TO DETAIL TD06 FOR ADDITIONAL INFORMATION.
2. CONTRACTOR SHALL PROVIDE AND INSTALL 2-POST RAIL KIT FOR UPS AND STEP DOWN TRANSFORMER.

FACEPLATES/INSERTS			
APPLICATION	DESCRIPTION	MANUFACTURER	PART NUMBER
DEMOUNTABLE	SURF MNT OFFICE BOX	ORTRONICS	OR-40300185
WALL MOUNTED	CADDY MPLS1	CADDY	MPLS1
DEMOUNTABLE/ WALL MOUNTED	TRAC-JACK FACEPLATE	ORTRONICS	OR-40300545-88
DEMOUNTABLE/ WALL MOUNTED	CAT 5E LAN 568B TRACJACK	ORTRONICS	OR-TJ5E00-88
DEMOUNTABLE/ WALL MOUNTED	YELLOW LAN #1 ICON	ORTRONICS	OR-40324200
DEMOUNTABLE/ WALL MOUNTED	BLUE LAN #2 ICON	ORTRONICS	OR-40328200
DEMOUNTABLE/ WALL MOUNTED	LT GREEN VIDEO #1 ICON	ORTRONICS	OR-40328200
DEMOUNTABLE/ WALL MOUNTED	BLANK MODULE	ORTRONICS	OR-42100002-88
WALL MOUNTED	SS WALL PHONE FACEPLATE	HUBBELL	PS30SR1GJ8
DEMOUNTABLE	SURF MNT GOLF TABLE LEG	ORTRONICS	OR-404122
WALL MOUNTED (PODIUM)	PODIUM DECORA FACEPLATE	ORTRONICS	OR-40300271
WALL MOUNTED (PODIUM)	PODIUM TRAC-JACK FRAME	ORTRONICS	OR-41900017

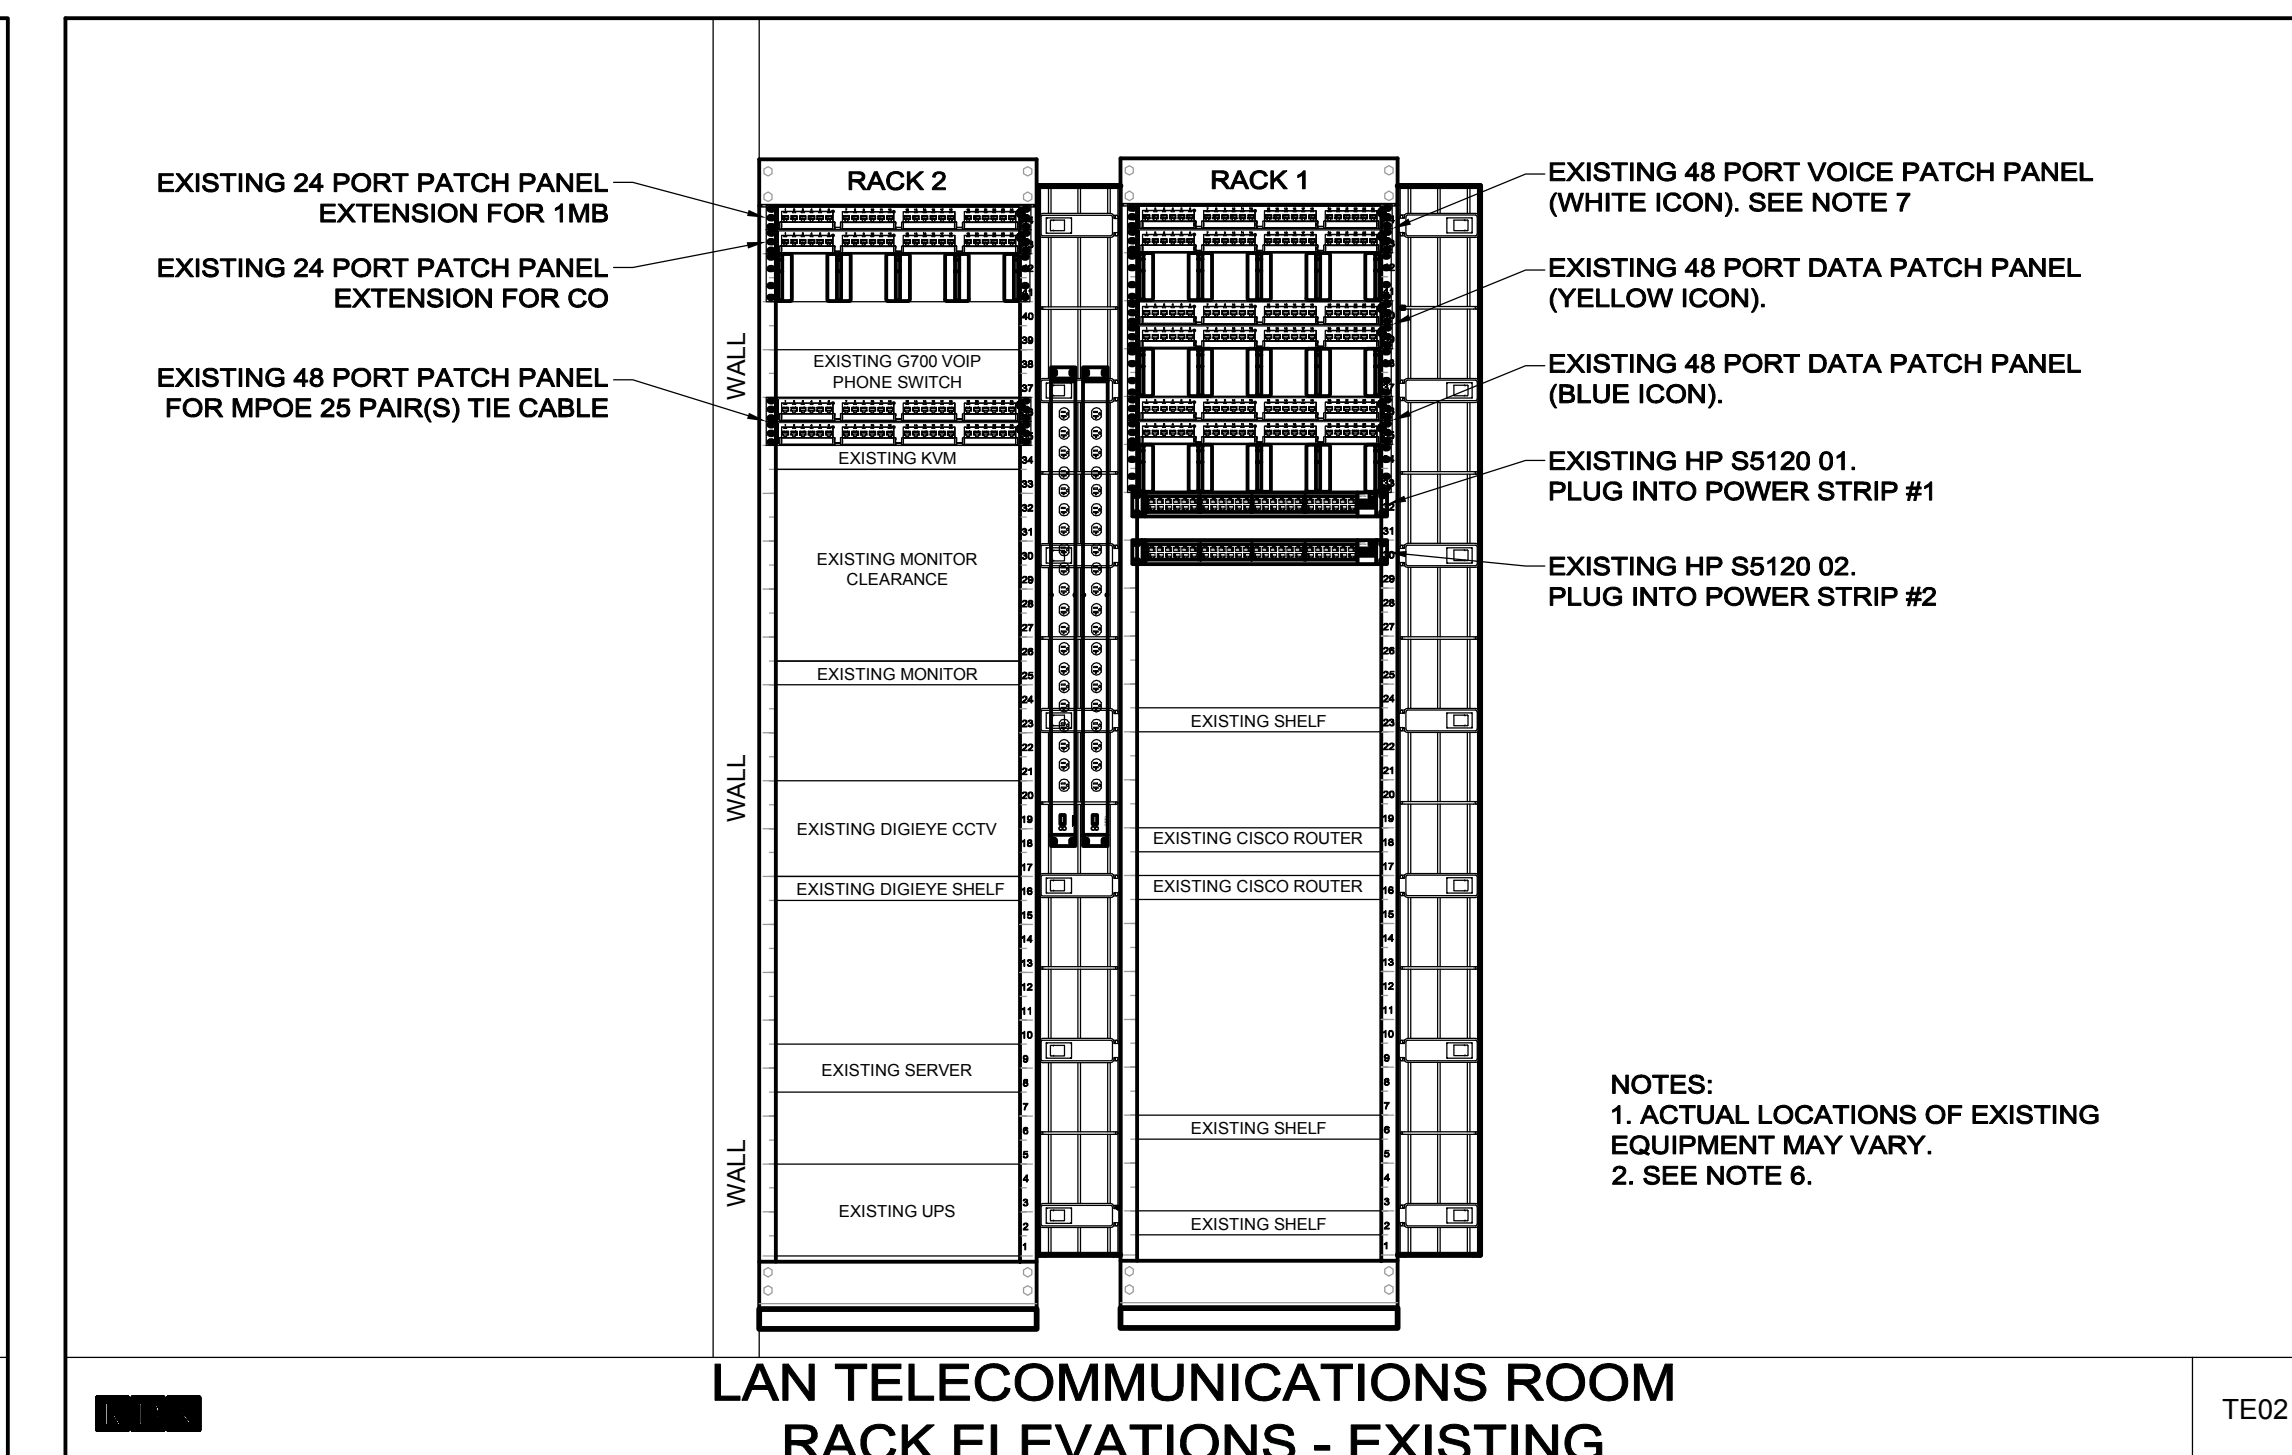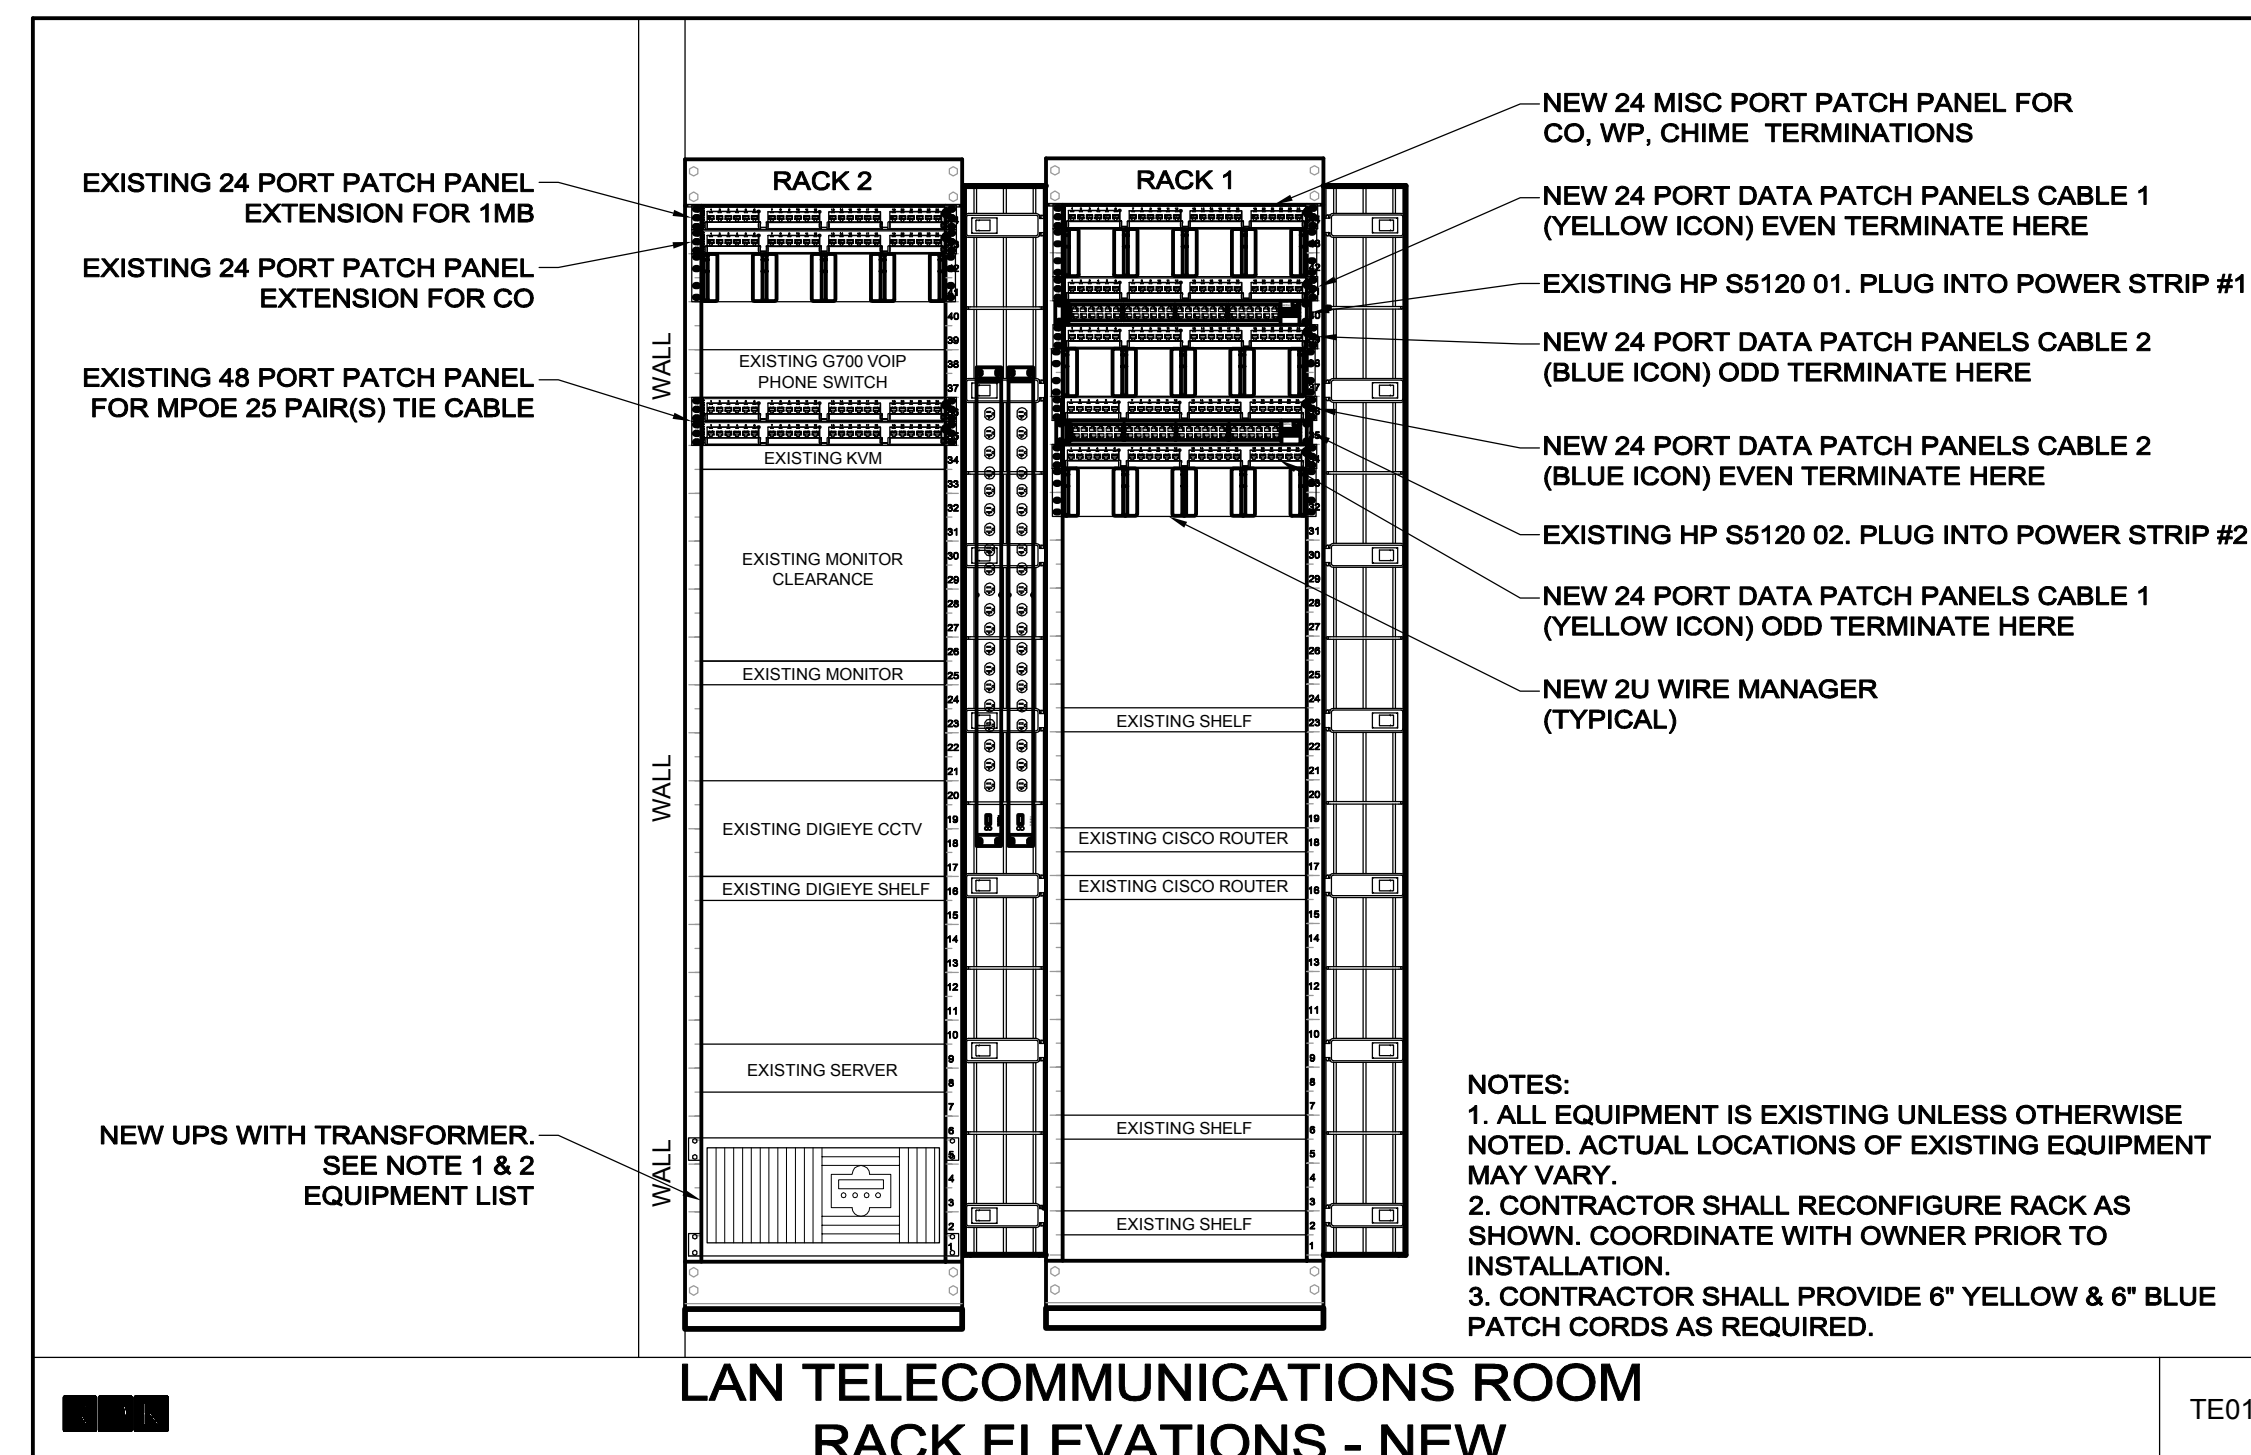

KLING STUBBINS

2301 Chestnut Street
Philadelphia, Pennsylvania
19103

P 215.569.2900
F 215.569.5963
W www.klingstubbins.com

Fidelity's Engineering Consultant:



Andover, MA • Boston, MA • Amherst, MA
Durham, NC • Charlotte, NC
70 Fargo Street Boston, MA 02210-1964
T.617-345-9888

Seals:

General Notes:

Project Title:




Fidelity Real Estate Company
245 Summer Street
Boston, MA 02110

Fidelity Investor Center
3 Canal Plaza
Portland, ME 04112
Branch ID No. 120

Number	Description	Date
03	ISSUED FOR PERMIT & CONSTR	03 OCT 14

Key Plan: Project North:

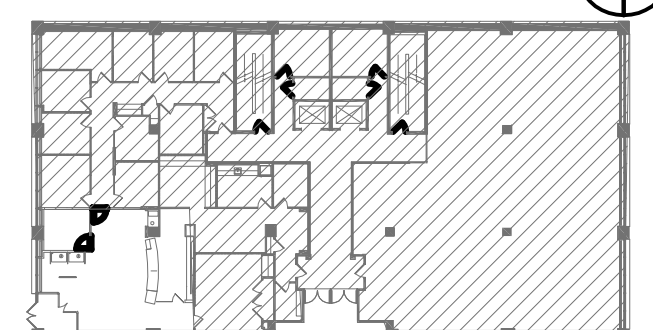

CAD File:
Project No.: 20140629
Copyright: 2014 KlingStubbins, Inc or LLC

Drawing Sheet Title:
**TELECOMMUNICATIONS
DETAILS**

Drawing Sheet Number:

T-600

Owner's Drawing Sheet No.: