


REVISION	DESCRIPTION	DATE
0	ISSUED FOR REVIEW & APPROVAL	5/10/2013
1	PORTLAND, ME FIRE PREV OFFICE REVIEW	5/13/2013

10 Princes Point Road, Yarmouth, Maine 04096 Office: 207.846.3350 • Fax: 207.846.6080	


NORMAN HANSON DETROY
2 CANAL PLAZA
PORTLAND, MAINE 04101
SECOND & THIRD FLOOR FIRE ALARM PLAN

DRAWN	JPB UNICAD JOB #13226
CHECKED	WAYNE B. HAYS NCET # 90496
DATE	5/3/2013
REVISION	1
SCALE	1/8"=1'-0"

FA-3
UNICAD Inc.
 578 W. 40th St.
 Portland, ME 04102
 Office: 601.865.0410
 www.unicad.net
 Fire Alarm Design & Drafting Services

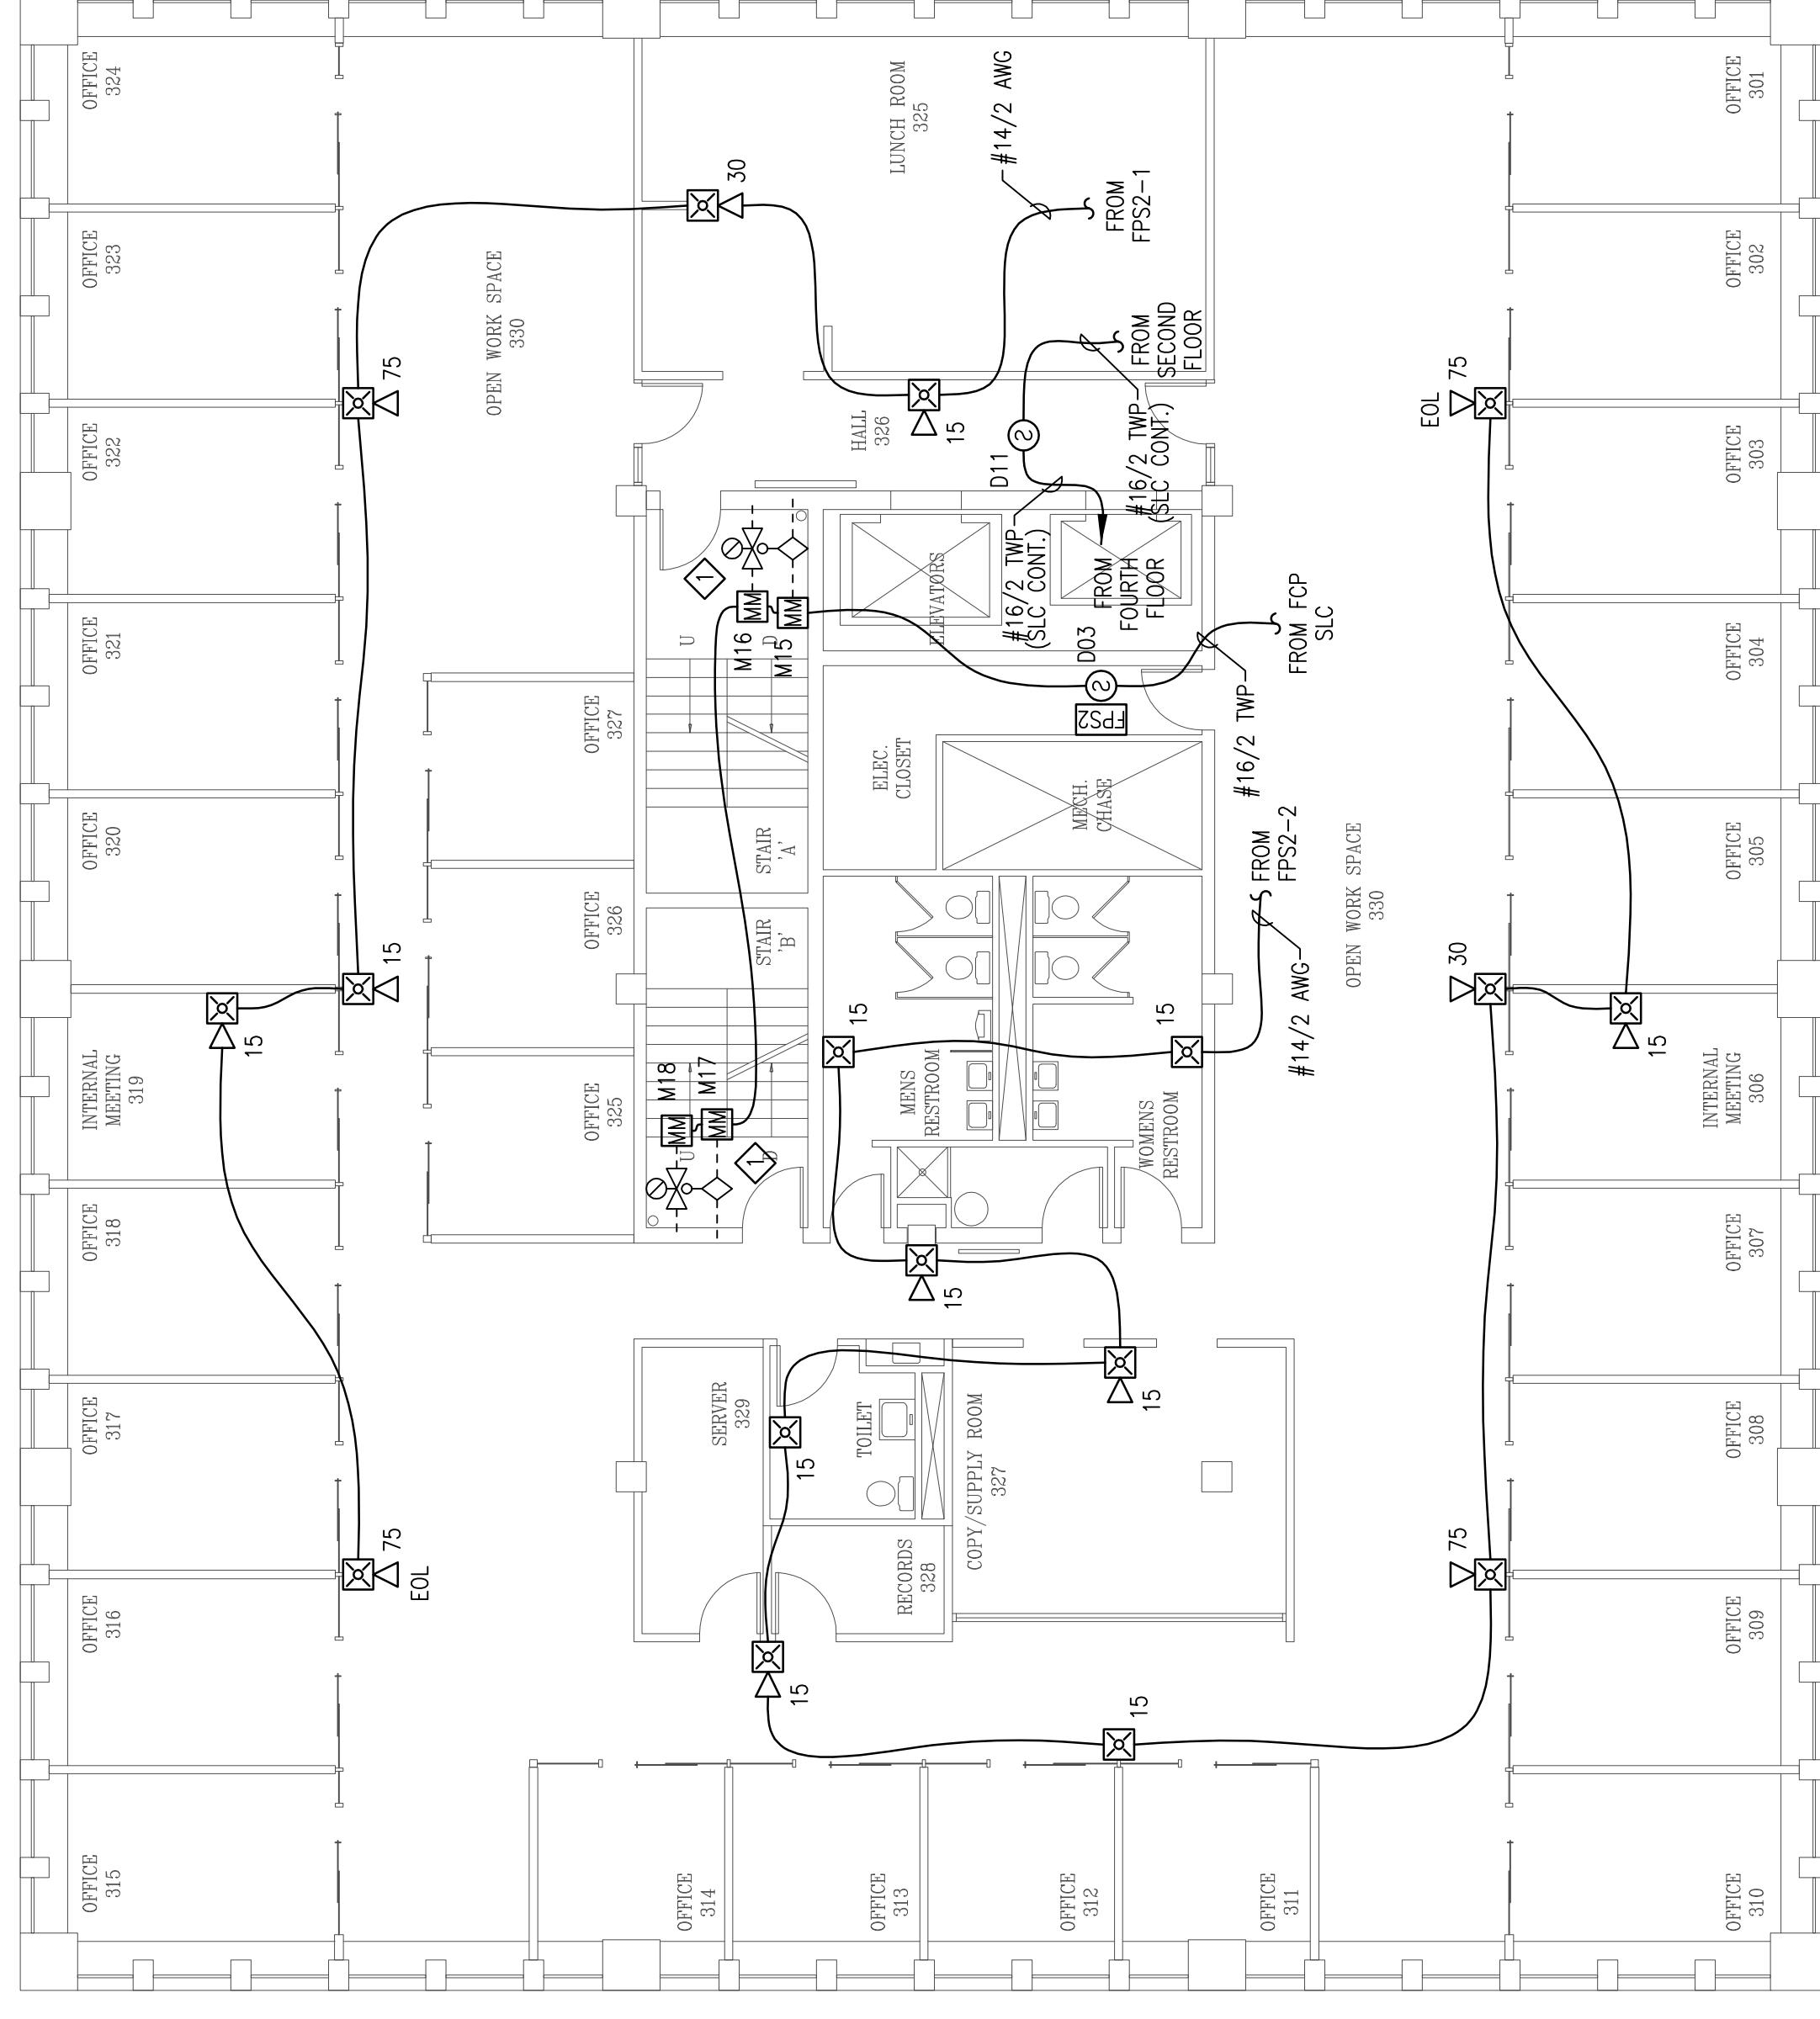

THIRD FLOOR FIRE ALARM PLAN
 SCALE: 1/8"=1'-0"

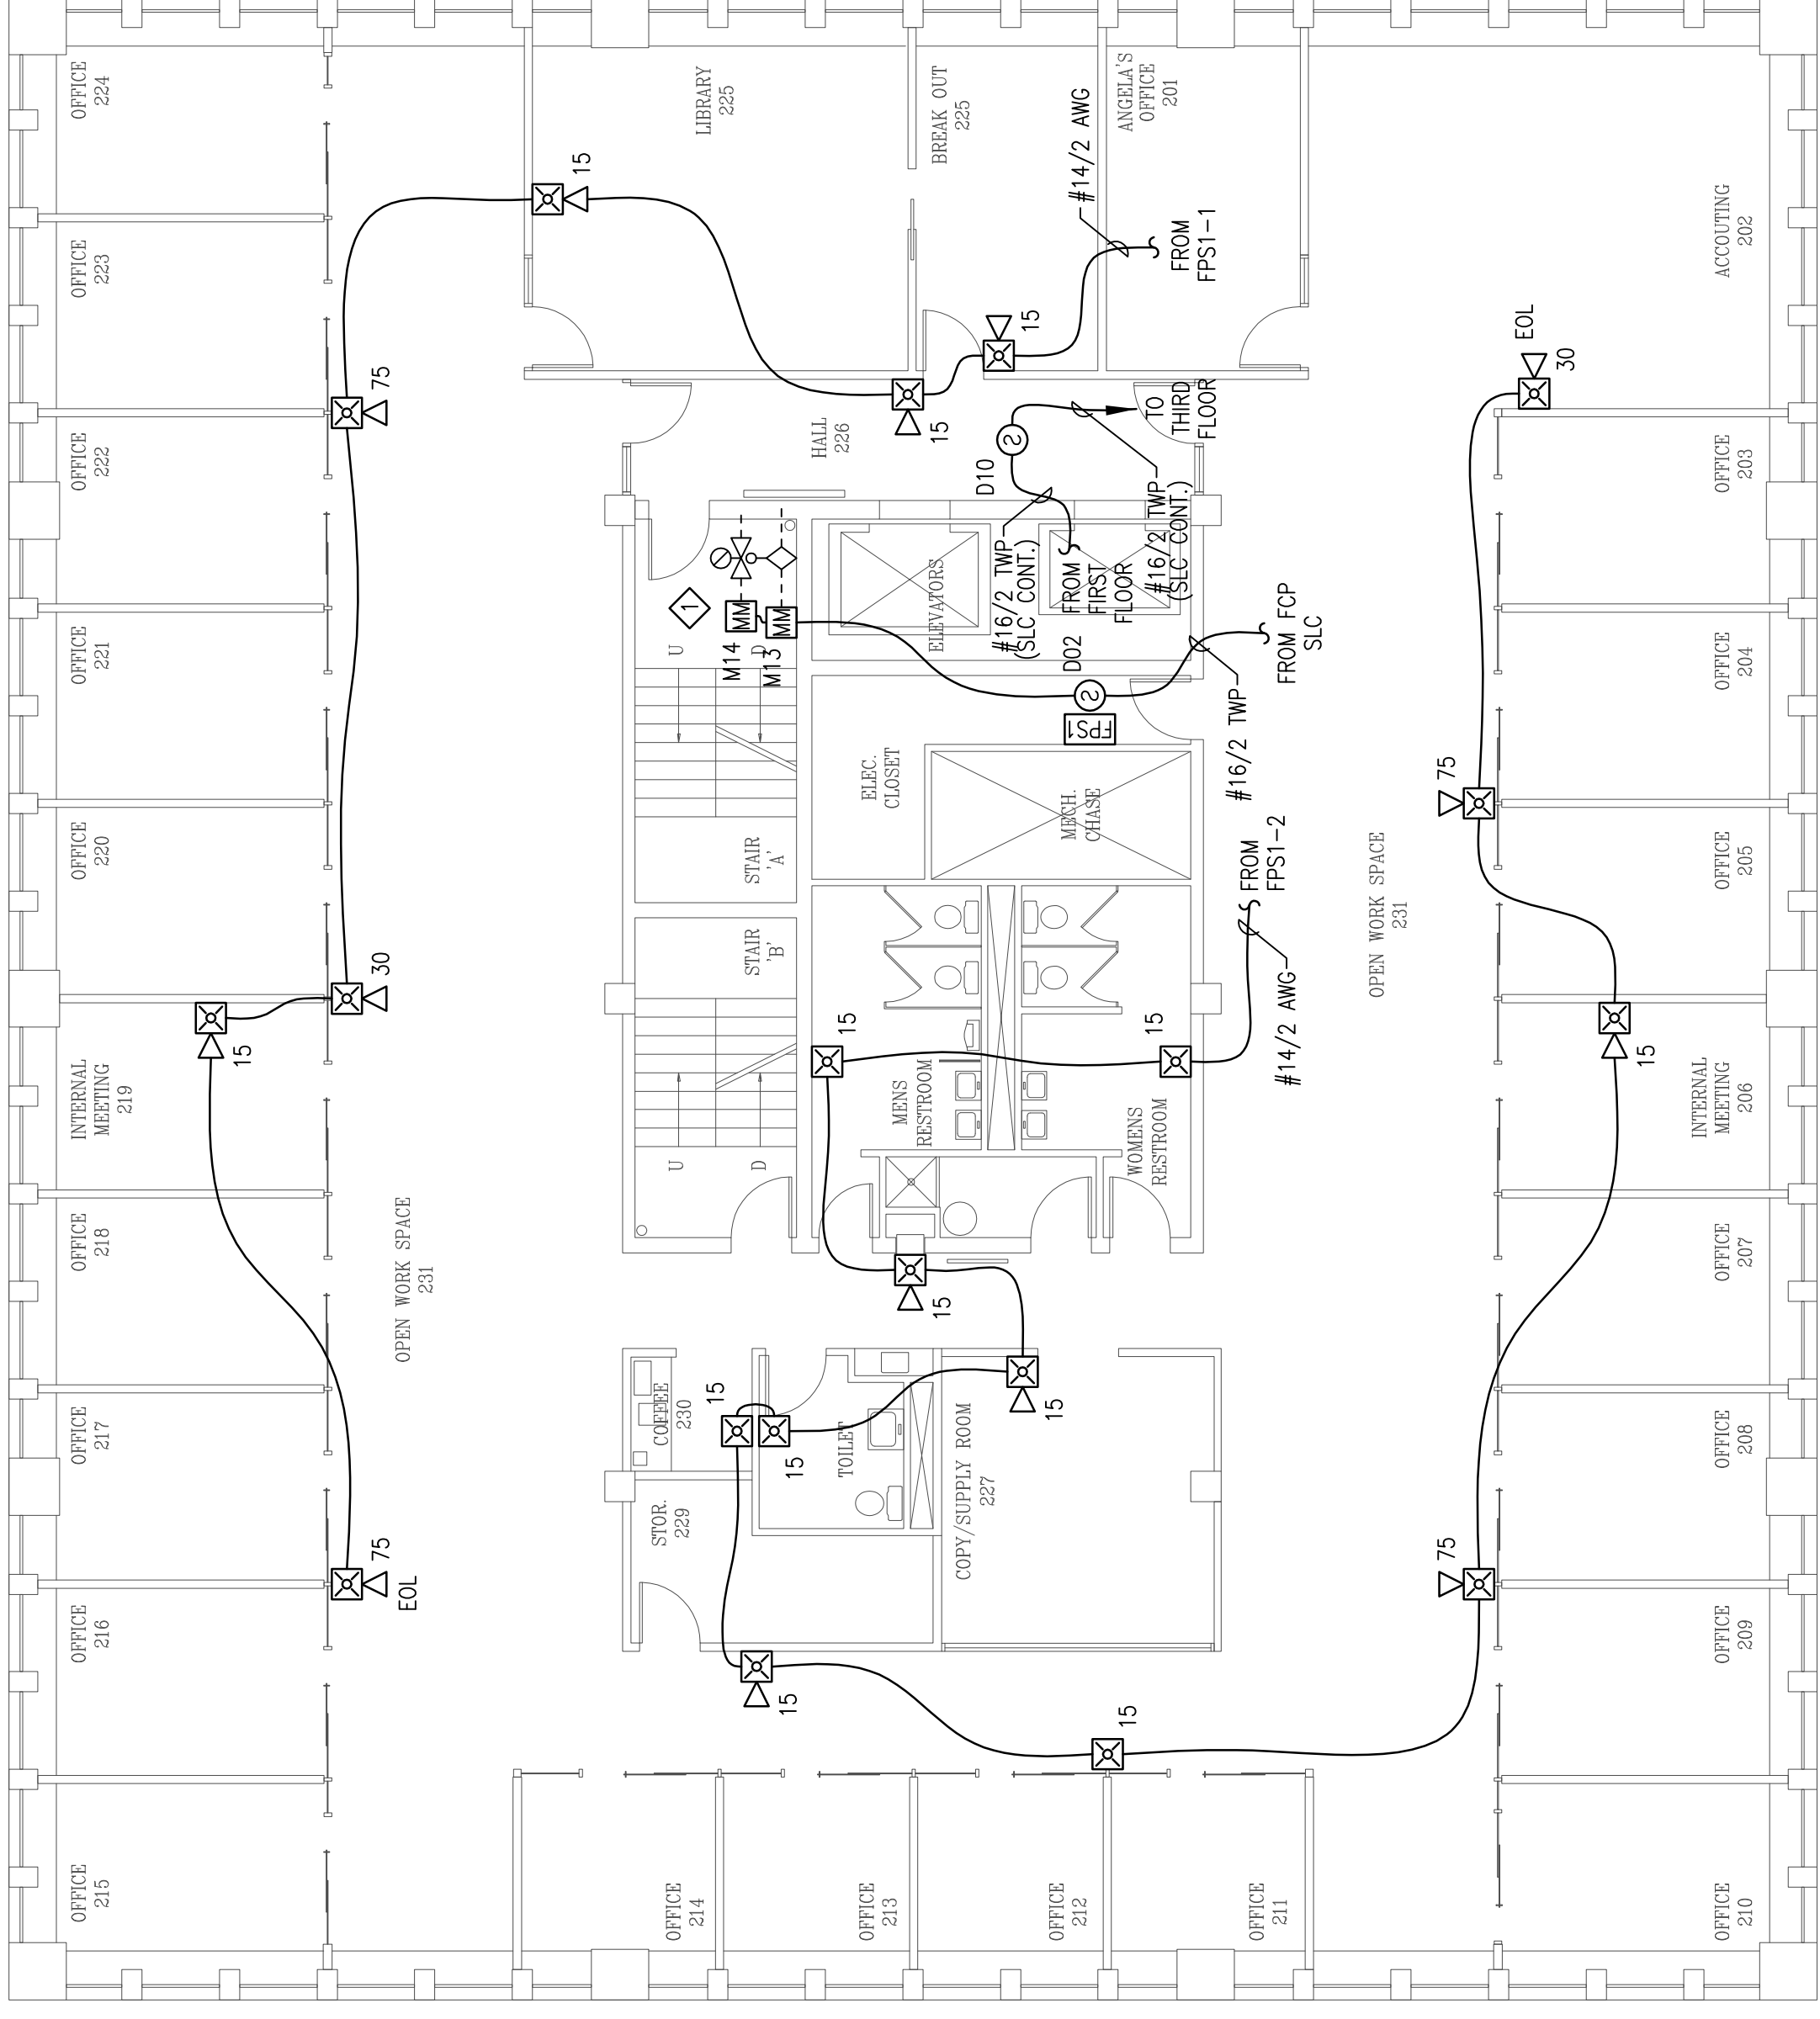

SECOND FLOOR FIRE ALARM PLAN
 SCALE: 1/8"=1'-0"

SHEET NOTES:

- ◊ ADDRESSABLE MONITOR MODULE(S) PROVIDED TO MONITOR ALL WATER FLOW, PRESSURE SWITCHES, TAMPER SWITCHES AND POST INDICATING VALVES ASSOCIATED WITH THE FIRE SPRINKLER SYSTEM. INSTALLING CONTRACTOR SHALL FIELD VERIFY EXACT MOUNTING, CIRCUITING AND PROGRAMMING REQUIREMENTS. FIELD VERIFY EXACT QUANTITY AND LOCATION(S).