



PROSPECT



DESIGN  
58 FORE ST., PORTLAND, ME  
www.prospectdesign.me  
T: 207-749-7400

**Hemesphere  
DESIGN**

Architecture


58 Fore Street  
Portland, ME 04101  
207.232.6079  
joe@hemespheredesign.com  
www.hemespheredesign.com

STONE COAST 4  
1 CANAL PLAZA  
STONECOAST FUND SERVICES

SIXTH FLOOR POWER AND DATA PLAN

PERMIT SET

SHEET TITLE	SIXTH FLOOR POWER AND DATA PLAN
REVISION	
DESIGN RVT##	
DATE:	

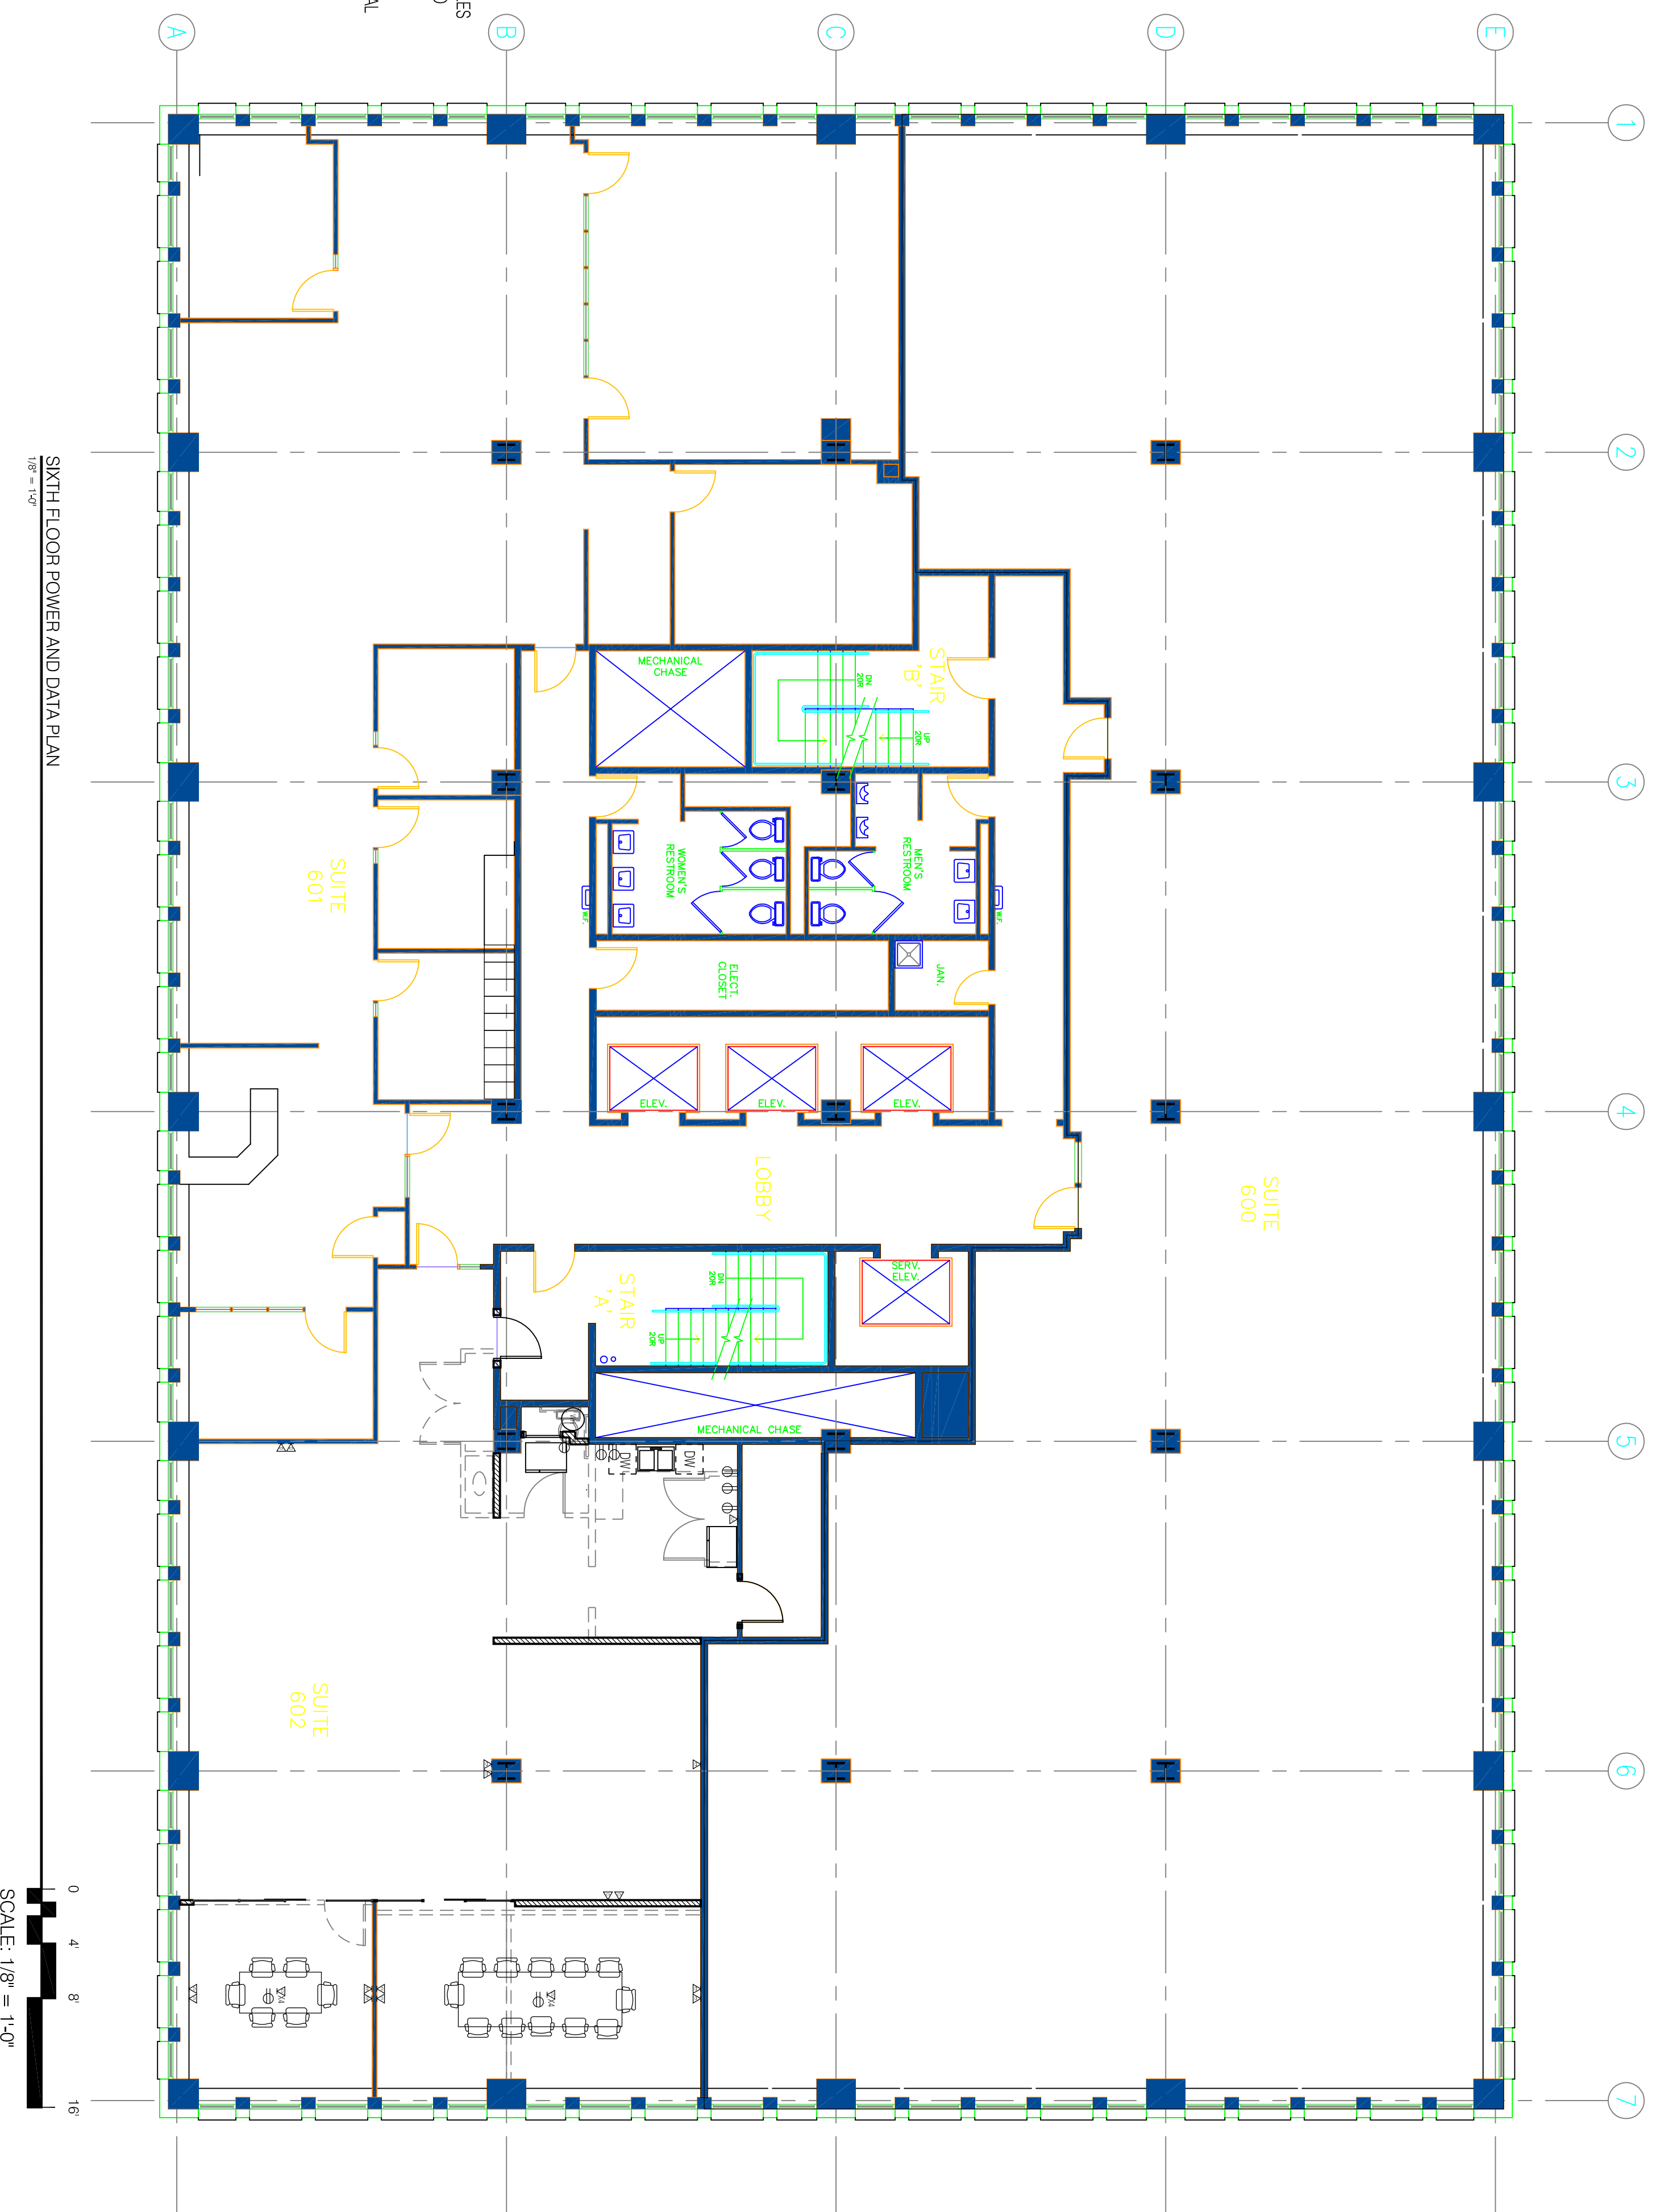

NOTE:  
ALL CUBICLE WIRING SHOULD EXTEND 15  
OUT OF WALL, EXCEPT AS NOTED  
ALL CUBICLE DATA WIRING WILL TERMINATE  
IN EACH CUBICLE  
DATA WIRING WILL ENTER CUBICLE GROUPS  
IN WIRE CLUSTERS AS SHOWN  
ALL CABLE CLUSTERS SHOULD EXIT COLUMN  
AS CLOSE TO CUBICLES AS POSSIBLE  
CORE DRILL UNDER CONFERENCE ROOM TABLES  
FOR DATA AND POWER CONNECTION, EACH TO  
HAVE ONE DUPLEX AND 4 DATA LINES  
CONVENIENCE OUTLETS PER CODE, ADDITIONAL  
OUTLETS AS MARKED ON PLAN

Φ DIRECT OUTLET  
▽ DATA PORT

SIXTH FLOOR POWER AND DATA PLAN  
1/8" = 1'-0"

SCALE: 1/8" = 1'-0"

A6.3