



PROSPECT



DESIGN
 58 FORE ST. PORTLAND, ME
 www.prospectdesign.me
 T: 207-749-7400

**HEMESPHERE
 DESIGN**

Architecture

58 Fore Street
 Portland, ME 04101
 joe@hemisphere.design.com
 www.hemisphere.design.com


STONE COAST 4
 1 CANAL PLAZA
 STONECOAST FUND SERVICES

PERMIT SET

SEVENTH FLOOR POWER AND DATA PLAN

DATE: February 19, 2016

A 7.3

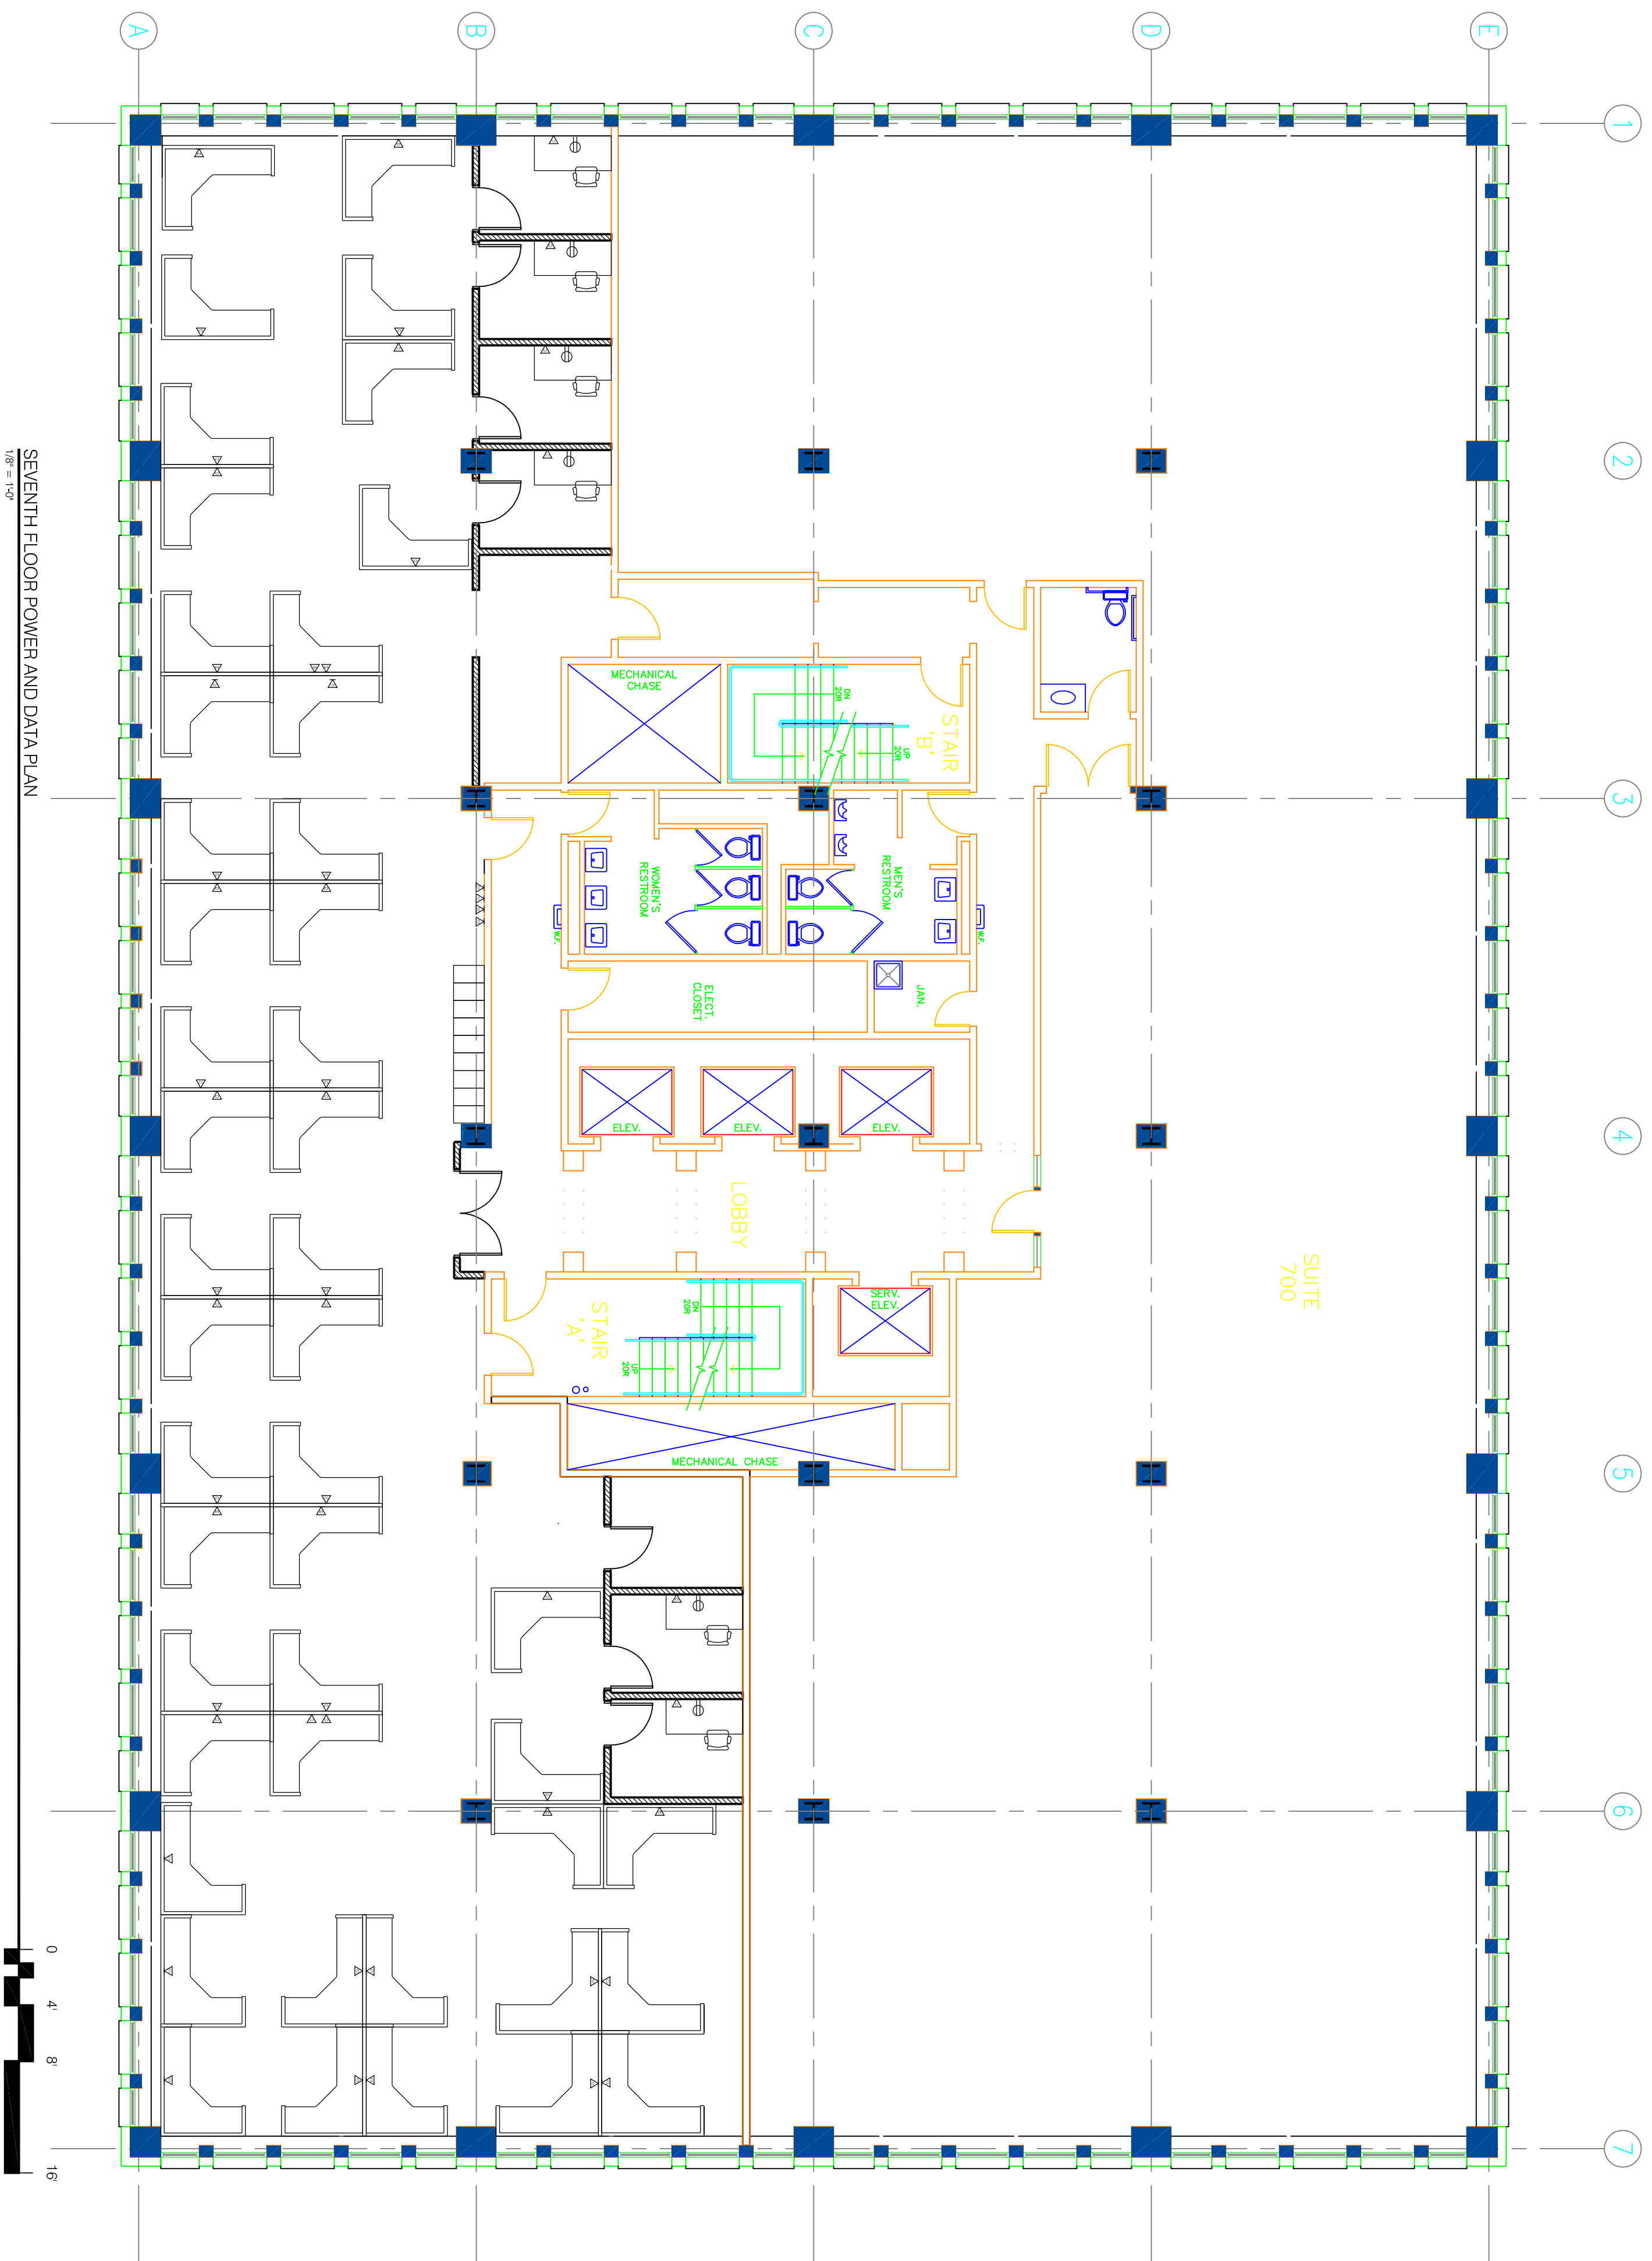

NOTE:
 EACH CUBICLE TWO HAVE TWO OUTLETS
 ALL CUBICLE WIRING SHOULD EXTEND 15'
 OUT OF WALL, EXCEPT AS NOTED
 ALL CUBICLE DATA WIRING WILL TERMINATE
 IN EACH CUBICLE
 DATA WIRING WILL ENTER CUBICLE GROUPS
 IN WIRE CLUSTERS AS SHOWN
 ALL CABLE CLUSTERS SHOULD EXIT COLUMN
 AS CLOSE TO CUBICLES AS POSSIBLE
 CORE DRILL UNDER CONFERENCE ROOM TABLES
 FOR DATA AND POWER CONNECTION. EACH TO
 HAVE ONE DUPLEX AND 4 DATA LINES
 CONVENIENCE OUTLETS PER CODE. ADDITIONAL
 OUTLETS AS MARKED ON PLAN

Φ DUPLEX OUTLET
 ▽ DATA PORT

SEVENTH FLOOR POWER AND DATA PLAN
 1/8" = 1'-0"

SCALE: 1/8" = 1'-0"