


FENCE LINE ALONG UNION ST.

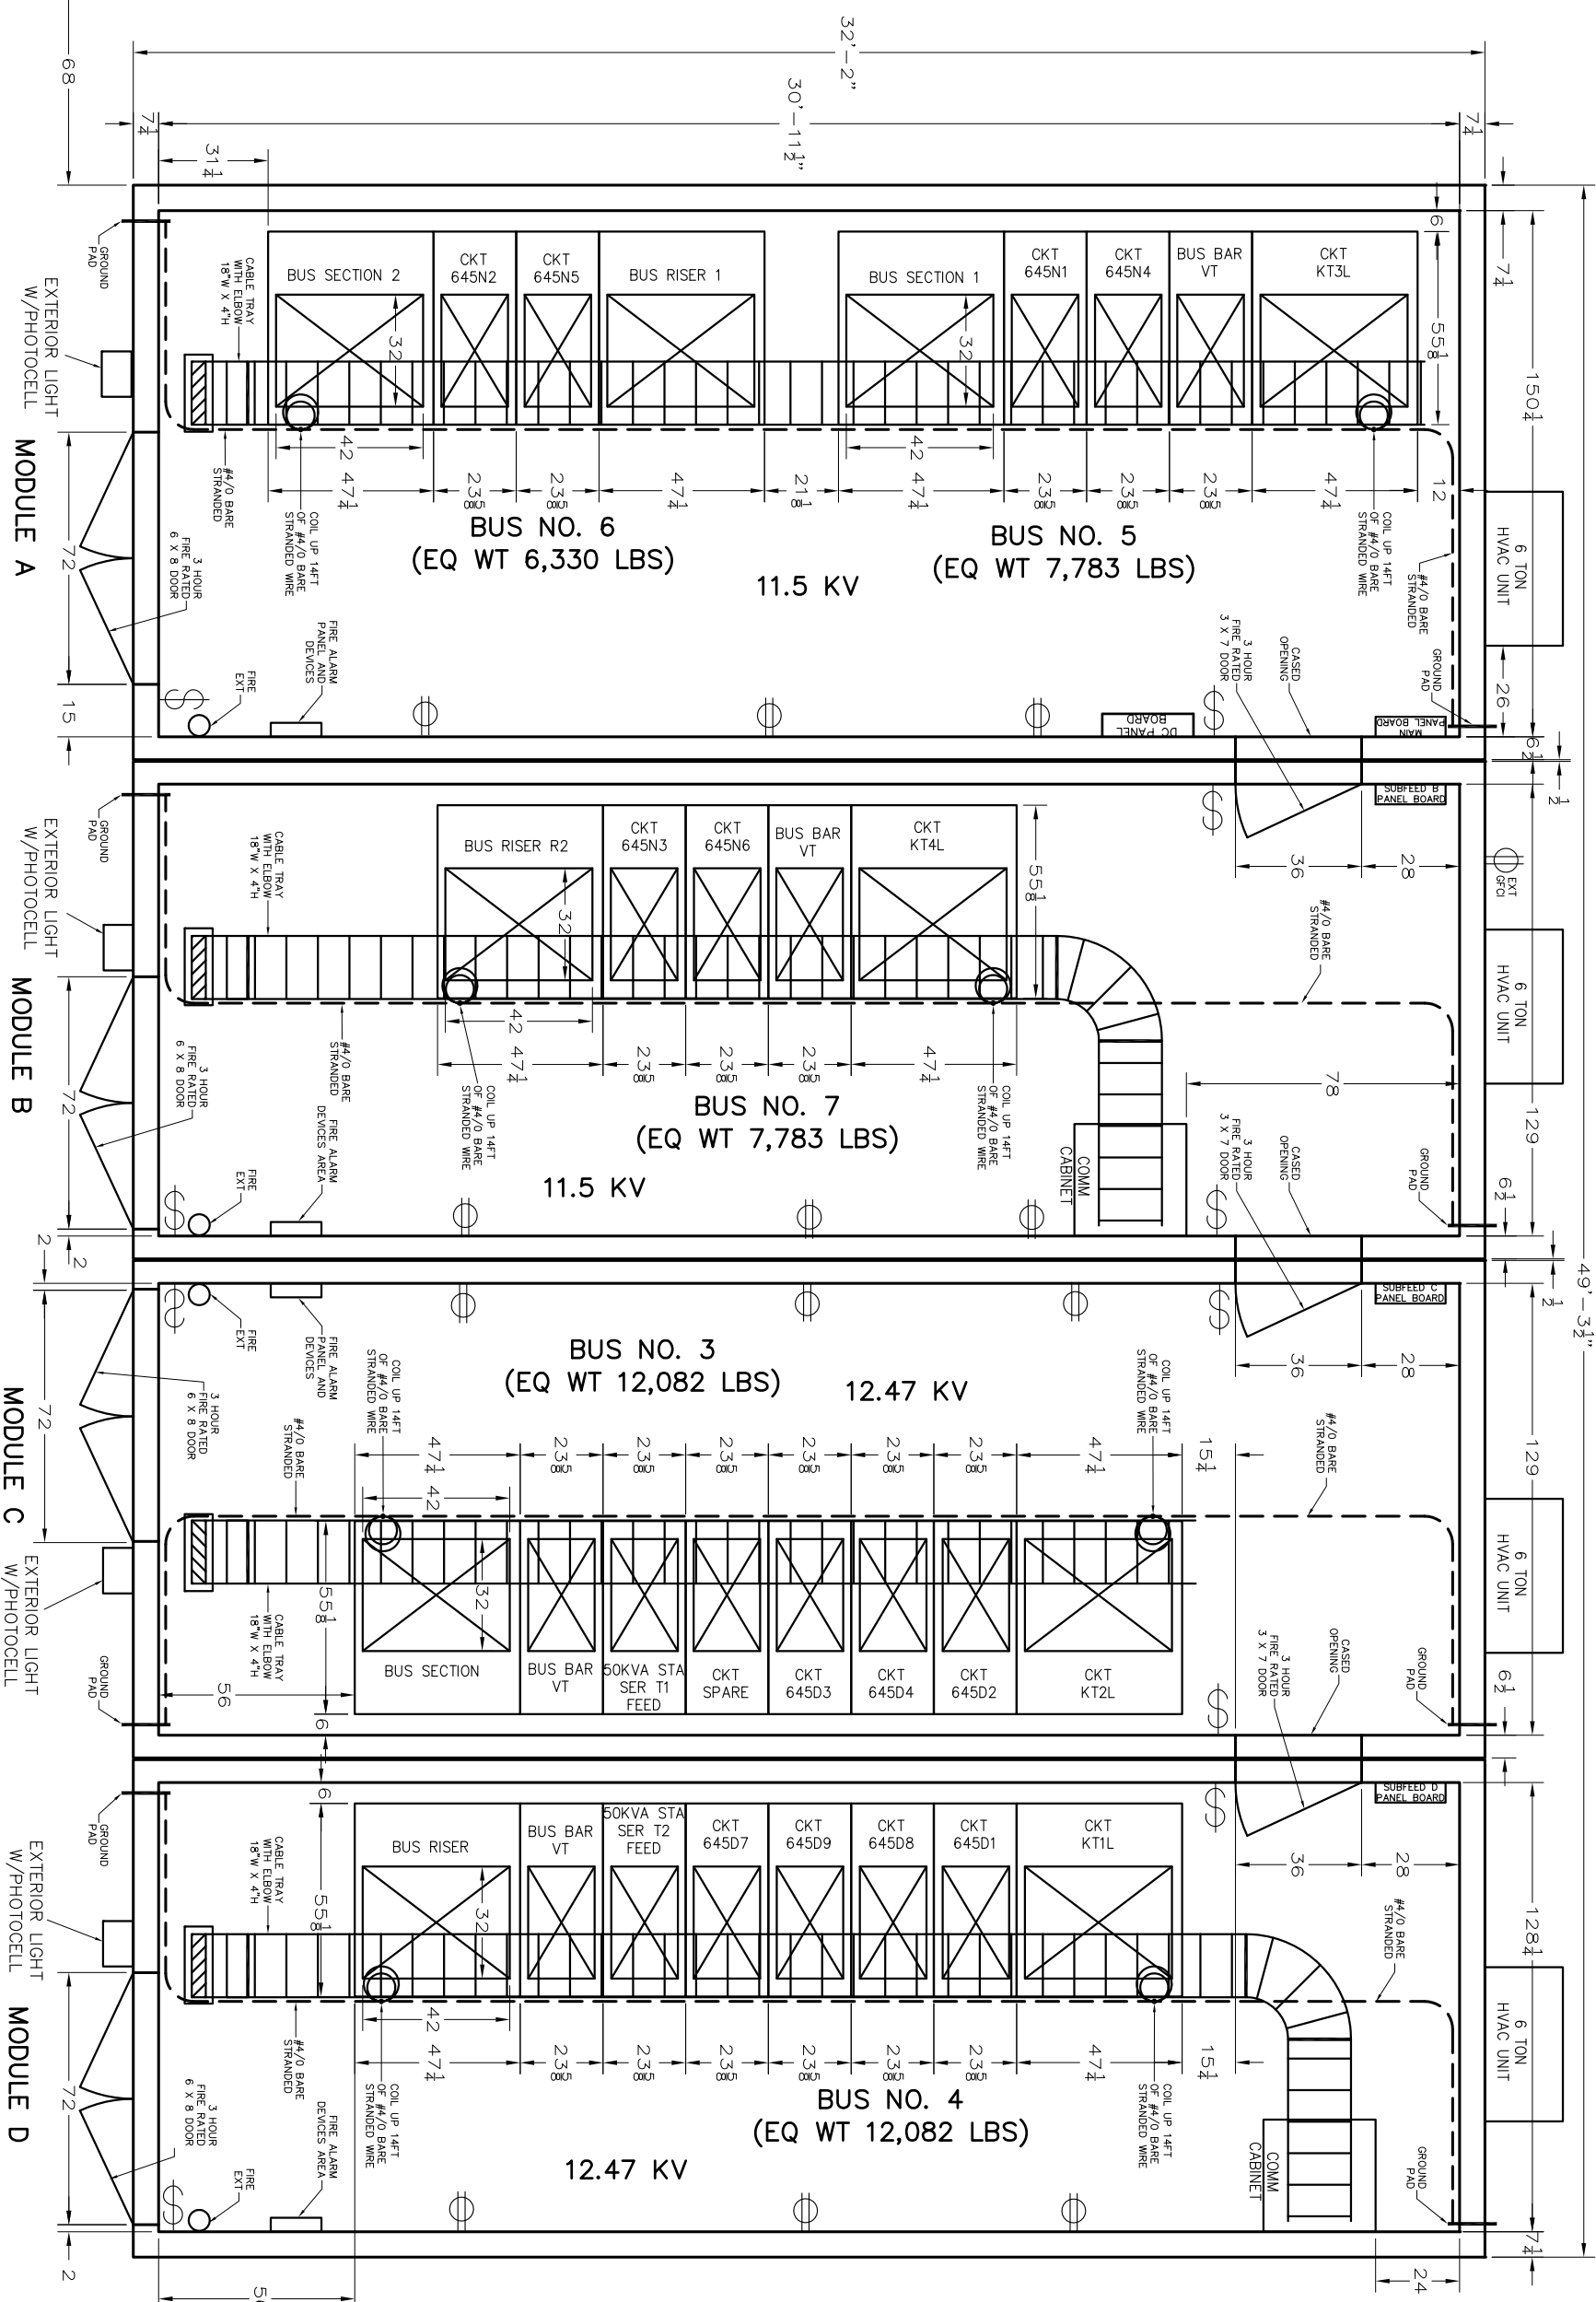

DRIVEWAY
 SITE: UNION STREET PORTLAND, ME
 MASTER FLOOR PLAN
 FLOOR LOAD - 250 PSF
 ROOF LOAD - 100 PSF

REV NO.	DESCRIPTION	DATE	BY
R3	REUSED EXTERIOR LIGHT.	7-9-13	RAP
MODULAR CONNECTIONS, LLC 1000 Industrial Blvd Bessmer, AL 35022 Phone: 205-980-4565 Fax: 205-980-3355 Email: info@modularconnections.com			
TITLE: SCHNEIDER ELECTRIC USA, INC 32'2" WOOD X 49'-5" LOD X 9'8" HD SHELTER FLOOR PLAN		SCALE: NA	PROJ MGR: CLP
DRAWING NO.: D12021 R3		SHEET: 00	

NOTICE: These drawings and specifications are the property of Modular Connections, LLC. All information contained herein which is not known generally in the field of Modular Connections, LLC shall be confidential except to only extent to which it is established to have been known previously from sources other than the drawings. No part of these drawings shall be reproduced, stored in a retrieval system, or used as the basis for the manufacture or sale of apparatus without written permission.