




CADD Drawing, DO NOT REVISE MANUALLY.

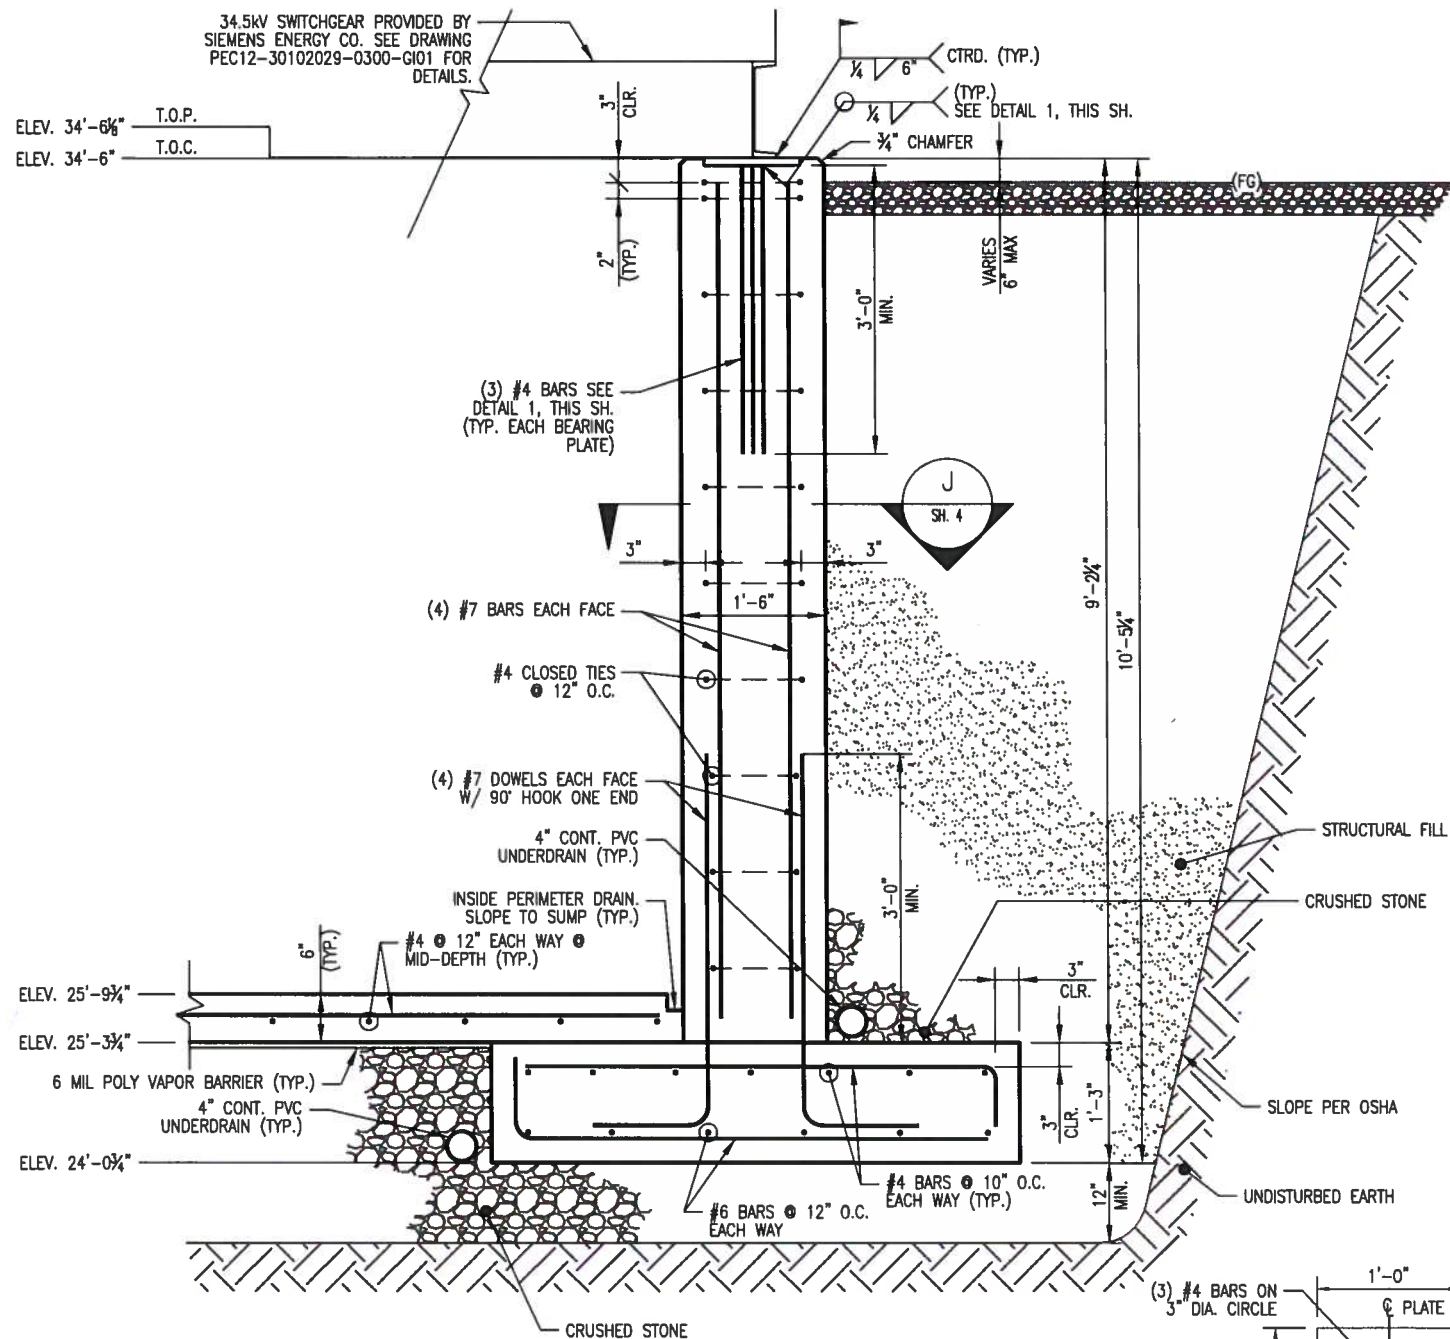

B SECTION B
547-3-8 SH.1
SCALE: 1/2"=1'-0"

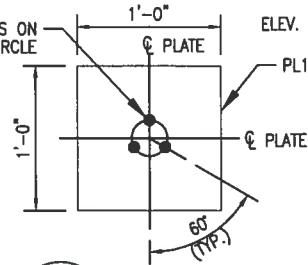

1 DETAIL 1
547-3-8 SH.1
SCALE: 3/4"=1'-0"

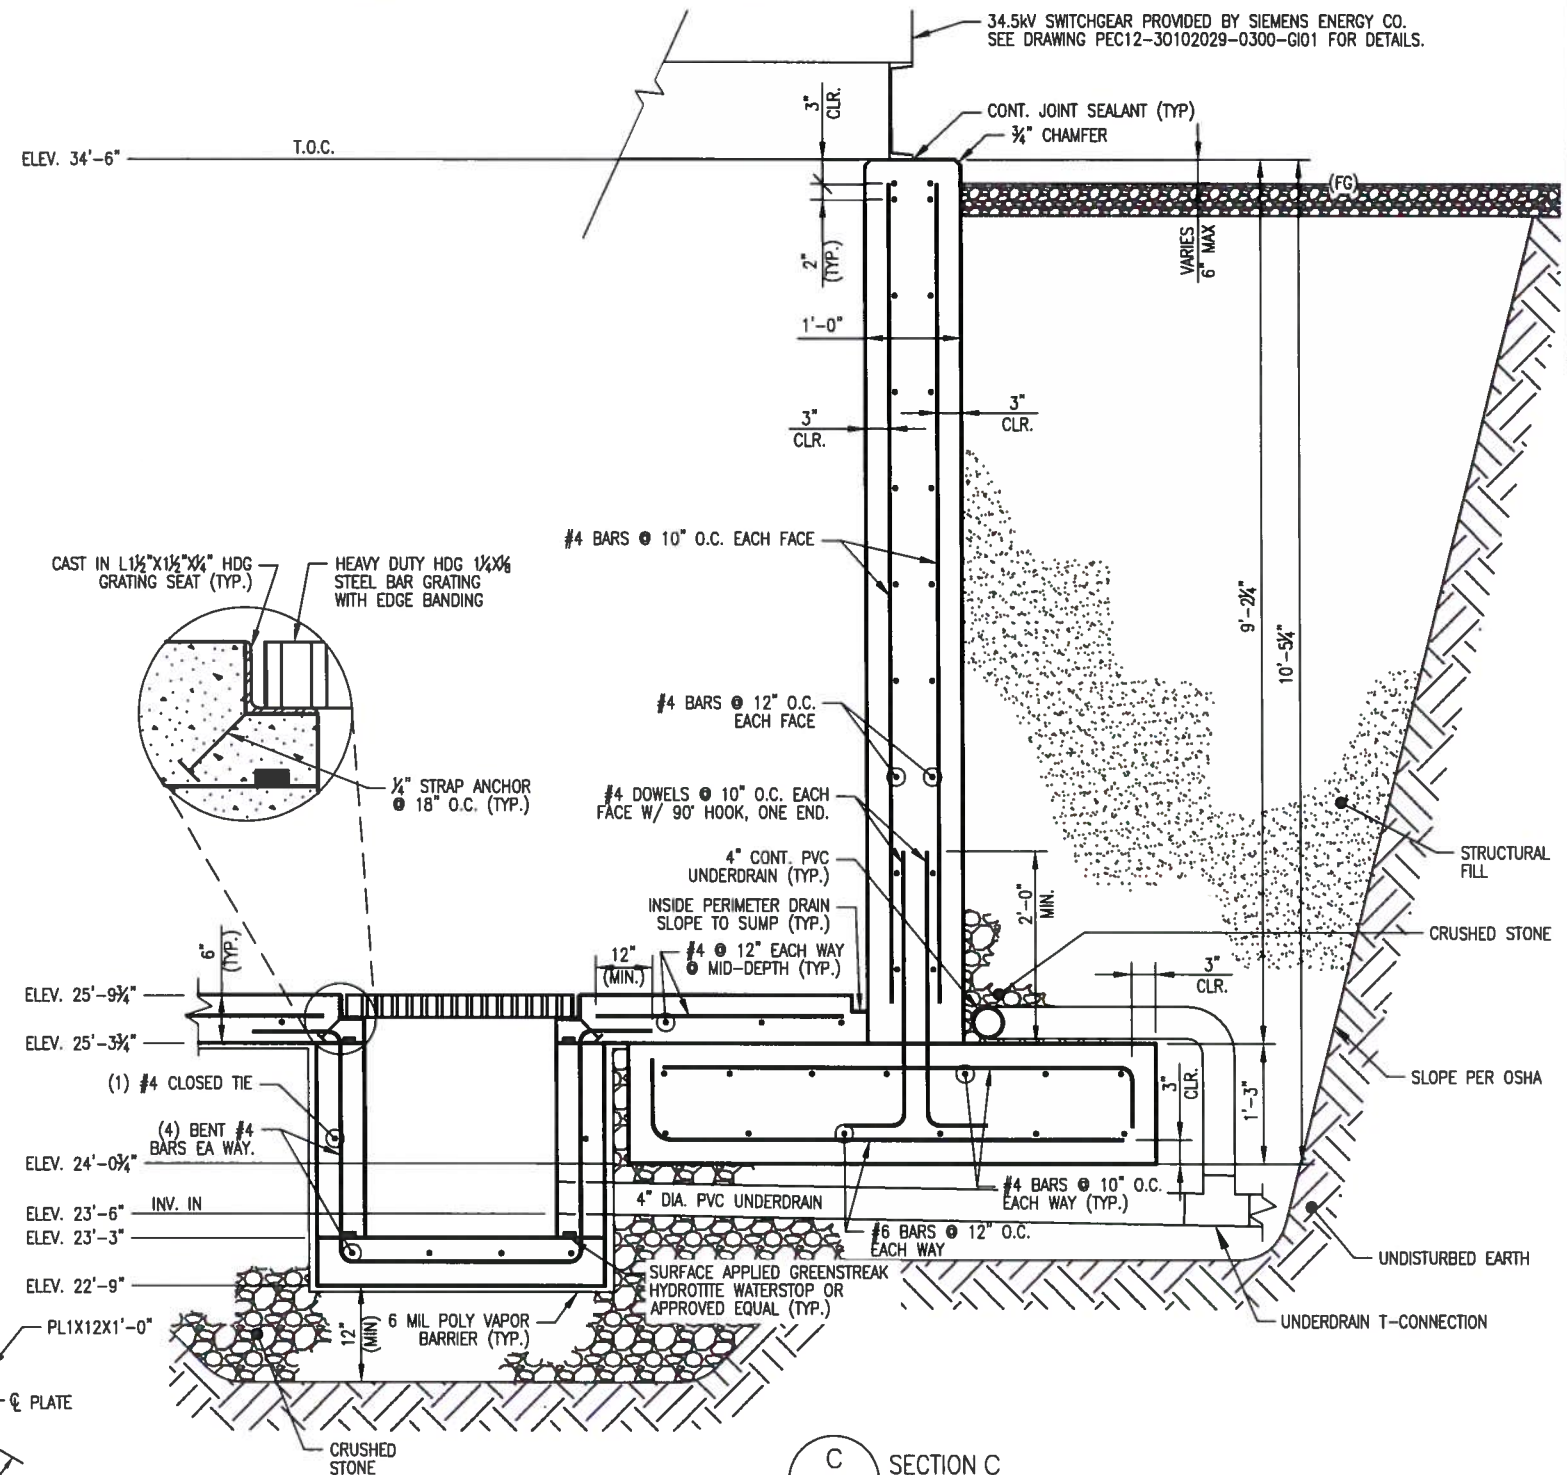


C SECTION C
547-3-8 SH.1
SCALE: 1/2"=1'-0"

- NOTES:**
- SEE DRAWING 547-3-8 SH. 1 FOR CONCRETE NOTES AND DESIGN DATA.
 - SEE DRAWING 547-3-8 SH. 3 FOR LEGEND OF ABBREVIATIONS.

TRC 249 WESTERN AVENUE
AUGUSTA, ME 04330
PROJECT NO: 183112

REFERENCE DRAWING NUMBER	DESCRIPTION
547-40	FOUNDATION PLAN & SECTIONS
547-6-3	CONDUIT PLAN
547-3-5	FOUNDATION PLAN

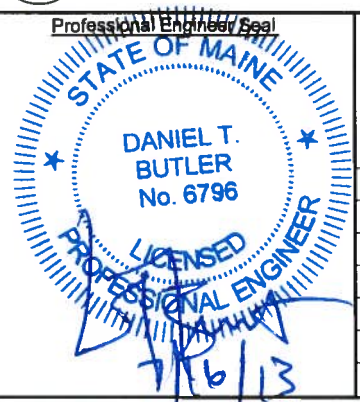

CENTRAL MAINE POWER CO.
IBERDROLA USA

IUSA ENGINEERING
CONFIDENTIAL, PROPRIETARY
and TRADE SECRET INFORMATION
Property of Iberdrola, USA

FOUNDATION DETAIL
34.5KV SWITCHGEAR FOUNDATION
UNION STREET SUBSTATION

REV.	DATE	BY	DESCRIPTION
0	07/16/13	TRC	IFC ISSUE FOR CONST 2013

DR.	TRC/SGL	FILE:	547-3-8 SH.2.DWG	REV.
CK.	TRC/RAY	NO.	547-3-8 SH.2	
APP.	CMP/PN	DATE:	5/14/12	SCALE: AS NOTED
APP.	DATE:	5/14/12	SCALE: AS NOTED	0