


CADD Drawing, DO NOT REVISE MANUALLY.

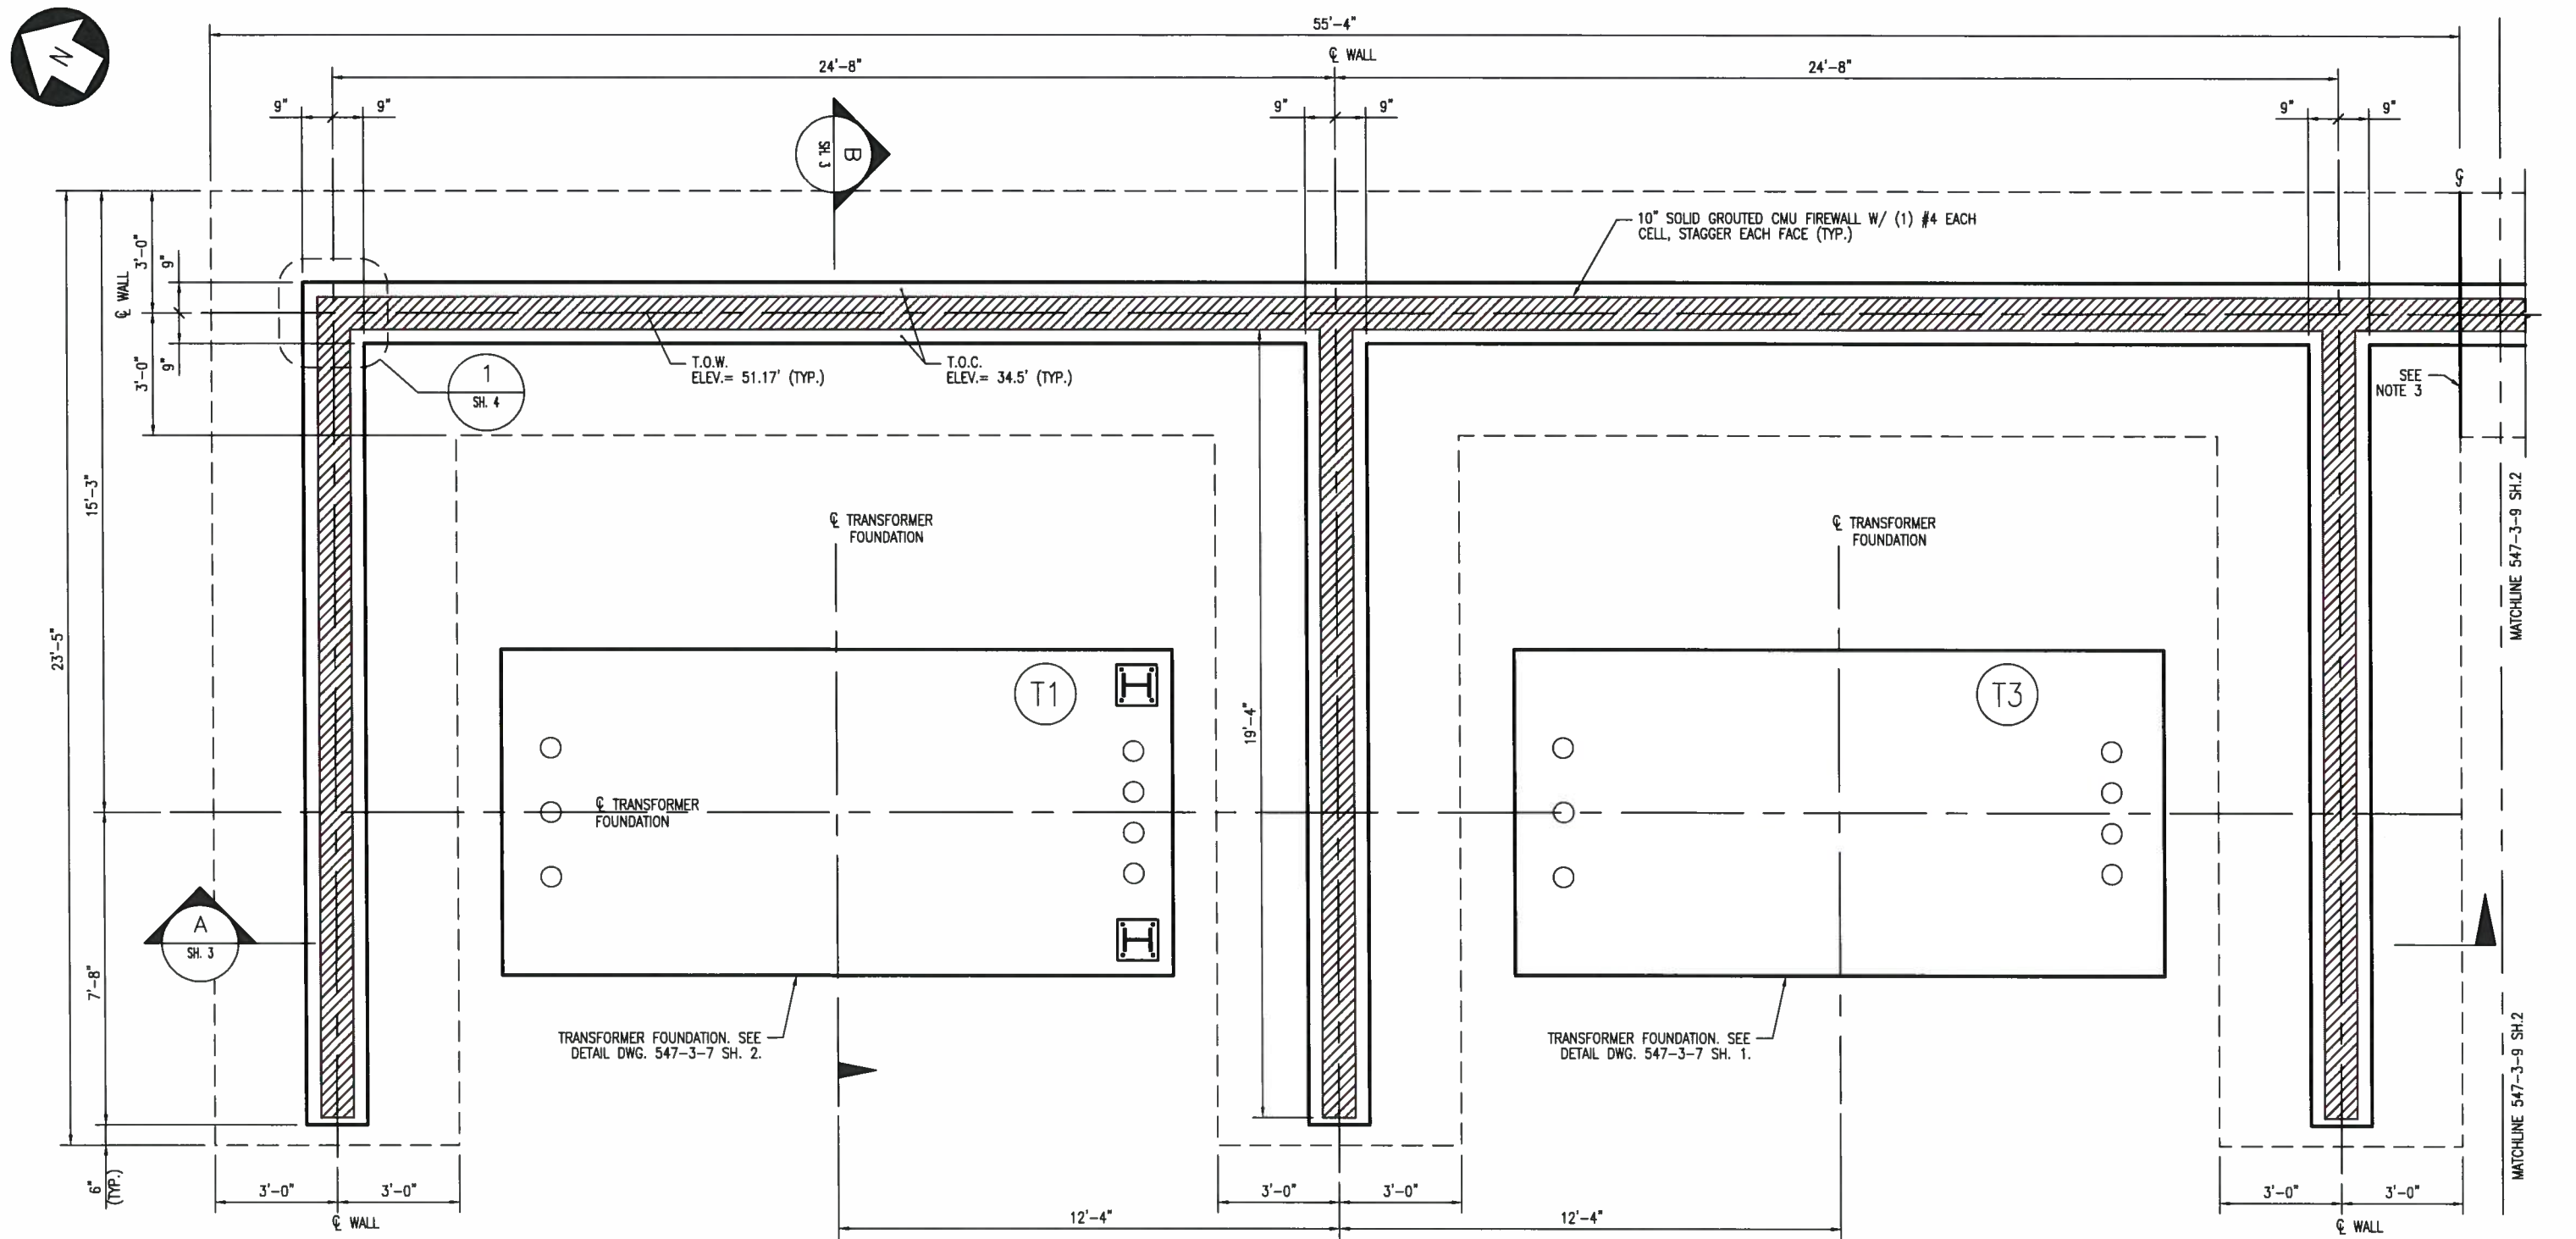

FIREWALL FOUNDATION PLAN
SCALE: 1/4" = 1'-0"

- NOTES:
- SEE DRAWING 547-3-9 SH. 3 FOR MATERIAL NOTES.
 - SEE DRAWING 547-3-9 SH. 4 FOR DESIGN DATA.
 - FIREWALL & FOUNDATION SHALL BE BUILT IN ACCORDANCE WITH APPROVED CONSTRUCTION SEQUENCE.

249 WESTERN AVENUE AUGUSTA, ME 04330 PROJECT NO: 183112	
REFERENCE DRAWING NUMBER	DESCRIPTION
547-6-3	CONDUIT PLAN
547-3-7	TRANSFORMER FOUNDATION DETAIL
547-3-5	FOUNDATION PLAN

Professional Engineer/SEA

CENTRAL MAINE POWER CO.
IBERDROLA USA

IUSA ENGINEERING
CONFIDENTIAL, PROPRIETARY
and TRADE SECRET INFORMATION
Property of Iberdrola, USA

0	07/16/13	TRC	IFC ISSUE FOR CONST 2013
REV.	DATE	BY	DESCRIPTION

FOUNDATION DETAIL
FIREWALL
UNION STREET SUBSTATION

DR. TRC/SGL	FILE: 547-3-9 SH.1.DWG	REV. 0
CK. TRC/RAY	NO. 547-3-9 SH.1	
DTB	APP. CMP/PN	SCALE: AS NOTED
APP. DATE: 5/14/12		