


CADD Drawing, DO NOT REVISE MANUALLY.

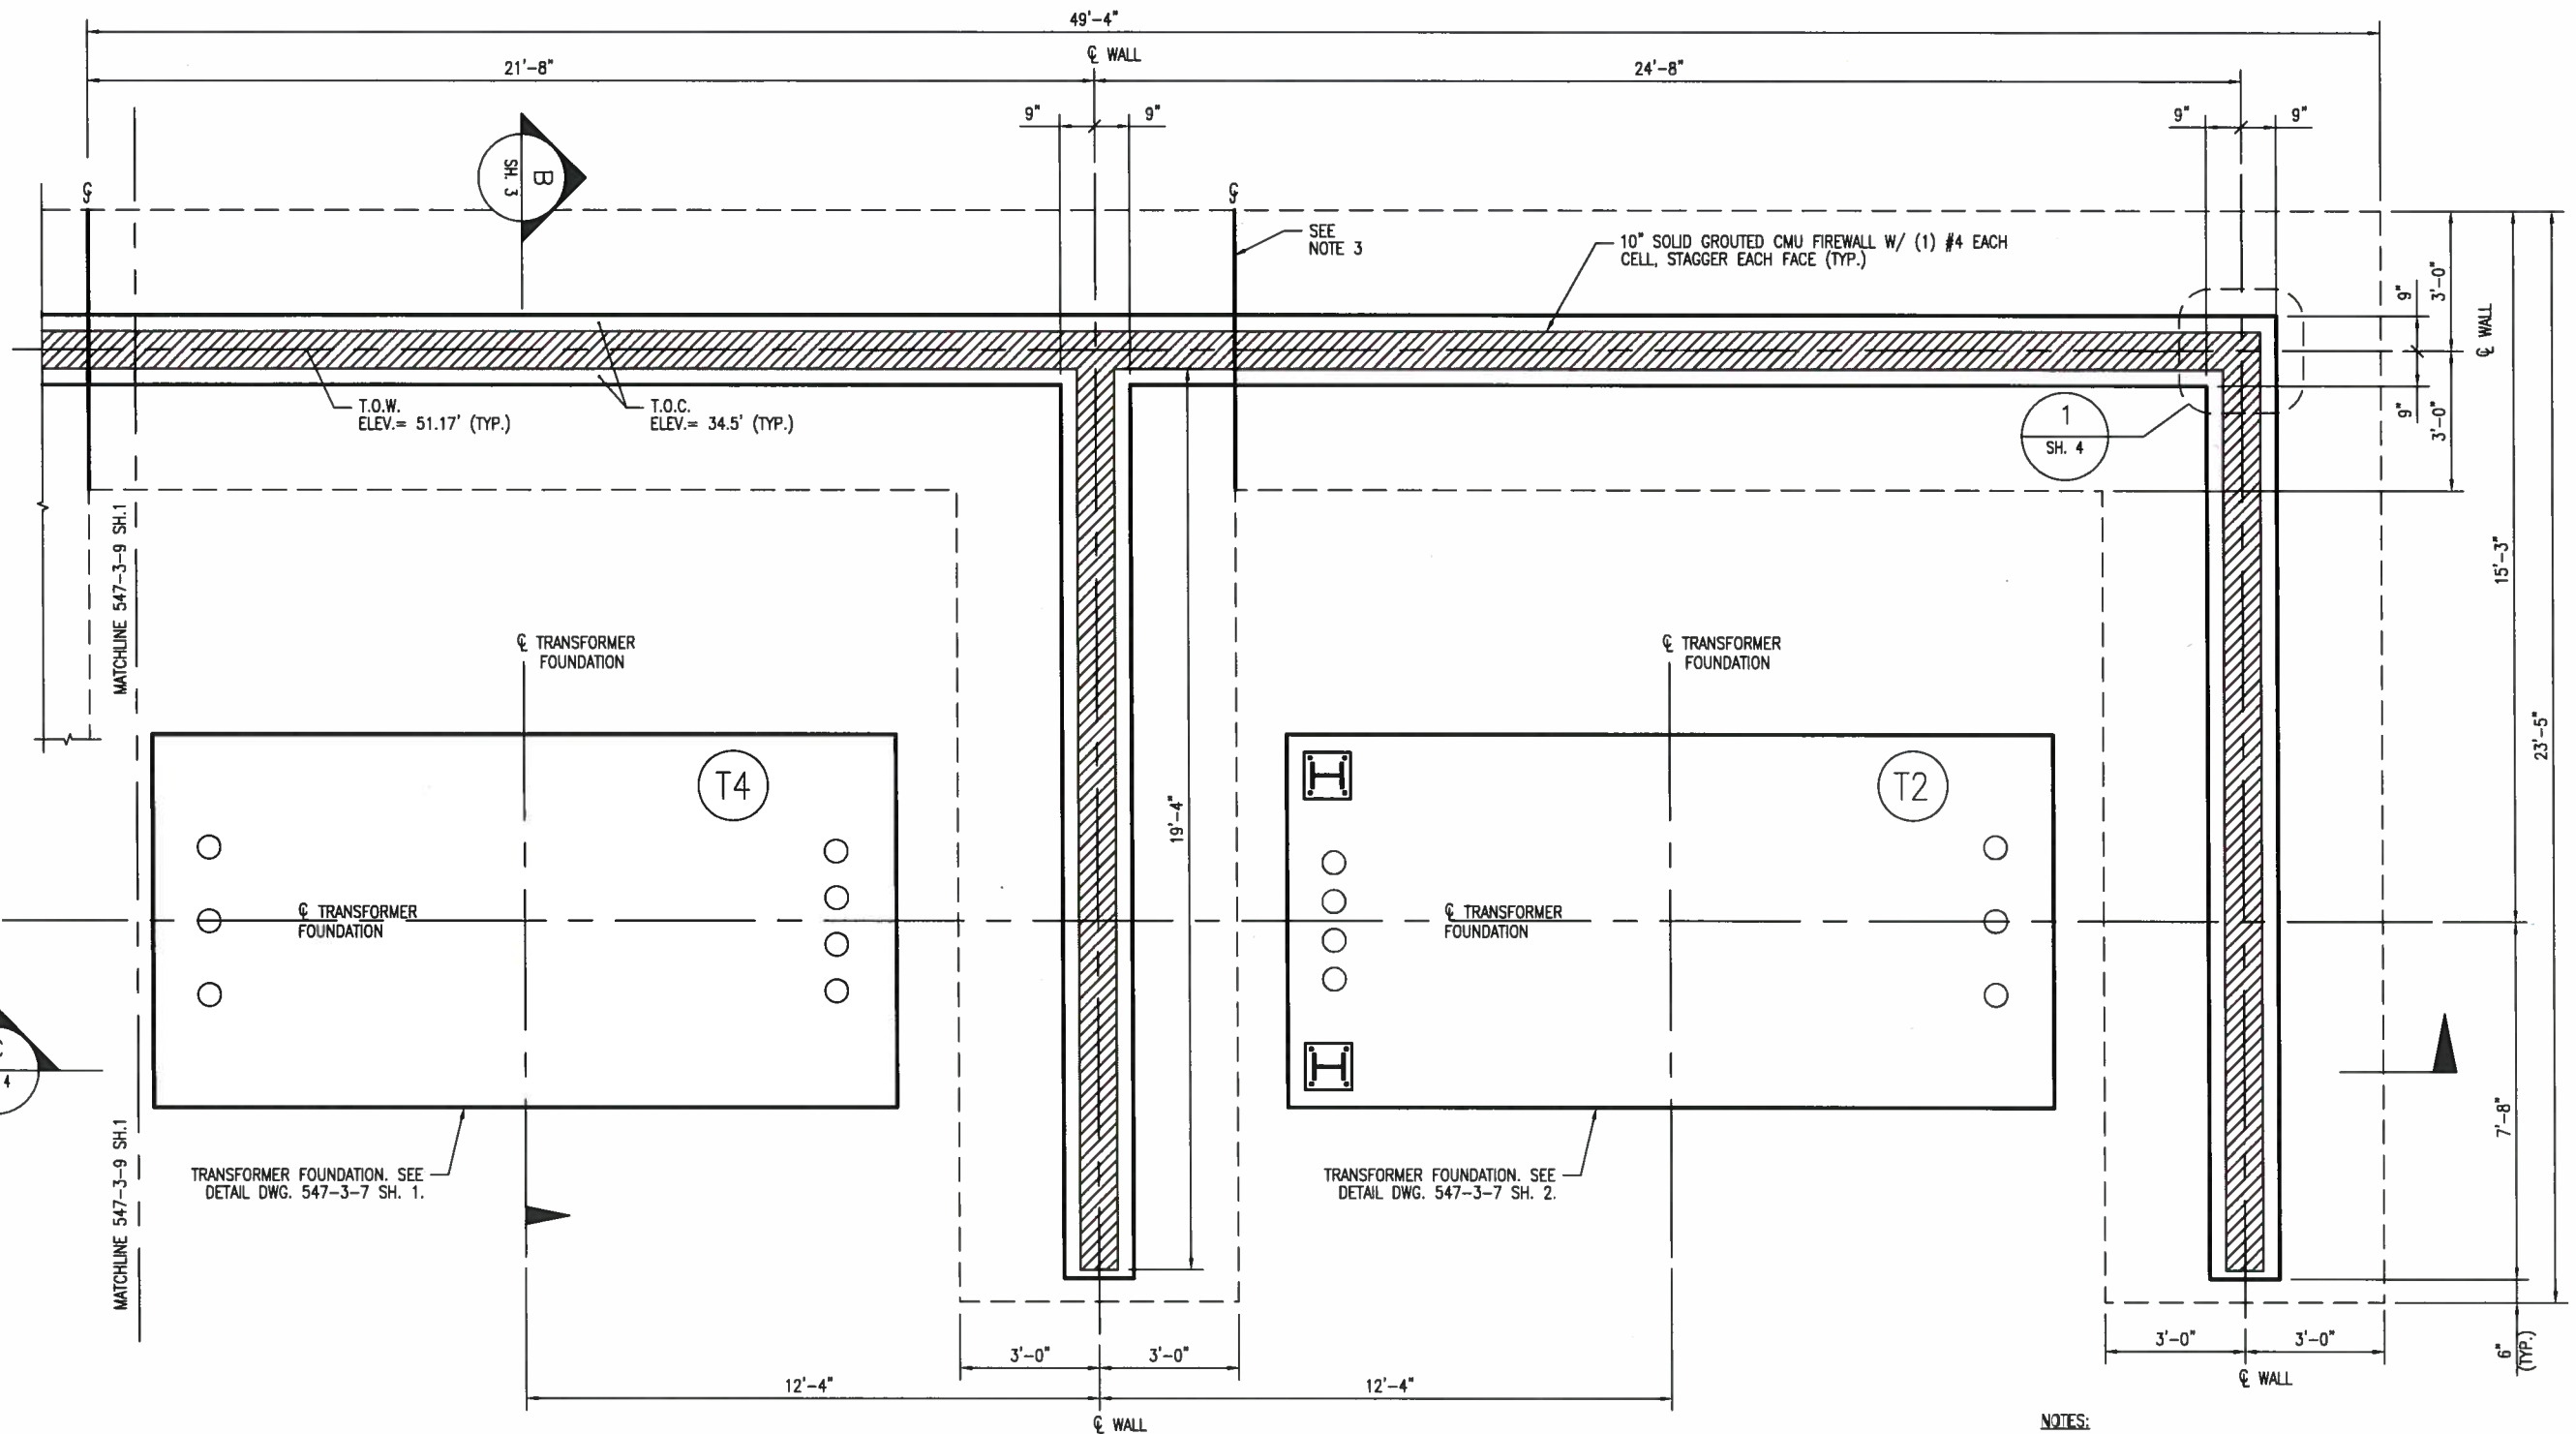

FIREWALL FOUNDATION PLAN  
SCALE: 1/4" = 1'-0"

NOTES:

1. SEE DRAWING 547-3-9 SH. 3 FOR MATERIAL NOTES
2. SEE DRAWING 547-3-9 SH. 4 FOR DESIGN DATA.
3. FIREWALL & FOUNDATION SHALL BE BUILT IN ACCORDANCE WITH APPROVED CONSTRUCTION SEQUENCE.



249 WESTERN AVENUE  
AUGUSTA, ME 04330  
PROJECT NO: 183112

REFERENCE DRAWING NUMBER	DESCRIPTION
547-6-3	CONDUIT PLAN
547-3-7	TRANSFORMER FOUNDATION DETAIL
547-3-5	FOUNDATION PLAN

Professional Engineer Seal



**CENTRAL MAINE POWER CO.**  
**IBERDROLA USA**

**IUSA ENGINEERING**  
**CONFIDENTIAL, PROPRIETARY**  
**and TRADE SECRET INFORMATION**  
Property of Iberdrola, USA

**FOUNDATION DETAIL**  
**FIREWALL**  
**UNION STREET SUBSTATION**

REV.	DATE	BY	DESCRIPTION
0	07/16/13	TRC	IFC ISSUE FOR CONST 2013

DR. TRC/SGL	FILE: 547-3-9 SH.2.DWG	REV. 0
CK. TRC/RAY	NO. 547-3-9 SH.2	
APP. CMP/PN	SCALE: AS NOTED	
APP. DATE: 5/14/12		