



NOTES:
 1. TRANSFORMER PHASING FOR ALL POWER TRANSFORMERS IS X1-03, X2-02, X3-01, H1-03, H2-02, H3-01.

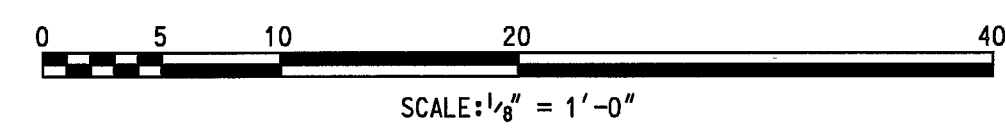

TRC 249 WESTERN AVENUE
 AUGUSTA, ME 04330
 PROJECT NO: 183112

REFERENCE DRAWING NUMBER	DESCRIPTION
547-2-2 SH.1 & 2	GENERAL ARRANGEMENT ELEVATIONS
547-3-5	FOUNDATION PLAN
547-6-1	GROUNDING & FENCE PLAN

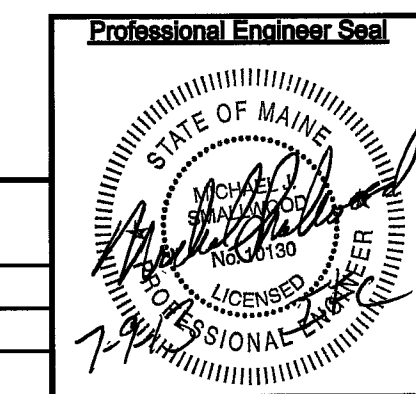

CENTRAL MAINE POWER CO.
IBERDROLA USA

IUSA ENGINEERING
 CONFIDENTIAL, PROPRIETARY
 and TRADE SECRET INFORMATION
 Property of Iberdrola, USA

GENERAL LOCATION PLAN			
UNION ST. S/S	PORTLAND, ME	DR. TRC/MJS	FILE: 547-03-01.DGN
0	07/09/13	TRC	IFC ISSUE FOR CONST 2013
MJS	APP. CMP/ZK	NO.	547-3-1
APP.	DATE: 10/11/11	SCALE:	1/8" = 1'-0"
REV.			0

CADD Drawing. DO NOT REVISE MANUALLY.