



ADDITIONAL INFORMATION SHALL BE PROVIDED IN ADDENDUM

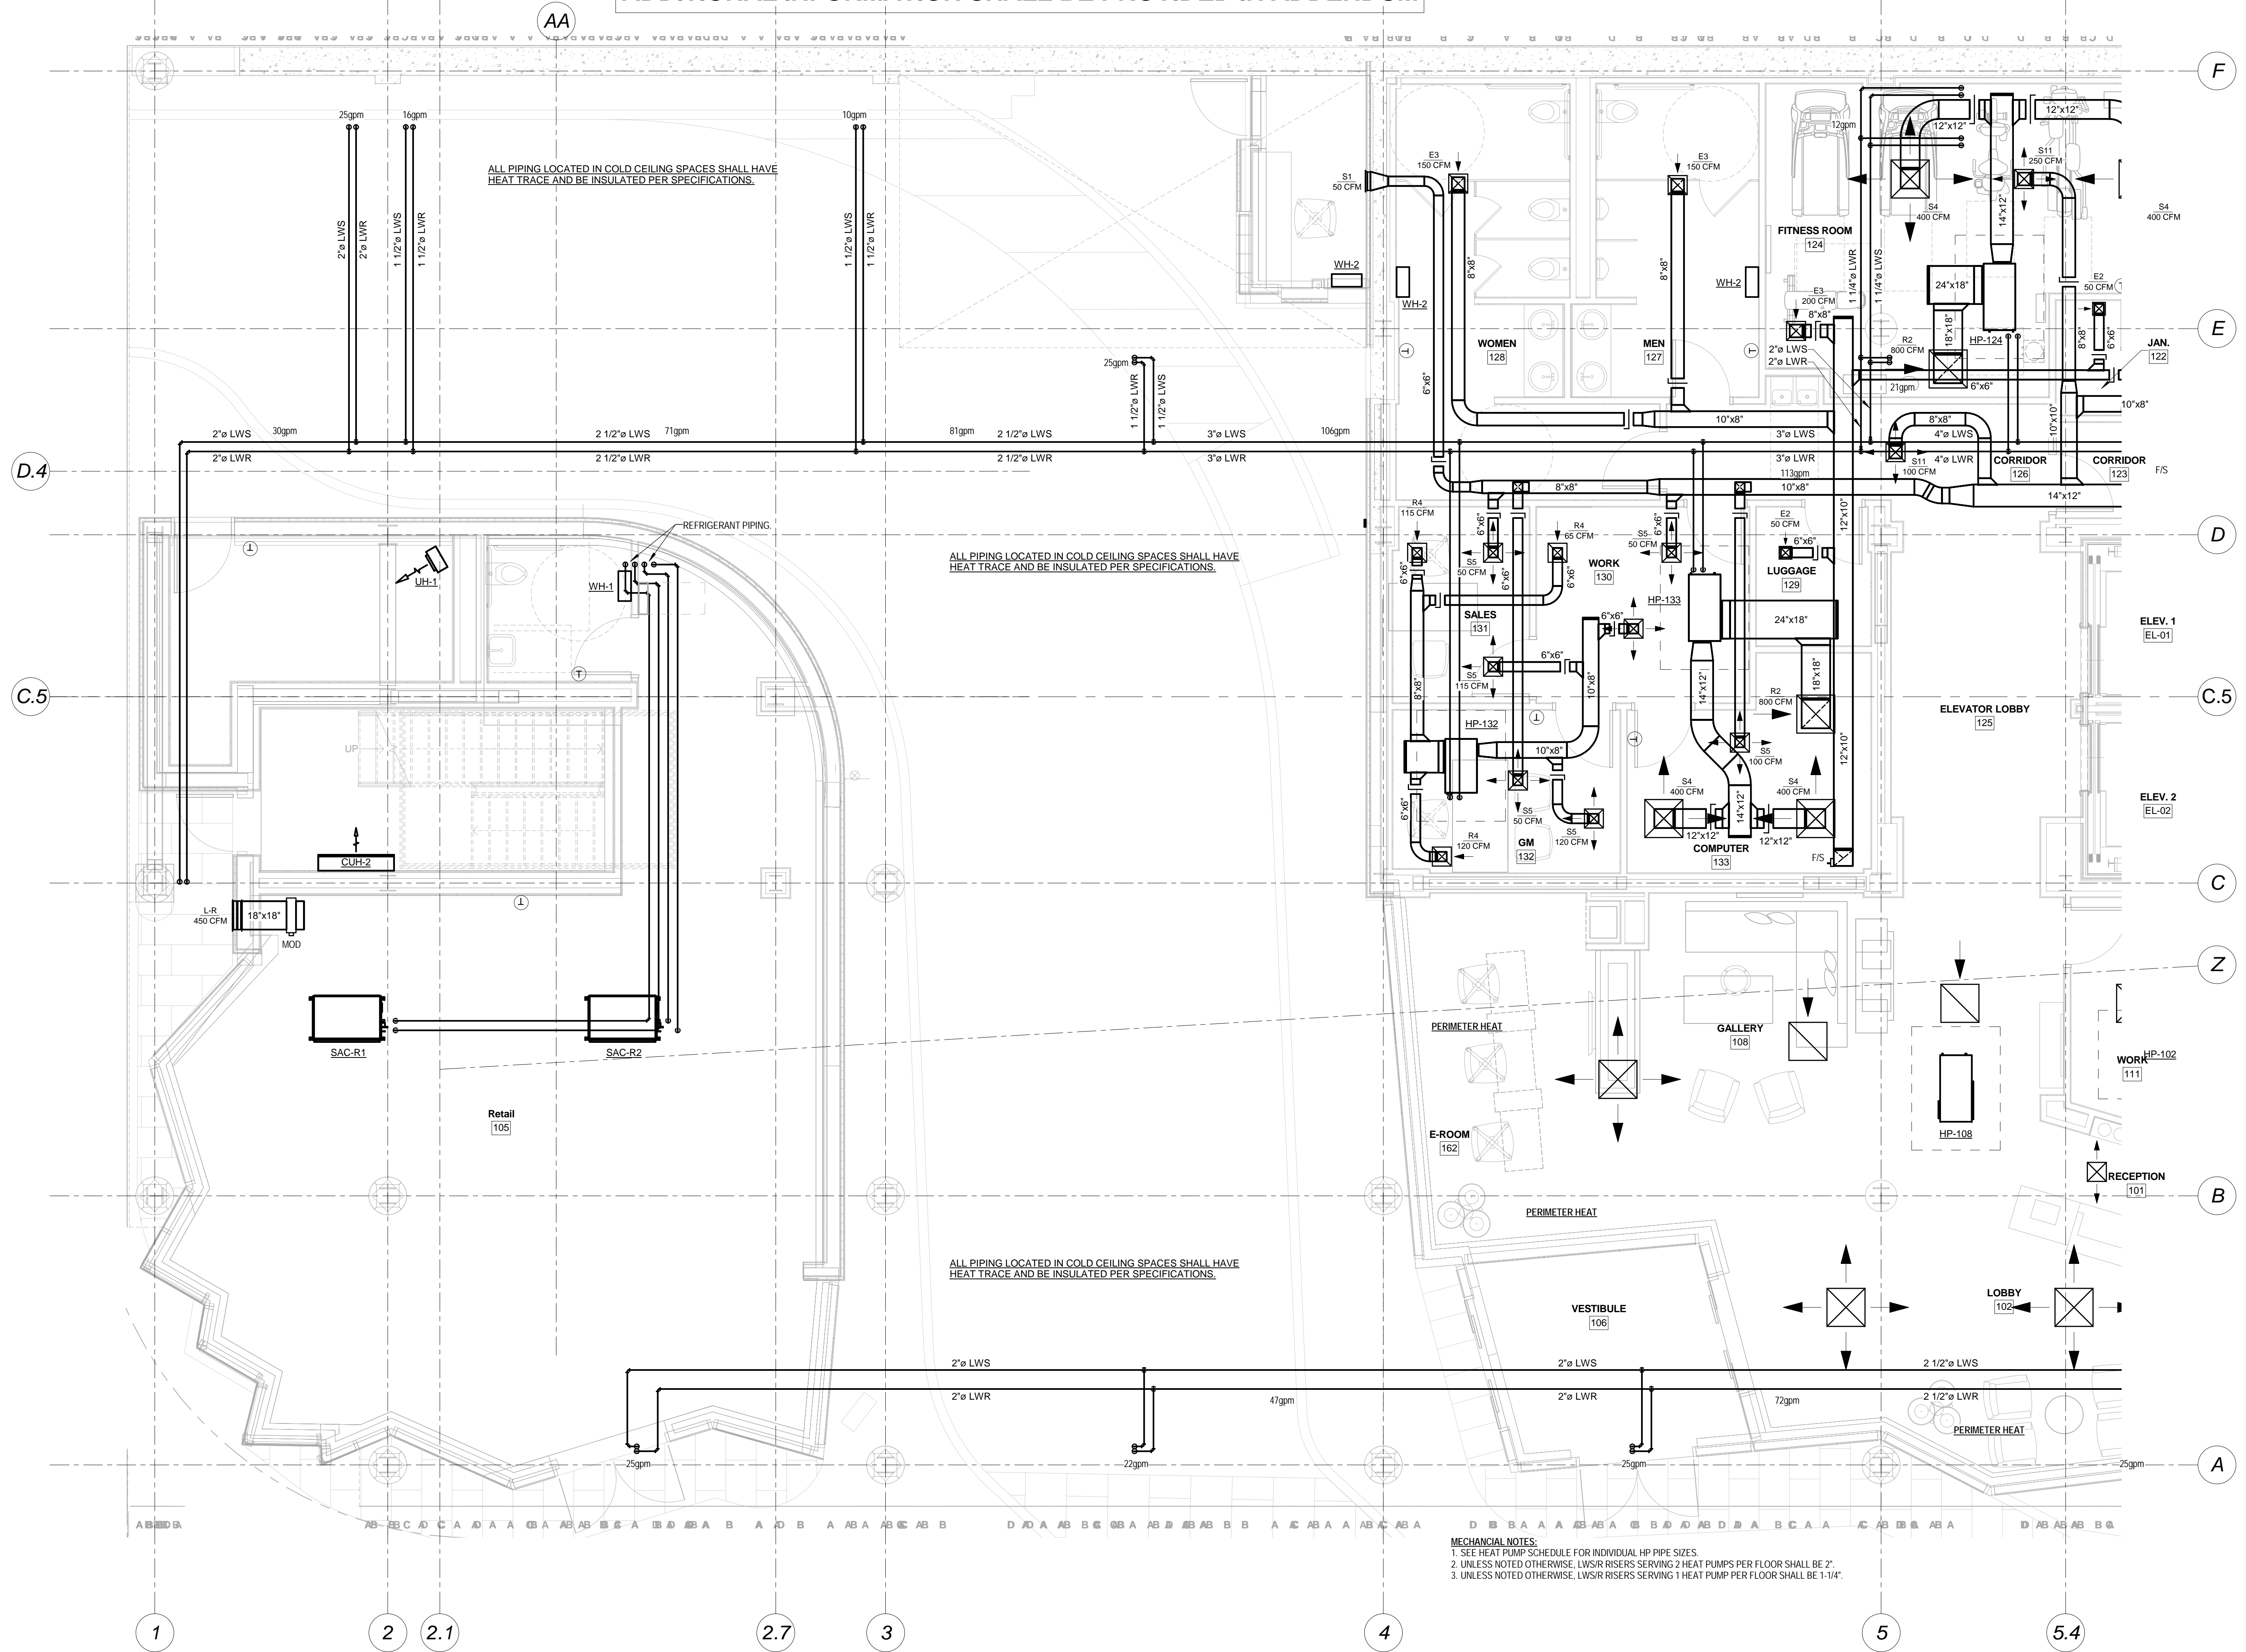

- MECHANICAL NOTES:**
 1. SEE HEAT PUMP SCHEDULE FOR INDIVIDUAL HP PIPE SIZES.
 2. UNLESS NOTED OTHERWISE, LWS/R RISERS SERVING 2 HEAT PUMPS PER FLOOR SHALL BE 2".
 3. UNLESS NOTED OTHERWISE, LWS/R RISERS SERVING 1 HEAT PUMP PER FLOOR SHALL BE 1-1/4".

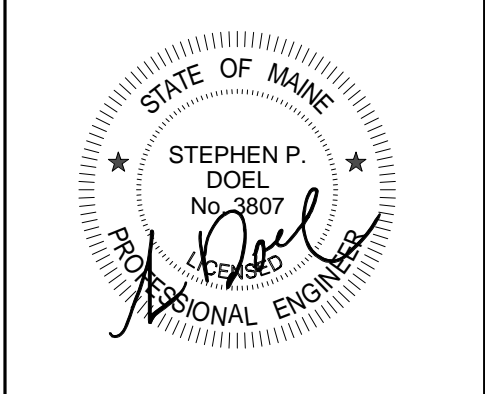

Mark Date Description
 Project Status
**ISSUED FOR
 CONSTRUCTION**
 03-01-2013

Drawing Title
**First Floor HVAC
 Plan - Part A**

Scale: 1/4" = 1'-0"

Drawing Number
M10.1A

1 First Floor HVAC Plan - Part A
 1/4" = 1'-0"