



COOLING TOWER / HEX-1 PIPING SCHEMATIC AND DETAIL
 NTS

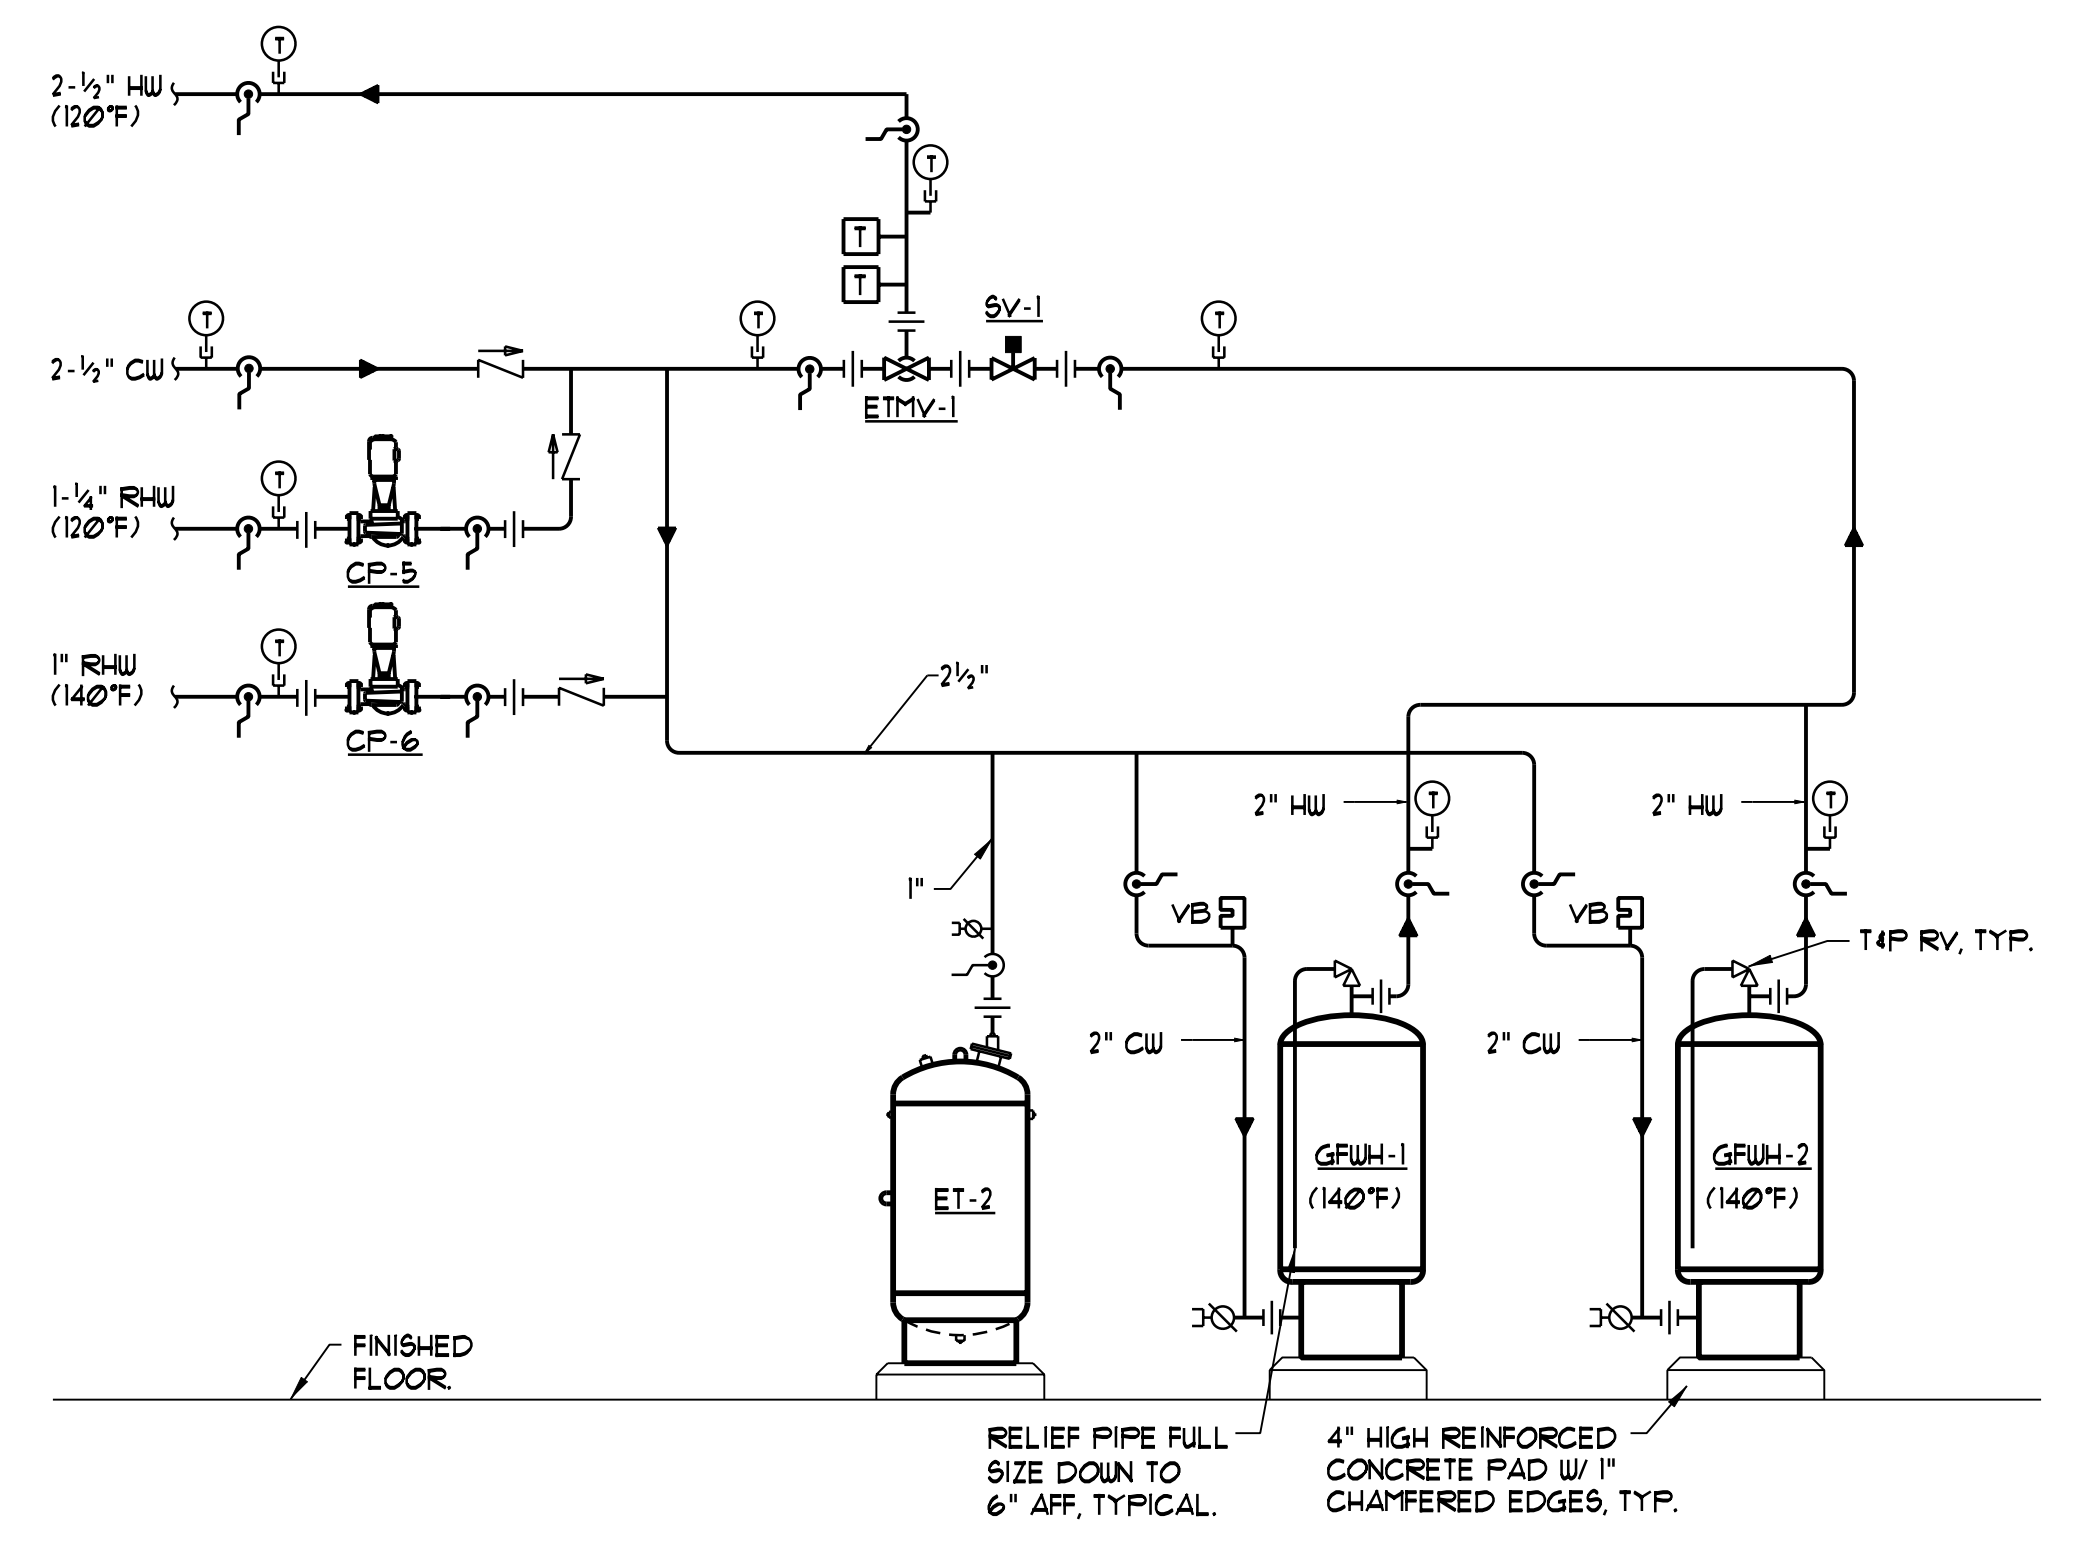

DOMESTIC HOT WATER PIPING SCHEMATIC
 NTS

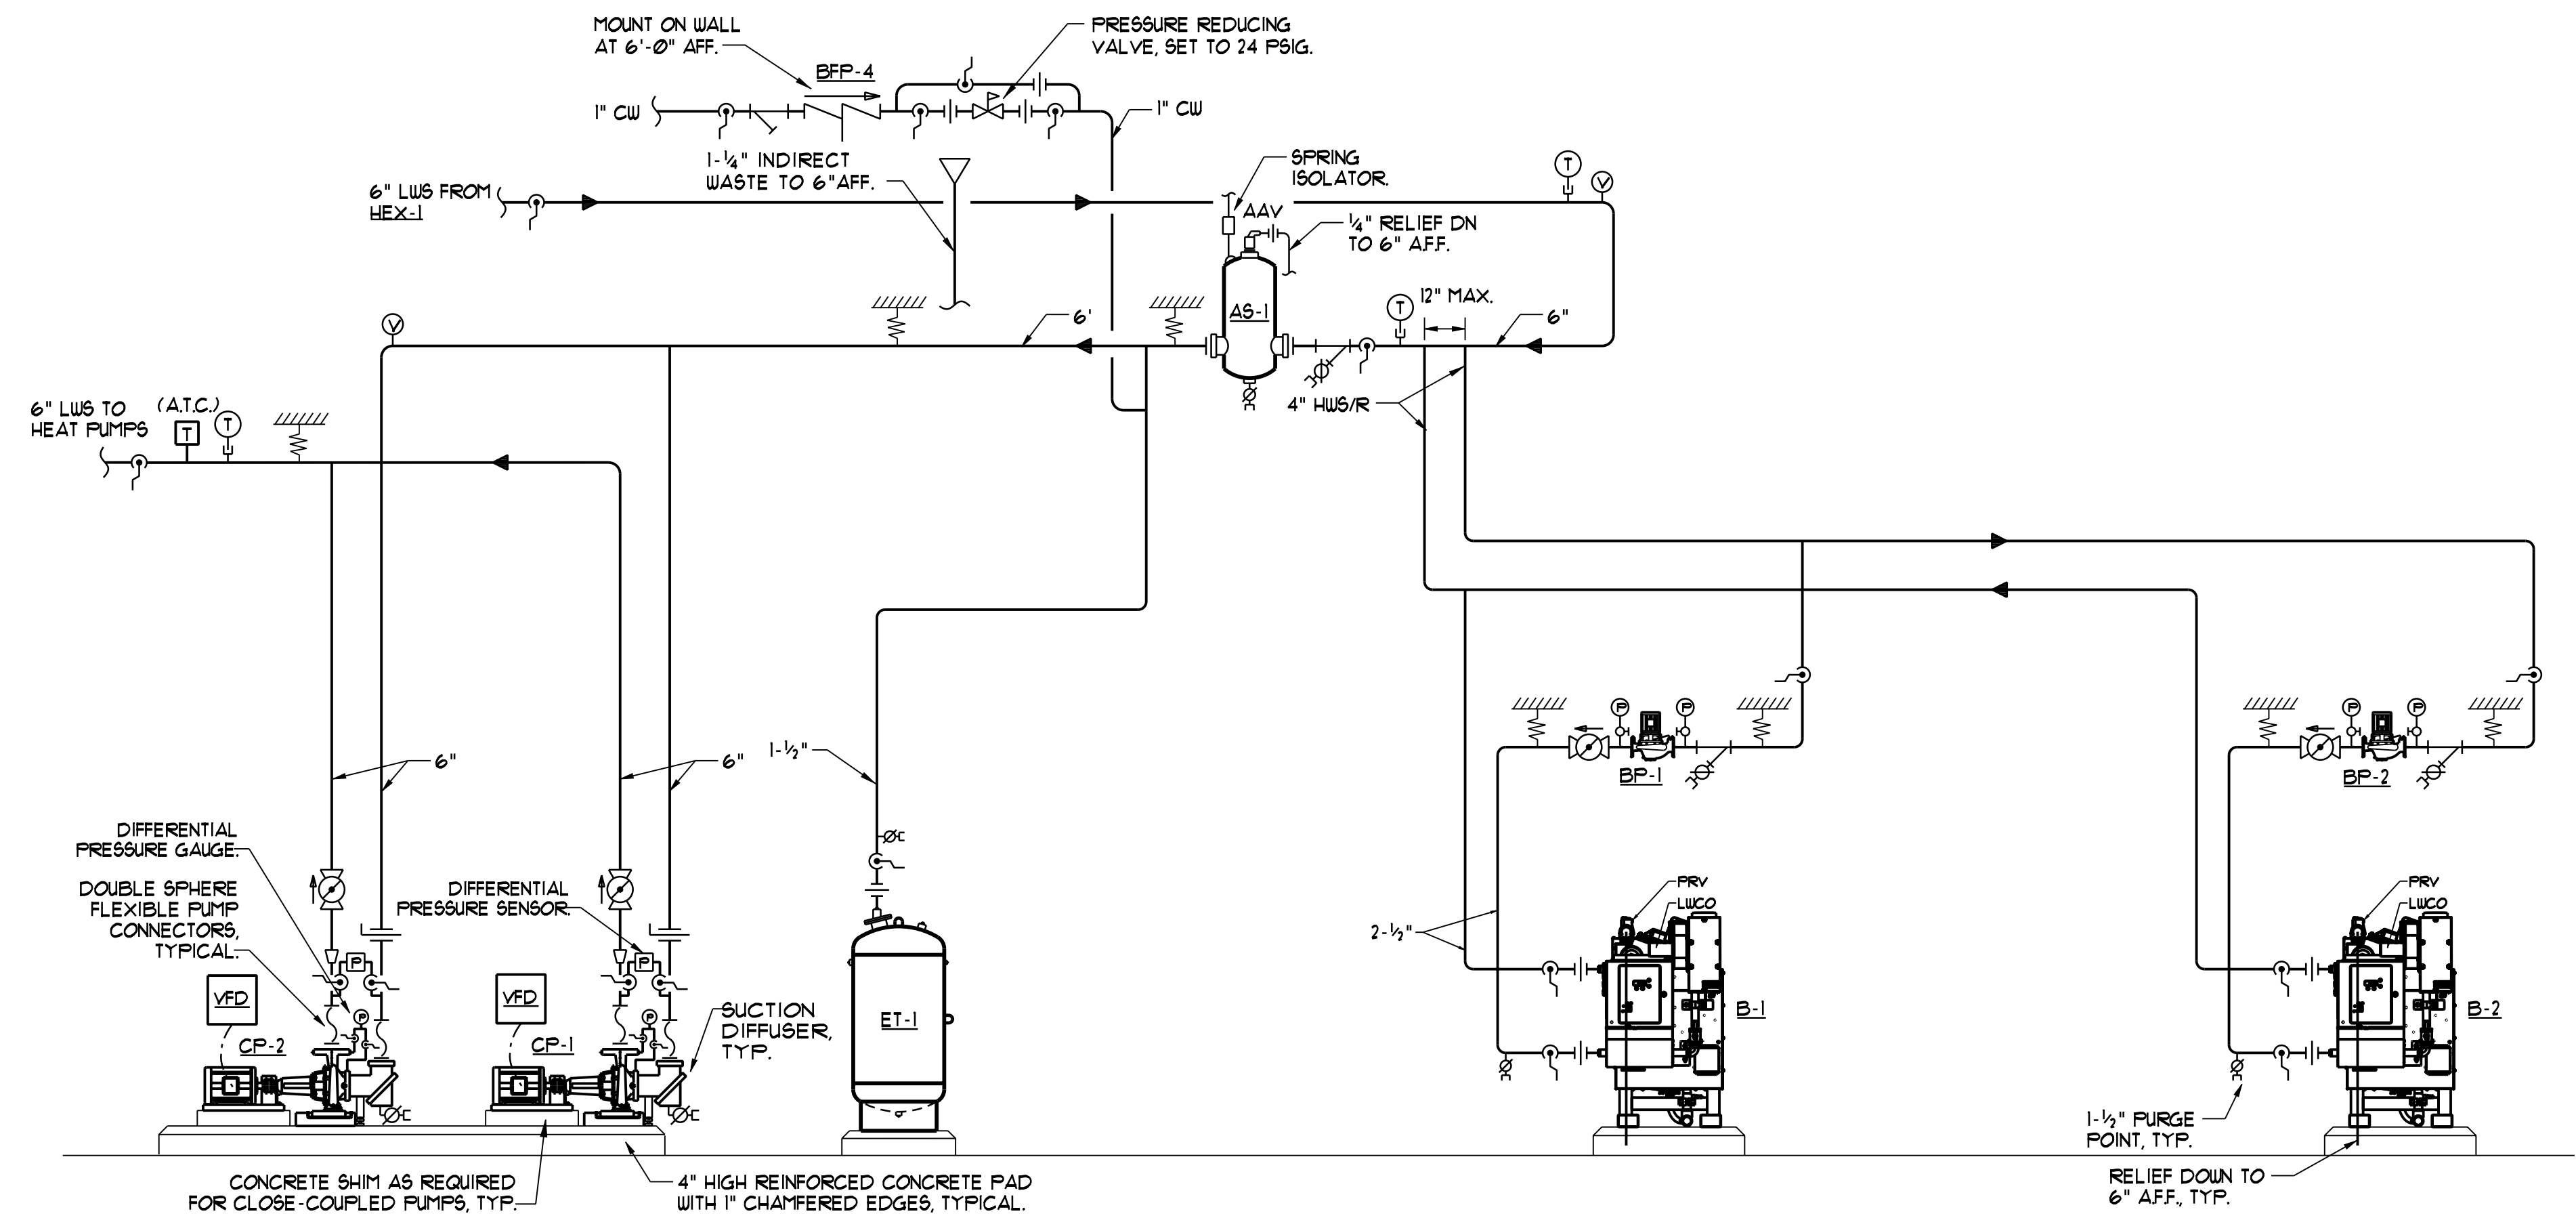

BOILER PIPING SCHEMATIC
 NTS

Mark	Date	Description
Project Status		
ISSUED FOR CONSTRUCTION		
03-01-2013		

Drawing Title
Mechanical Details

Scale:
 Drawing Number

M30.3