



ADDITIONAL INFORMATION SHALL BE PROVIDED IN ADDENDUM

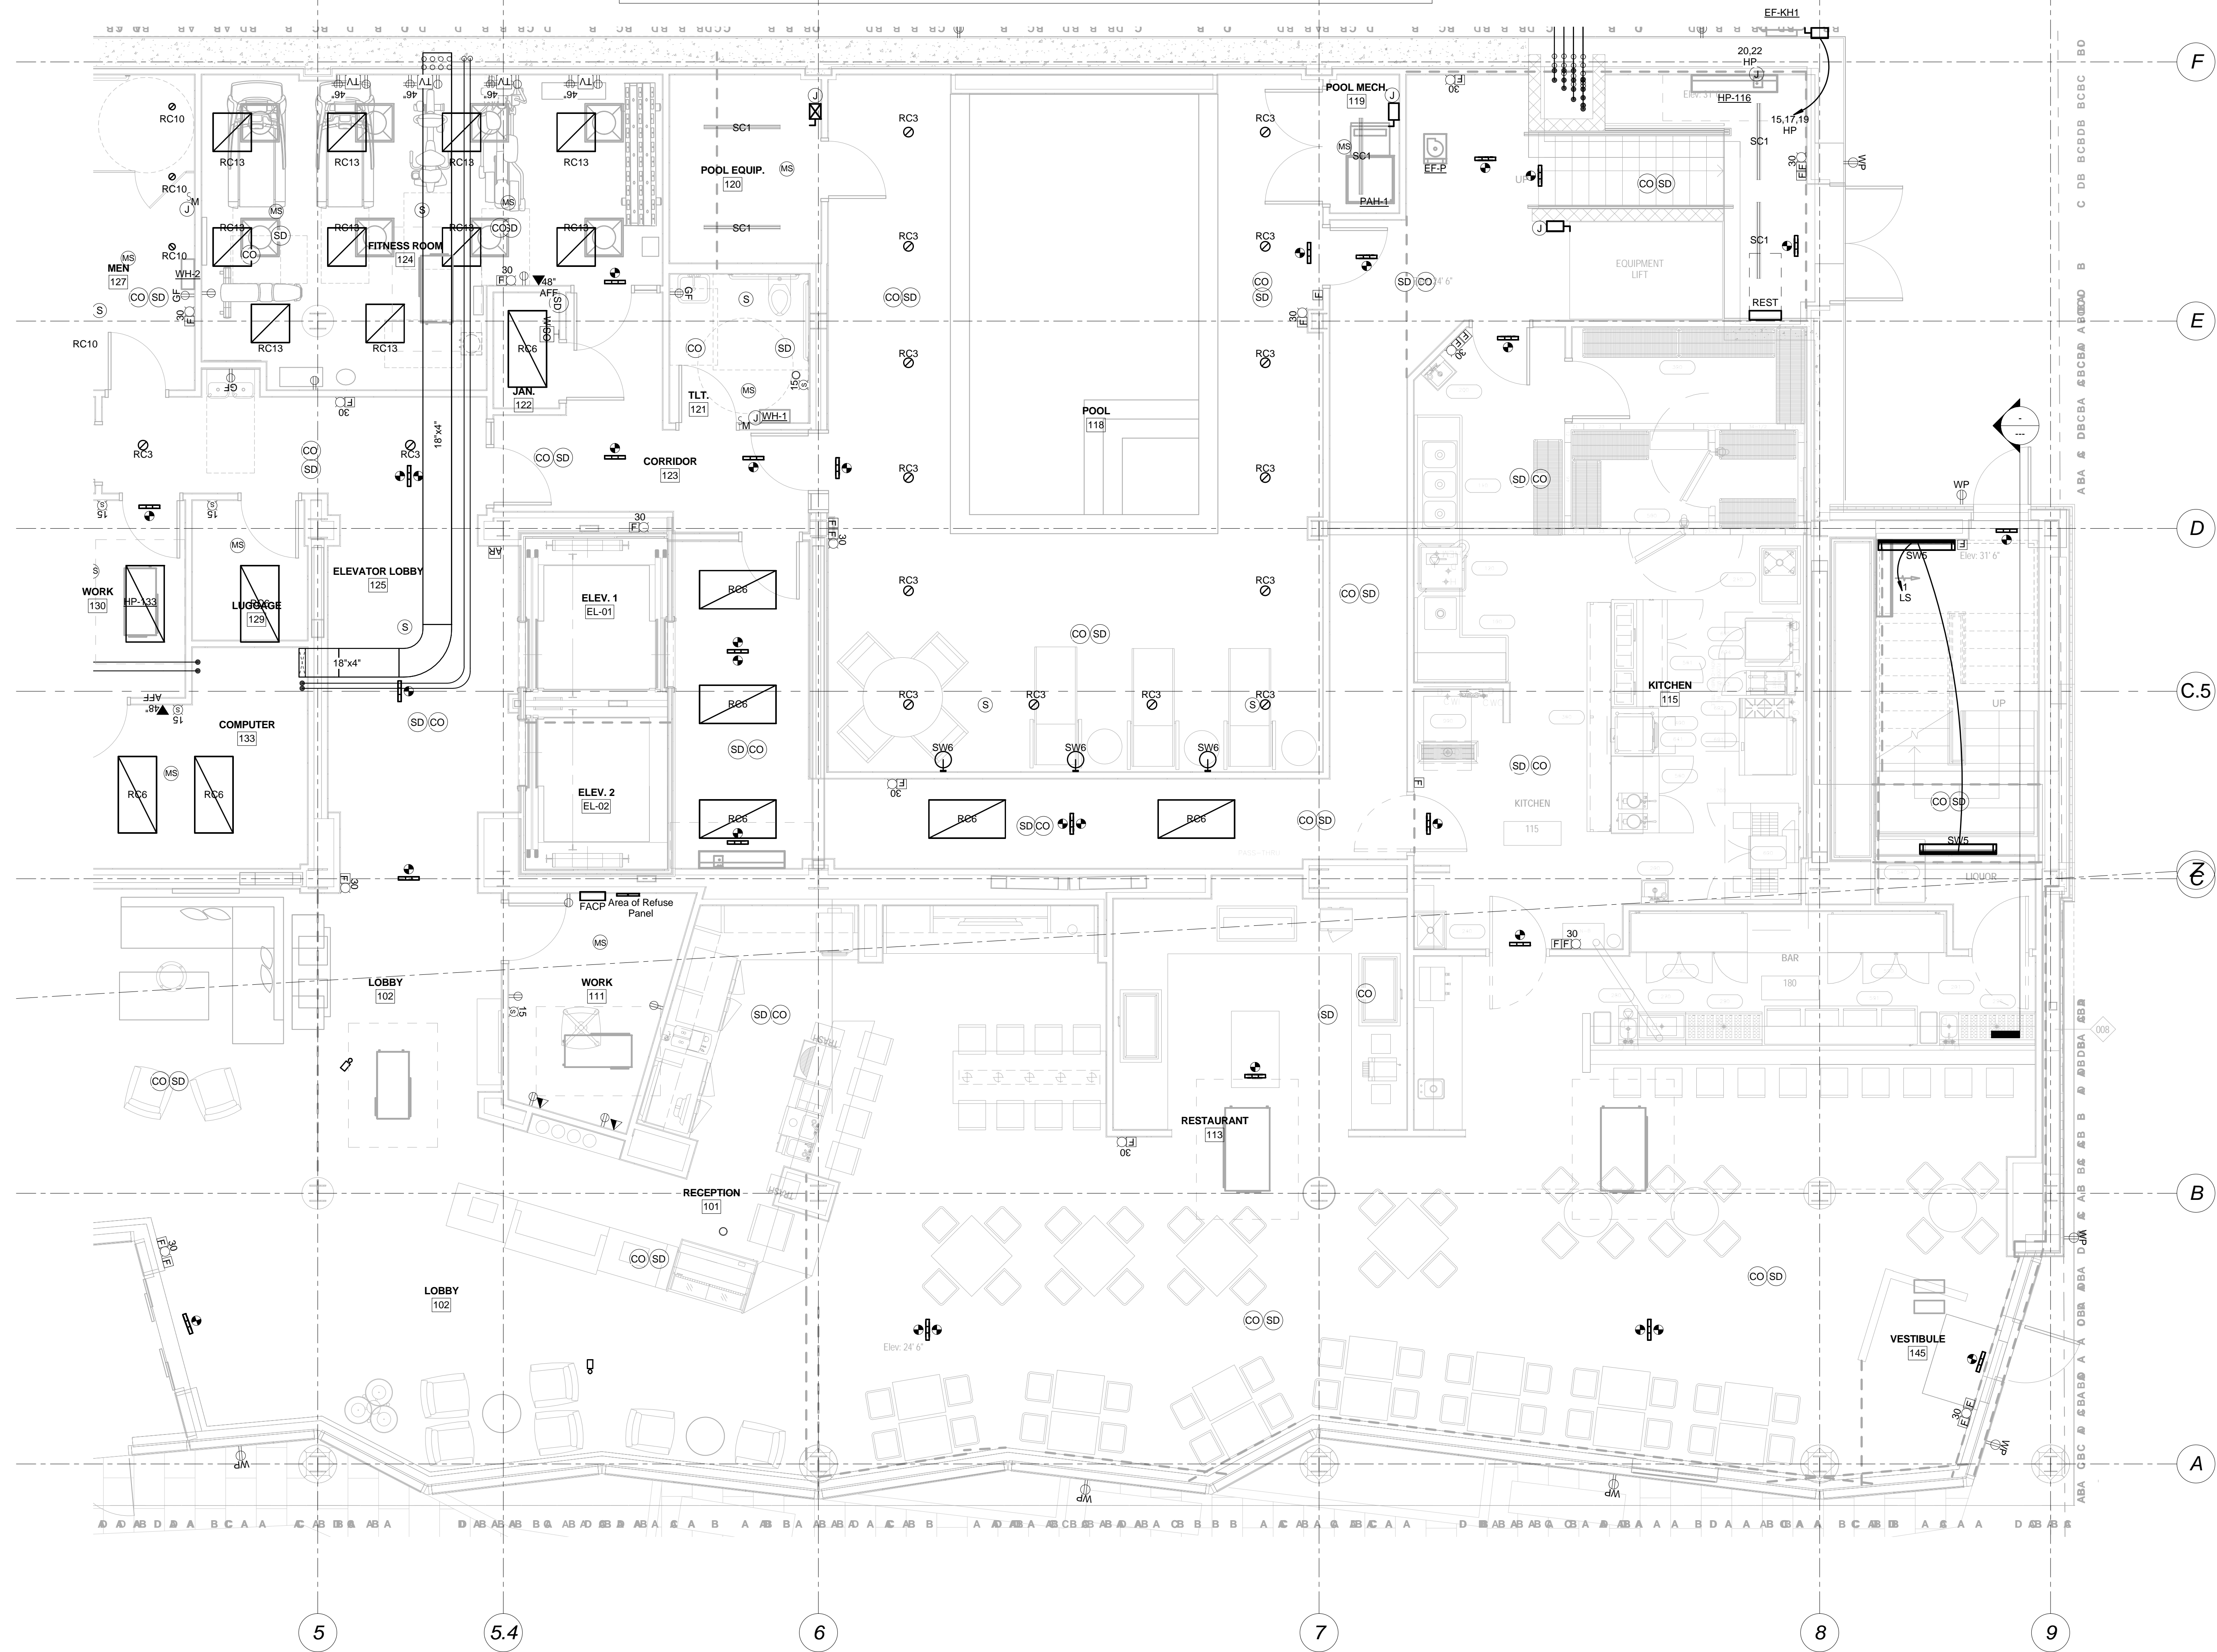

**CANAL STUDIO**  
 Architecture / Planning / Interior Design  
 207 553 2115  
 One Canal Plaza, Suite 888  
 Portland, Maine 04101  
 canalstudio.com

Project Title  
**HYATT PLACE  
 PORTLAND - OLD  
 PORT**  
 433 FORE STREET, PORTLAND, ME  
 C55 Project No. 12013

**BENNETT  
 ENGINEERING**  
 MECHANICAL • ELECTRICAL  
 (207) 965-9475

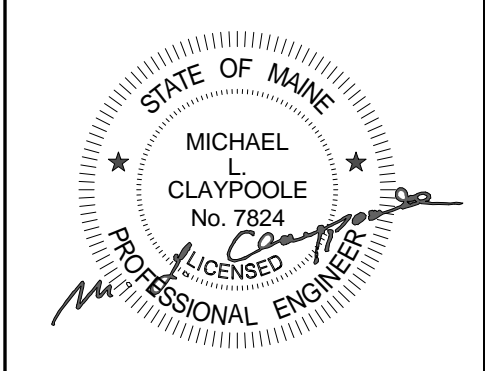

Mark	Date	Description
Project Status		
<b>ISSUED FOR CONSTRUCTION</b>		
03-01-2013		
Drawing Title		
<b>First Floor Electrical Plan-Part B</b>		
Scale: 1/4" = 1'-0"		
Drawing Number		
<b>E20.1B</b>		

1 First Floor Electrical Plan-Part B  
 1/4" = 1'-0"