


Mark	Date	Description
Project Status		
ISSUED FOR CONSTRUCTION		
03-01-2013		
Drawing Title		
Seventh Floor Electrical Plan-Part A		
Scale: 1/4" = 1'-0"		
Drawing Number		
E20.7A		

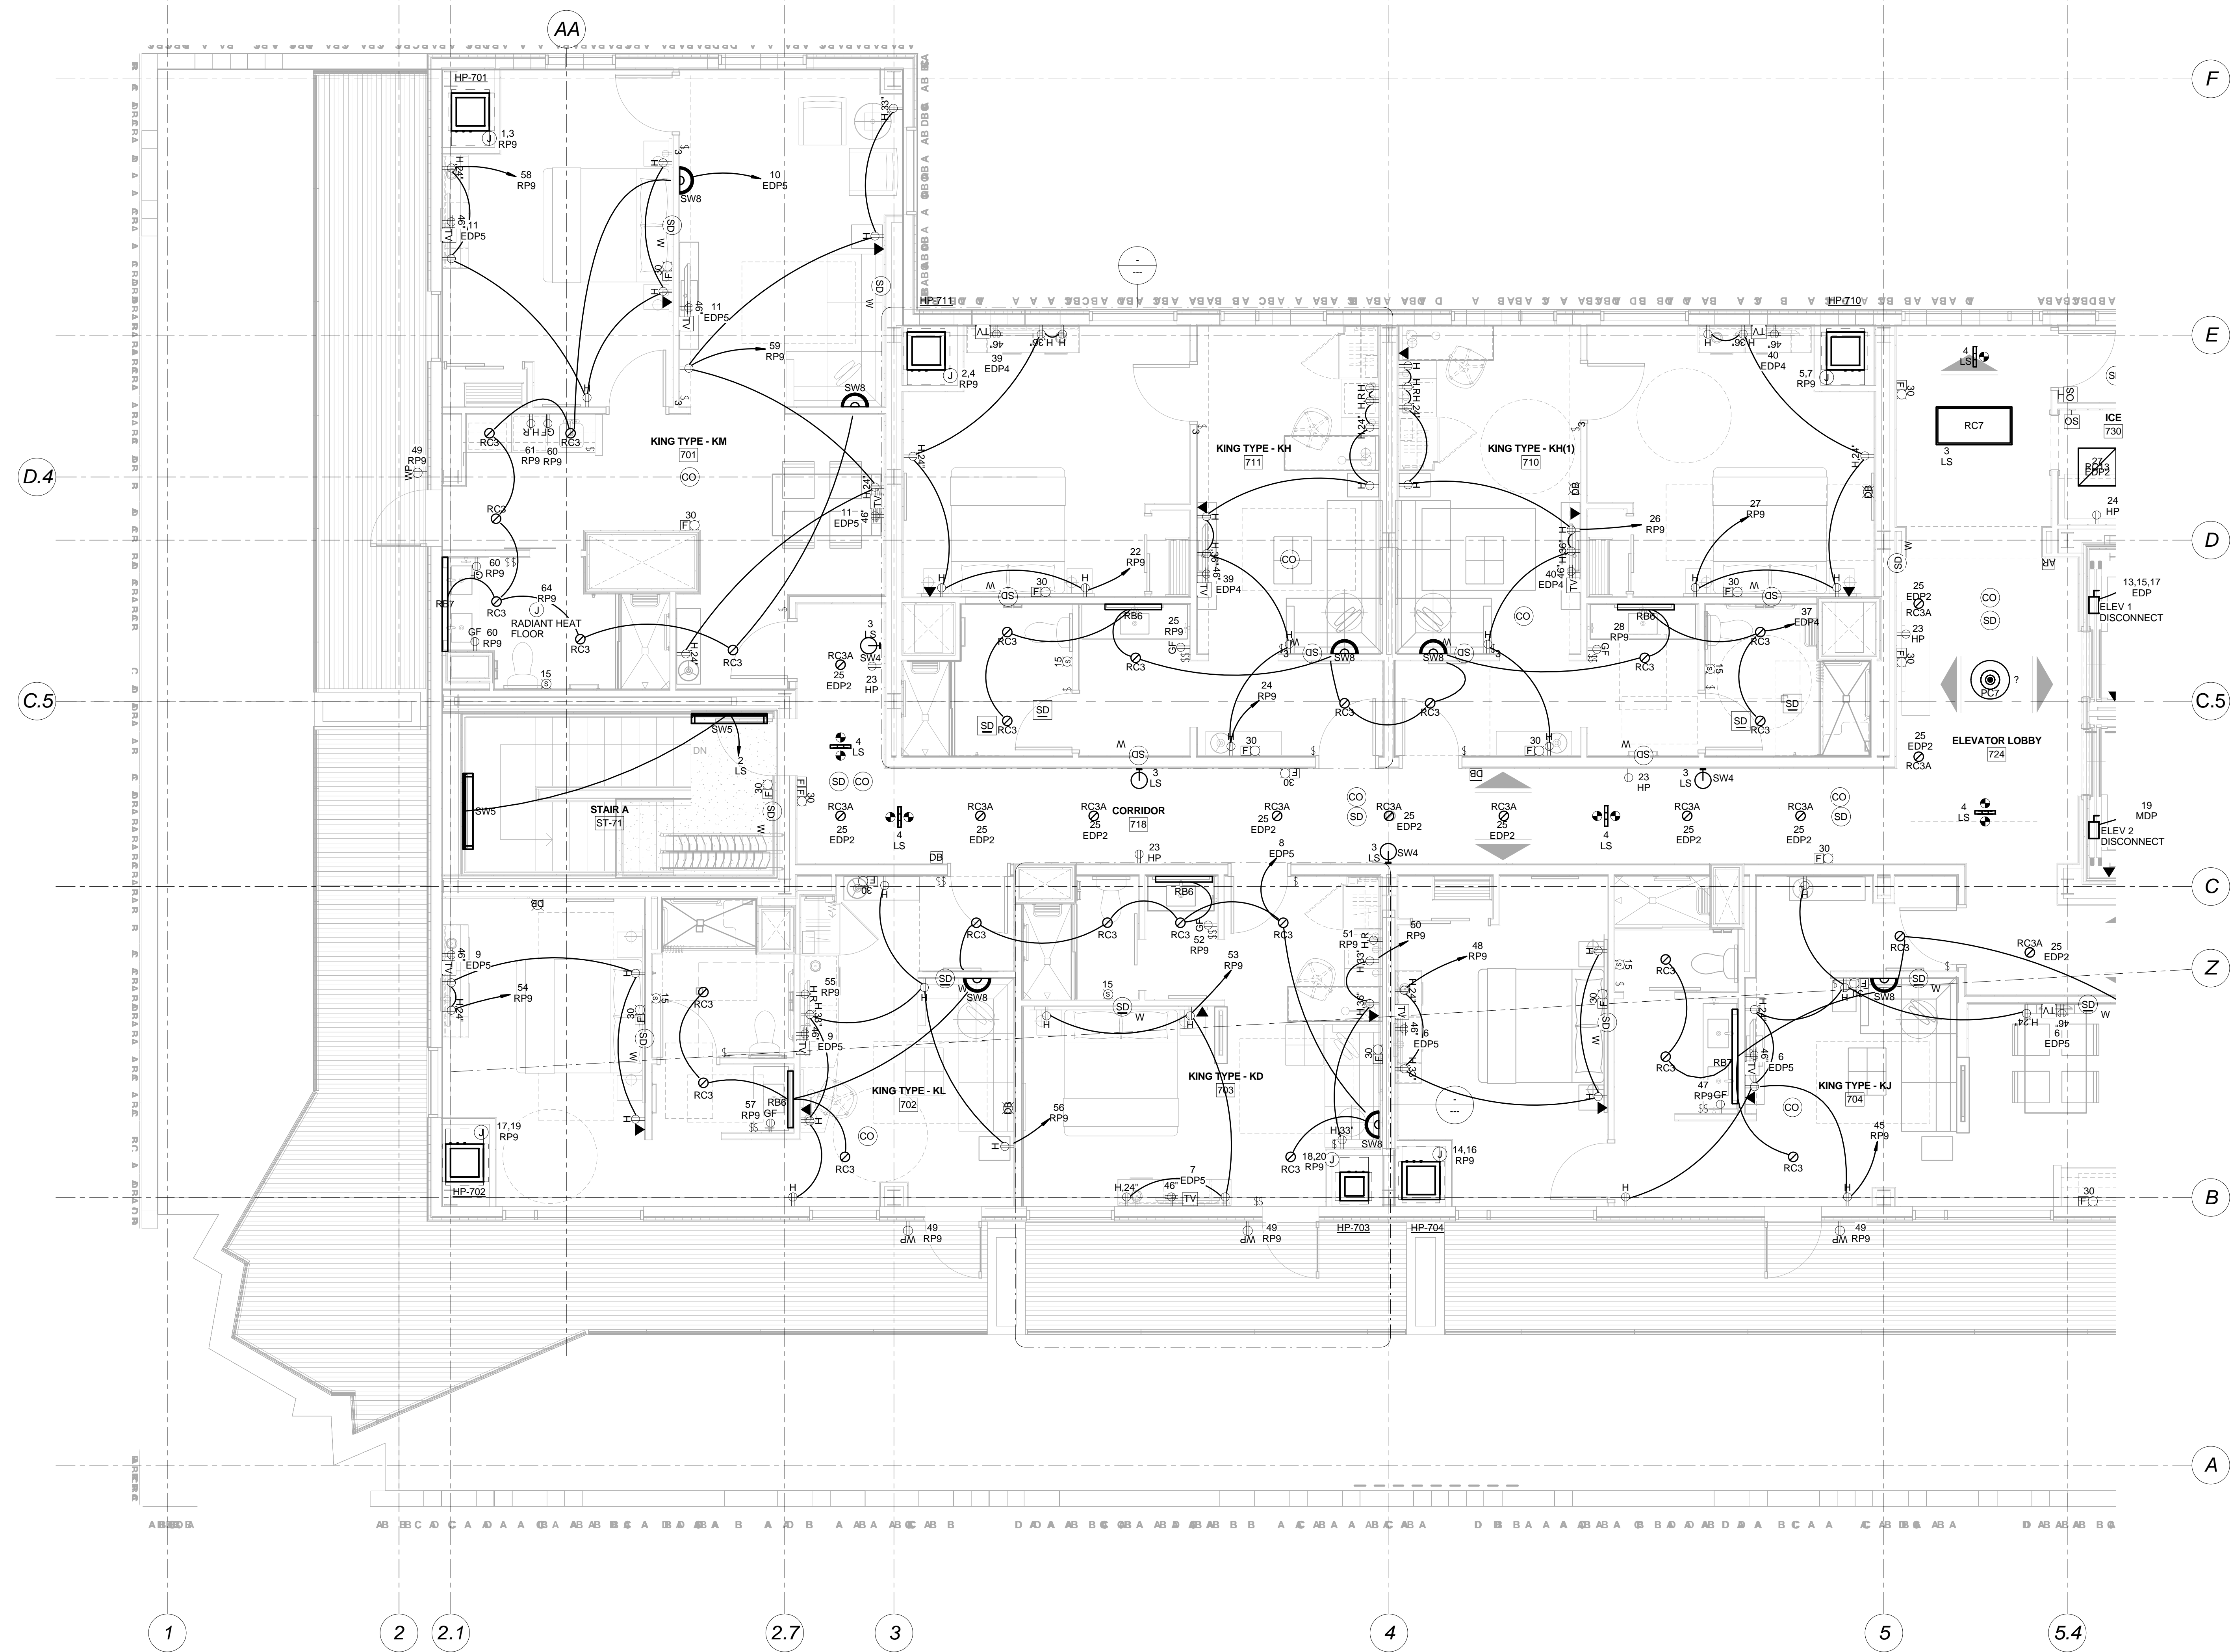

1 7A-Power
 1/4" = 1'-0"