


Luminaire Schedule							
Symbol	Qty	Label	Arrangement	Lumens/Lamp	LLF	Total Watts	Description
■	21	5M-E	SINGLE	4595	0.960	966	PKG-304-5M-PD-04-E-UL-WH-350-40K

Footcandles calculated using predicted lumen values after 50K hours of operation					
Label	Avg	Max	Min	Avg/Min	Max/Min
CANOPY PARKING	4.45	6.8	2.1	2.12	3.24
PERIMETER PARKING	1.41	5.3	0.1	14.10	53.00
SPILL LIGHT	0.04	0.3	0.0	N.A.	N.A.

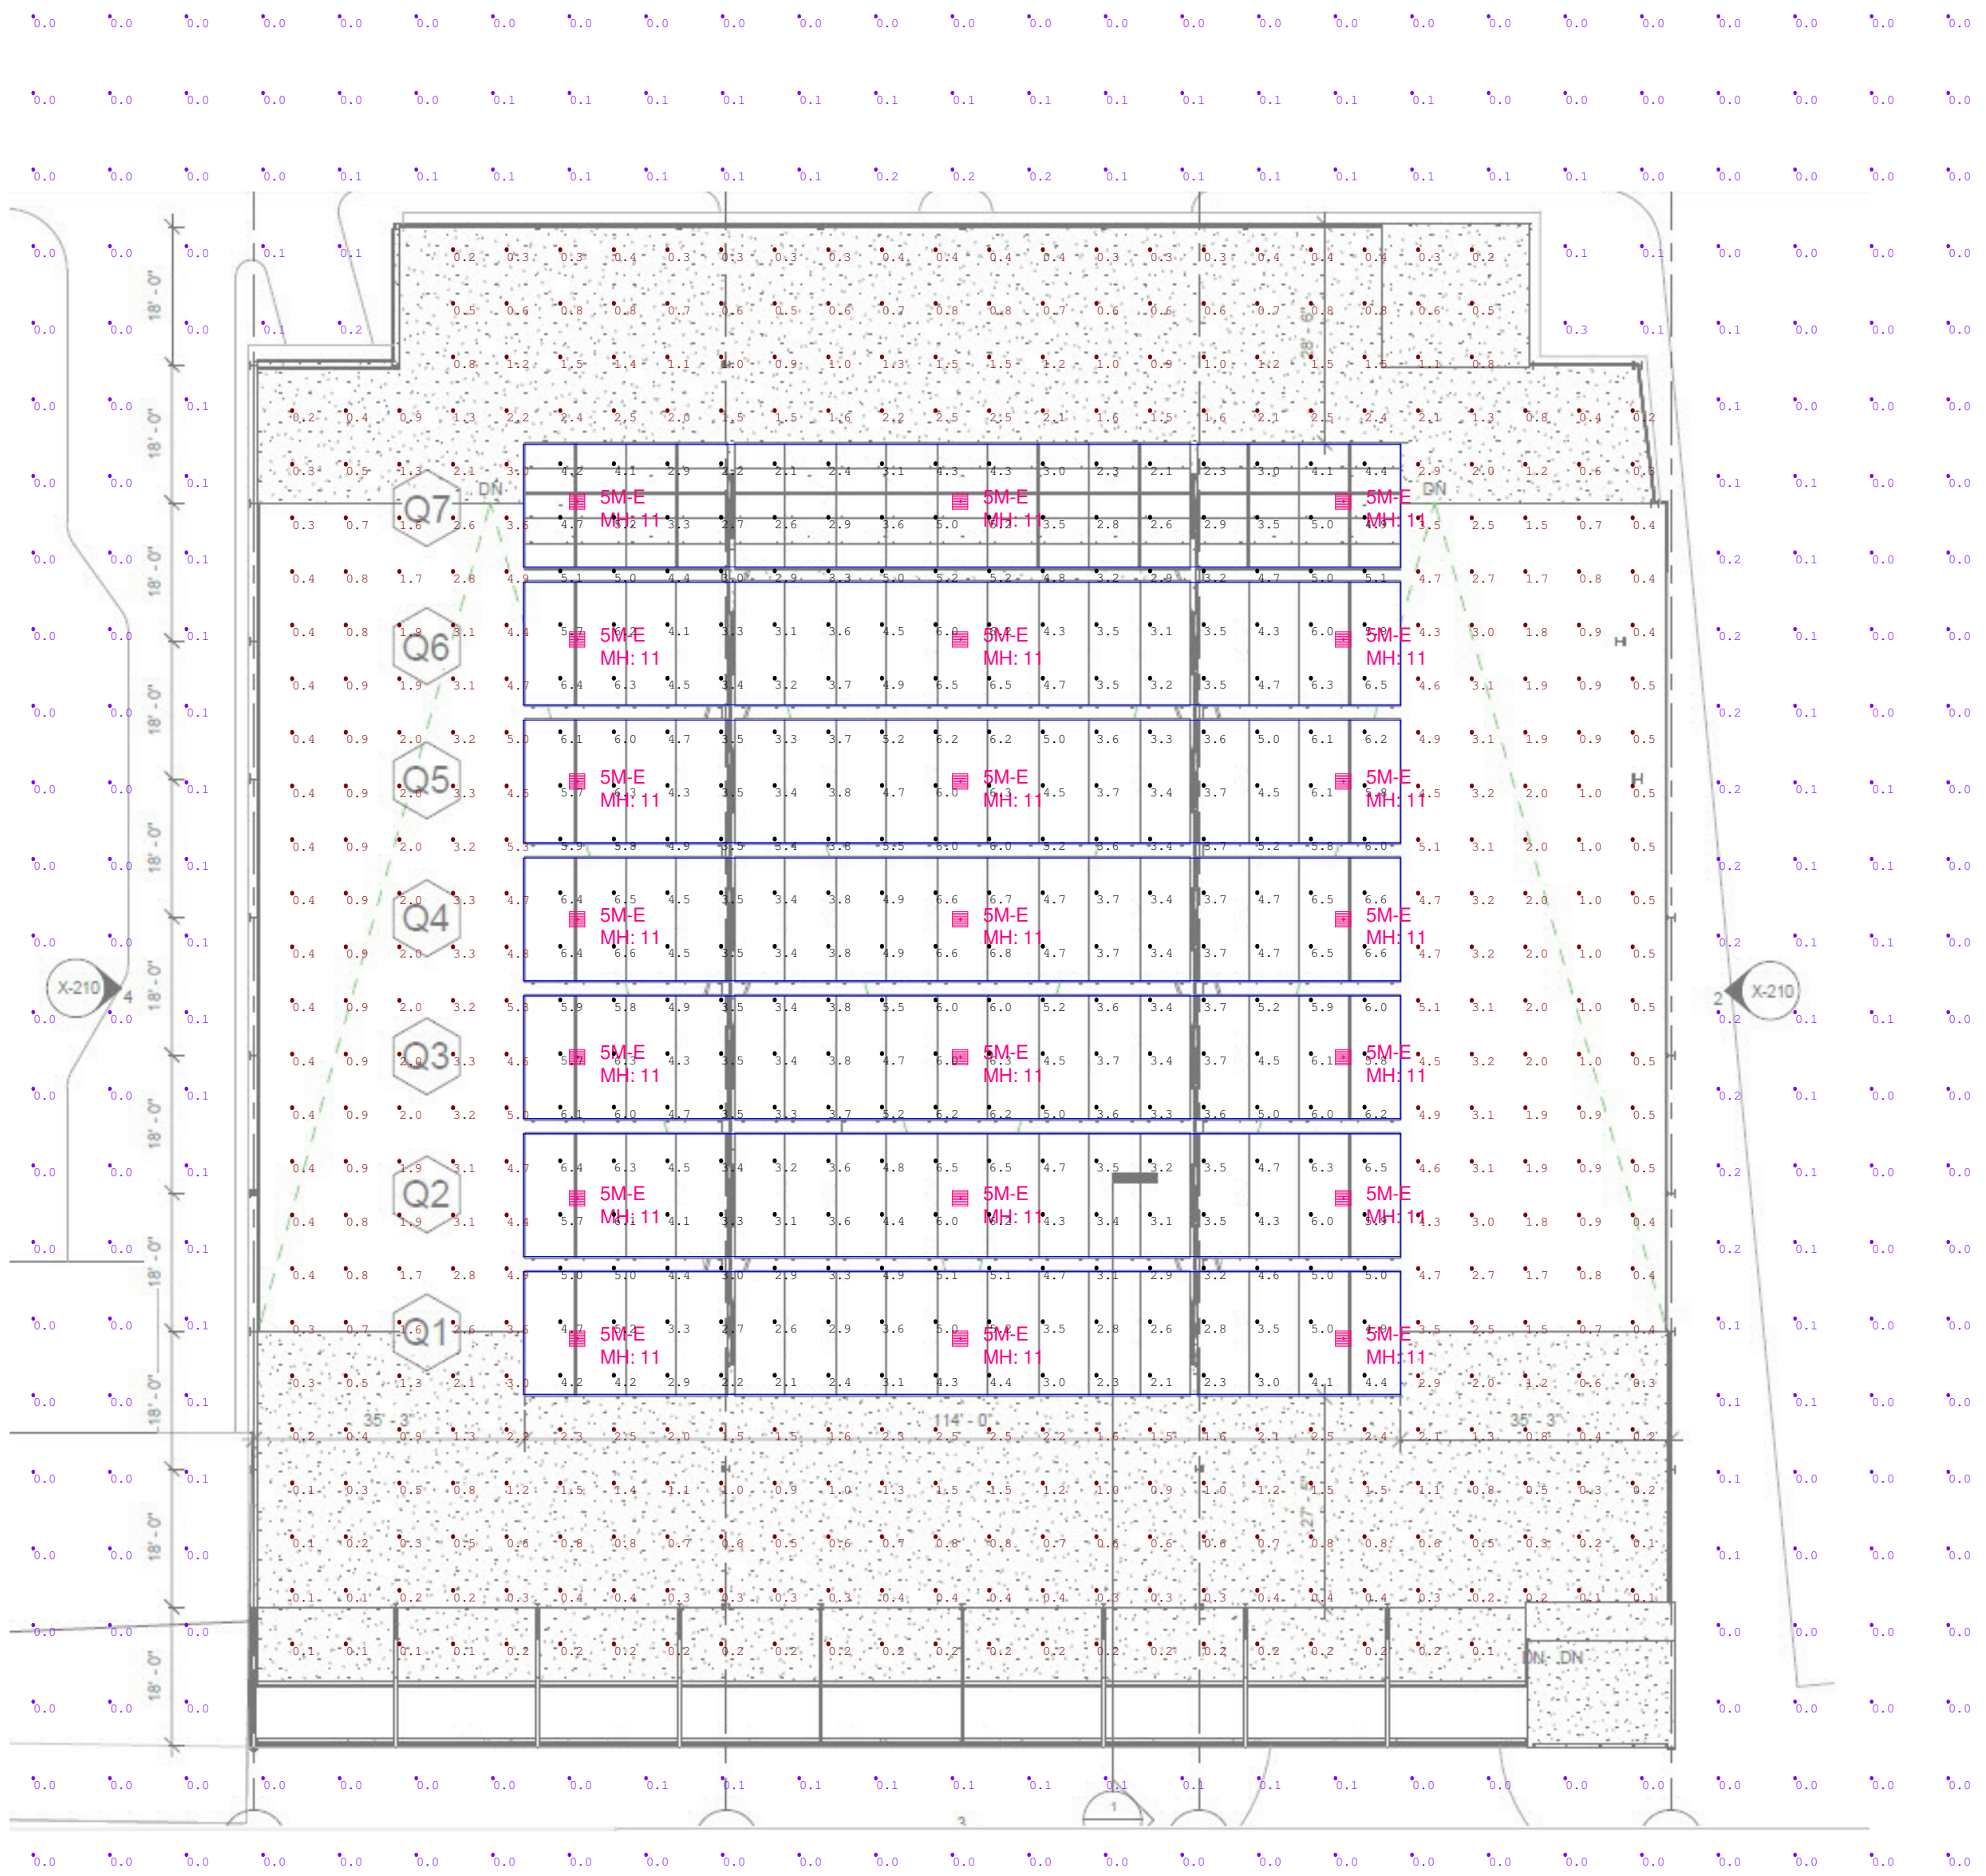

1200 92nd Street - Sturtevant, WI 53177
www.cree.com - (800) 236-6800

Project Name: FORE STREET GARAGE SR-22321
Date: 4/27/2017 Scale: 1"=20' Footcandles calculated at grade
Filename: V:\Common\AppEng\OUT\170328CW1LJSR2.AGI Layout by: LINDA SCHALLER

DLC V4 is in effect as of April 1, 2017, which impacts the rebate eligibility of many LED products. If you require DLC-qualified fixtures, please reference <https://www.designlights.org/search/> for updated qualified product listings. Email rebates@cree.com or rebates@cree.com for assistance.

Illumination results shown on this lighting design are based on project parameters provided to Cree, Inc. used in conjunction with luminaire test procedures conducted under laboratory conditions. Actual project conditions differing from these design parameters may affect field results. The customer is responsible for verifying dimensional accuracy along with compliance with any applicable electrical, lighting, or energy code.

