


Mark	Date	Description
Project Status		
<b>DESIGN DEVELOPMENT</b>		
11-16-12		
Drawing Title		
<b>First Floor HVAC Plan - Part A</b>		
Scale: 1/4" = 1'-0"		
Drawing Number		
<b>M10.1A</b>		

1 First Floor HVAC Plan - Part A  
 1/4" = 1'-0"

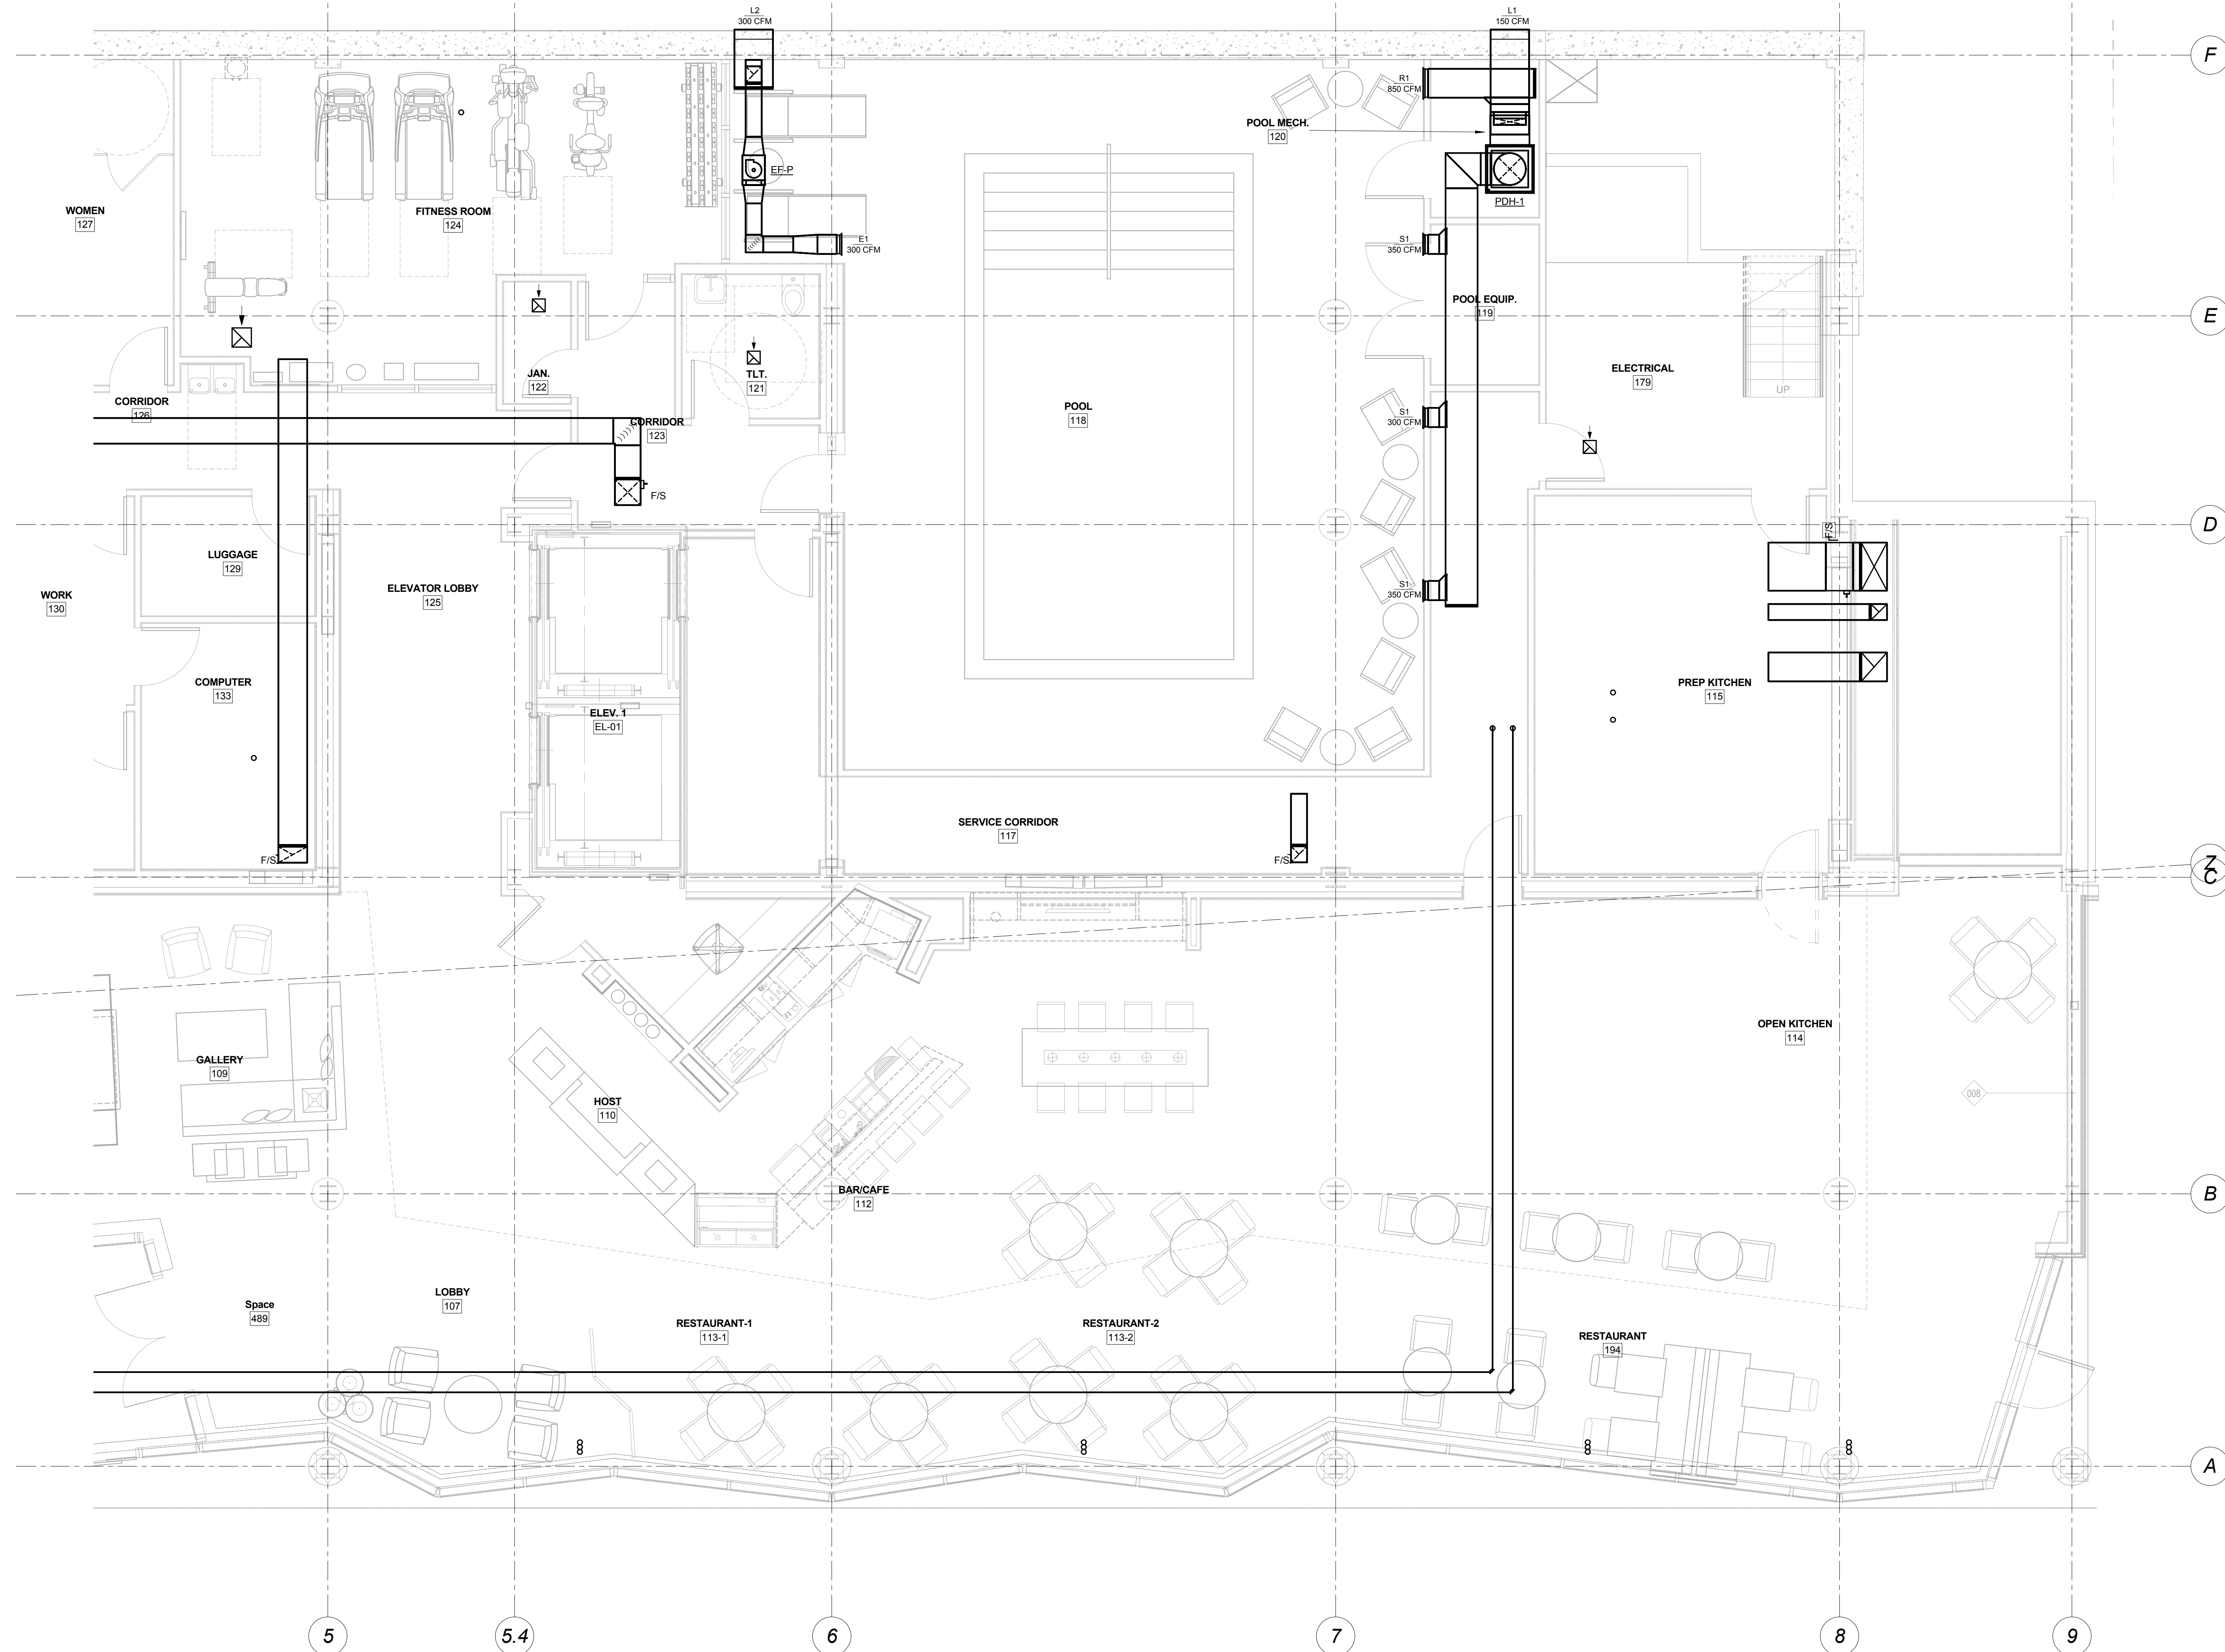

1 First Floor HVAC Plan - Part B  
1/4" = 1'-0"

Mark	Date	Description

Project Status

DESIGN  
DEVELOPMENT  
11-16-12


Drawing Title

First Floor HVAC  
Plan - Part B

Scale: 1/4" = 1'-0"

Drawing Number


M10.1B

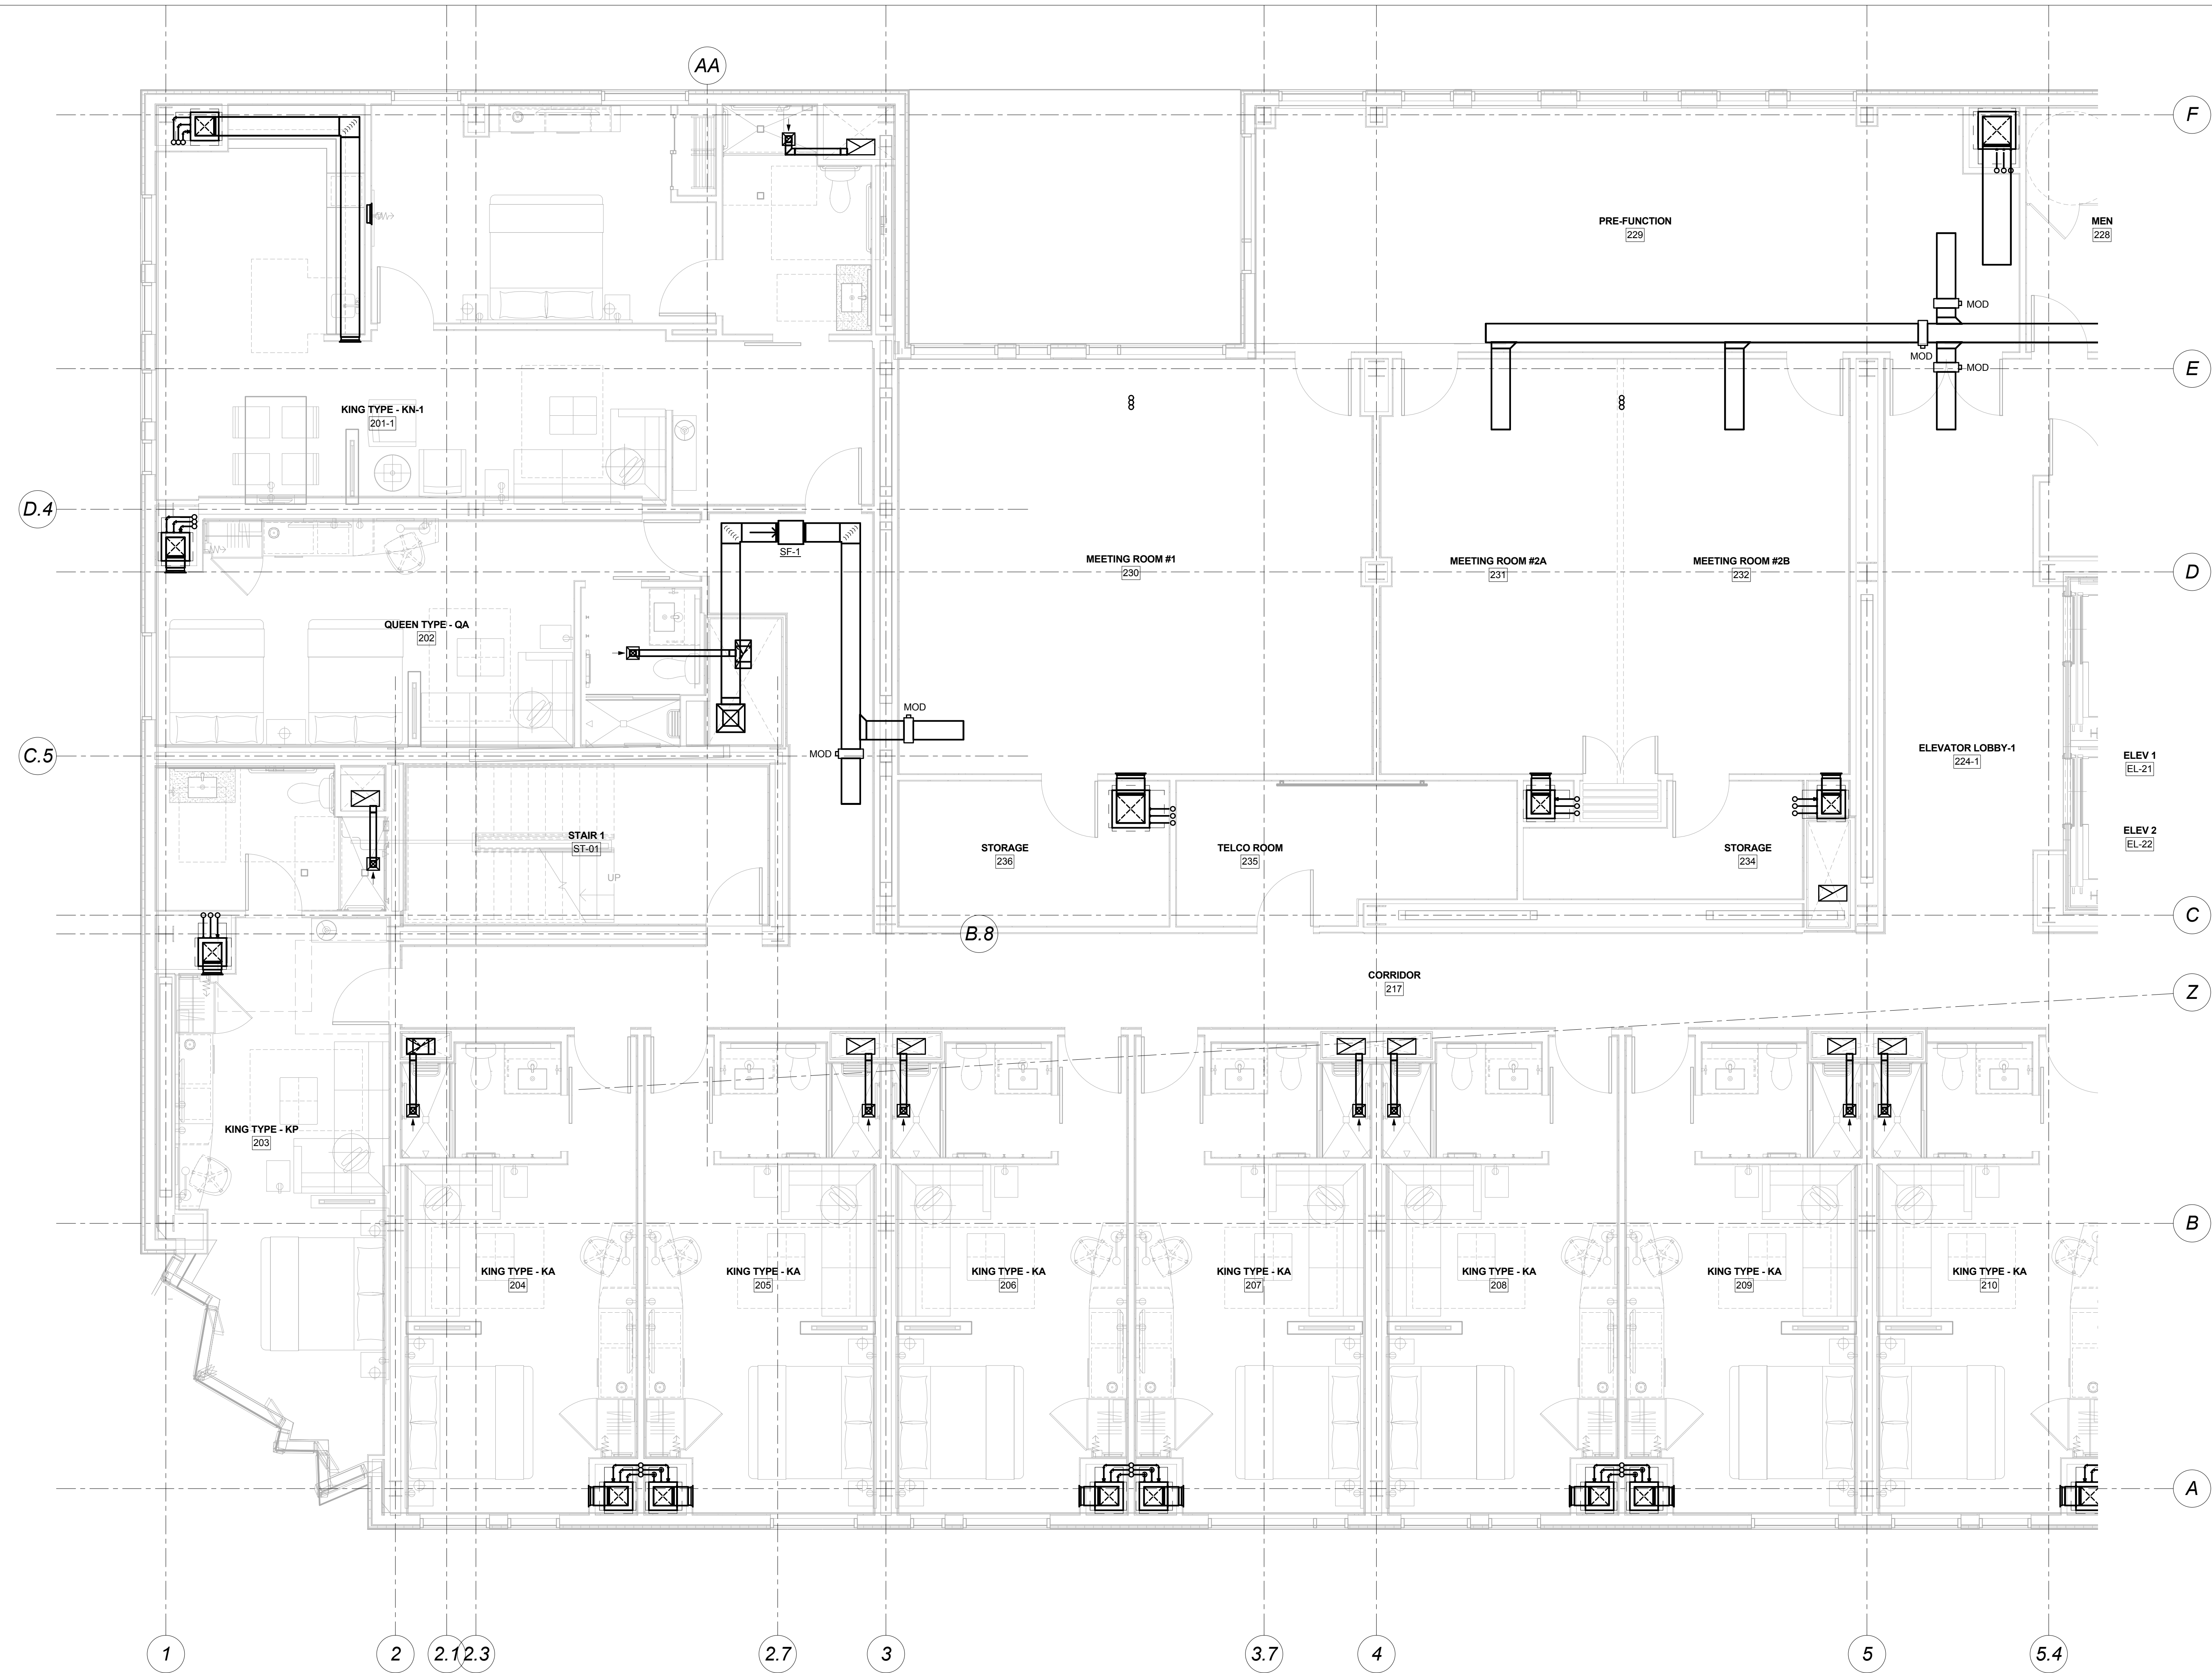

1 Second Floor HVAC Plan  
 1/4" = 1'-0"

Mark	Date	Description
Project Status		
		<b>DESIGN DEVELOPMENT</b> 11-16-12
Drawing Title		
<b>Second Floor HVAC Plan-Part A</b>		
Scale: 1/4" = 1'-0"		
Drawing Number		

**M10.2A**

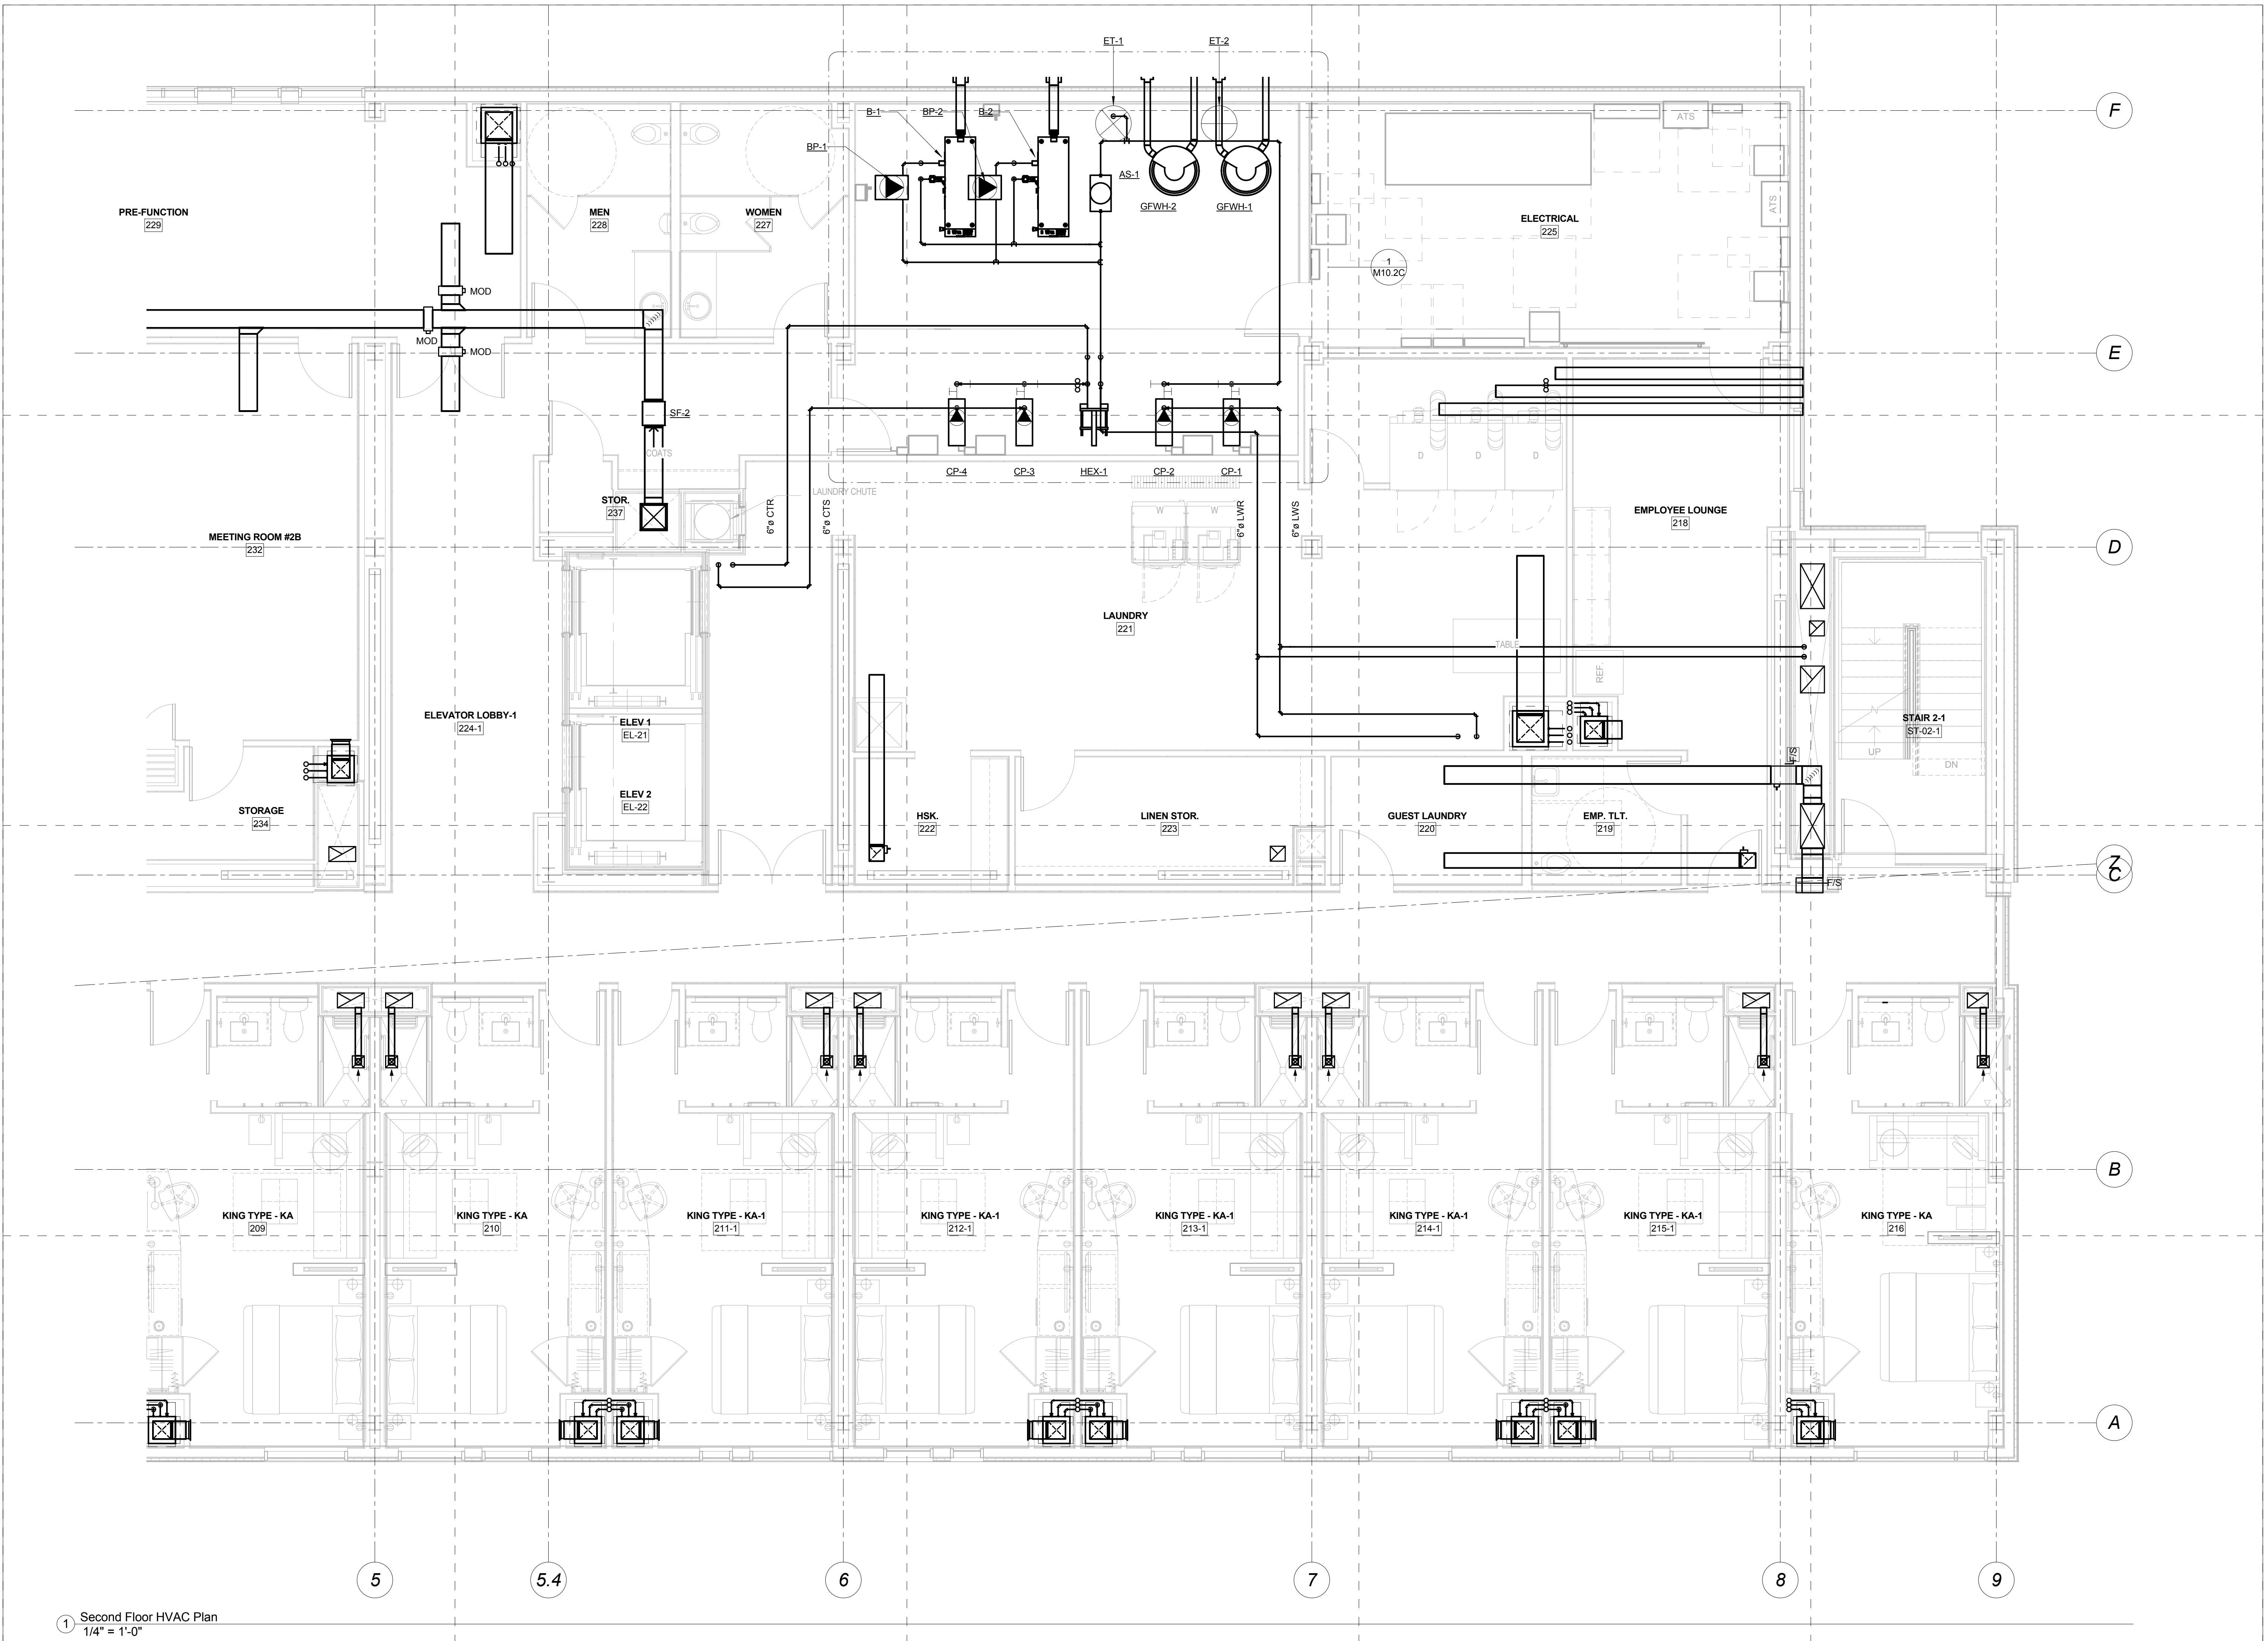

1 Second Floor HVAC Plan  
1/4" = 1'-0"

**CANAL STUDIO**  
Architecture / Planning / Interior Design  
207 553 2115  
One Canal Plaza, Suite 888  
Portland, Maine 04101  
canalstudio.com

**EAST BROWN COW**  
MANAGEMENT, INC.

**shinberg**  
CONSULTING, LLC


Project Title  
**Hyatt Place,  
Portland-Old Port**

433 Fore Street  
Portland, ME

CSS Project No. 12013


**BENNETT ENGINEERING**  
MECHANICAL • ELECTRICAL  
(207) 865-9475

Mark	Date	Description
Project Status		
<b>DESIGN DEVELOPMENT</b>		
11-16-12		
Drawing Title		
<b>Second Floor HVAC Plan-Part B</b>		
Scale: 1/4" = 1'-0"		
Drawing Number		
<b>M10.2B</b>		

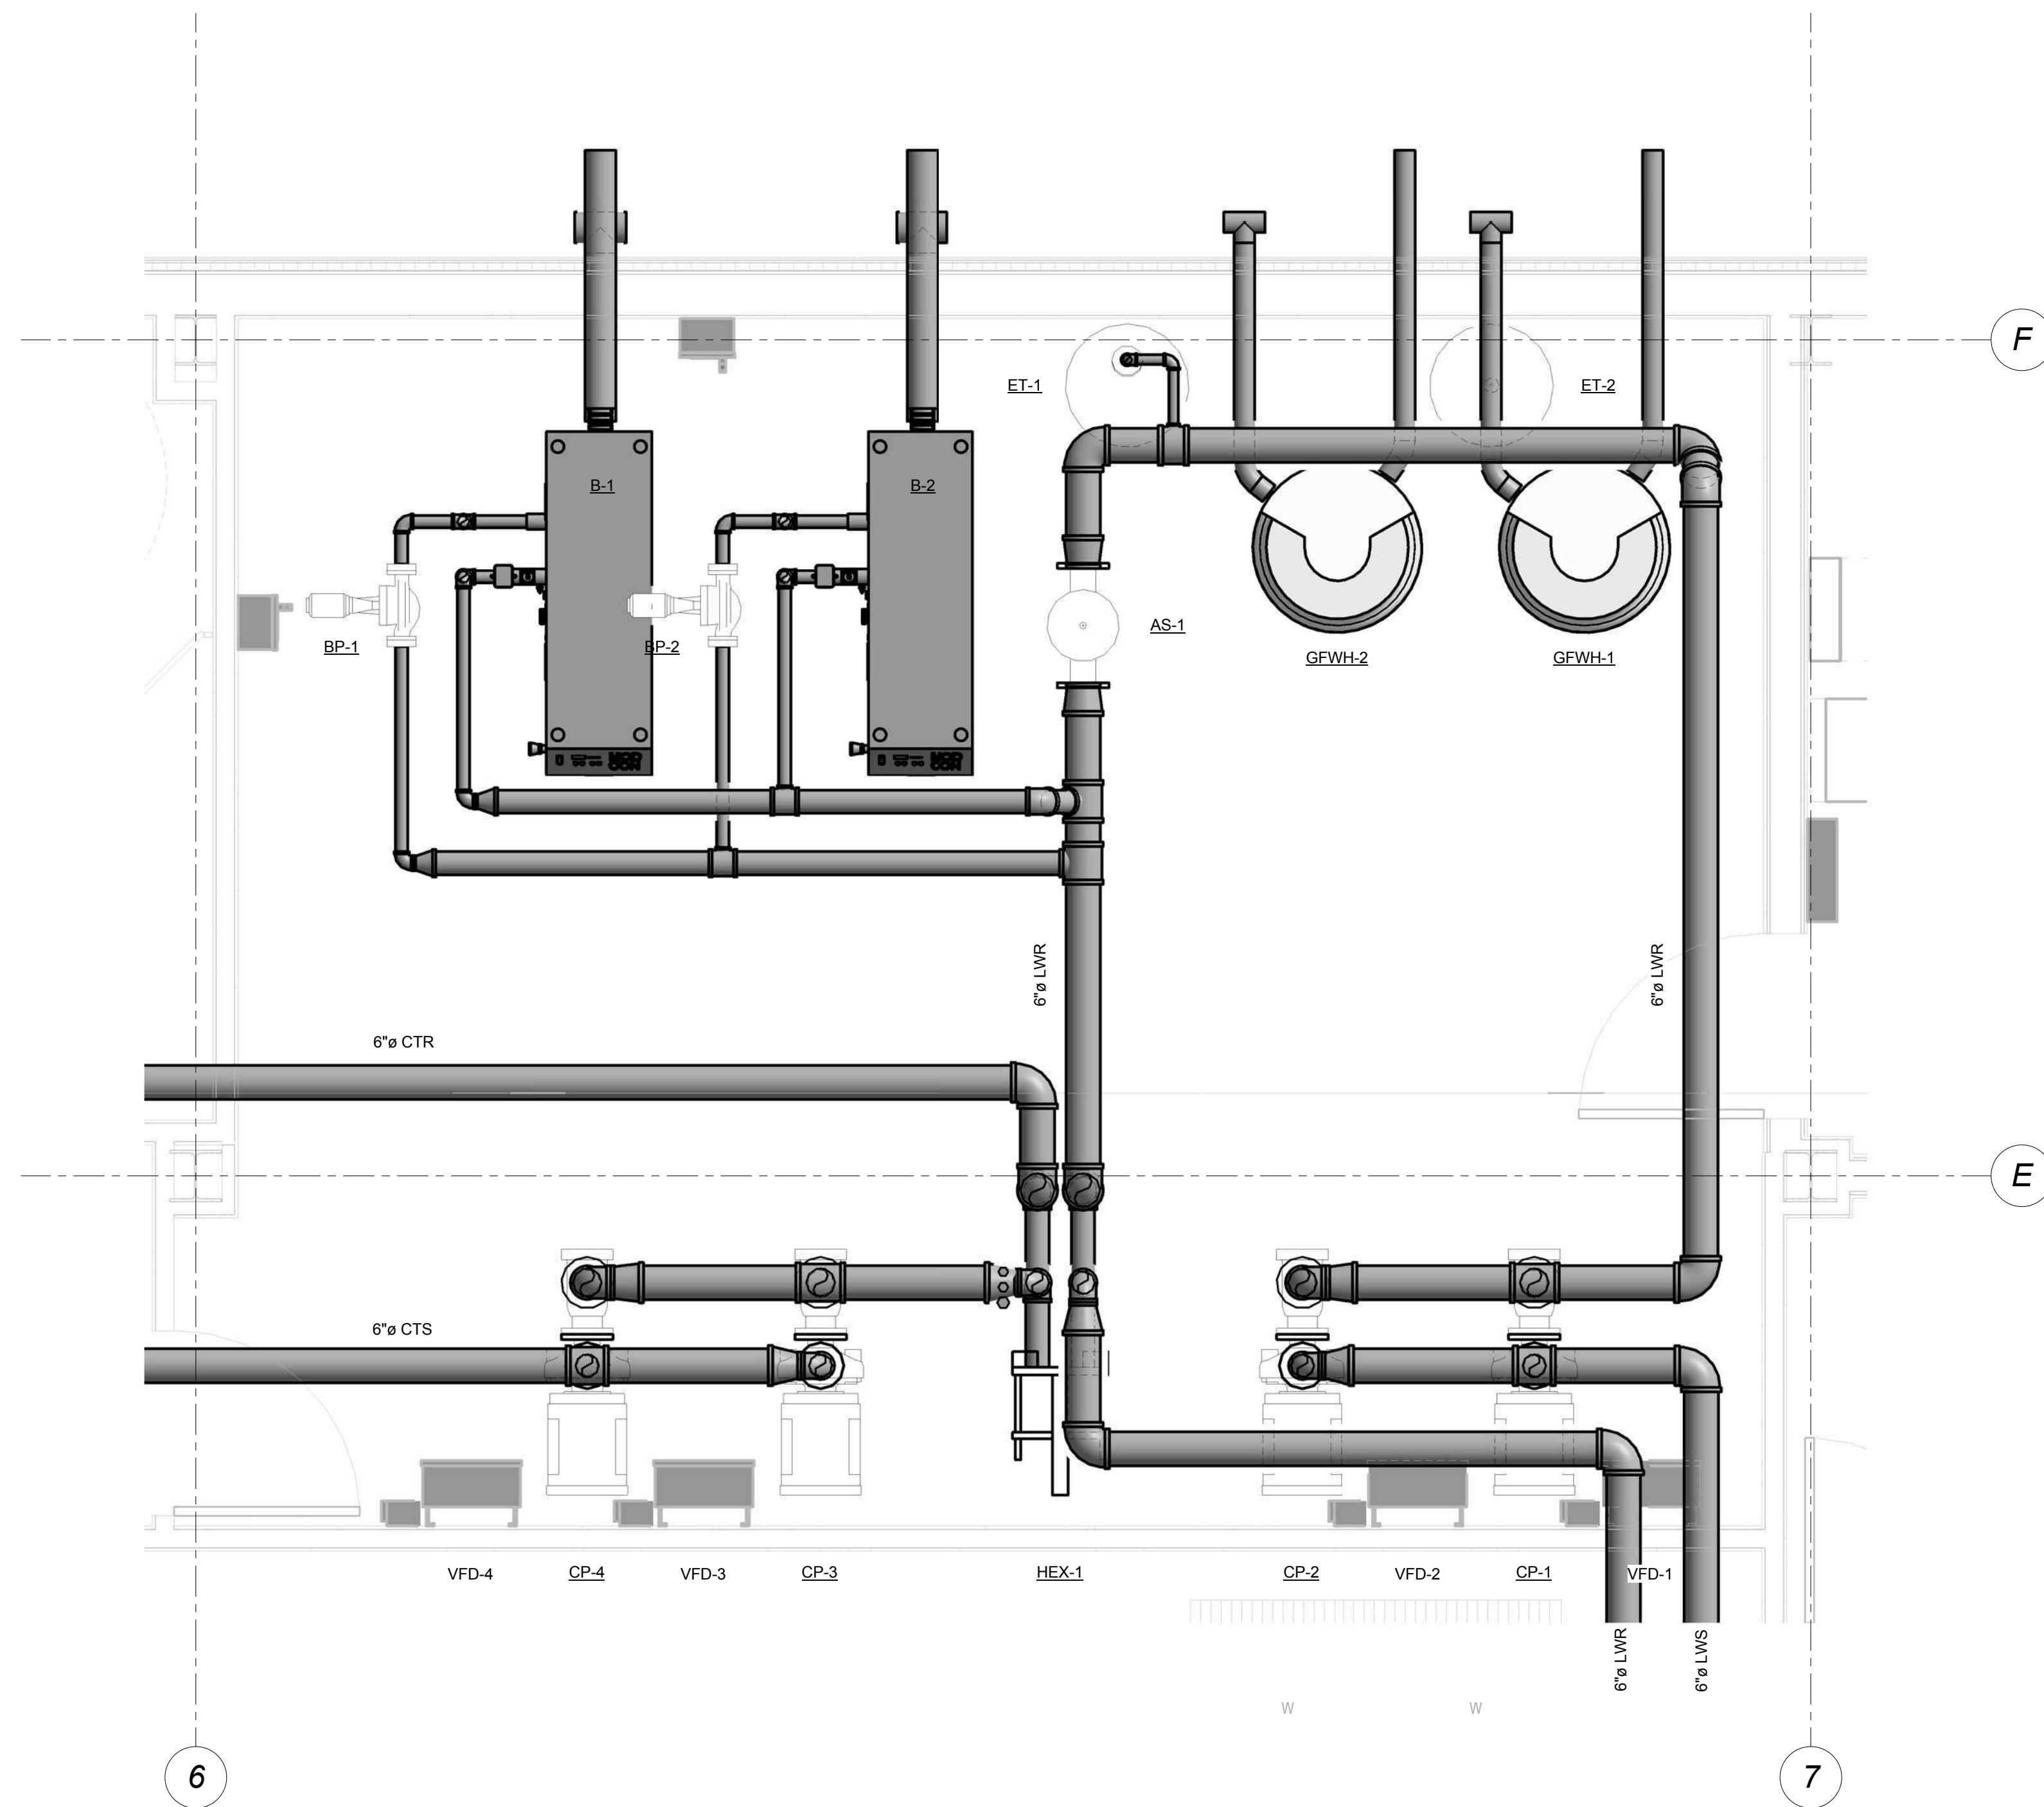

1 Enlarged Boiler Room Plan  
1/2" = 1'-0"

Mark	Date	Description
Project Status		
<b>DESIGN DEVELOPMENT</b>		
11-16-12		
Drawing Title		
<b>Boiler Room Details</b>		
Scale: 1/2" = 1'-0"		
Drawing Number		
<b>M10.2C</b>		

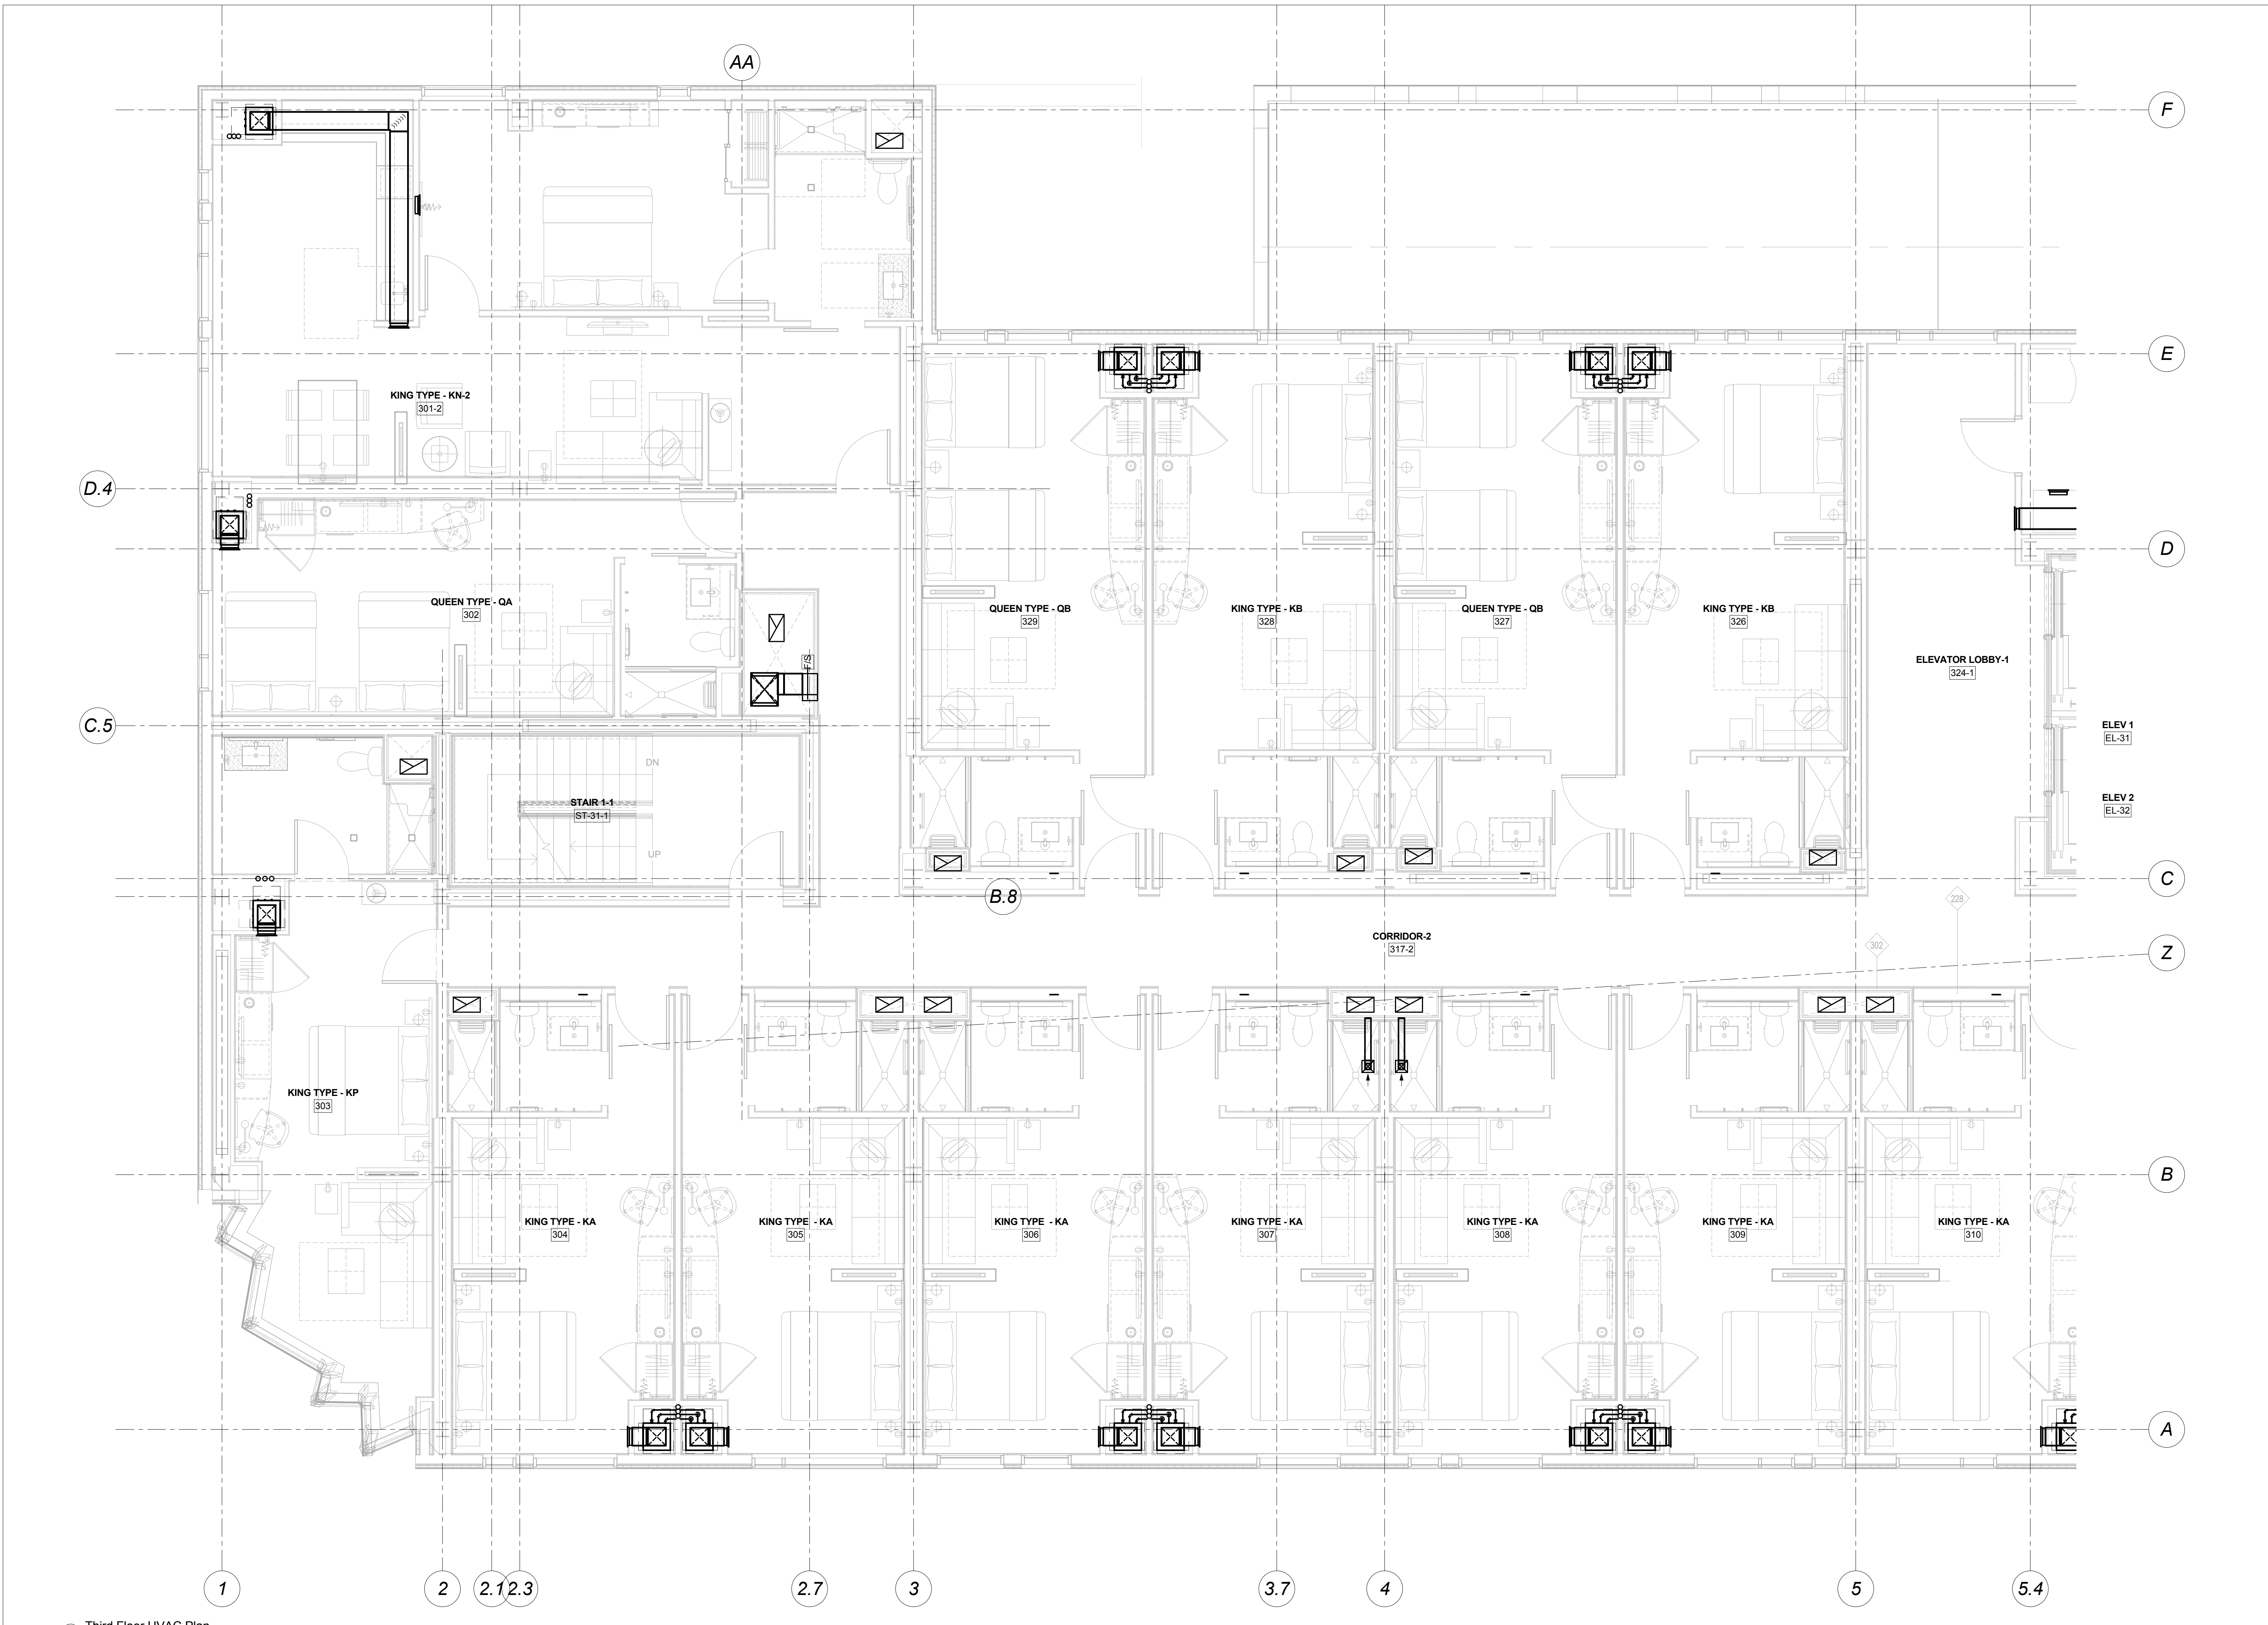

1 Third Floor HVAC Plan  
1/4" = 1'-0"


Mark	Date	Description

Project Status	<b>DESIGN DEVELOPMENT</b> 11-16-12
----------------	---------------------------------------

Drawing Title	<b>Third Floor HVAC Plan-Part A</b>
---------------	-------------------------------------

Scale:	1/4" = 1'-0"
--------	--------------

Drawing Number	<b>M10.3A</b>
----------------	---------------

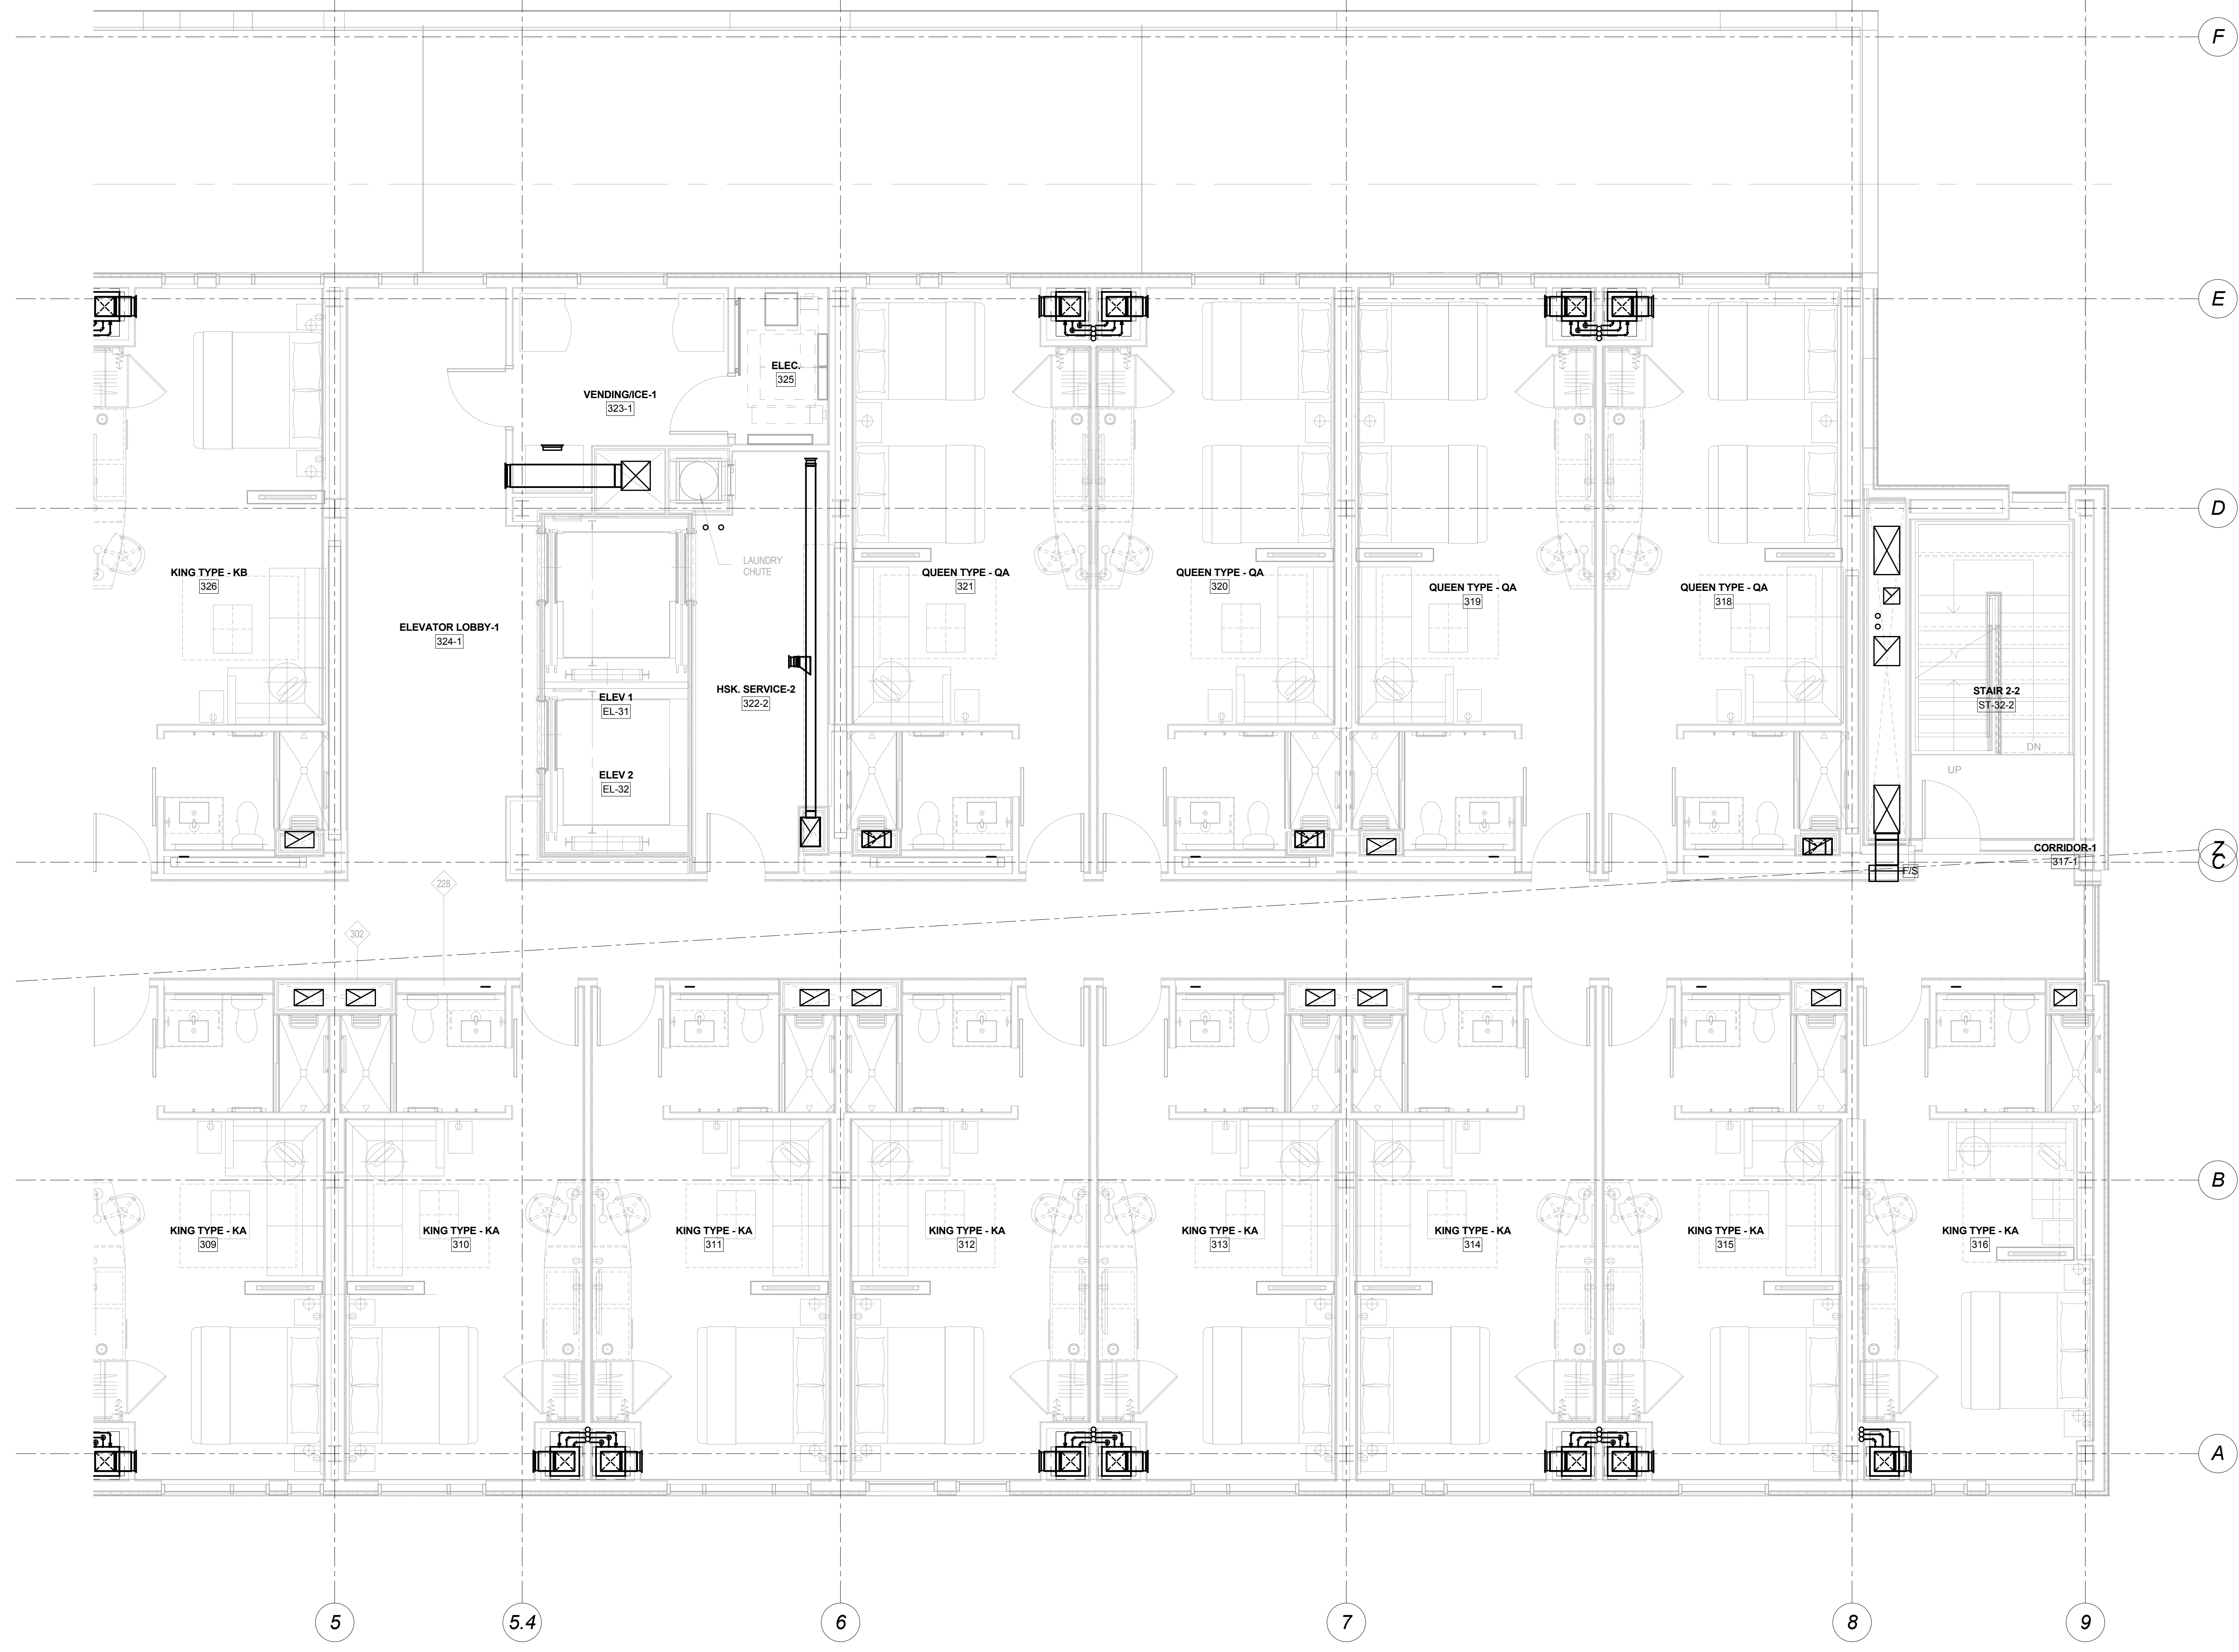

1 Third Floor HVAC Plan  
 1/4" = 1'-0"

Mark	Date	Description
Project Status		
		<b>DESIGN DEVELOPMENT</b> 11-16-12
Drawing Title		
		<b>Third Floor HVAC Plan-Part B</b>
Scale: 1/4" = 1'-0"		
Drawing Number		
		<b>M10.3B</b>

Mark	Date	Description
------	------	-------------

Project Status

**DESIGN  
DEVELOPMENT**

11-16-12


Drawing Title

**Fourth Floor HVAC  
Plan-Part A**

Scale: 1/4" = 1'-0"


Drawing Number

**M10.4A**

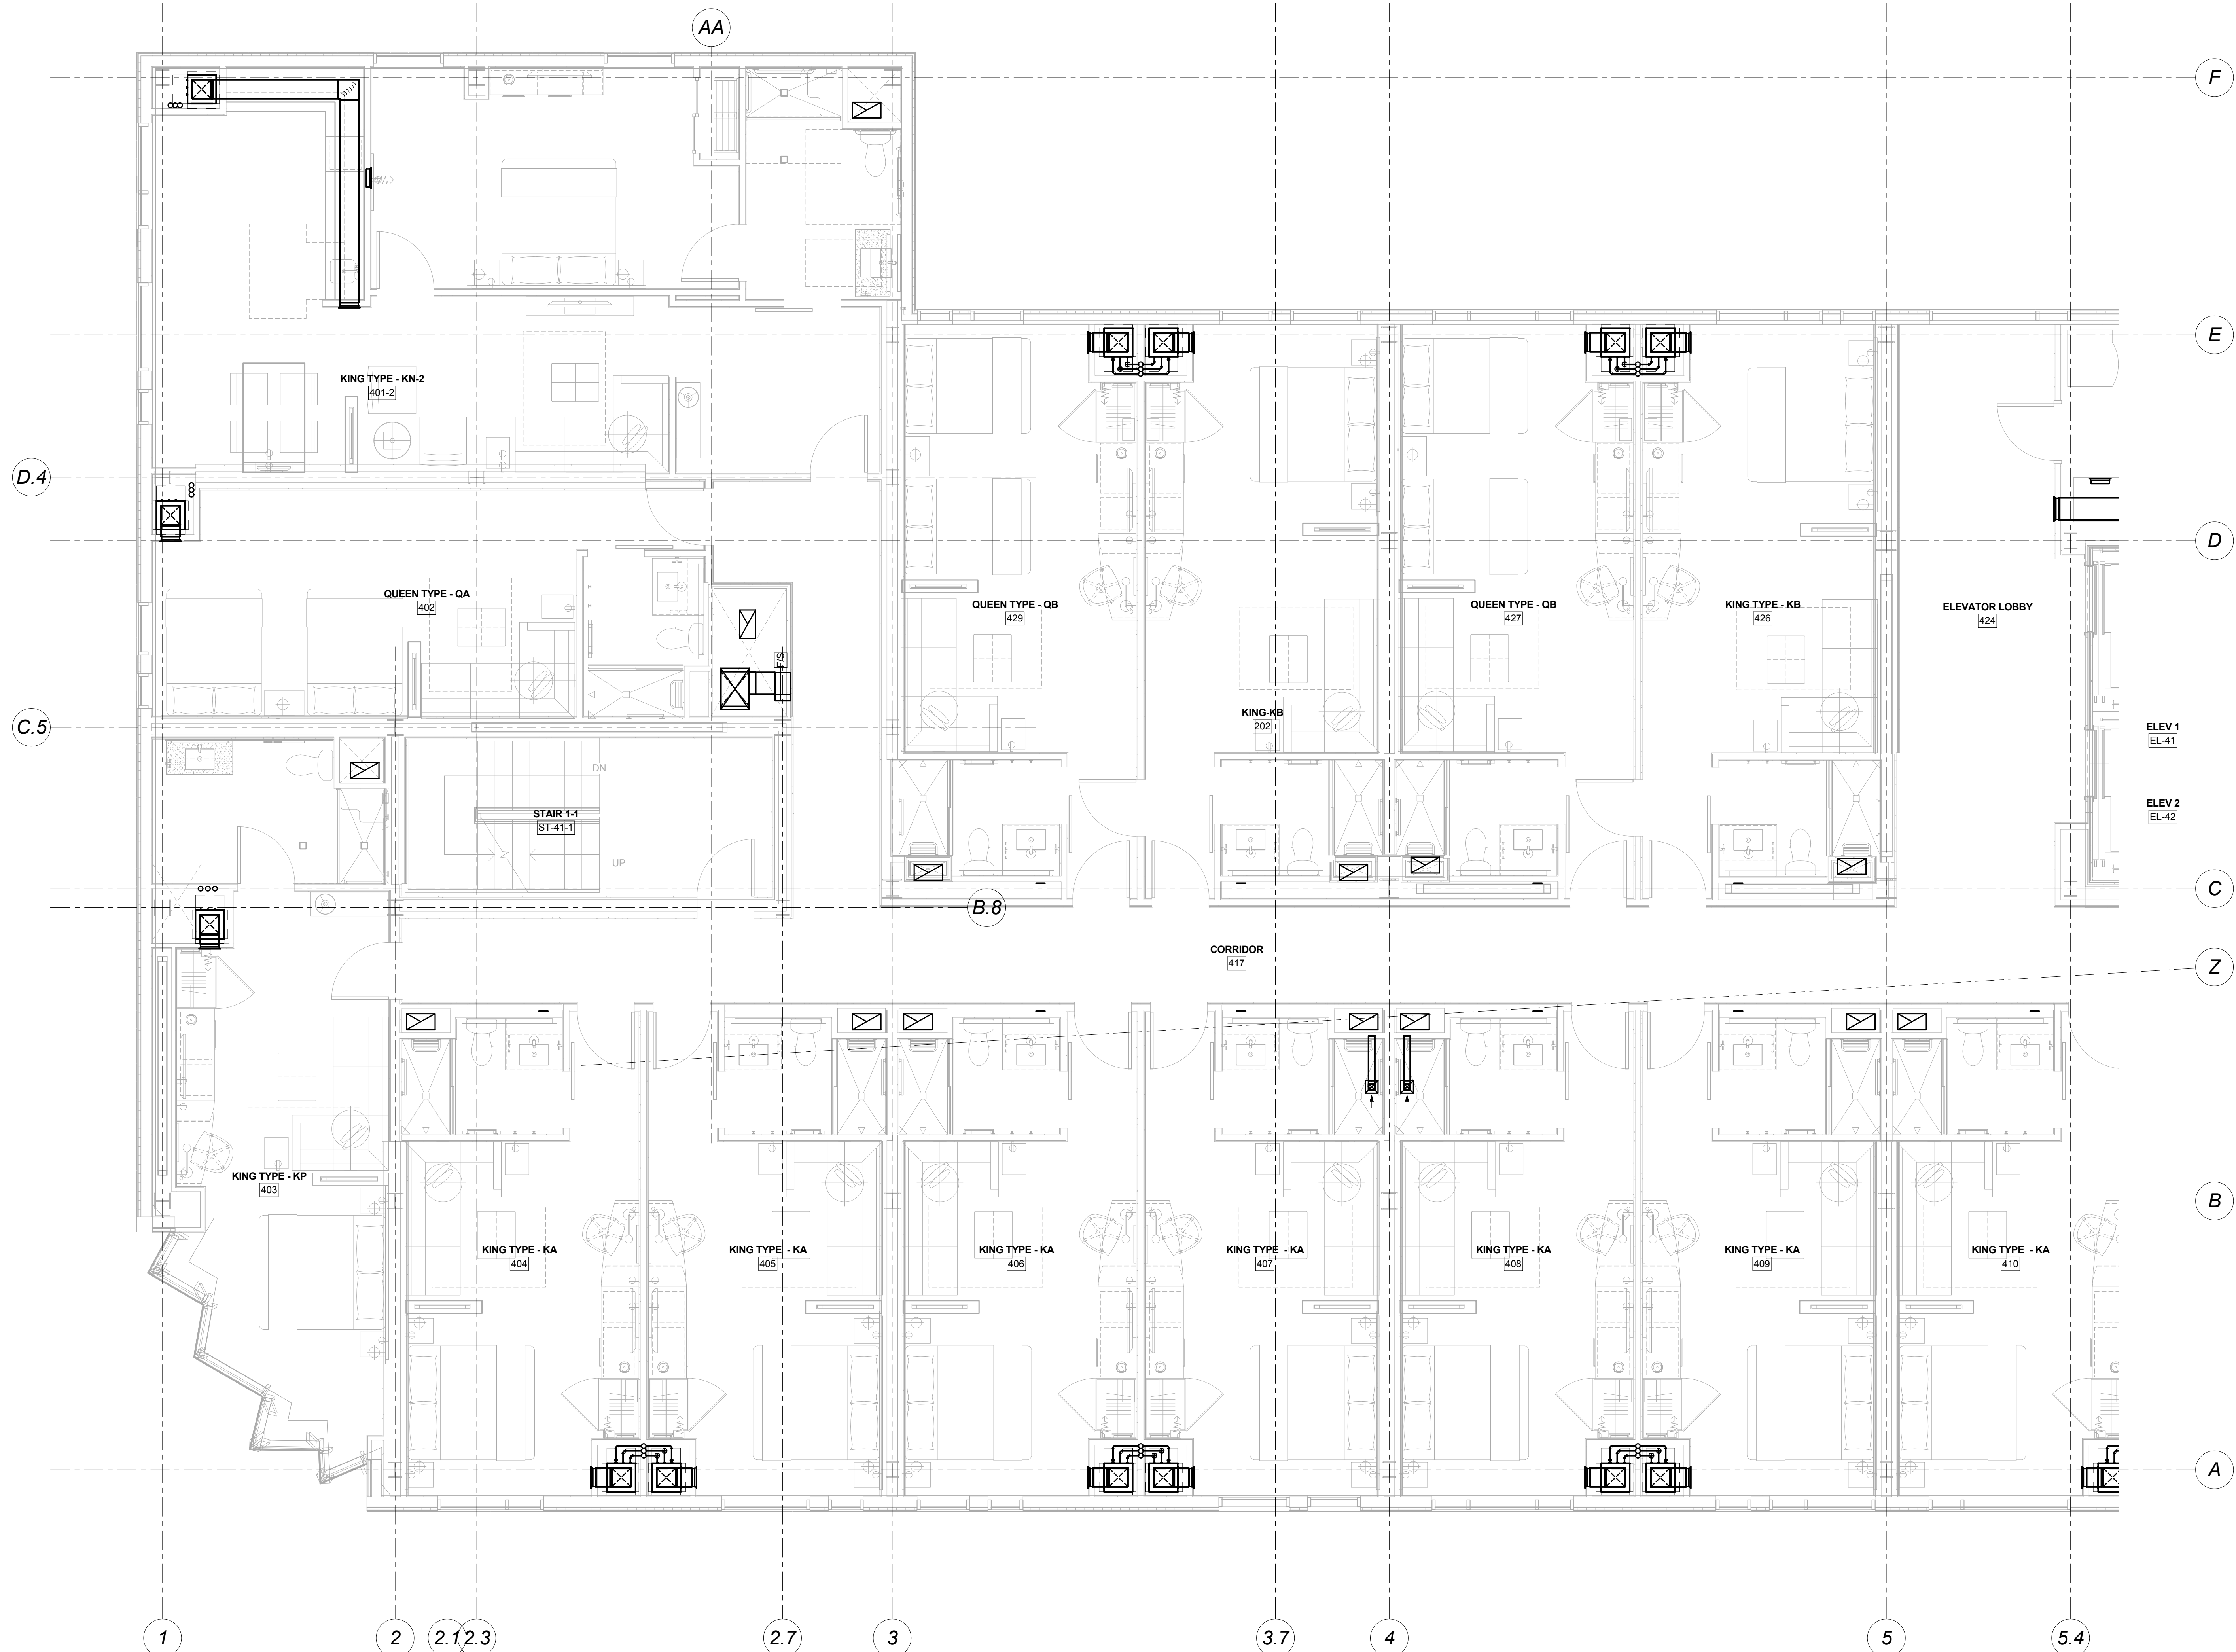


1 Fourth Floor HVAC Plan-Part A  
1/4" = 1'-0"



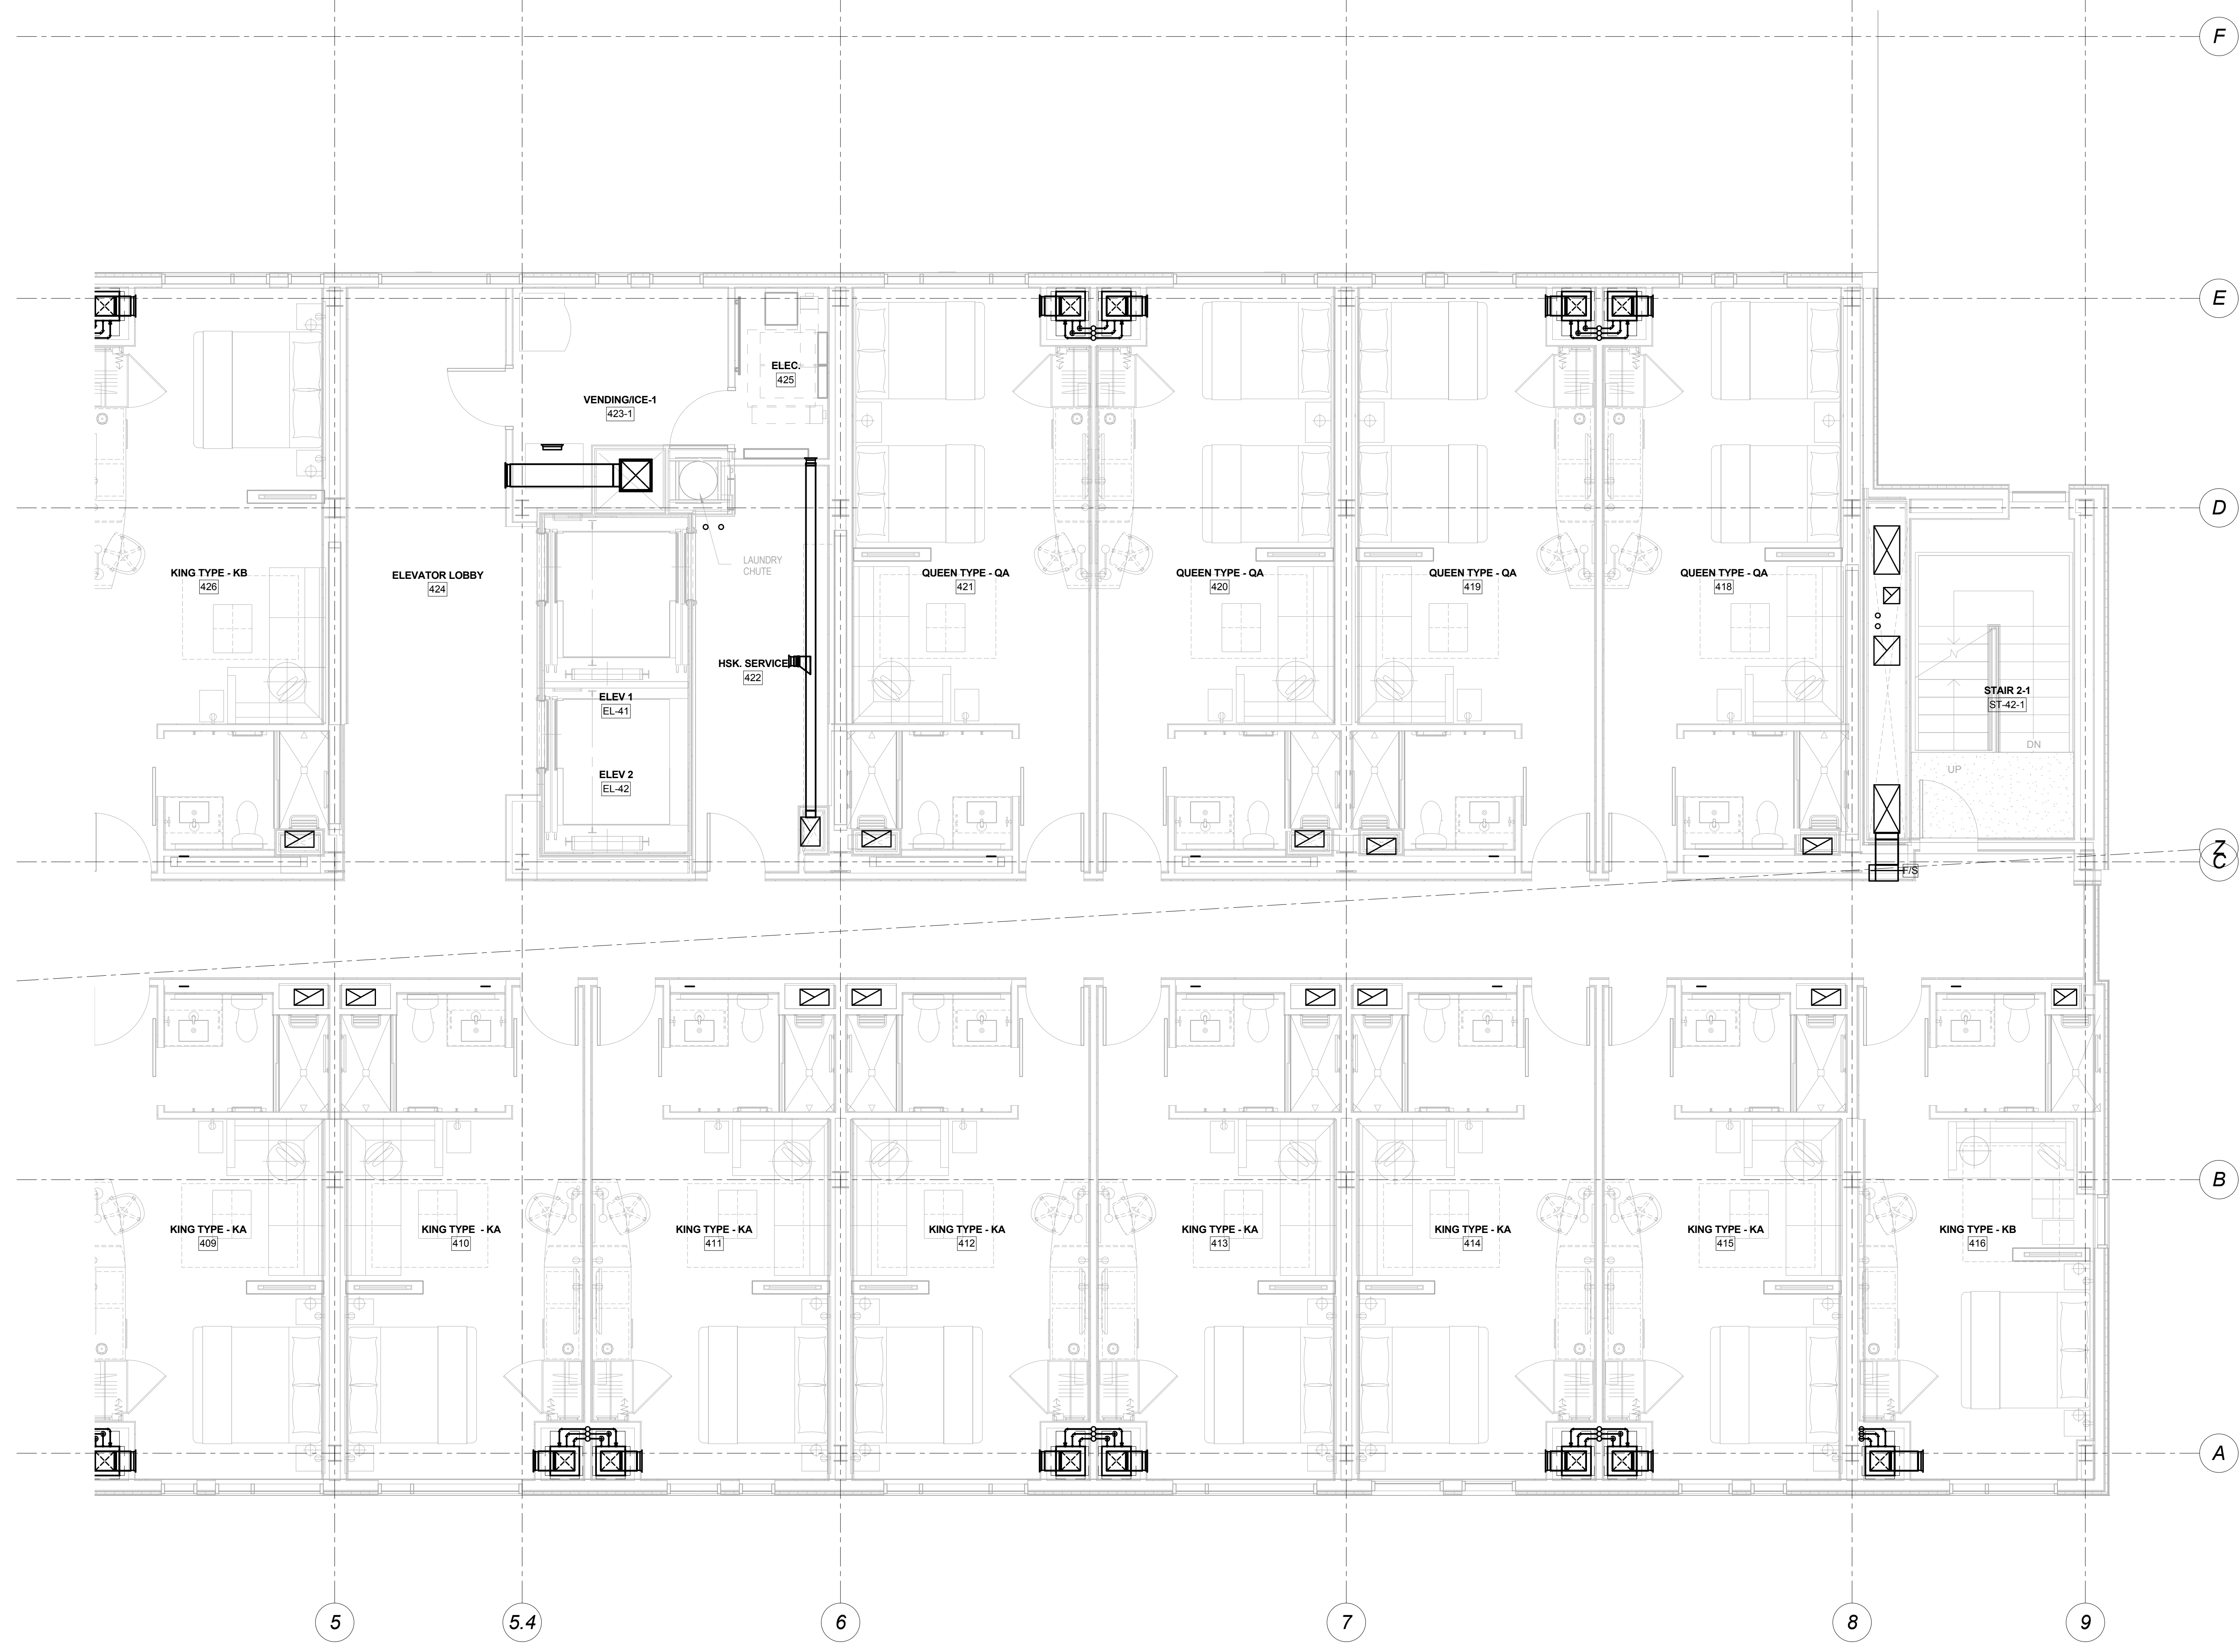

① Fourth Floor HVAC Plan-Part B  
 1/4" = 1'-0"

Mark	Date	Description
Project Status		
<b>DESIGN DEVELOPMENT</b>		
11-16-12		
Drawing Title		
<b>Fourth Floor HVAC Plan-Part B</b>		
Scale: 1/4" = 1'-0"		
Drawing Number		
<b>M10.4B</b>		

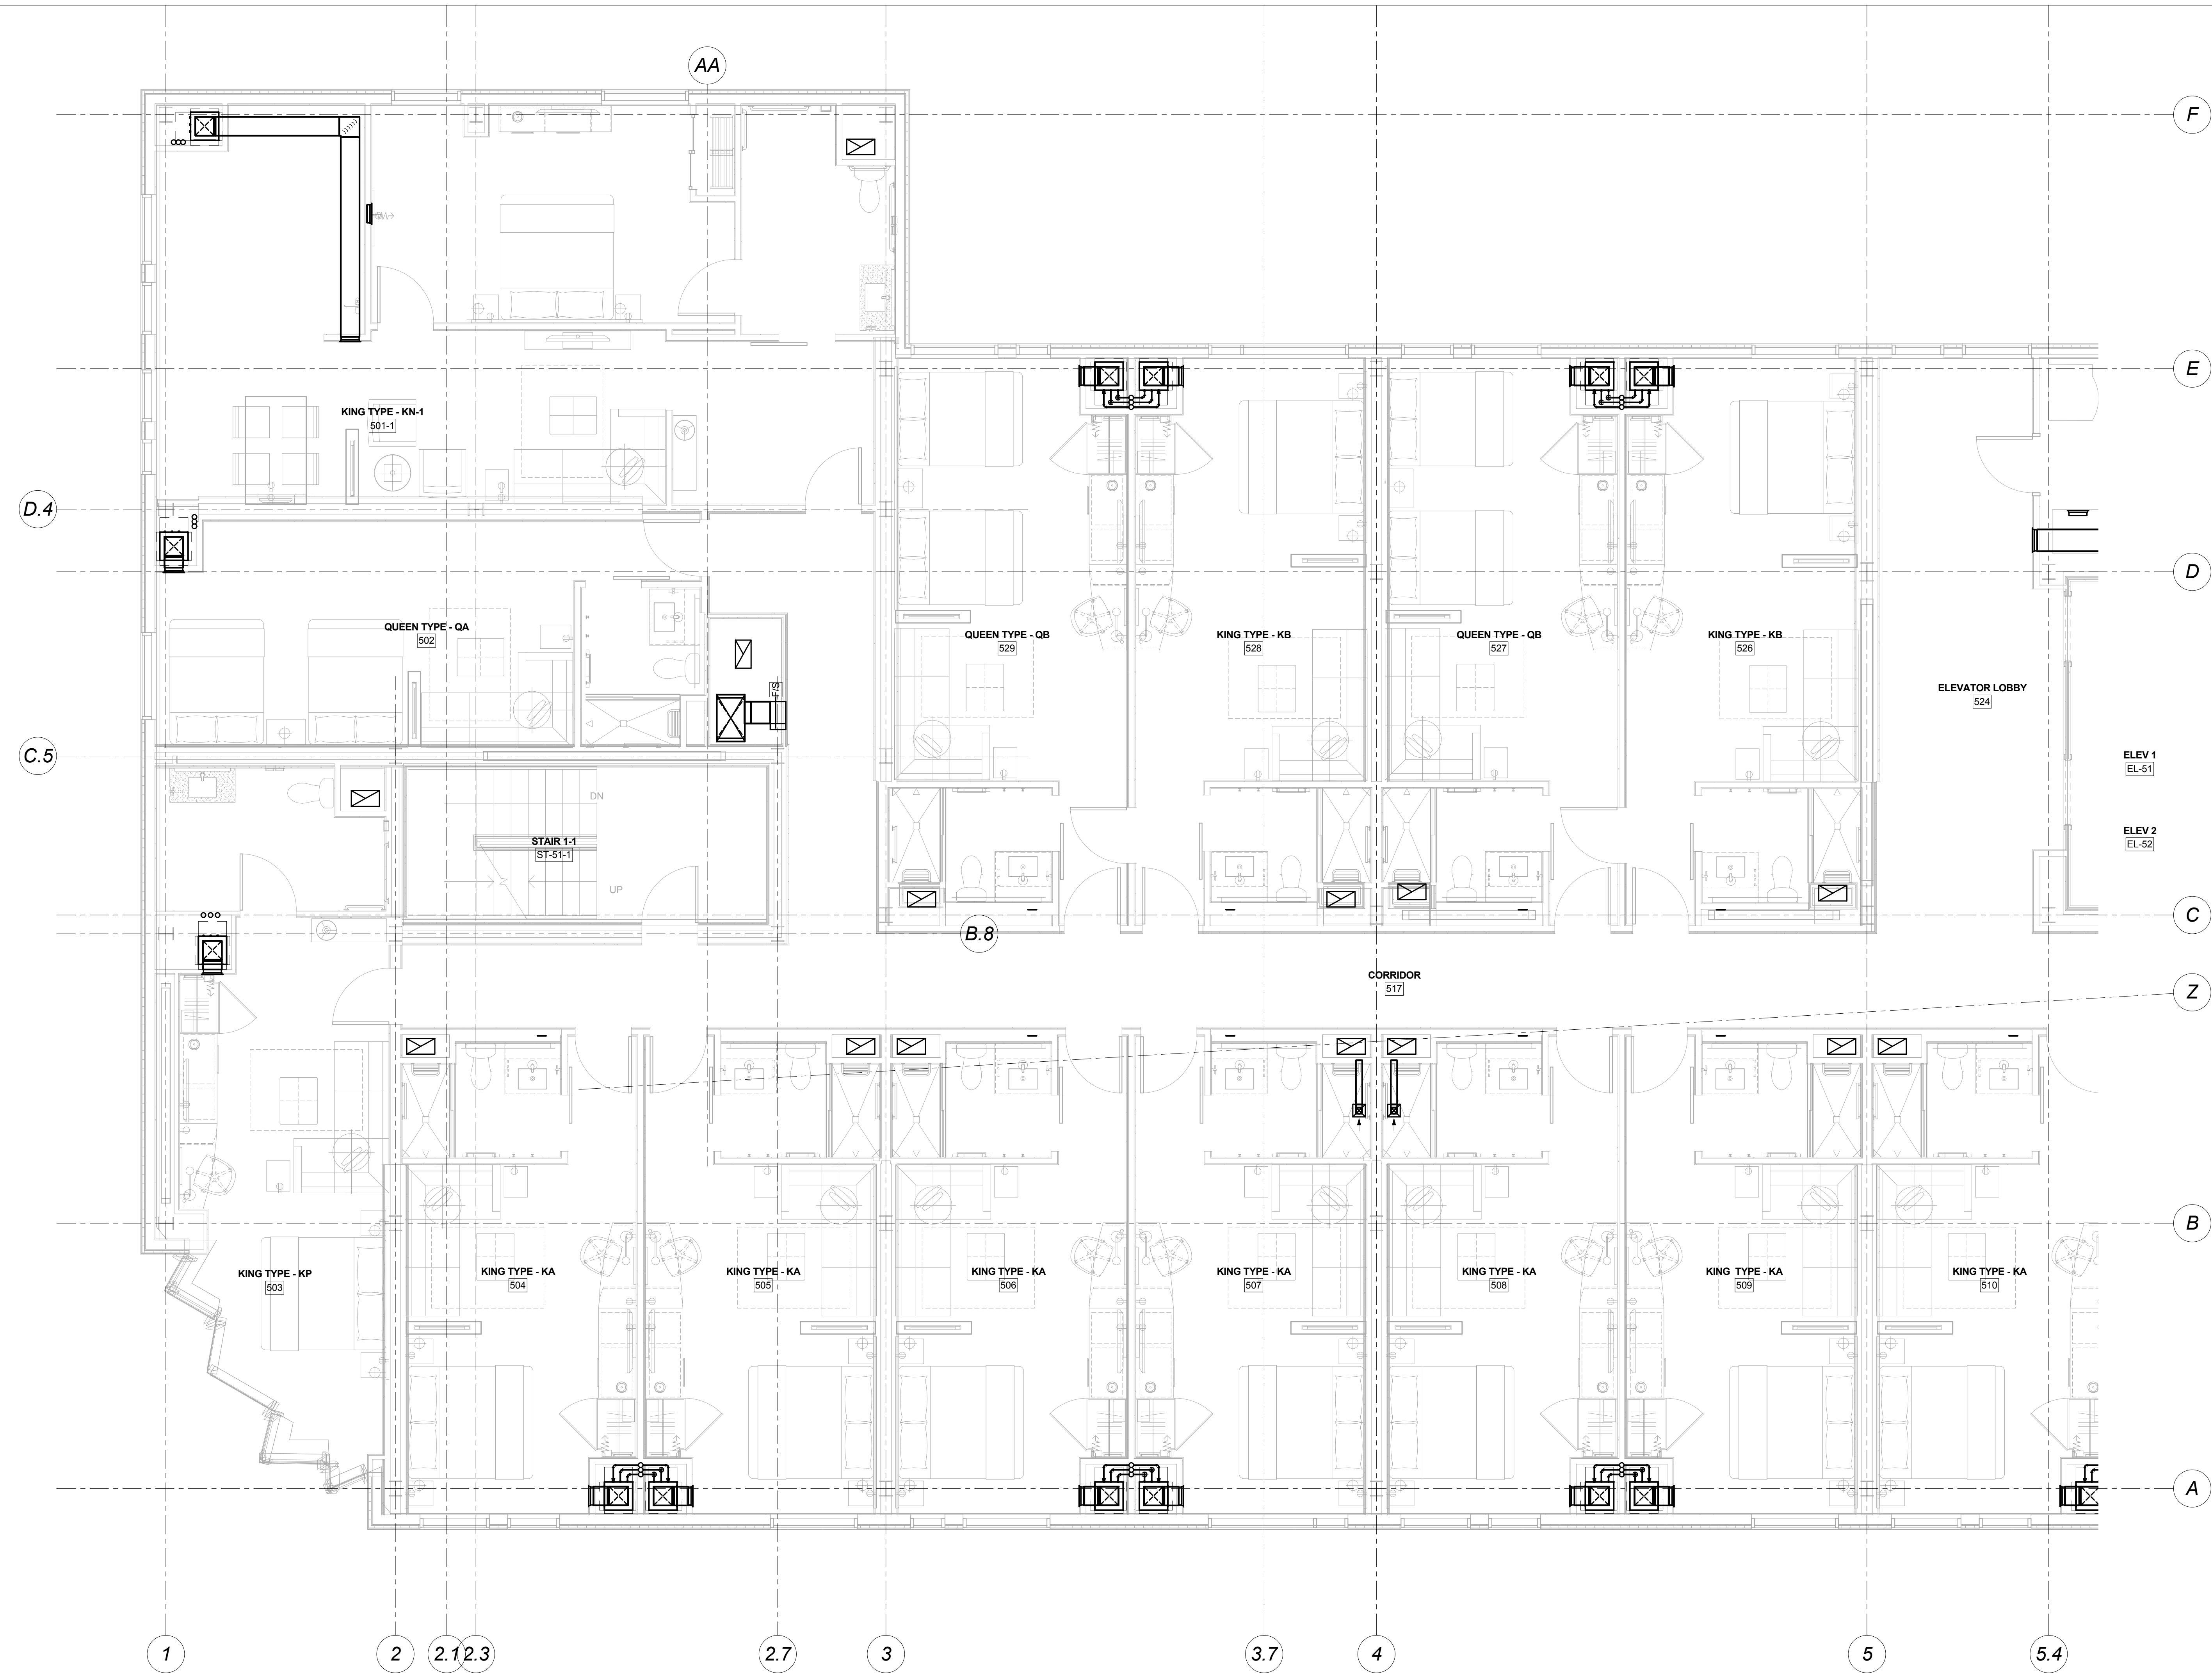

1 Fifth Floor HVAC Plan-Part A  
1/4" = 1'-0"

Mark	Date	Description
------	------	-------------

Project Status

**DESIGN  
DEVELOPMENT**  
11-16-12


Drawing Title

**Fifth Floor HVAC  
Plan-Part A**

Scale: 1/4" = 1'-0"

Drawing Number

**M10.5A**

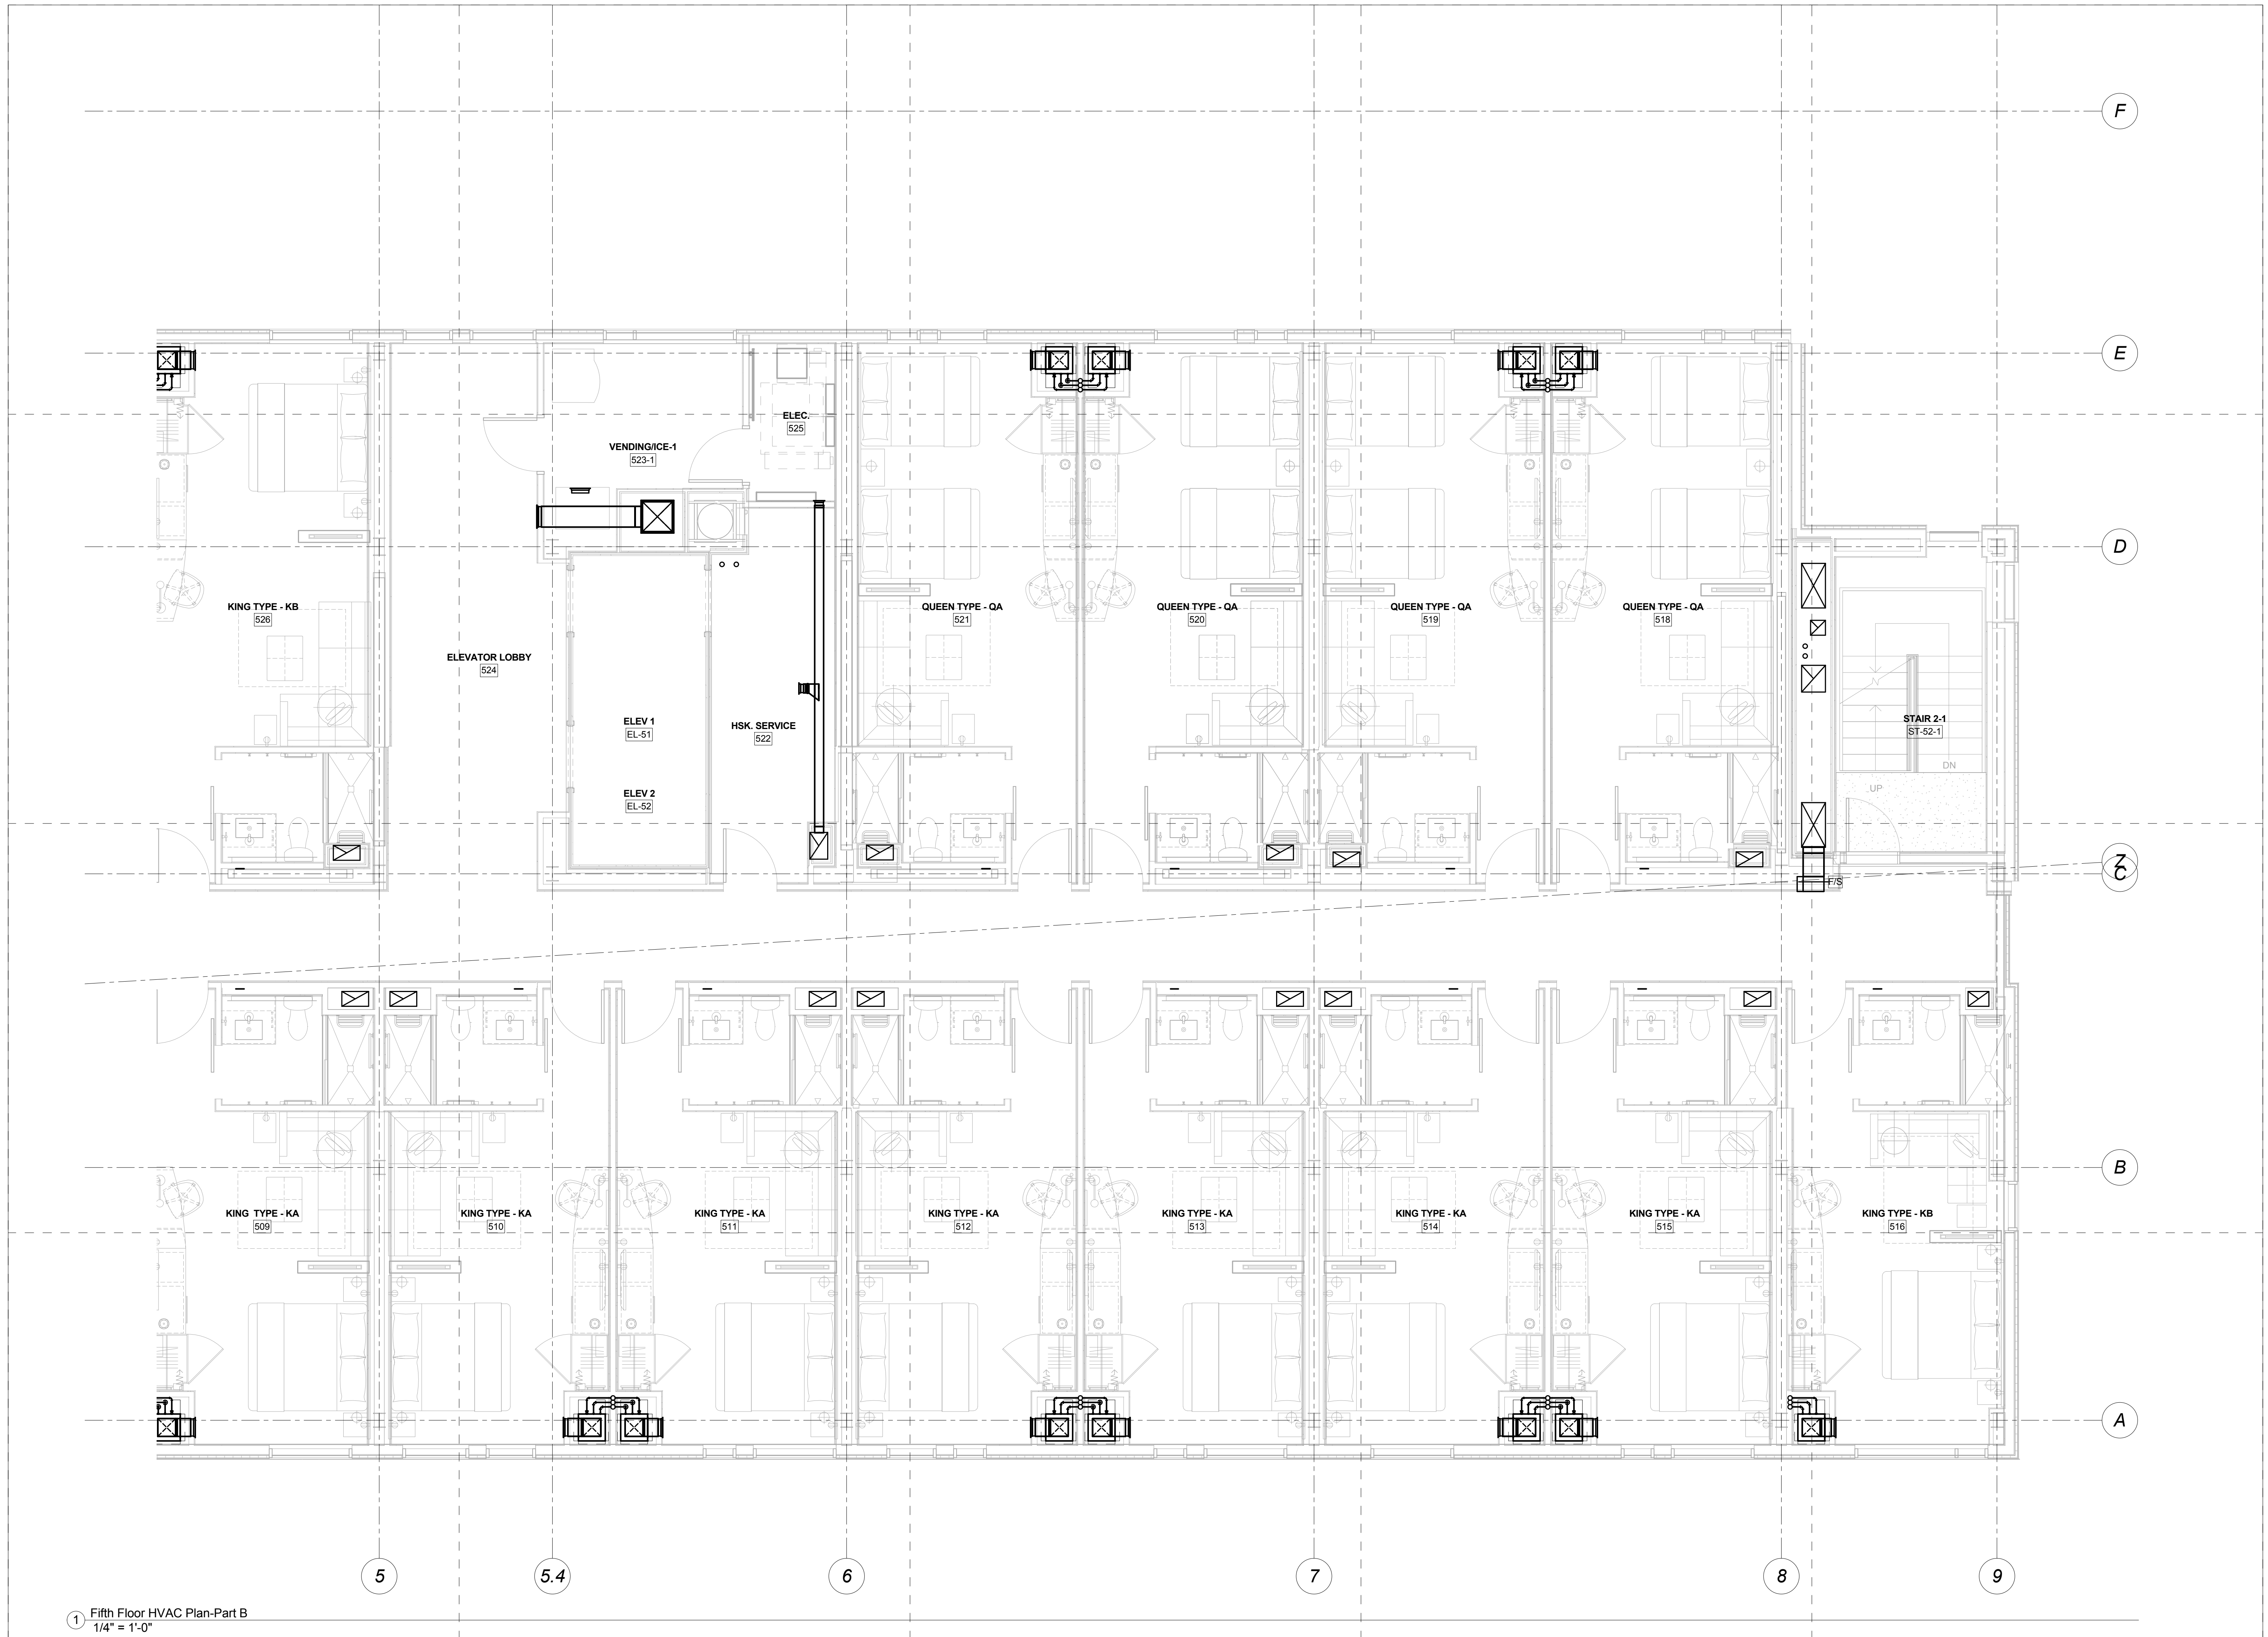

1 Fifth Floor HVAC Plan-Part B  
1/4" = 1'-0"

Mark	Date	Description
Project Status		
		<b>DESIGN DEVELOPMENT</b> 11-16-12


Drawing Title  
**Fifth Floor HVAC  
Plan-Part B**

Scale: 1/4" = 1'-0"


Drawing Number  
**M10.5B**

Mark	Date	Description
Project Status		
<b>DESIGN DEVELOPMENT</b>		
11-16-12		
Drawing Title		
<b>Sixth Floor HVAC Plan-Part A</b>		
Scale: 1/4" = 1'-0"		
Drawing Number		

**M10.6A**

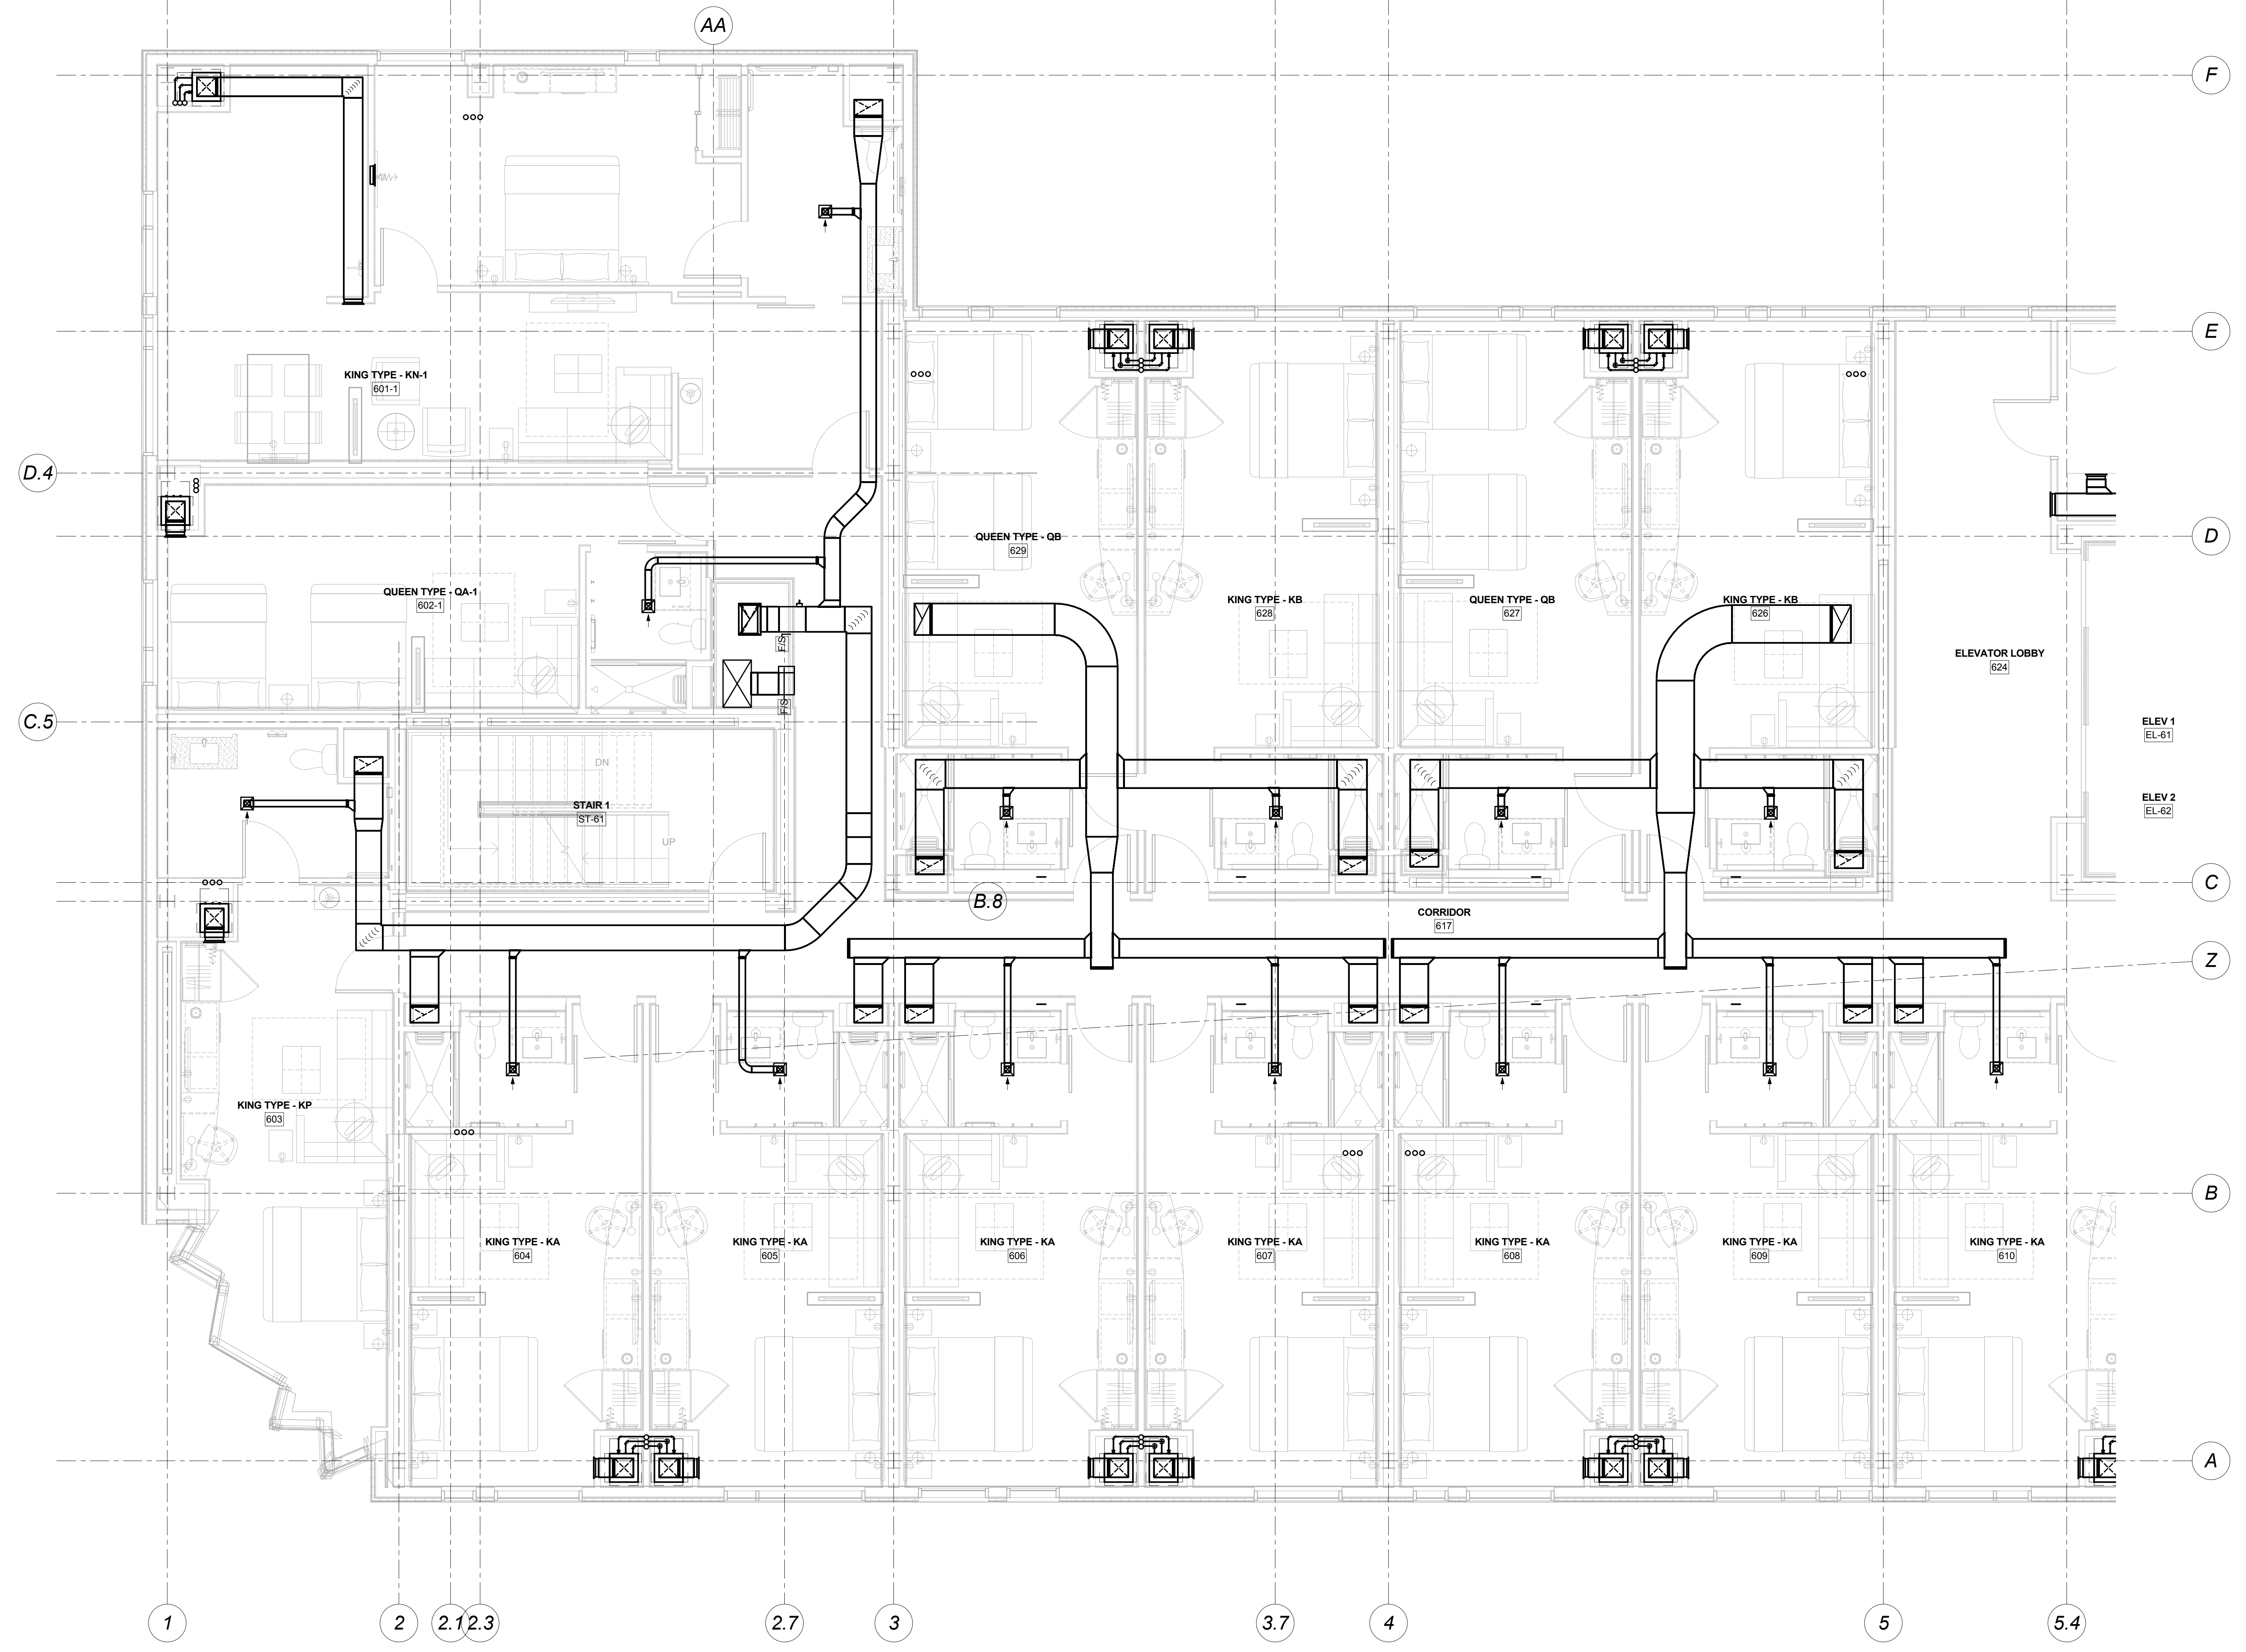


1 Sixth Floor HVAC Plan-Part A  
 1/4" = 1'-0"

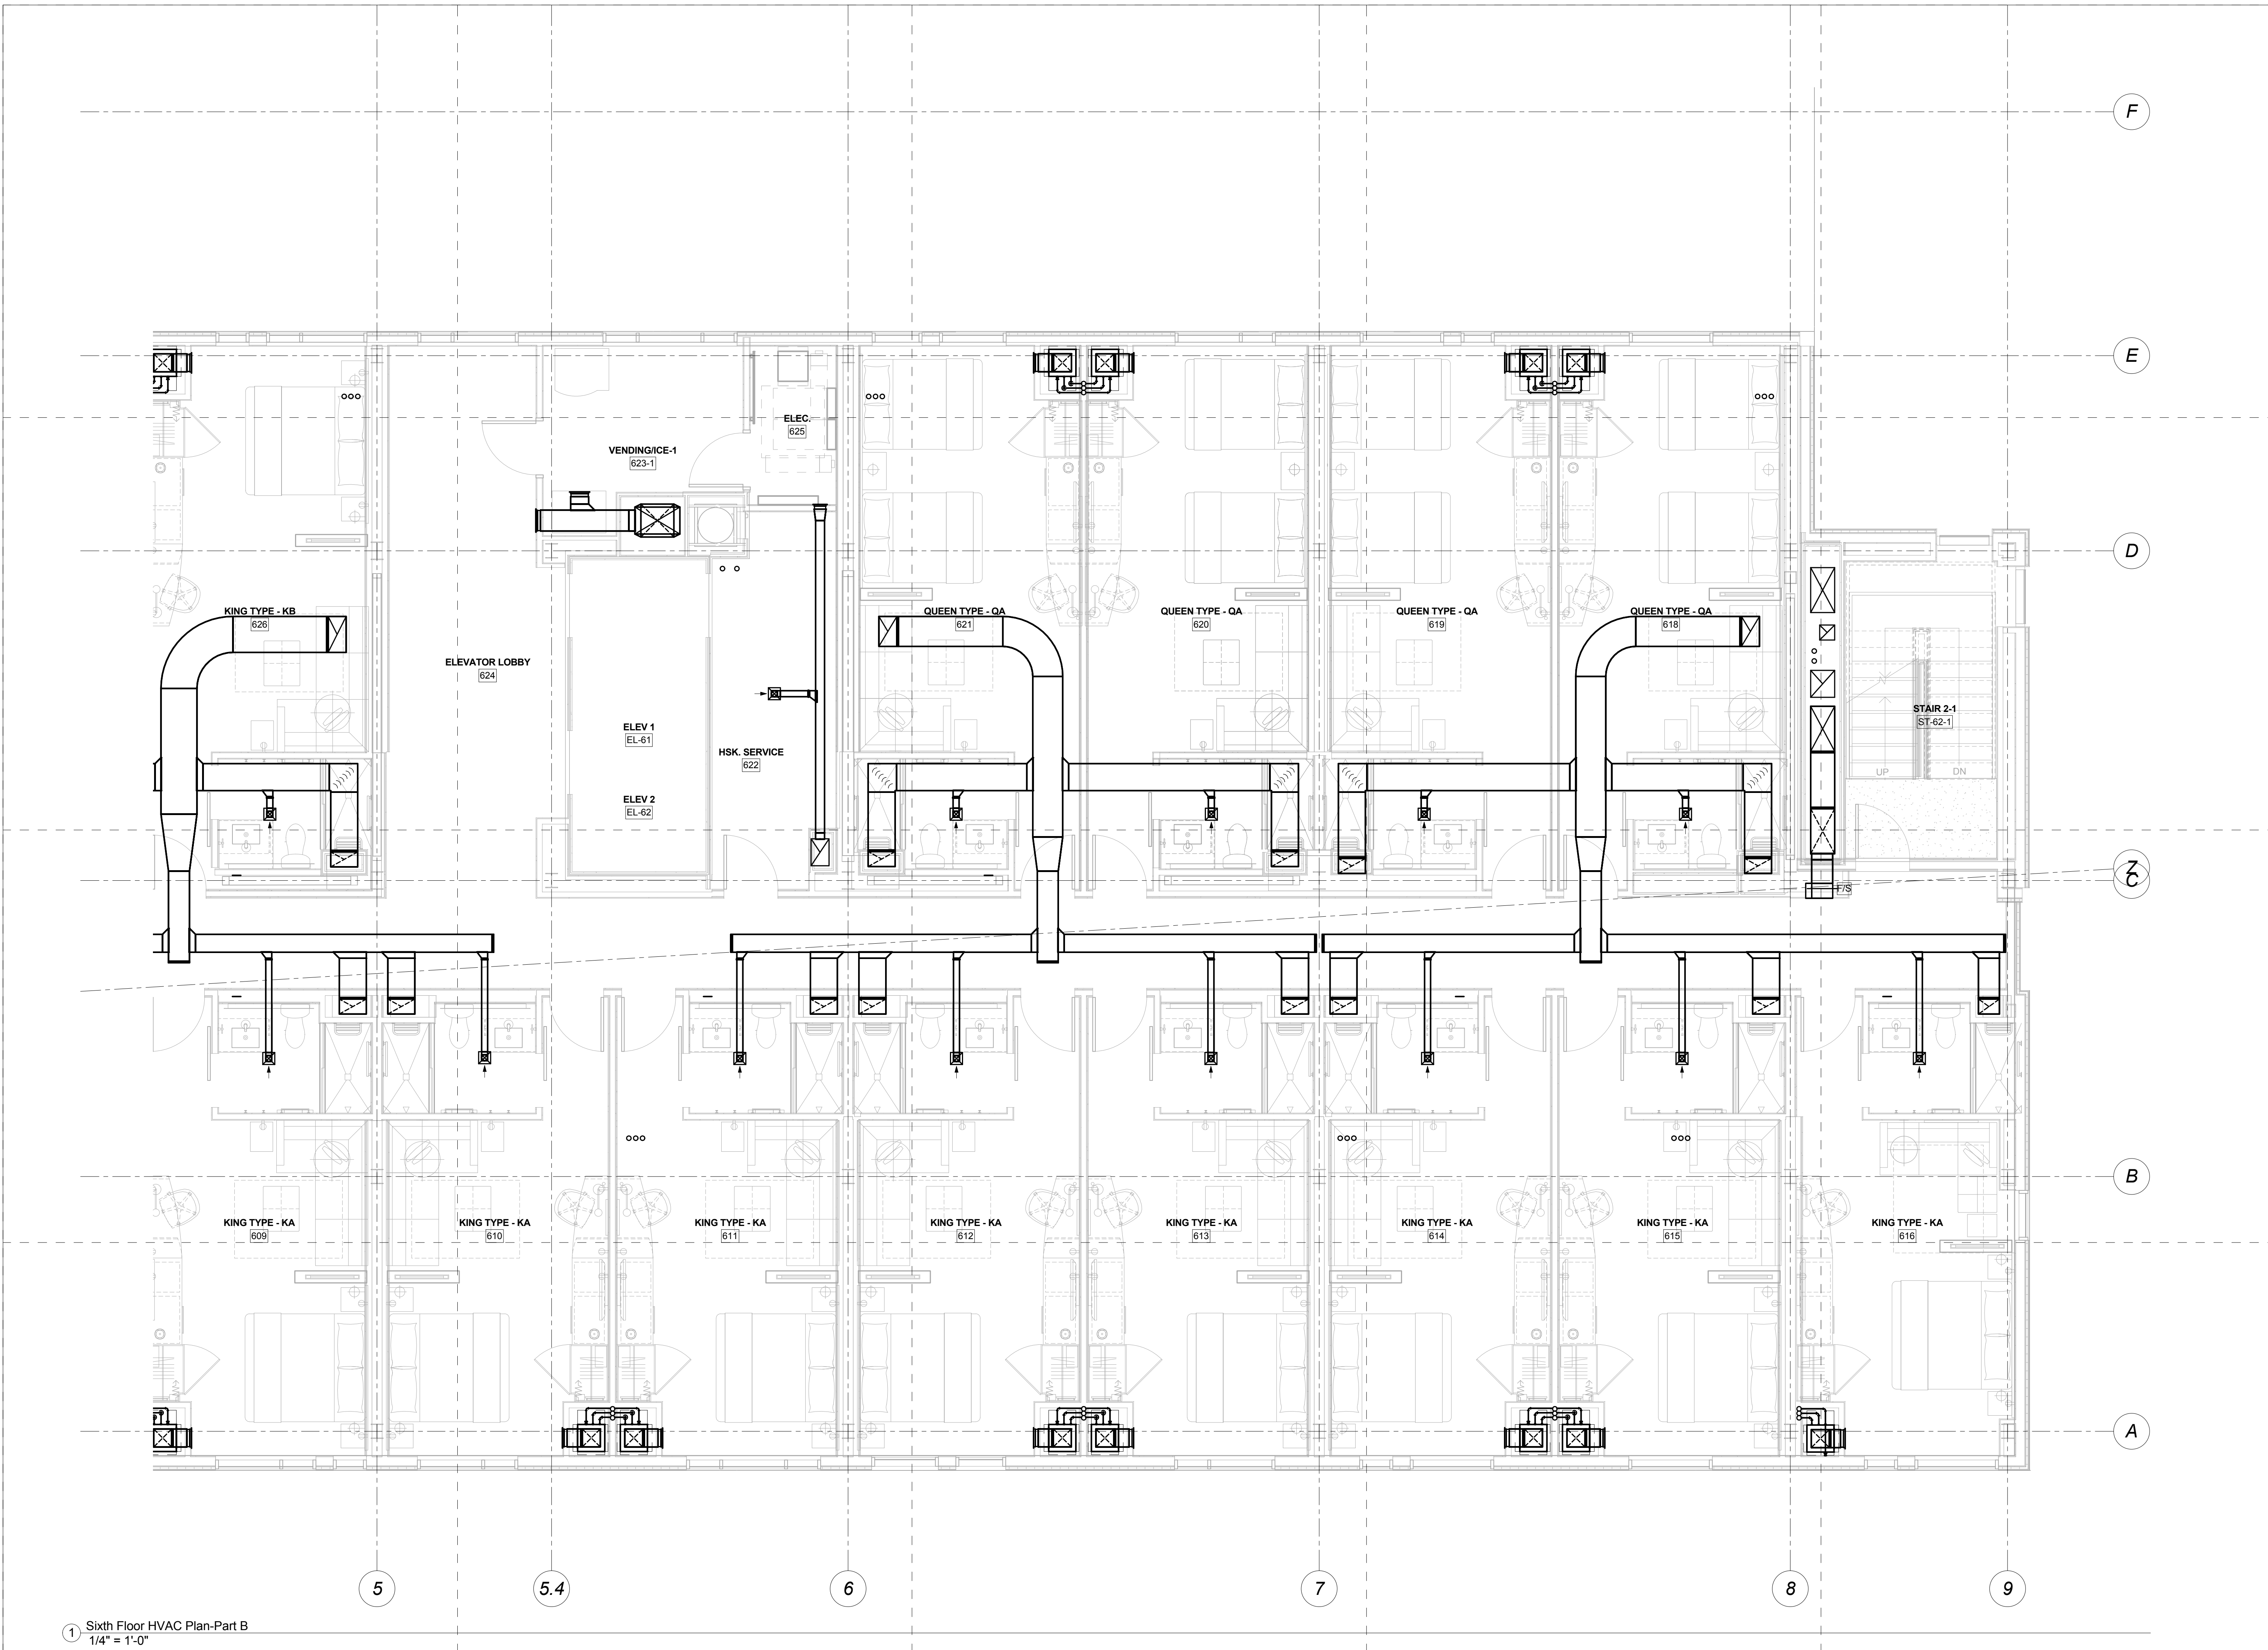

1 Sixth Floor HVAC Plan-Part B  
 1/4" = 1'-0"

Mark	Date	Description
Project Status		
<b>DESIGN DEVELOPMENT</b>		
11-16-12		
Drawing Title		
<b>Sixth Floor HVAC Plan-Part B</b>		
Scale: 1/4" = 1'-0"		
Drawing Number		
<b>M10.6B</b>		

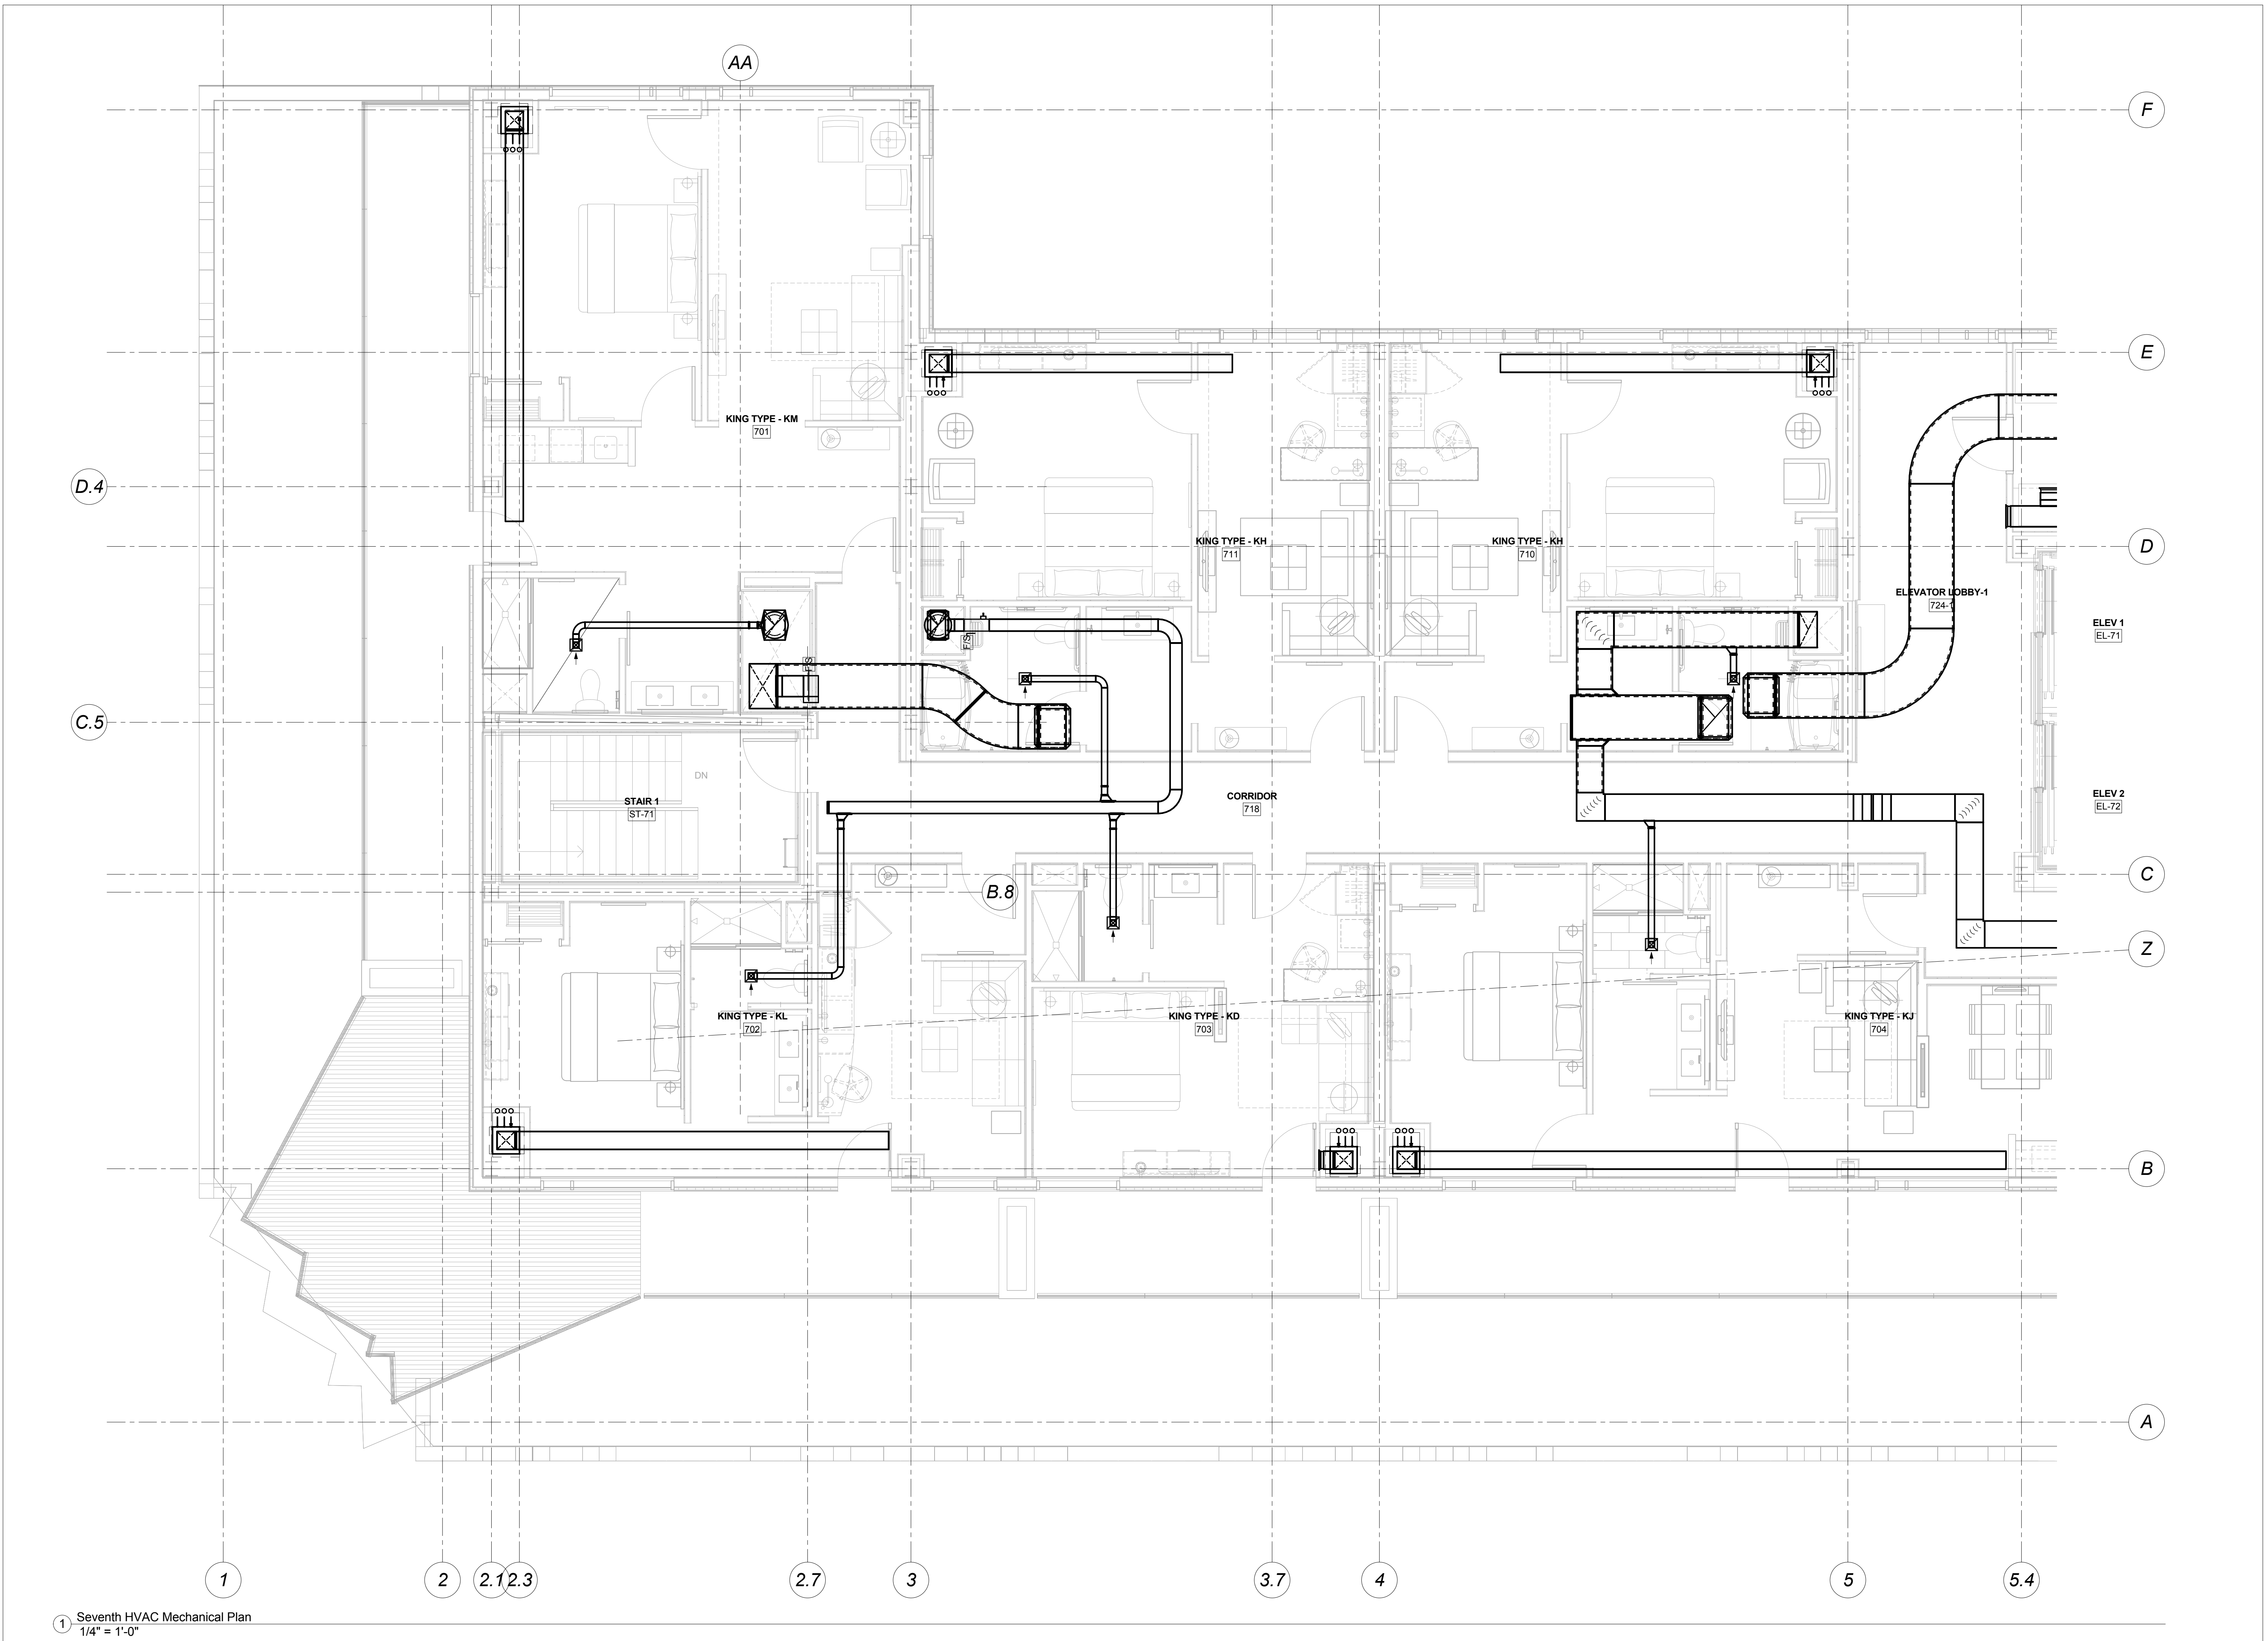

1 Seventh HVAC Mechanical Plan  
1/4" = 1'-0"

**CANAL STUDIO**  
Architecture / Planning / Interior Design  
207 553 2115  
One Canal Plaza, Suite 888  
Portland, Maine 04101  
canalstudio.com

**EAST BROWN COW**  
MANAGEMENT, INC.

**shinberg**  
CONSULTING, LLC

Project Title  
**Hyatt Place,  
Portland-Old Port**  
433 Fore Street  
Portland, ME  
CSS Project No. 12013

**BENNETT**  
ENGINEERING  
MECHANICAL • ELECTRICAL  
(207) 865-9475


Mark	Date	Description
Project Status		
<b>DESIGN DEVELOPMENT</b>		
11-16-12		
Drawing Title		
<b>Seventh Floor HVAC Plan-Part A</b>		
Scale: 1/4" = 1'-0"		
Drawing Number		
<b>M10.7A</b>		

Mark	Date	Description
Project Status		
<b>DESIGN DEVELOPMENT</b>		
11-16-12		


Drawing Title  
**Seventh Floor  
 HVAC Plan-Part B**

Scale: 1/4" = 1'-0"

Drawing Number  
**M10.7B**

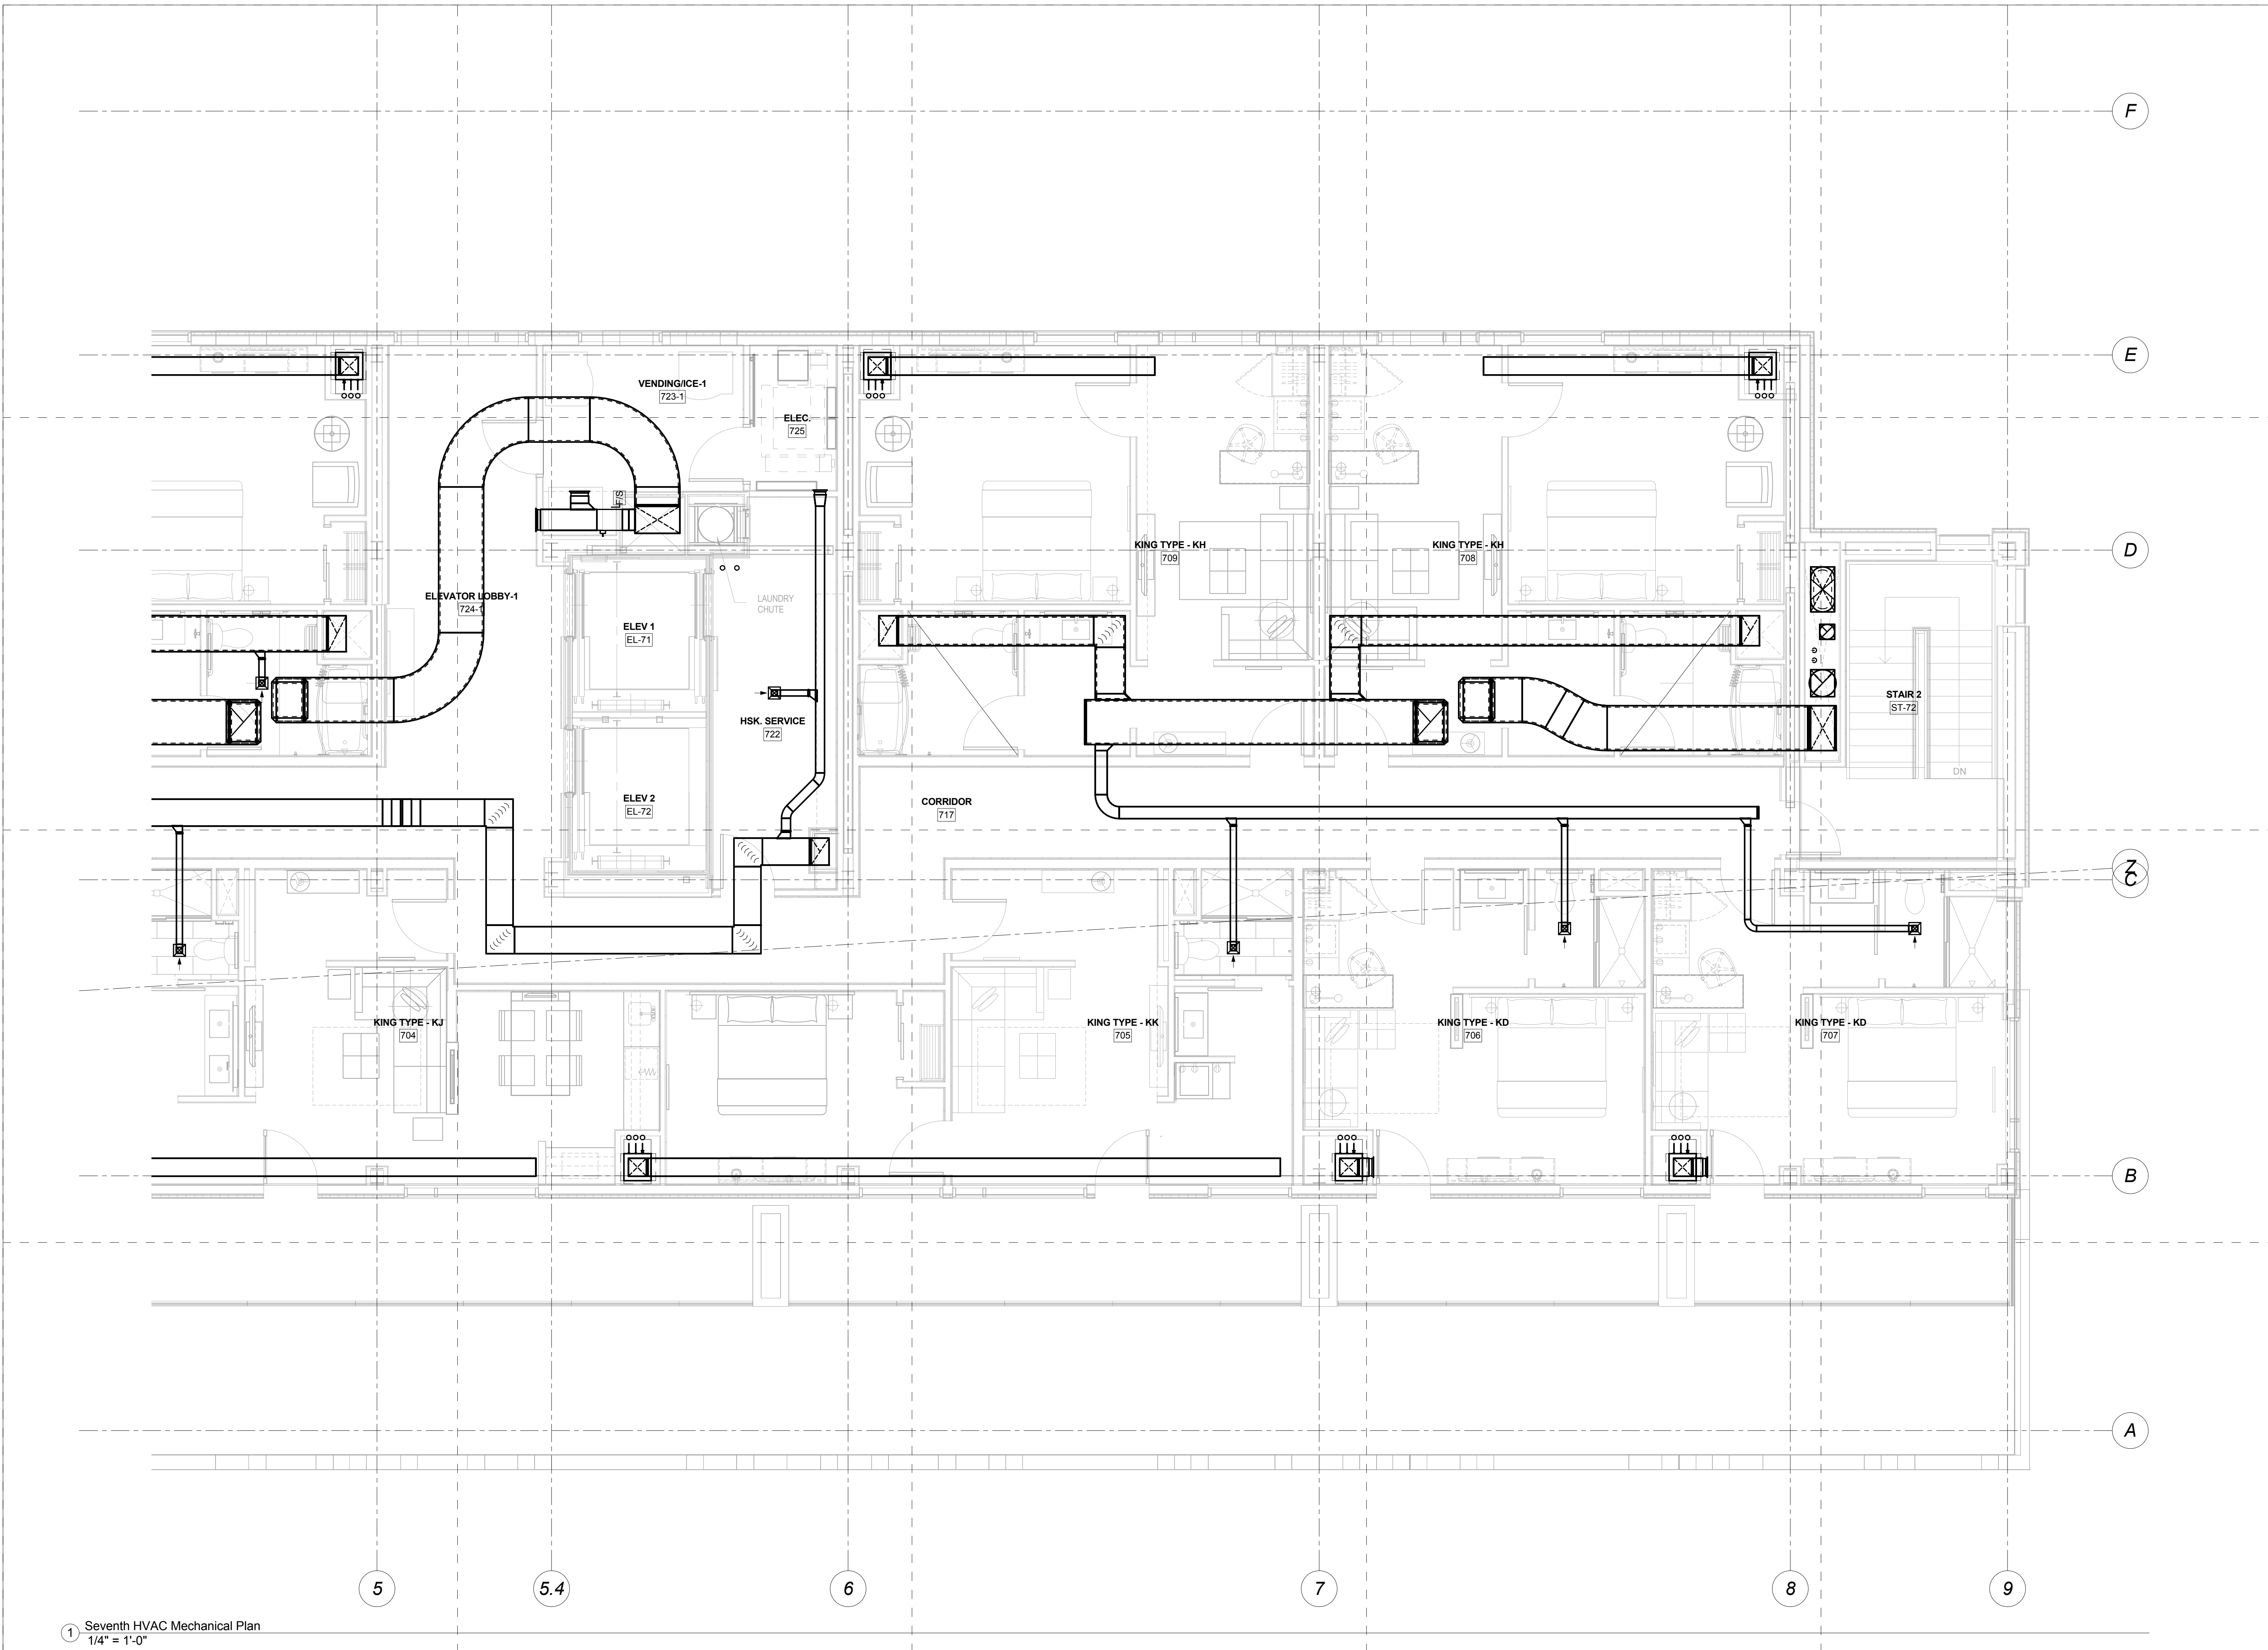

① Seventh HVAC Mechanical Plan  
 1/4" = 1'-0"

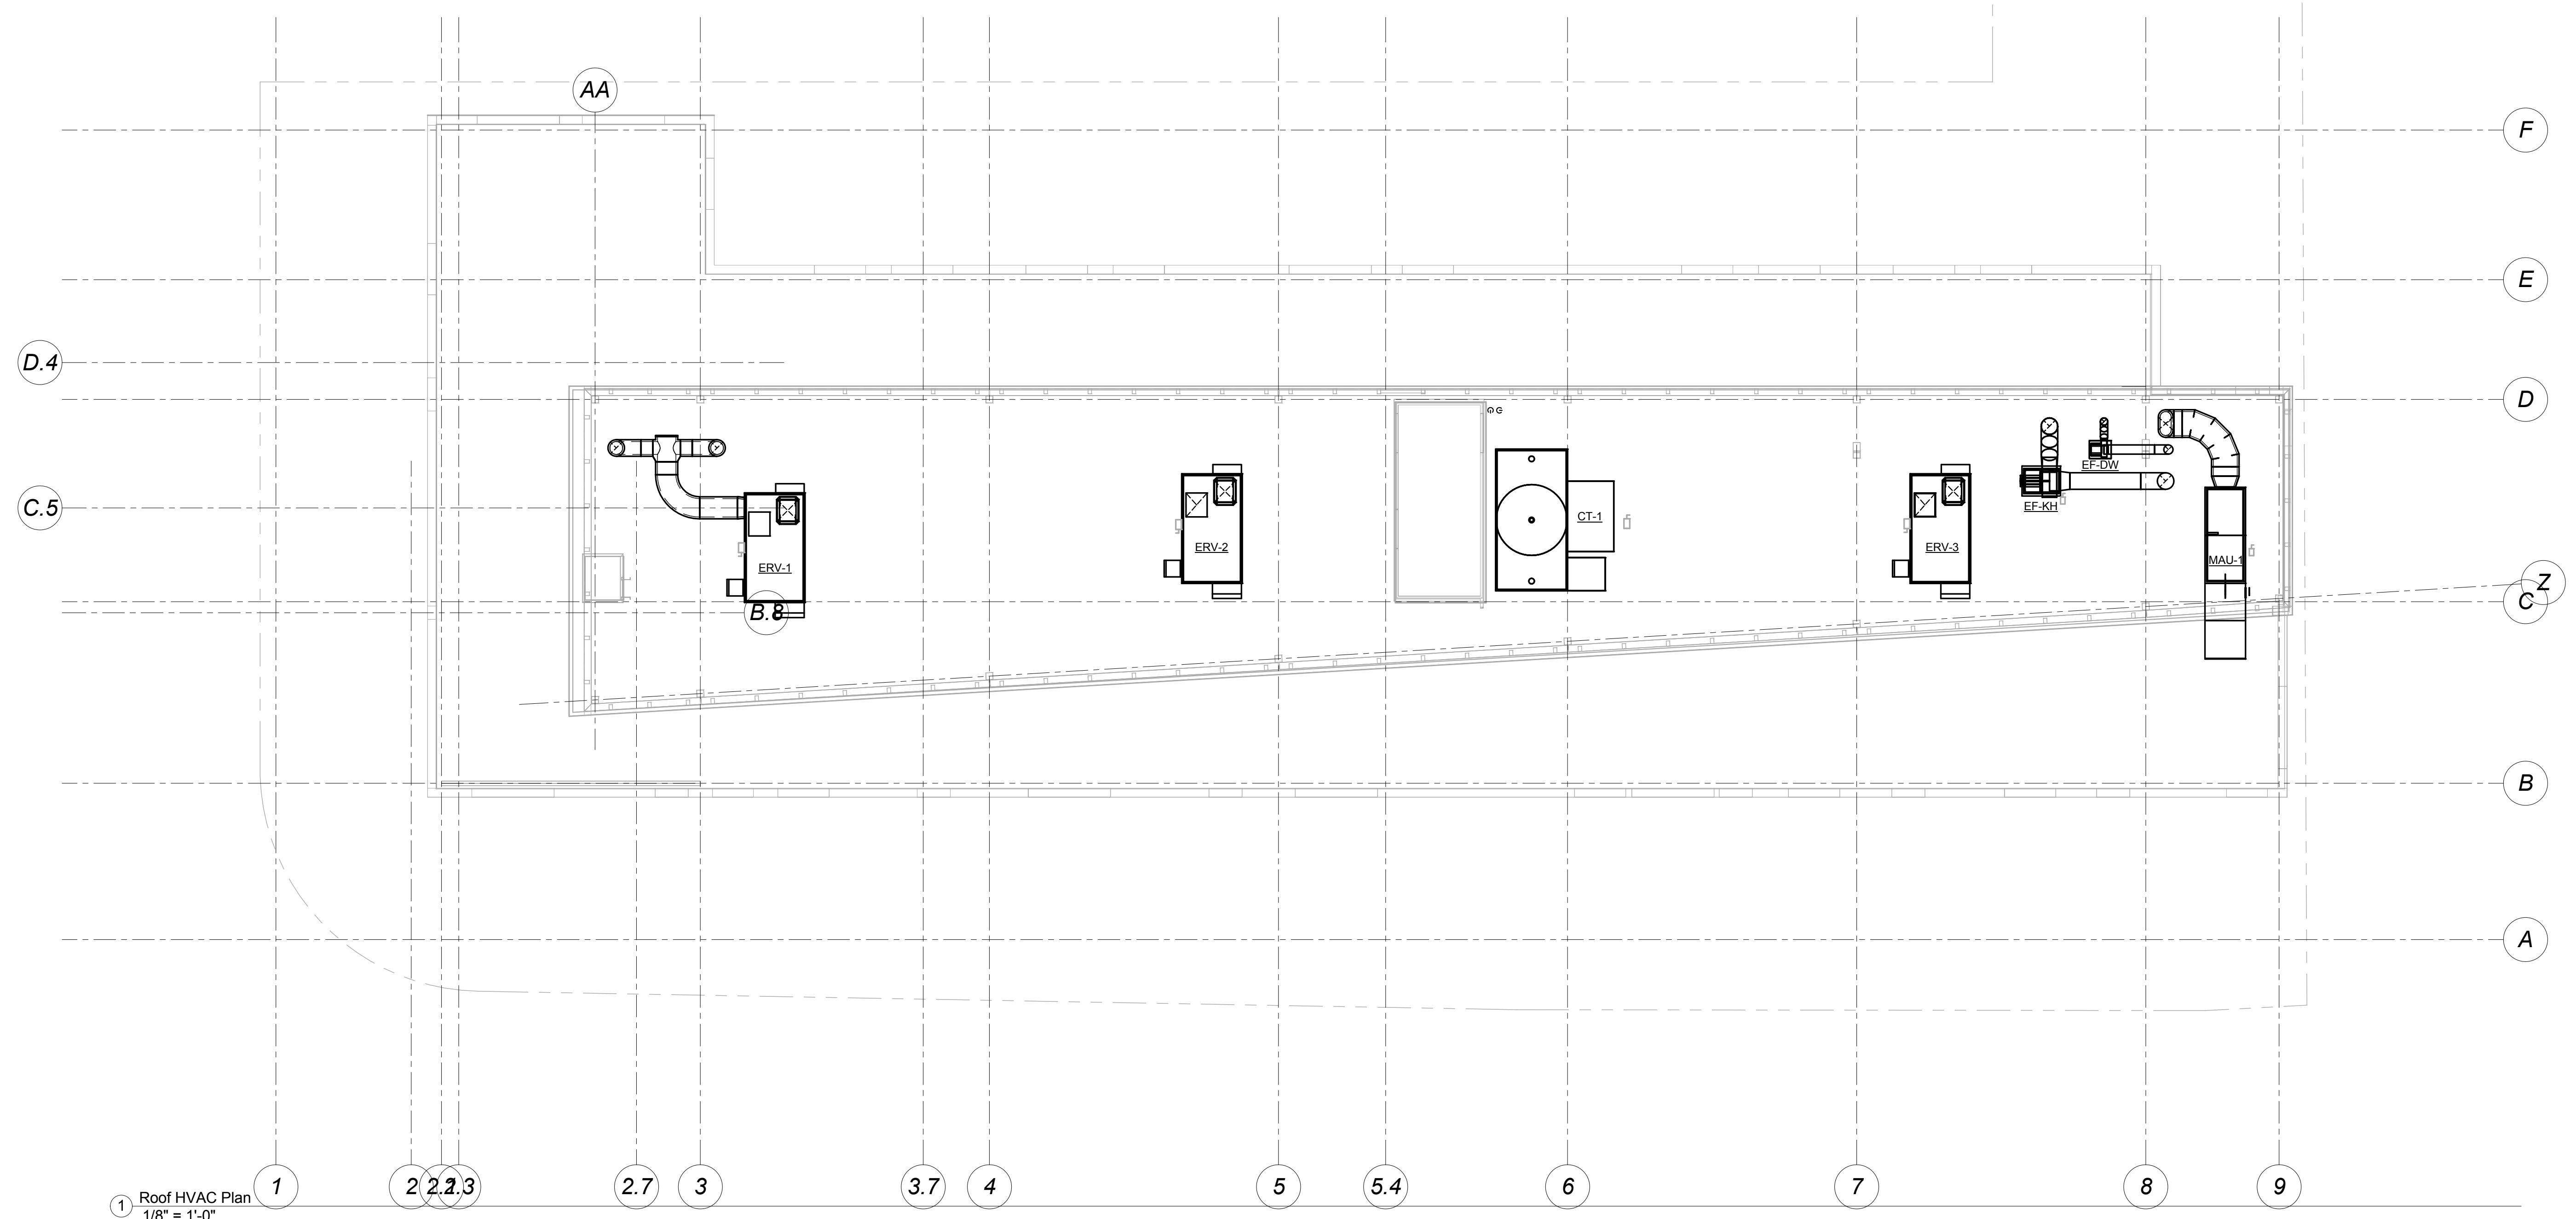

Mark	Date	Description

Project Status  
**DESIGN  
 DEVELOPMENT**  
 11-16-12

Drawing Title  
**Roof HVAC Plan**

Scale: 1/8" = 1'-0"

Drawing Number  
**M10.8**