


Mark	Date	Description
Project Status		
DESIGN DEVELOPMENT		
11-16-12		
Drawing Title		
First Floor Plumbing-Part A		
Scale: 1/4" = 1'-0"		
Drawing Number		
M20.1A		

1 First Floor Plumbing Plan-Part A
 1/4" = 1'-0"

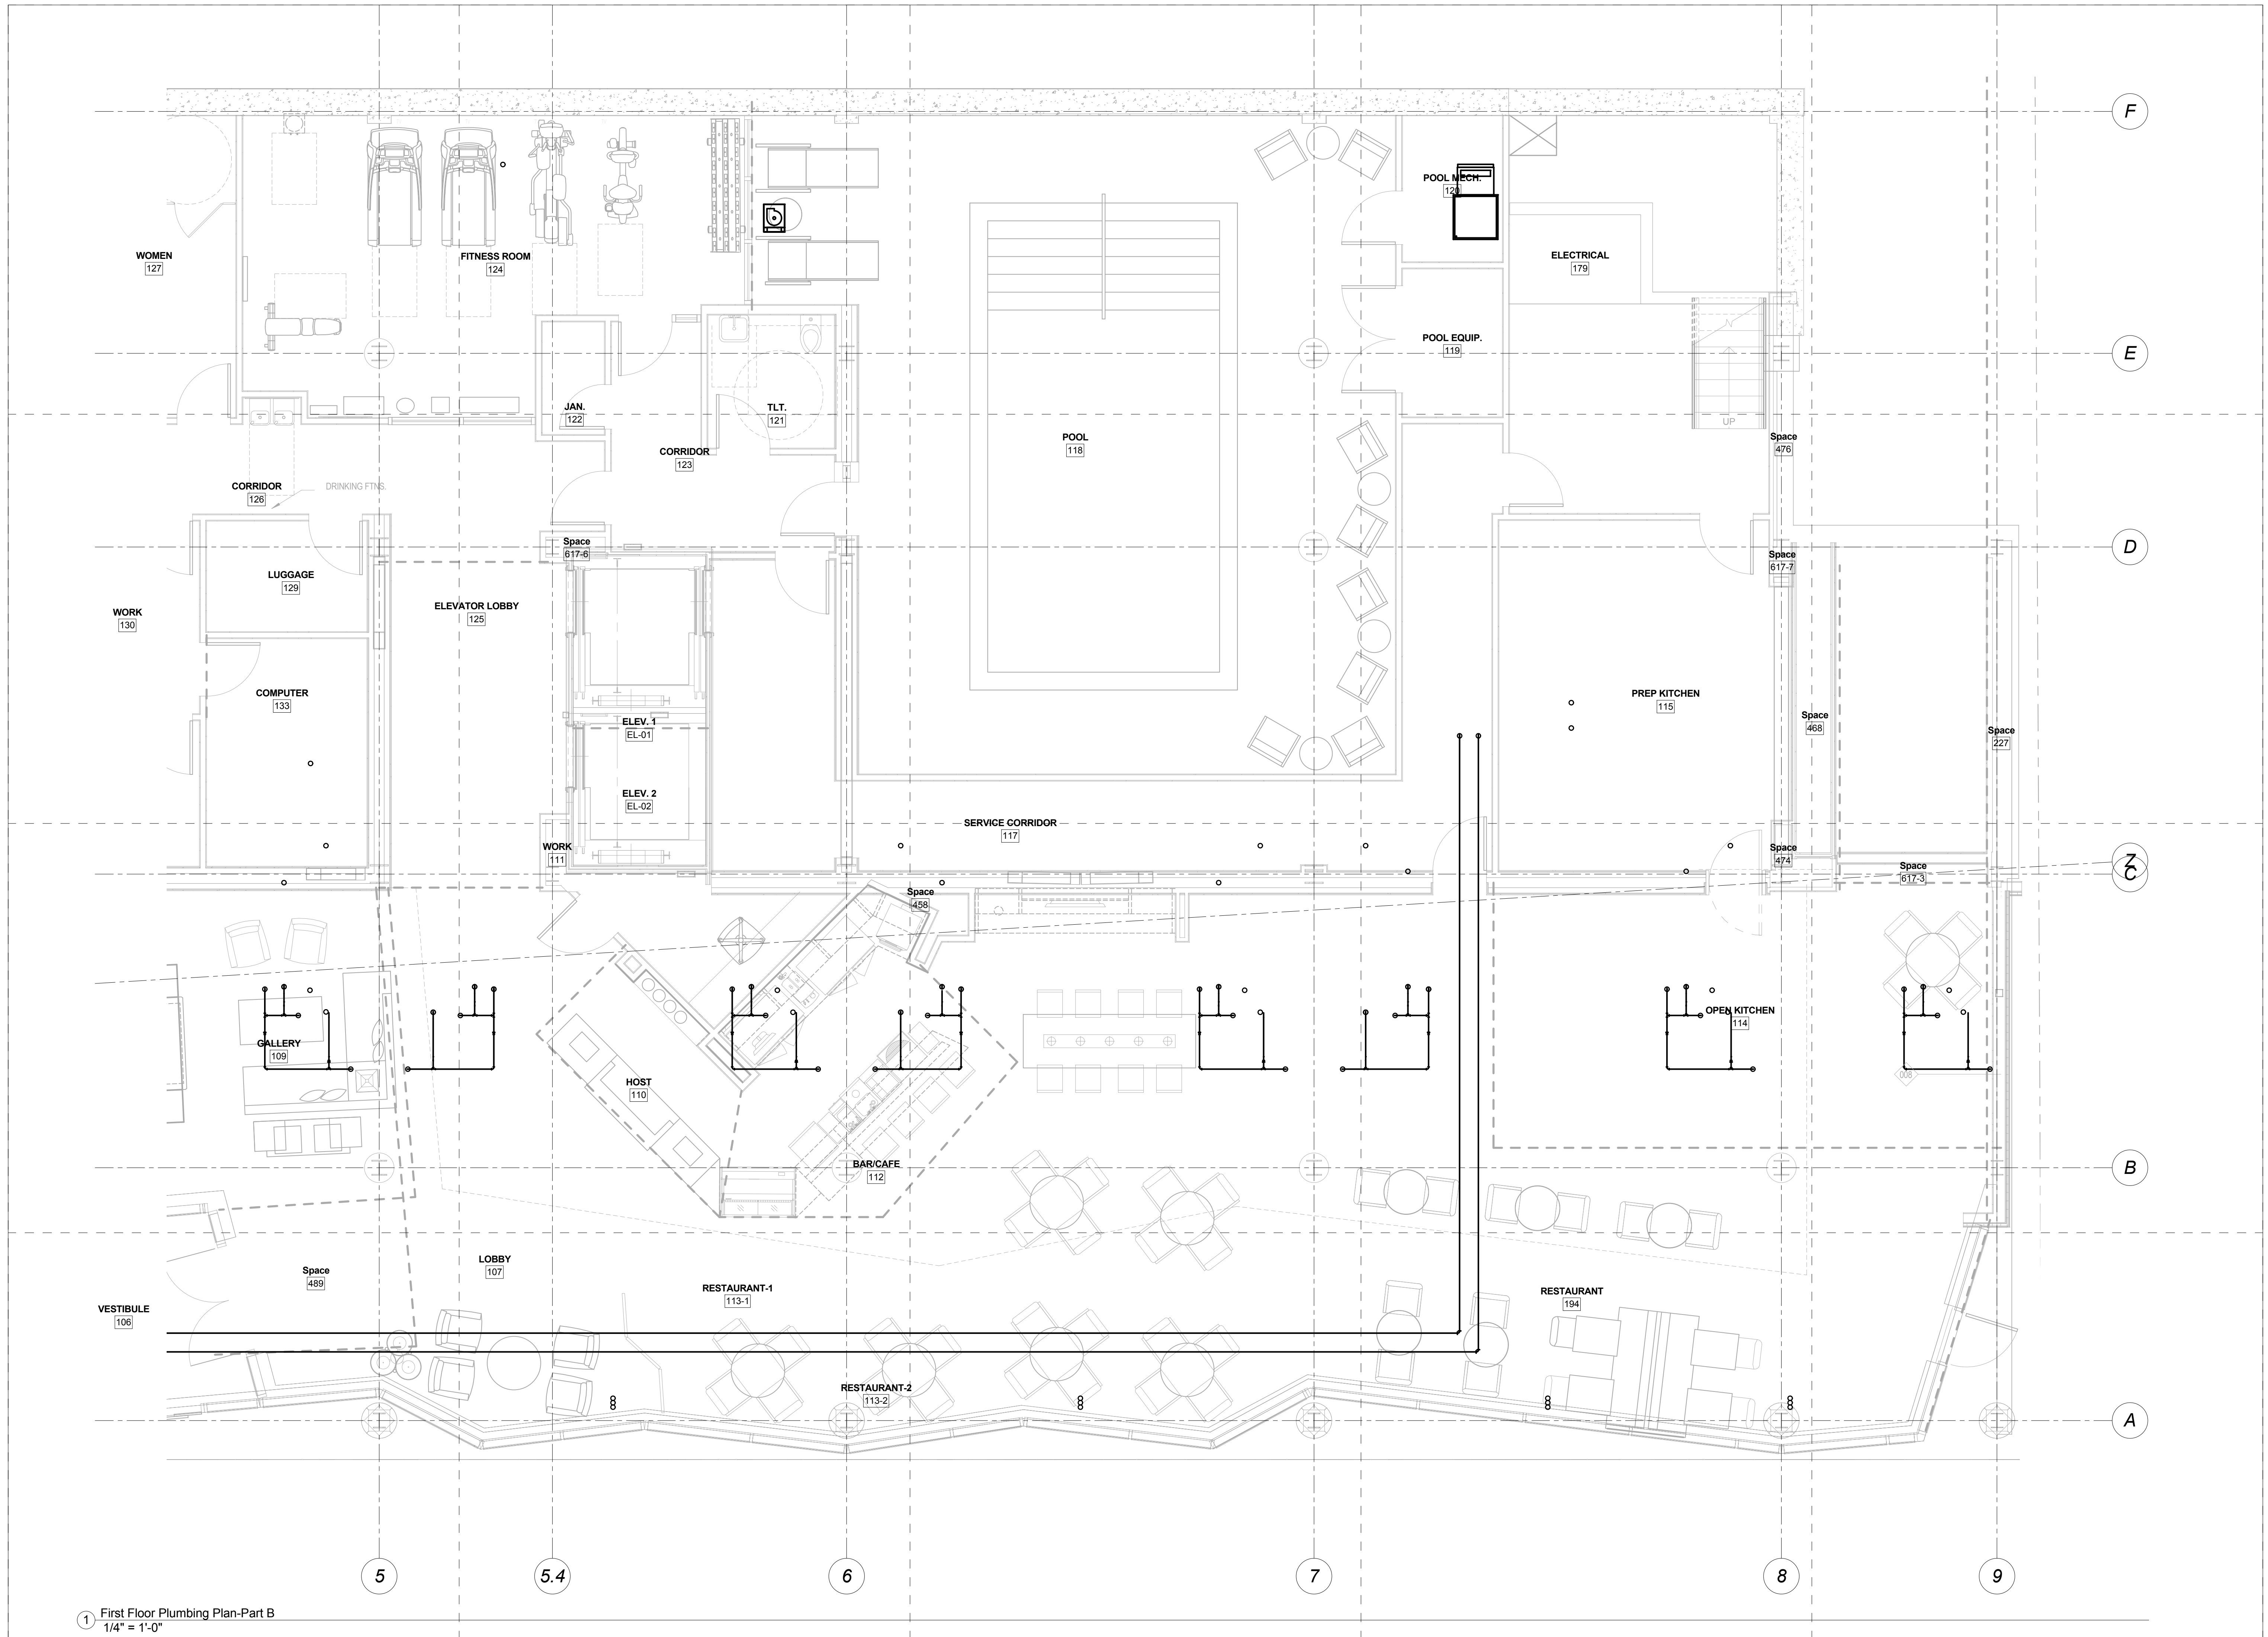

CANAL STUDIO
 Architecture / Planning / Interior Design
 207 553 2115
 One Canal Plaza, Suite 888
 Portland, Maine 04101
 canalstudio.com

EAST BROWN COW
 MANAGEMENT, INC.

shinberg
 CONSULTING, LLC

Project Title
**Hyatt Place,
 Portland-Old Port**


433 Fore Street
 Portland, ME
 CSS Project No. 12013

BENNETT ENGINEERING
 MECHANICAL • ELECTRICAL
 (207) 865-9475


Mark	Date	Description
		Project Status
		DESIGN DEVELOPMENT
		11-16-12
		Drawing Title
		First Floor Plumbing-Part B
		Scale: 1/4" = 1'-0"
		Drawing Number
		M20.1B

1 First Floor Plumbing Plan-Part B
 1/4" = 1'-0"

Mark	Date	Description
Project Status		
DESIGN DEVELOPMENT		
11-16-12		
Drawing Title		
Second Floor Plumbing-Part A		
Scale: 1/4" = 1'-0"		
Drawing Number		
M20.2A		

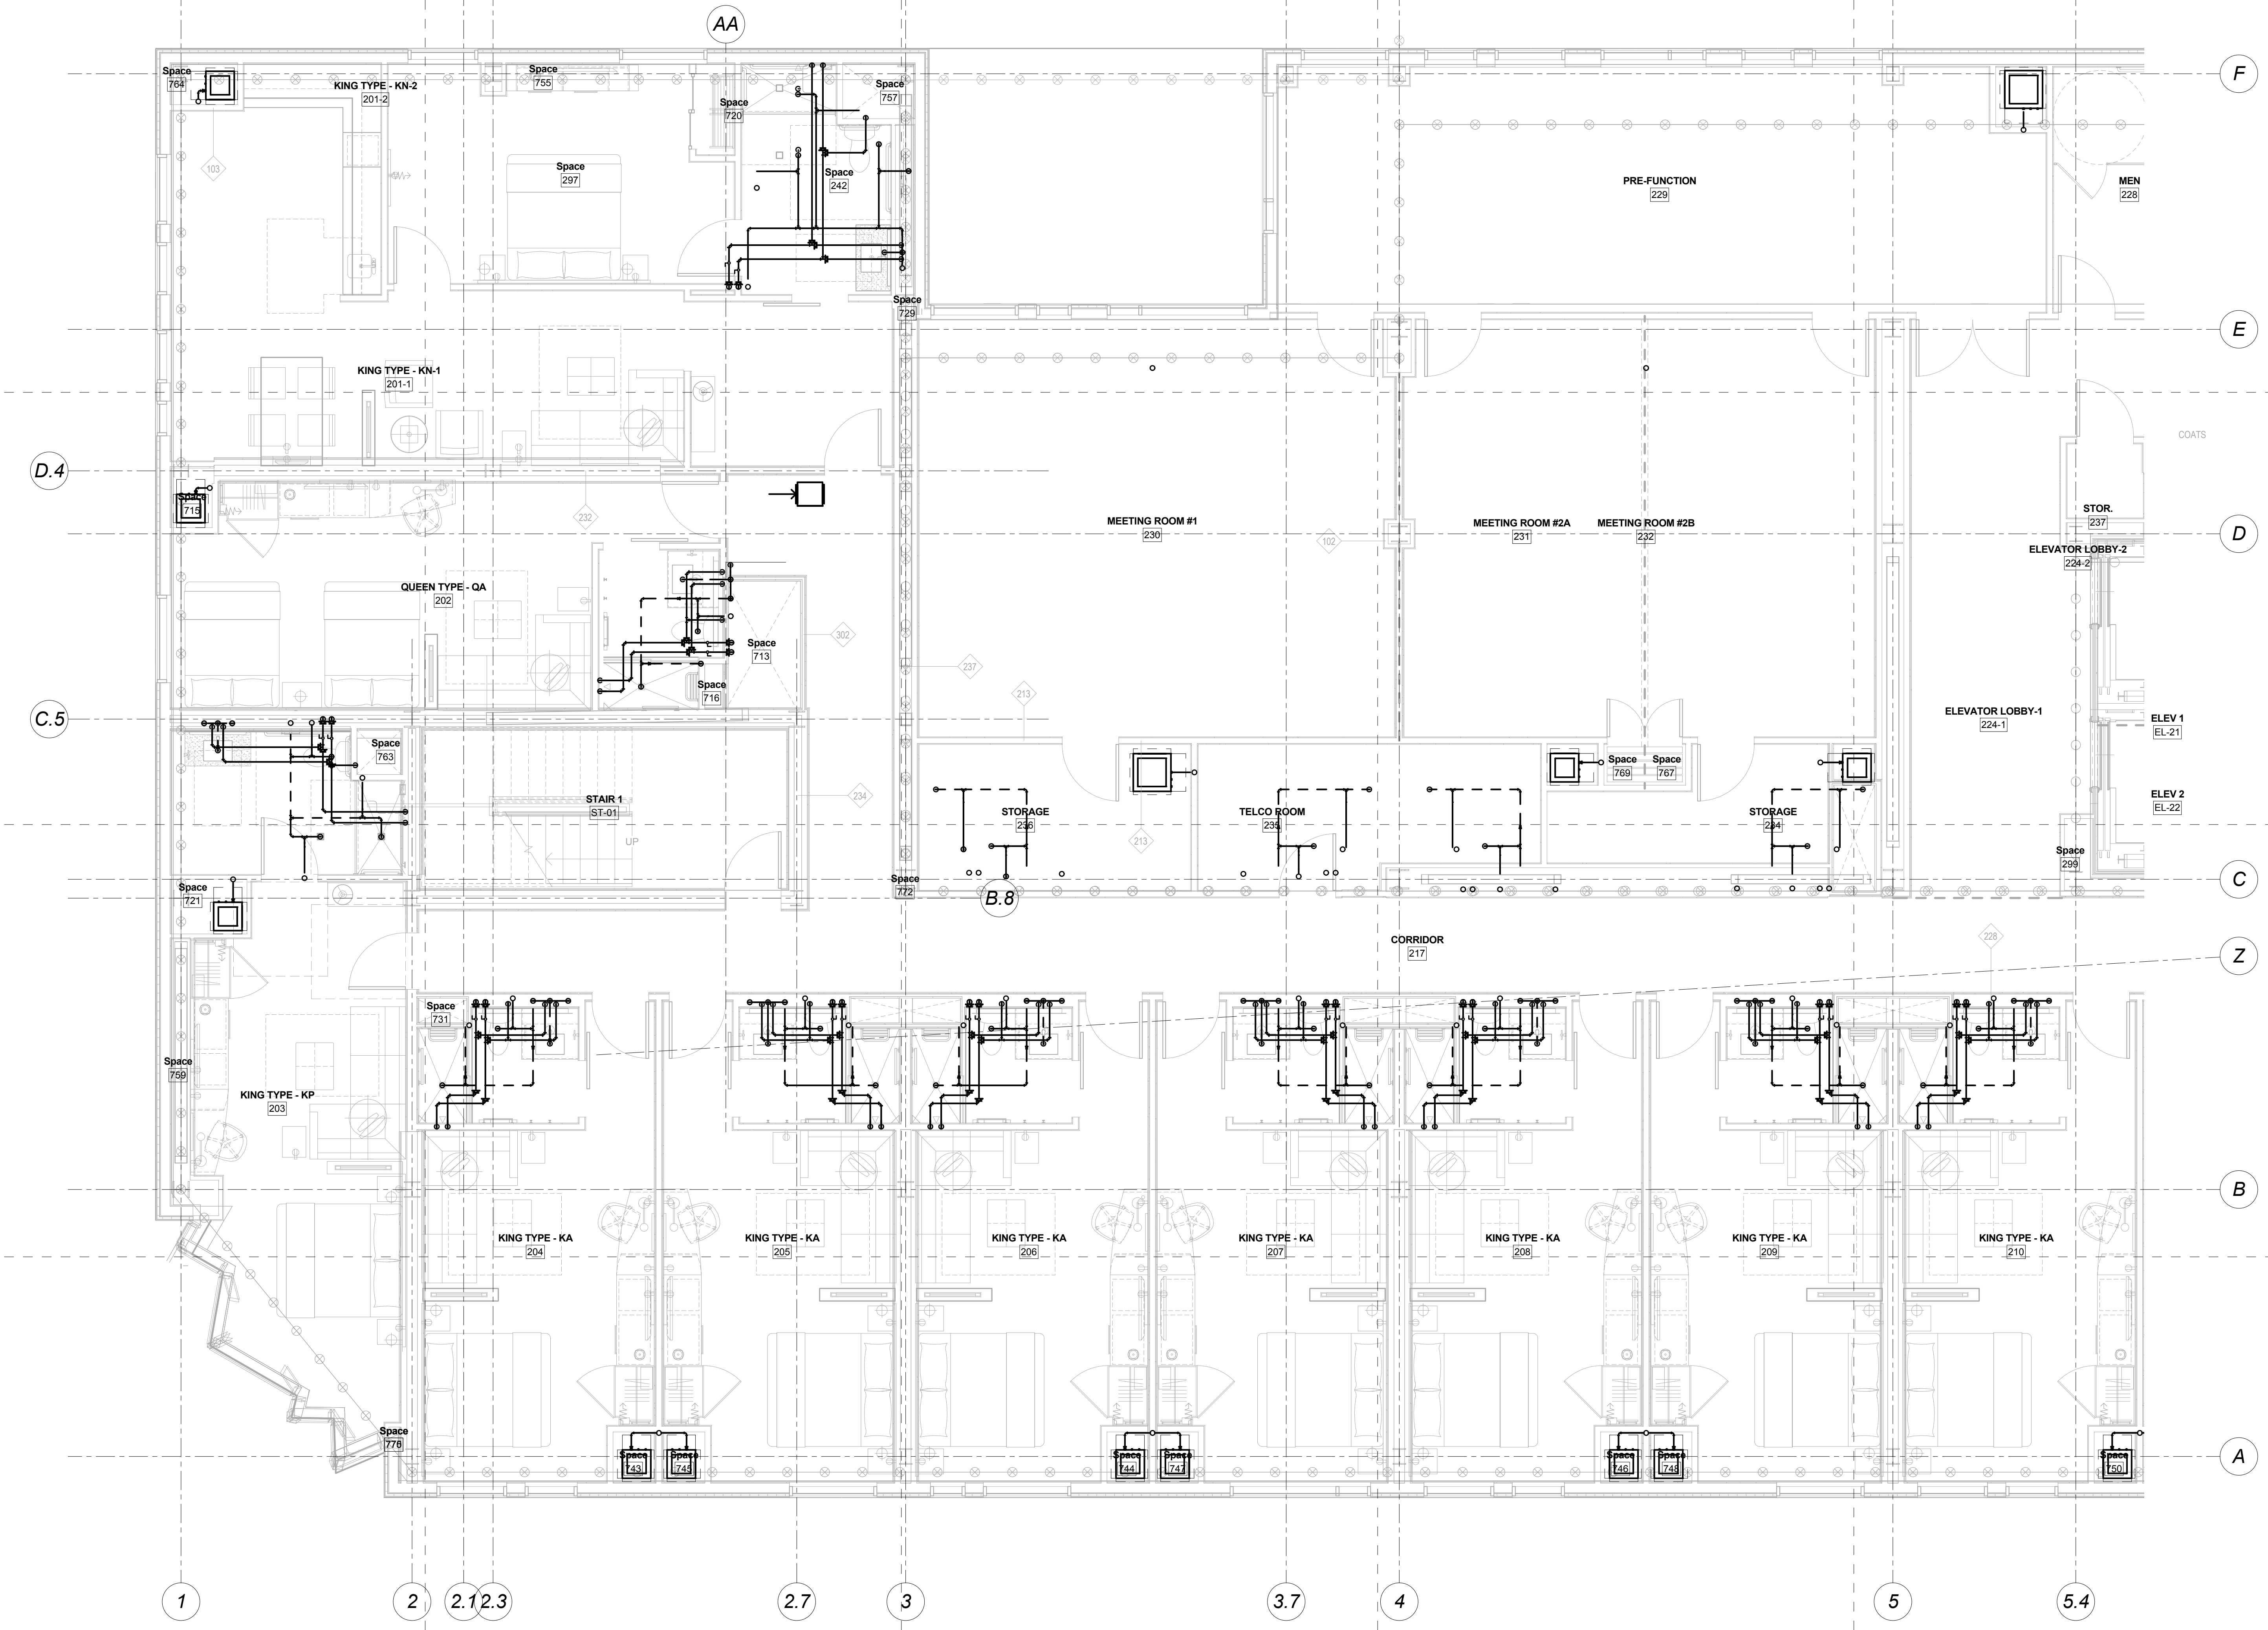

1 Second Floor Plumbing Plan-Part A
 1/4" = 1'-0"

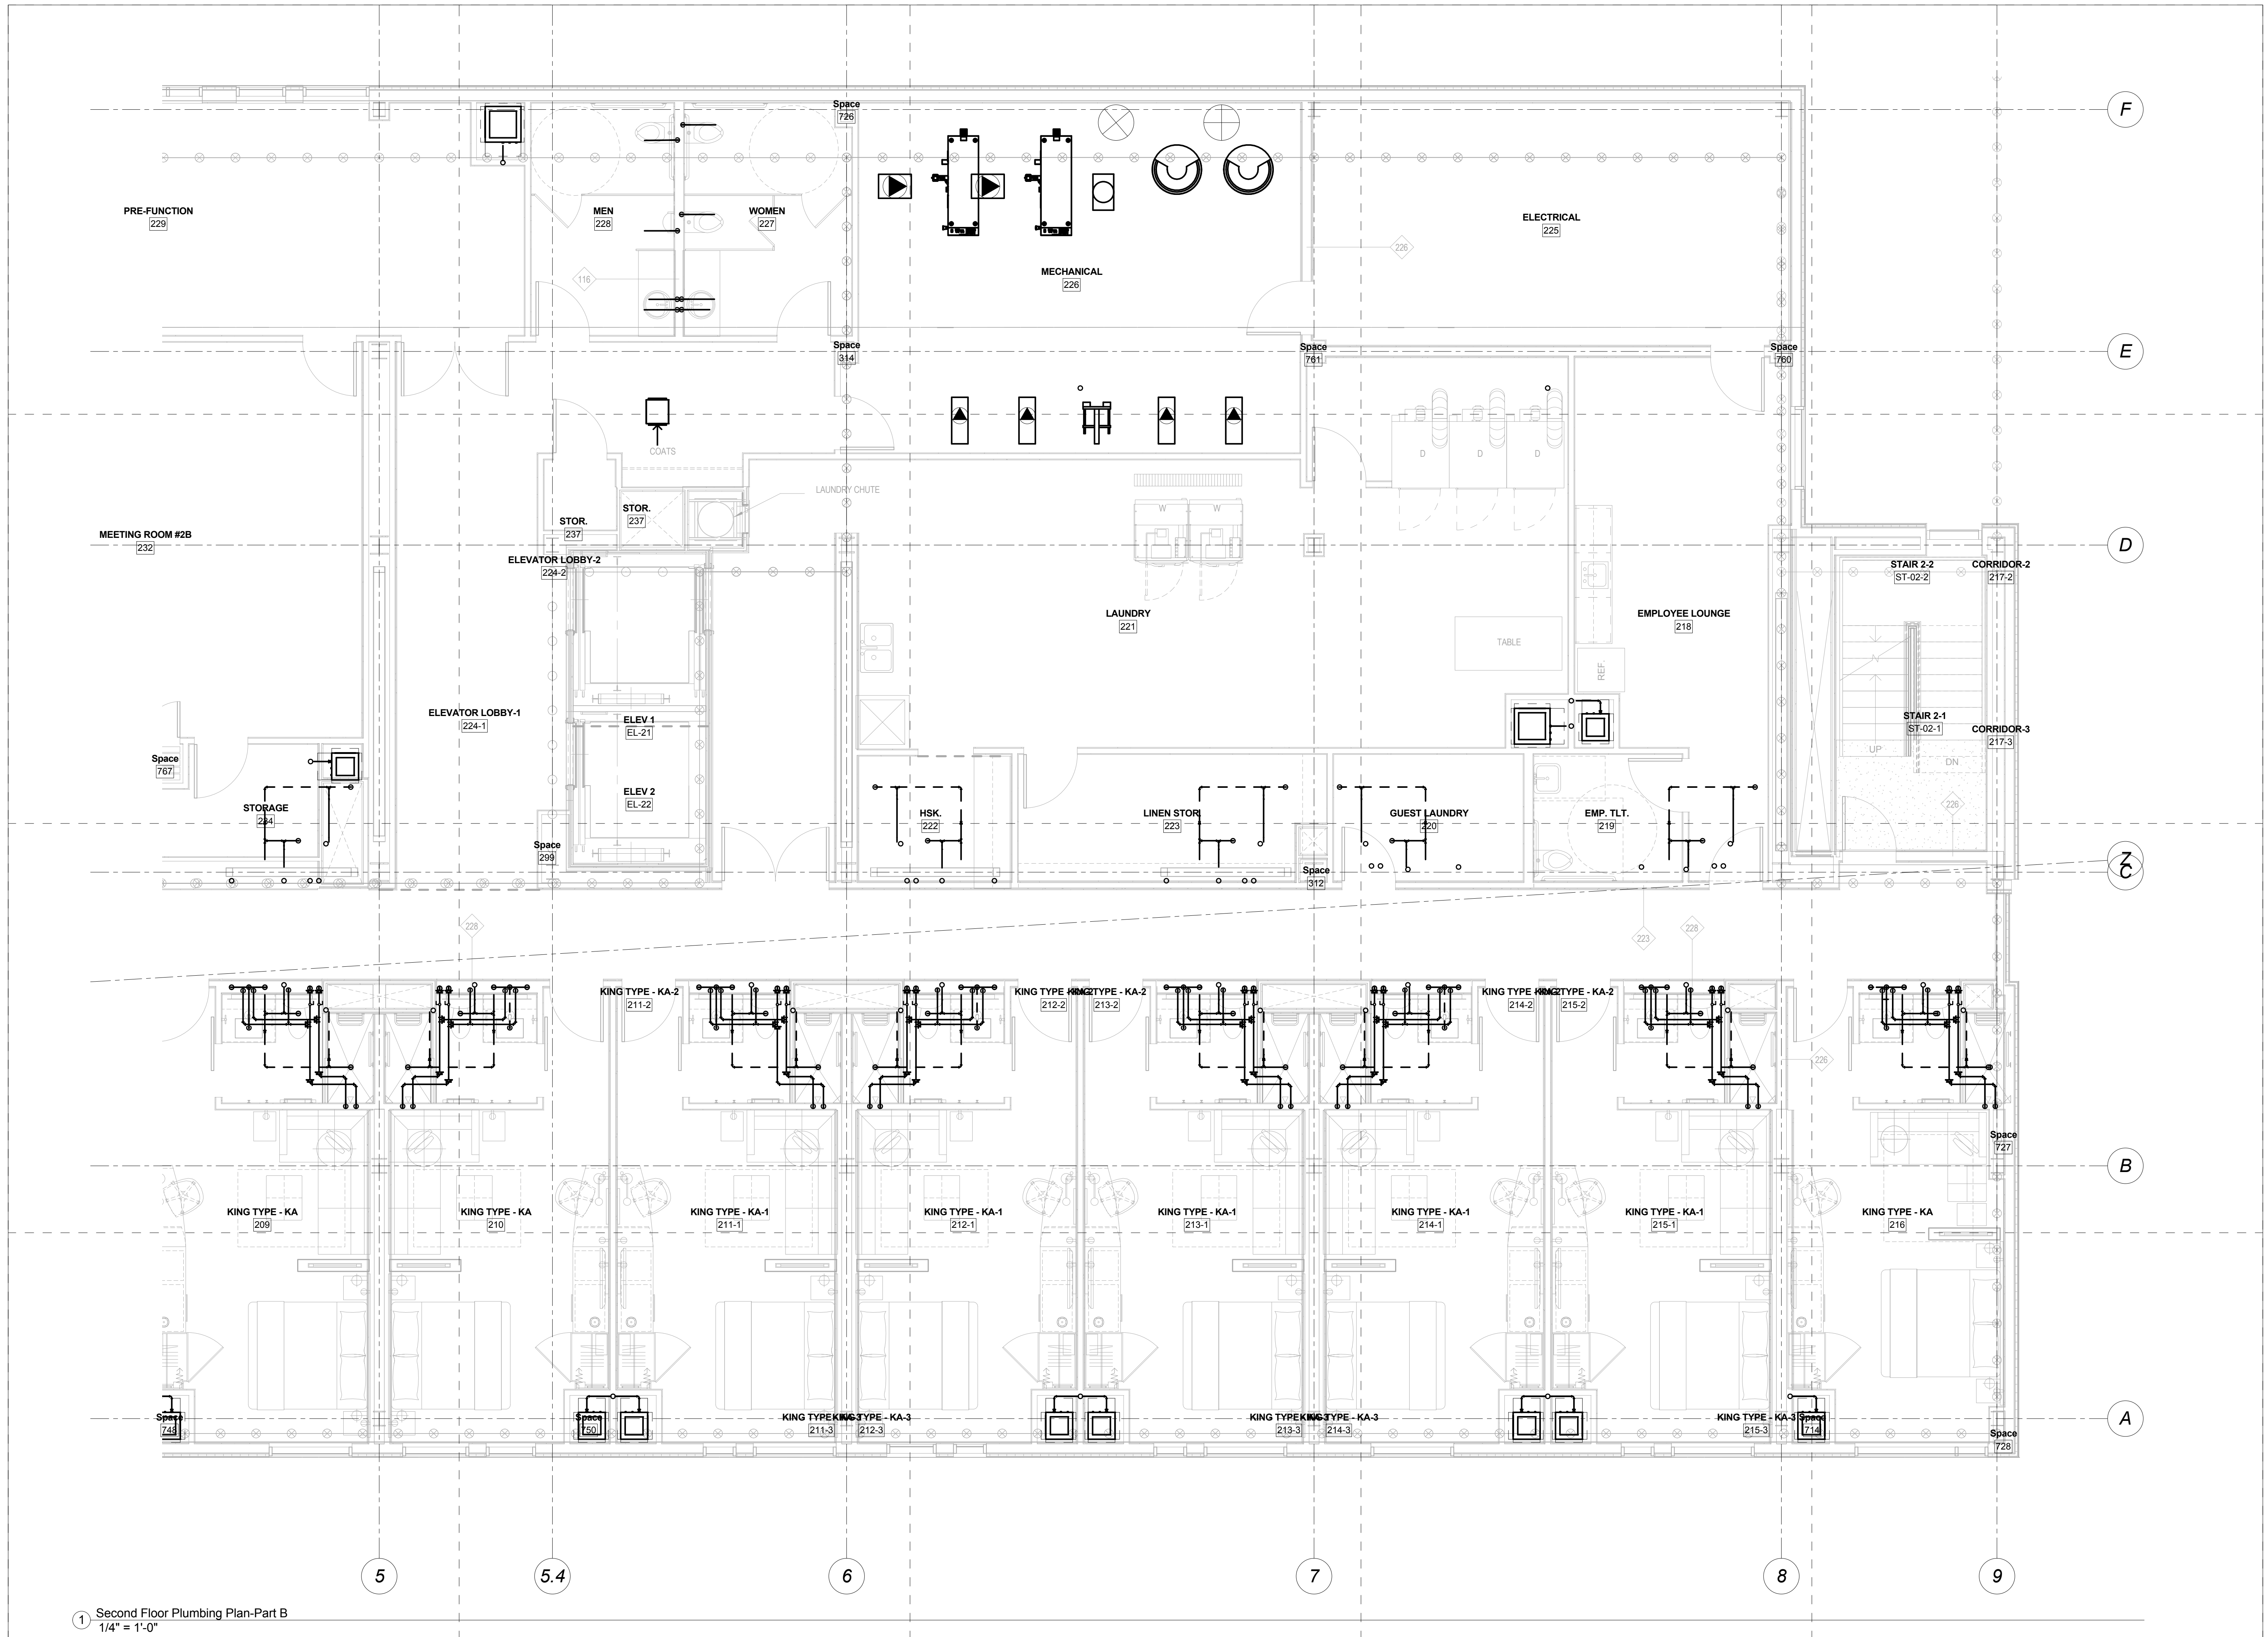

CANAL STUDIO
 Architecture / Planning / Interior Design
 207 553 2115
 One Canal Plaza, Suite 888
 Portland, Maine 04101
 canalstudio.com

EAST BROWN COW
 MANAGEMENT, INC.

shinberg
 CONSULTING, LLC

Project Title
**Hyatt Place,
 Portland-Old Port**


433 Fore Street
 Portland, ME

CSS Project No. 12013

BENNETT ENGINEERING
 MECHANICAL • ELECTRICAL
 (207) 865-9475


Mark	Date	Description
Project Status		
DESIGN DEVELOPMENT		
11-16-12		
Drawing Title		
Second Floor Plumbing-Part B		
Scale: 1/4" = 1'-0"		
Drawing Number		
M20.2B		

1 Second Floor Plumbing Plan-Part B
 1/4" = 1'-0"

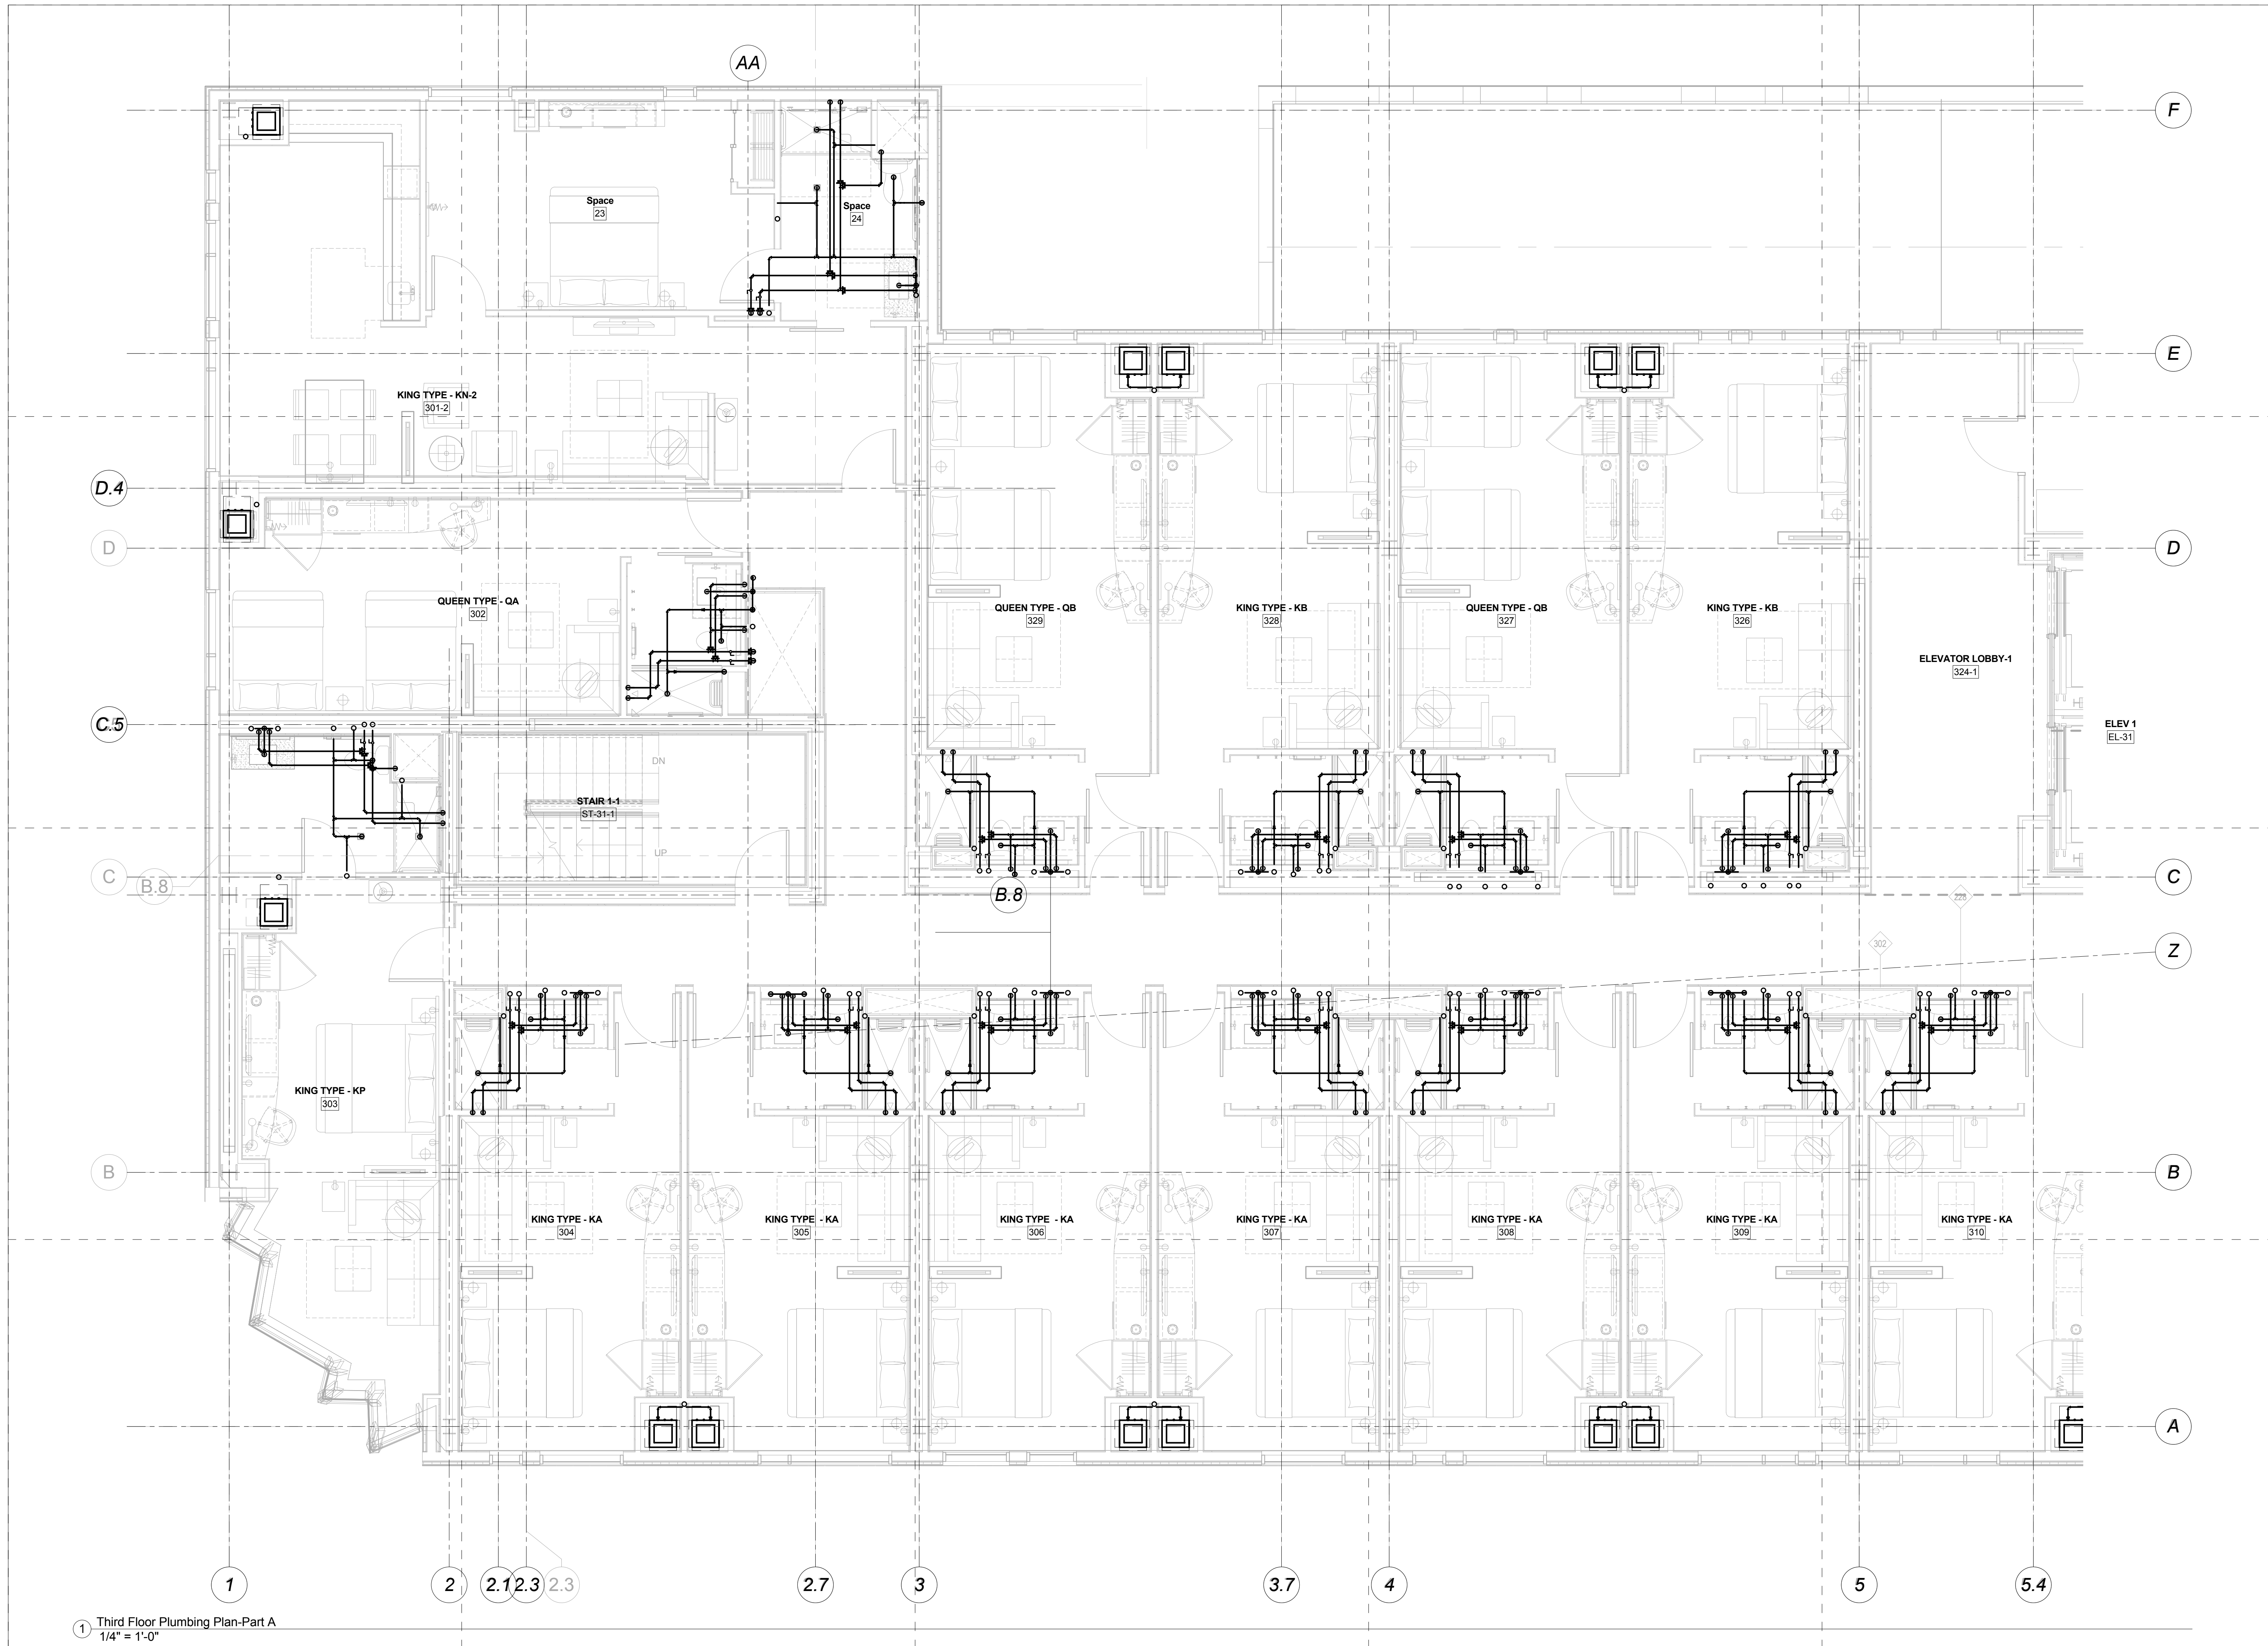

Mark	Date	Description
Project Status		
DESIGN DEVELOPMENT		
11-16-12		
Drawing Title		
Third Floor Plumbing-Part A		
Scale: 1/4" = 1'-0"		
Drawing Number		
M20.3A		

1 Third Floor Plumbing Plan-Part A
 1/4" = 1'-0"

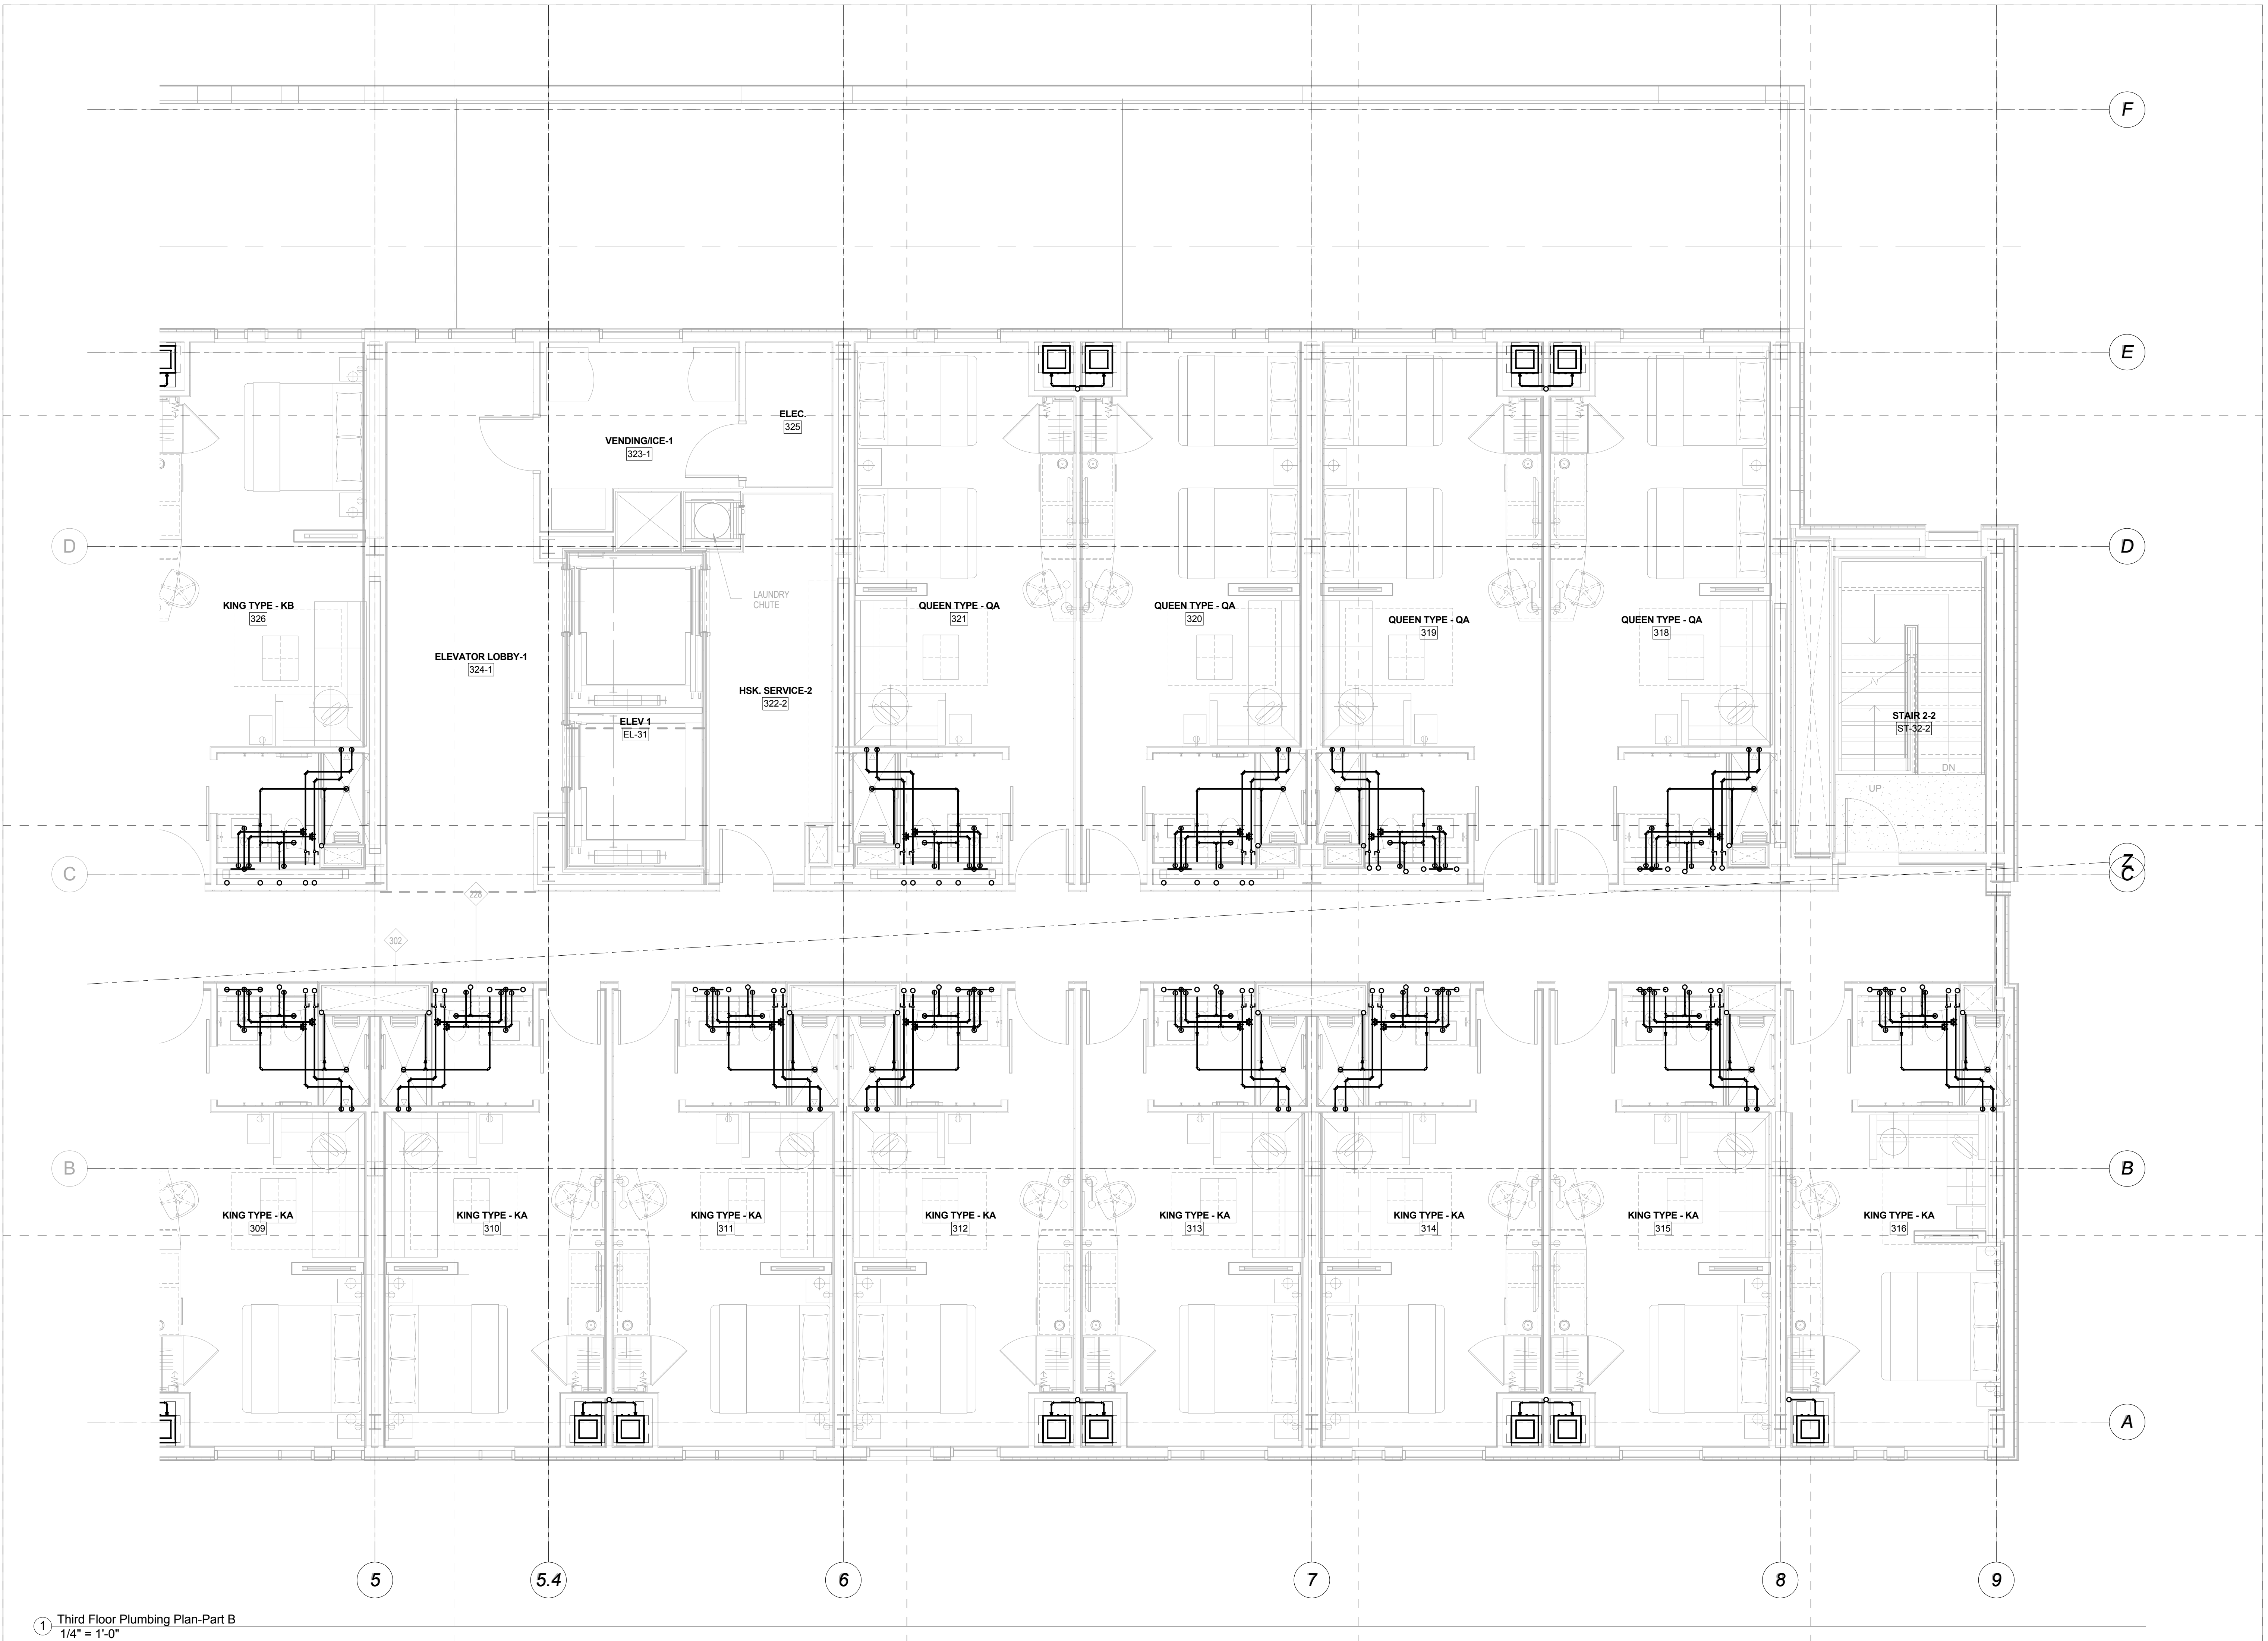

1 Third Floor Plumbing Plan-Part B
1/4" = 1'-0"

CANAL 5 STUDIO
Architecture / Planning / Interior Design
207 553 2115
One Canal Plaza, Suite 888
Portland, Maine 04101
canal5studio.com

EAST BROWN COW
MANAGEMENT, INC.

shinberg
CONSULTING, LLC

Project Title
**Hyatt Place,
Portland-Old Port**
433 Fore Street
Portland, ME
CSS Project No. 12013


BENNETT ENGINEERING
MECHANICAL • ELECTRICAL
(207) 865-9475

Mark	Date	Description
Project Status		
		DESIGN DEVELOPMENT 11-16-12

Drawing Title
**Third Floor
Plumbing-Part B**


Scale: 1/4" = 1'-0"

Drawing Number
M20.3B

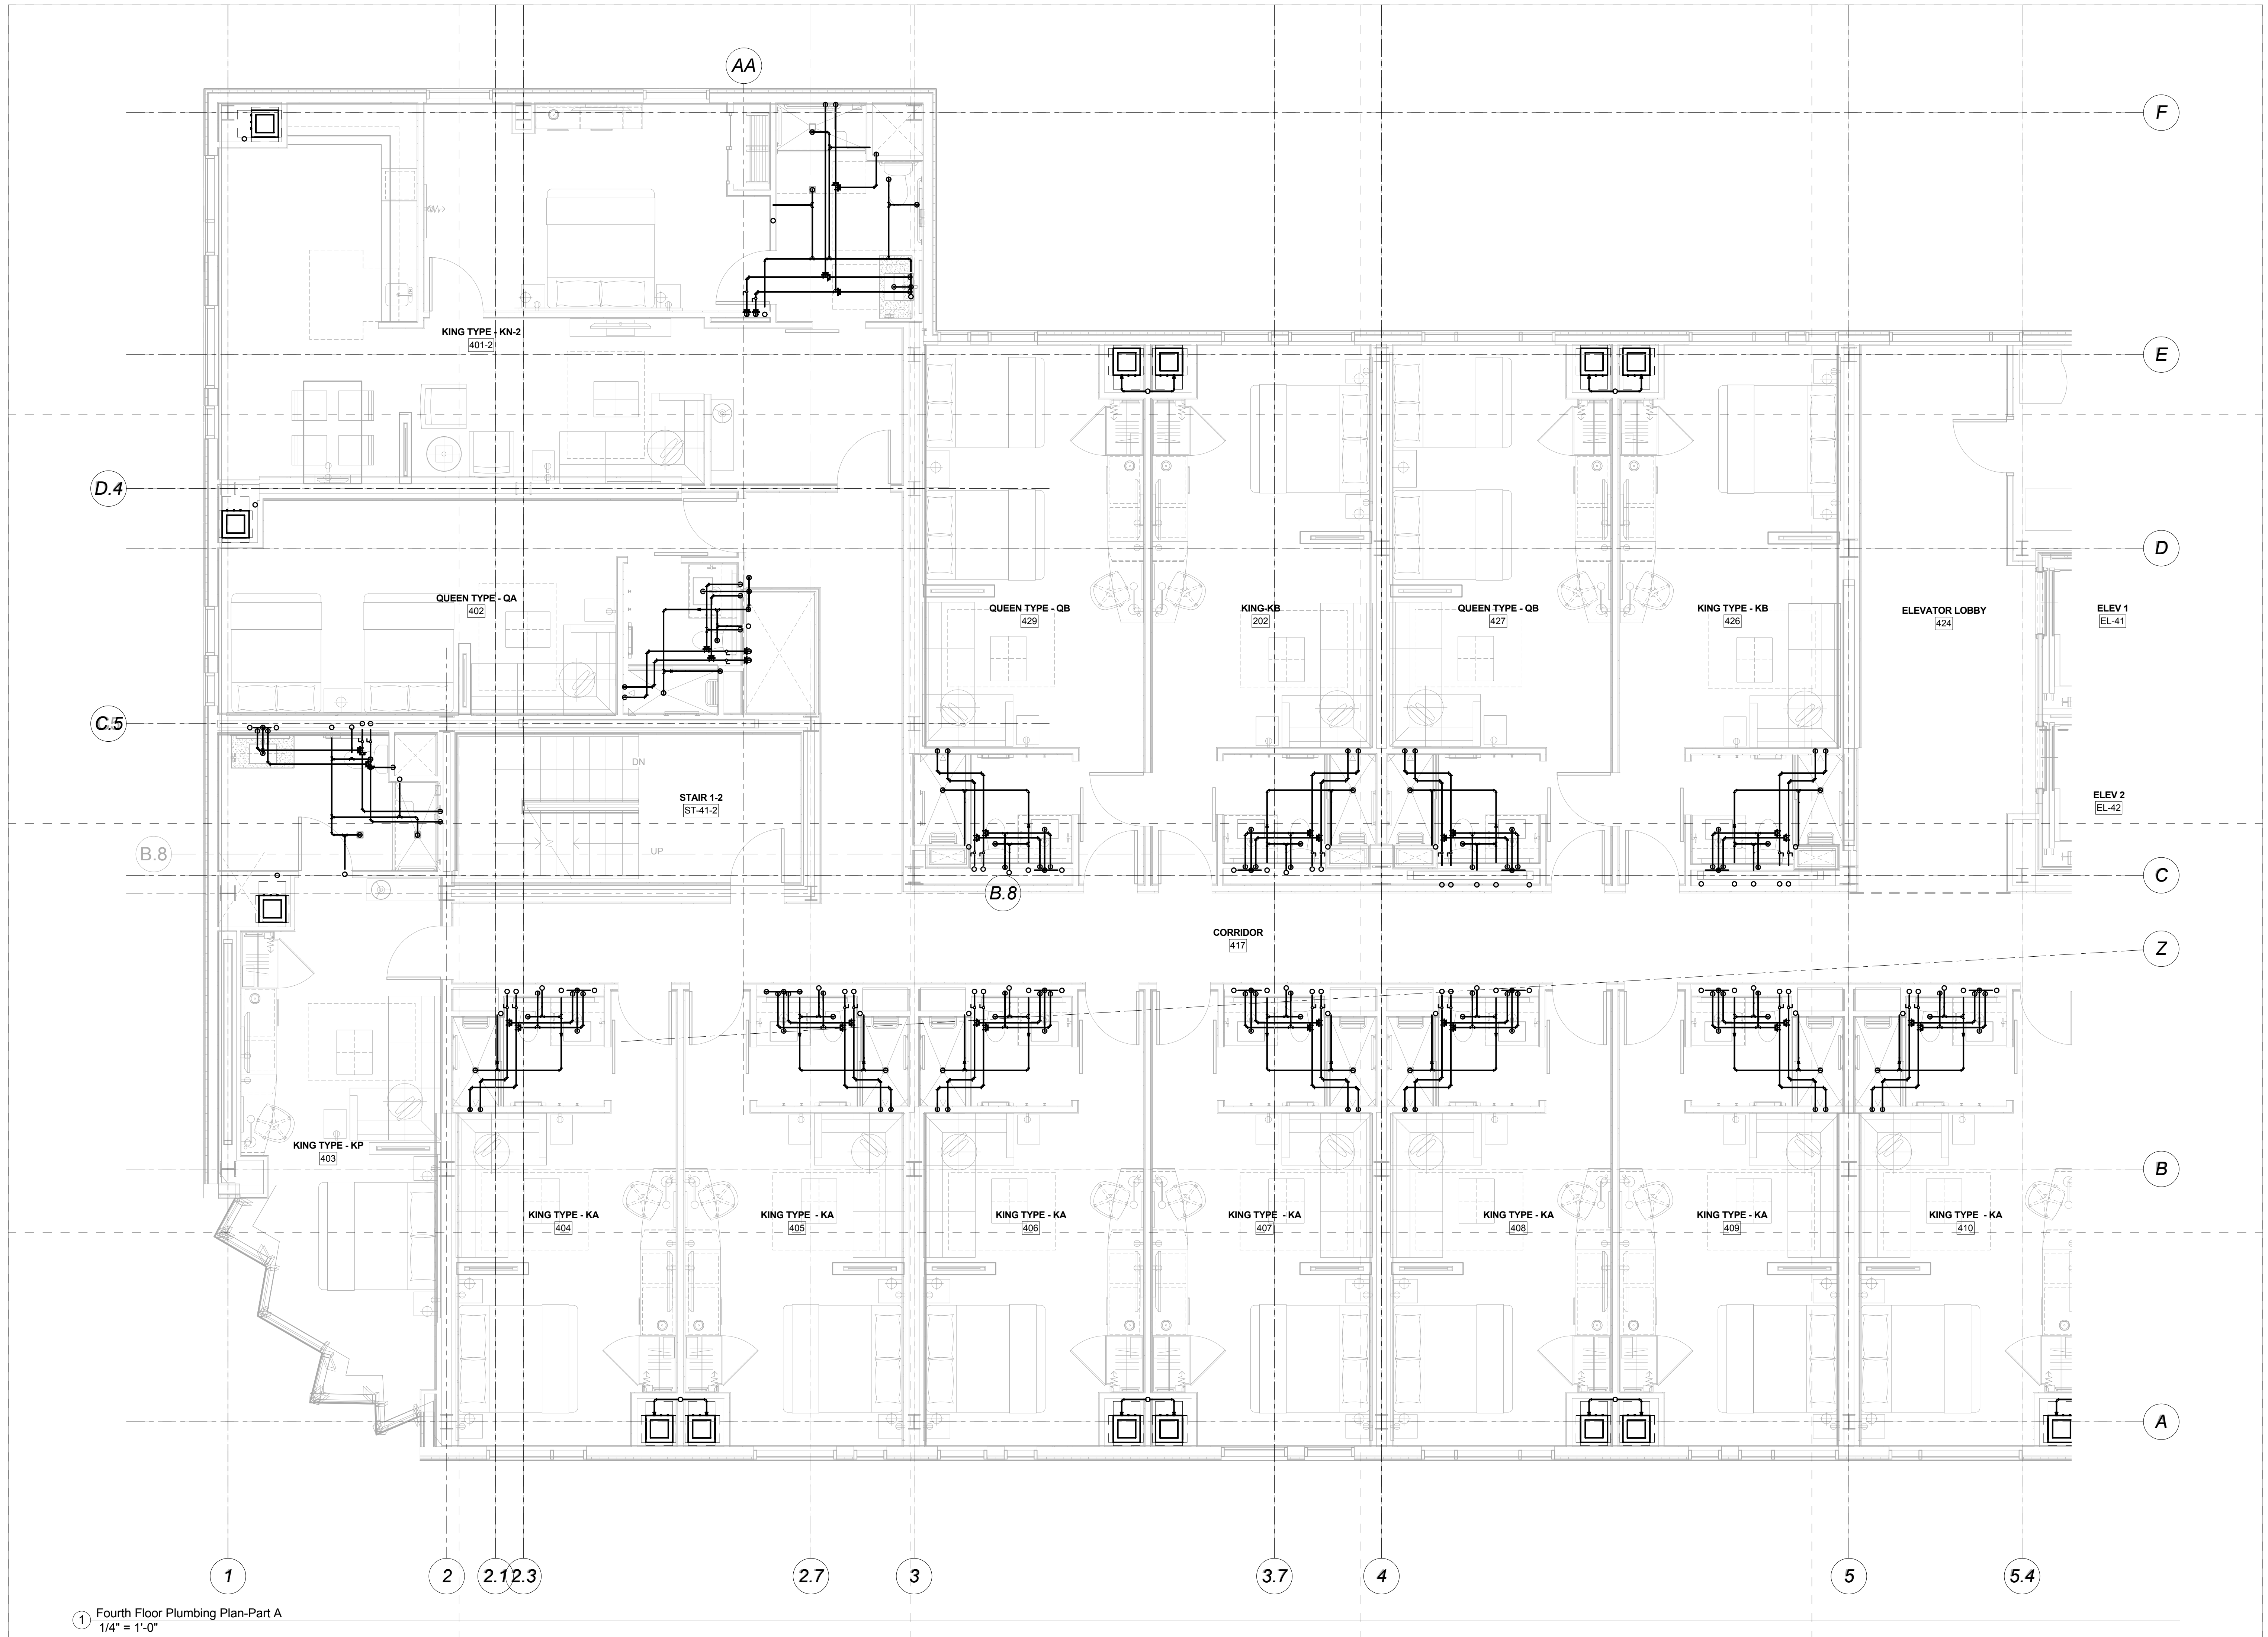

Mark	Date	Description
Project Status		
DESIGN DEVELOPMENT		
11-16-12		
Drawing Title		
Fourth Floor Plumbing-Part A		
Scale: 1/4" = 1'-0"		
Drawing Number		
M20.4A		

1 Fourth Floor Plumbing Plan-Part A
 1/4" = 1'-0"

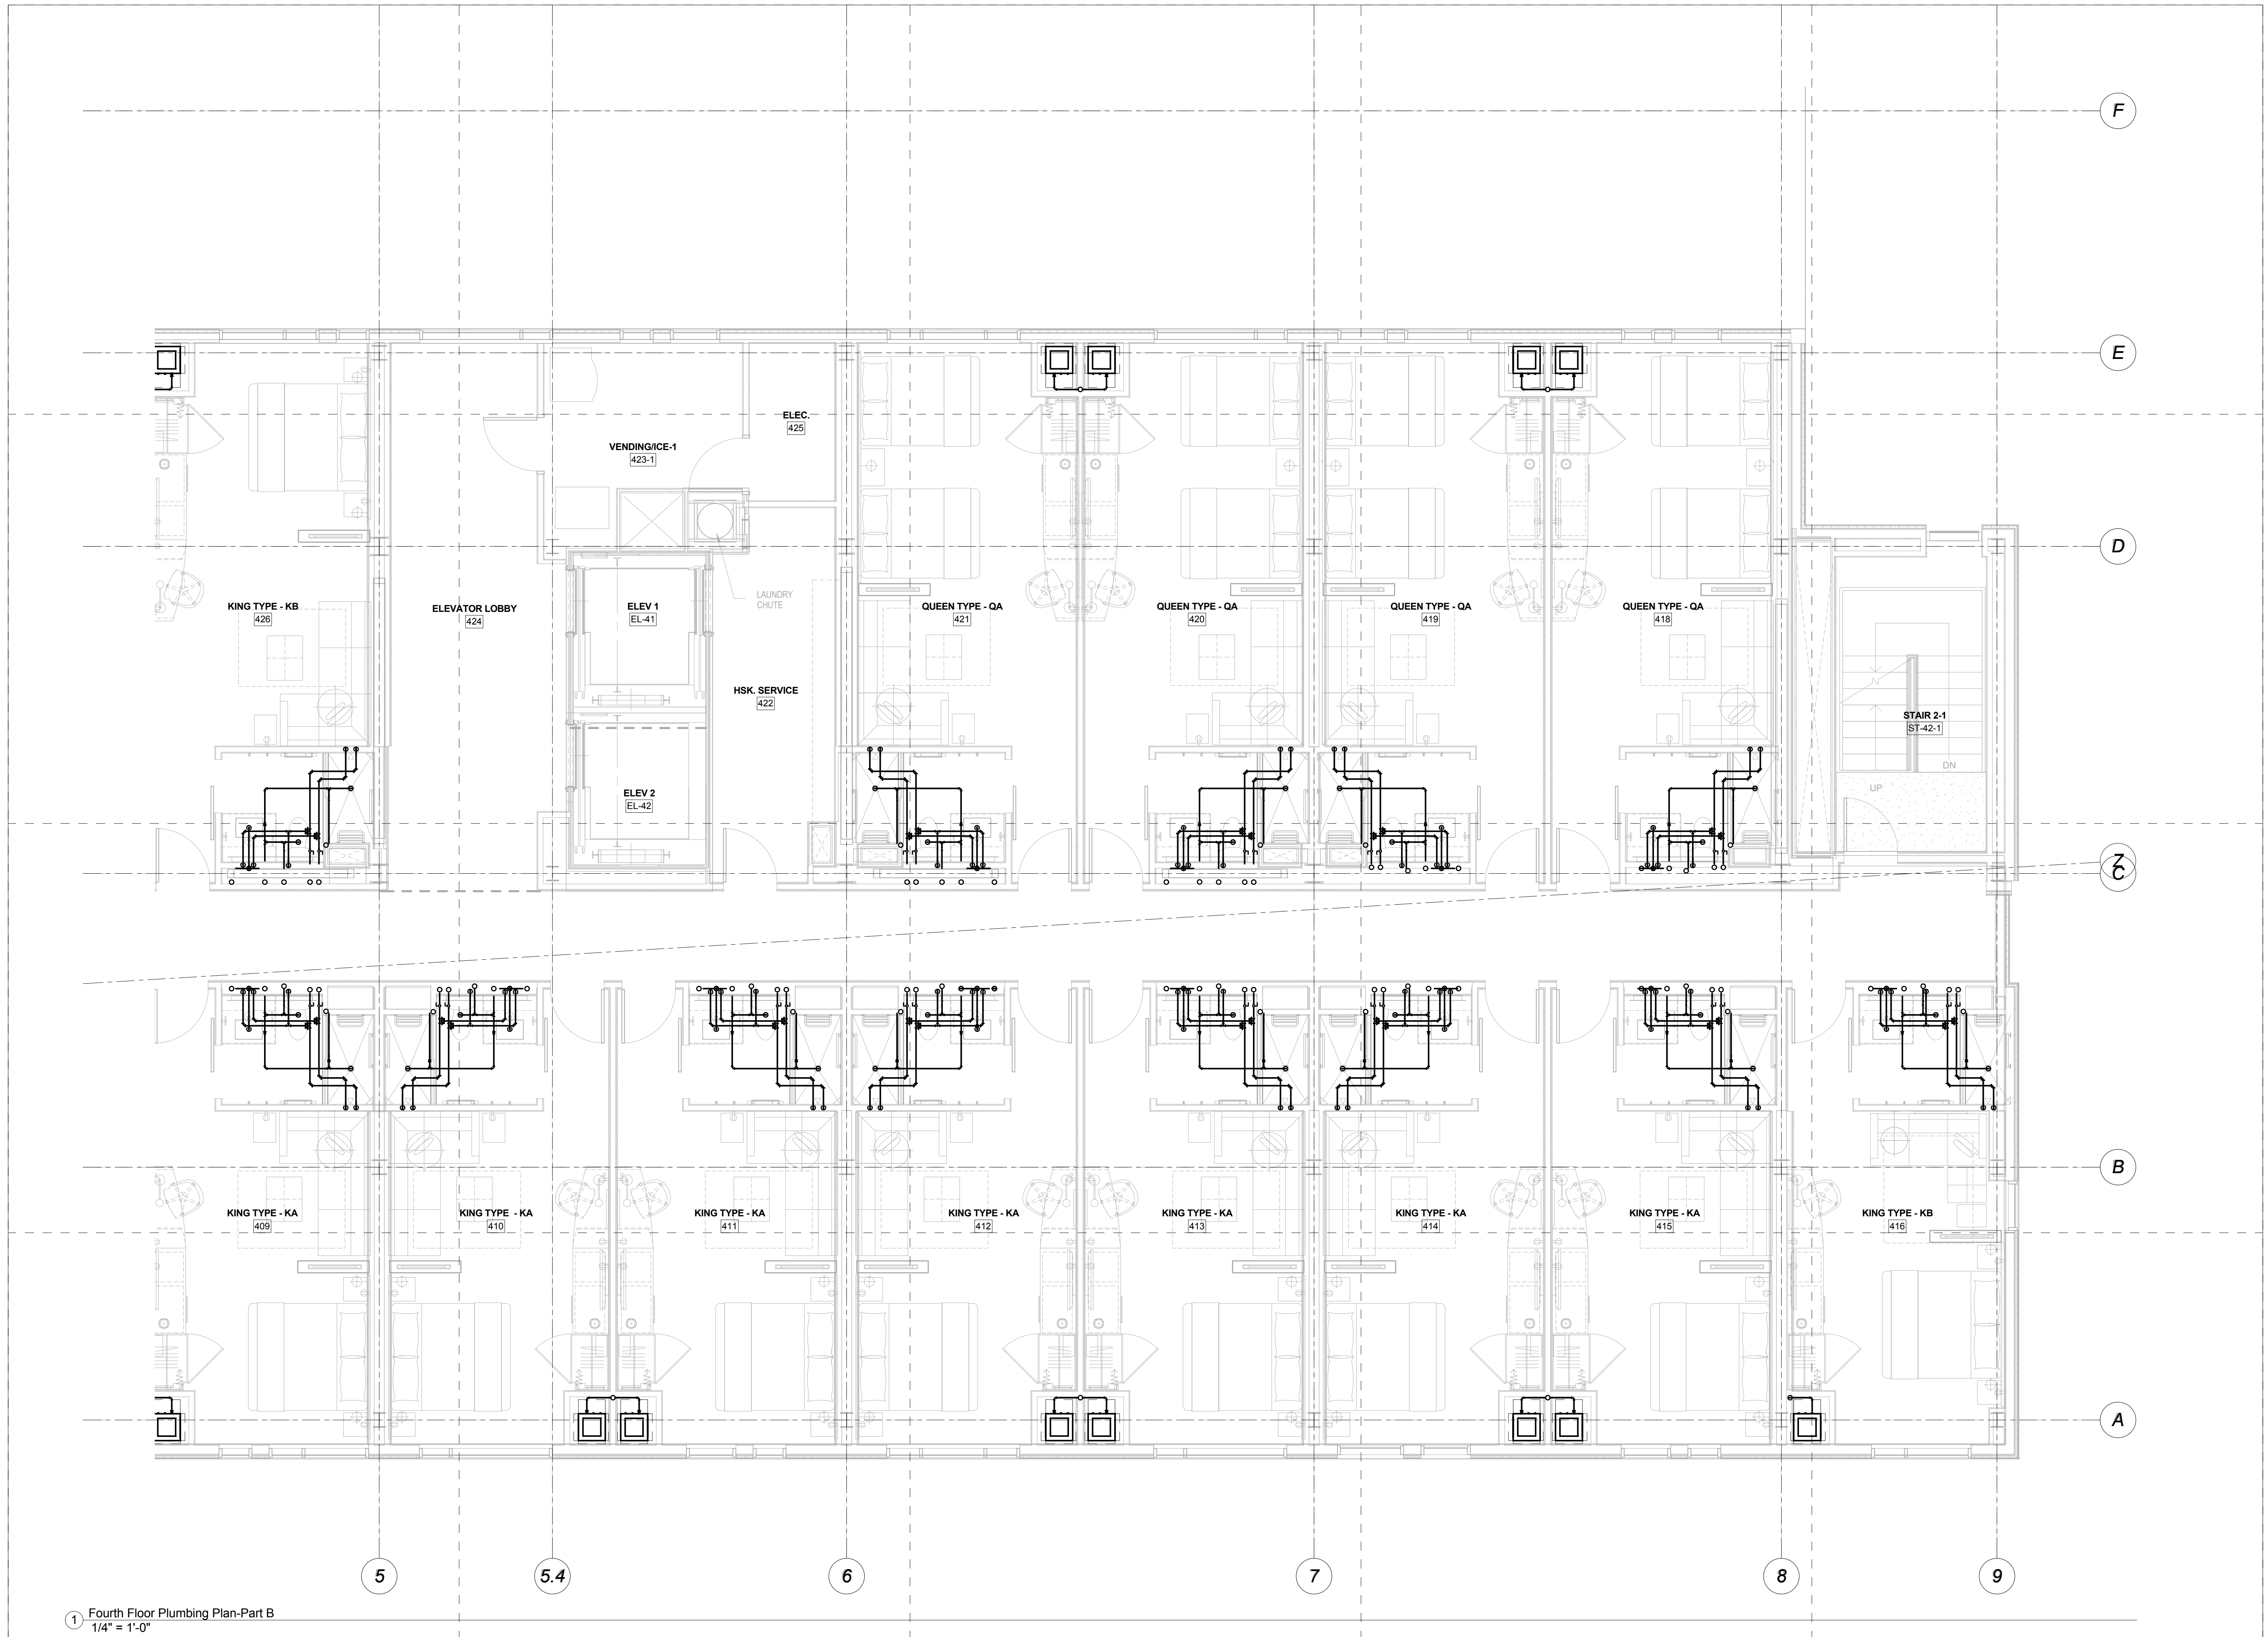

① Fourth Floor Plumbing Plan-Part B
1/4" = 1'-0"

CANAL 5 STUDIO
Architecture / Planning / Interior Design
207 553 2115
One Canal Plaza, Suite 888
Portland, Maine 04101
canal5studio.com

EAST BROWN COW
MANAGEMENT, INC.

shinberg
CONSULTING, LLC

Project Title
**Hyatt Place,
Portland-Old Port**
433 Fore Street
Portland, ME
CSS Project No. 12013


BENNETT
ENGINEERING
MECHANICAL • ELECTRICAL
(207) 865-9475

Mark	Date	Description
Project Status		
		DESIGN DEVELOPMENT 11-16-12

Drawing Title
**Fourth Floor
Plumbing-Part B**

Scale: 1/4" = 1'-0"

Drawing Number
M20.4B

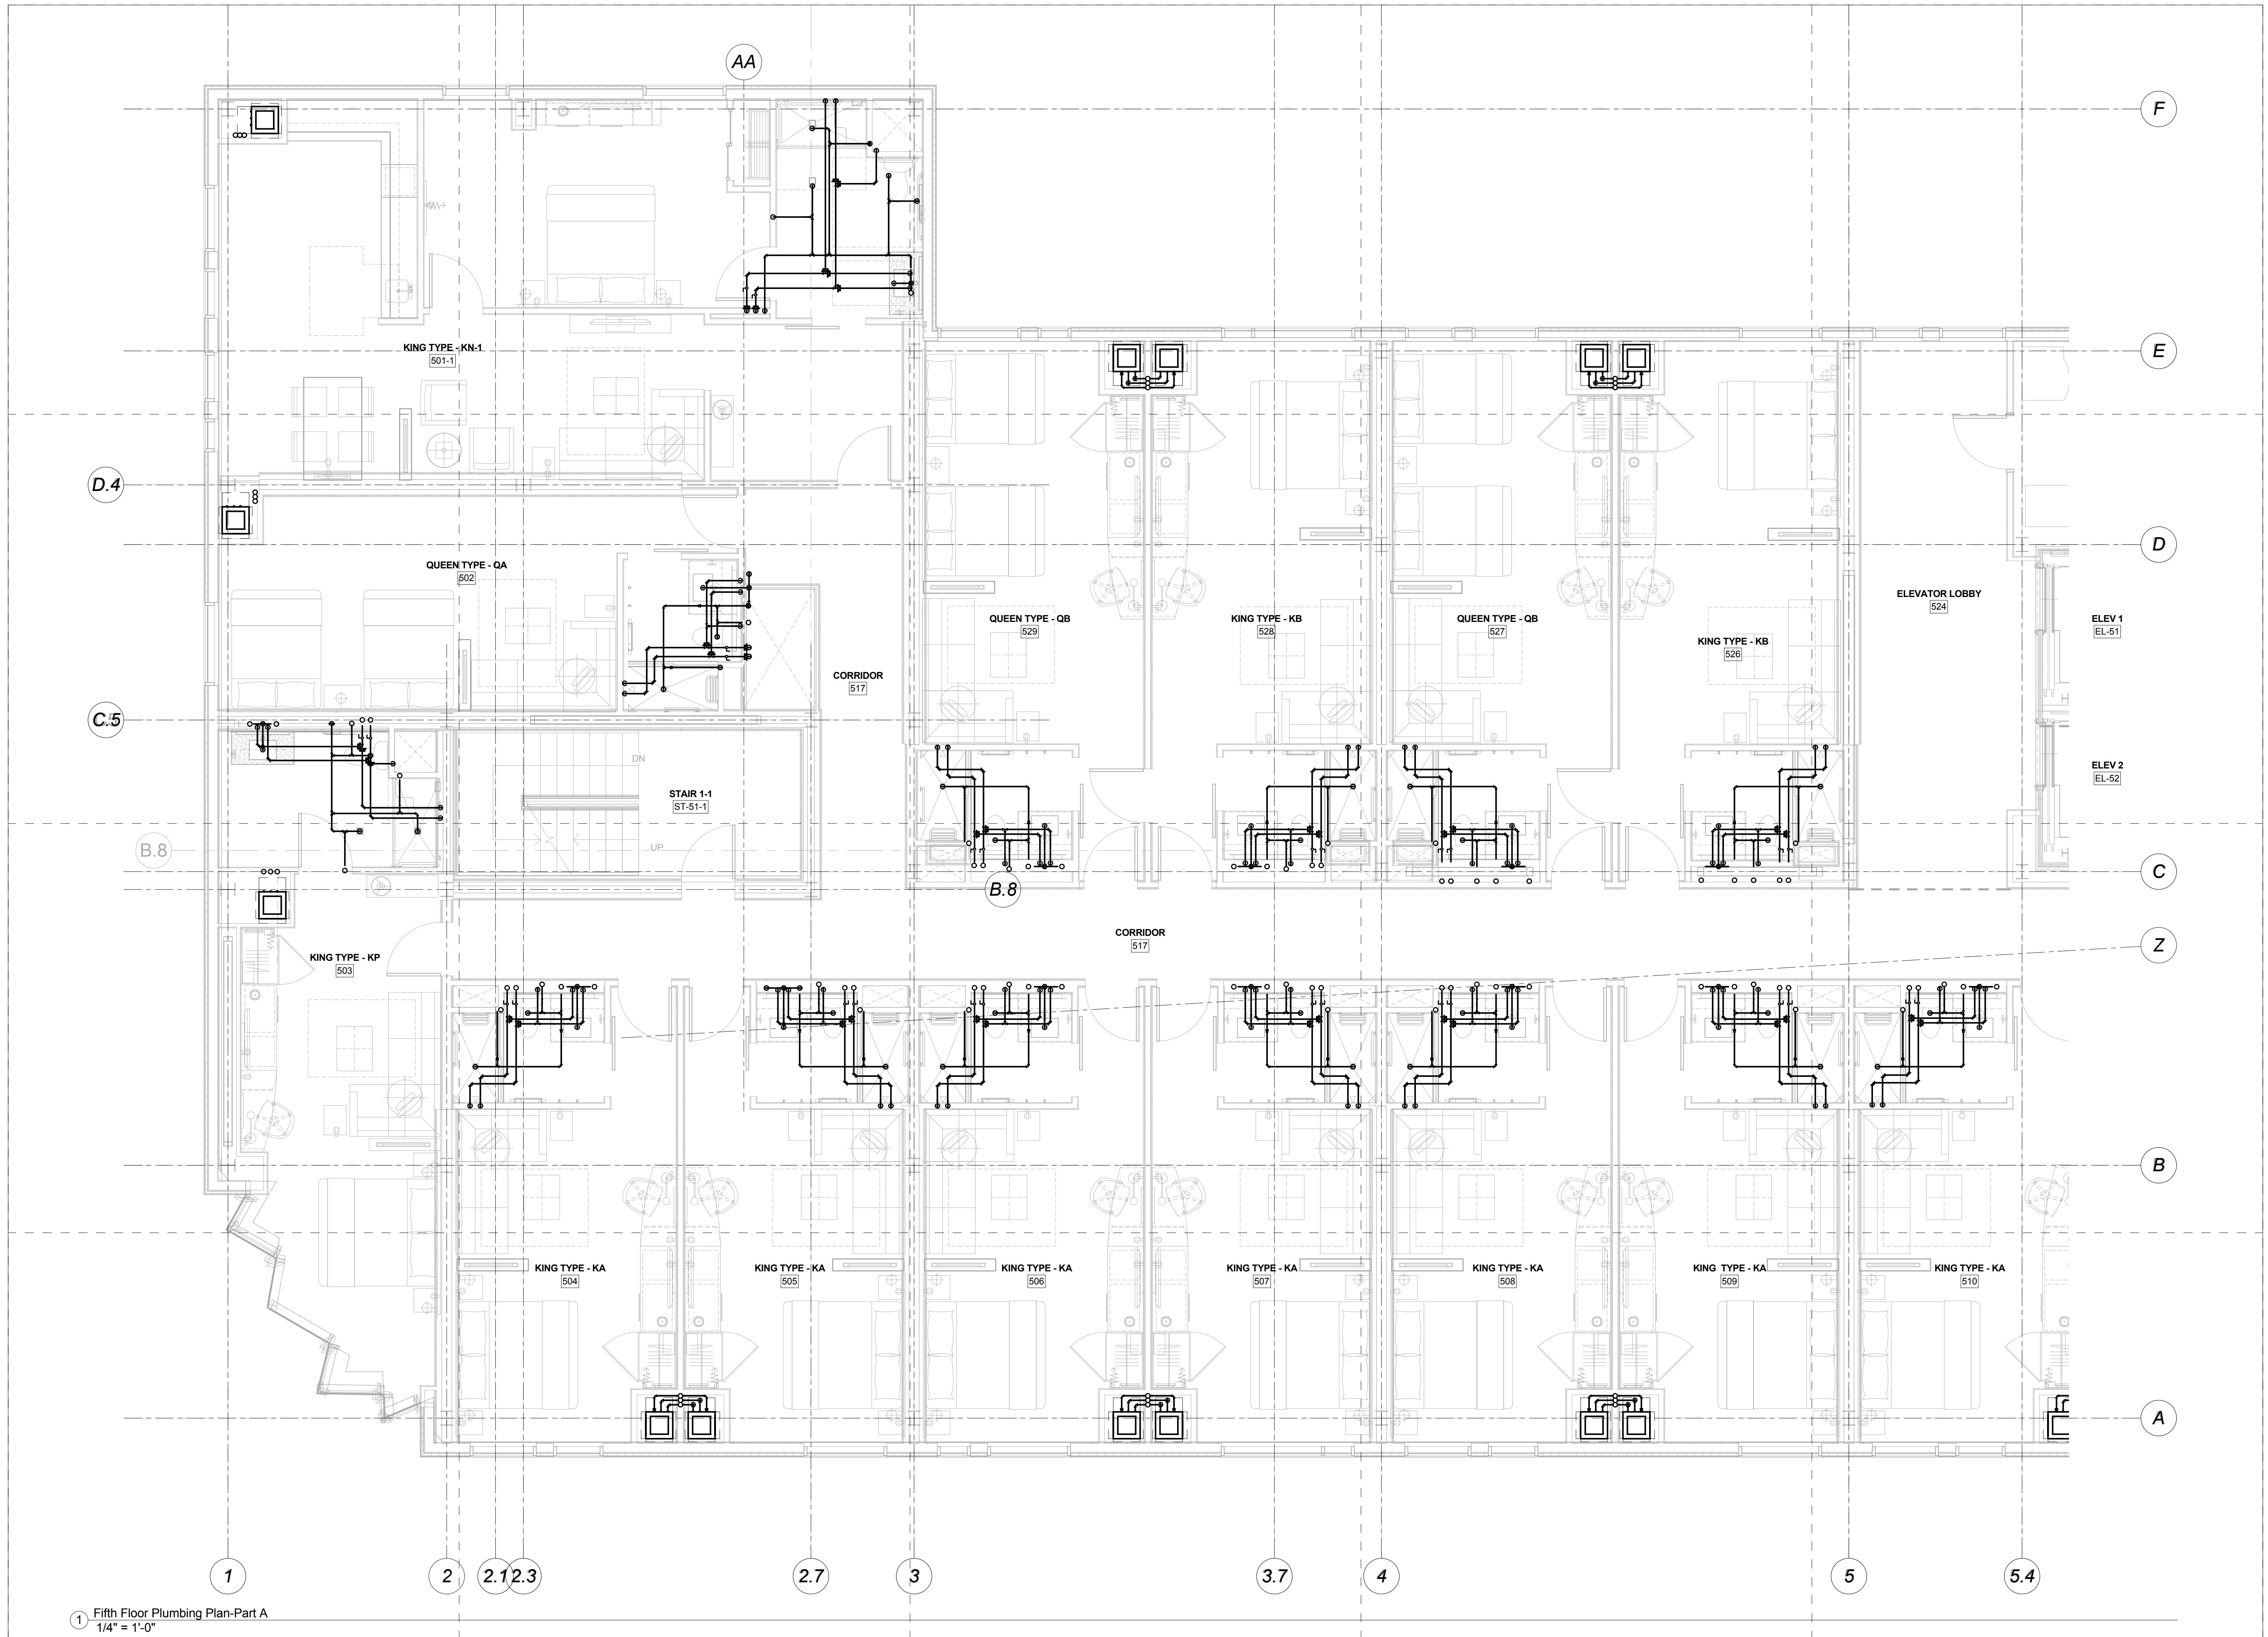

1 Fifth Floor Plumbing Plan-Part A
1/4" = 1'-0"

CANAL STUDIO
Architecture / Planning / Interior Design
207 553 2115
One Canal Plaza, Suite 888
Portland, Maine 04101
canalstudio.com


EAST BROWN COW
MANAGEMENT, INC.

shinberg
CONSULTING, LLC

Project Title
**Hyatt Place,
Portland-Old Port**
433 Fore Street
Portland, ME
CSS Project No. 12013

BENNETT ENGINEERING
MECHANICAL • ELECTRICAL
(207) 865-9475

Mark	Date	Description
Project Status		
DESIGN DEVELOPMENT		
11-16-12		
Drawing Title		
Fifth Floor Plumbing-Part A		
Scale: 1/4" = 1'-0"		
Drawing Number		
M20.5A		

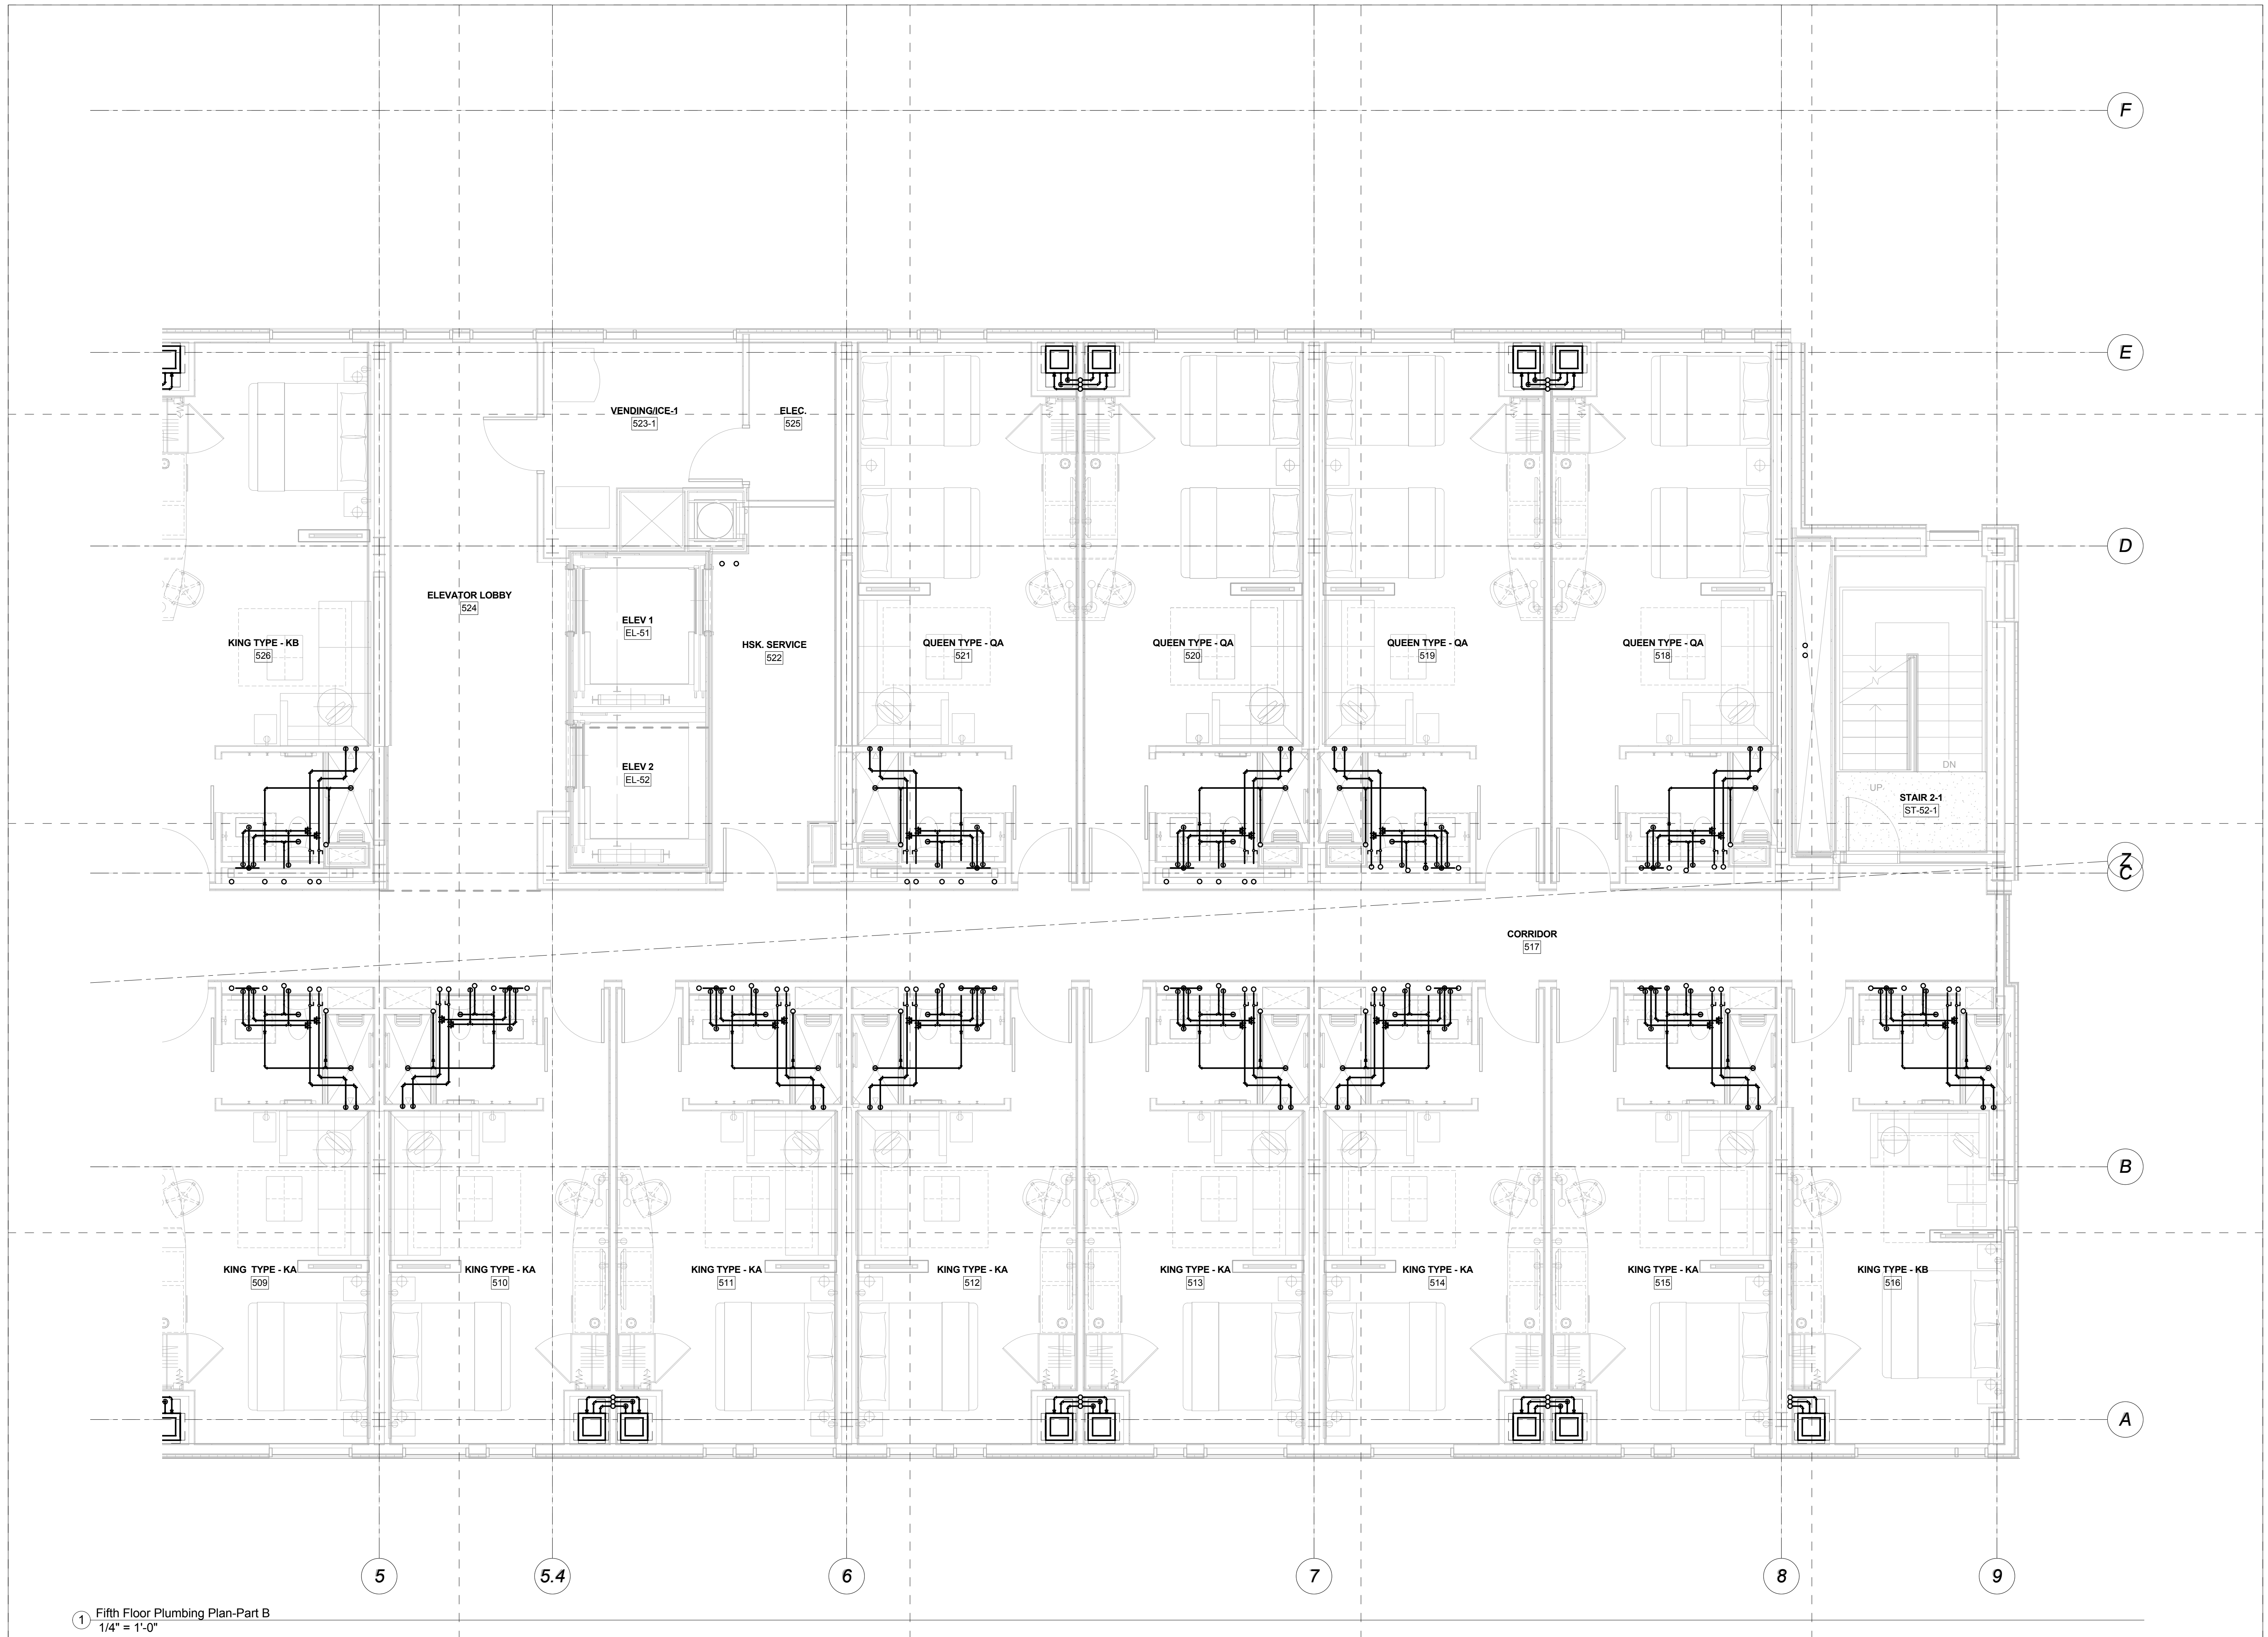

1 Fifth Floor Plumbing Plan-Part B
1/4" = 1'-0"

CANAL STUDIO
Architecture / Planning / Interior Design
207 553 2115
One Canal Plaza, Suite 888
Portland, Maine 04101
canalstudio.com

EAST BROWN COW
MANAGEMENT, INC.

shinberg
CONSULTING, LLC

Project Title
**Hyatt Place,
Portland-Old Port**
433 Fore Street
Portland, ME
CSS Project No. 12013


BENNETT ENGINEERING
MECHANICAL • ELECTRICAL
(207) 865-9475

Mark	Date	Description
Project Status		
DESIGN DEVELOPMENT		
11-16-12		

Drawing Title
**Fifth Floor
Plumbing-Part B**

Scale: 1/4" = 1'-0"


Drawing Number
M20.5B

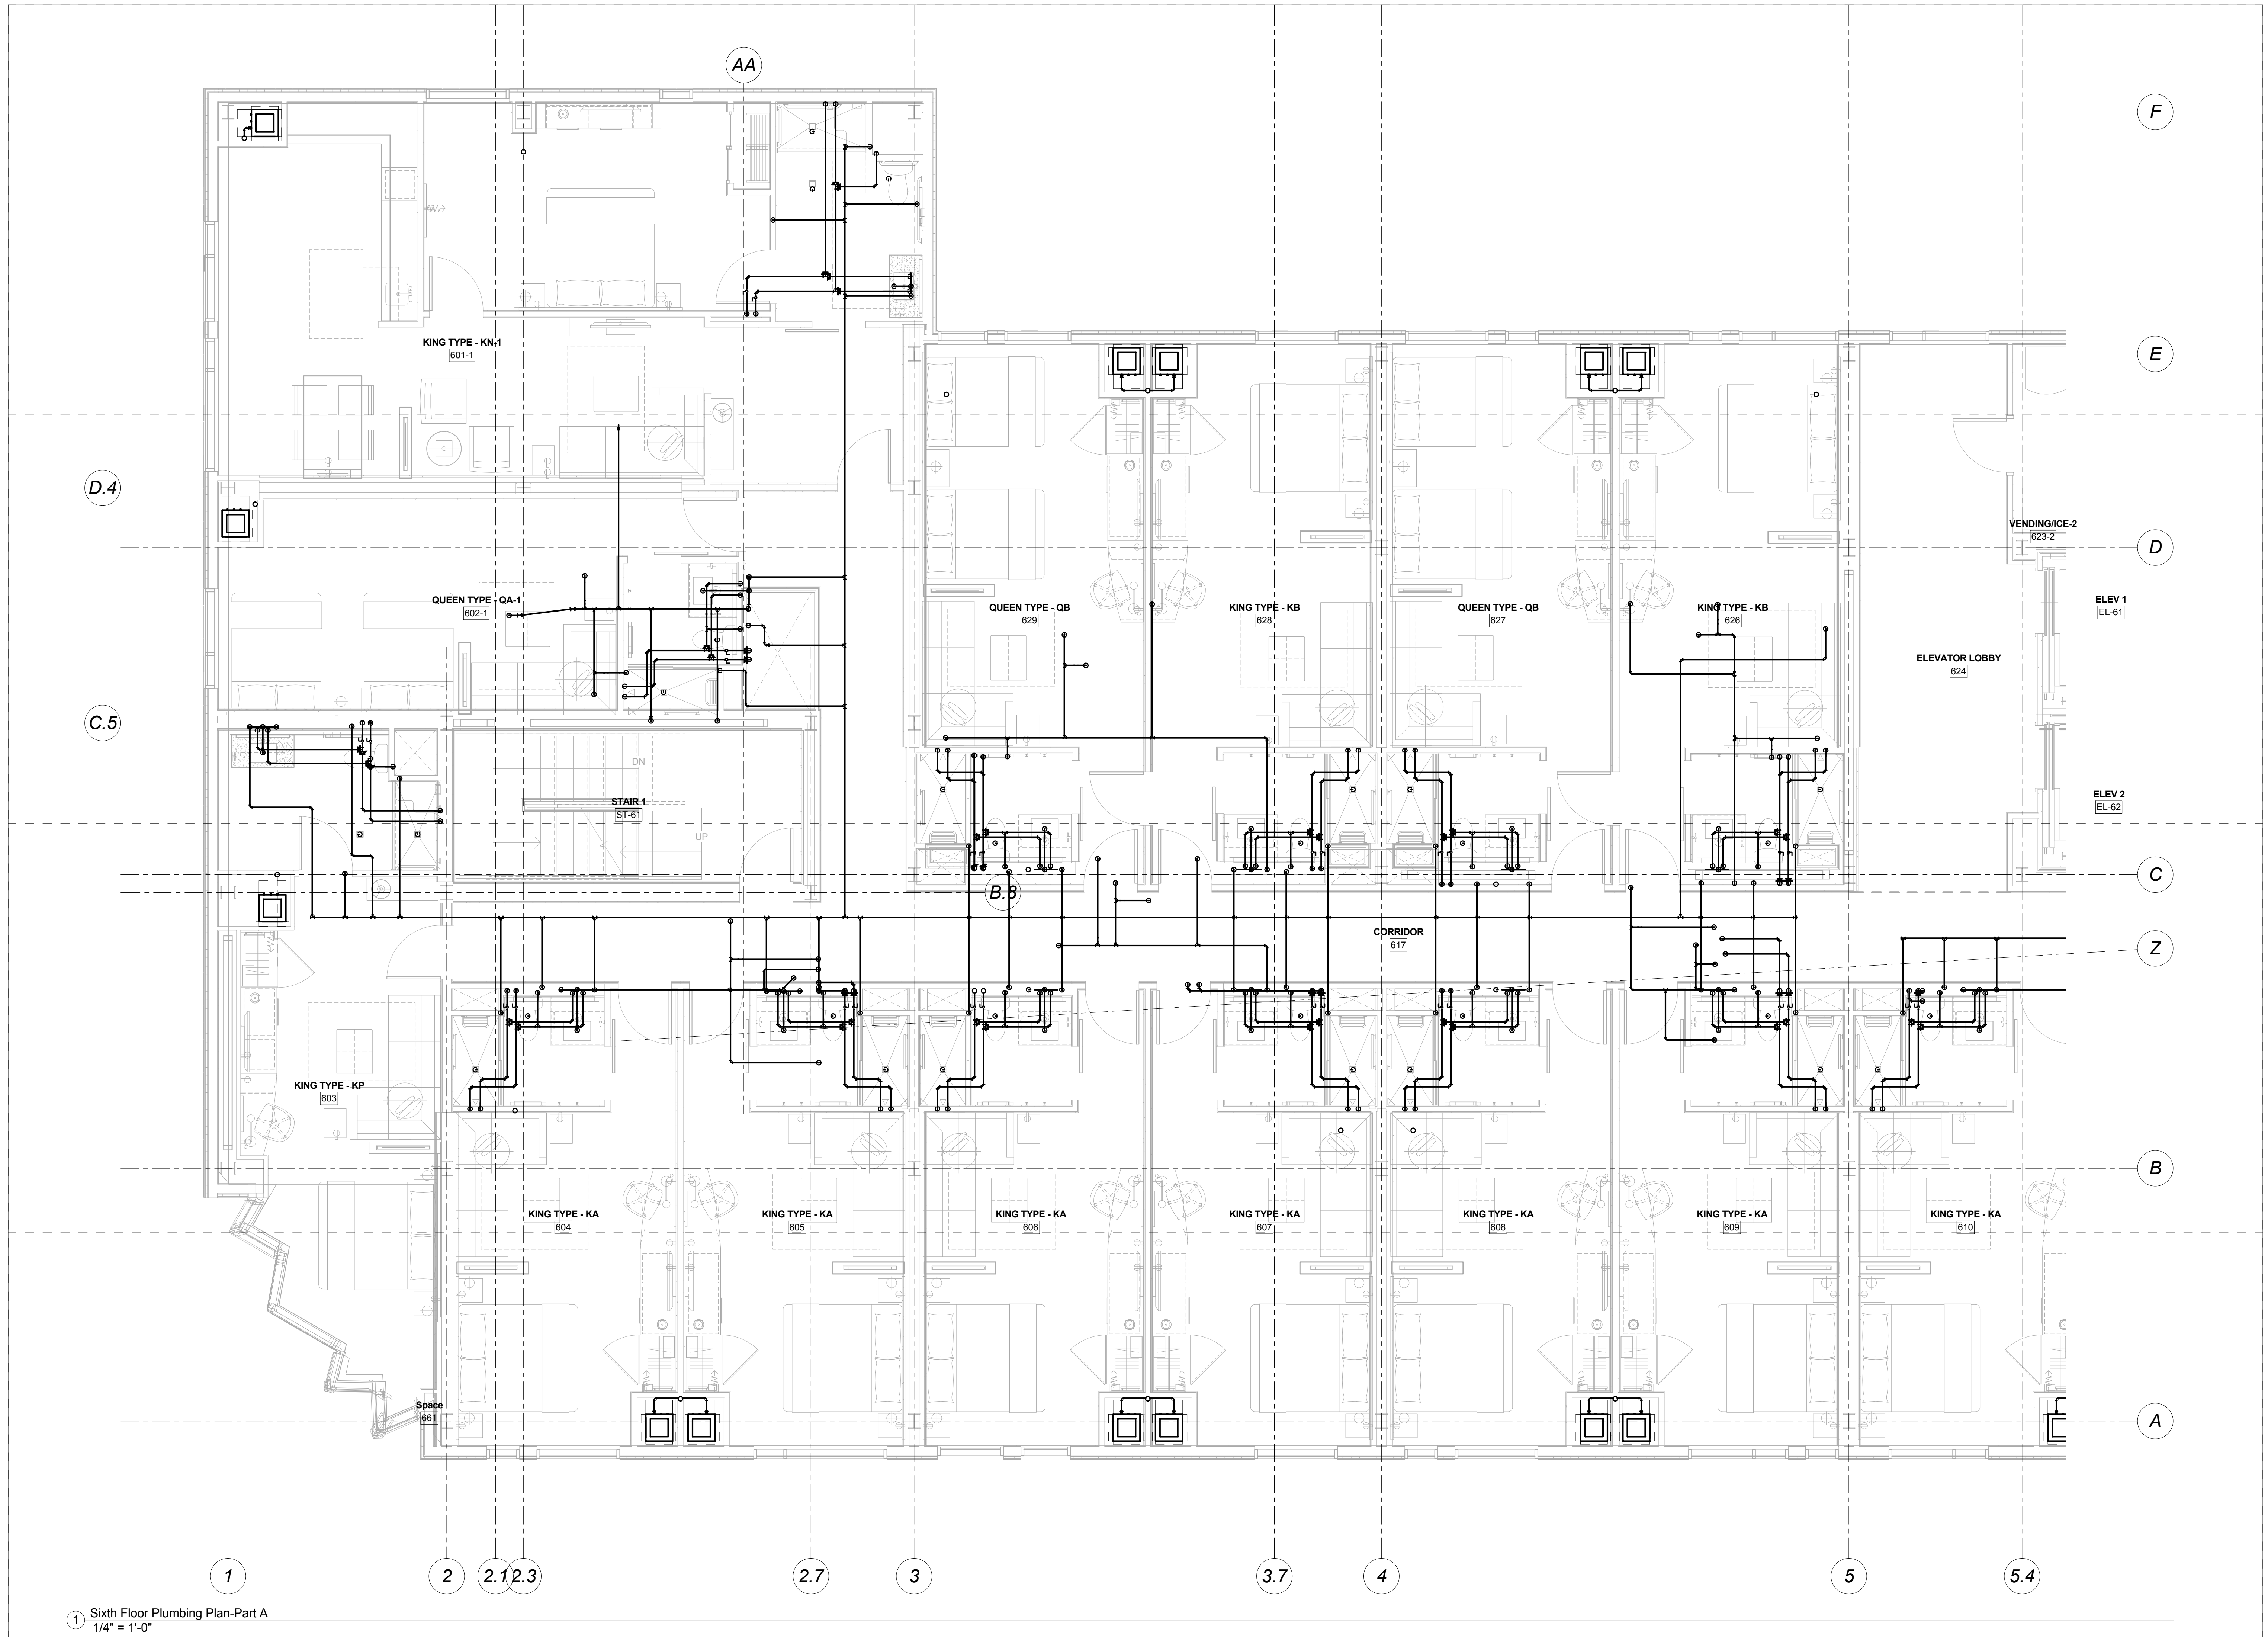


Mark	Date	Description
Project Status		
DESIGN DEVELOPMENT		
11-16-12		
Drawing Title		
Sixth Floor Plumbing-Part A		
Scale: 1/4" = 1'-0"		
Drawing Number		
M20.6A		

① Sixth Floor Plumbing Plan-Part A
1/4" = 1'-0"

Mark	Date	Description
Project Status		
DESIGN DEVELOPMENT		
11-16-12		
Drawing Title		
Sixth Floor Plumbing-Part B		
Scale: 1/4" = 1'-0"		
Drawing Number		
M20.6B		

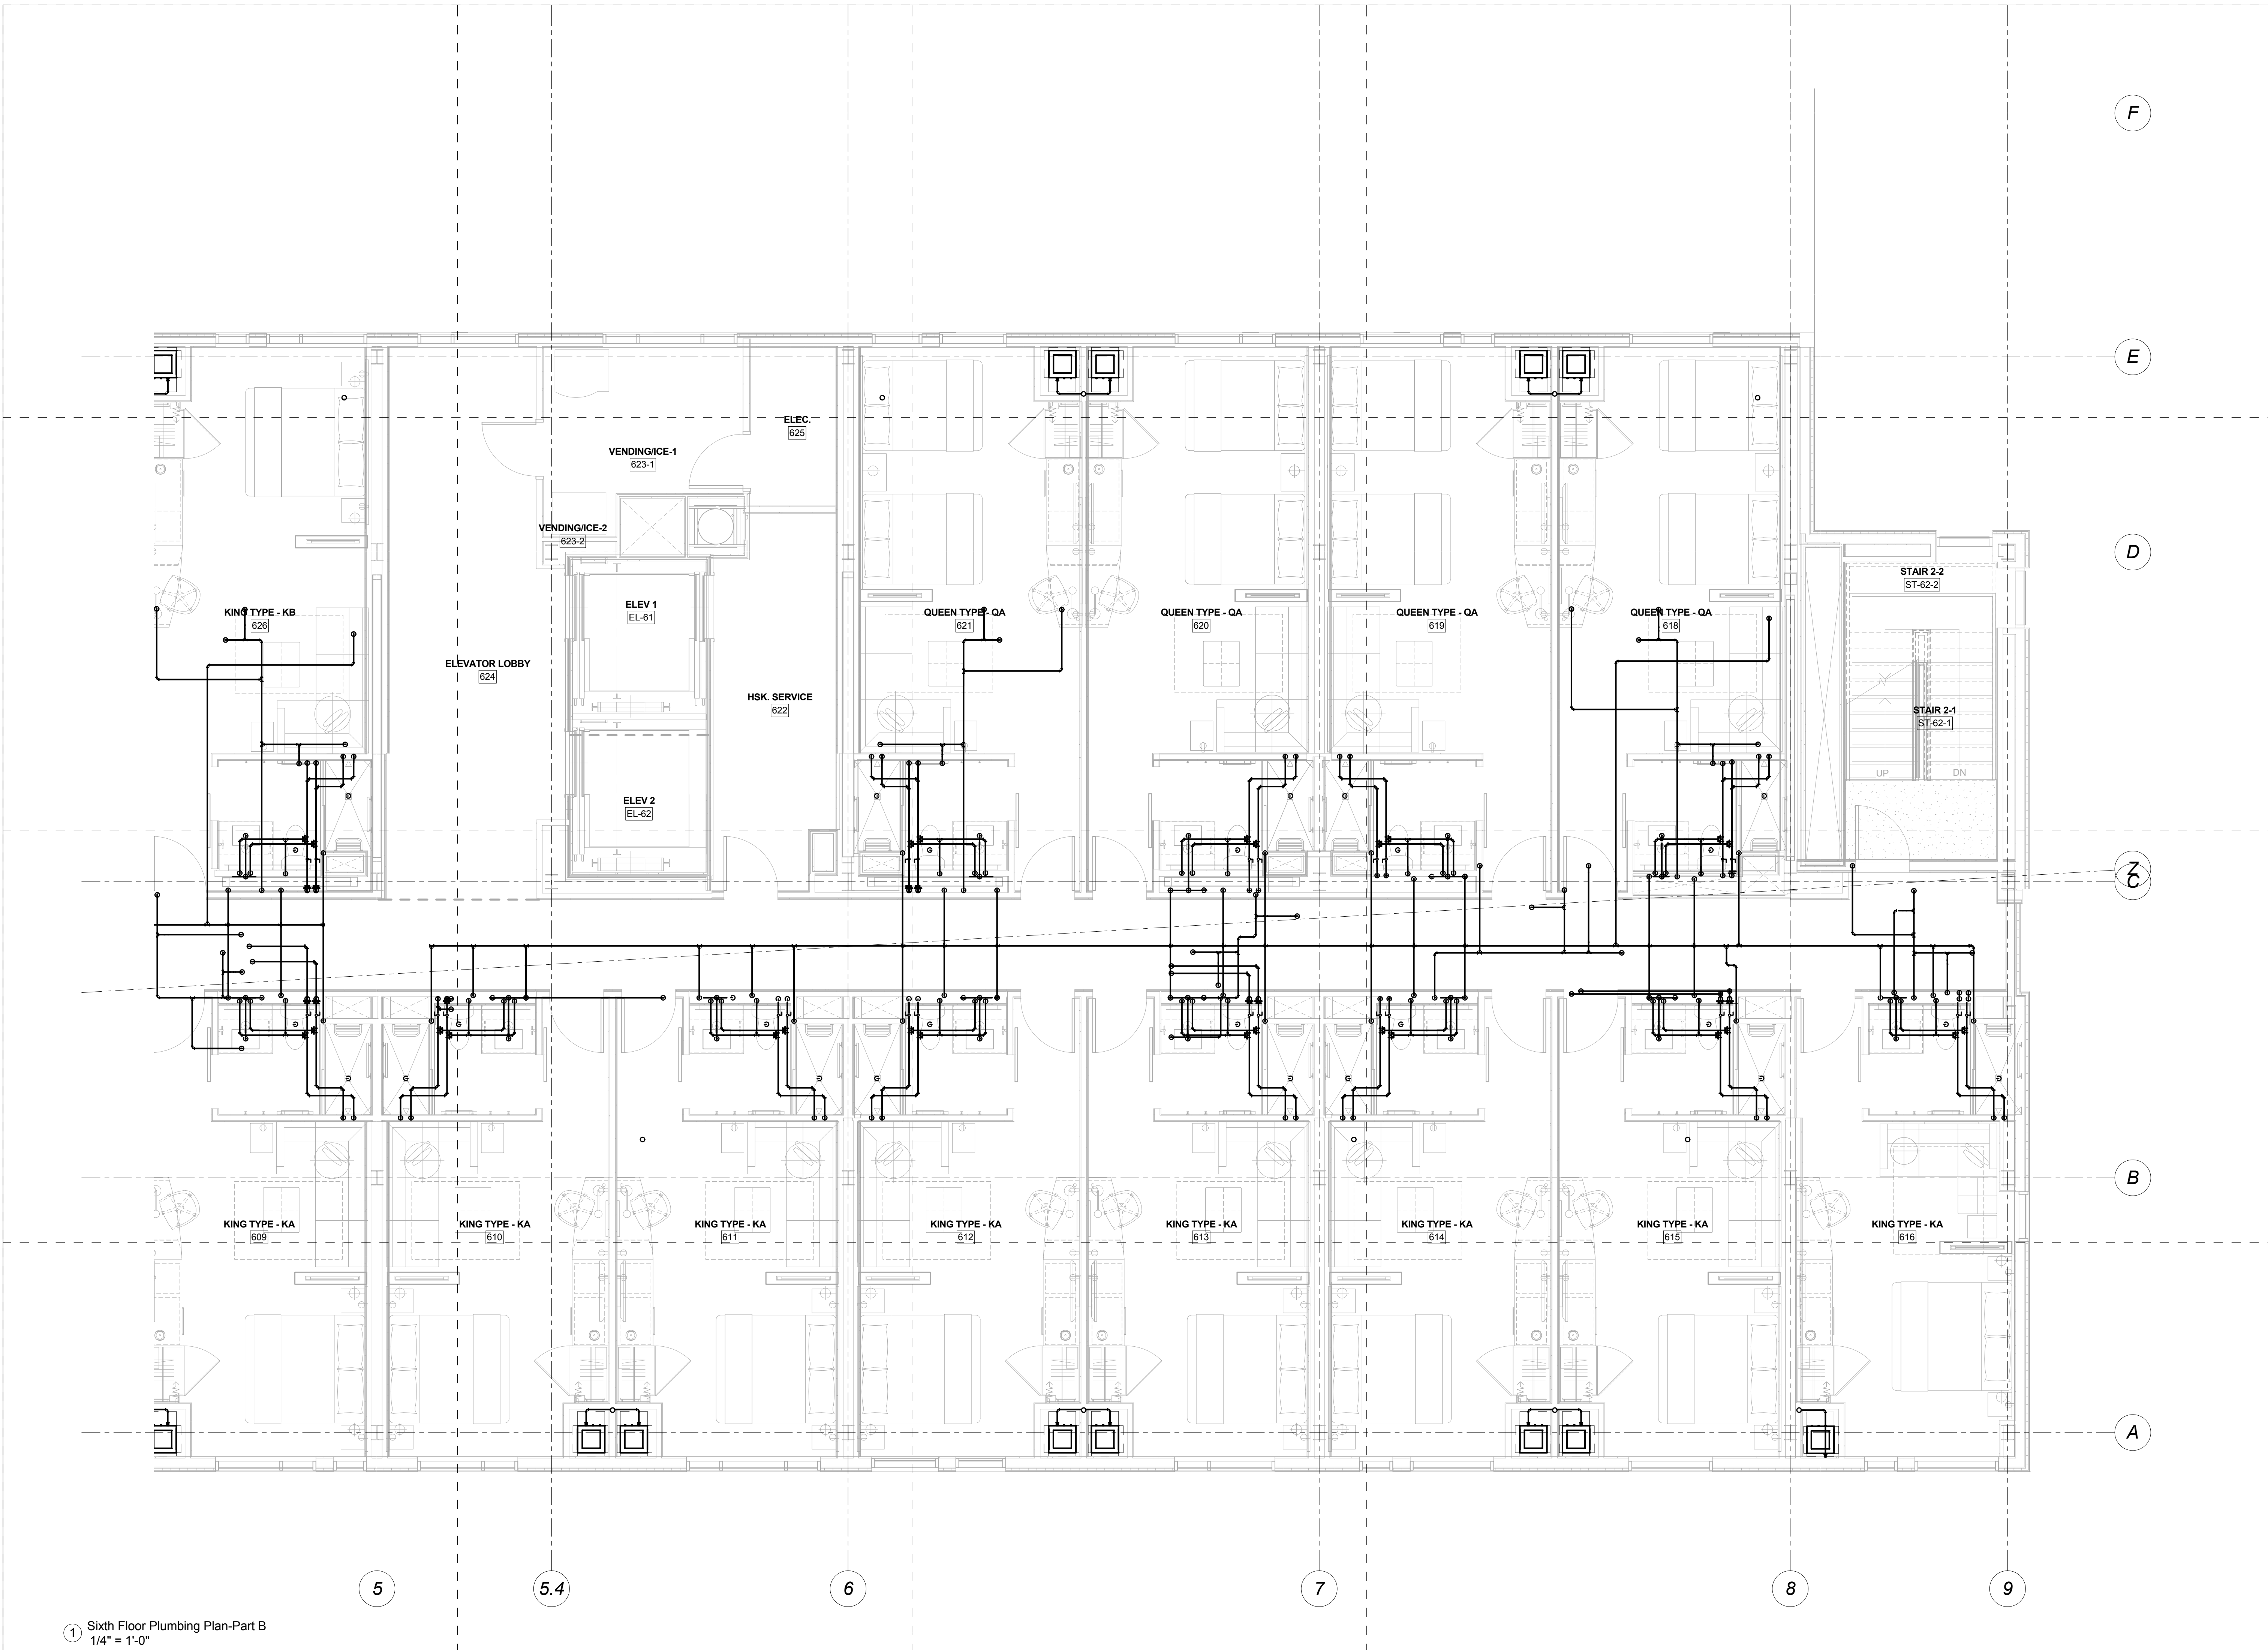

① Sixth Floor Plumbing Plan-Part B
 1/4" = 1'-0"

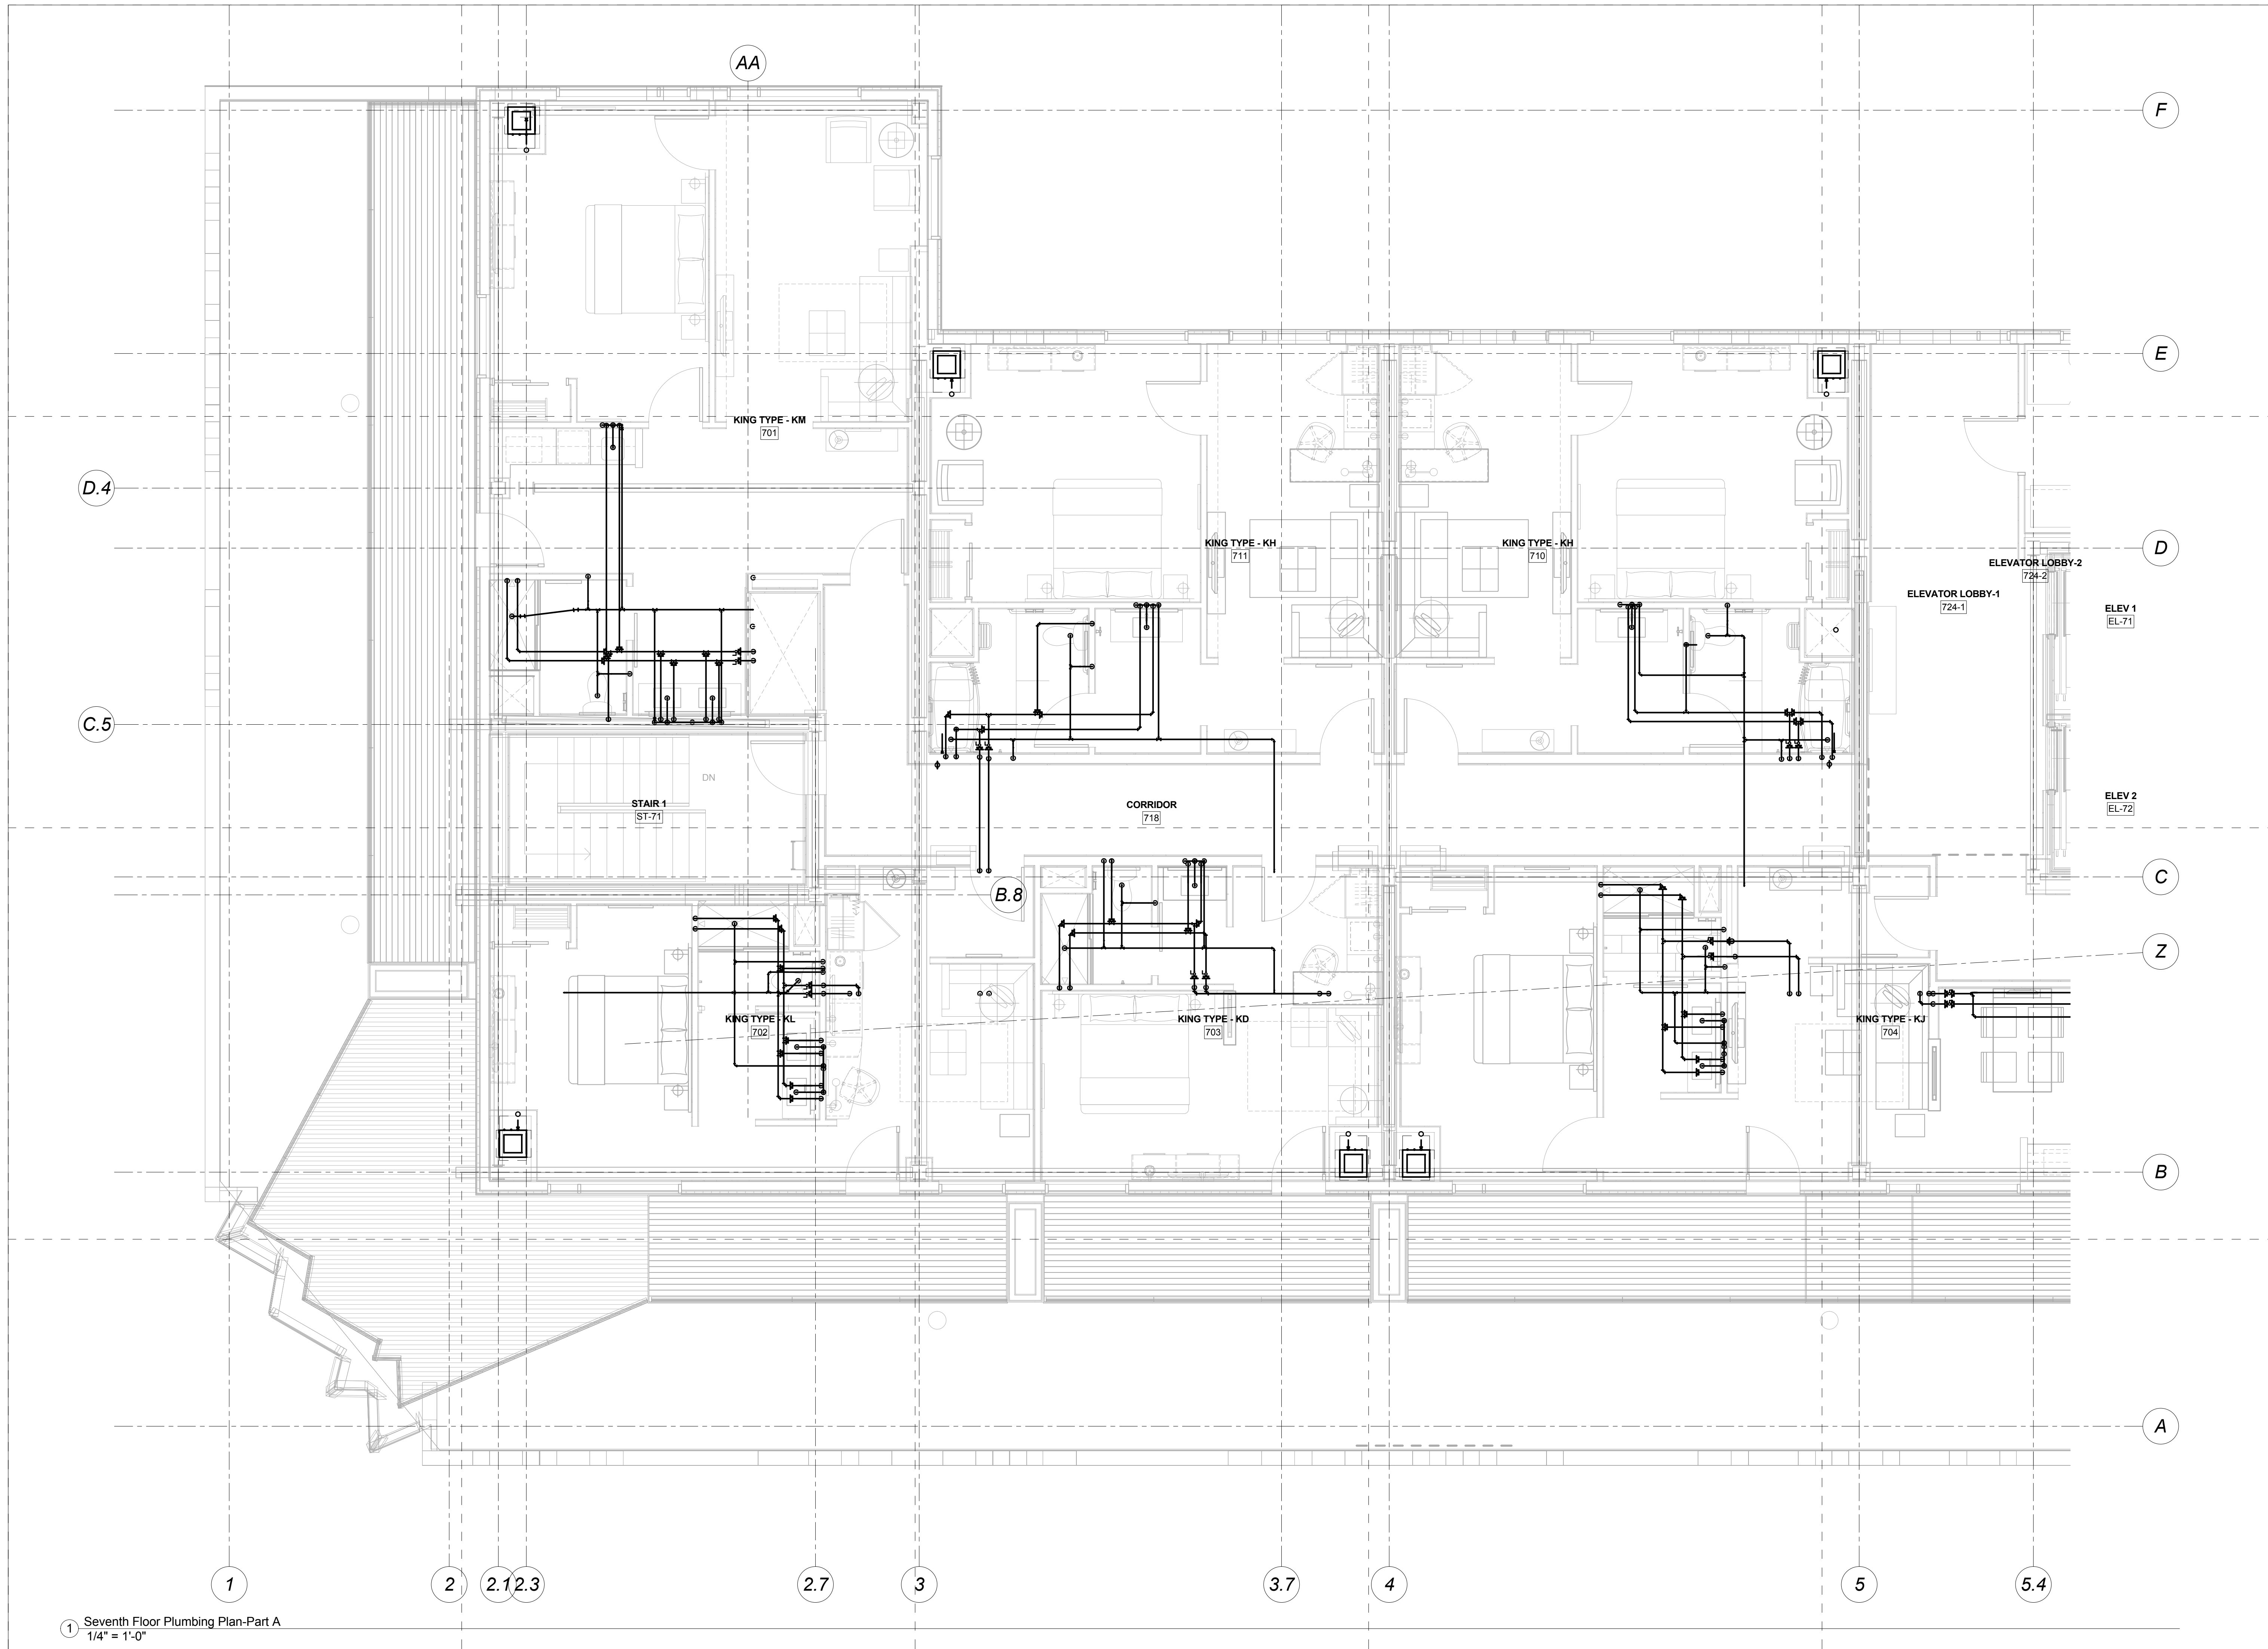

1 Seventh Floor Plumbing Plan-Part A
1/4" = 1'-0"

CANAL 5 STUDIO
Architecture / Planning / Interior Design
207 553 2115
One Canal Plaza, Suite 888
Portland, Maine 04101
canal5studio.com

EAST BROWN COW
MANAGEMENT, INC.

shinberg
CONSULTING, LLC

Project Title
**Hyatt Place,
Portland-Old Port**

433 Fore Street
Portland, ME
CSS Project No. 12013

BENNETT ENGINEERING
MECHANICAL • ELECTRICAL
(207) 865-9475

Mark	Date	Description
Project Status		
DESIGN DEVELOPMENT		
11-16-12		
Drawing Title		
Seventh Floor Plumbing-Part A		
Scale: 1/4" = 1'-0"		
Drawing Number		
M20.7A		

Mark	Date	Description
------	------	-------------

Project Status

**DESIGN
DEVELOPMENT**
11-16-12


Drawing Title

**Seventh Floor
Plumbing-Part B**


Scale: 1/4" = 1'-0"

Drawing Number

M20.7B

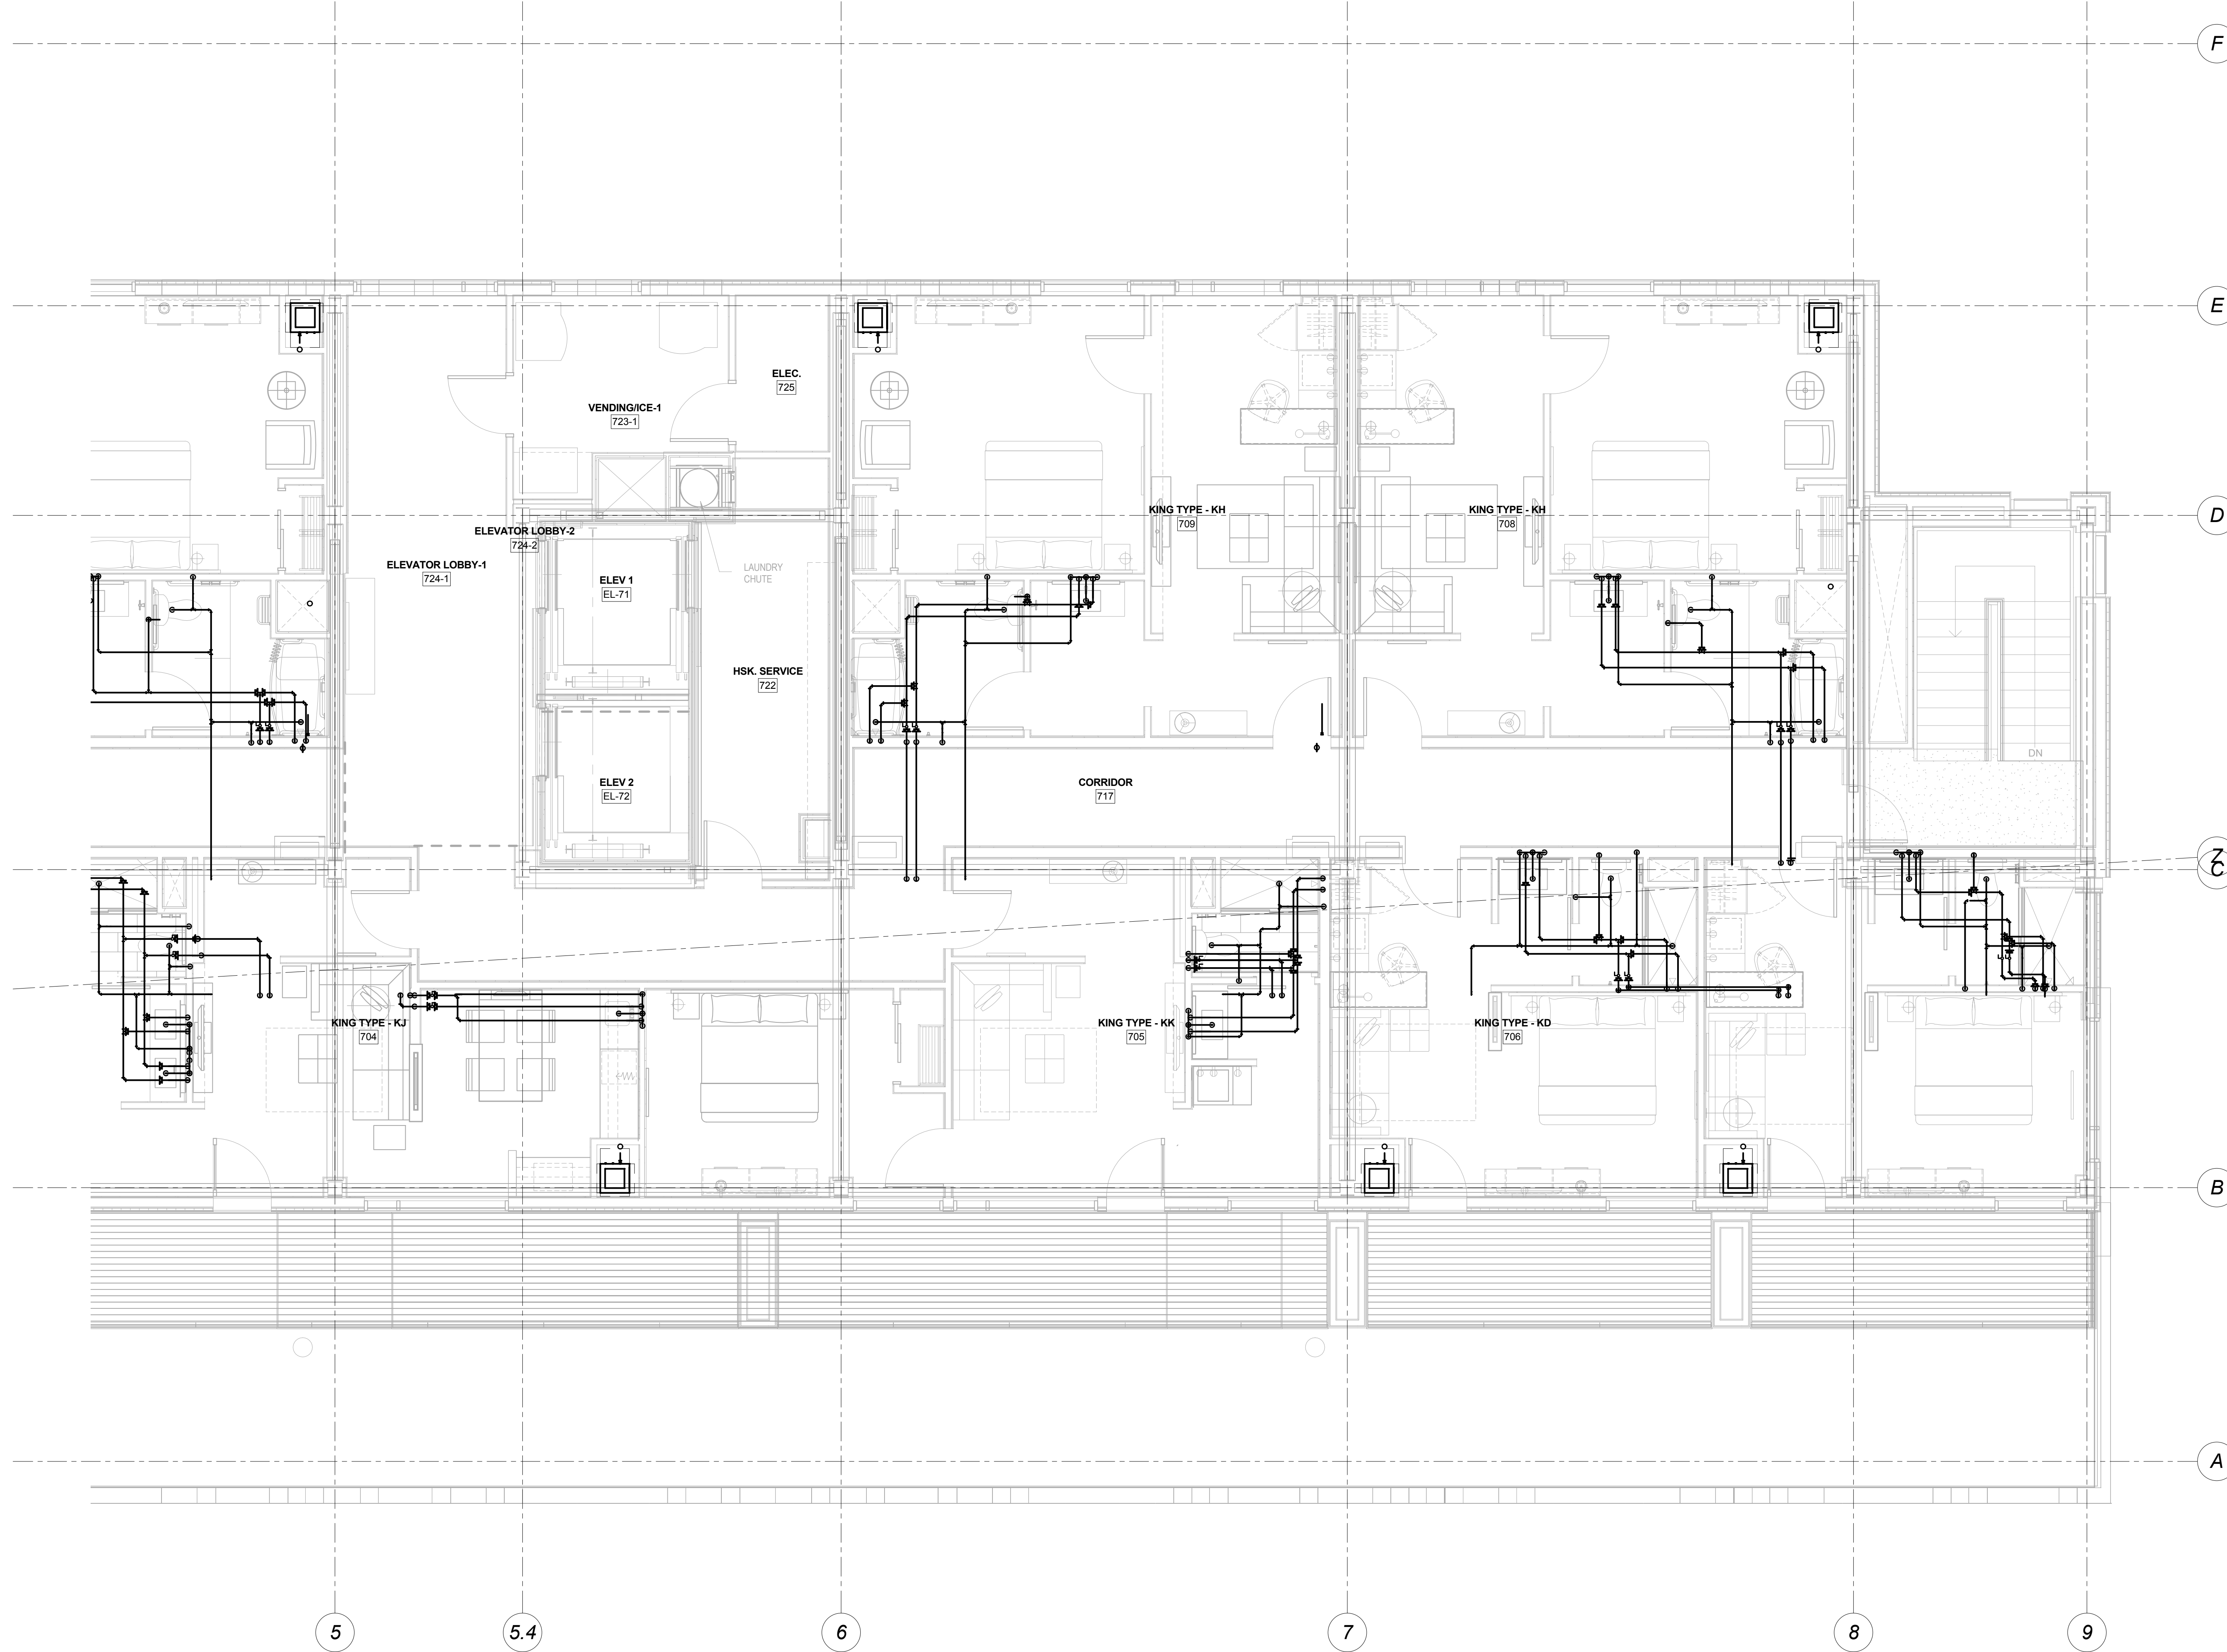

① Seventh Floor Plumbing Plan-Part B
1/4" = 1'-0"

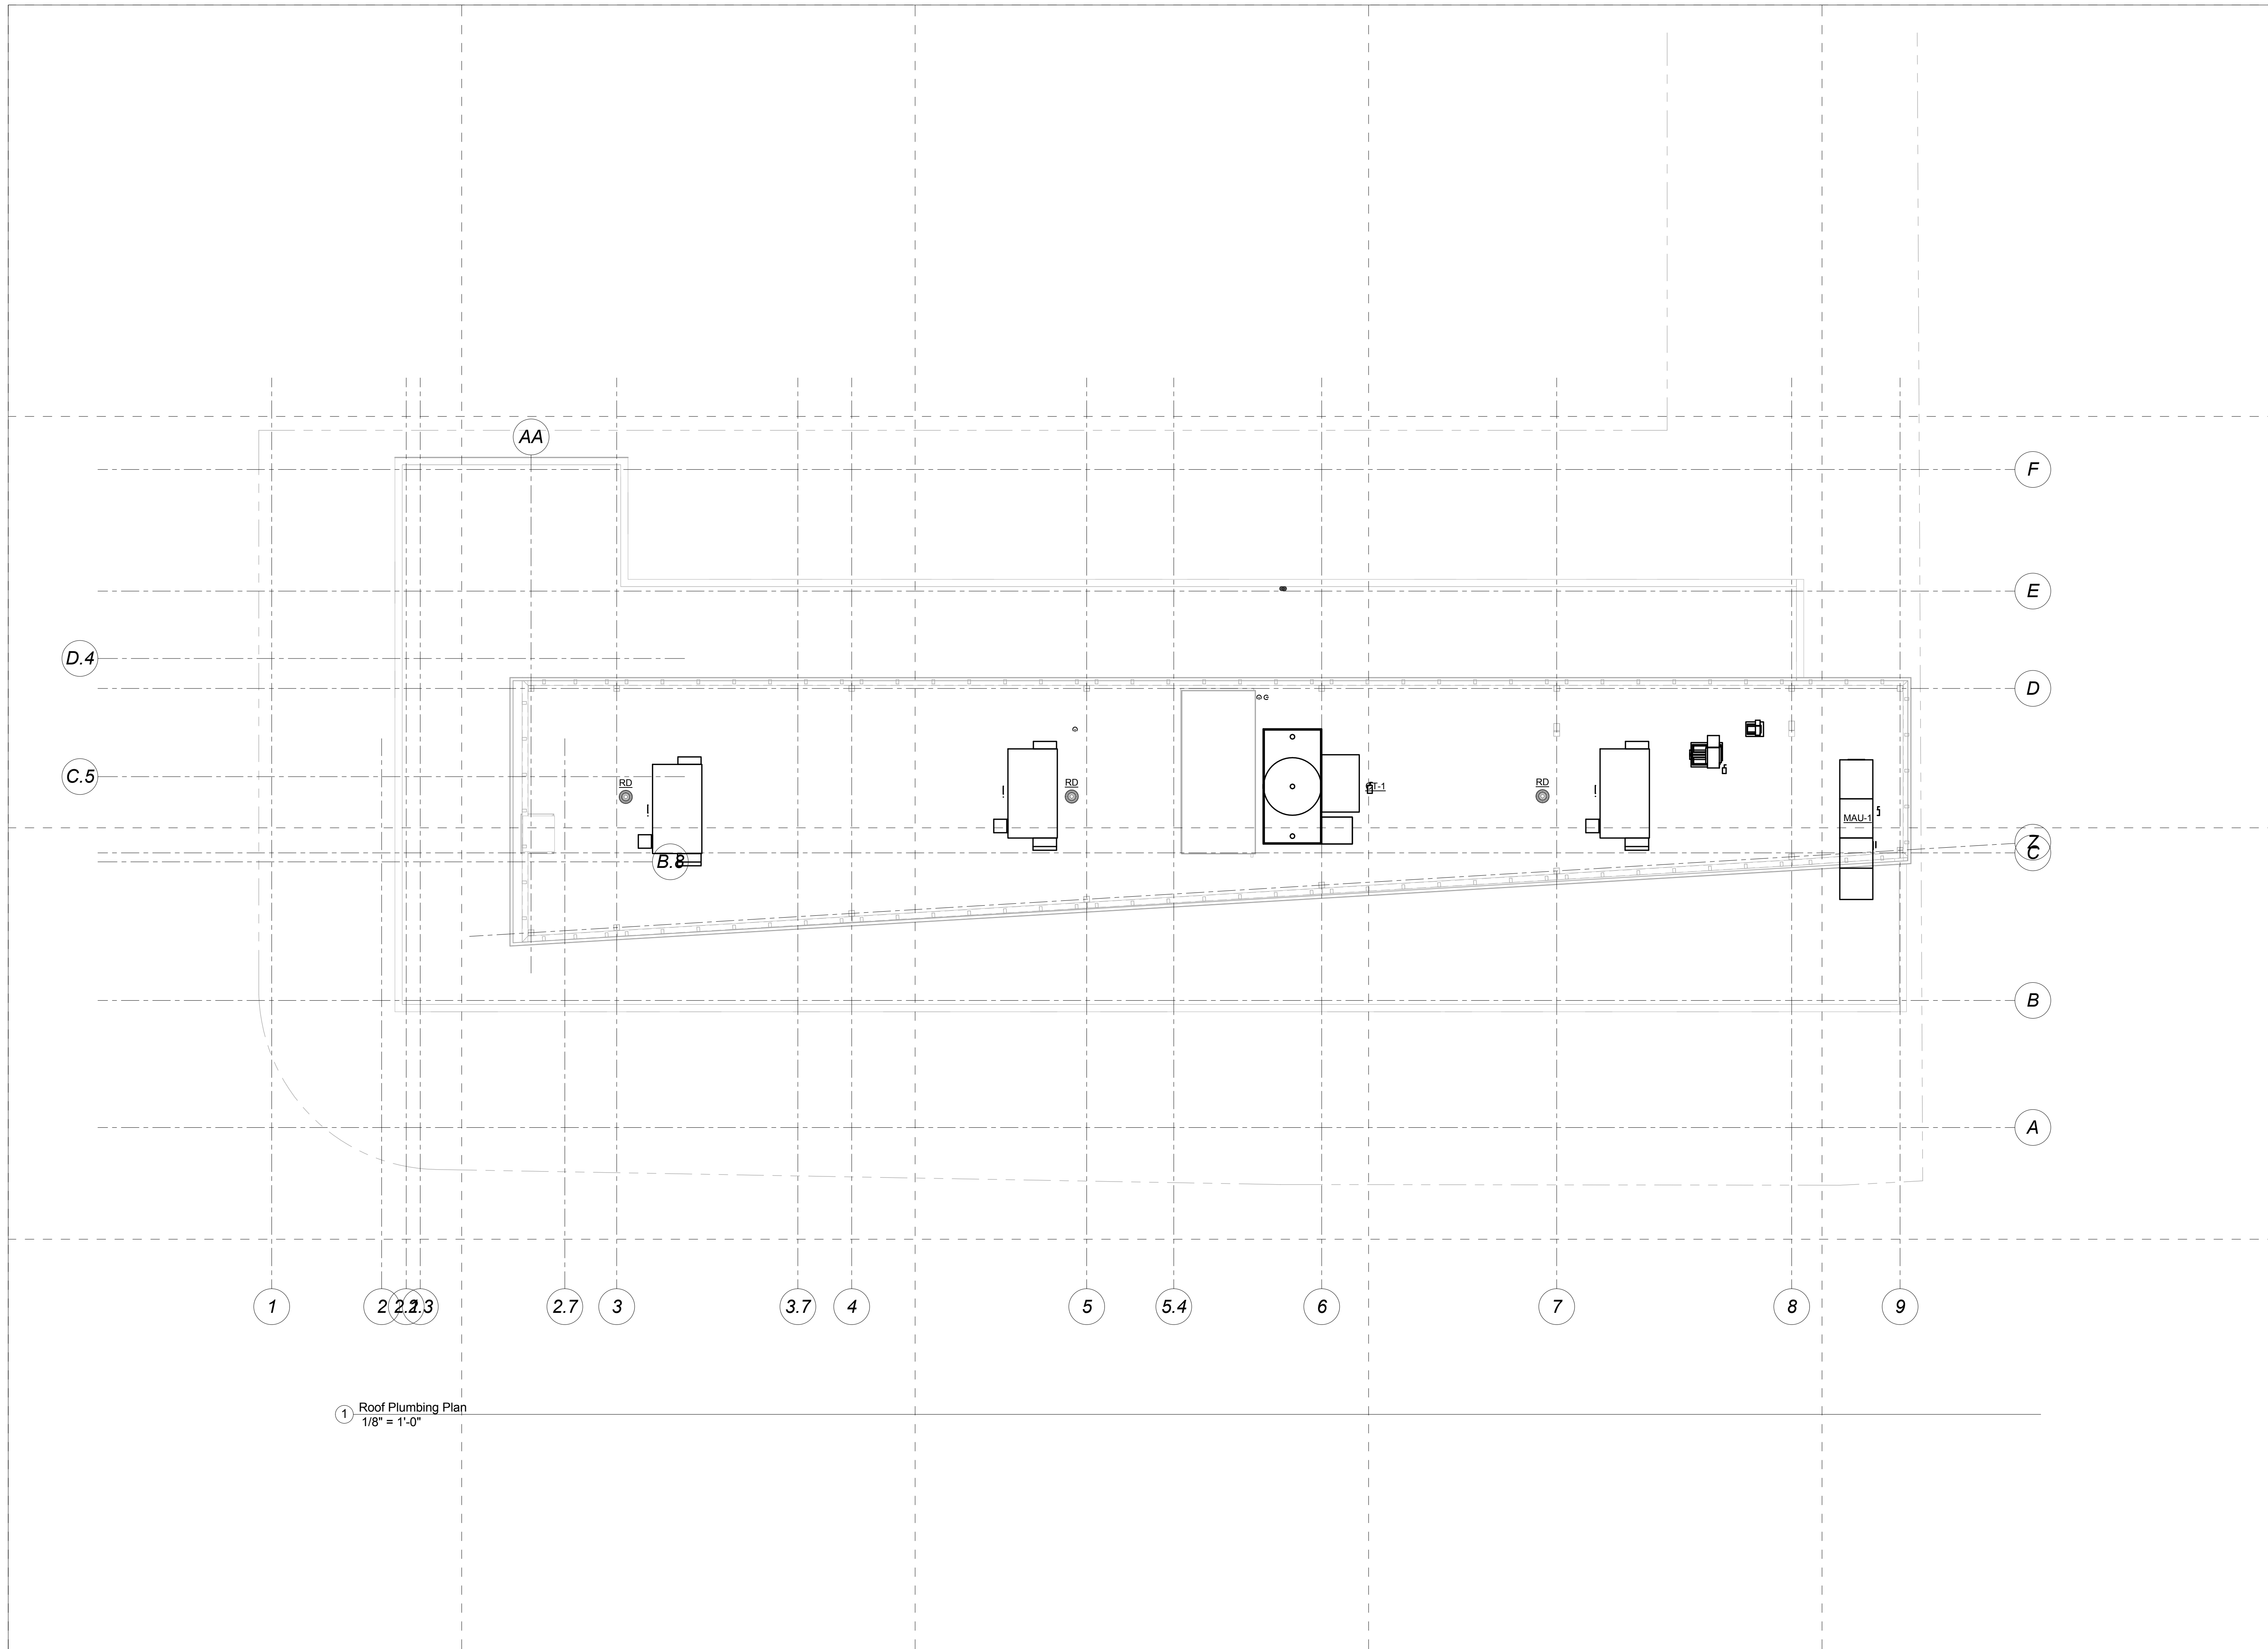

1 Roof Plumbing Plan
1/8" = 1'-0"

Mark	Date	Description
------	------	-------------

Project Status	DESIGN DEVELOPMENT
	11-16-12

Drawing Title	Roof Plumbing
---------------	----------------------

Scale:	1/8" = 1'-0"
--------	--------------

Drawing Number	M20.8
----------------	--------------