

1 First Floor Electrical Plan-Part A
1/4" = 1'-0"

CANAL STUDIO
Architecture / Planning / Interior Design
207 553 2115
One Canal Plaza, Suite 888
Portland, Maine 04101
canal5studio.com

EAST BROWN COW
MANAGEMENT, LLC

shinberg
CONSULTING, LLC


Project Title
**Hyatt Place,
Portland-Old Port**

433 Fore Street
Portland, ME

CSS Project No. 12013

BENNETT ENGINEERING
MECHANICAL • ELECTRICAL
(207) 865-9475

| Mark | Date | Description |
|-------------------------------------------|------|-------------|
| Project Status | | |
| DESIGN DEVELOPMENT | | |
| 11-16-12 | | |
| Drawing Title | | |
| First Floor Electrical Plan-Part A | | |
| Scale: 1/4" = 1'-0" | | |
| Drawing Number | | |
| E30.1A | | |

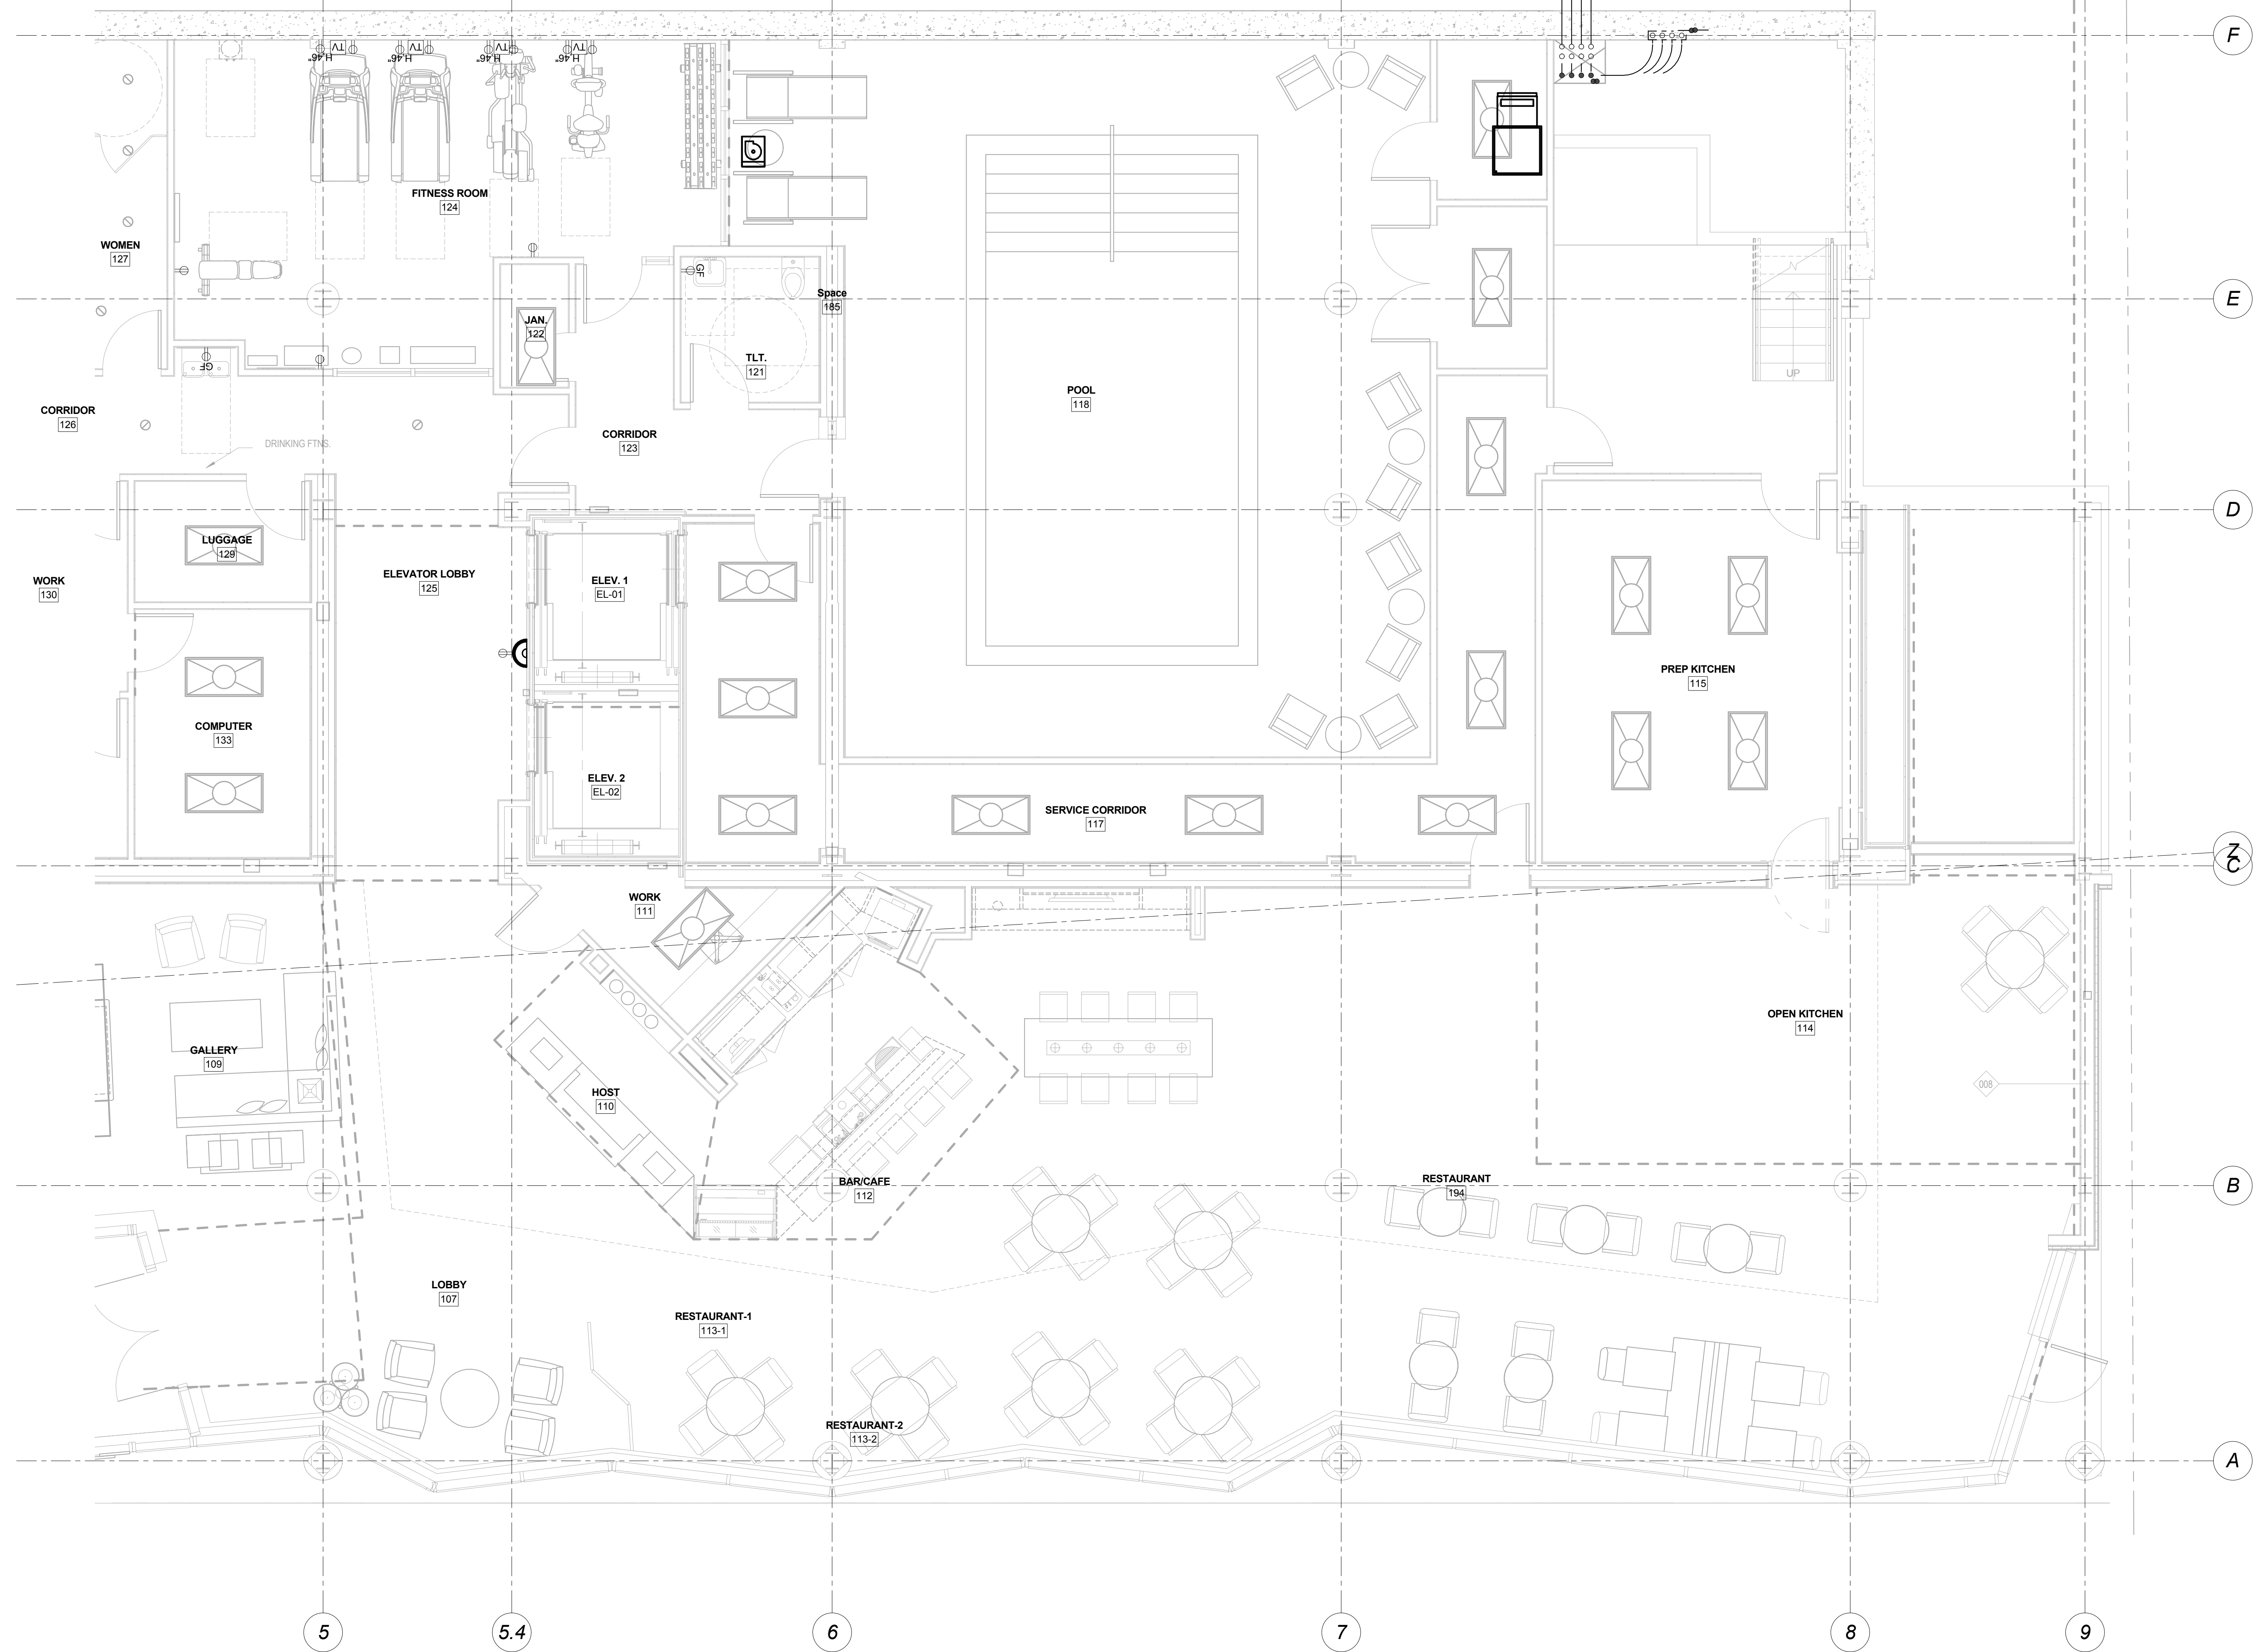

1 First Floor Electrical Plan-Part B
1/4" = 1'-0"


| Mark | Date | Description |
|------|------|-------------|
| | | |

| | |
|----------------|-------------------------------------------|
| Project Status | DESIGN DEVELOPMENT 11-16-12 |
|----------------|-------------------------------------------|

| | |
|---------------|-----------------------------------------------|
| Drawing Title | First Floor Electrical Plan-Part B |
|---------------|-----------------------------------------------|


| | |
|--------|--------------|
| Scale: | 1/4" = 1'-0" |
|--------|--------------|

| | |
|----------------|---------------|
| Drawing Number | E30.1B |
|----------------|---------------|

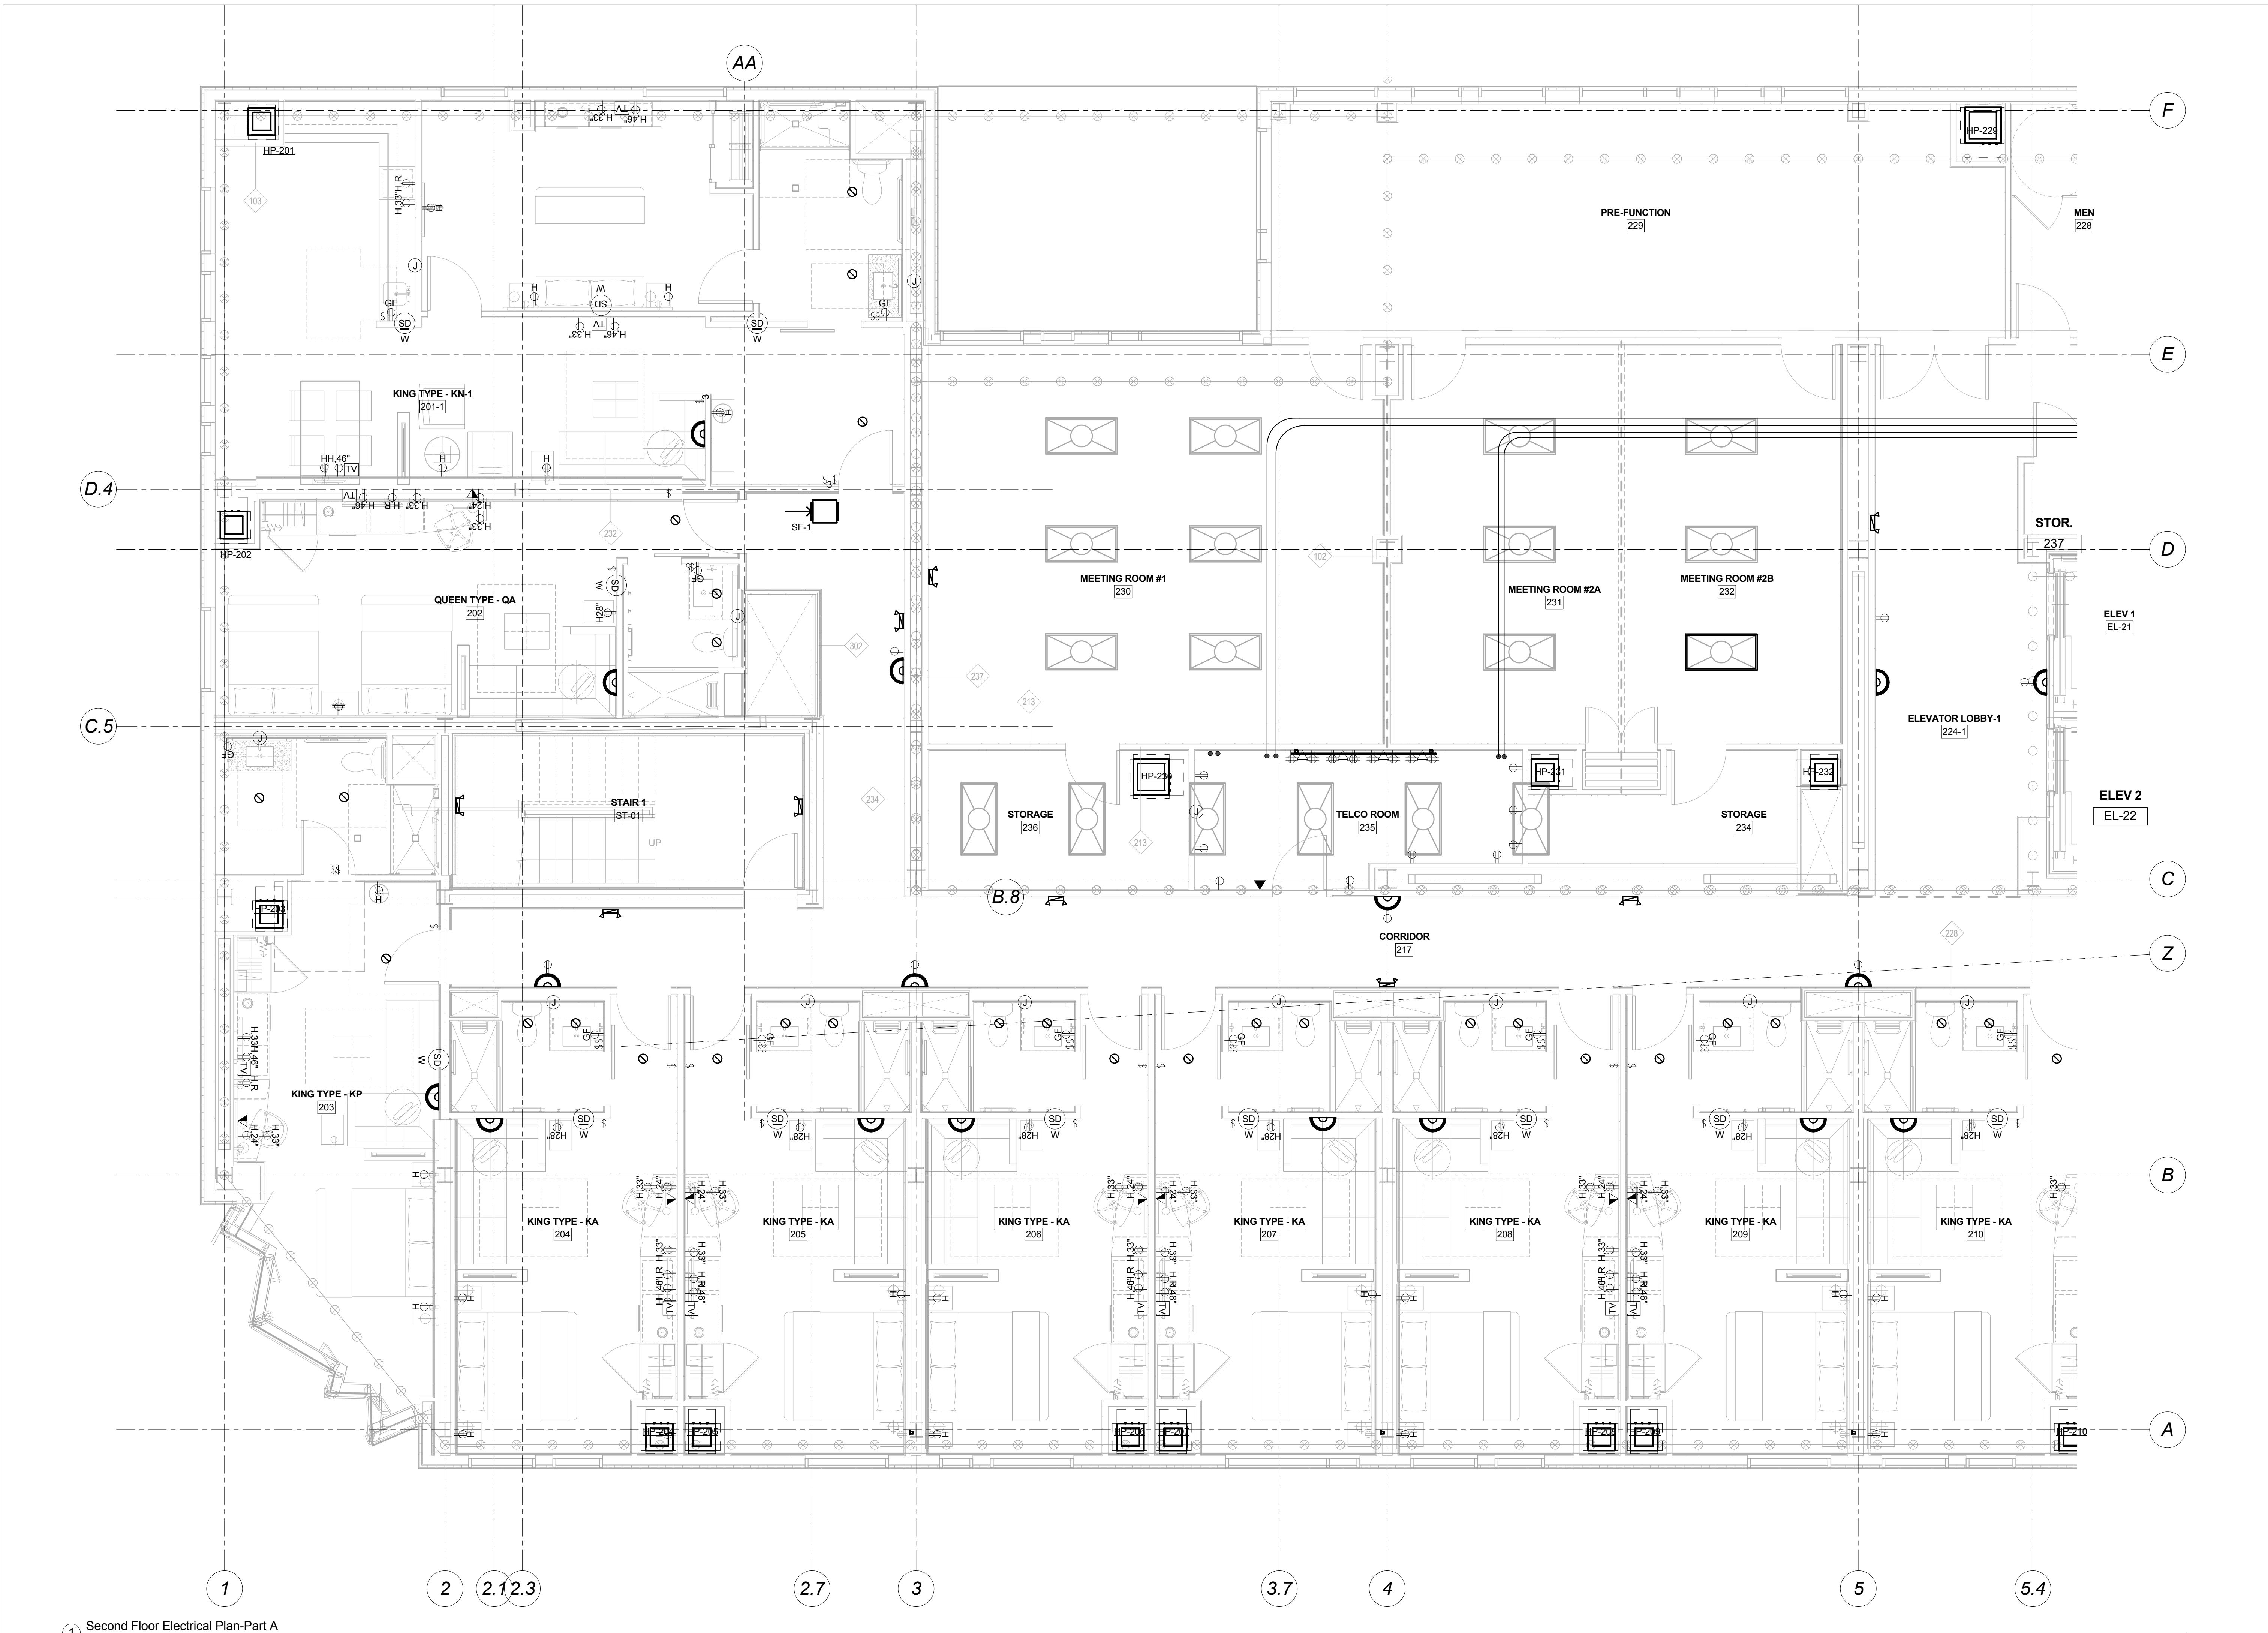

1 Second Floor Electrical Plan-Part A
 1/4" = 1'-0"

| Mark | Date | Description |
|--------------------------------------------|------|-------------|
| Project Status | | |
| DESIGN DEVELOPMENT | | |
| 11-16-12 | | |
| Drawing Title | | |
| Second Floor Electrical Plan-Part A | | |
| Scale: 1/4" = 1'-0" | | |
| Drawing Number | | |
| E30.2A | | |

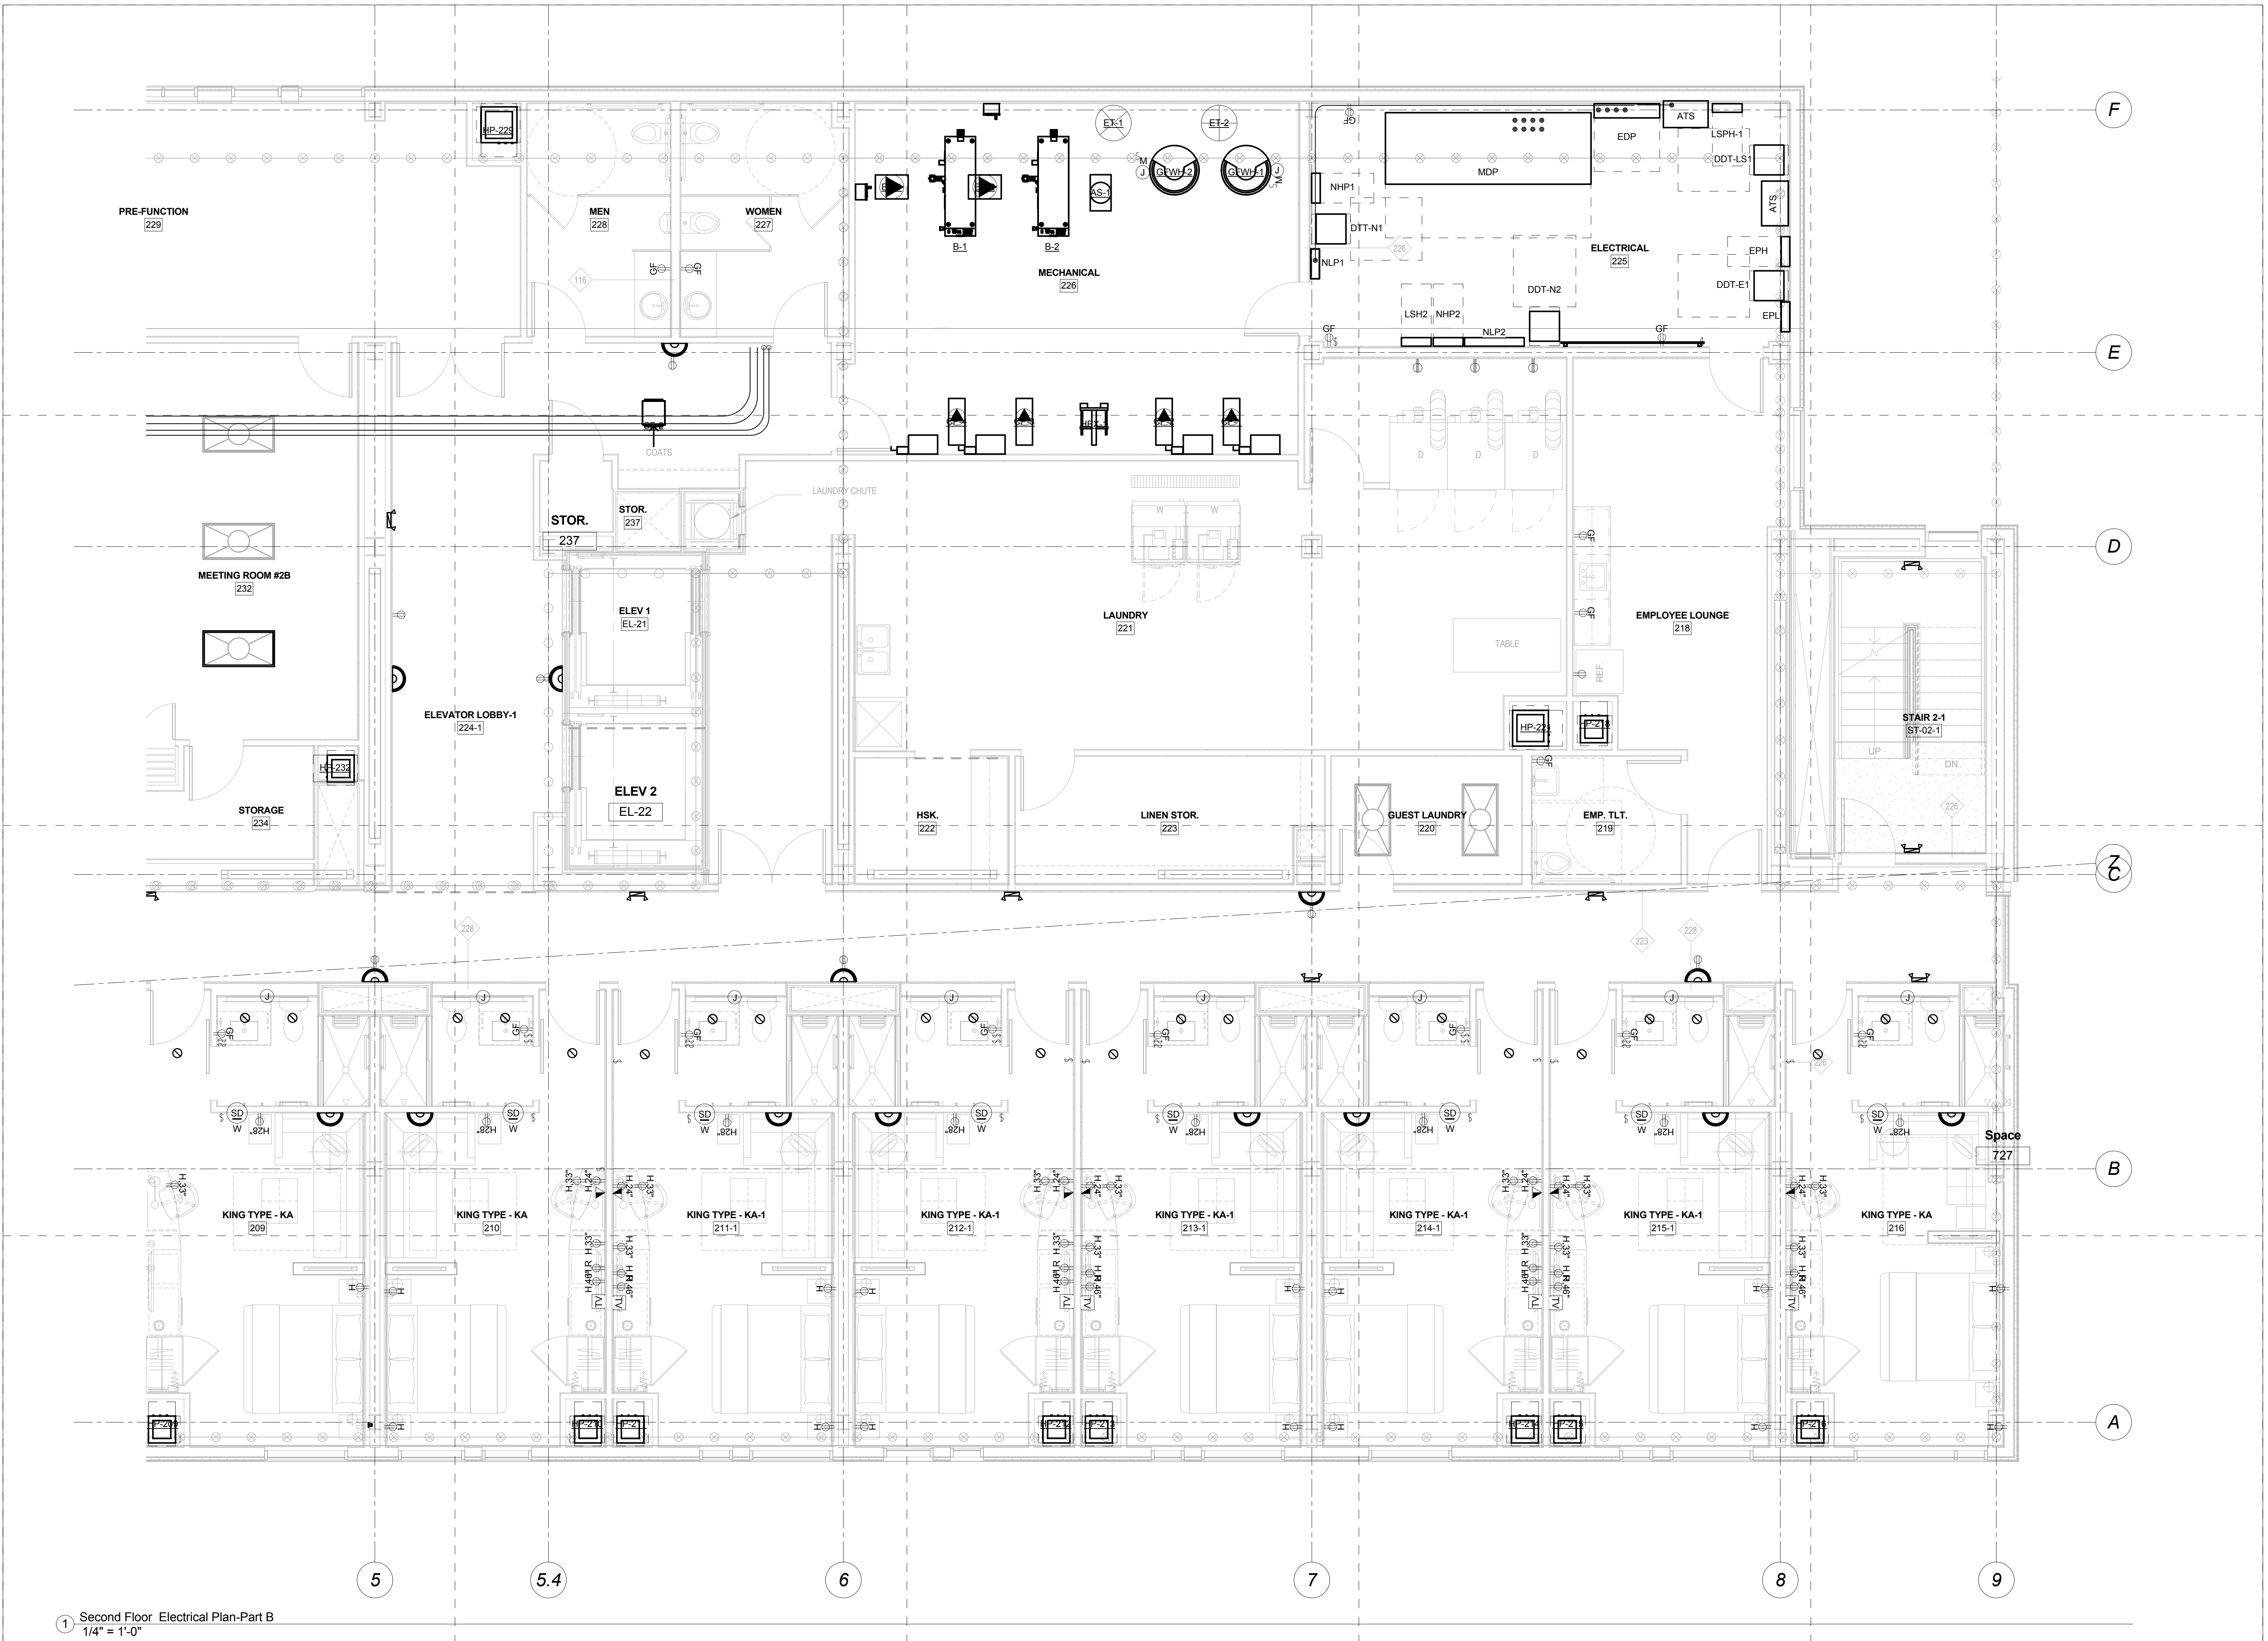

1 Second Floor Electrical Plan-Part B
1/4" = 1'-0"

CANAL STUDIO
Architecture / Planning / Interior Design
207 553 2115
One Canal Plaza, Suite 888
Portland, Maine 04101
canalstudio.com

EAST BROWN COW
MANAGEMENT, INC.
shinberg
CONSULTING, LLC

Project Title
**Hyatt Place,
Portland-Old Port**
433 Fore Street
Portland, ME
CSS Project No. 12013


BENNETT ENGINEERING
MECHANICAL • ELECTRICAL
(207) 865-9475

| Mark | Date | Description |
|----------------|------|---------------------------------------|
| Project Status | | DESIGN DEVELOPMENT 11-16-12 |

Drawing Title
**Second Floor
Electrical Plan-Part
B**

Scale: 1/4" = 1'-0"

Drawing Number
E30.2B

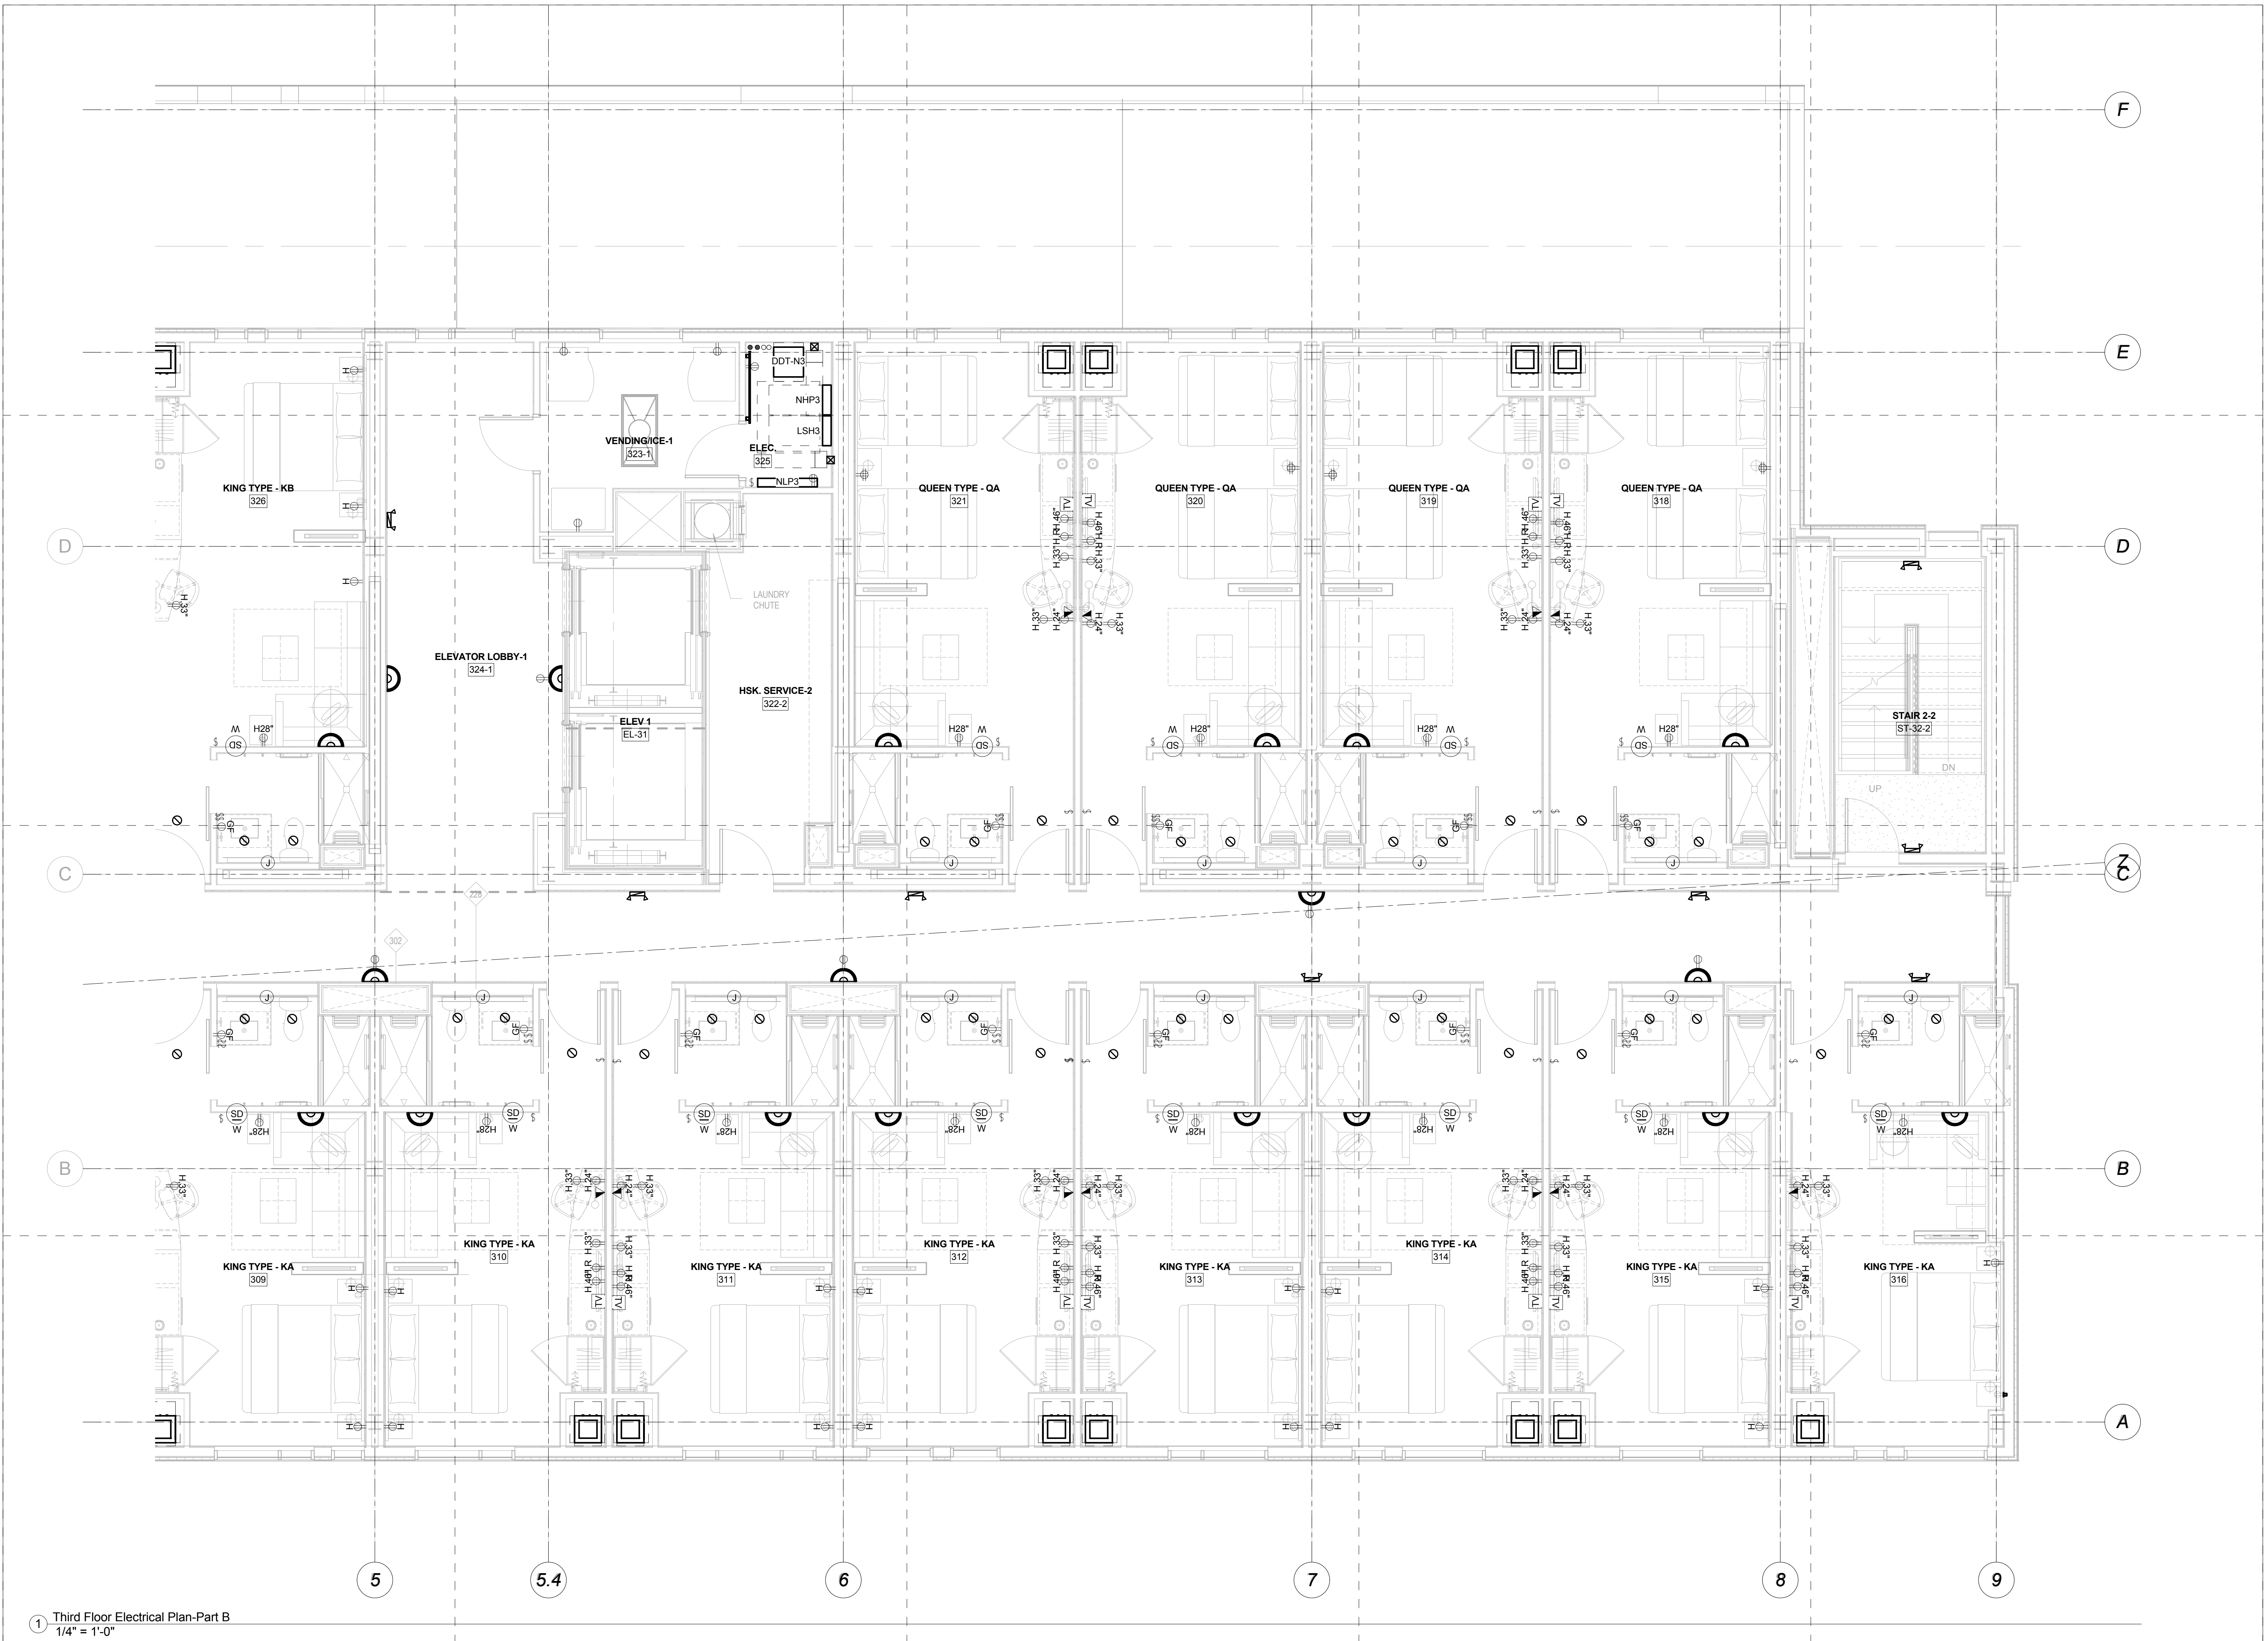

1 Third Floor Electrical Plan-Part B
1/4" = 1'-0"

CANAL STUDIO
Architecture / Planning / Interior Design
207 553 2115
One Canal Plaza, Suite 888
Portland, Maine 04101
canalstudio.com

EAST BROWN COW
MANAGEMENT, INC.

shinberg
CONSULTING, LLC

Project Title
**Hyatt Place,
Portland-Old Port**
433 Fore Street
Portland, ME
CSS Project No. 12013


BENNETT ENGINEERING
MECHANICAL • ELECTRICAL
(207) 865-9475

| Mark | Date | Description |
|----------------|------|---------------------------------------|
| Project Status | | DESIGN DEVELOPMENT 11-16-12 |

Drawing Title
**Third Floor
Electrical Plan-Part
B**


Scale: 1/4" = 1'-0"

Drawing Number
E30.3B

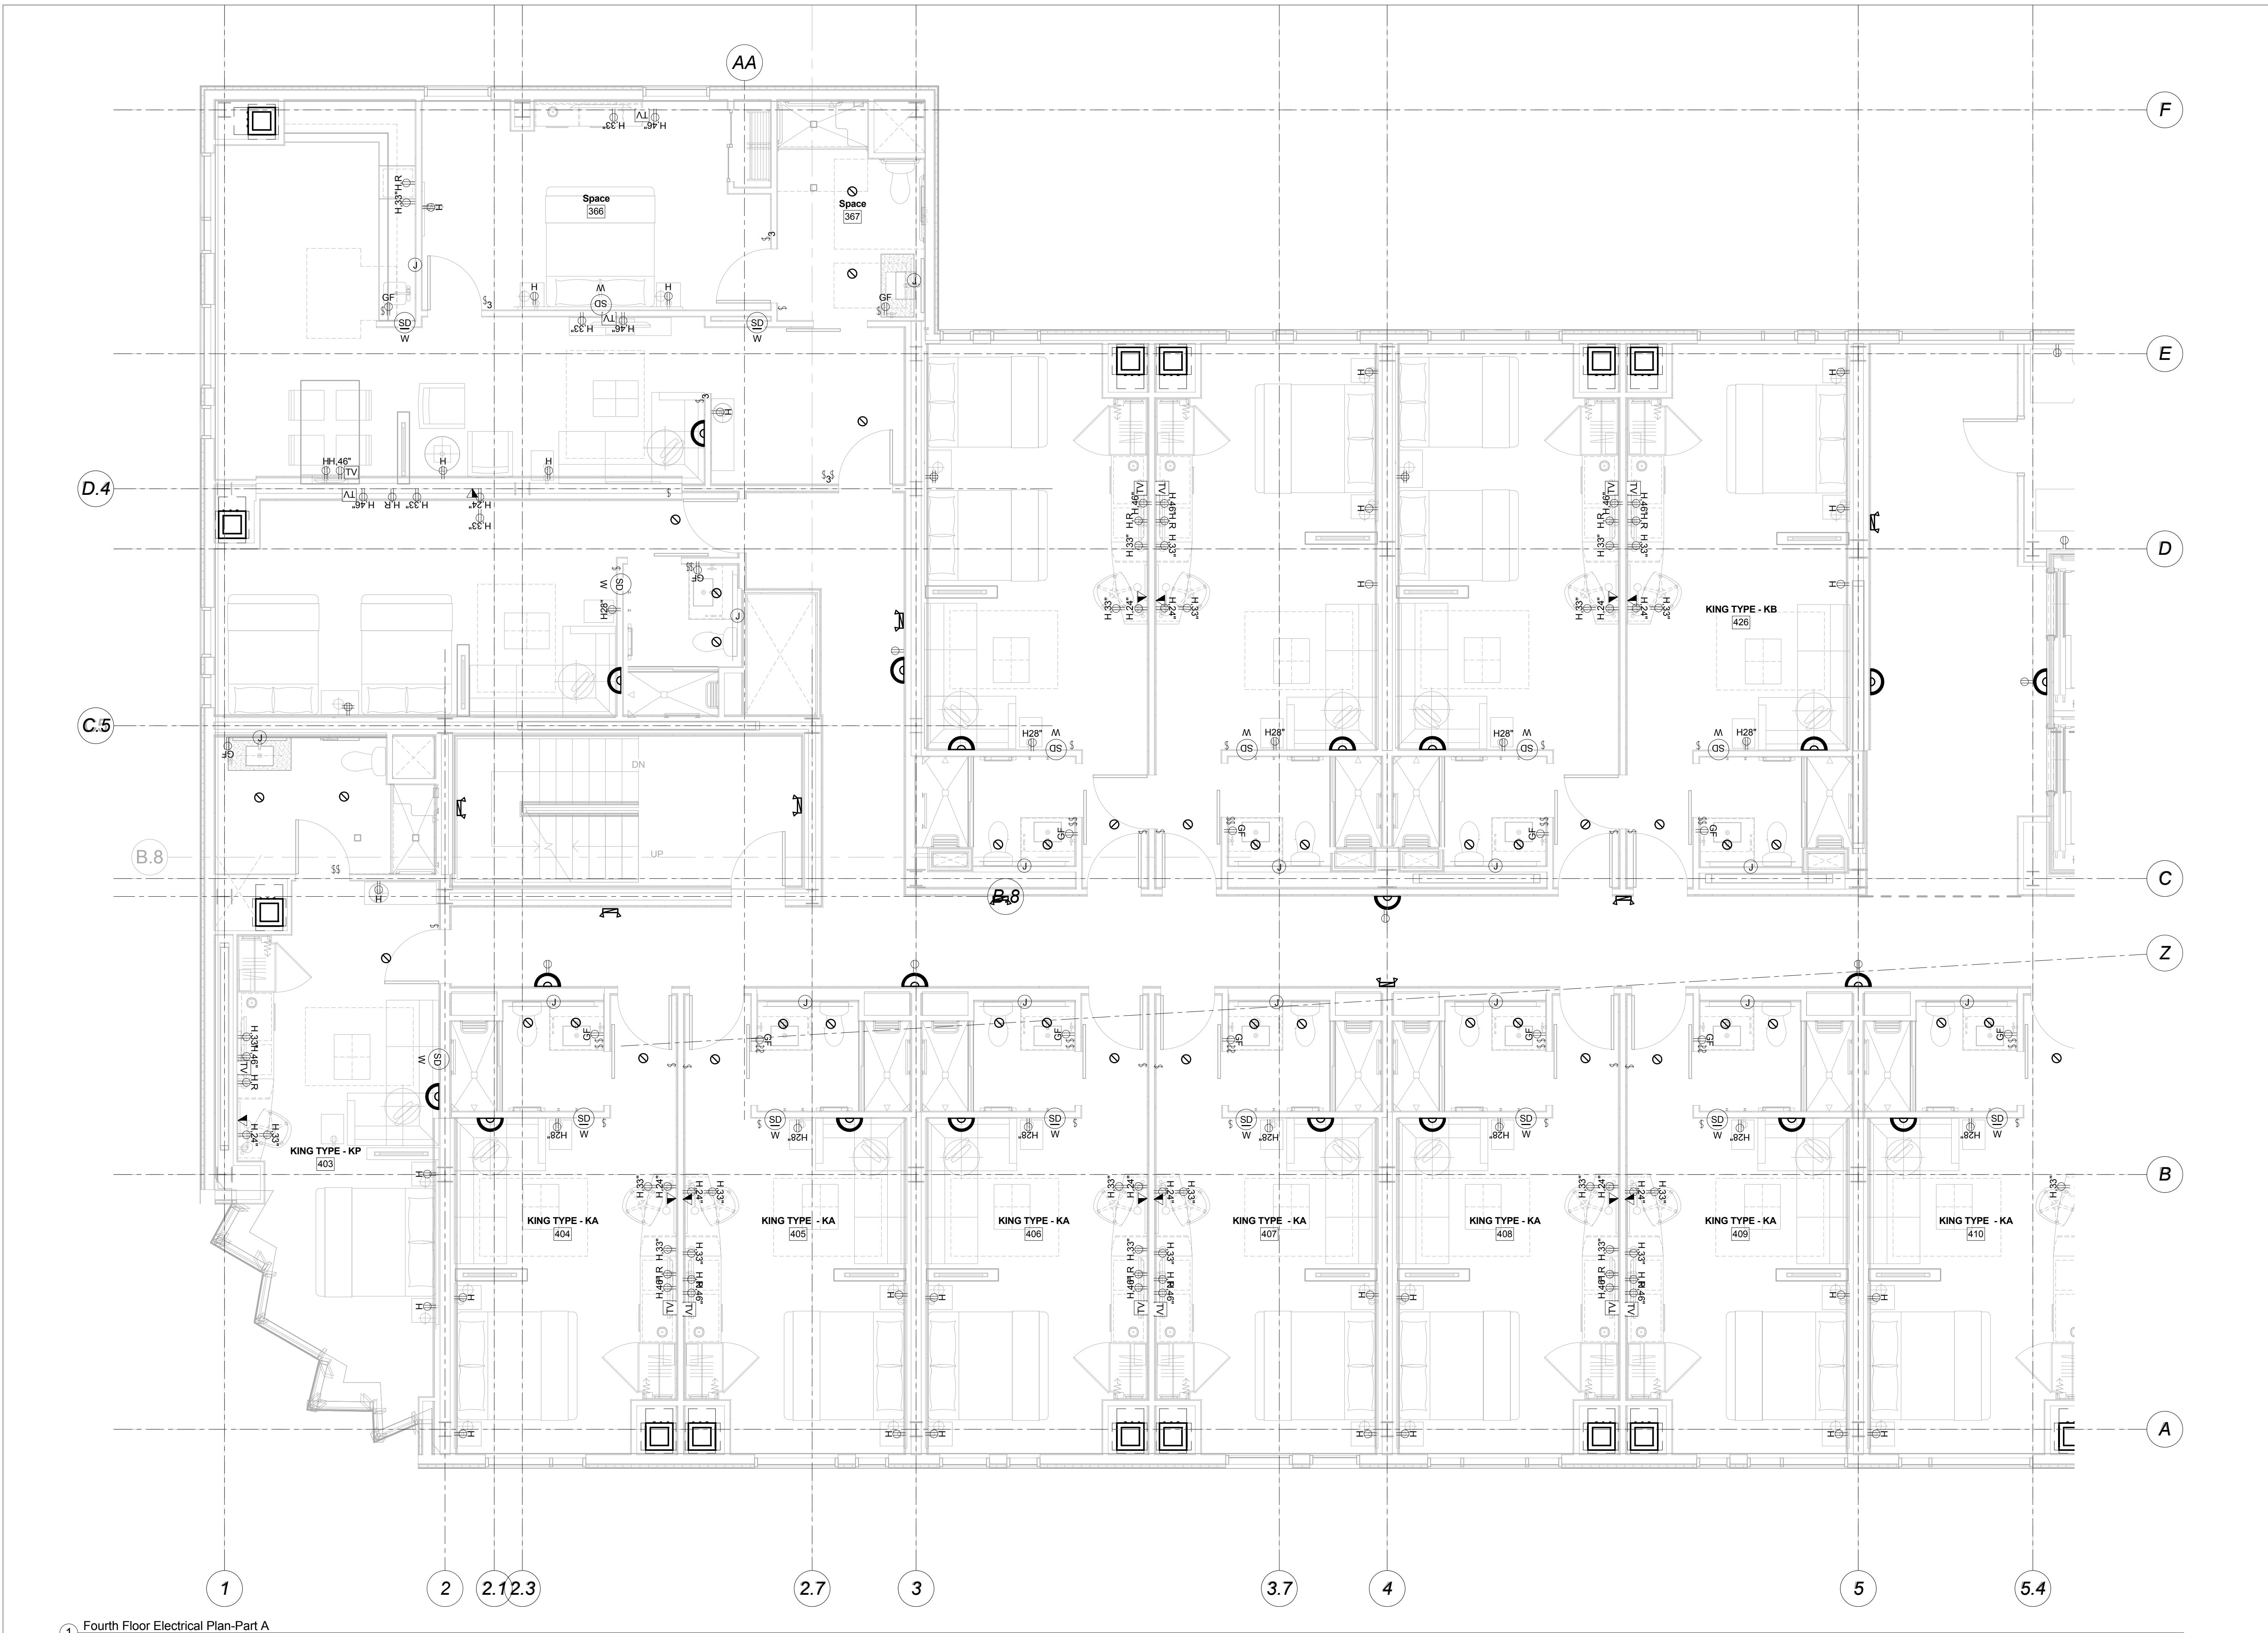


① Fourth Floor Electrical Plan-Part A
 1/4" = 1'-0"

| Mark | Date | Description |
|--------------------------------------------|------|-------------|
| Project Status | | |
| DESIGN DEVELOPMENT | | |
| 11-16-12 | | |
| Drawing Title | | |
| Fourth Floor Electrical Plan-Part A | | |
| Scale: 1/4" = 1'-0" | | |
| Drawing Number | | |
| E30.4A | | |

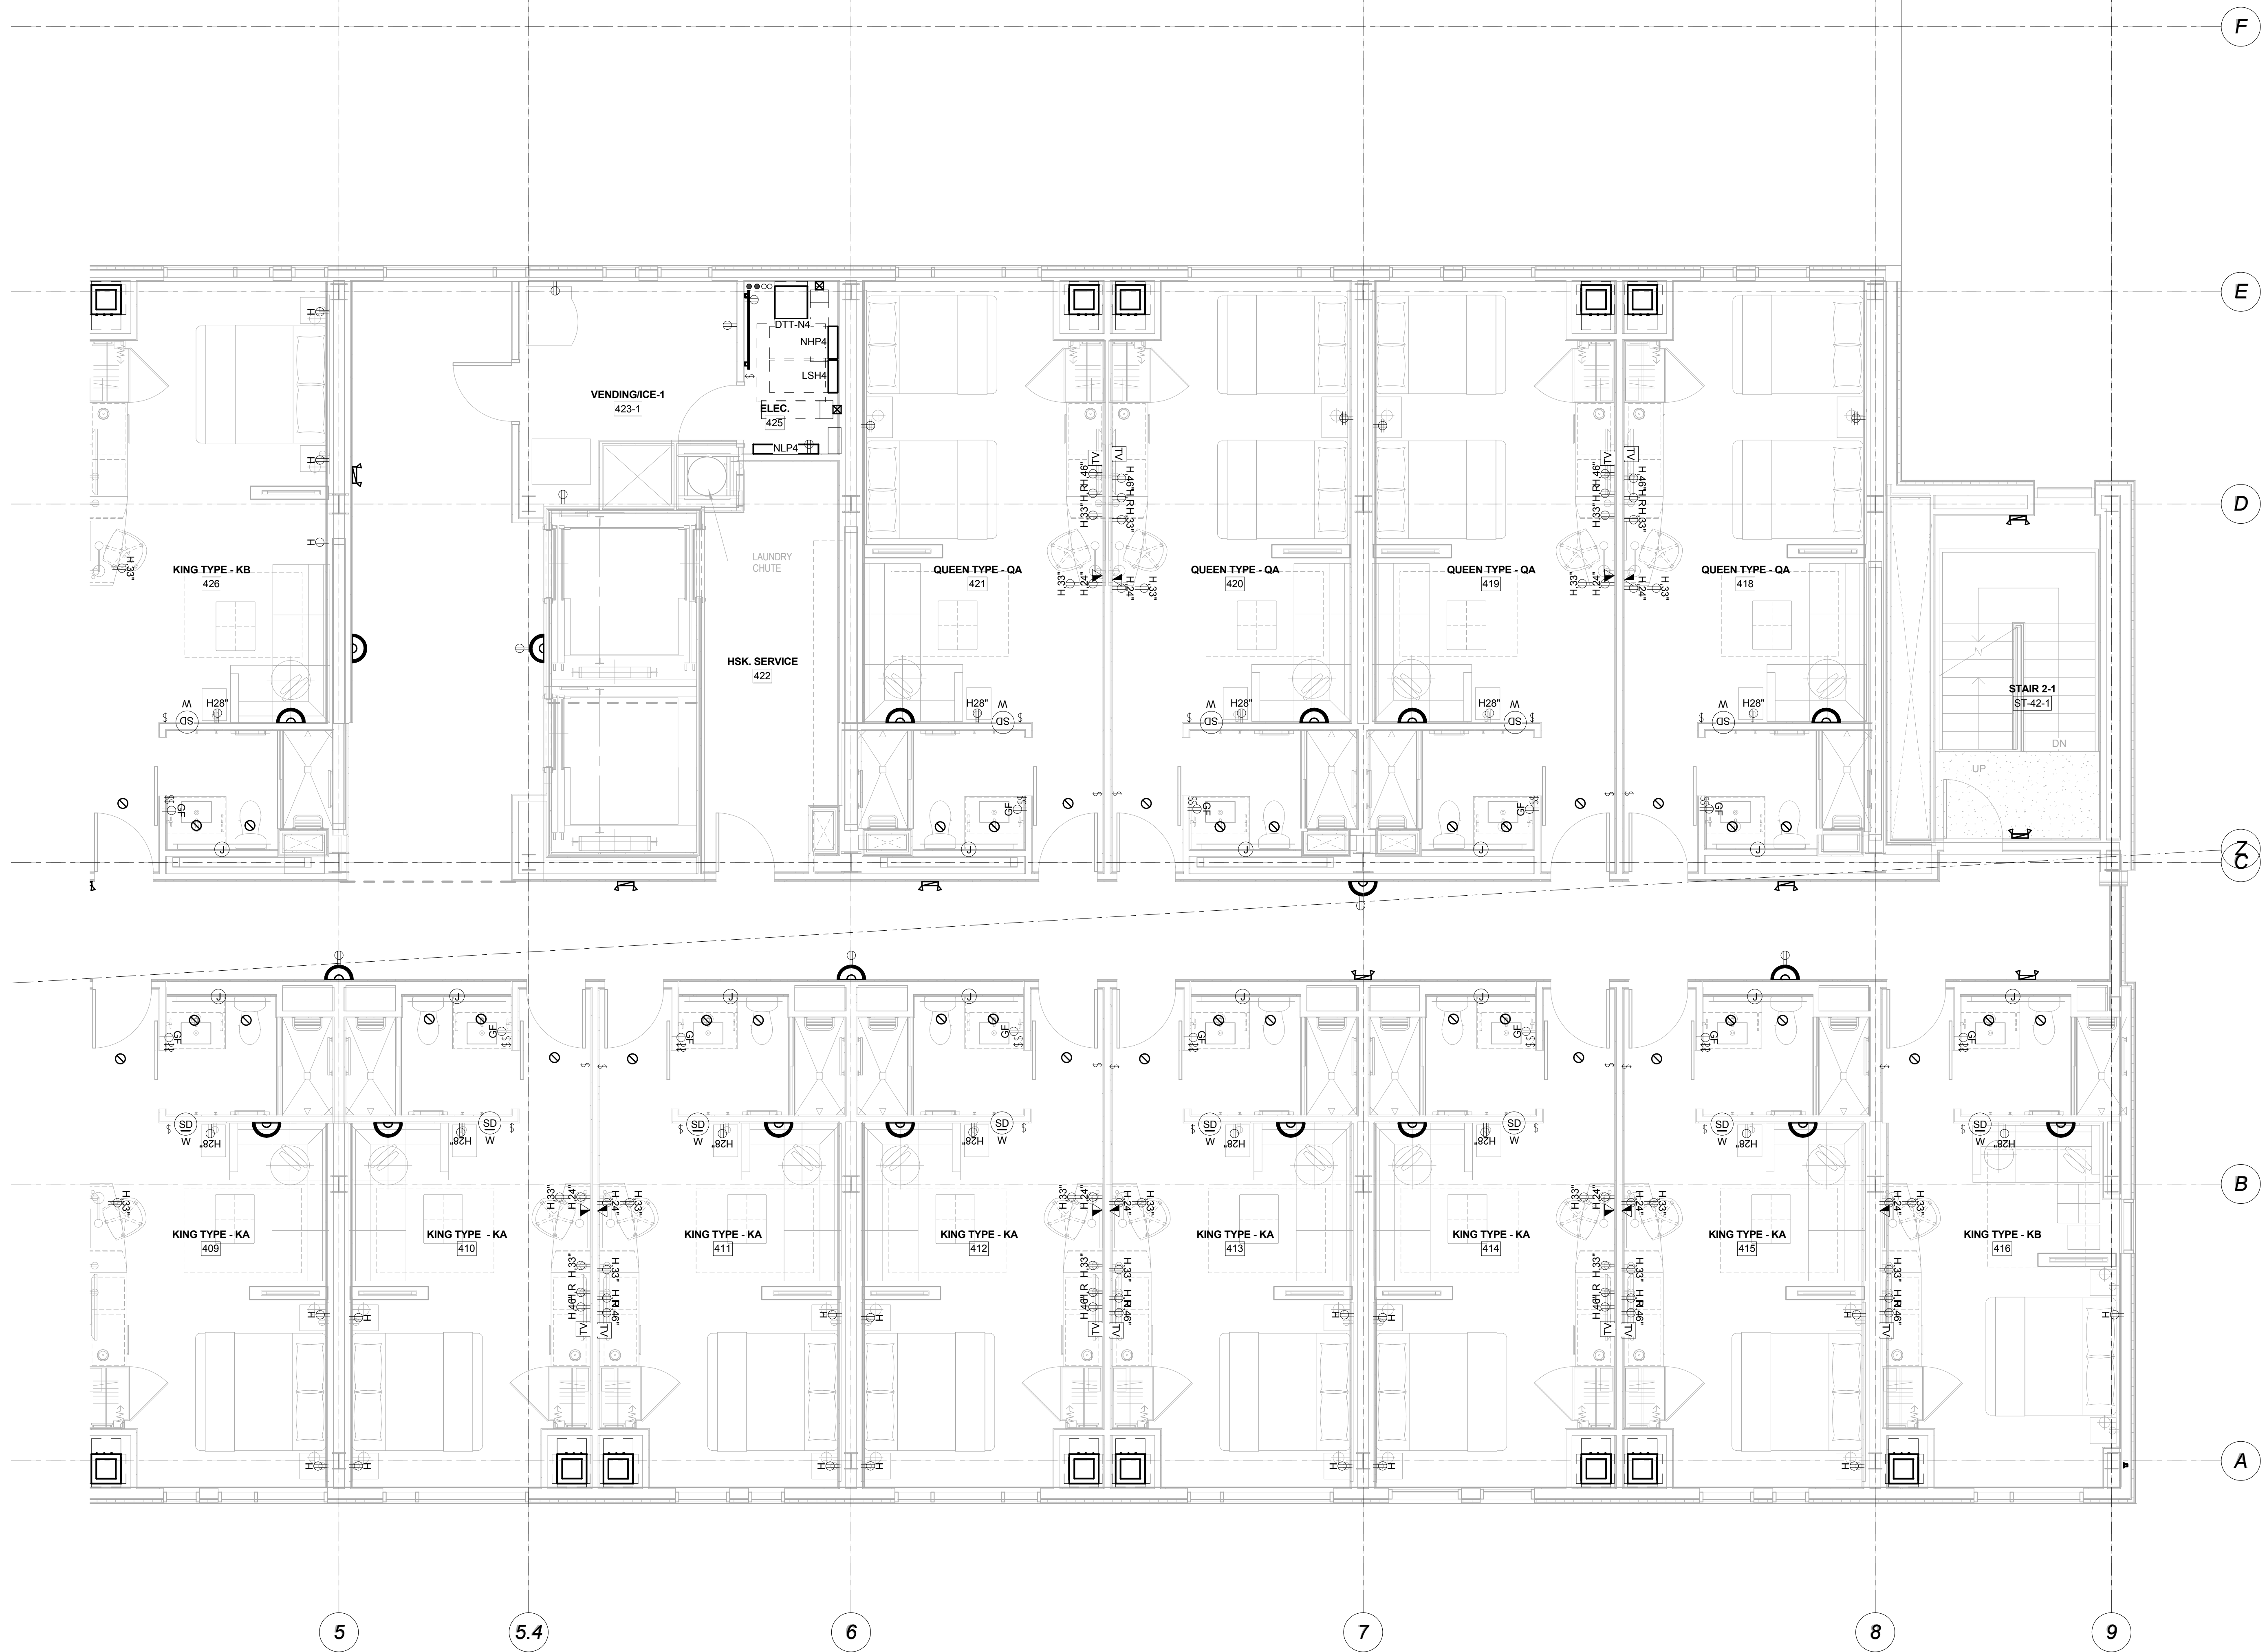

① Fourth Floor Electrical Plan-Part B
 1/4" = 1'-0"

| Mark | Date | Description |
|----------------------------------------------------------|------|-------------|
| Project Status | | |
| DESIGN DEVELOPMENT | | |
| 11-16-12 | | |
| Drawing Title | | |
| Fourth Floor Electrical Plan-Part B | | |
| Scale: 1/4" = 1'-0" | | |
| Drawing Number | | |
| E30.4B | | |

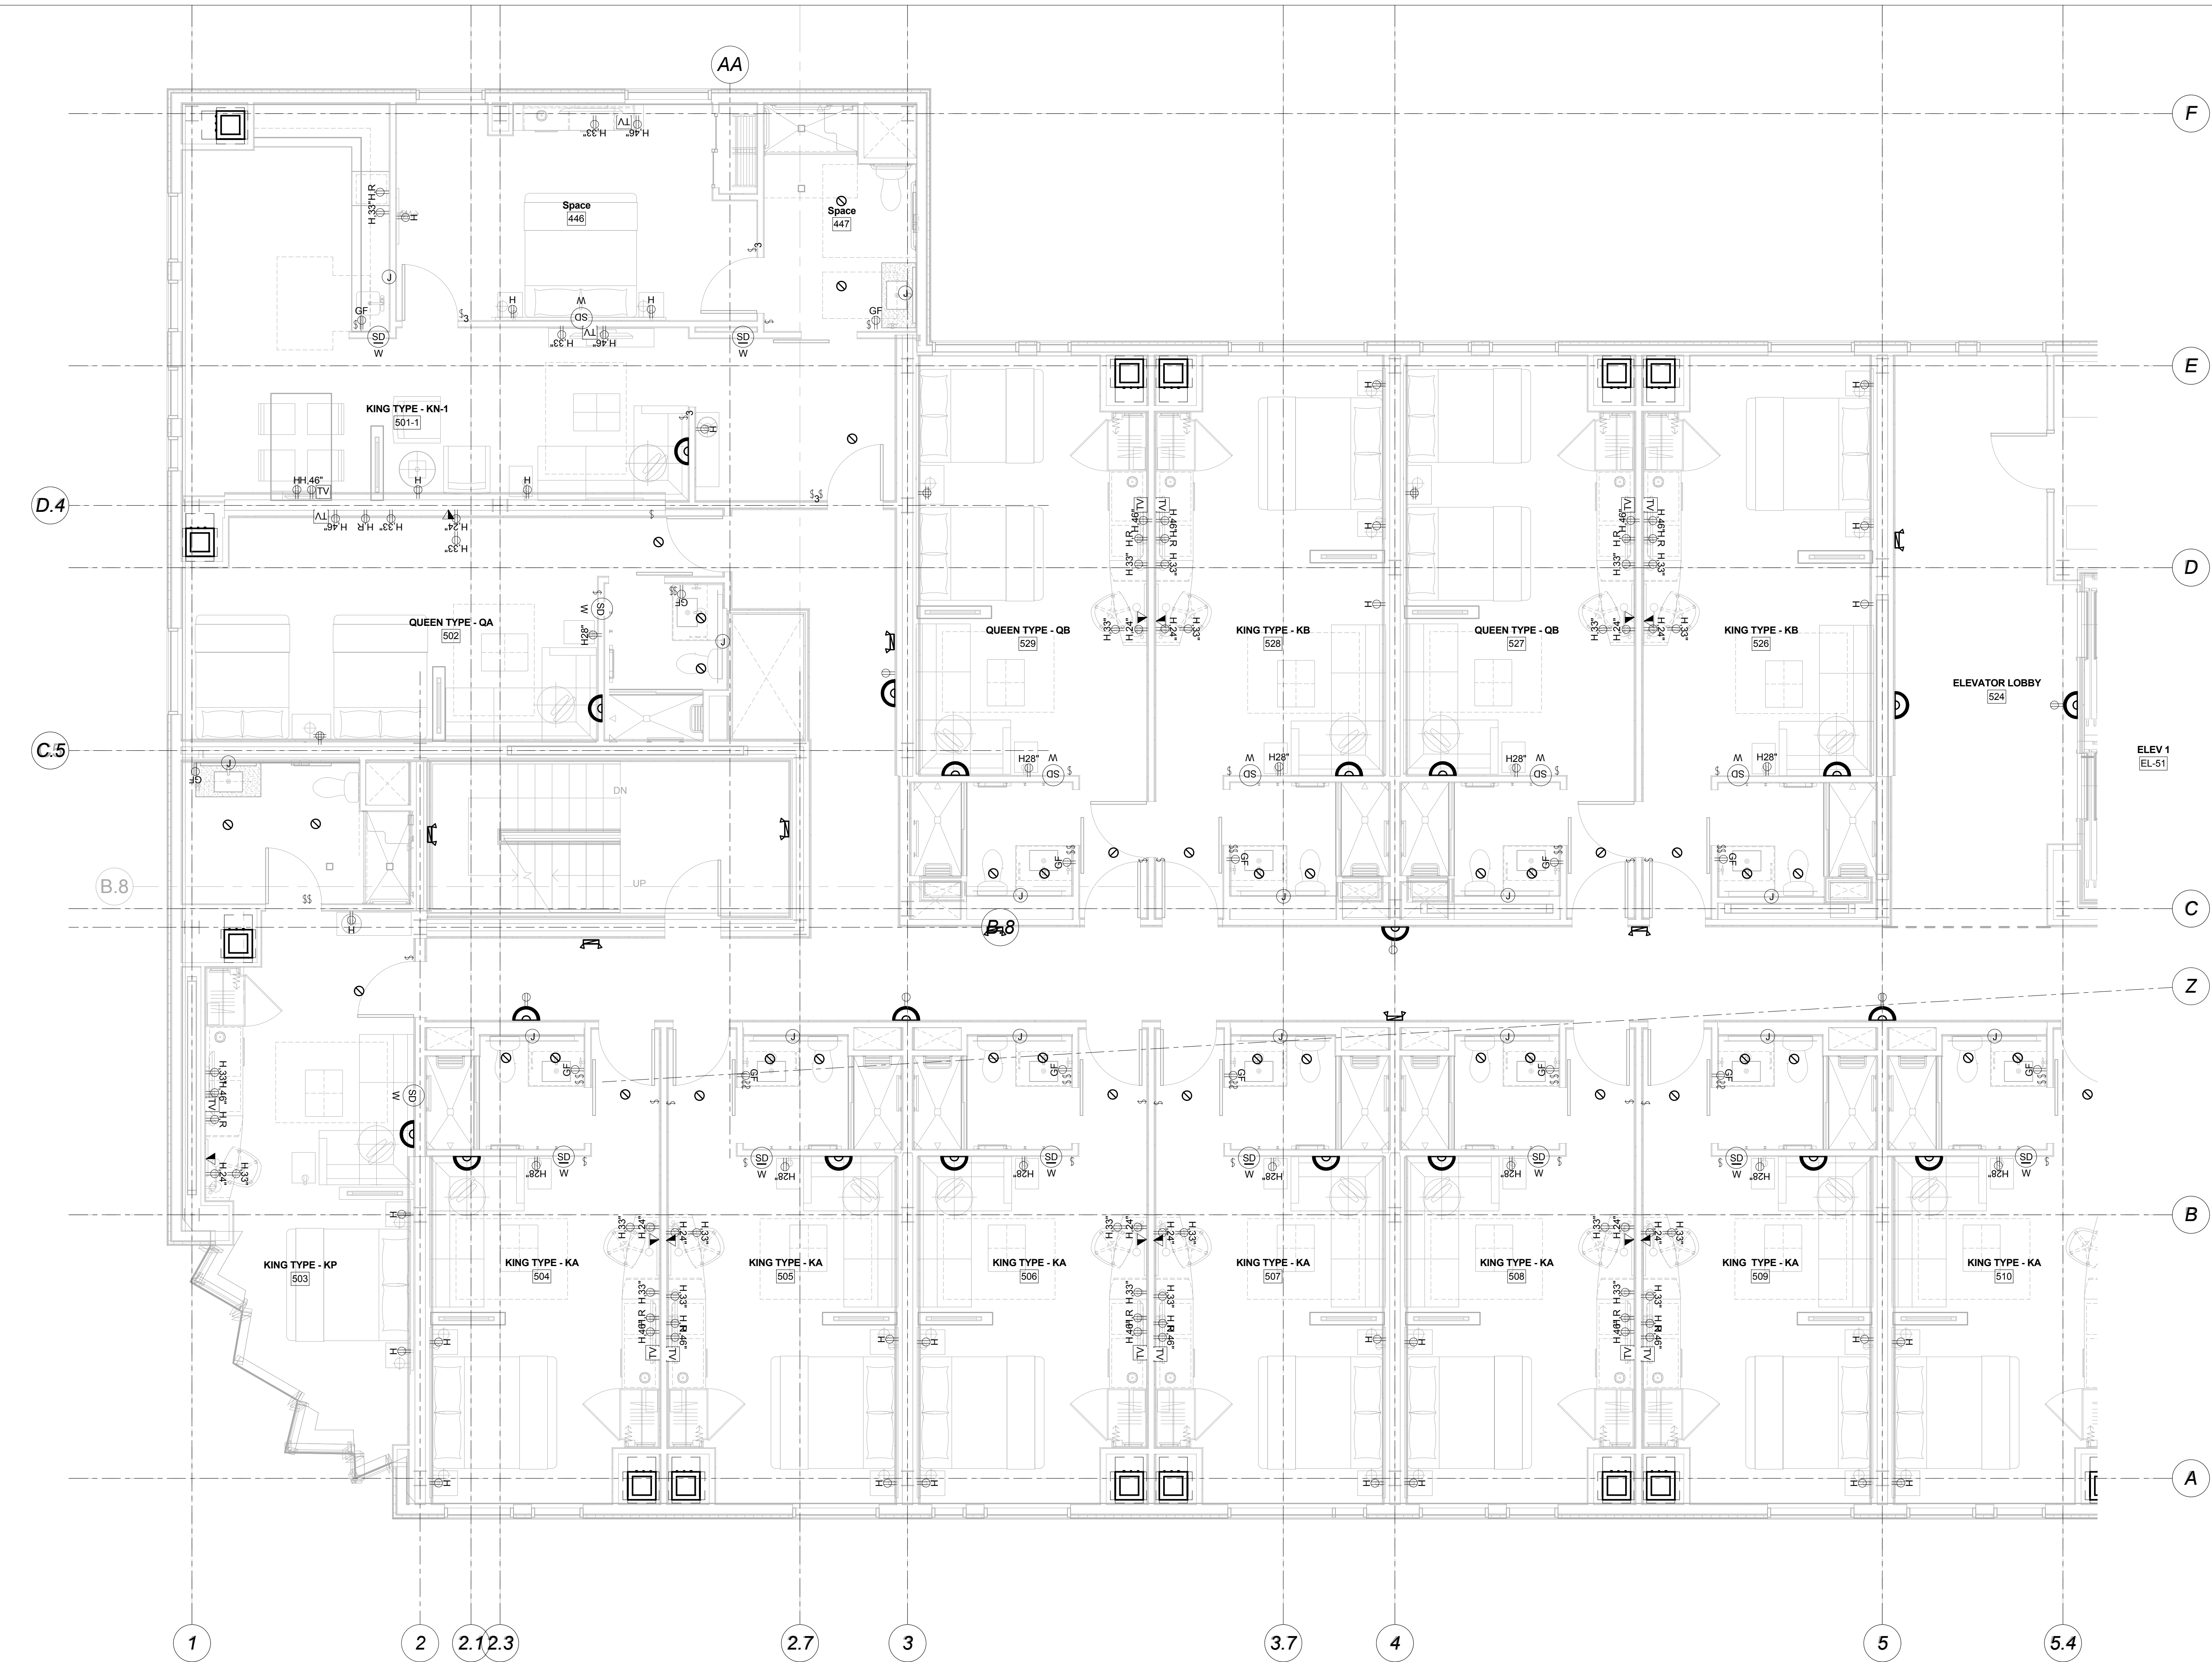

1 Fifth Floor Electrical Plan-Part A
1/4" = 1'-0"

| Mark | Date | Description |
|---------------------------------------|------|-------------|
| Project Status | | |
| DESIGN DEVELOPMENT | | |
| 11-16-12 | | |
| Drawing Title | | |
| Fifth Floor Electrical Plan-Part A | | |
| Scale: 1/4" = 1'-0" | | |
| Drawing Number | | |
| E30.5A | | |

DESIGN
DEVELOPMENT

11-16-12


Drawing Title

Fifth Floor Electrical
Plan-Part A

Scale: 1/4" = 1'-0"

Drawing Number

E30.5A

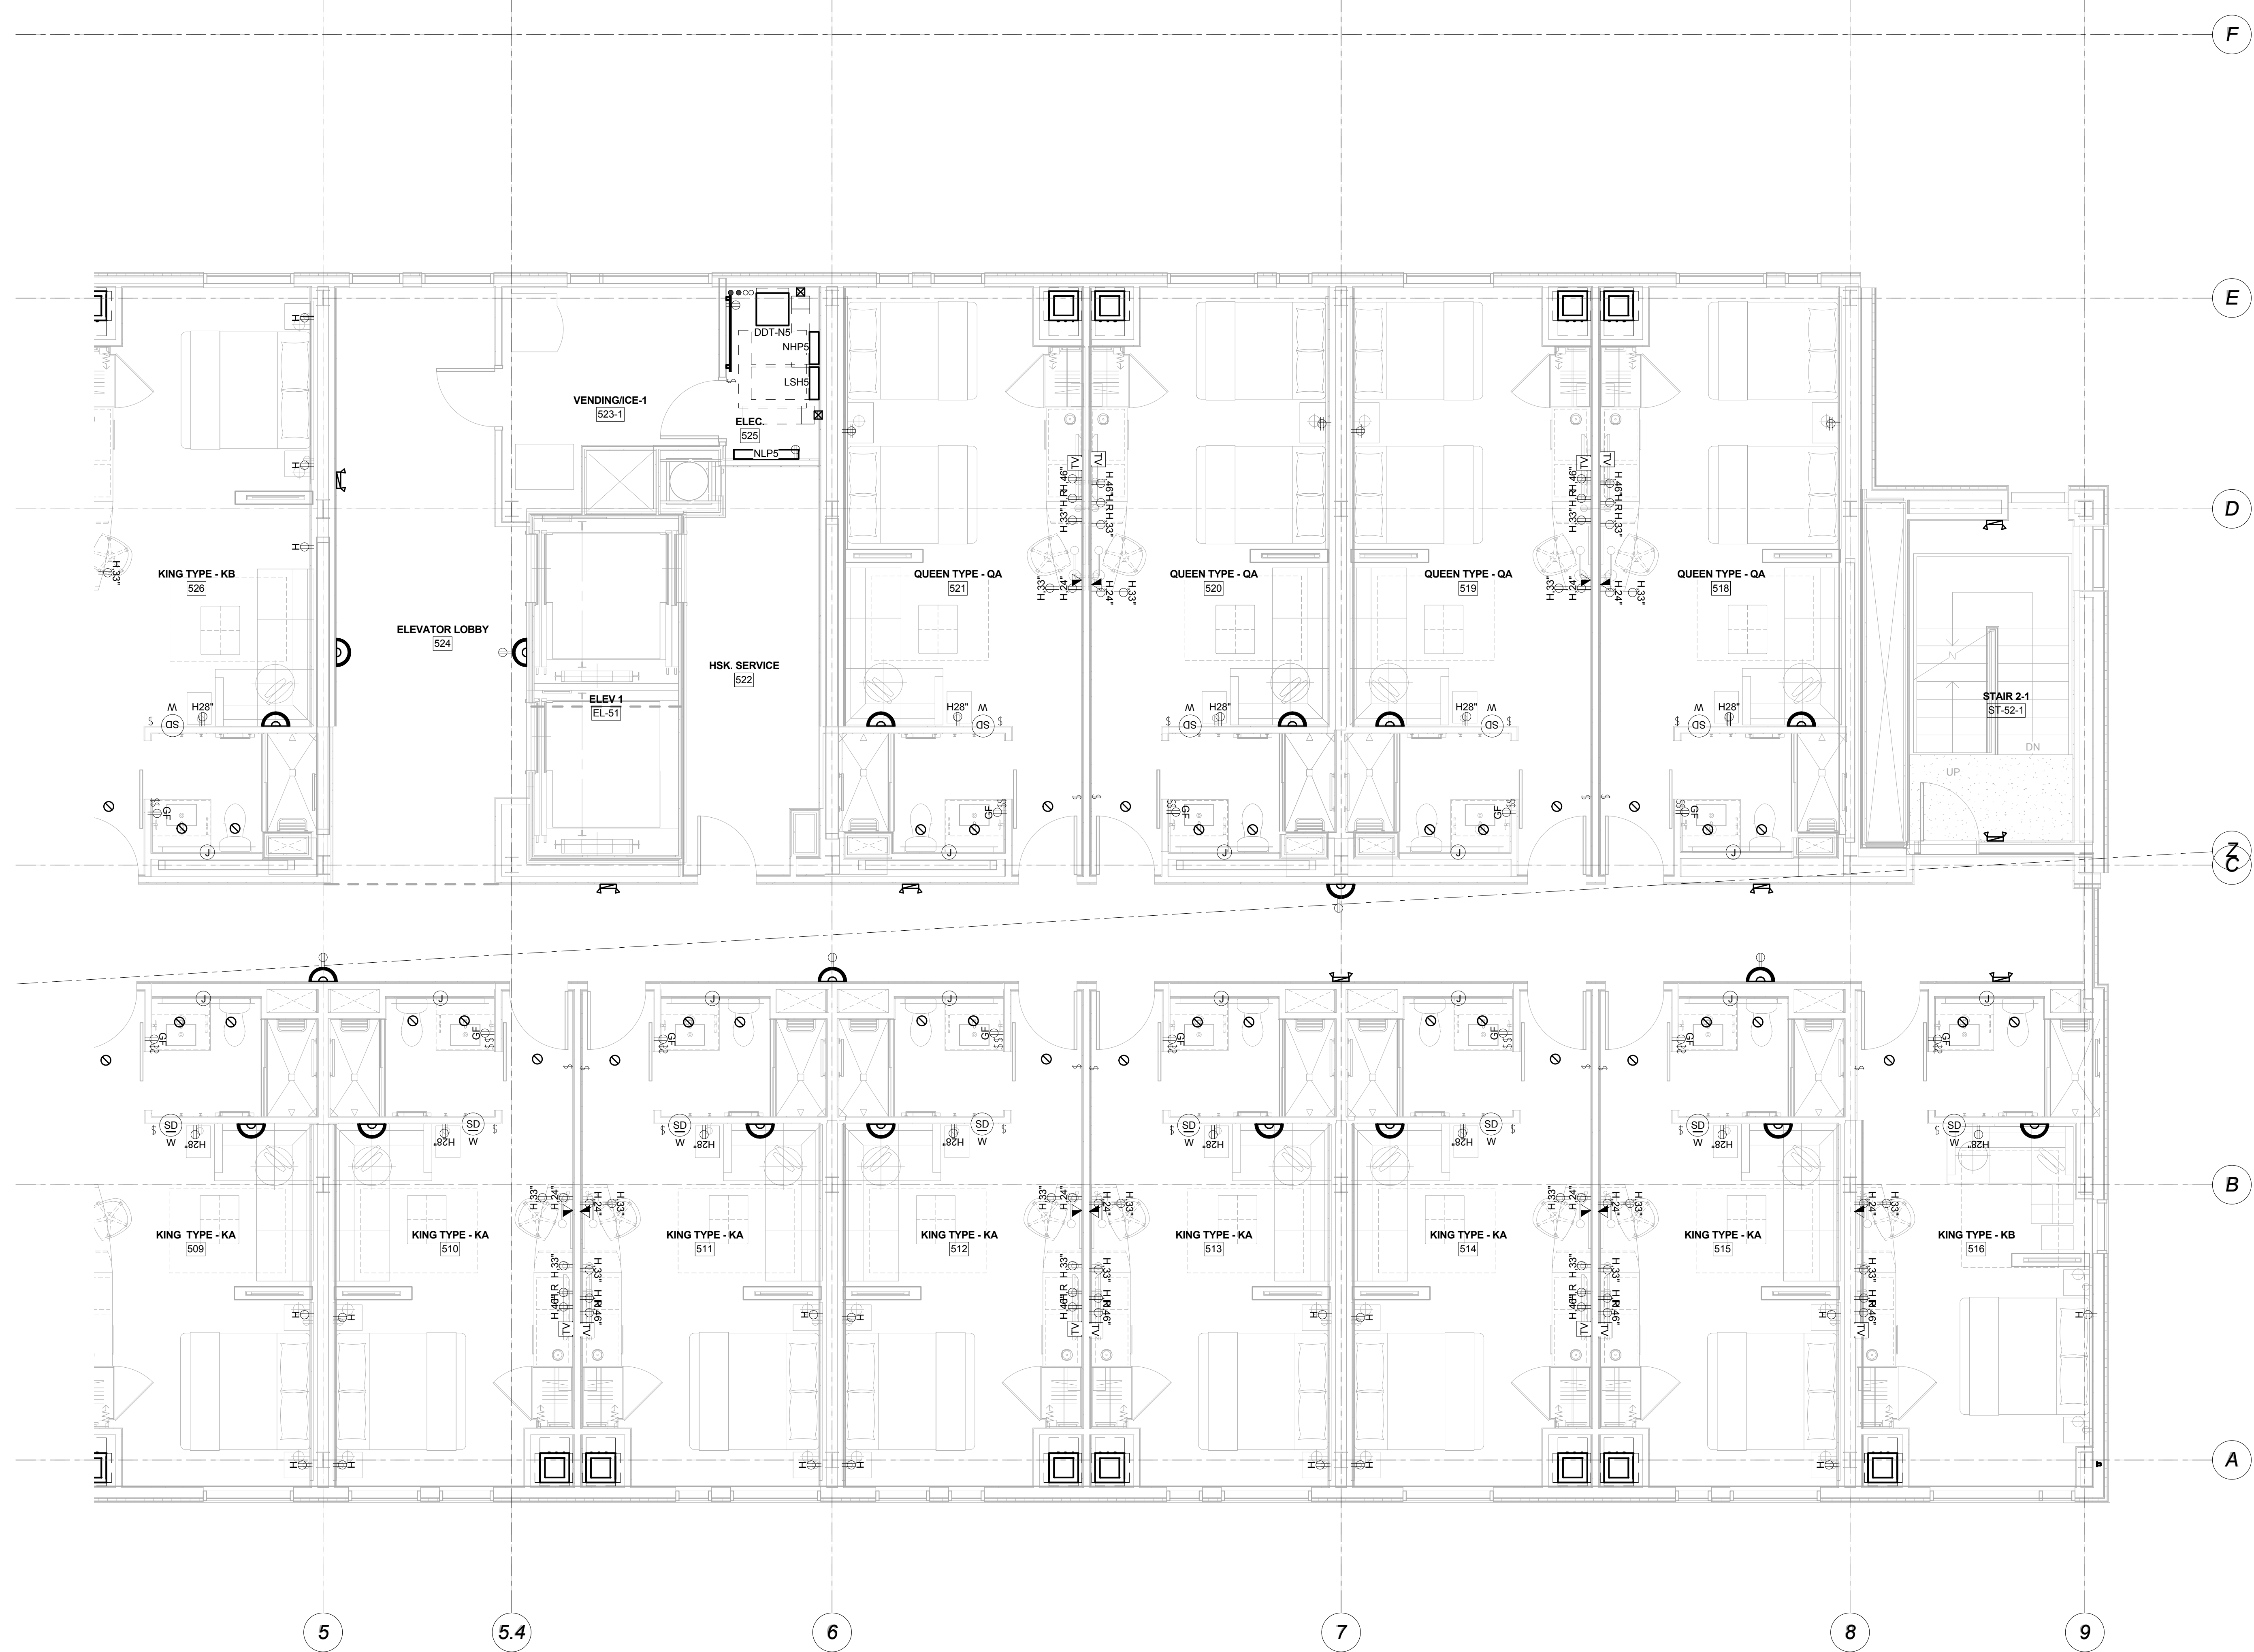


1 Fifth Floor Electrical Plan-Part B
1/4" = 1'-0"

| Mark | Date | Description |
|----------------|------|---------------------------------------|
| Project Status | | |
| | | DESIGN DEVELOPMENT 11-16-12 |

Drawing Title
**Fifth Floor Electrical
Plan-Part B**


Scale: 1/4" = 1'-0"

Drawing Number
E30.5B

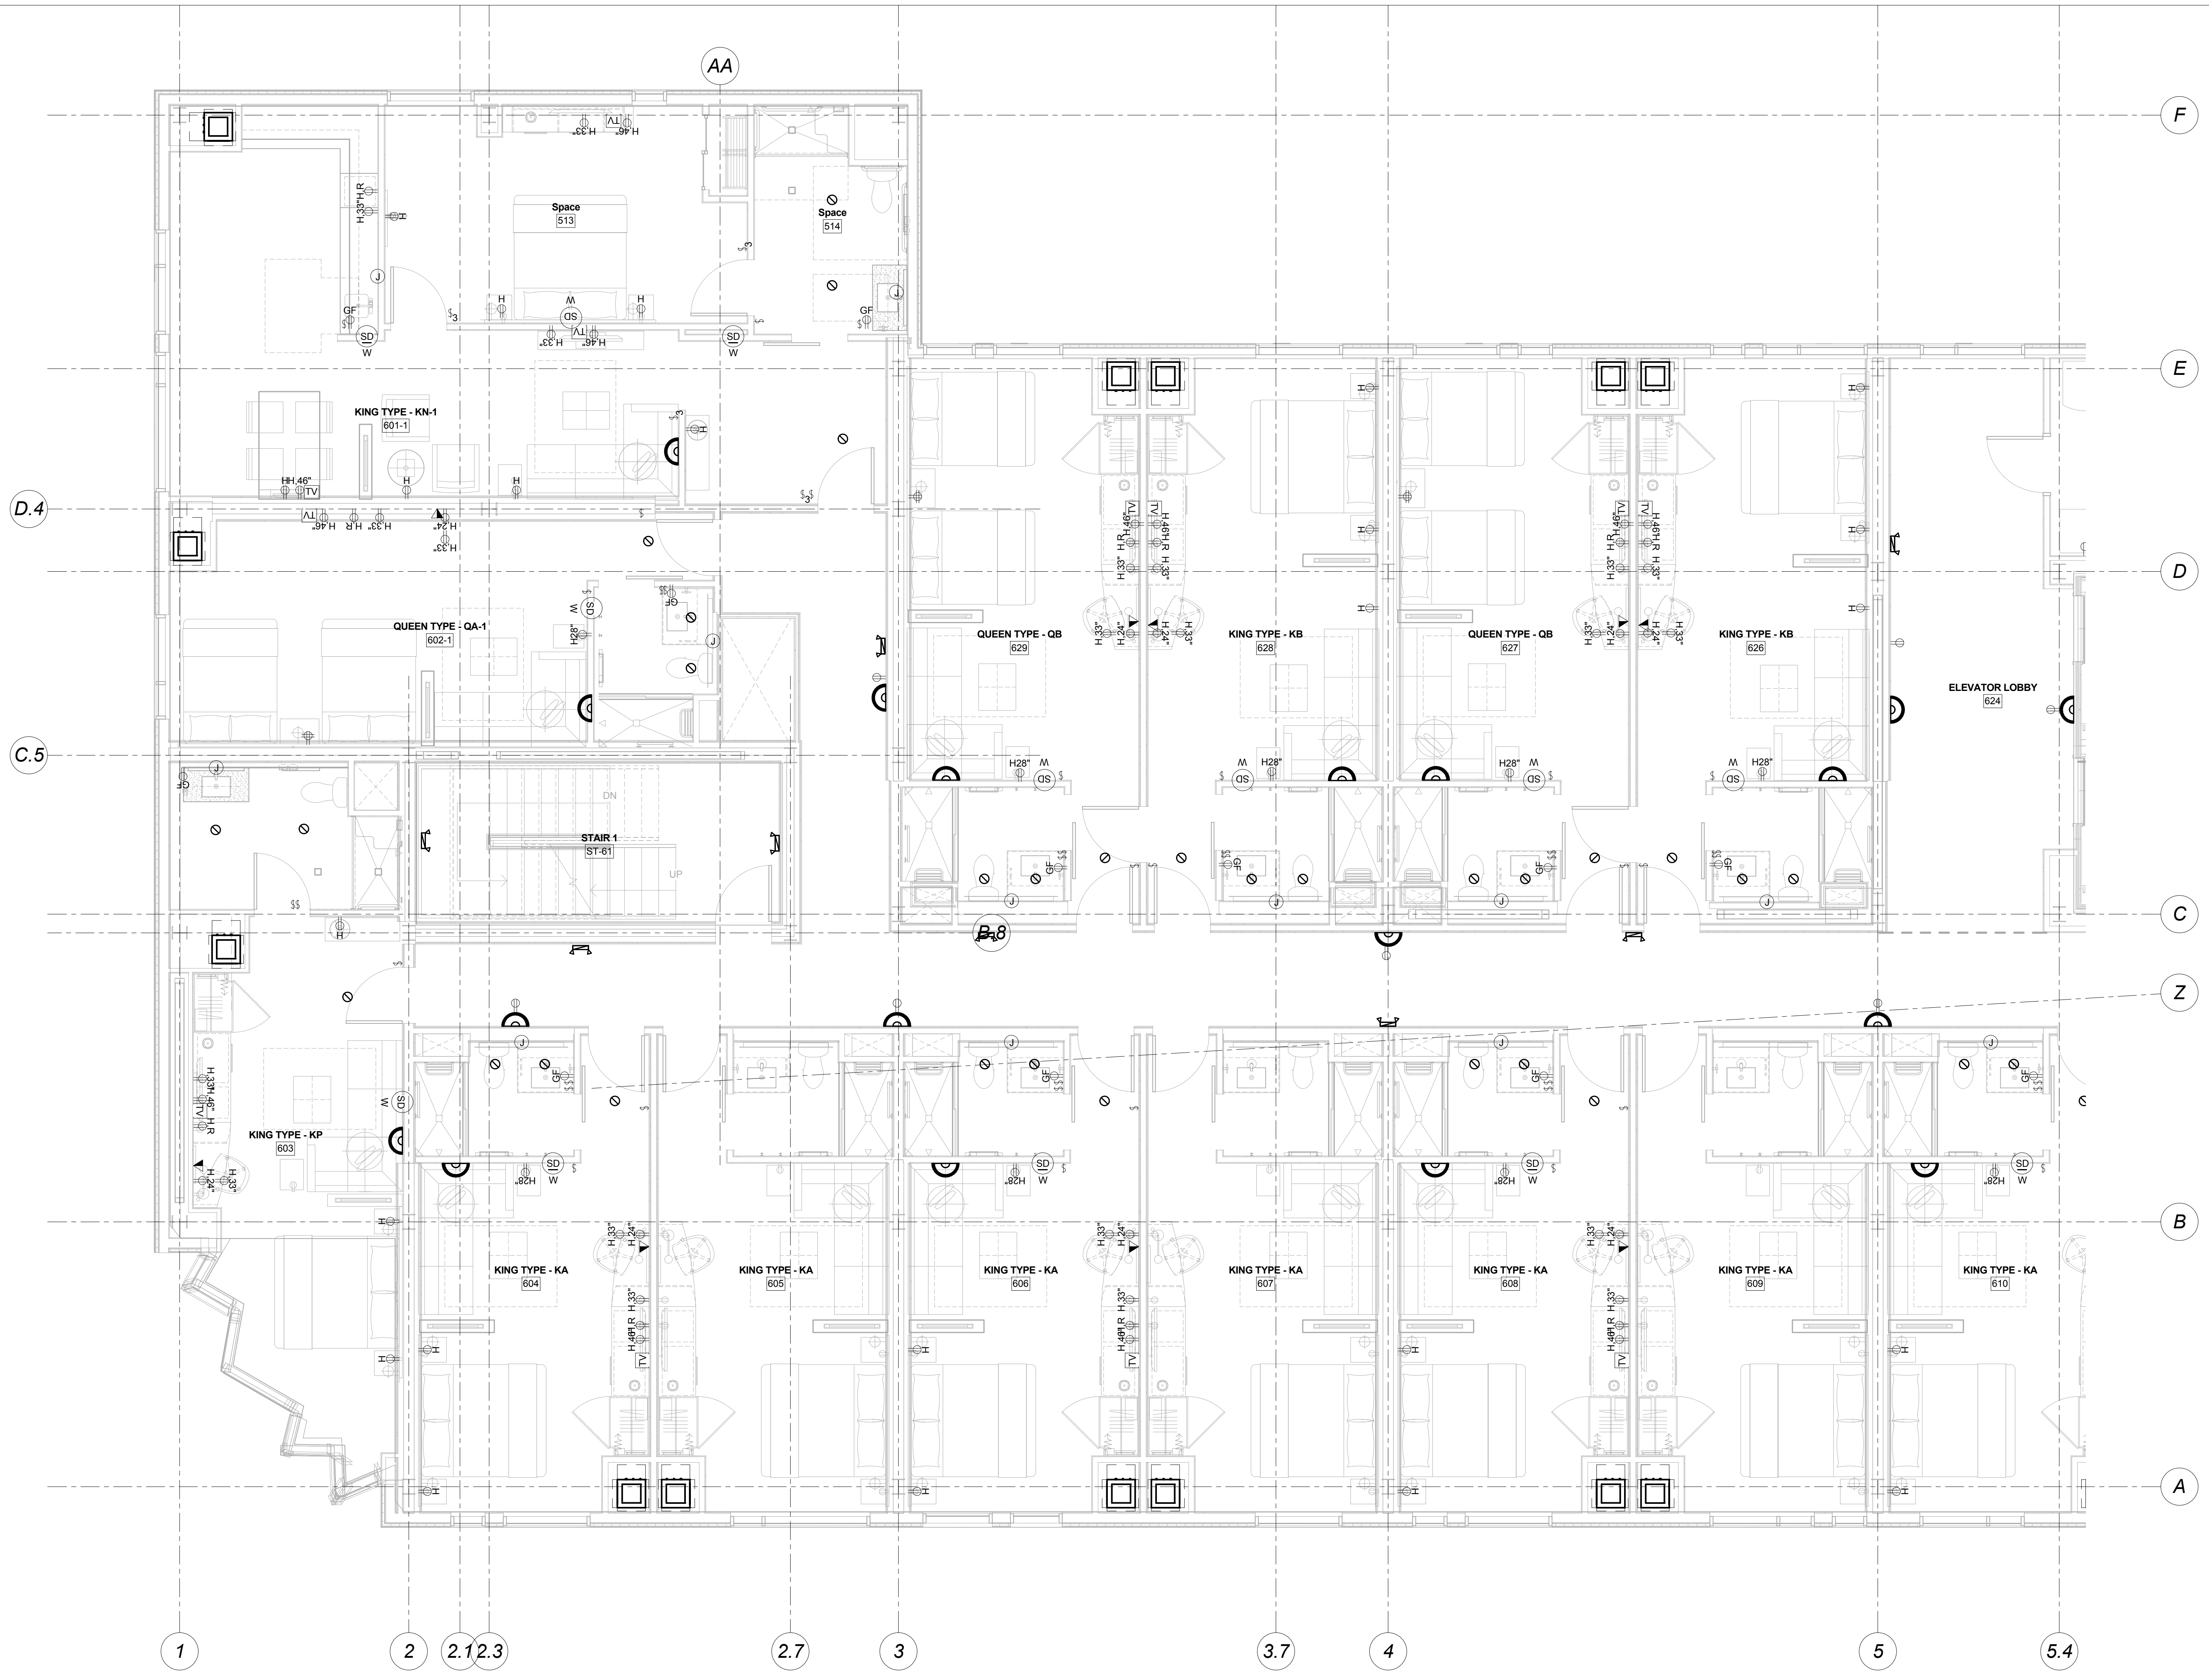


1 Sixth Floor Electrical Plan-Part A
 1/4" = 1'-0"

| Mark | Date | Description |
|------------------------------------------|------|-------------|
| Project Status | | |
| DESIGN DEVELOPMENT | | |
| 11-16-12 | | |
| Drawing Title | | |
| Sixth Floor Electrical Plan-Part A | | |
| Scale: 1/4" = 1'-0" | | |
| Drawing Number | | |
| E30.6A | | |

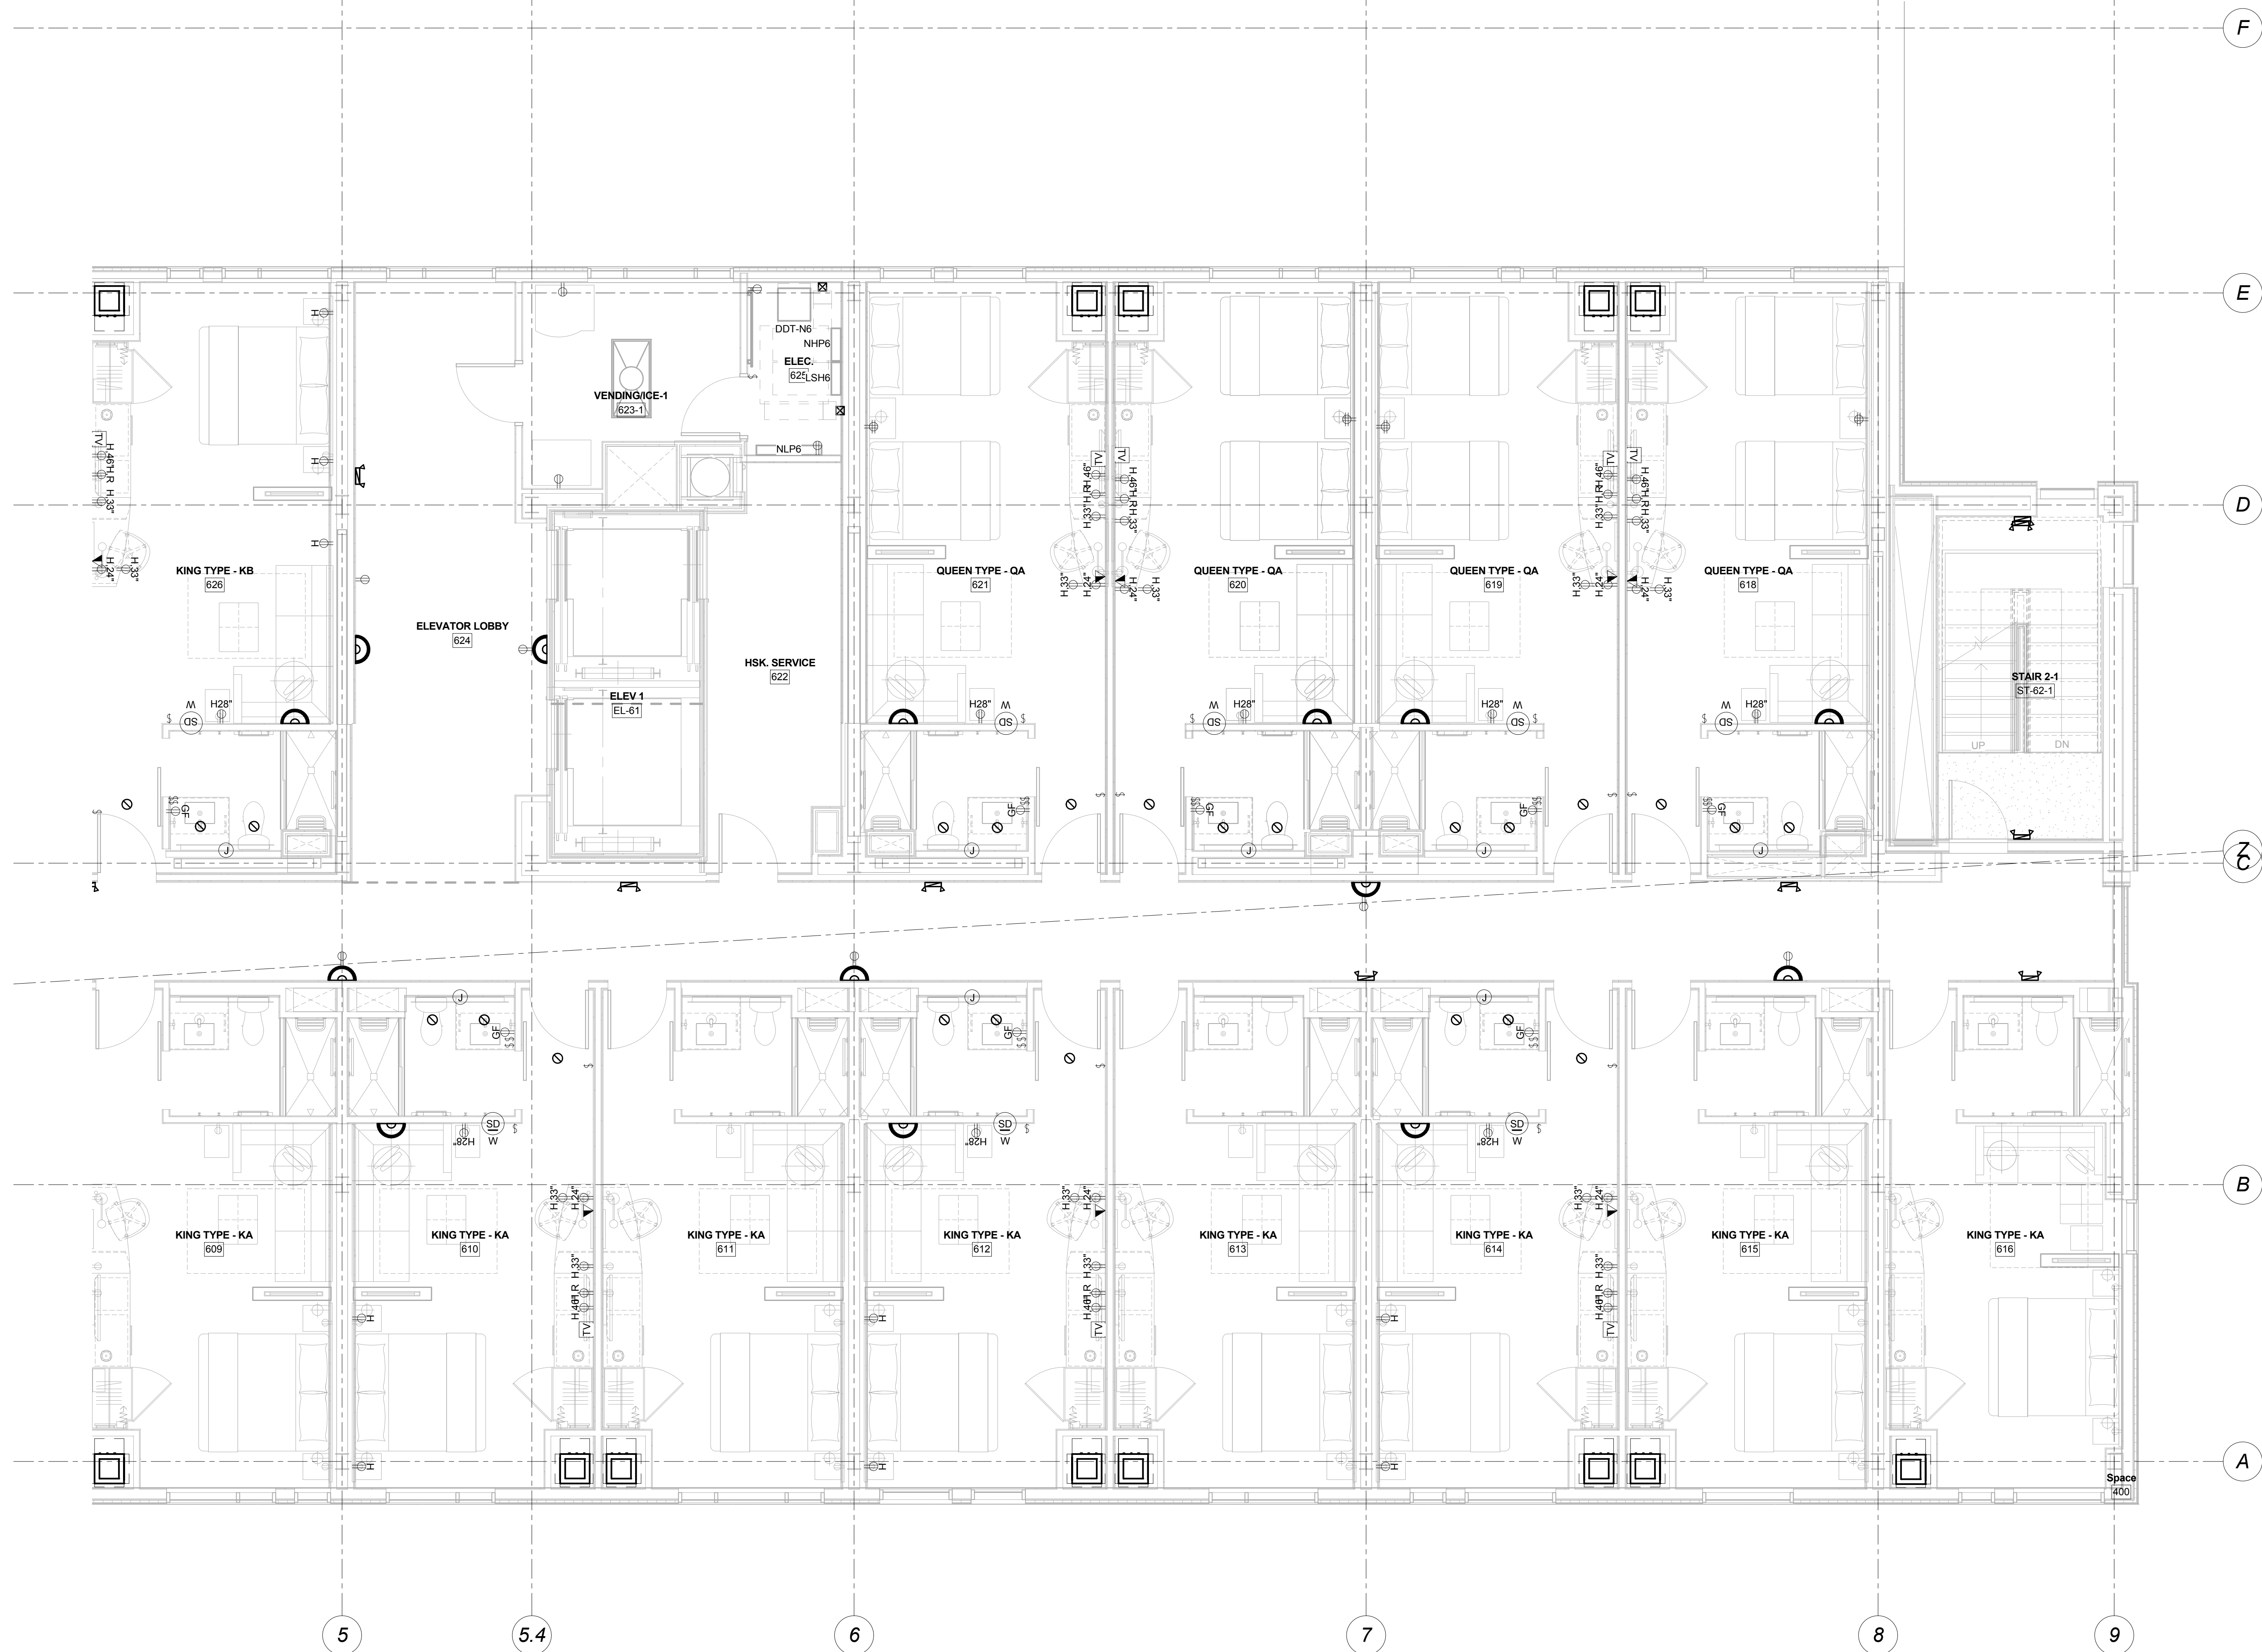


① Sixth Floor Electrical Plan-Part B
1/4" = 1'-0"

| Mark | Date | Description |
|---------------------------------------------------|------|-------------|
| Project Status | | |
| DESIGN DEVELOPMENT | | |
| 11-16-12 | | |
| Drawing Title | | |
| Sixth Floor Electrical Plan-Part B | | |
| Scale: 1/4" = 1'-0" | | |
| Drawing Number | | |

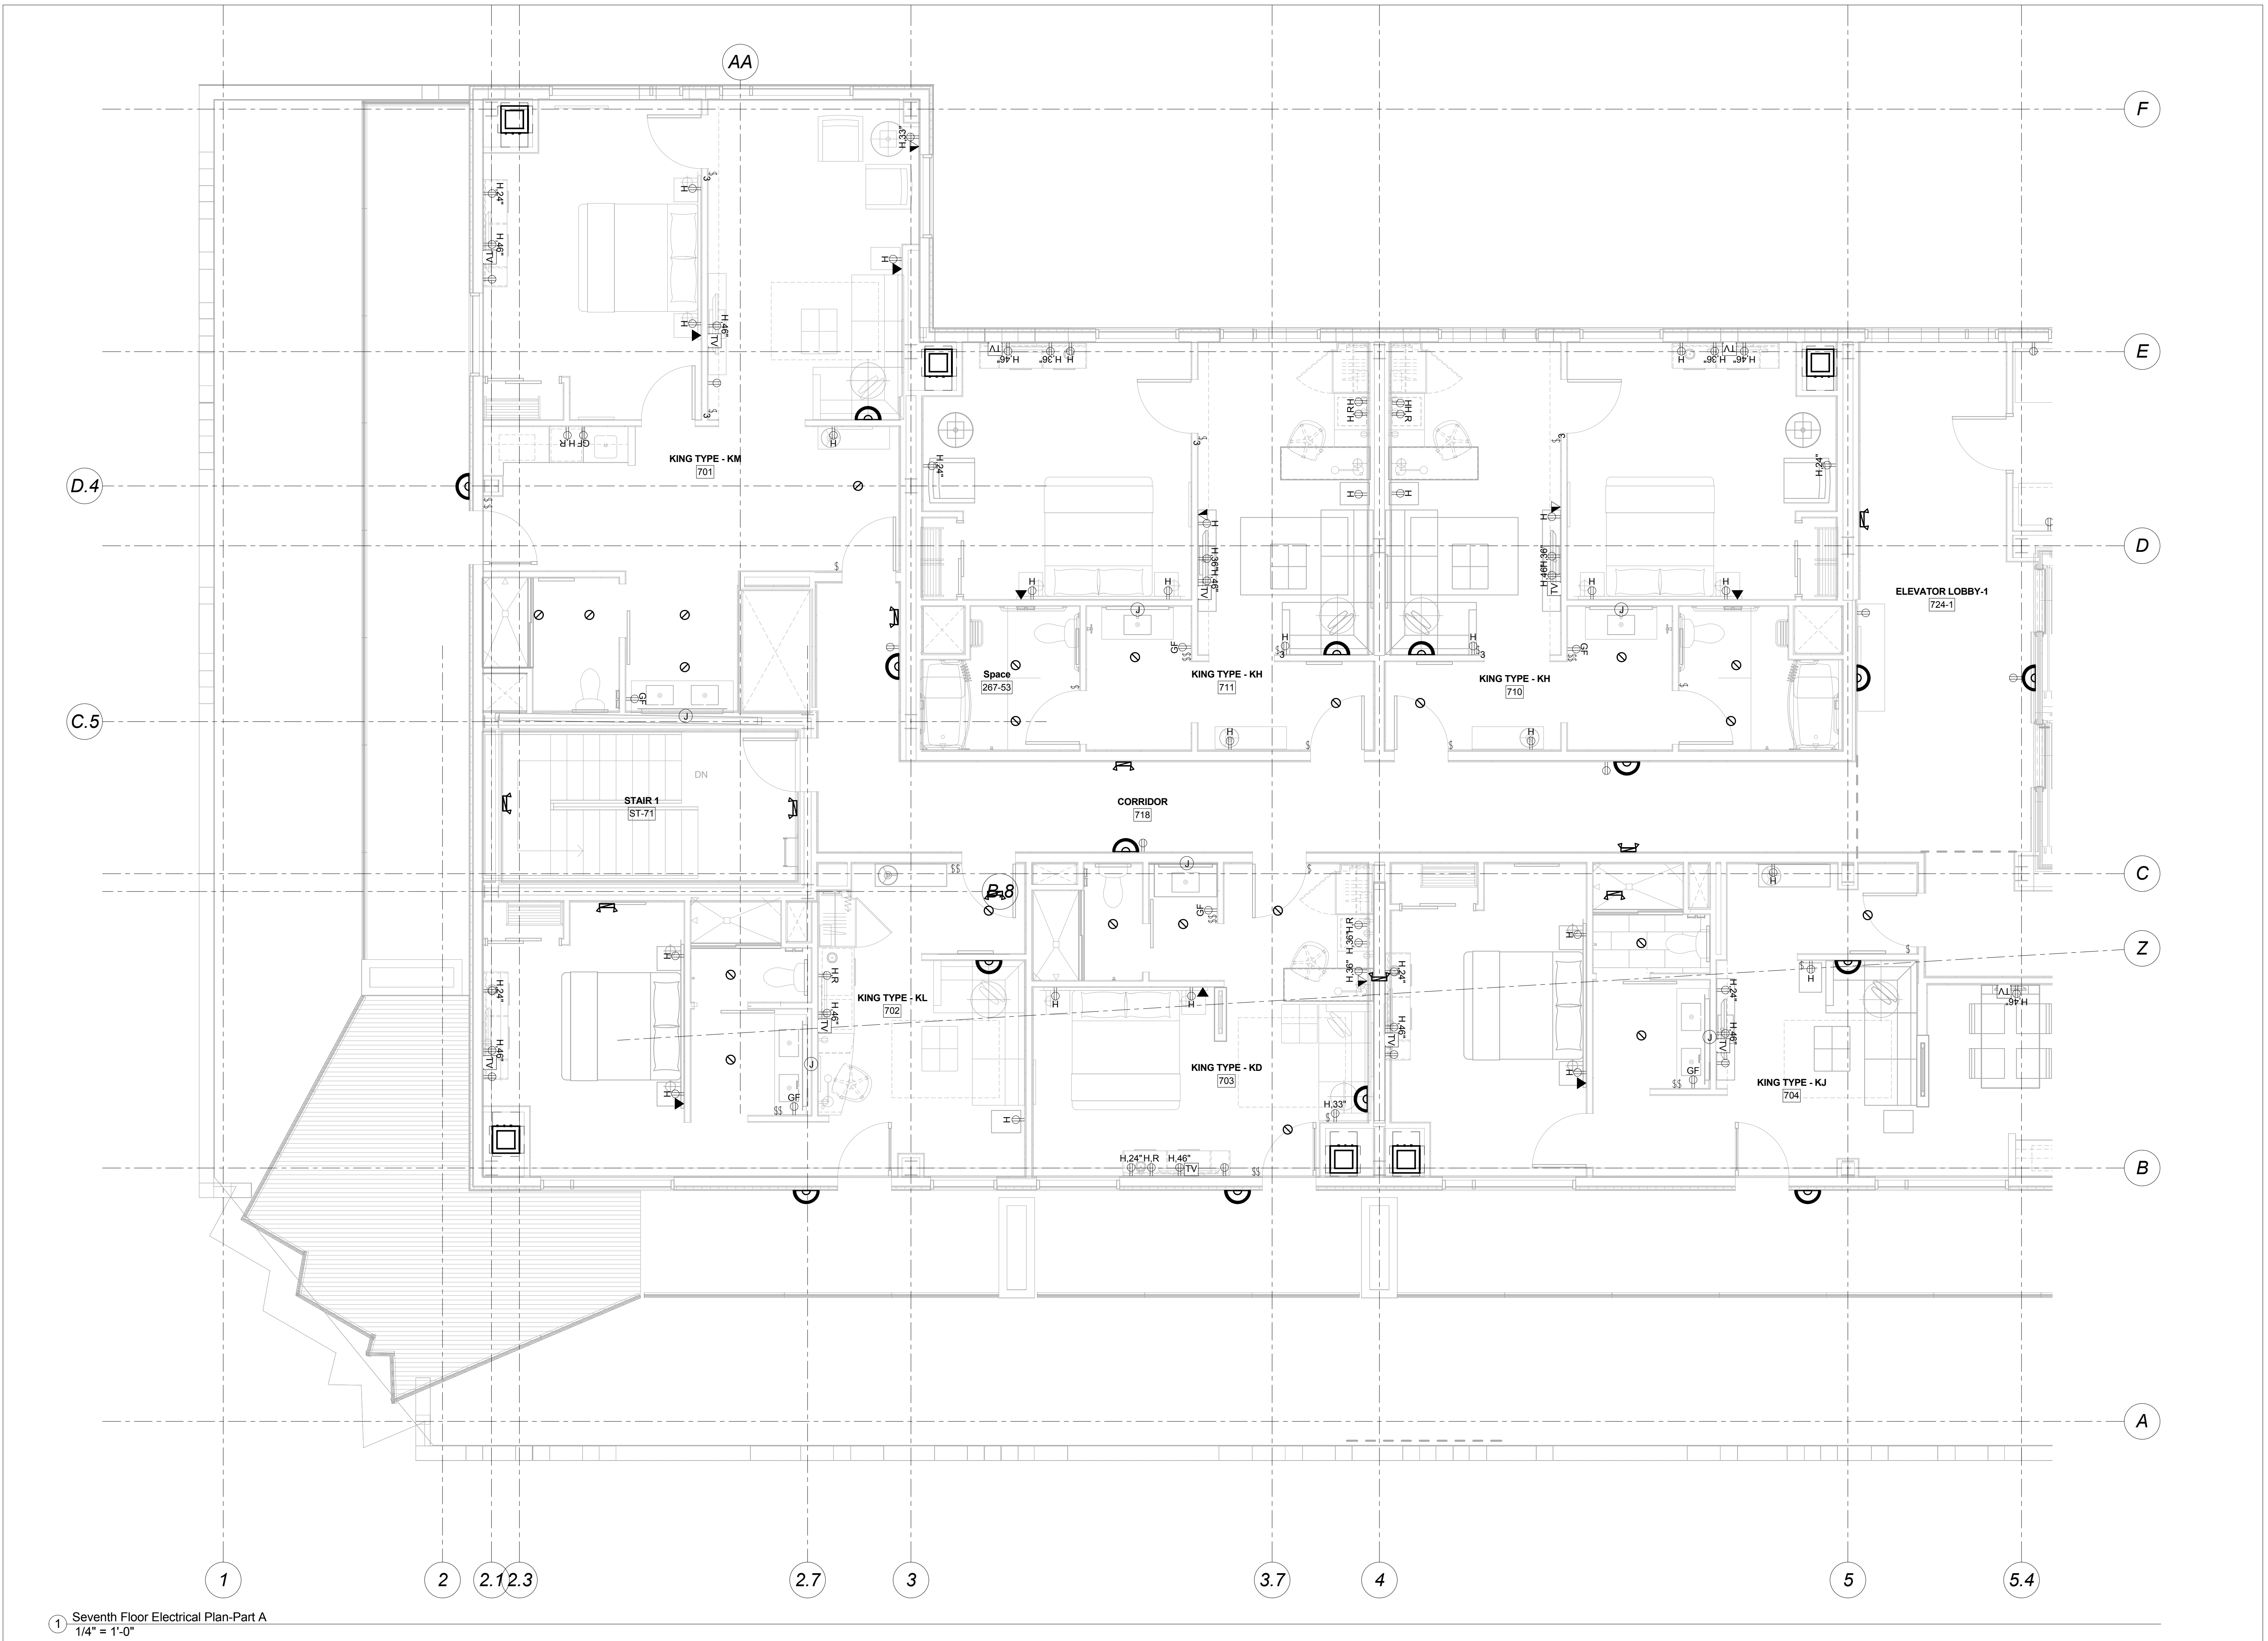

| Mark | Date | Description |
|-----------------------------------------------------|------|-------------|
| Project Status | | |
| DESIGN DEVELOPMENT | | |
| 11-16-12 | | |
| Drawing Title | | |
| Seventh Floor Electrical Plan-Part A | | |
| Scale: 1/4" = 1'-0" | | |
| Drawing Number | | |
| E30.7A | | |

1 Seventh Floor Electrical Plan-Part A
 1/4" = 1'-0"

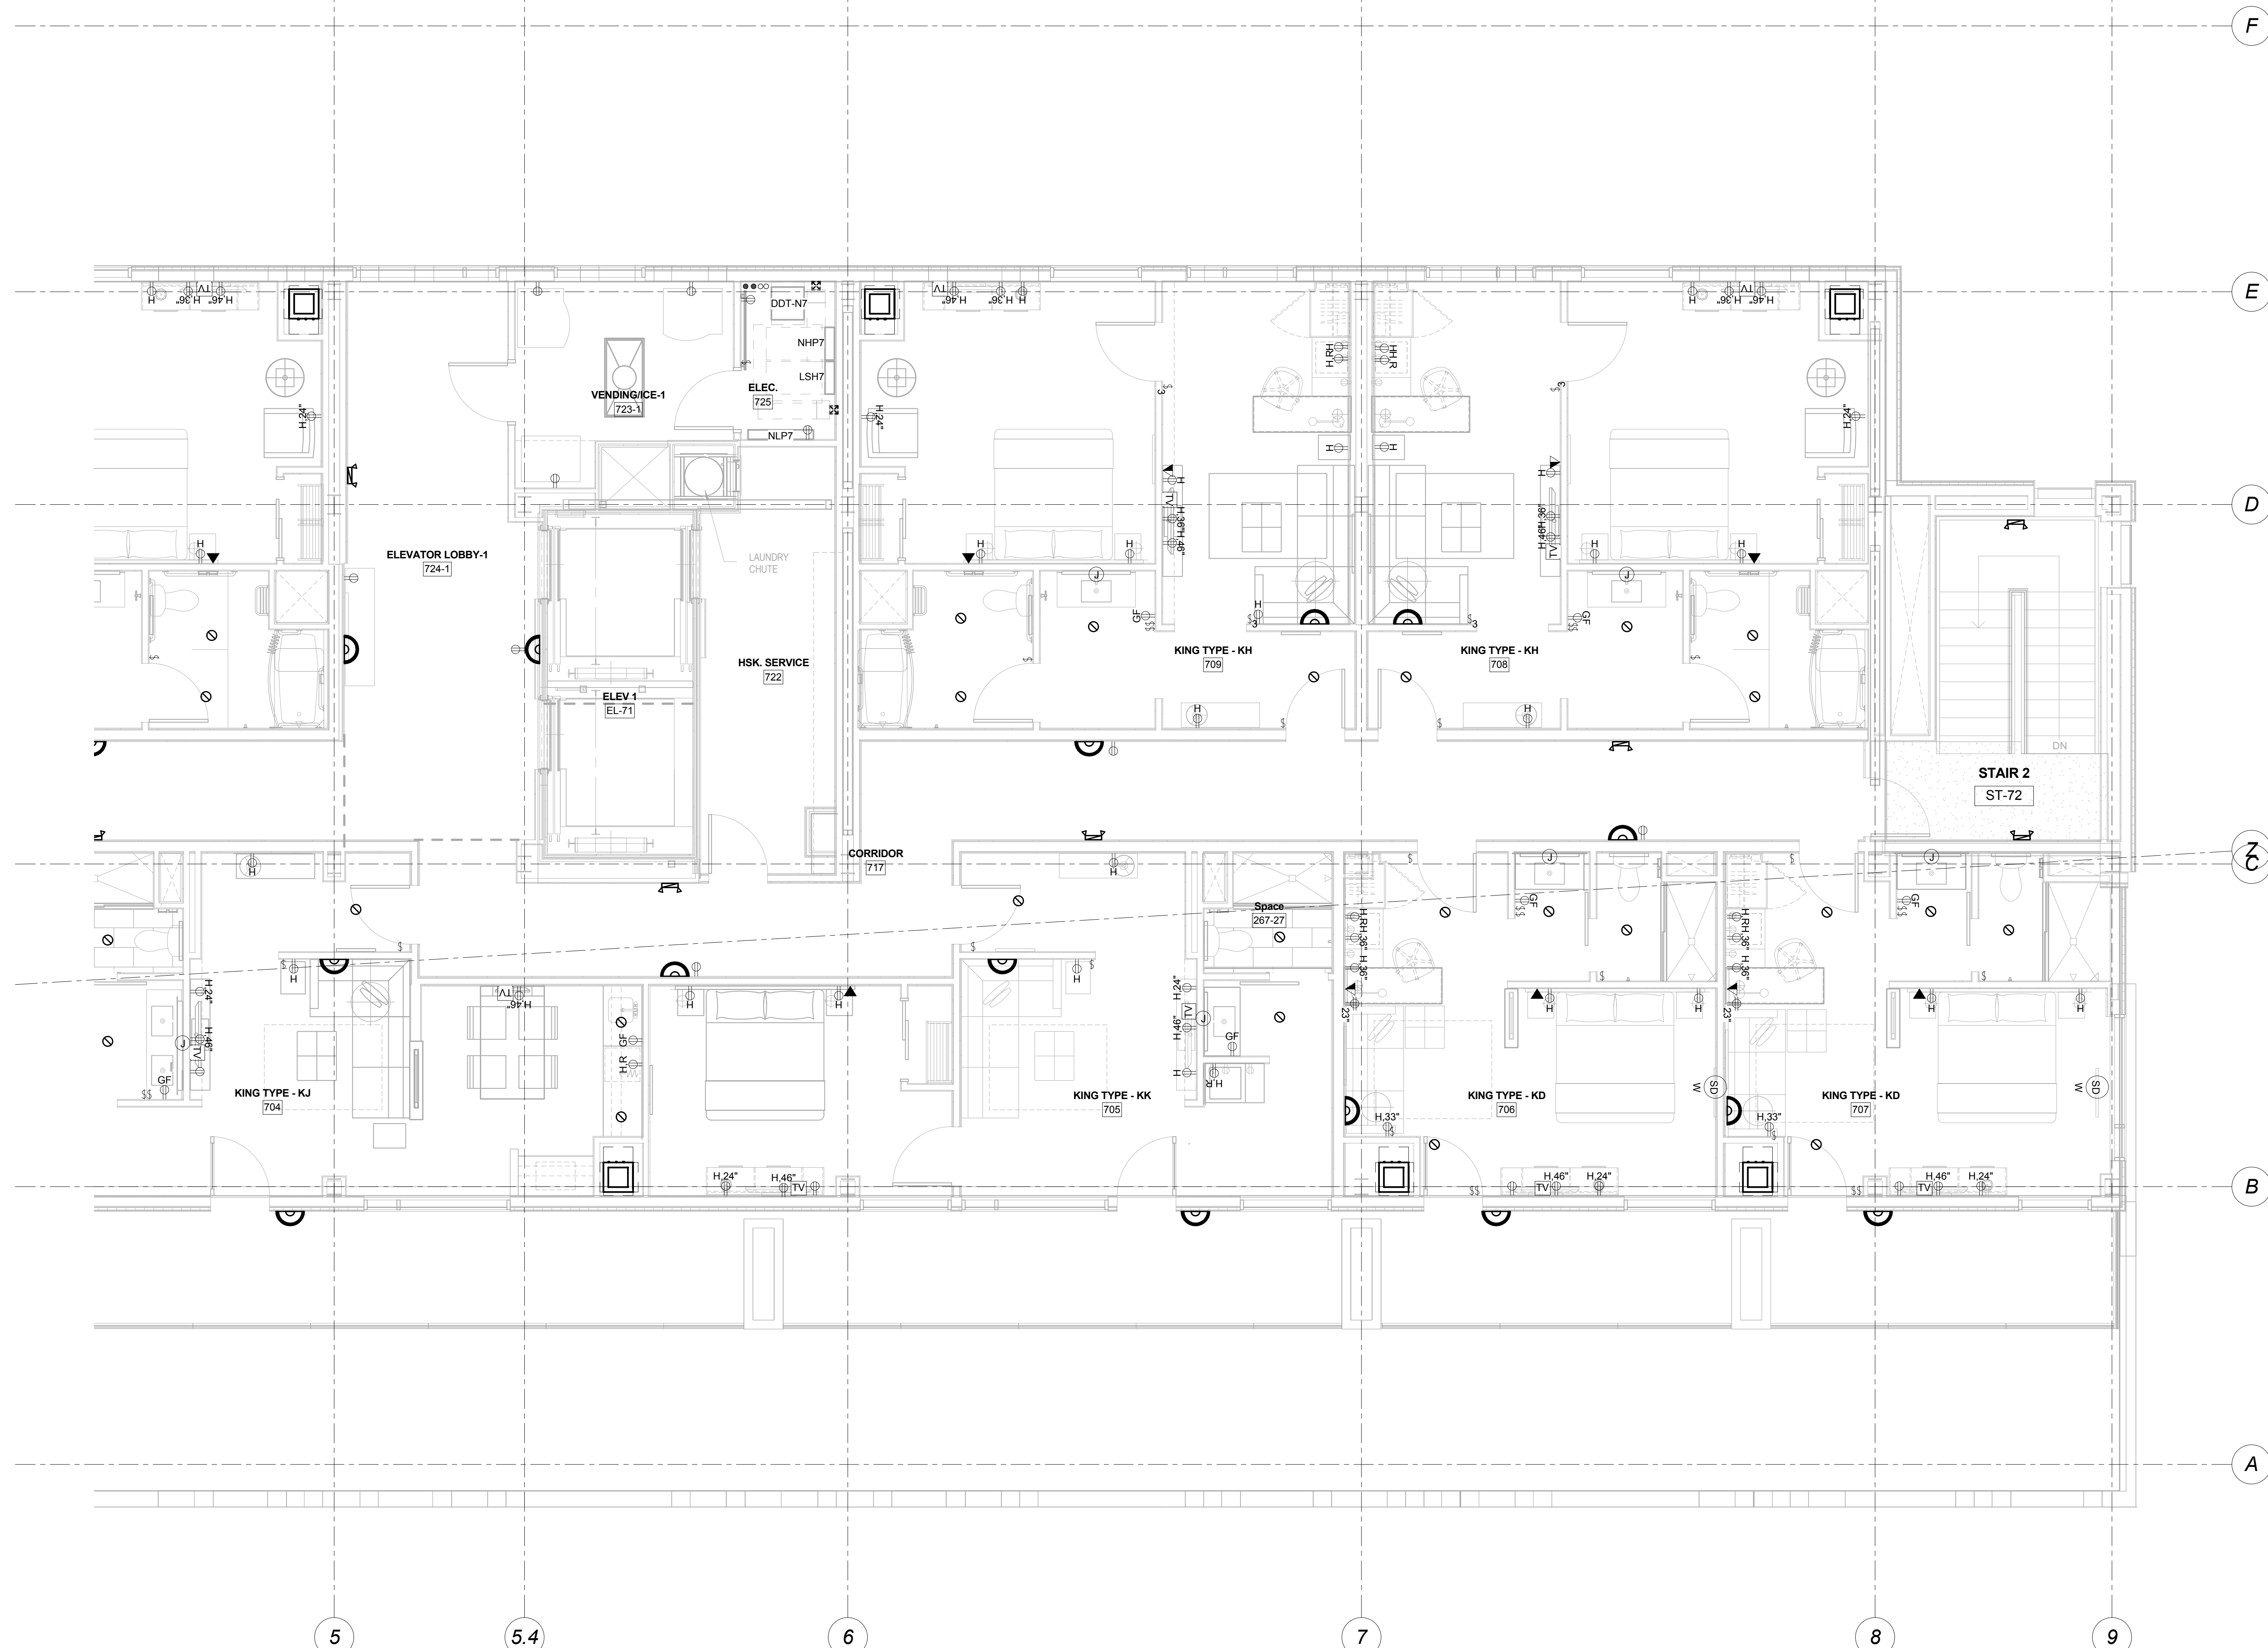


| Mark | Date | Description |
|---------------------------|------|-------------|
| Project Status | | |
| DESIGN DEVELOPMENT | | |
| 11-16-12 | | |

Drawing Title
**Seventh Floor
 Electrical Plan-Part
 B**

Scale: 1/4" = 1'-0"

Drawing Number
E30.7B

1 Seventh Floor Electrical Plan-Part B
 1/4" = 1'-0"

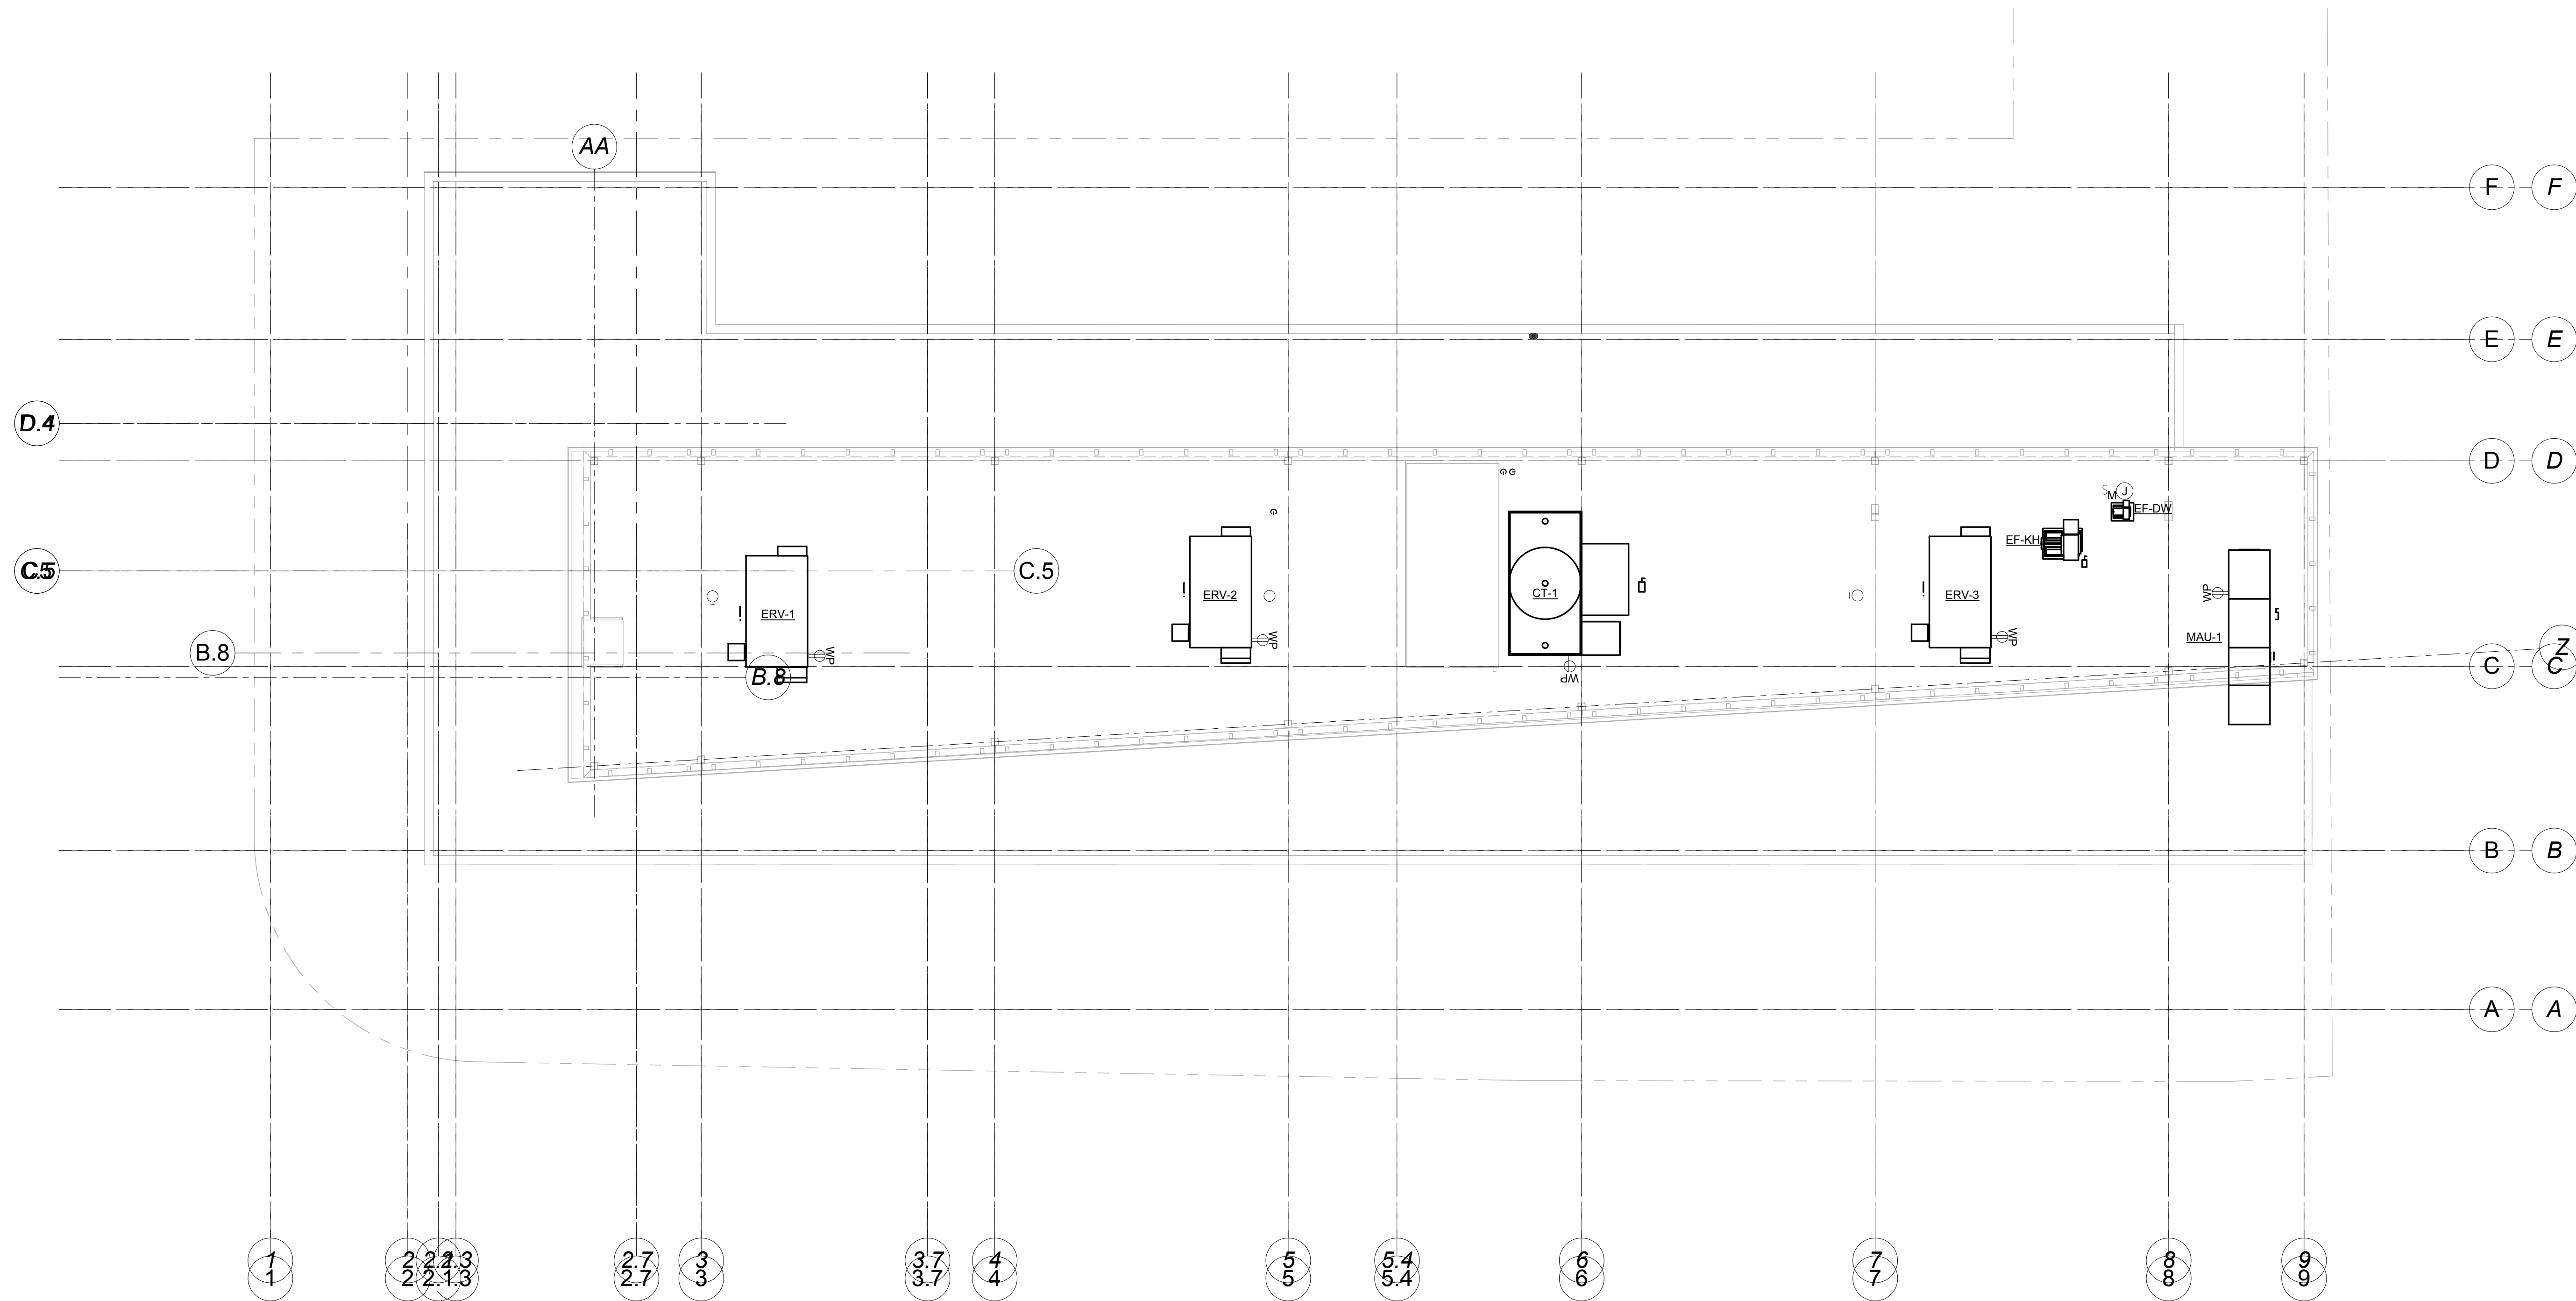

1 Roof - Power
 1/8" = 1'-0"

| Mark | Date | Description |
|------|------|-------------|
| | | |

Project Status
**DESIGN
 DEVELOPMENT**
 11-16-12

Drawing Title
Roof Electrical Plan

Scale: 1/8" = 1'-0"

Drawing Number
E30.8