

Mark	Date	Description

Project Status

**ISSUED FOR
CONSTRUCTION**
03-01-2013


Drawing Title

**Sixth Floor HVAC
Plan-Part B**

Scale: 1/4" = 1'-0"

Drawing Number

M10.6B

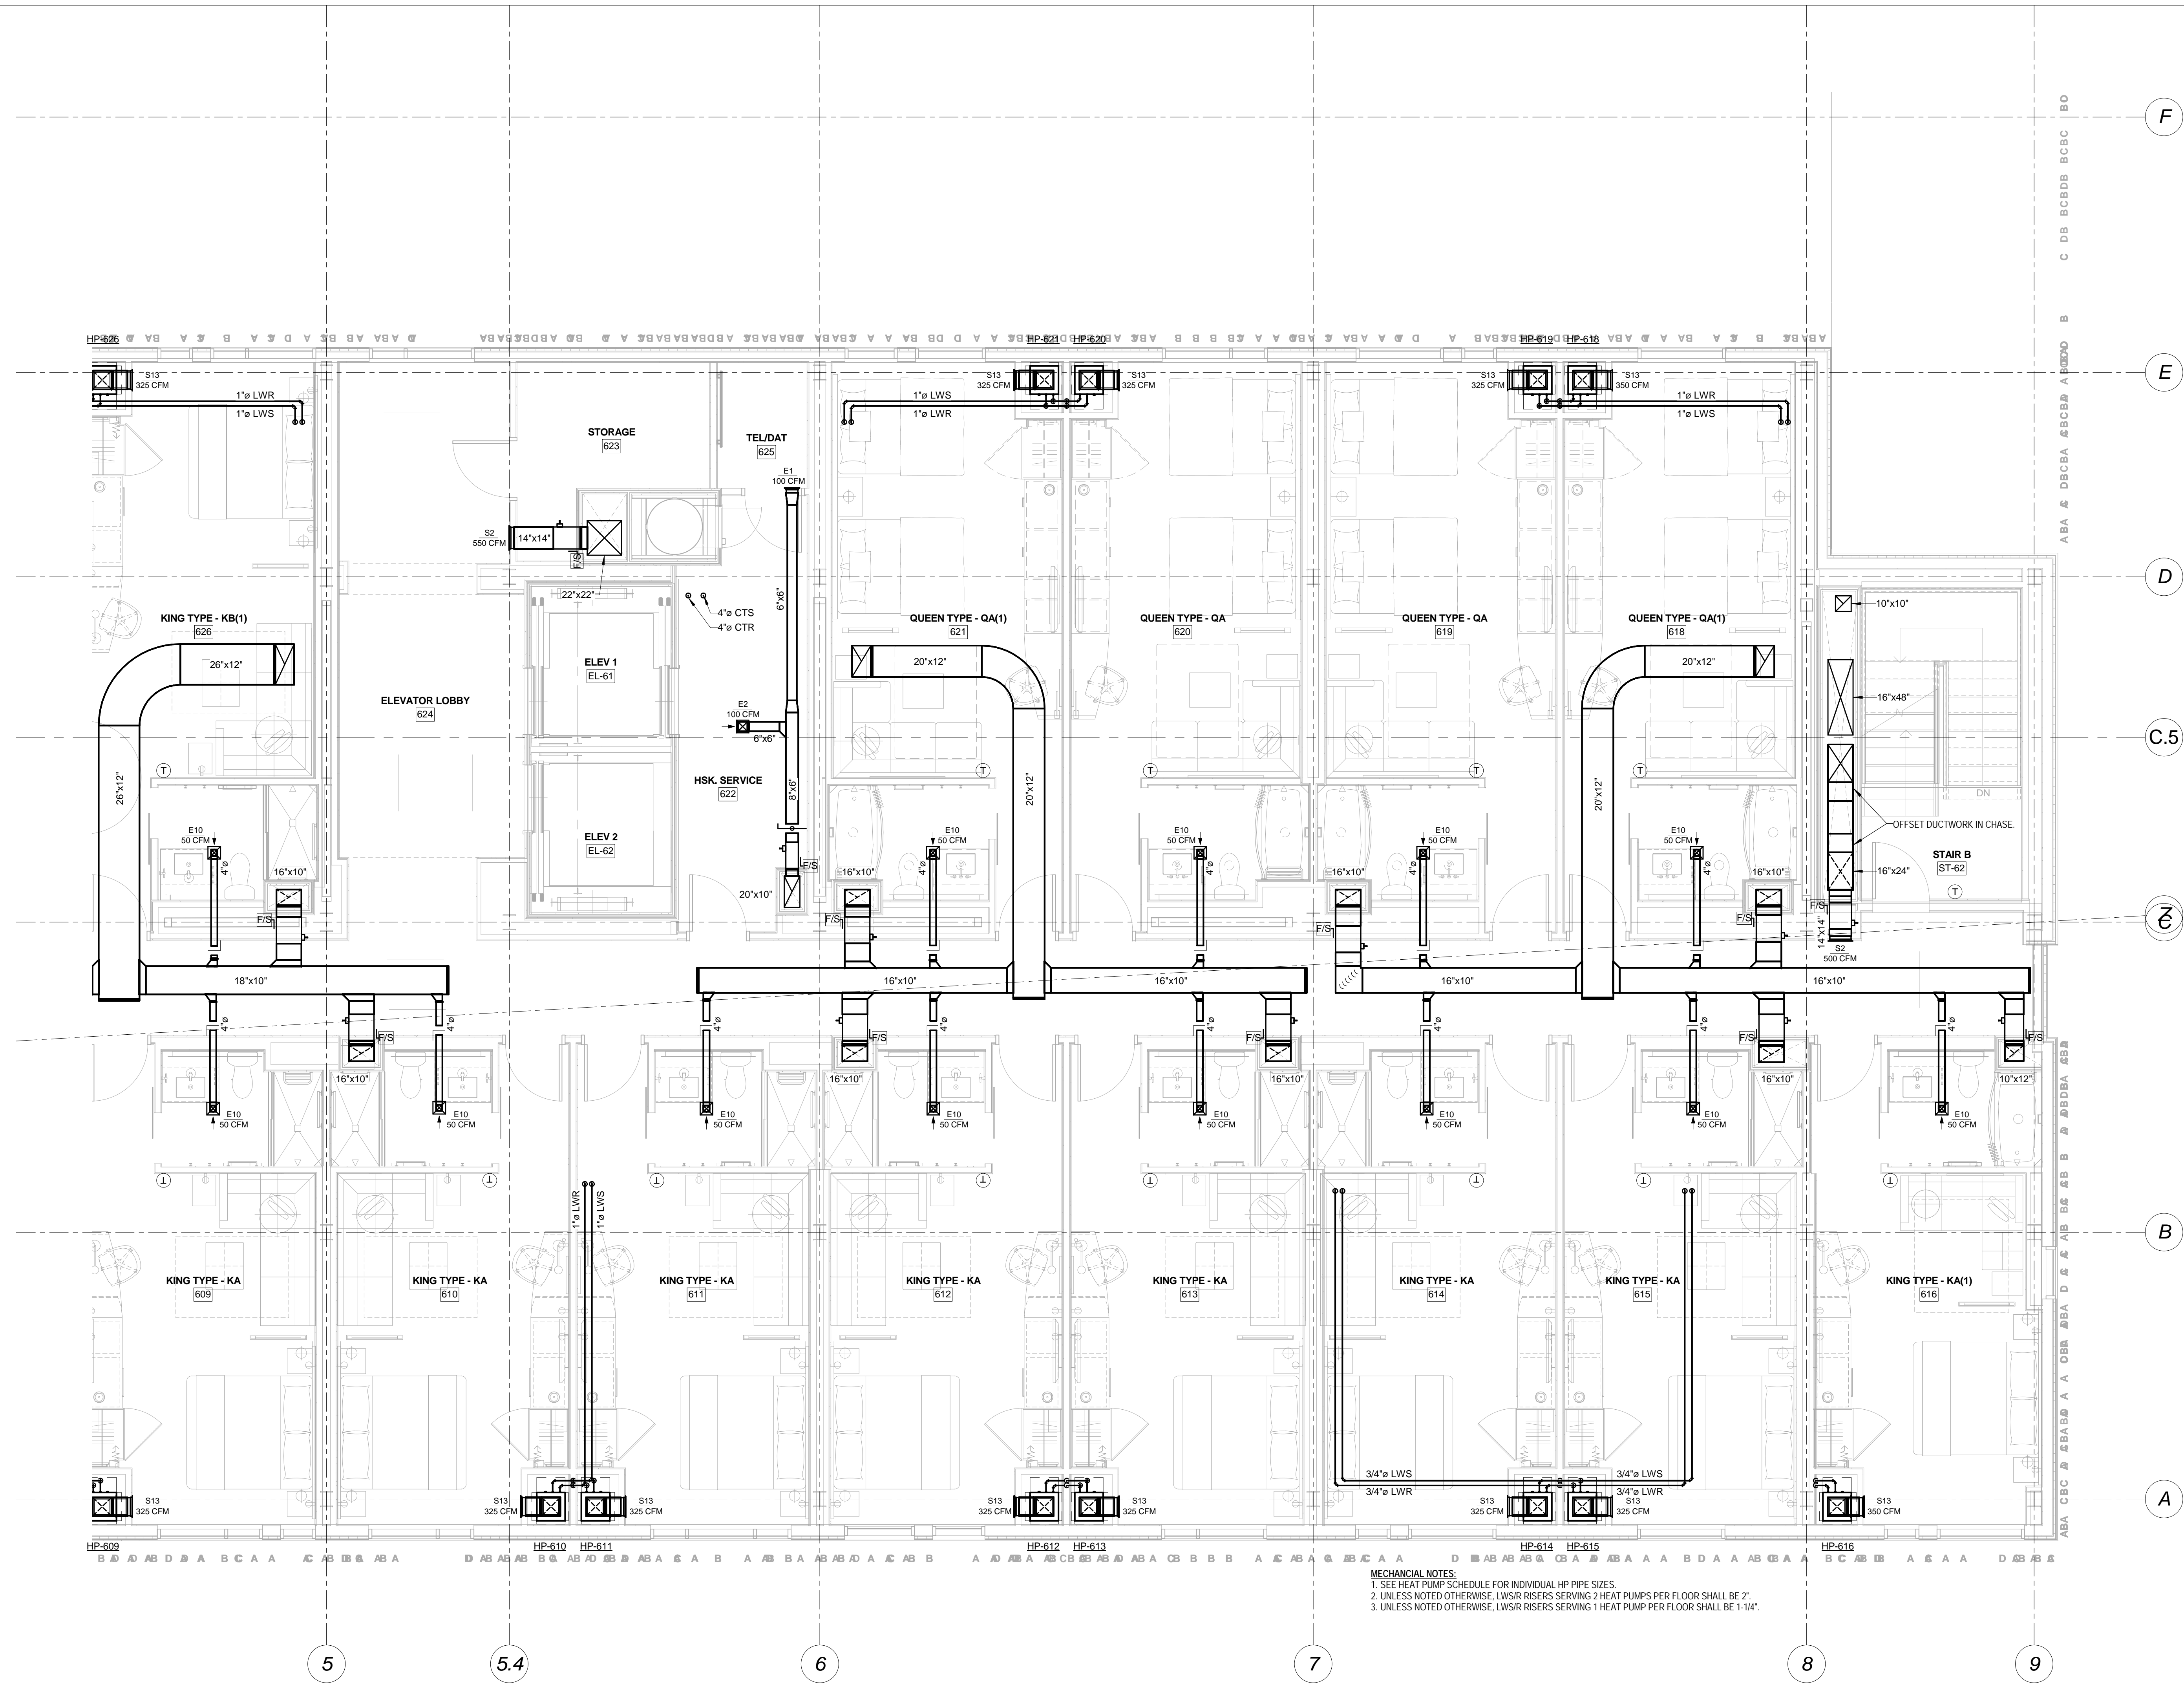

MECHANICAL NOTES:
1. SEE HEAT PUMP SCHEDULE FOR INDIVIDUAL HP PIPE SIZES.
2. UNLESS NOTED OTHERWISE, LWS/R RISERS SERVING 2 HEAT PUMPS PER FLOOR SHALL BE 2".
3. UNLESS NOTED OTHERWISE, LWS/R RISERS SERVING 1 HEAT PUMP PER FLOOR SHALL BE 1-1/4".