

Mark	Date	Description
------	------	-------------

Project Status

**ISSUED FOR
CONSTRUCTION**

03-01-2013


Drawing Title

**Seventh Floor
HVAC Plan-Part B**

Scale: 1/4" = 1'-0"

Drawing Number

M10.7B

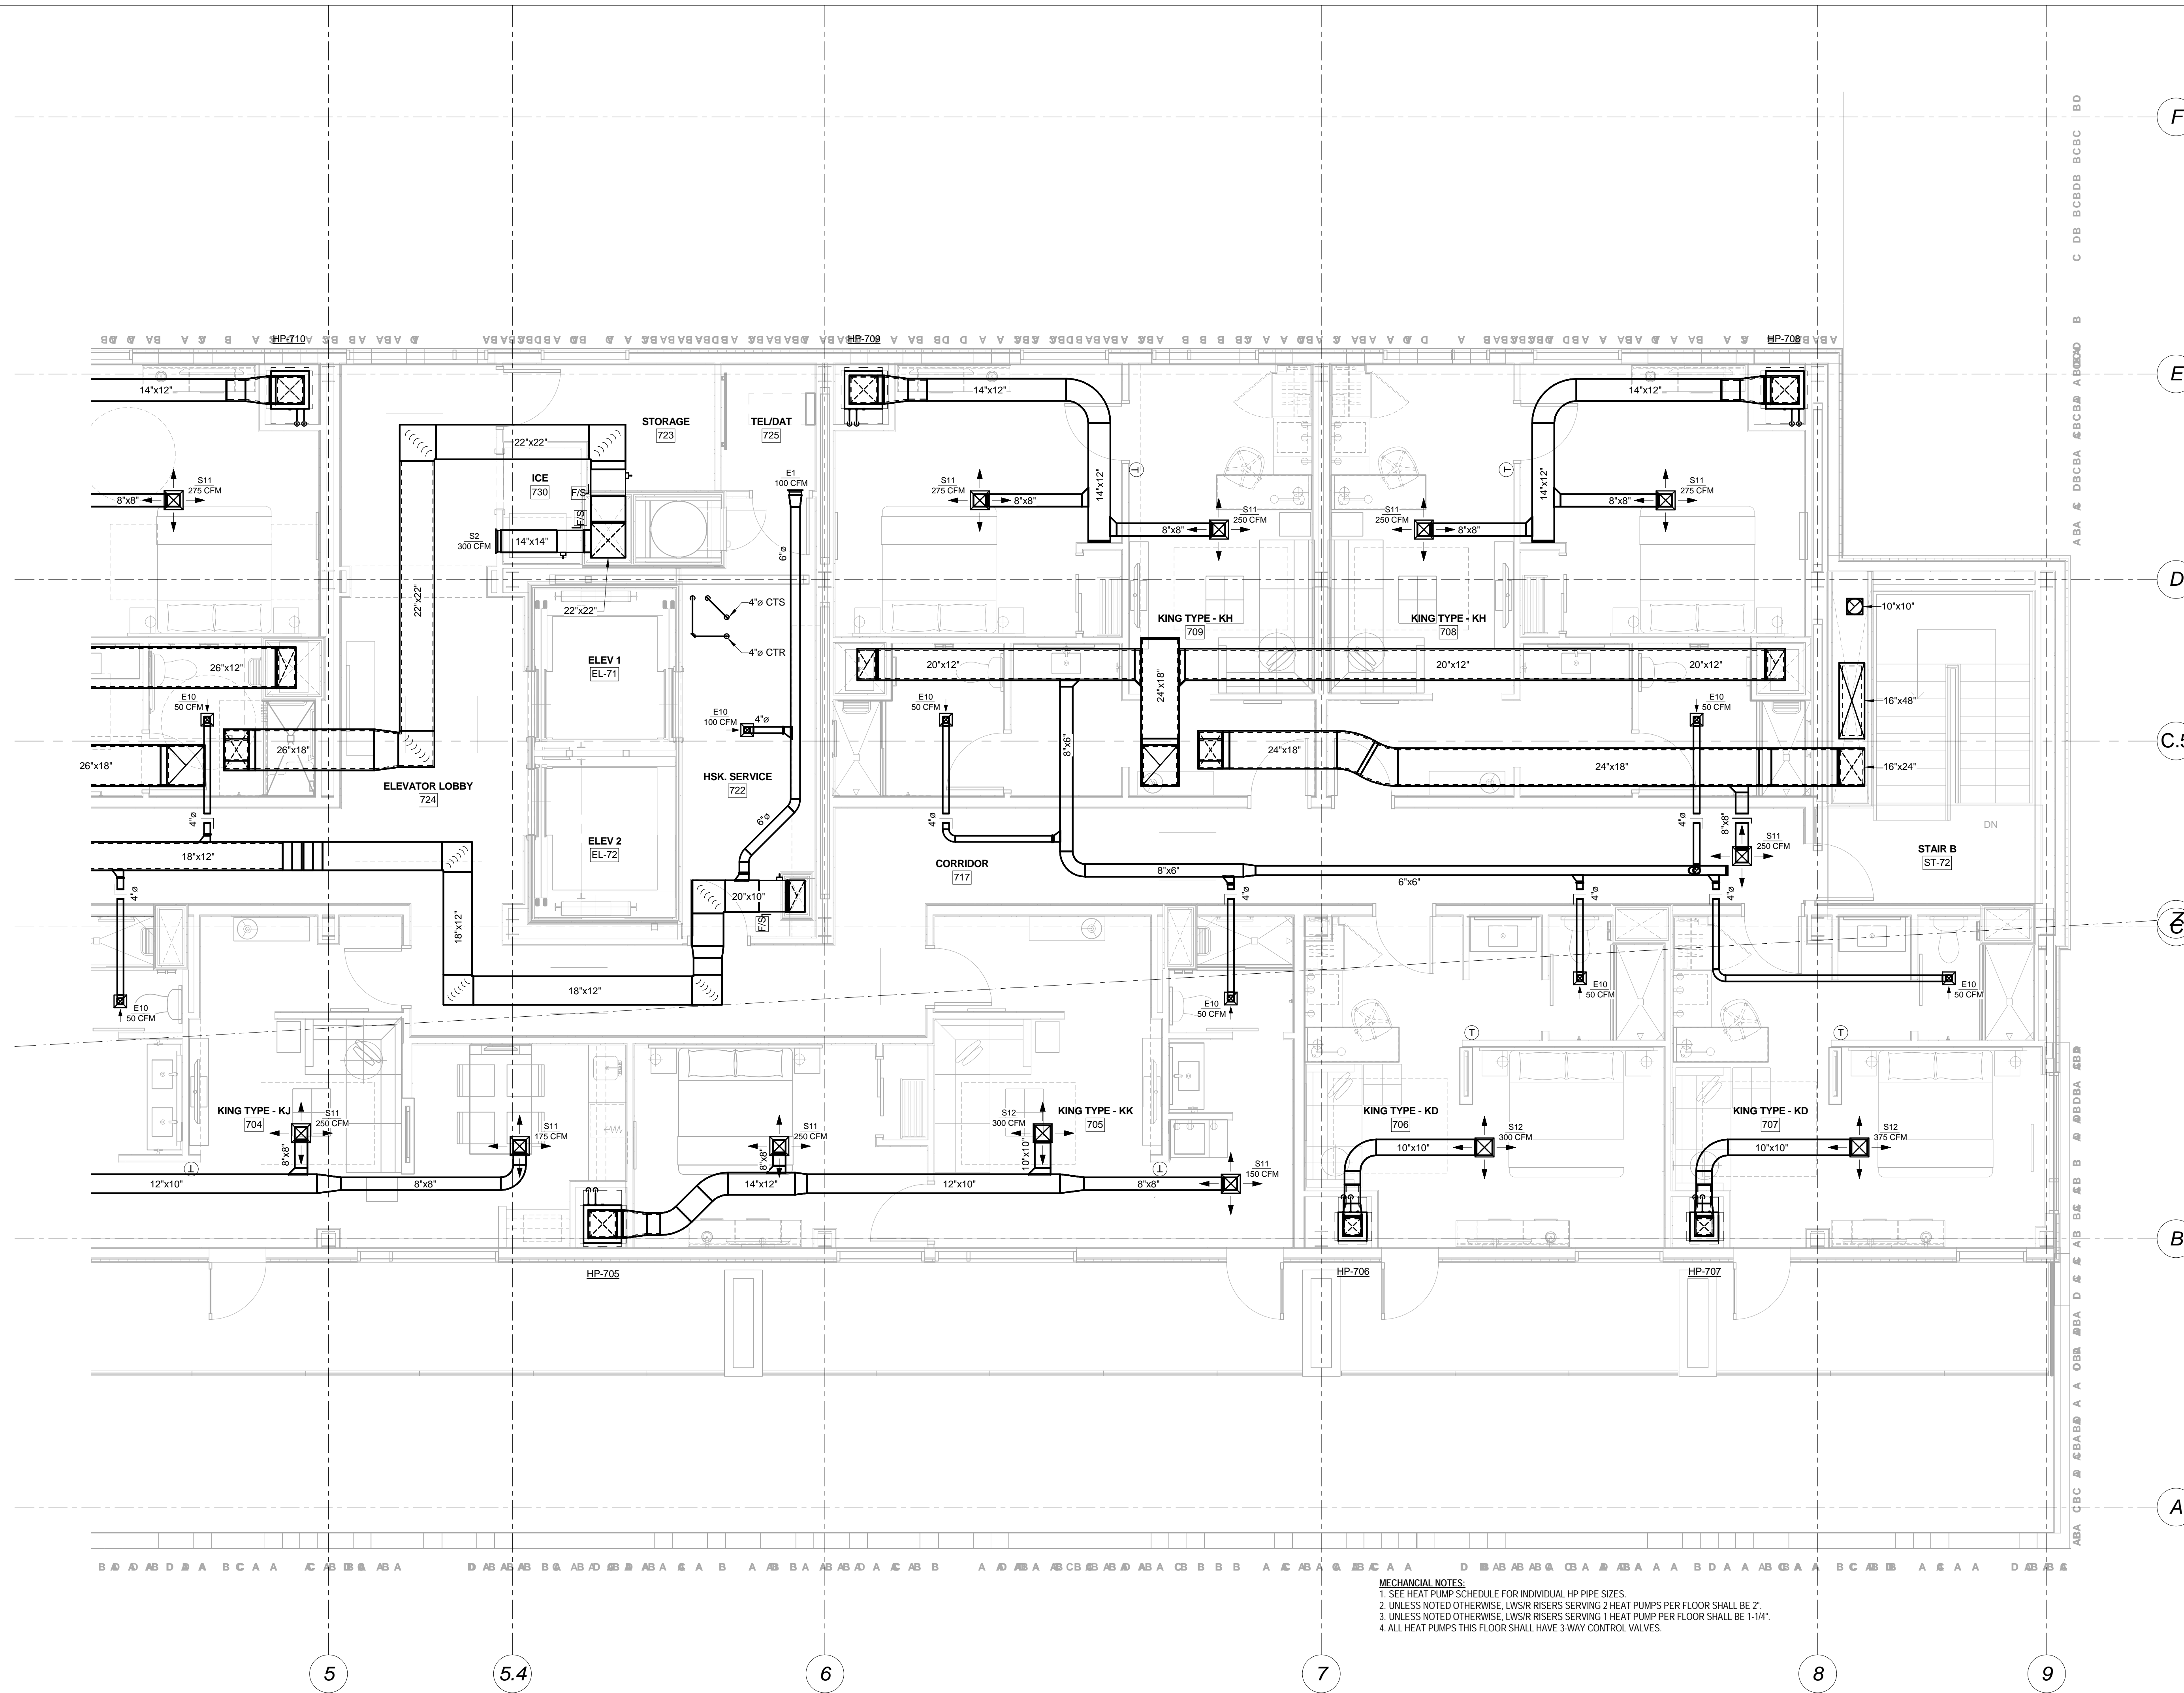

MECHANICAL NOTES:
1. SEE HEAT PUMP SCHEDULE FOR INDIVIDUAL HP PIPE SIZES.
2. UNLESS NOTED OTHERWISE, LWSIR RISERS SERVING 2 HEAT PUMPS PER FLOOR SHALL BE 2".
3. UNLESS NOTED OTHERWISE, LWSIR RISERS SERVING 1 HEAT PUMP PER FLOOR SHALL BE 1-1/4".
4. ALL HEAT PUMPS THIS FLOOR SHALL HAVE 3-WAY CONTROL VALVES.