


Mark	Date	Description
Project Status		
ISSUED FOR CONSTRUCTION		
03-01-2013		
Drawing Title		
Seventh Floor Plumbing-Part A		
Scale: 1/4" = 1'-0"		
Drawing Number		
M20.7A		

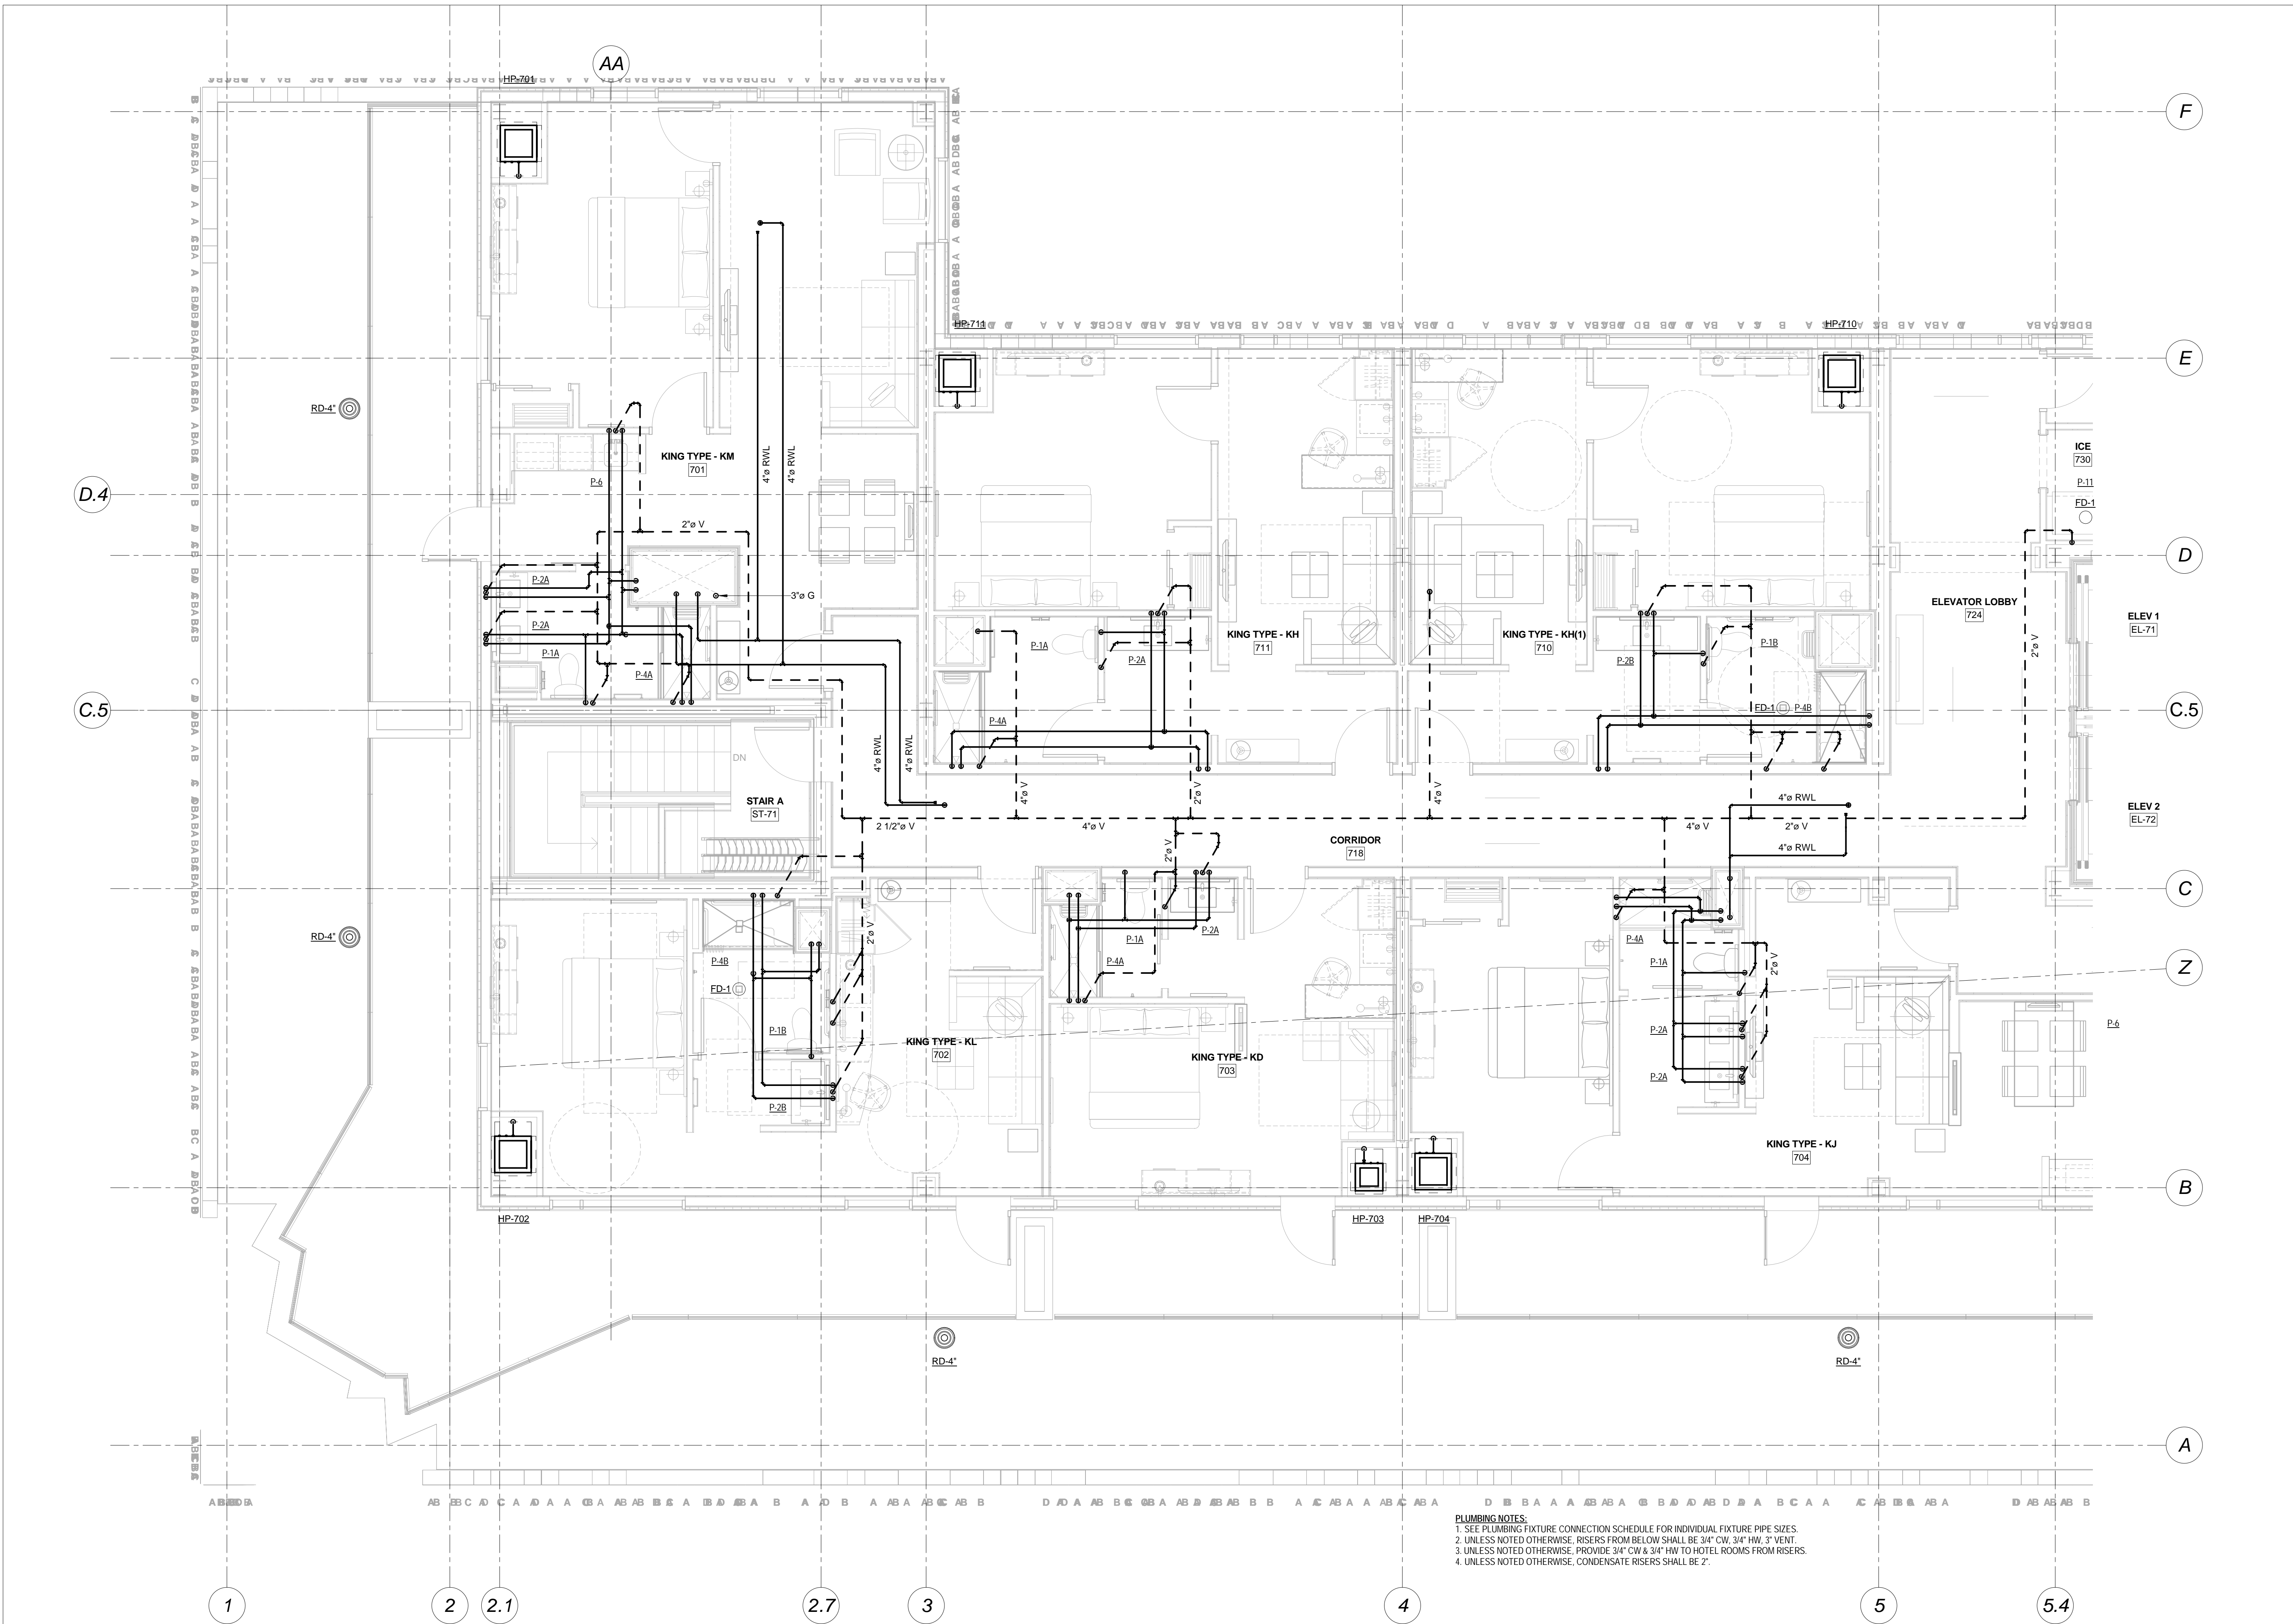

PLUMBING NOTES:
 1. SEE PLUMBING FIXTURE CONNECTION SCHEDULE FOR INDIVIDUAL FIXTURE PIPE SIZES.
 2. UNLESS NOTED OTHERWISE, RISERS FROM BELOW SHALL BE 3/4" CW, 3/4" HW, 3" VENT.
 3. UNLESS NOTED OTHERWISE, PROVIDE 3/4" CW & 3/4" HW TO HOTEL ROOMS FROM RISERS.
 4. UNLESS NOTED OTHERWISE, CONDENSATE RISERS SHALL BE 2".

① Seventh Floor Plumbing Plan-Part A
 1/4" = 1'-0"